



ELEVATION A

Scale: 1:20 @ A1

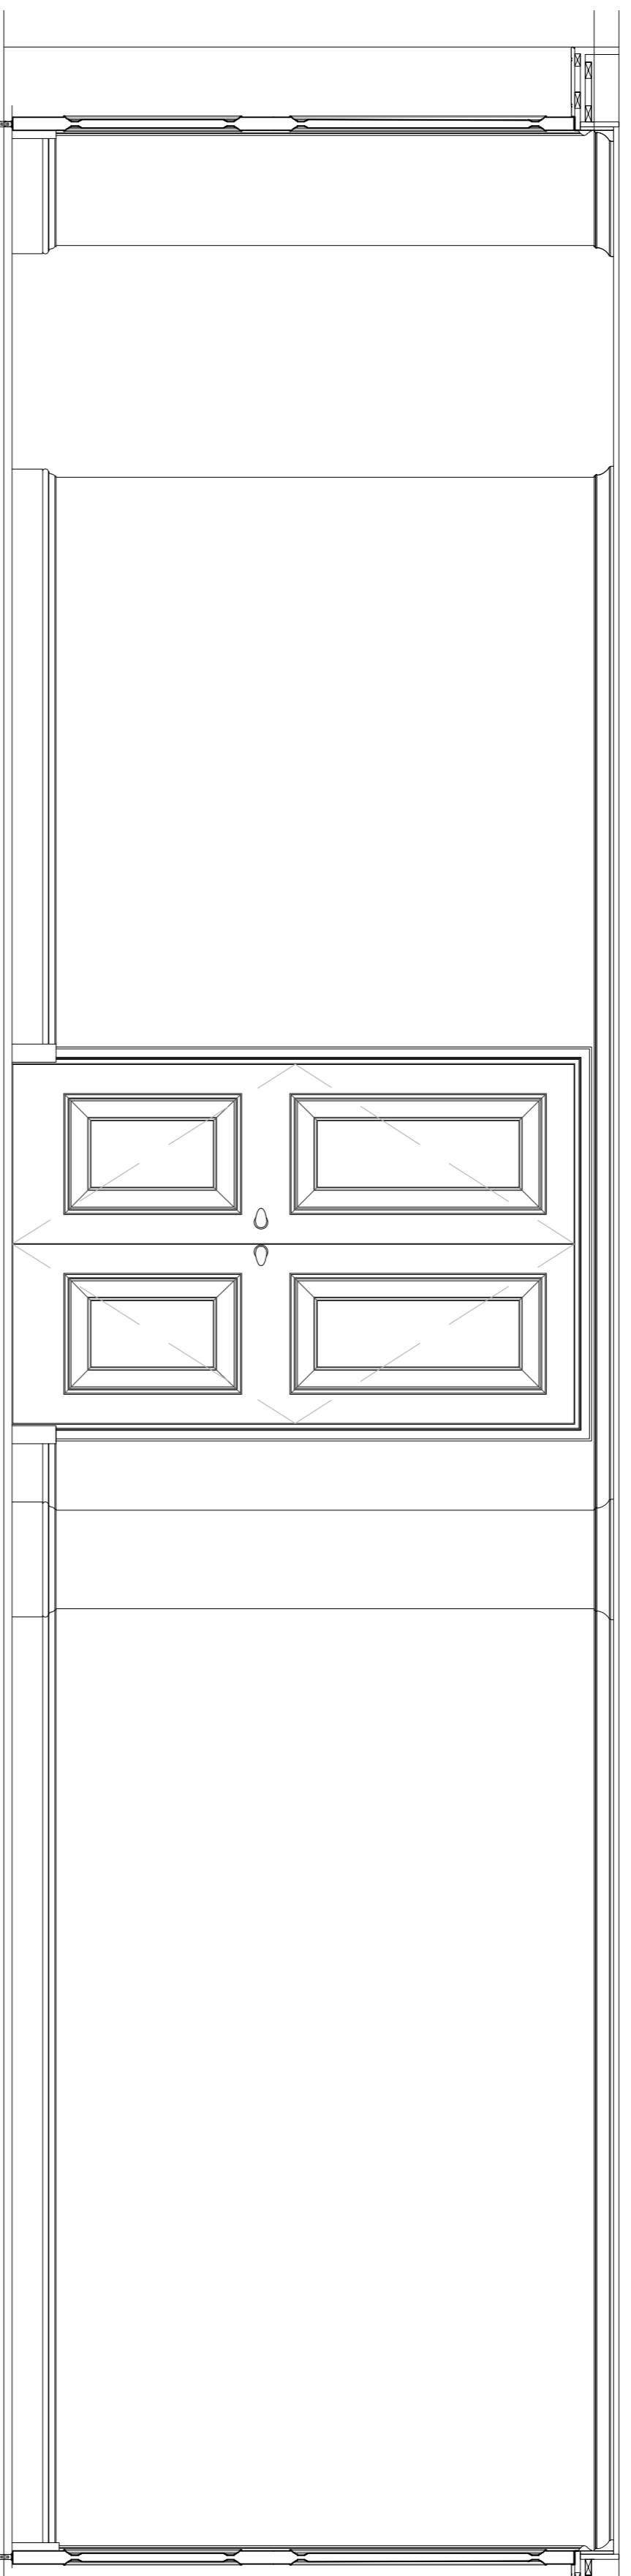


ELEVATION C

Scale: 1:20 @ A1

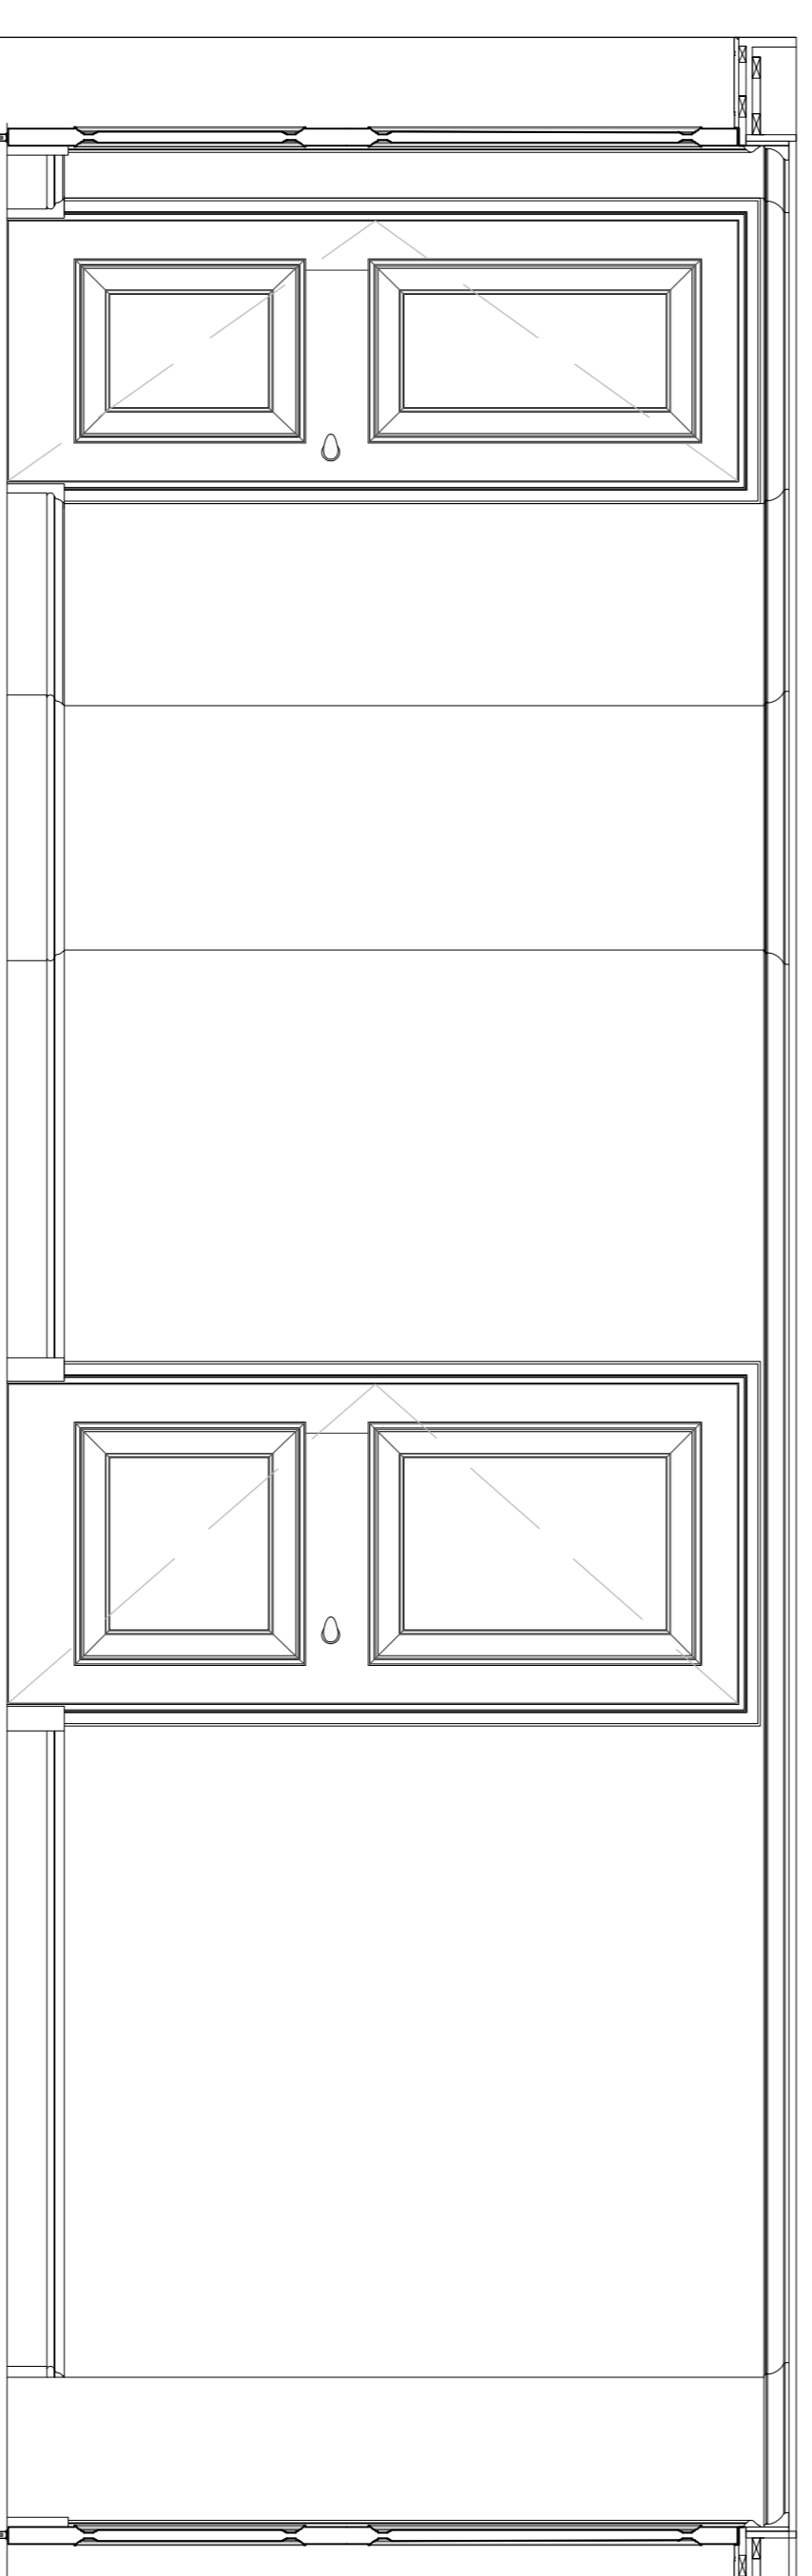


ELEVATION B

Scale: 1:20 @ A1

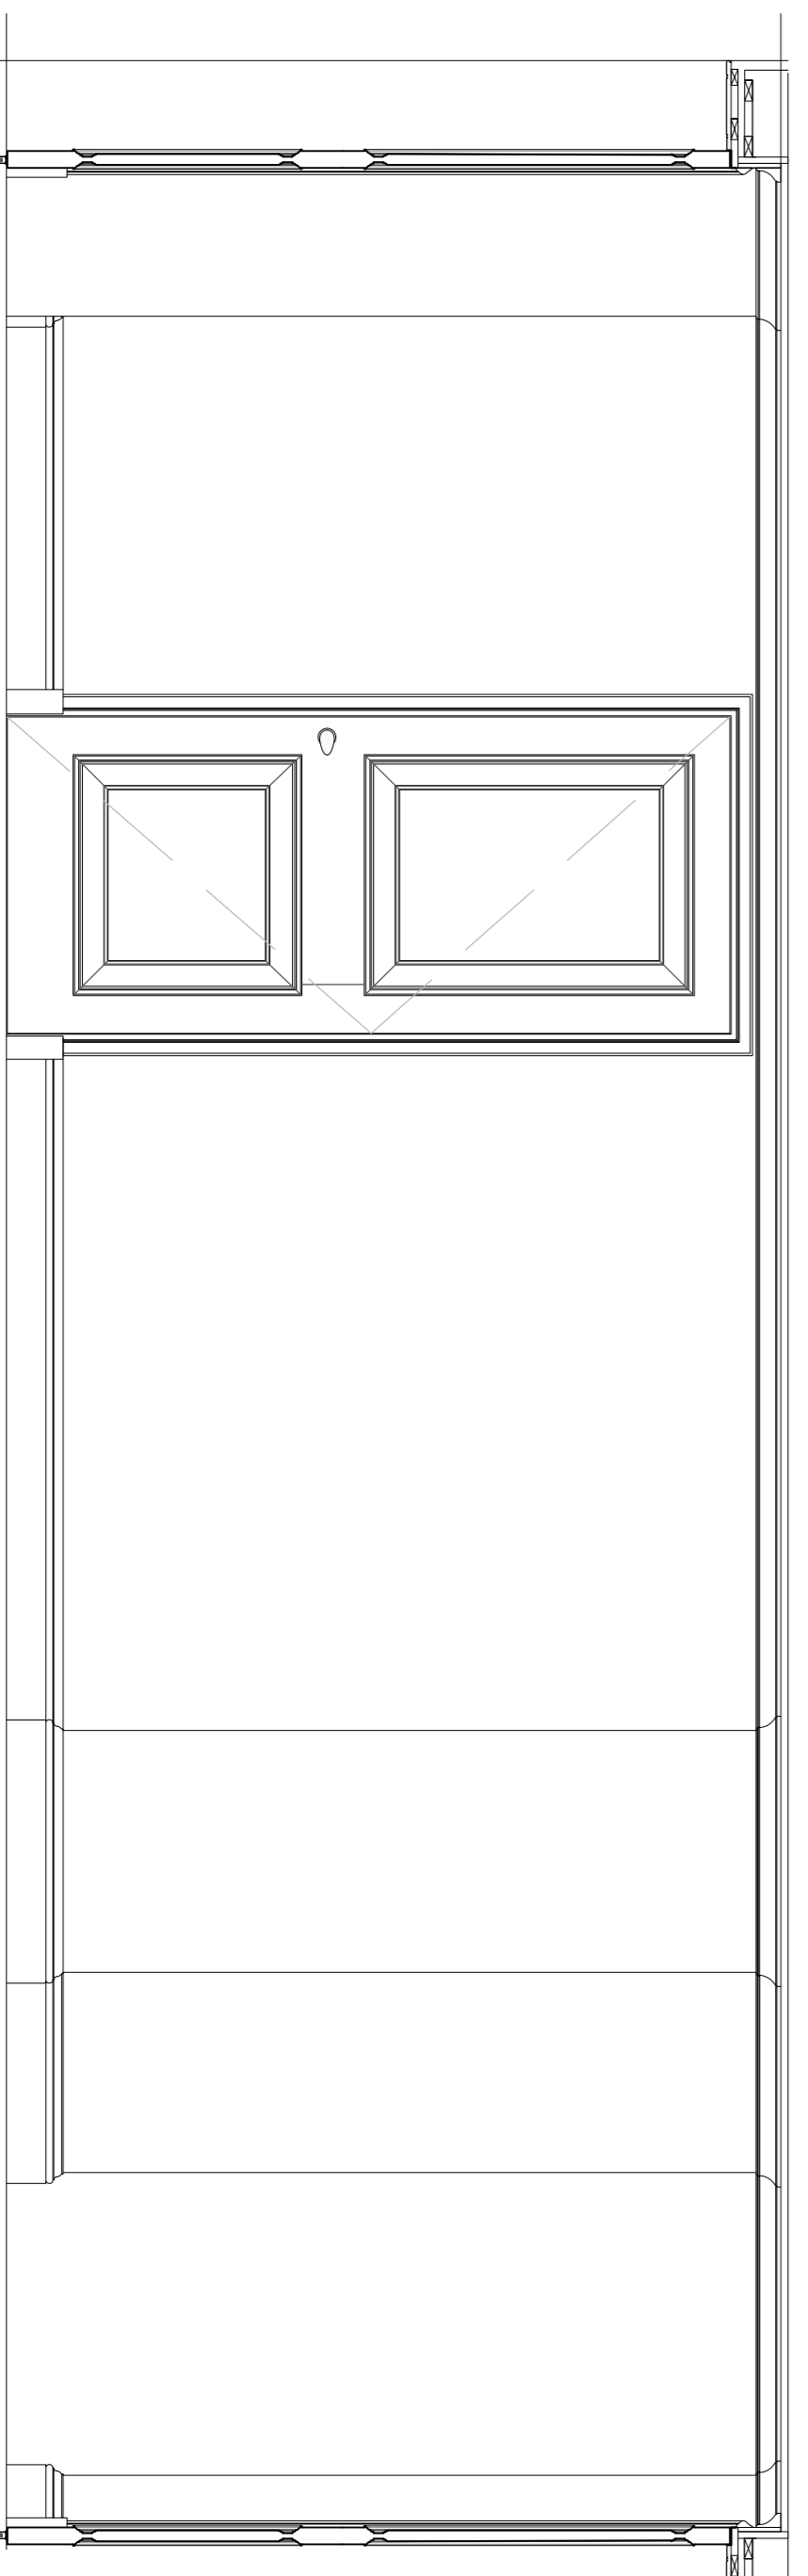


ELEVATION D

Scale: 1:20 @ A1

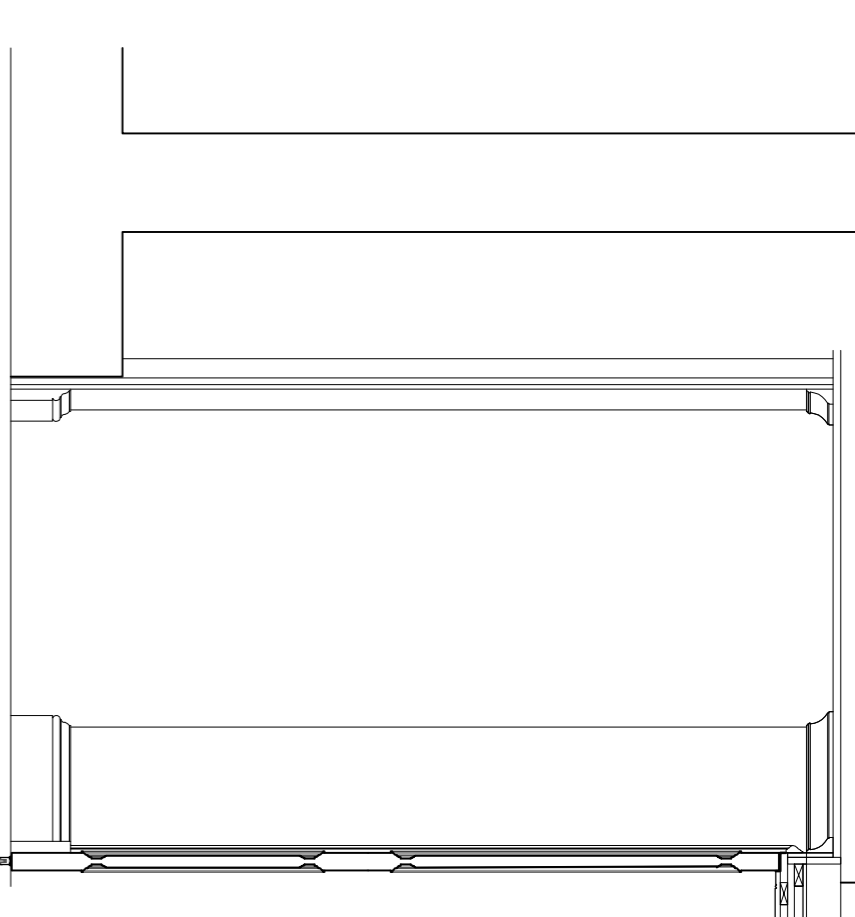


ELEVATION G

Scale: 1:20 @ A1

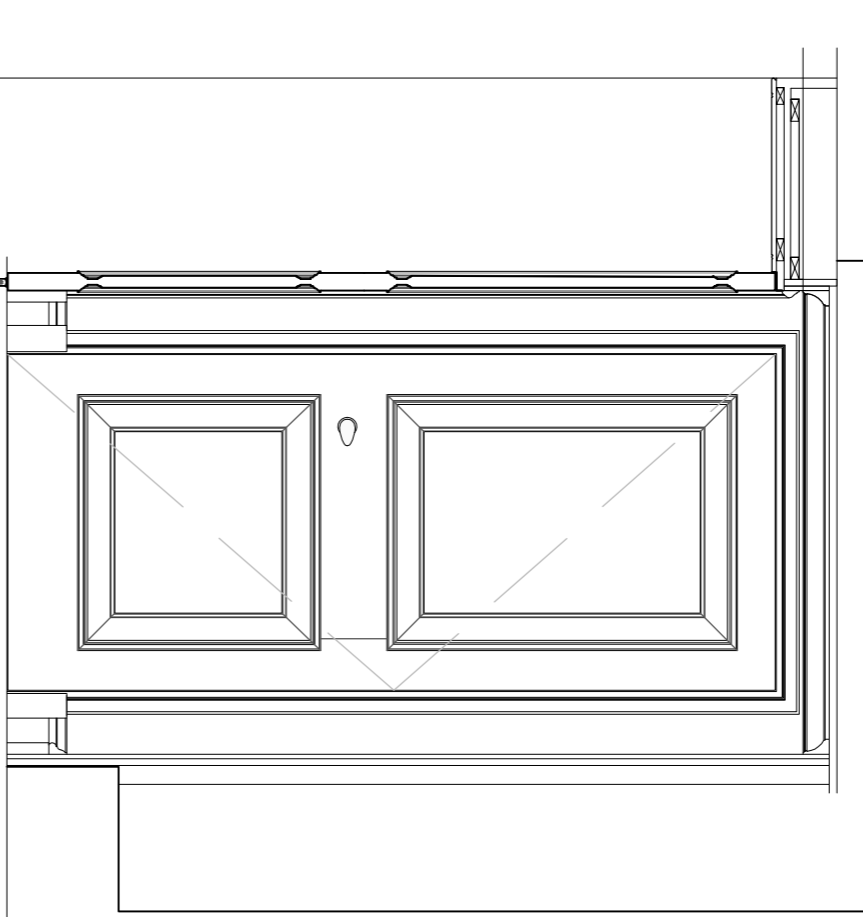


ELEVATION H

Scale: 1:20 @ A1

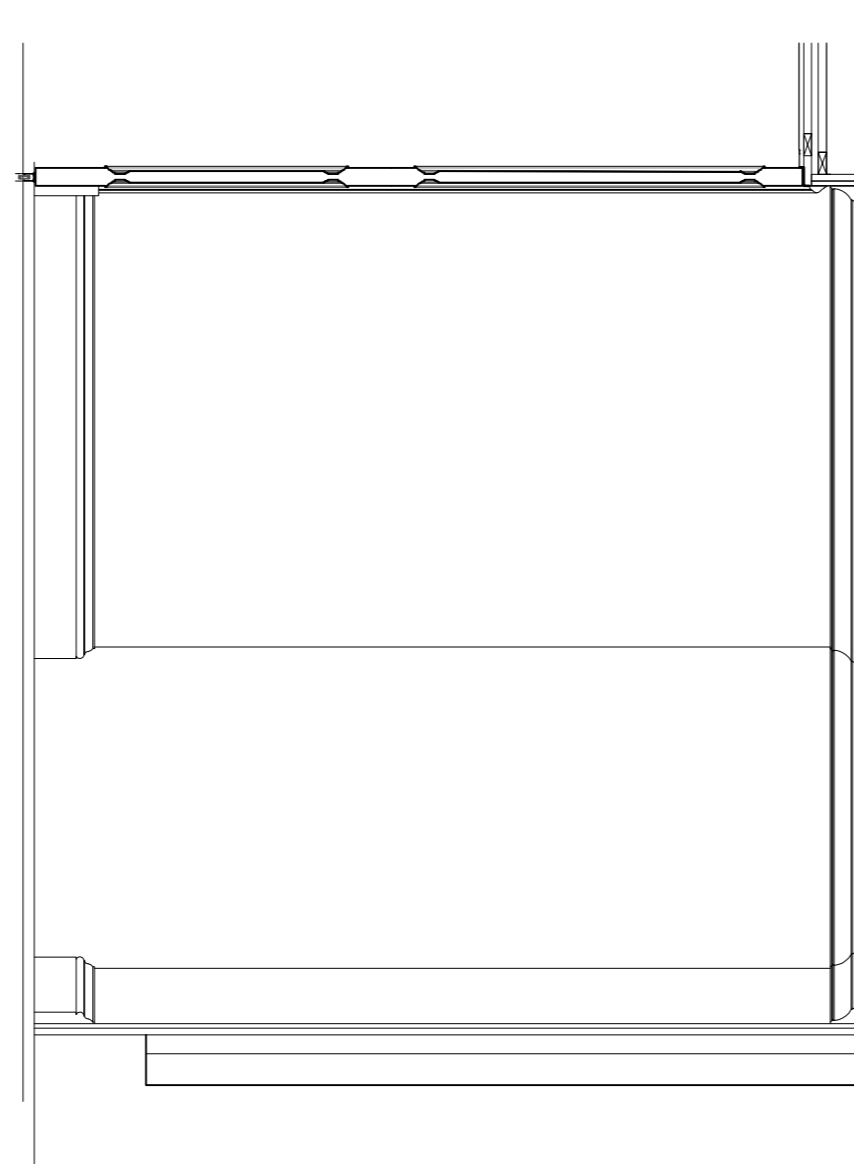

ELEVATION E

Scale: 1:20 @ A1

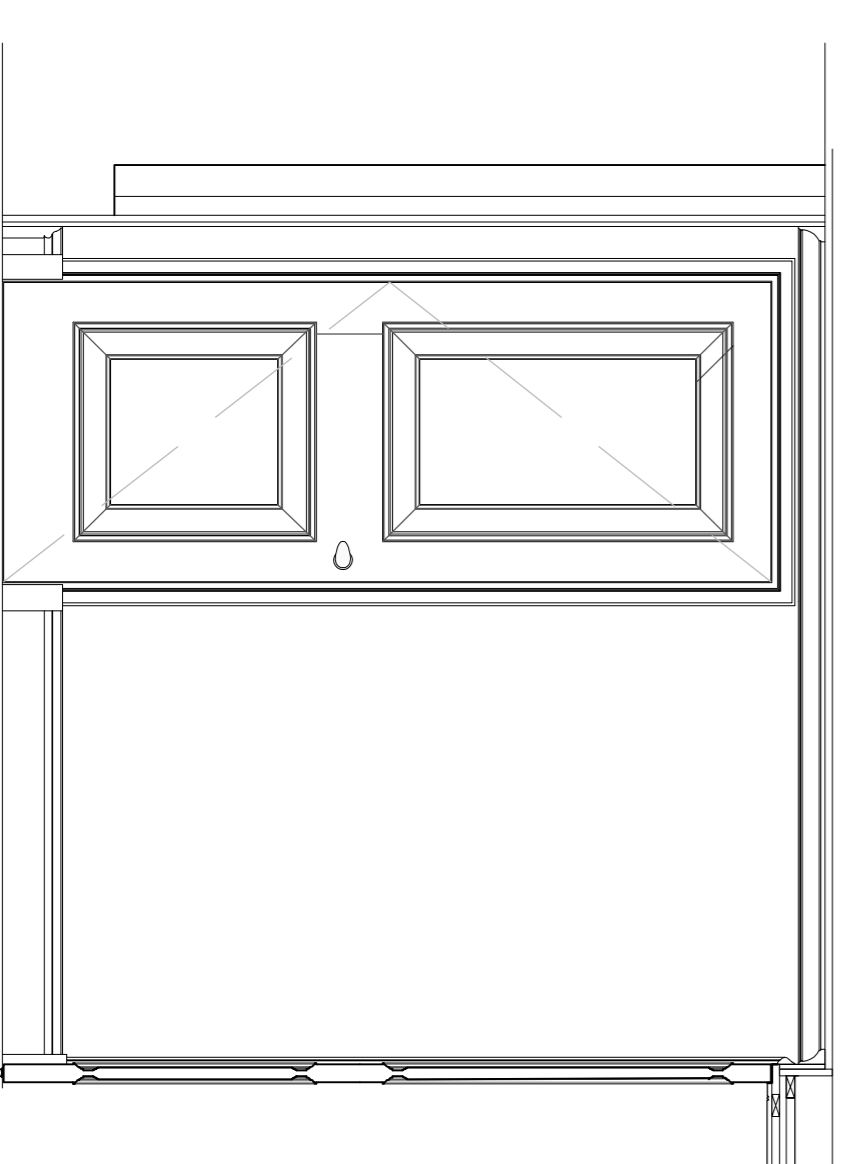

ELEVATION F

Scale: 1:20 @ A1

MOML

GENERAL NOTES

1. Do not scale off the drawing, use figured dimensions only. All dimensions and levels shall be given in millimetres and rounded to the nearest millimetre.
2. The drawing is to be used in conjunction with consultant drawings and specifications.
3. The drawing is to be used in conjunction with consultant drawings and specifications.
4. The drawing is copyright of GOKK and may not be copied, altered or reproduced in any way or passed to a third party without written permission from GOKK.
5. The main contractor should be conversant with the statutory obligations under the provisions of the Building Regulations 2010.
6. The dimensions shown on the drawing have been based on the measurements provided by an independent survey company.

SCHEDULES FOR REFERENCE

1. Refer to V&K for the lighting layout and schedule
2. Refer to GOKK for Lighting schedule
3. Refer to Vector for Small Power layout and schedule
4. Refer to Sanitary International for AV layout and schedules
5. Refer to GOKK for Sanitaryware schedule
6. Refer to GOKK for Homogeneity schedule
7. Refer to GOKK for Mairle and Javery schedules
8. Refer to GOKK for Specialist Paintwork schedule
9. Refer to GOKK for Soft Furnishings schedule
9. Refer to M&S Specification

WITANHURST CONSTRUCTION

MANAGEMENT LTD.
THE GATEHOUSE,
41 HIGHGATE WEST HILL,
LONDON, N6 6LS.
Tel: 0207 209 5175 Fax: 0207 209 5407
Email: admin@witanhurst.com

Status:
PLANNING

Project:
WITANHURST HOUSE
41 HIGHGATE WEST HILL,
HIGHGATE,
LONDON, N6 6LS.

Title:
B02-B03-B07 ELEVATIONS

Date: 13-06-13	Drawing No.:	Rev:
Scale: 1:20	601-P-1147	000