

LEGEND


Door Nos. are circular
Window Nos. are hexagonal
Room Nos. are rectangular

Fireplace Nos. are triangular
The room, door and window numbering system is as follows:

Doors	24	D	8	E	01
Windows	25	W	G	E	02
Rooms	24	R	1	P	03
Fireplaces	24	F			01

Floor Codes
B - Basement
G - Ground
J - First
2 - Second
3 - Third
4 - Roof

N.B. For information on the following items please refer to these drawings:
(00) Existing
(10) Demolition
(99) Proposed

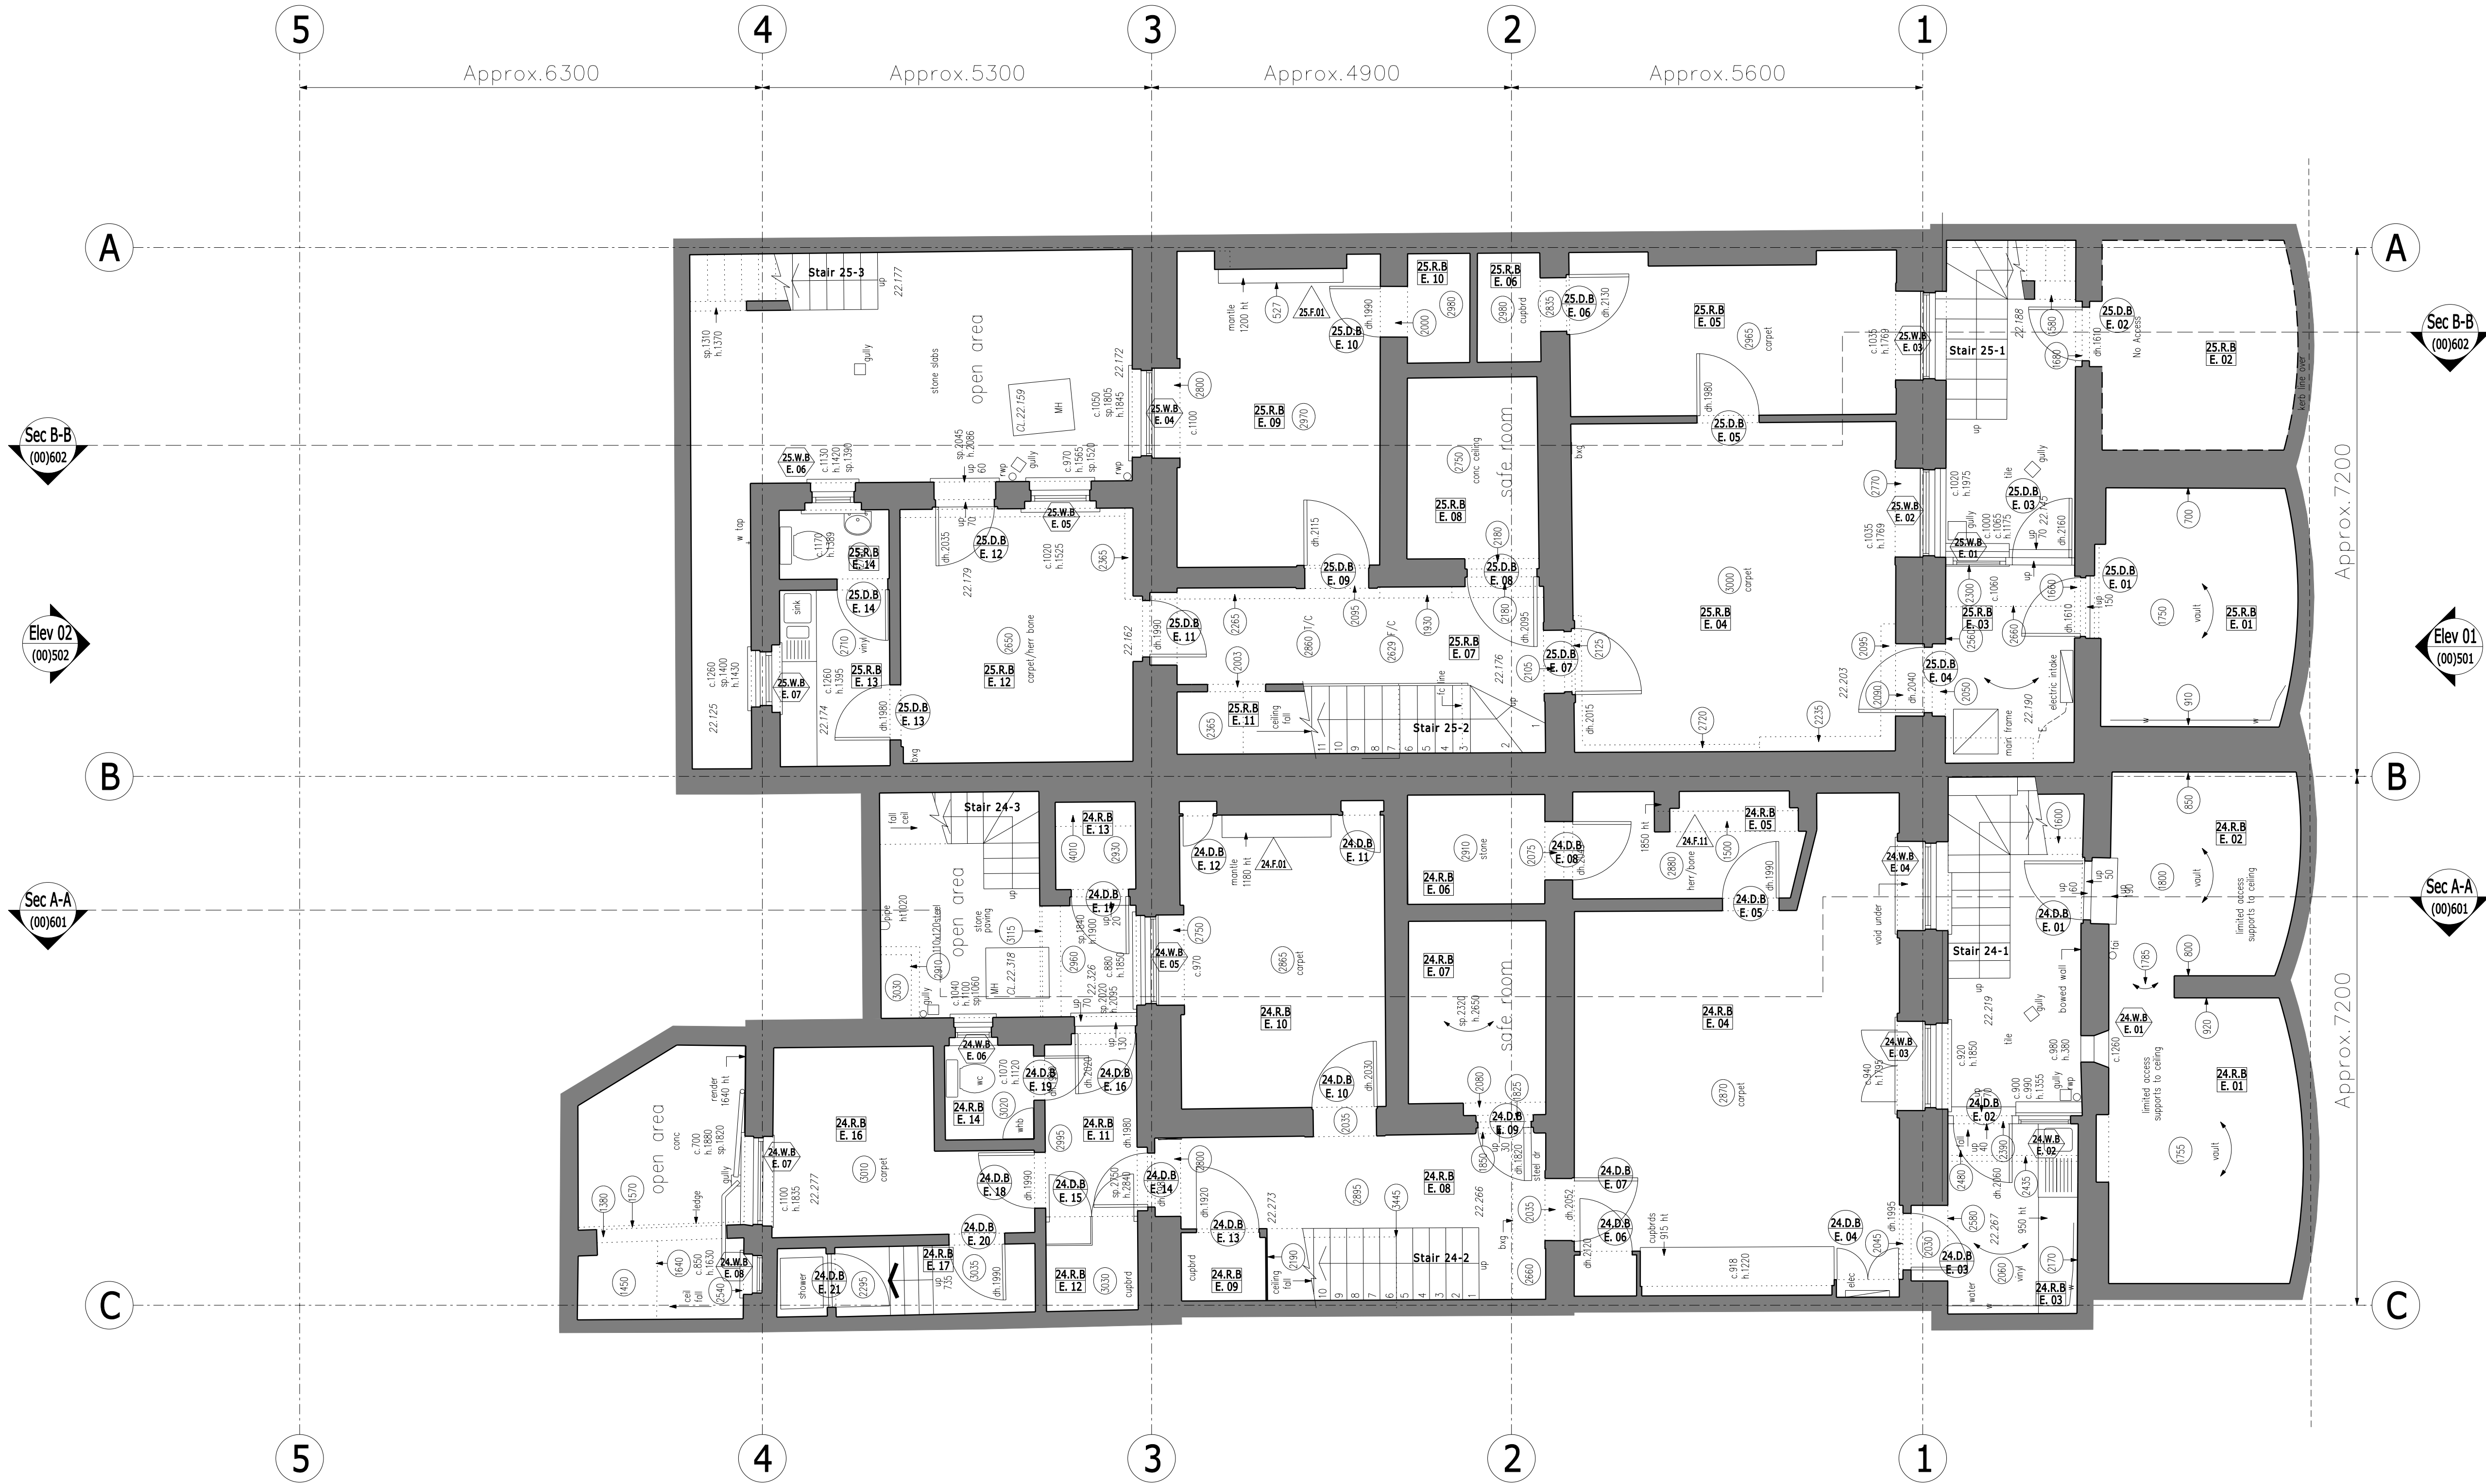

SURVEY KEY

AB alarm bell	H cill to head height
BGP break glass point	IC inspection cover
BK brick	LP lamp post
BT british telecom	MH manhole
C concrete	RS road sign
C/B chain link	RSJ rolled steel joist
CL ceiling level	RSS rolled steel stanton
CK close board	RWP rain water pipe
CL/L chain link	SV stop valve
DK drop kerb	TBM temporary bench mark
DH door height	V vent
FH fire hydrant	VP vent pipe
FHR fire hose reel	WP waste pipe
FL false ceiling	WHB wash hand basin
FL floor level	WM water meter
GV gas valve	WSC water stop cock

All levels are in metres and are related to the Ordnance Survey Bench Mark located Entrance gate british museum Left Hand pier Value 26.29m

Level positions are indicated by either a cross or by the decimal point.

Drainage

CL cover level	NVC no visible connection
IL invert level	UTL unable to lift
_____ foul water run	
_____ storm water run	

all drainage should be checked on site before using information

Drawing Title
**Existing
Basement Floor Plan**

Status

Date 20.01.11 Sheet By DW Scale @ Size 1:50@A1

Job Number 3686 Code (00) Drawing Number B01 Rev B

DLG Architects LLP
11-29 Fashion Street
London E1 6PZ

t +44(0)20 7426 3630
f +44(0)20 7426 3631
london@dlgarchitects.com

dlgarchitects.com

