



Taylor Project Services LLP

**11 Gower Street
London, WC1B 3HB**

PLANNING STAGE

Mechanical Services



THE BEDFORD ESTATES

Revision O

February 2013

Taylor Project Services LLP
No1 Cornhill
London EC3V 3ND
Tele: 020 7743 6602


GENERAL NOTES



VRV UNIT POSITION



ELECTRIC HEATER

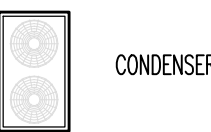



CONDENSER



REFRIGERANT PIPEWORK RUN



VRV UNIT BS BOX

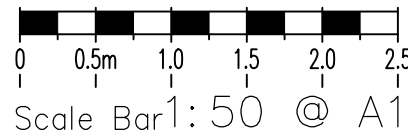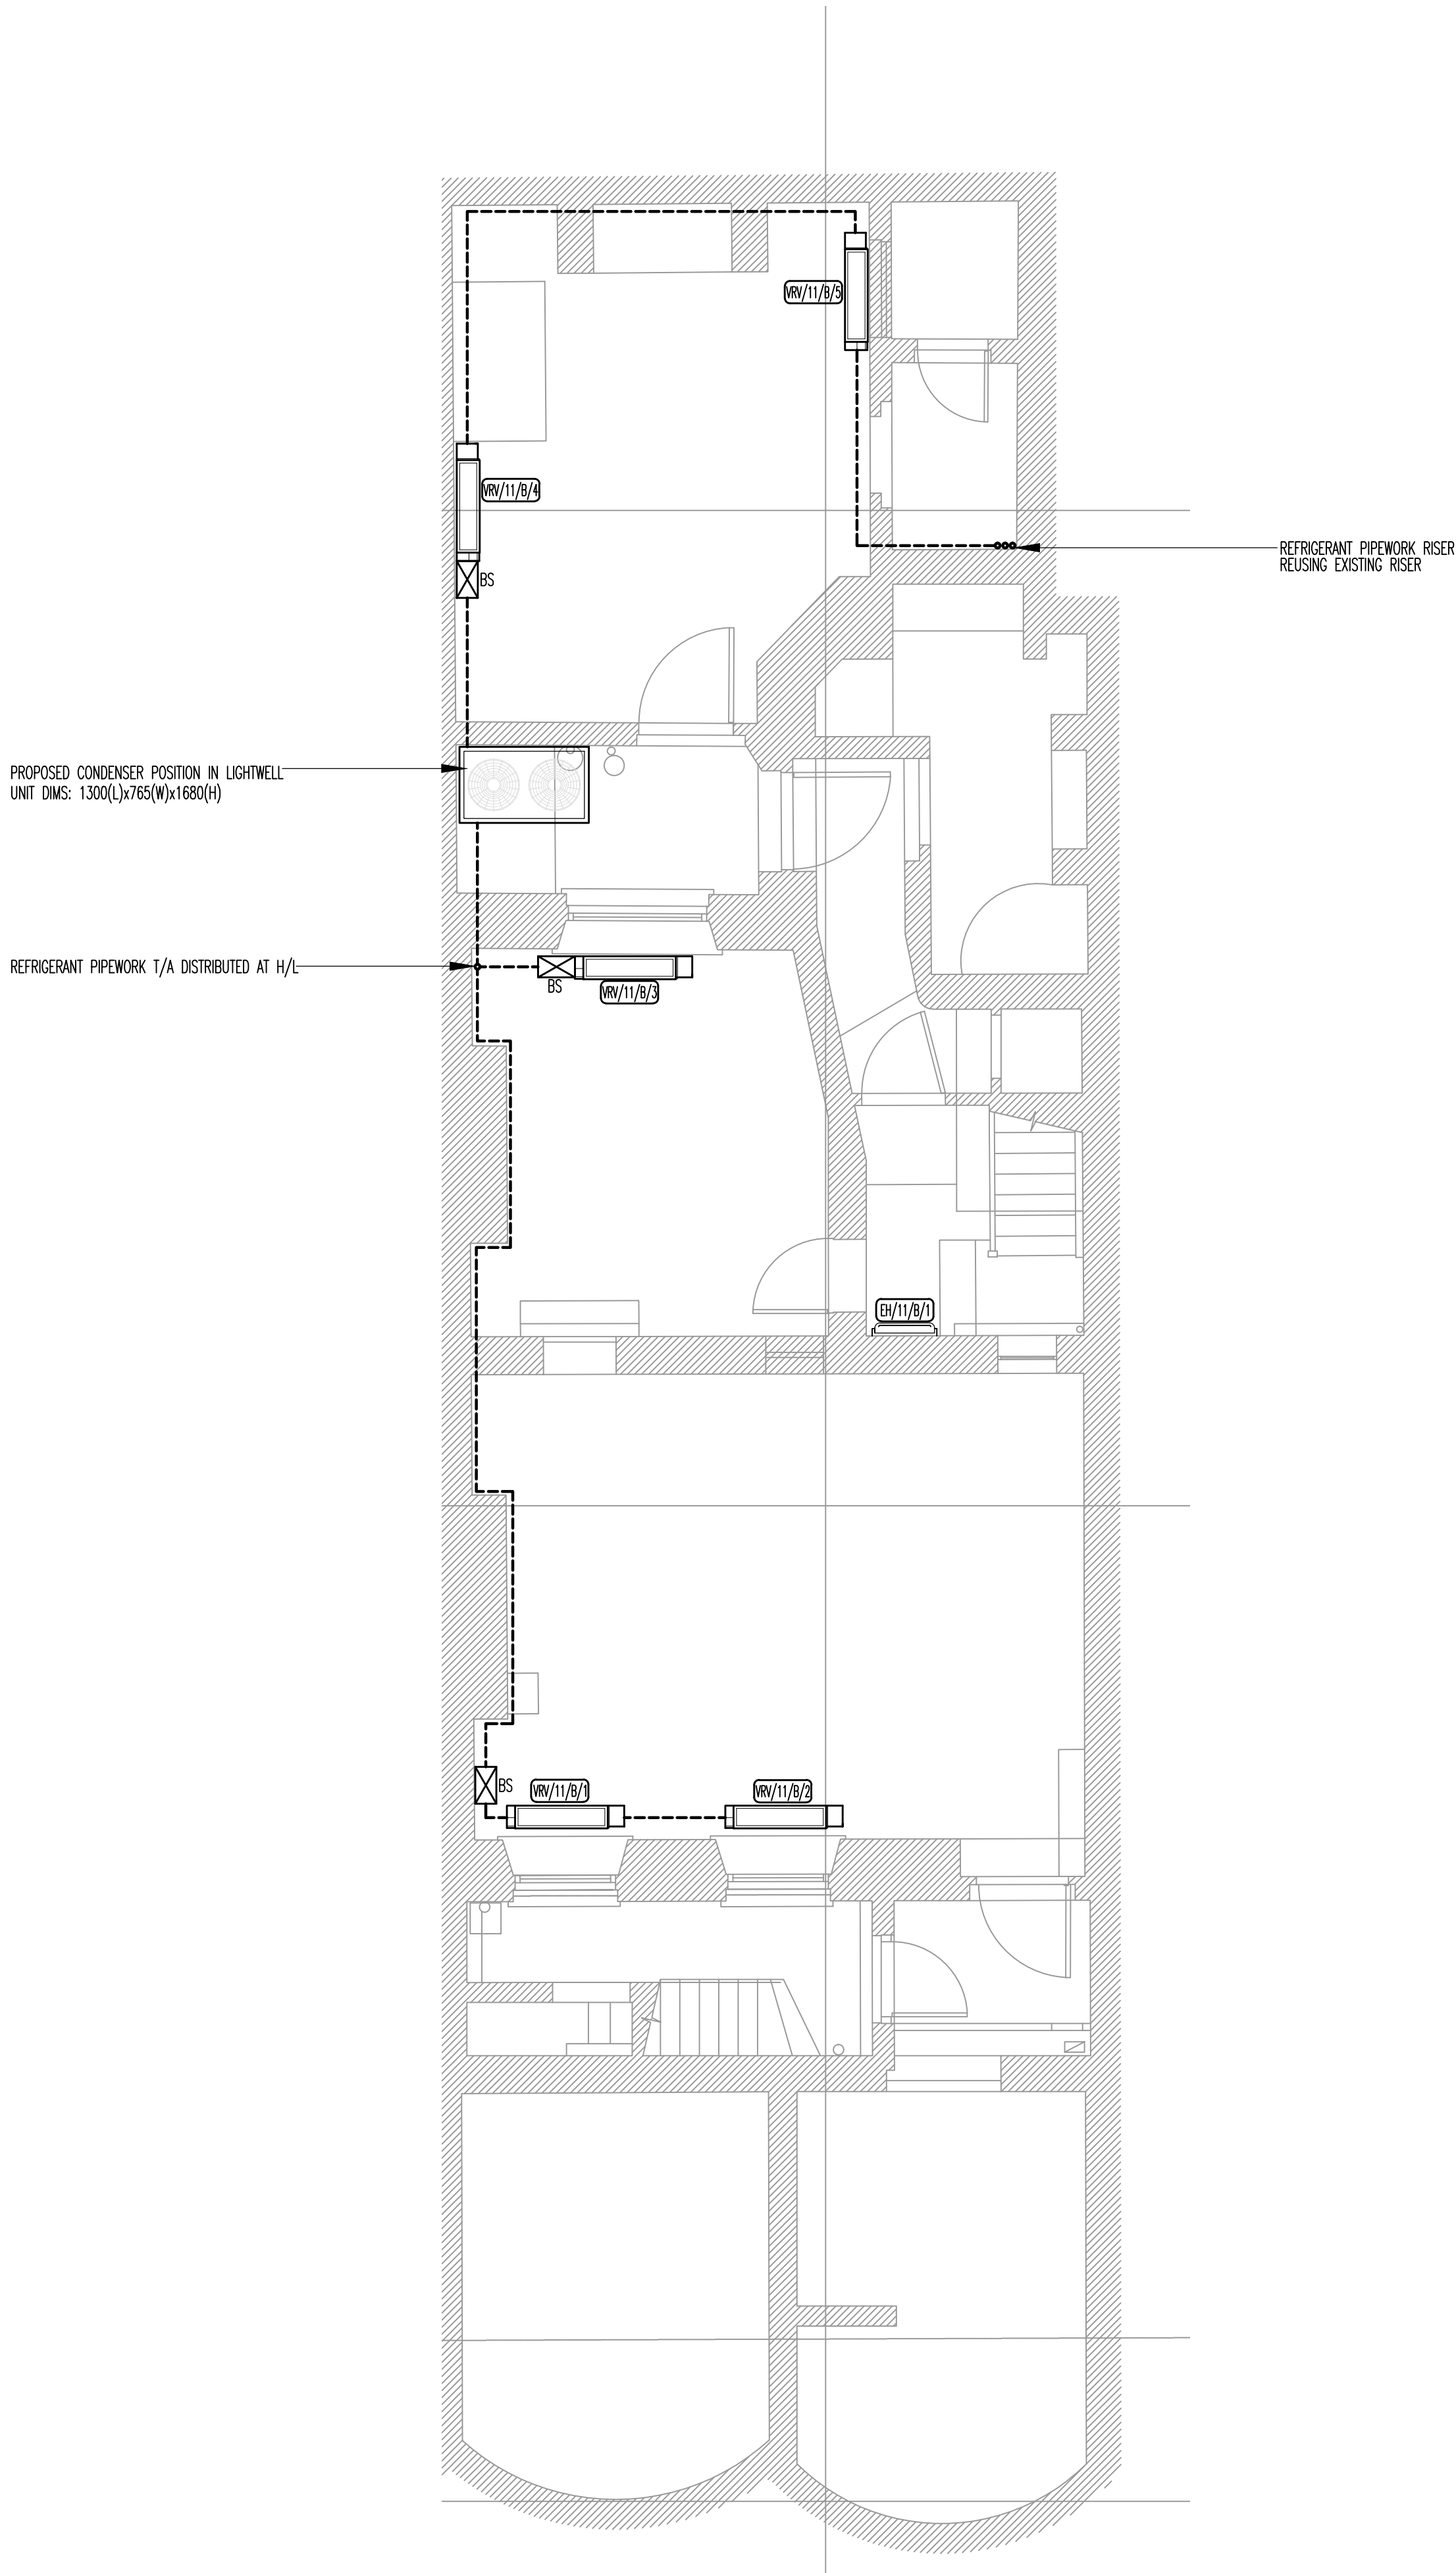

PLANNING

0	FEB.13	PLANNING ISSUE
Rev	Date	Description

TPS

Taylor Project Services LLP

No.1 Cornhill
London EC3V 3ND
Tel 020 7743 6602
www.taylorprojectservices.com

Client:



**THE
BEDFORD
ESTATES**

29a Montague Street
London
WC1B 5SL
Tel: 0171 406 2865
Fax: 0171 255 1729

Project

11 GOWER STREET
LONDON
WC1

Drawing Title

BASEMENT LEVEL
PROPOSED
VRV POSITIONS

Scale	1:50 © A1	Date	07.02.13
Drawn	L.R.	Checked	G.N.T.

Drawing Status

PLANNING



Revision	0																		
----------	---	--	--	--	--	--	--	--	--	--	--	--	--	--	--	--	--	--	--

Drawing No.

TPS/11GS/B/VRV/P

TO BE STRIPPED OUT

RADIATOR

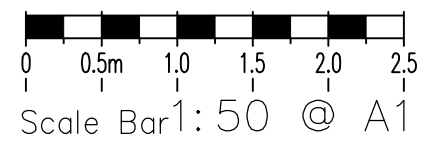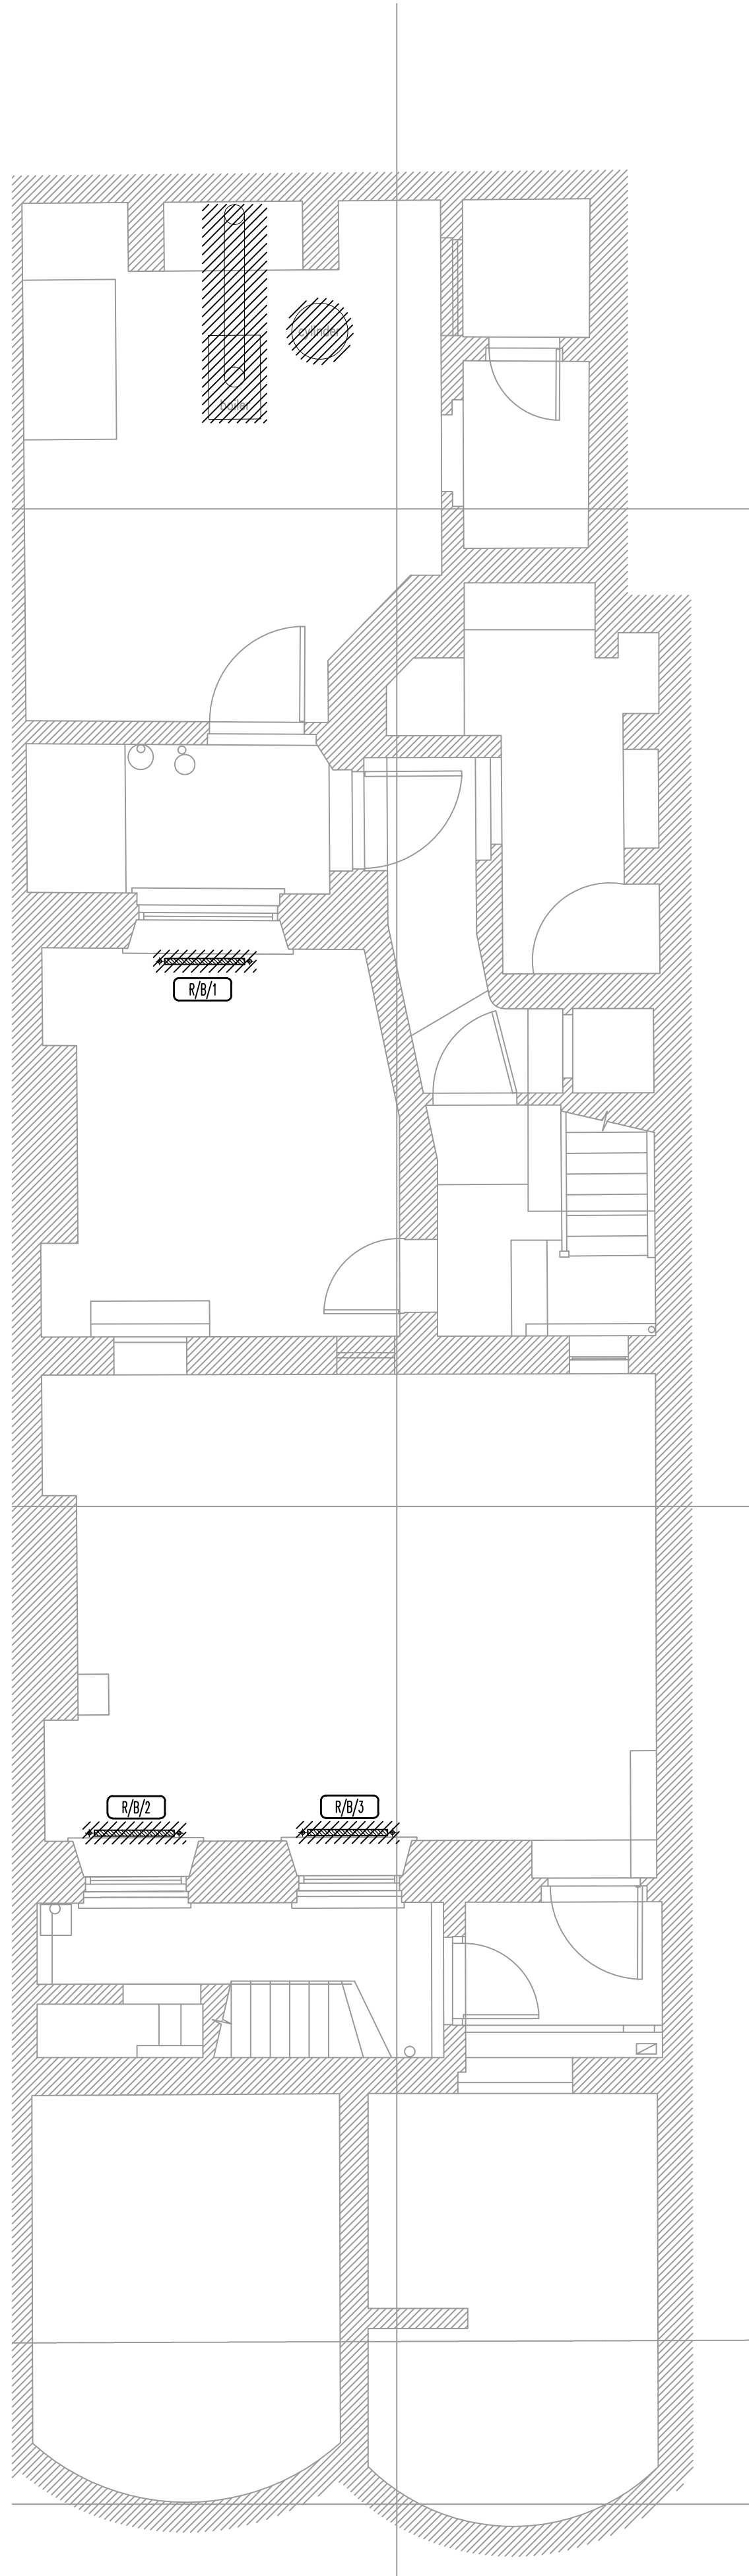

0	FEB.13	PLANNING ISSUE
Rev	Date	Description

Taylor Project Services LLP

No.1 Cornhill
London EC3V 3ND
Tel 020 7743 6602
www.taylorprojectservices.com

Client:



THE
BEDFORD
ESTATES

Montague Street
London
WC1B 5BL
Tel: 0171 636 2885
Fax: 0171 255 1729

Project

11 GOWER STREET
LONDON
WC1

Drawing Title

BASEMENT LEVEL
EXISTING SERVICES LAYOUT

Scale 1:50 @ A1

07.02.13

Drawn L.R.

G.N.T.

Drawing Status

PLANNING

Revision	0	
----------	---	--

Drawing No.

TPS/11GS/B/E

 
GENERAL NOTES



VRV UNIT POSITION



ELECTRIC HEATER





CONDENSER



REFRIGERANT PIPEWORK RUN



VRV UNIT BS BOX

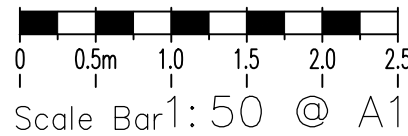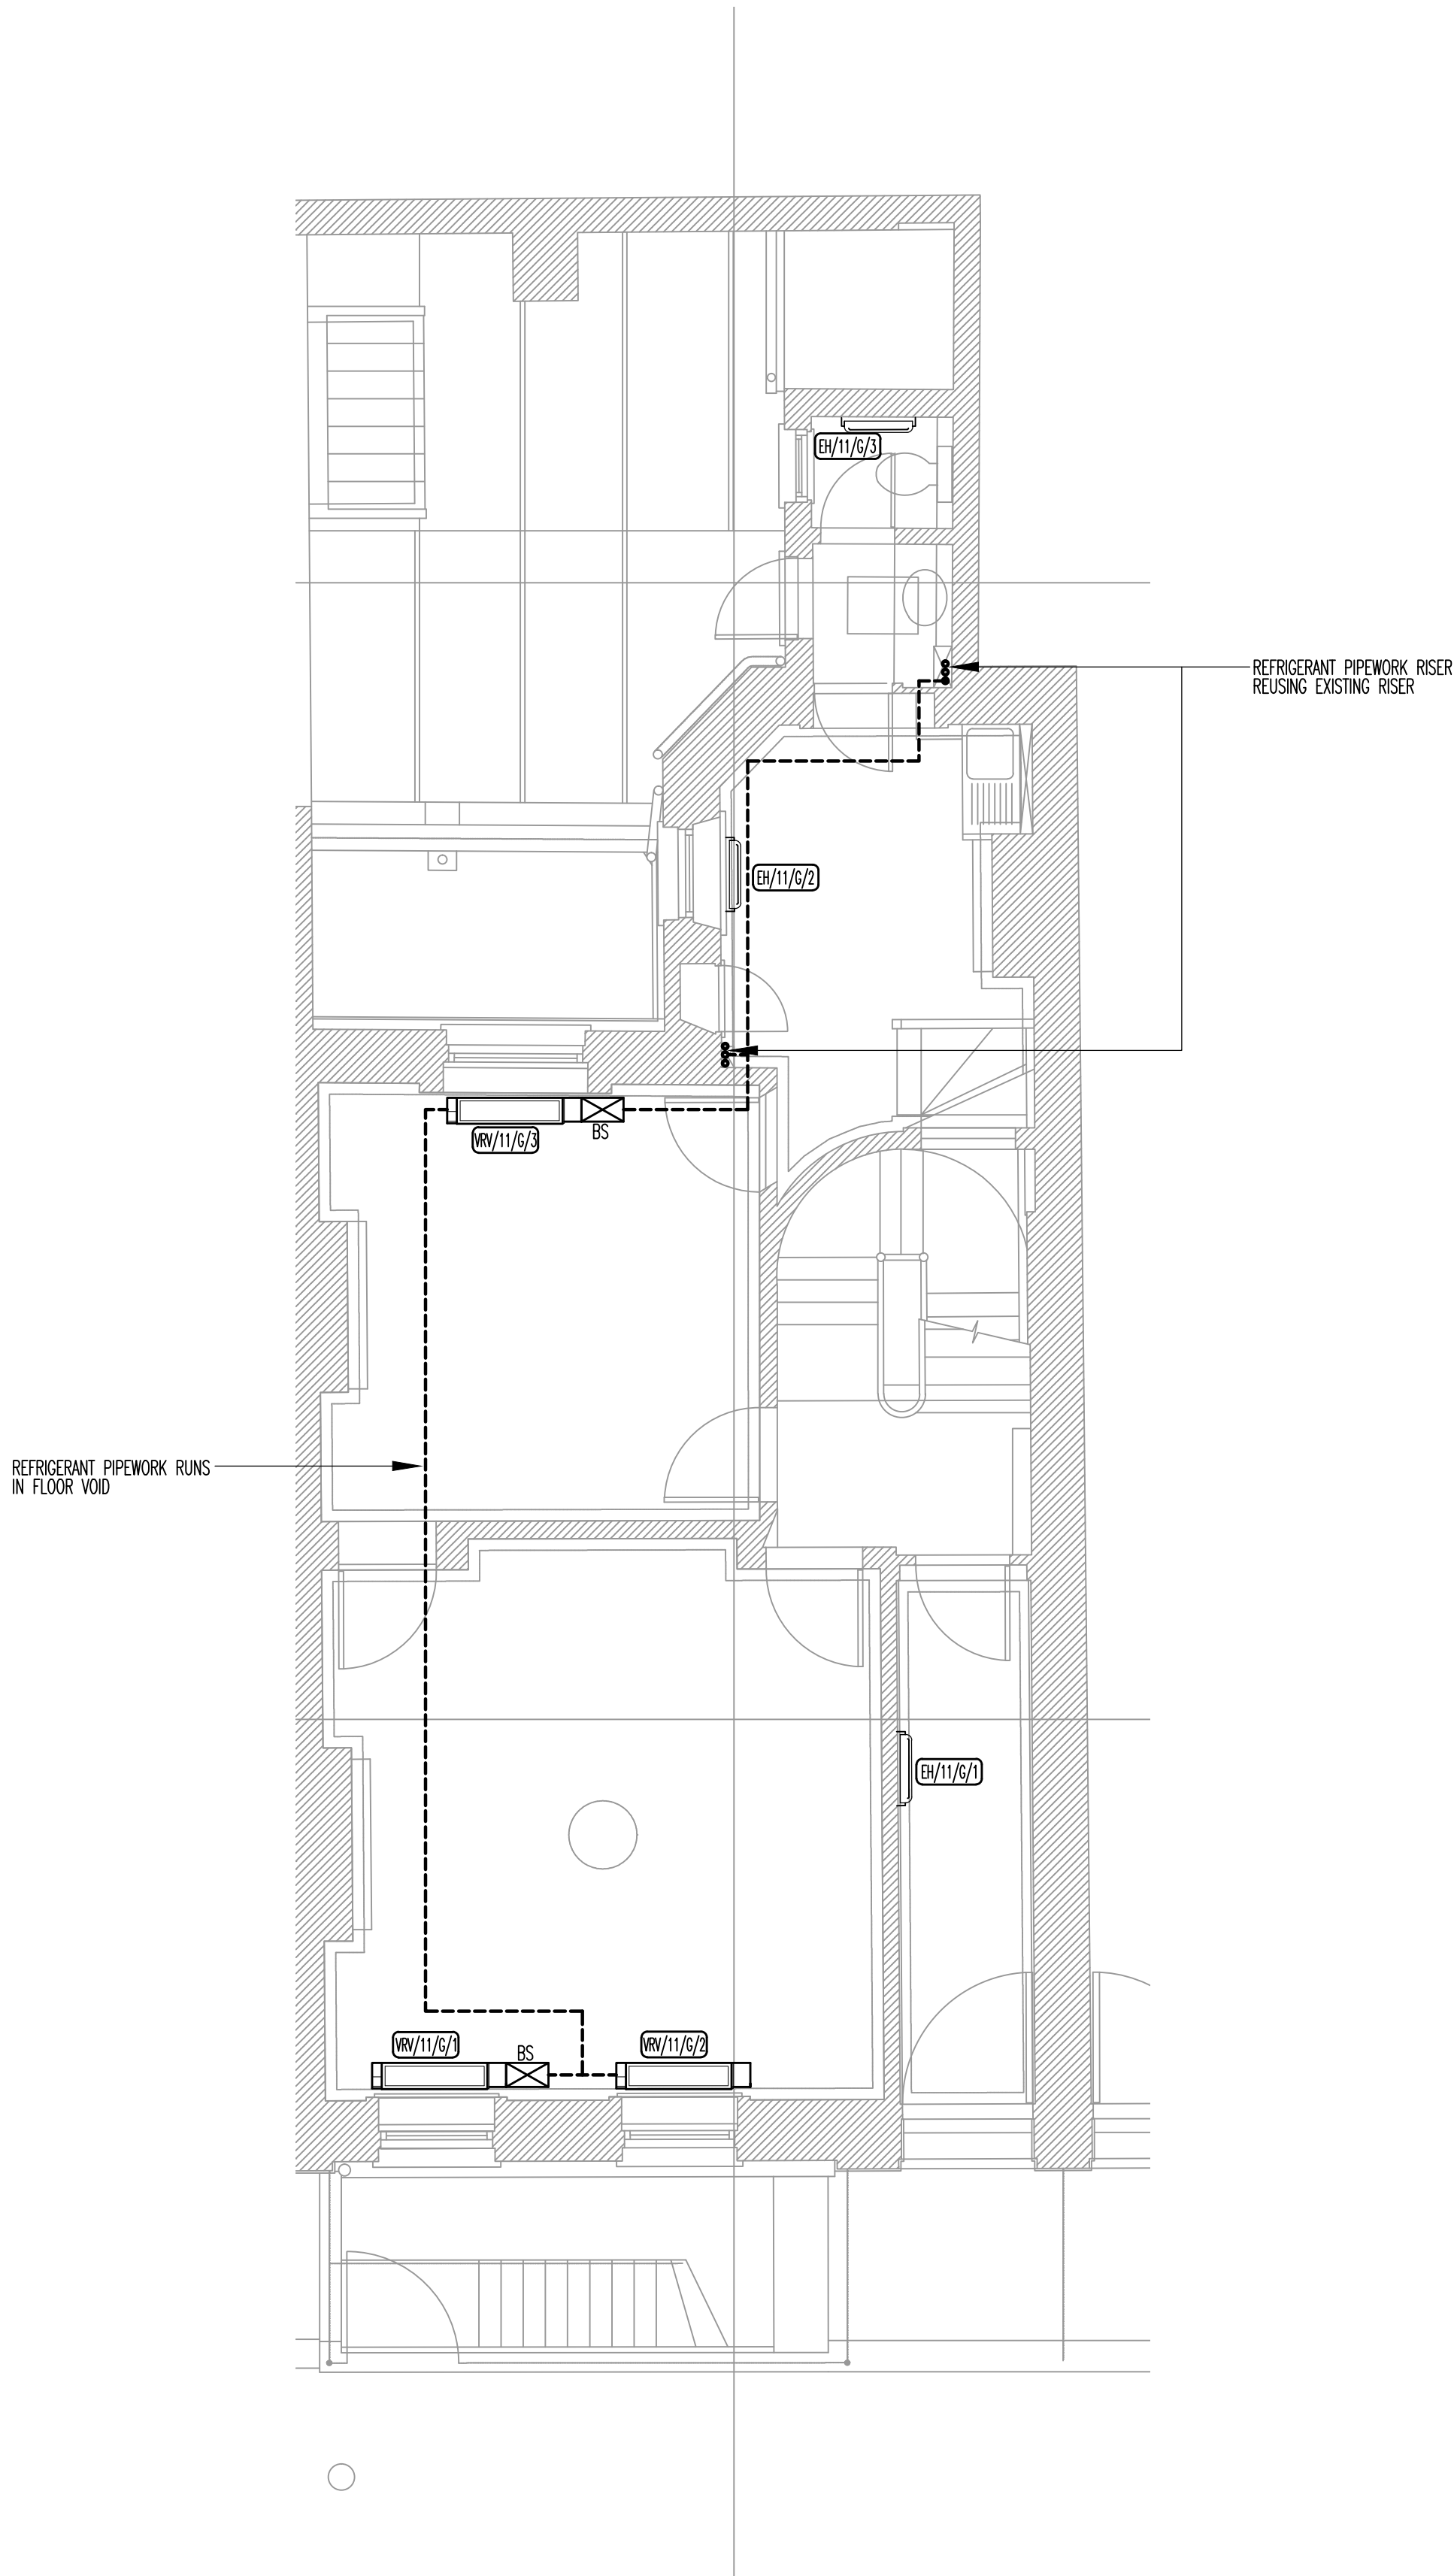

PLANNING

0	FEB.13	PLANNING ISSUE
Rev	Date	Description

TPS

Taylor Project Services LLP

No.1 Cornhill
London EC3V 3ND
Tel 020 7743 6602
www.taylorprojectservices.com

Client:



**THE
BEDFORD
ESTATES**

29a Montague Street
London
WC1B 5SL
Tel: 0171 406 2865
Fax: 0171 255 1729

Project

11 GOWER STREET
LONDON
WC1

Drawing Title

GROUND FLOOR
PROPOSED
VRV POSITIONS

Scale	1:50 © A1	Date	07.02.13
Drawn	L.R.	Checked	G.N.T.

Drawing Status

PLANNING

Revision	0																		
----------	---	--	--	--	--	--	--	--	--	--	--	--	--	--	--	--	--	--	--


Drawing No.

TPS/11GS/G/VRV/P


THIS DRAWING MUST NOT BE REPRODUCED WITHOUT PRIOR CONSENT.
DO NOT SCALE FROM THIS DRAWING.
THIS DRAWING IS COPYRIGHT. ©

GENERAL NOTES

TO BE STRIPPED OUT



RADIATOR

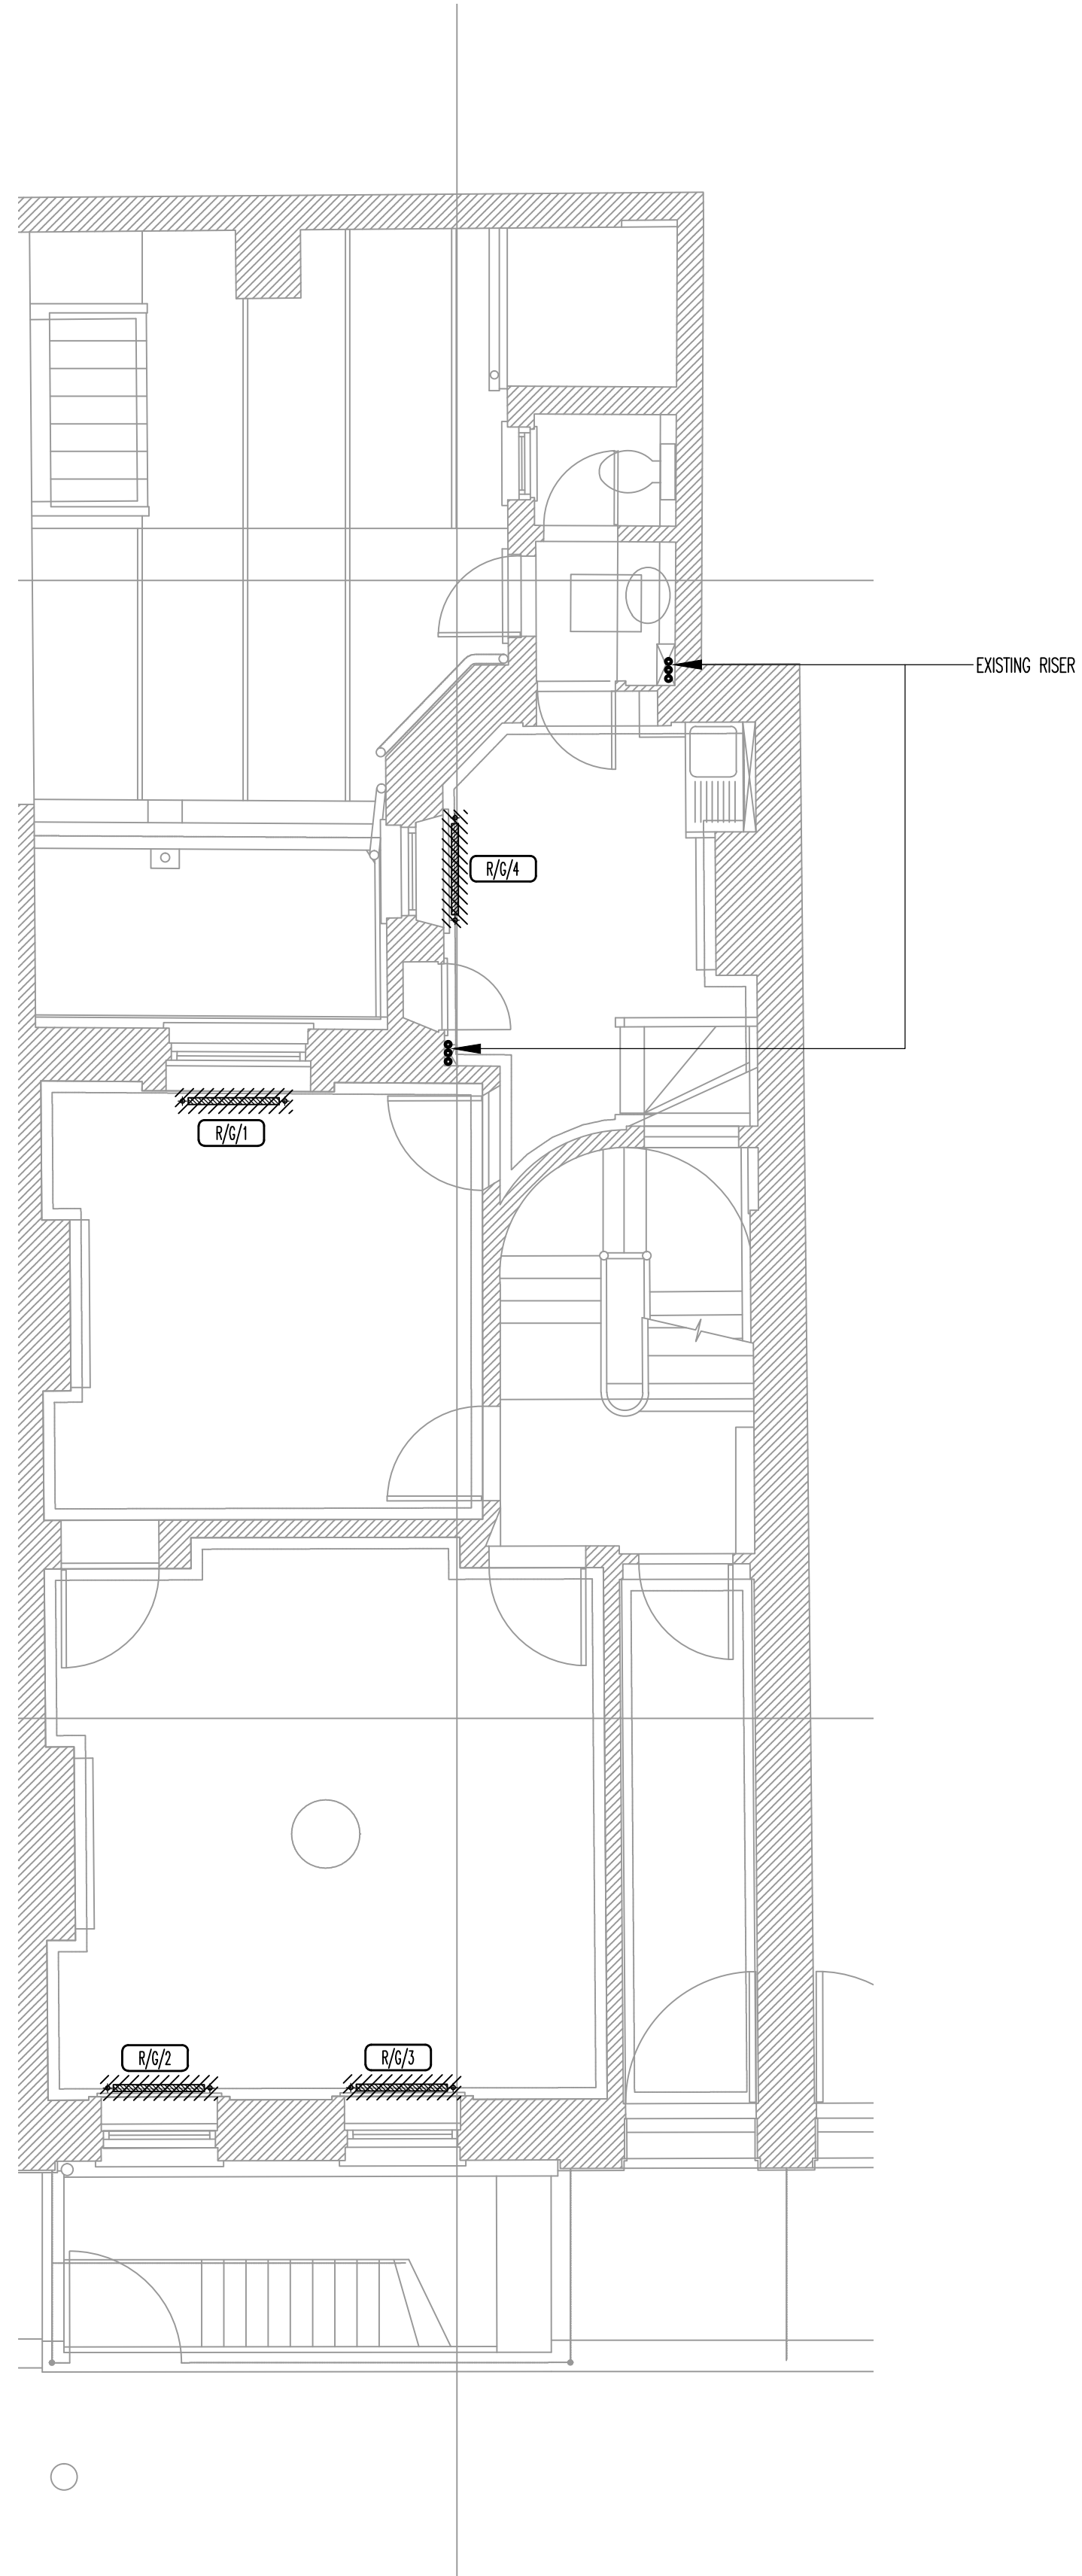

PLANNING

0	FEB.13	PLANNING ISSUE
Rev	Date	Description

TPS

Taylor Project Services LLP

**No.1 Cornhill
London EC3V 3ND
Tel 020 7743 6602
www.taylorprojectservices.com**

Client:



THE
BEDFORD
ESTATES

9a Montague Street
London
WC1B 5BL
Tel: 0171 634 2885
Fax: 0171 255 1729

Project

11 GOWER STREET
LONDON
WC1

Drawing Title

GROUND FLOOR
EXISTING SERVICES LAYOUT

Scale 1:50 @ A1

Date 07.02.13

Drawn L.R.

Checked G.N.T.

Drawing Status


PLANNING

Revision	0	
----------	---	--

[illegible]

Drawing No.

 TPS/11GS/G/E



Scale Bar 1:50 @ A1

GENERAL NOTES



VRV UNIT POSITION



ELECTRIC HEATER





CONDENSER



REFRIGERANT PIPEWORK RUN



VRV UNIT BS BOX

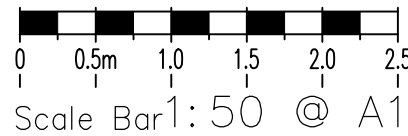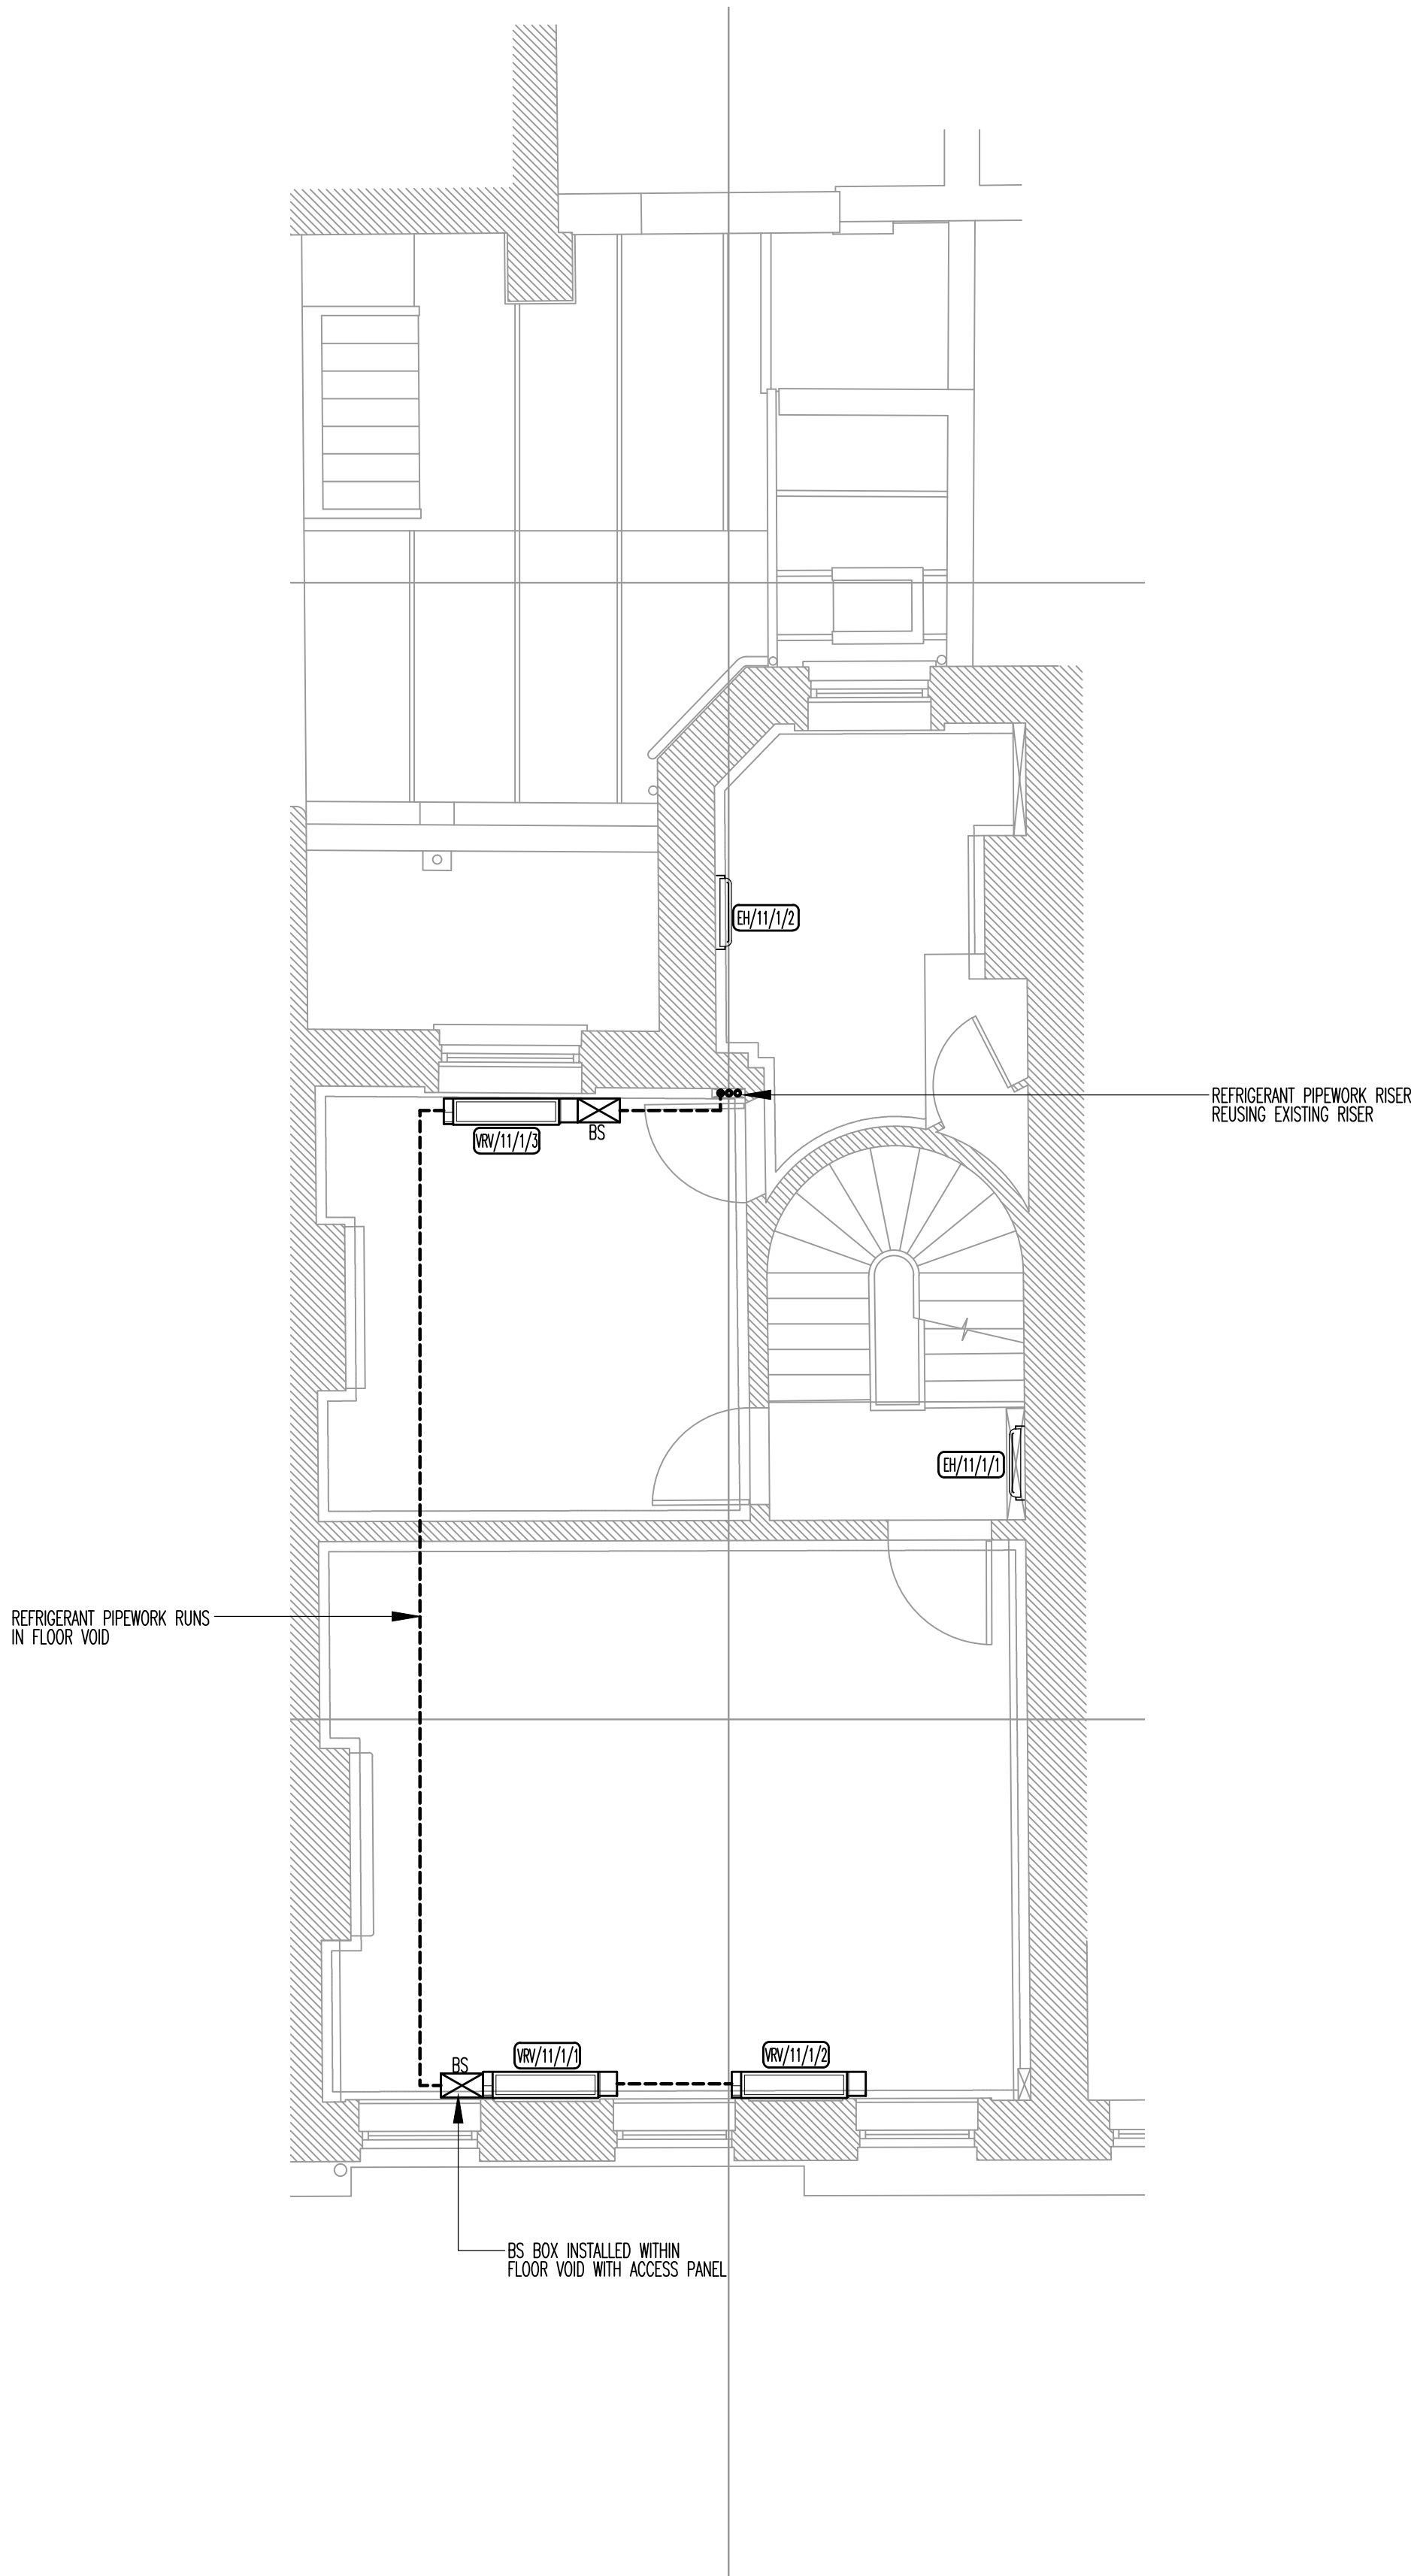

PLANNING

0	FEB.13	PLANNING ISSUE
Rev	Date	Description

TPS

Taylor Project Services LLP

No.1 Cornhill
London EC3V 3ND
Tel 020 7743 6602
www.taylorprojectservices.com

Client:



**THE
BEDFORD
ESTATES**

29a Montague Street
London
WC1B 5PL
Tel: 0171 406 2865
Fax: 0171 255 1729

Project
**11 GOWER STREET
LONDON
WC1**



Drawing Title
**FIRST FLOOR
PROPOSED
VRV POSITIONS**

Scale	1:50 © A1	Date	07.02.13
Drawn	L.R.	Checked	G.N.T.

Drawing Status
PLANNING

Revision	0																		
----------	---	--	--	--	--	--	--	--	--	--	--	--	--	--	--	--	--	--	--

Drawing No.
TPS/11GS/1/VRV/P

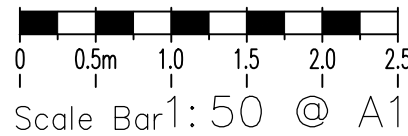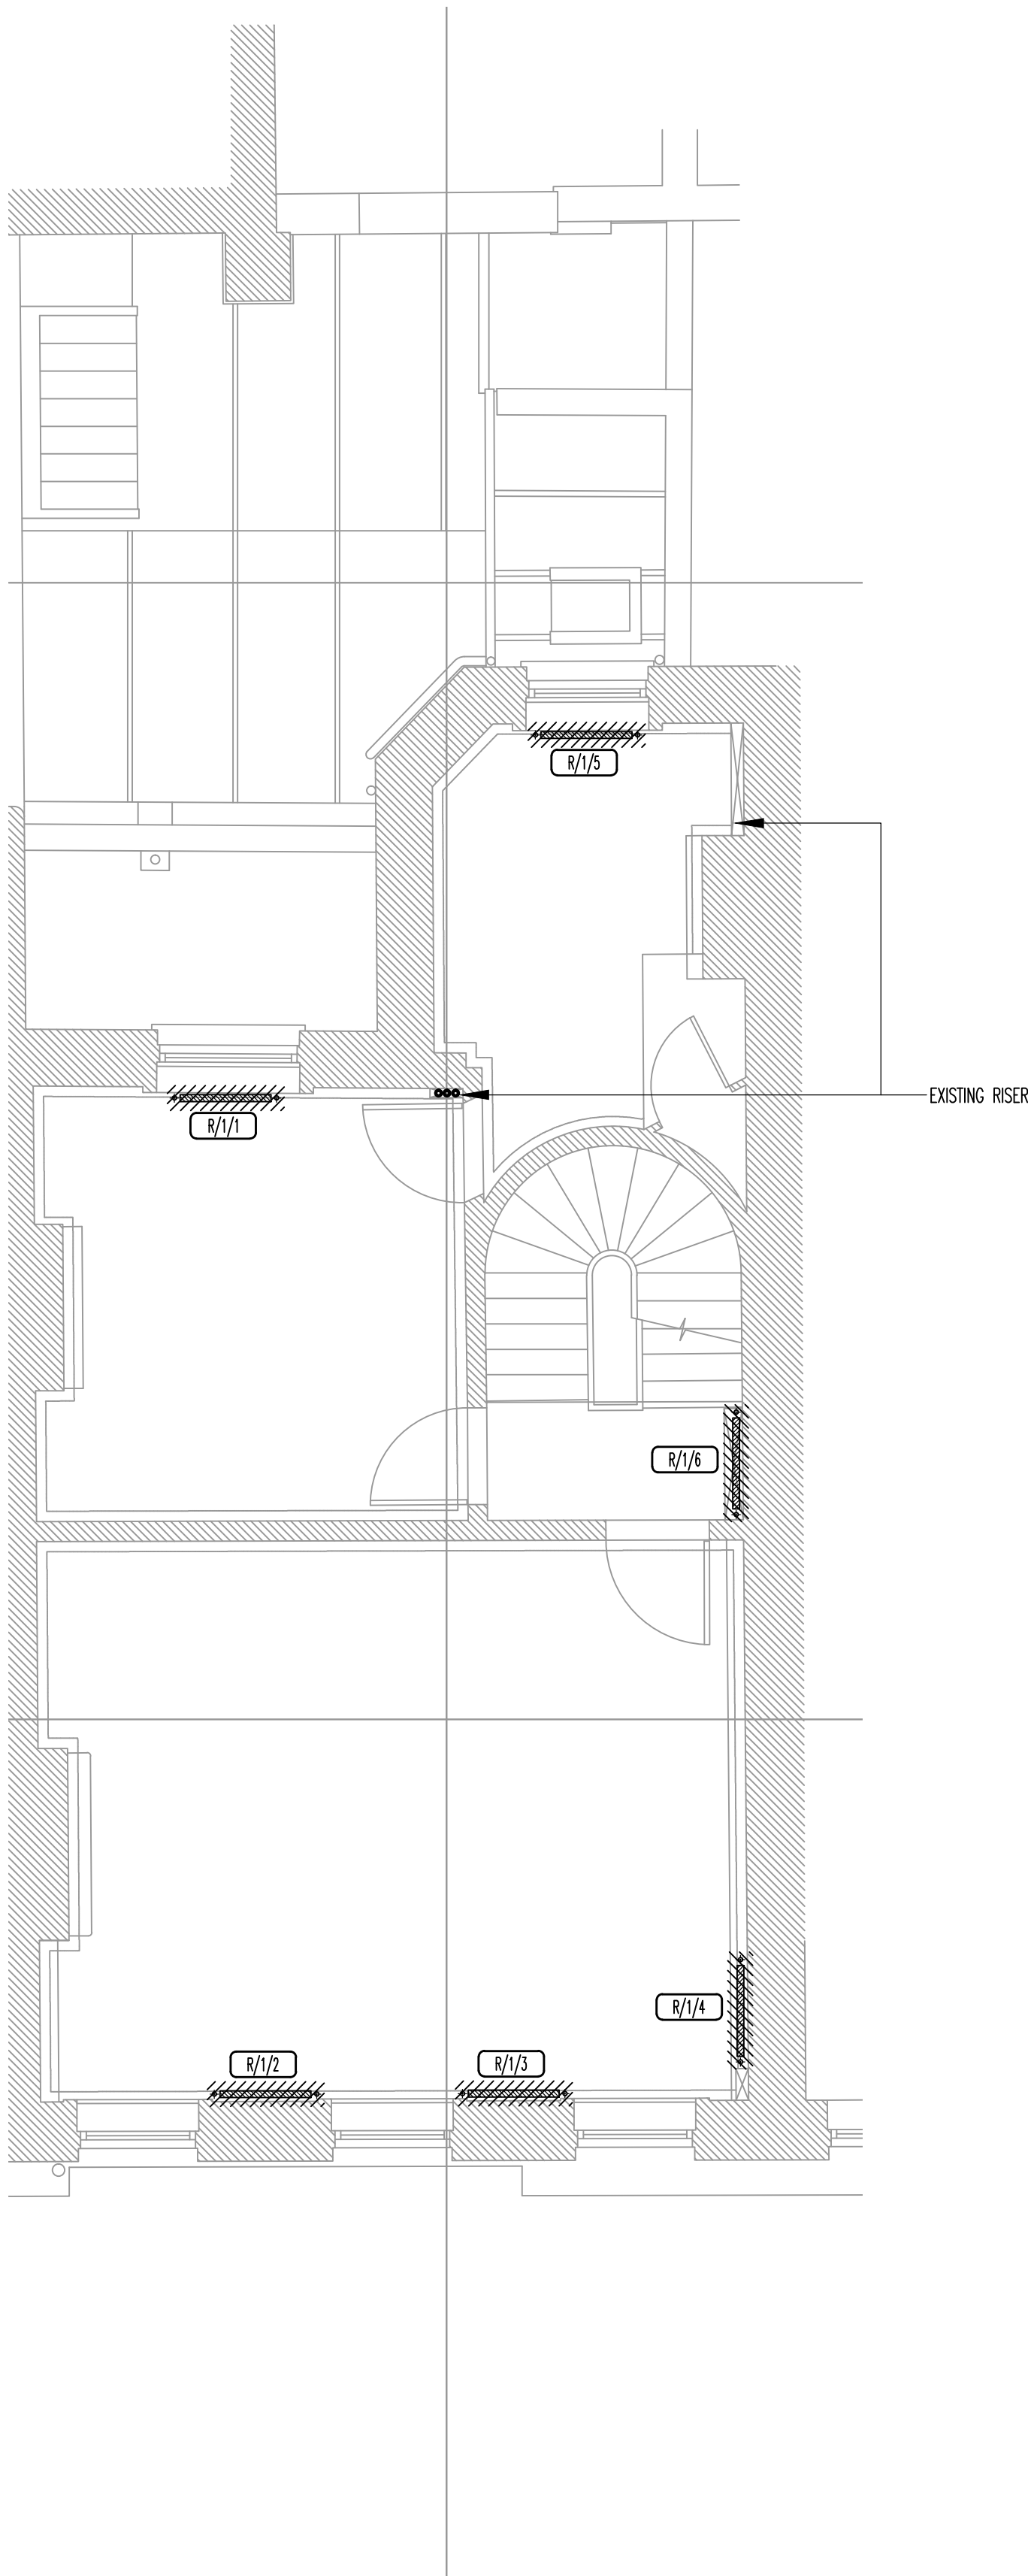

THIS DRAWING MUST NOT BE REPRODUCED WITHOUT PRIOR CONSENT.
DO NOT SCALE FROM THIS DRAWING.
THIS DRAWING IS COPYRIGHT. ©

GENERAL NOTES

TO BE STRIPPED OUT

RADIATOR

PLANNING

0	FEB.13	PLANNING ISSUE
Rev	Date	Description

TPS

Taylor Project Services LLP

No.1 Cornhill
London EC3V 3ND
Tel 020 7743 6602
www.taylorprojectservices.com

Client:

THE BEDFORD ESTATES

29a Montague Street
London
WC1B 5PL
Tel: 0171 406 2865
Fax: 0171 255 1729

Project

11 GOWER STREET
LONDON
WC1

Drawing Title

FIRST FLOOR
EXISTING SERVICES LAYOUT

Scale	1:50 © A1	Date	07.02.13
Drawn	L.R.	Checked	G.N.T.
Drawing Status			
PLANNING			
Revision	0		
Drawing No.			
TPS/11GS/1/E			

GENERAL NOTES



VRV UNIT POSITION



ELECTRIC HEATER




CONDENSER



REFRIGERANT PIPEWORK RUN



VRV UNIT BS BOX

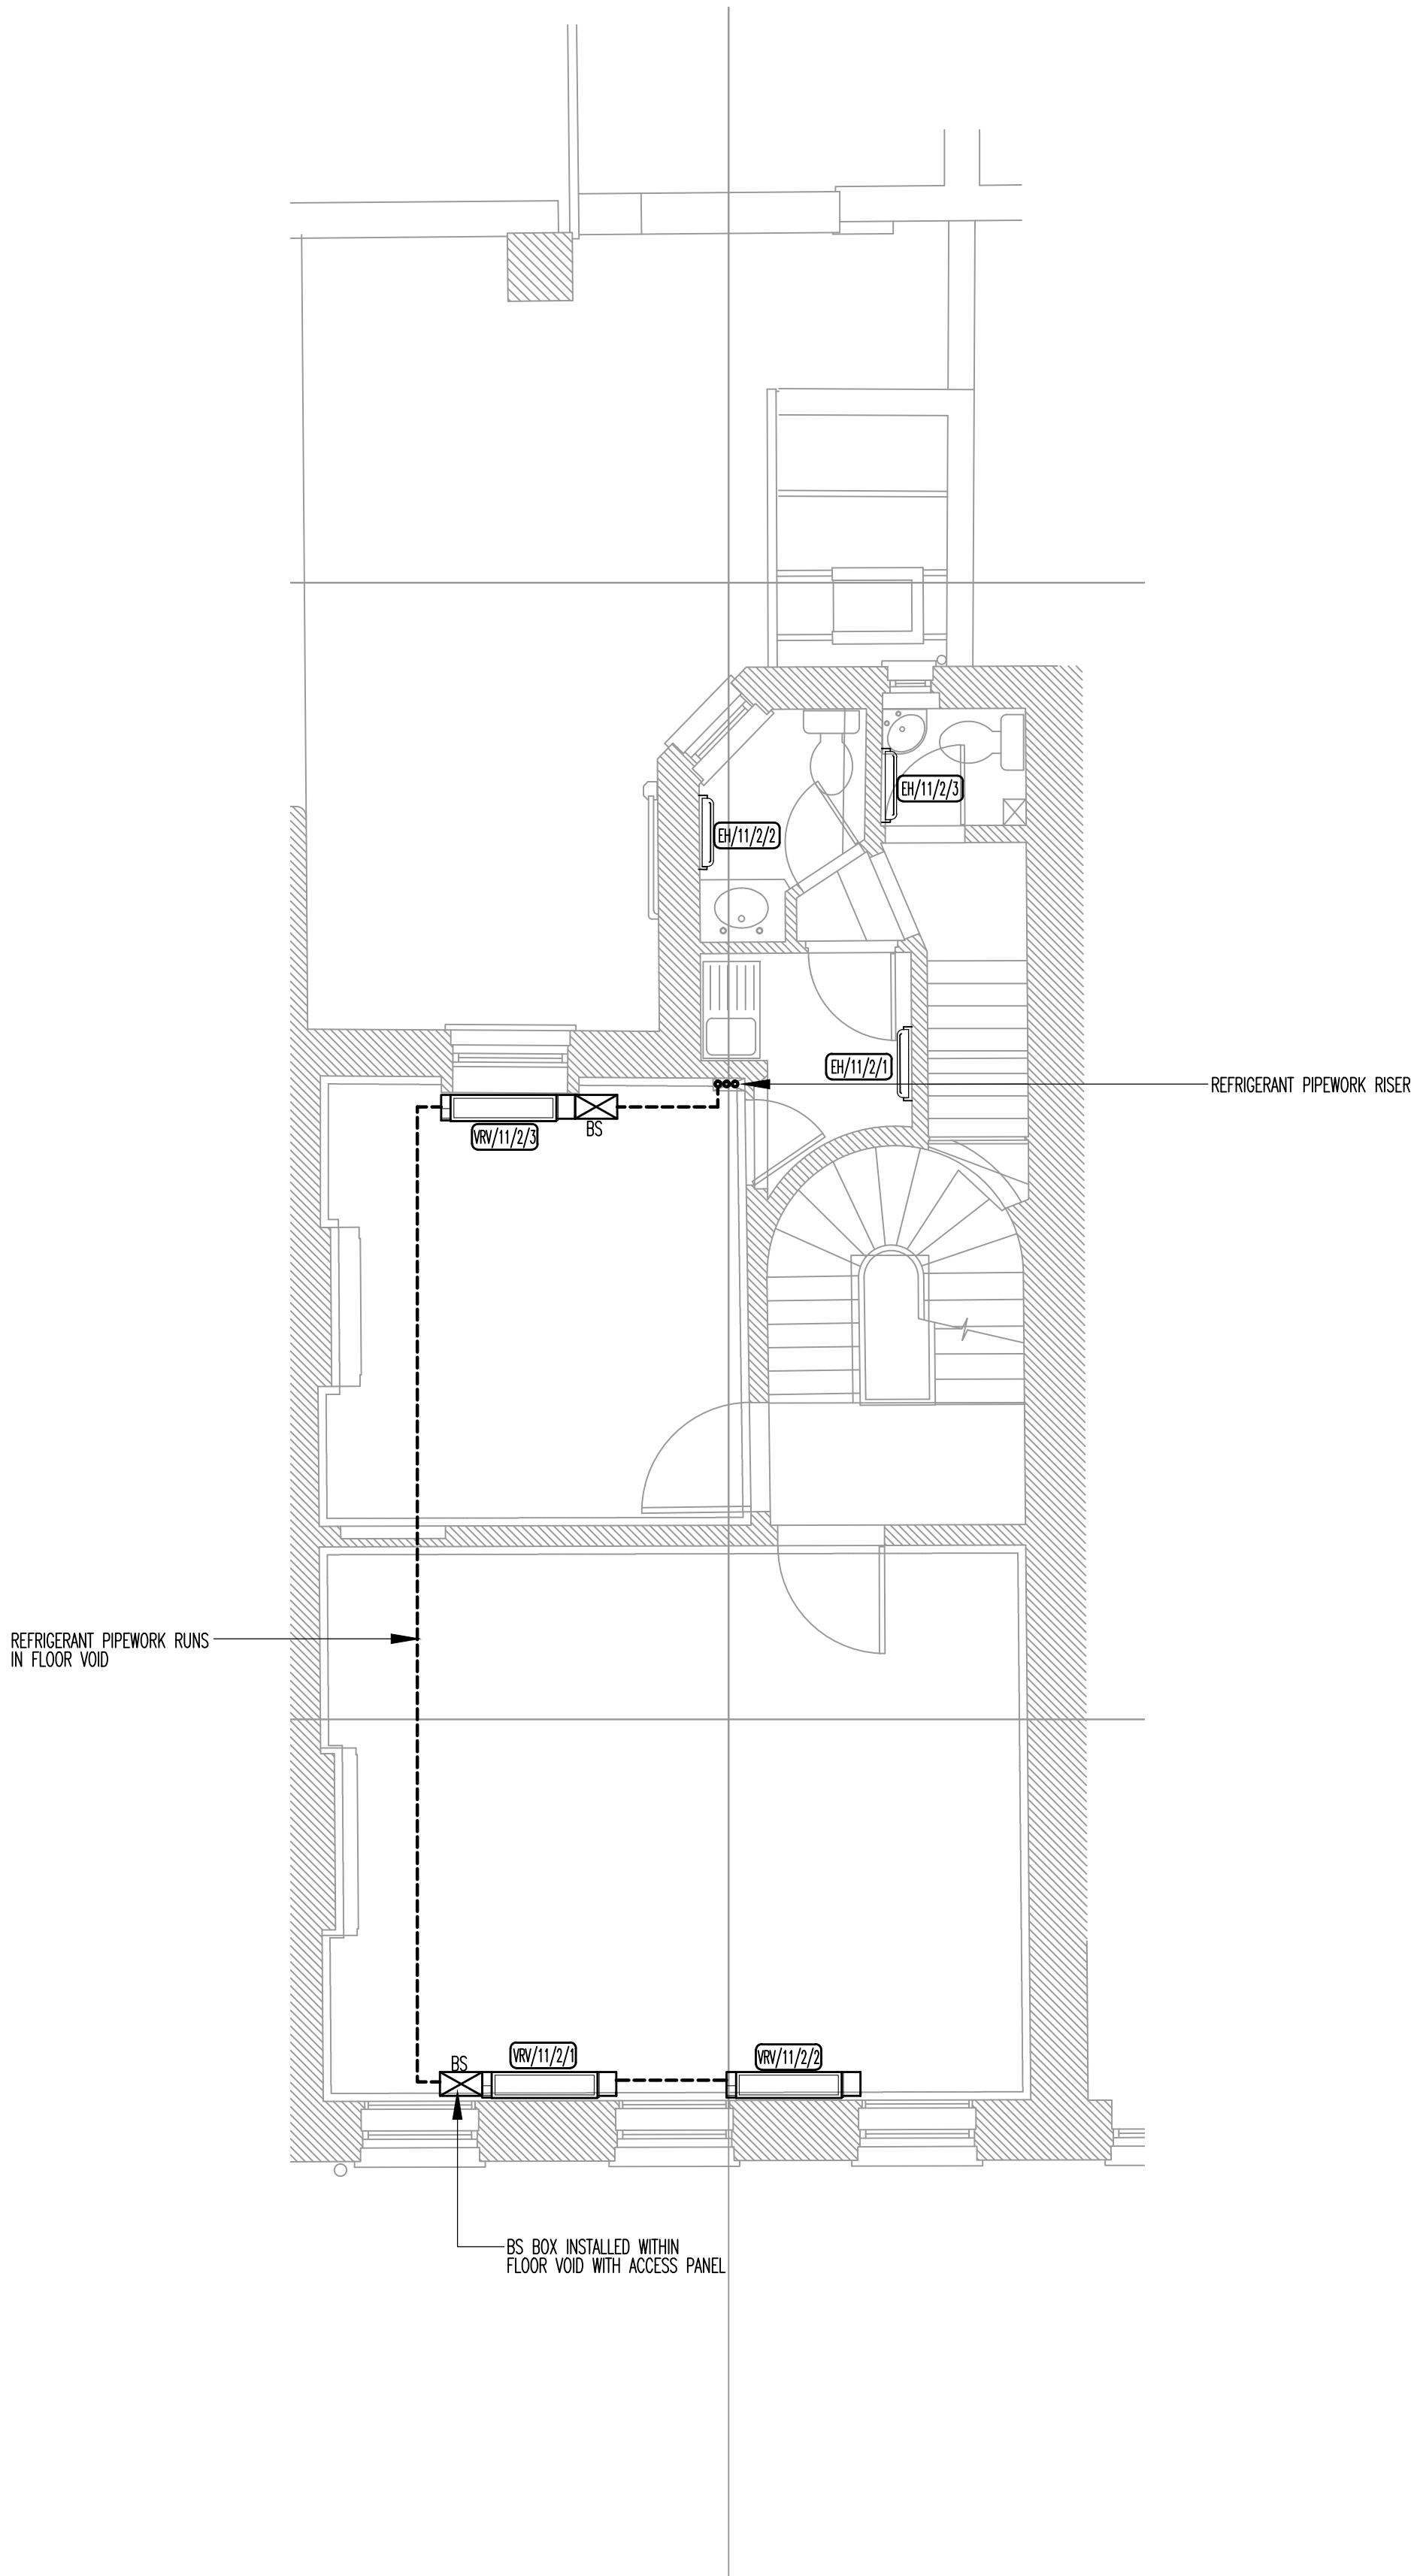

PLANNING

0	FEB.13	PLANNING ISSUE
Rev	Date	Description

TPS

Taylor Project Services LLP

No.1 Cornhill
London EC3V 3ND
Tel 020 7743 6602
www.taylorprojectservices.com

Client:



**THE
BEDFORD
ESTATES**

29a Montague Street
London
WC1B 5PL
Tel: 0171 406 2865
Fax: 0171 255 1729

Project

11 GOWER STREET
LONDON
WC1

Drawing Title

SECOND FLOOR
PROPOSED
VRV POSITIONS

Scale 1:50 @ A1

Date 07.02.13

Drawn L.R.

Checked G.N.T.

Drawing Status



PLANNING

Revision 0

Drawing No.

TPS/11GS/2/VRV/P

0 0.5m 1.0 1.5 2.0 2.5
Scale Bar 1:50 @ A1

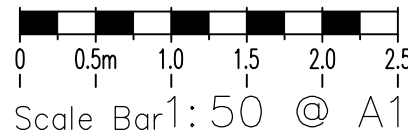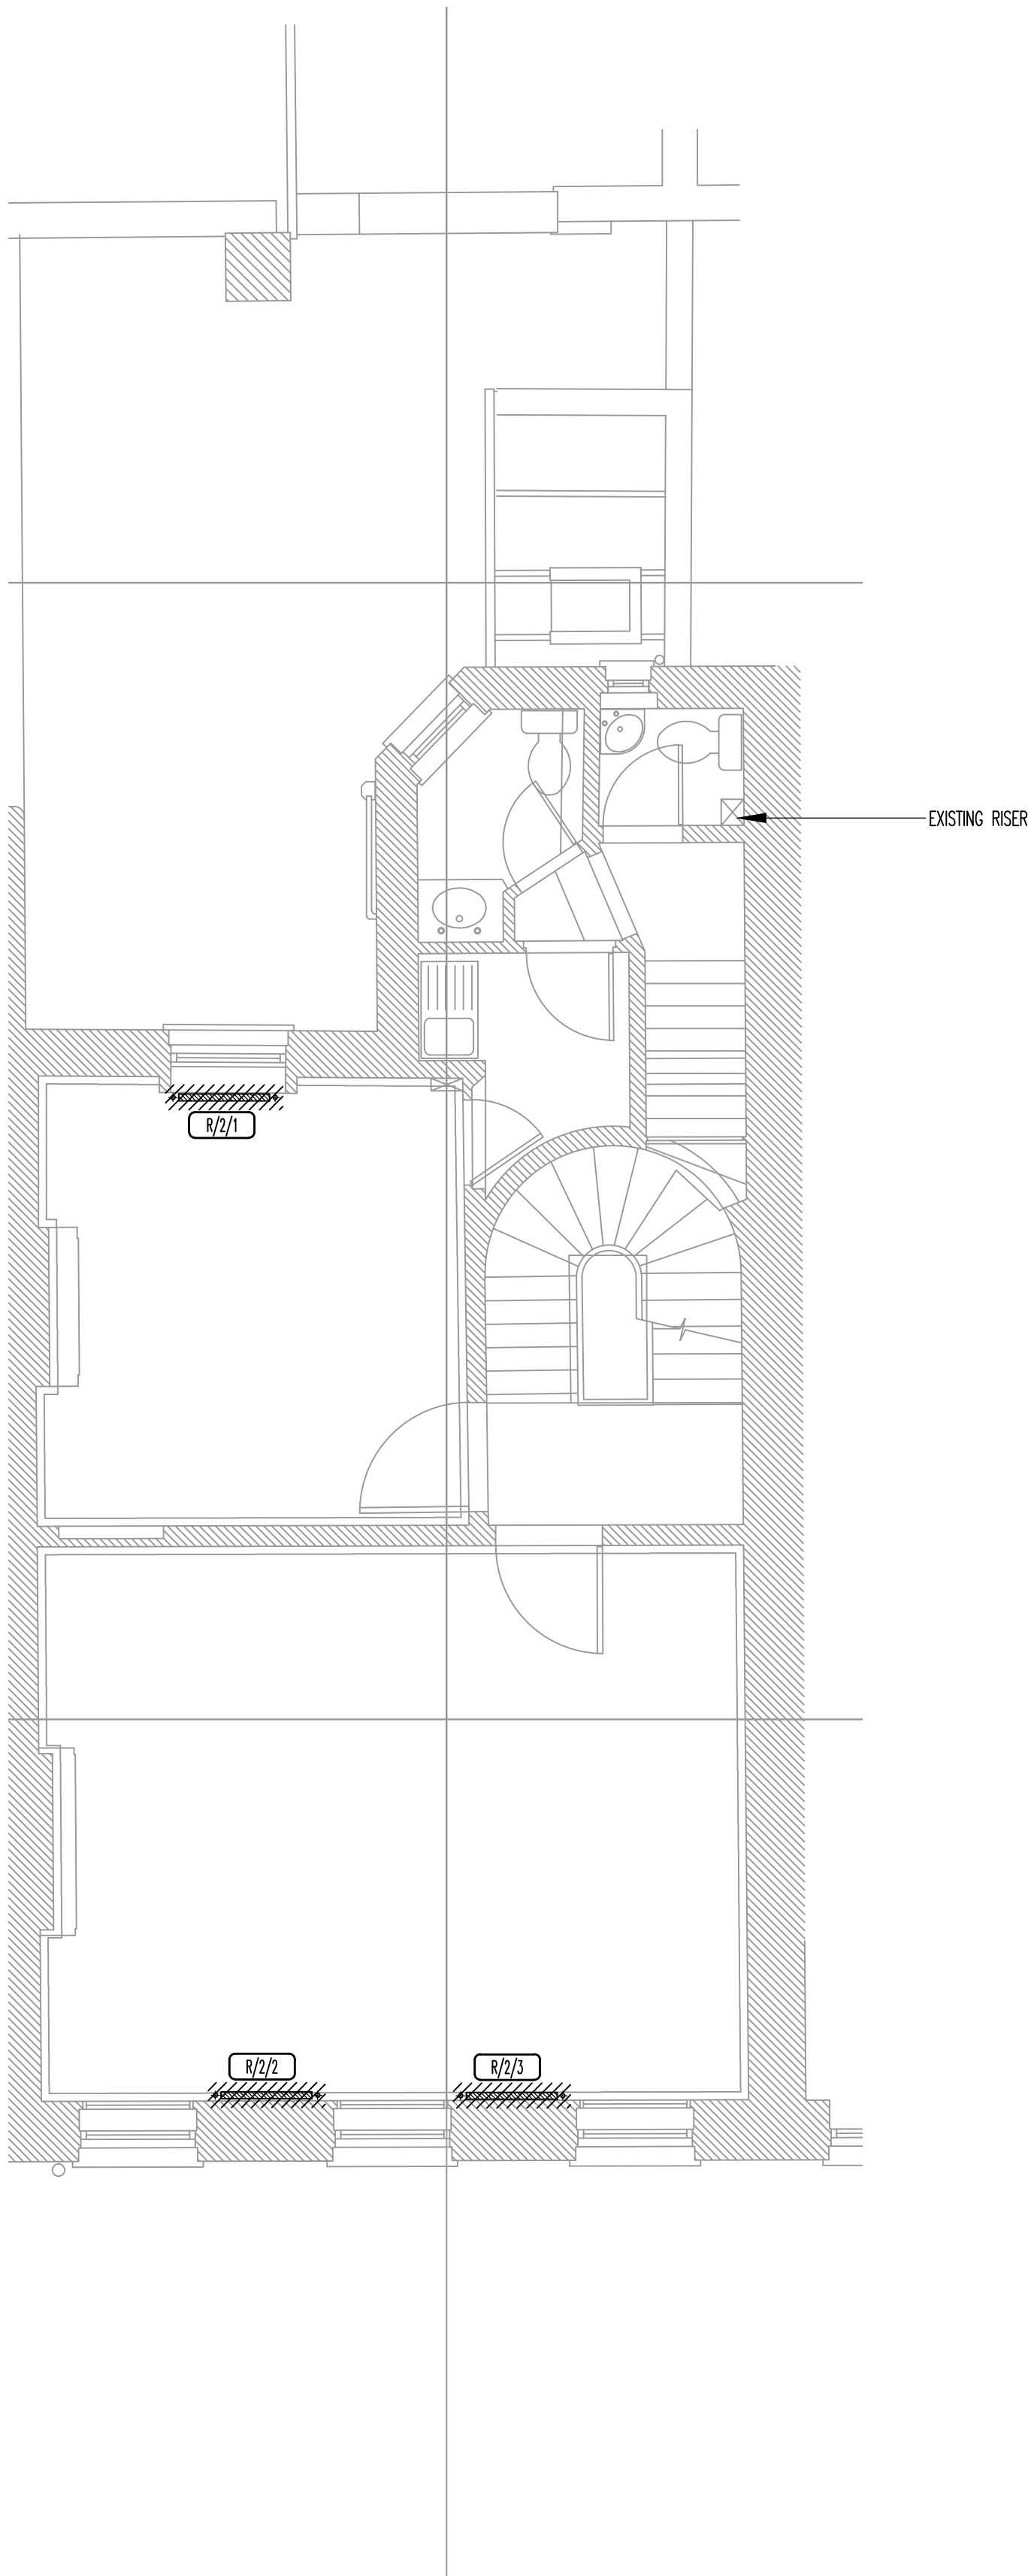

THIS DRAWING MUST NOT BE REPRODUCED WITHOUT PRIOR CONSENT.
DO NOT SCALE FROM THIS DRAWING.
THIS DRAWING IS COPYRIGHT. ©

GENERAL NOTES

TO BE STRIPPED OUT

RADIATOR

PLANNING

0	FEB.13	PLANNING ISSUE
Rev	Date	Description

TPS

Taylor Project Services LLP

No.1 Cornhill
London EC3V 3ND
Tel 020 7743 6602
www.taylorprojectservices.com

Client:

THE BEDFORD ESTATES

29a Montague Street
London
WC1B 5PL
Tel: 0171 406 2865
Fax: 0171 255 1729

Project

11 GOWER STREET
LONDON
WC1

Drawing Title

SECOND FLOOR
EXISTING SERVICES LAYOUT

Scale	1:50 © A1	Date	07.02.13
Drawn	L.R.	Checked	G.N.T.
Drawing Status			
PLANNING			
Revision	0		
Drawing No.			
TPS/11GS/2/E			

GENERAL NOTES



VRV UNIT POSITION



ELECTRIC HEATER





CONDENSER



REFRIGERANT PIPEWORK RUN



VRV UNIT BS BOX

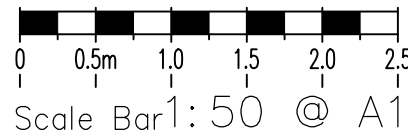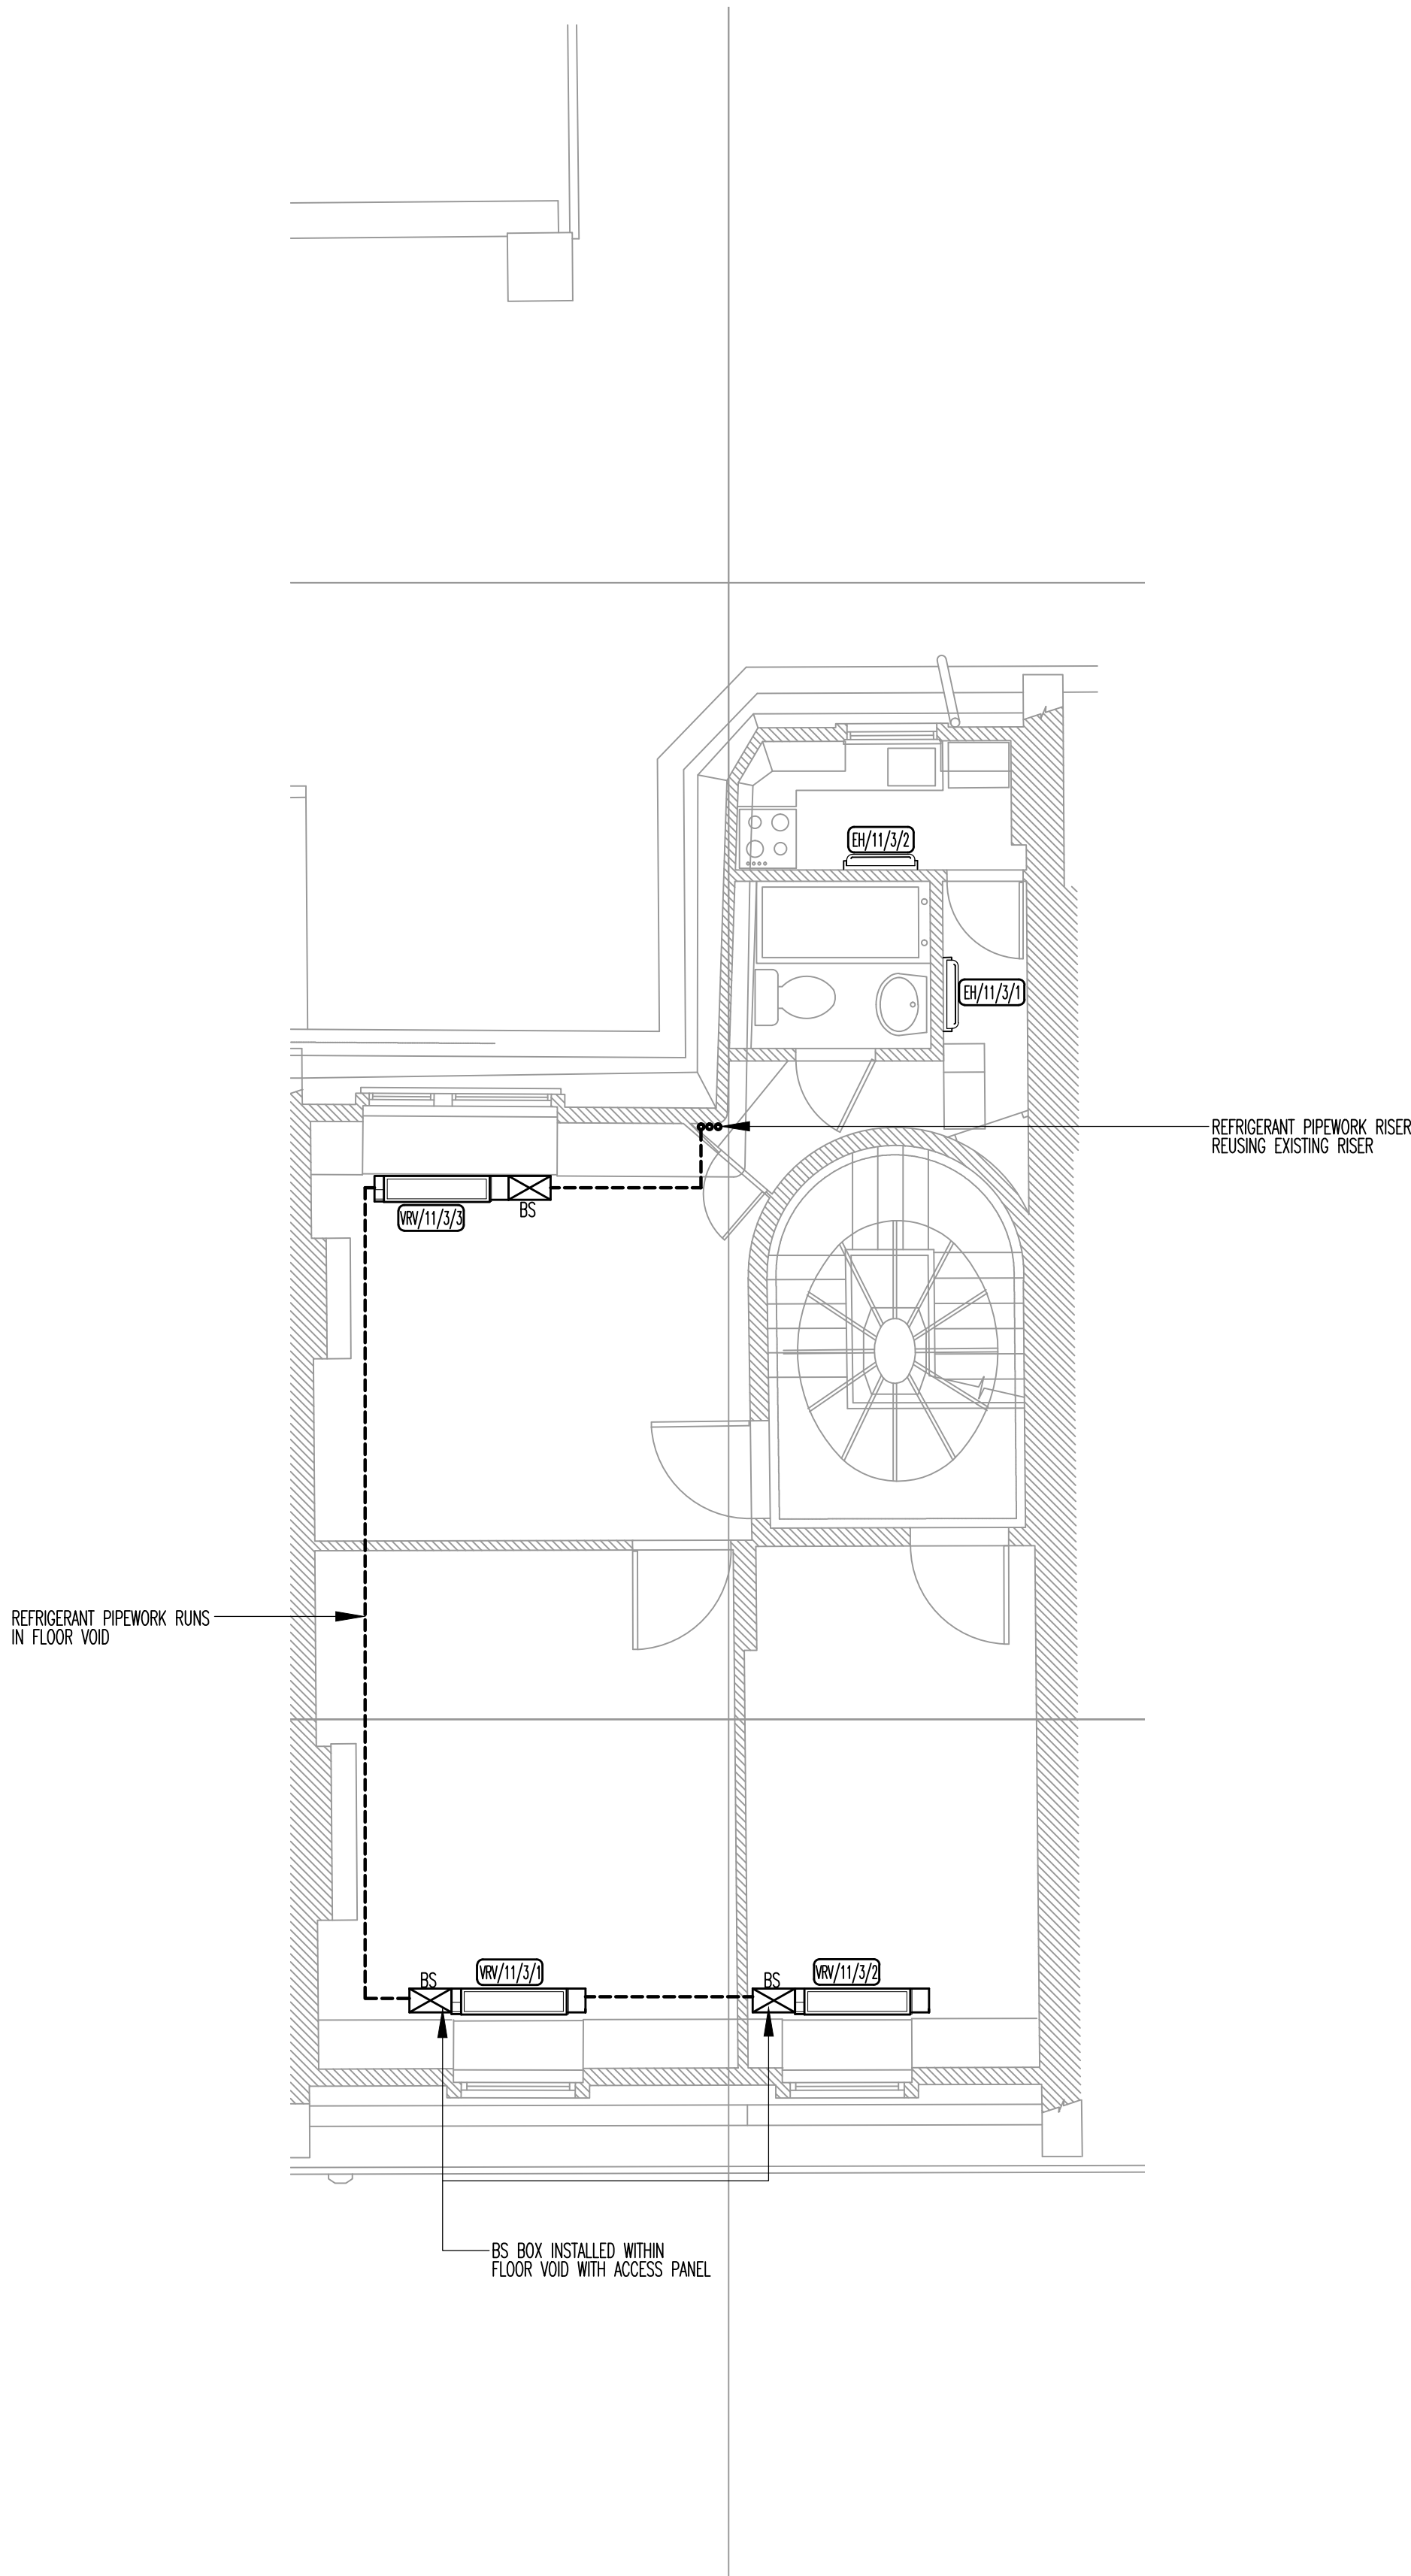

PLANNING

0	FEB.13	PLANNING ISSUE
Rev	Date	Description

TPS

Taylor Project Services LLP

No.1 Cornhill
London EC3V 3ND
Tel 020 7743 6602
www.taylorprojectservices.com

Client:



**THE
BEDFORD
ESTATES**

29a Montague Street
London
WC1B 5PL
Tel: 0171 406 2865
Fax: 0171 255 1729

Project

11 GOWER STREET
LONDON
WC1

Drawing Title

THIRD FLOOR
PROPOSED
VRV POSITIONS

Scale	1:50 © A1	Date	07.02.13
Drawn	L.R.	Checked	G.N.T.


Drawing Status

PLANNING

Revision	0																		
----------	---	--	--	--	--	--	--	--	--	--	--	--	--	--	--	--	--	--	--

Drawing No.

TPS/11GS/3/VRV/P

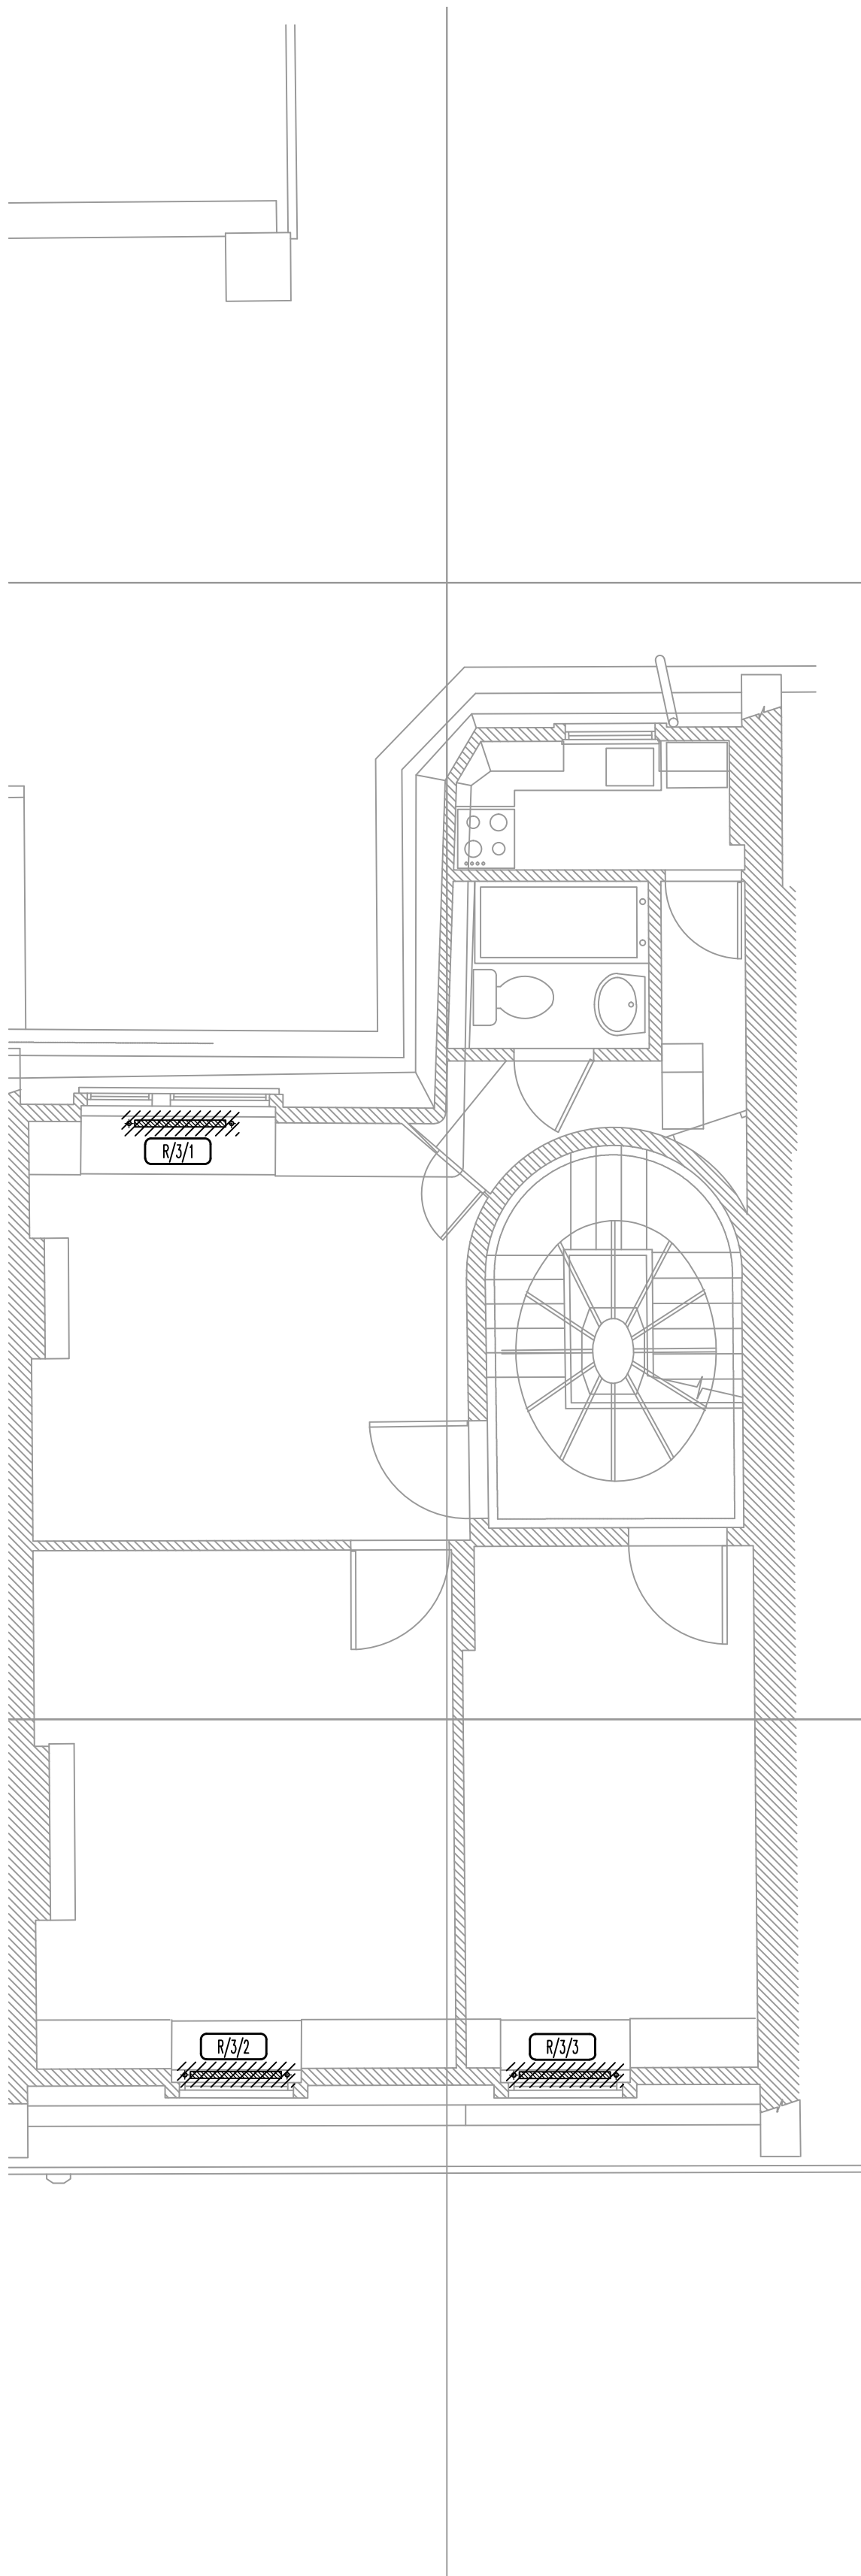

THIS DRAWING MUST NOT BE REPRODUCED WITHOUT PRIOR CONSENT.
DO NOT SCALE FROM THIS DRAWING.
THIS DRAWING IS COPYRIGHT. ©

GENERAL NOTES

TO BE STRIPPED OUT

RADIATOR

PLANNING


0	FEB.13	PLANNING ISSUE
Rev	Date	Description

TPS

Taylor Project Services LLP

No.1 Cornhill
London EC3V 3ND
Tel 020 7743 6602
www.taylorprojectservices.com

Client:



**THE
BEDFORD
ESTATES**

29a Montague Street
London
WC1B 5PL
Tel: 0171 406 2865
Fax: 0171 255 1729


Project

11 GOWER STREET
LONDON
WC1

Drawing Title



THIRD FLOOR
EXISTING SERVICES LAYOUT

Scale	1:50 © A1	Date	07.02.13
Drawn	L.R.	Checked	G.N.T.
Drawing Status		PLANNING	
Revision	0		
Drawing No. TPS/11GS/3/E			

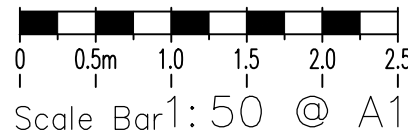

THIS DRAWING MUST NOT BE REPRODUCED WITHOUT PRIOR CONSENT.
DO NOT SCALE FROM THIS DRAWING.
THIS DRAWING IS COPYRIGHT. ©

GENERAL NOTES

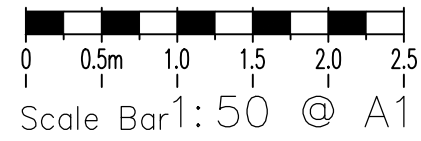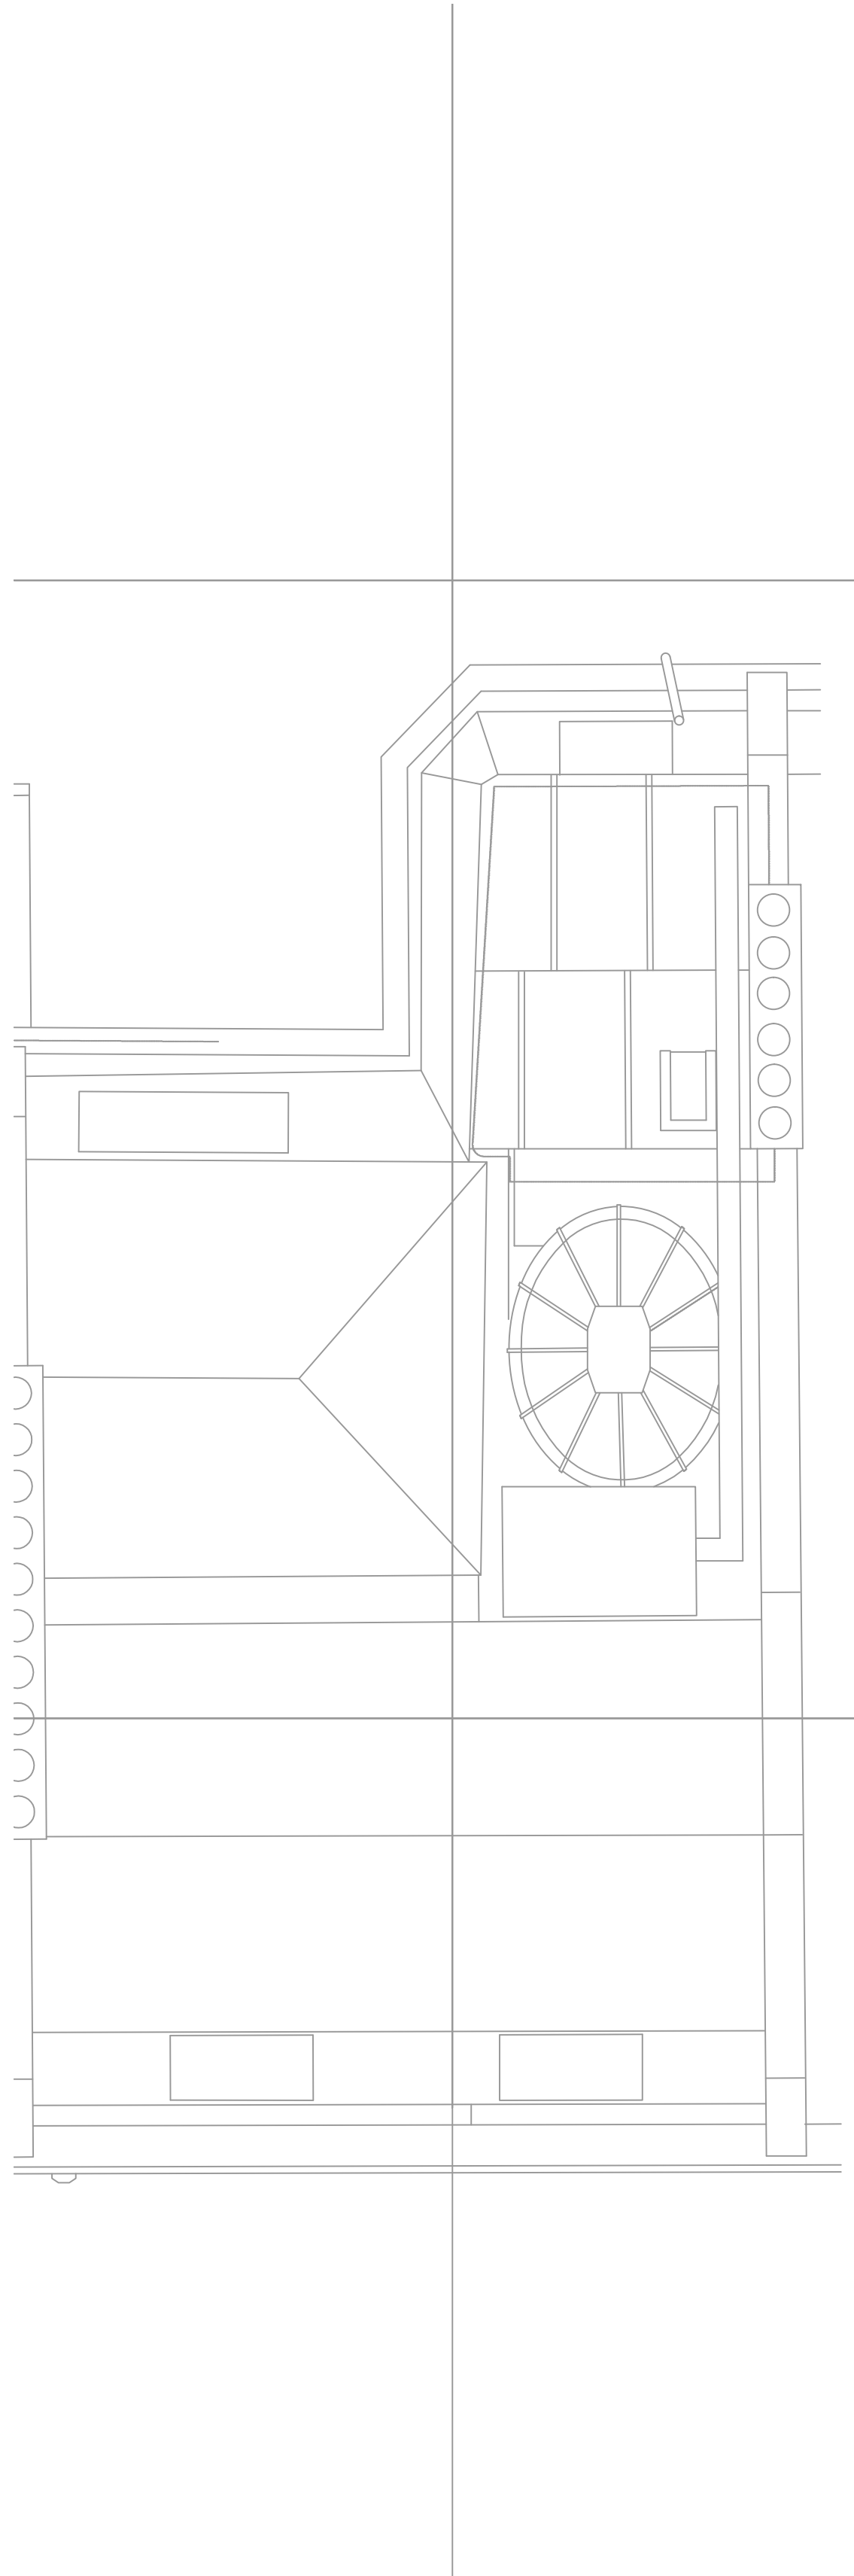

PLANNING

0	FEB.13	PLANNING ISSUE
Rev	Date	Description

TPS

Taylor Project Services LLP

<p>No.1 Cornhill London EC3V 3ND Tel 020 7743 6602 www.taylorprojectservices.com</p>	
---	--

Client:



THE
BEDFORD
ESTATES

a Montague Street
 London
 WC1B 5BL
 Tel: 0171 636 2885
 Fax: 0171 255 1729

Project

11 GOWER STREET
LONDON
WC1

Drawing Title

ROOF LEVEL
PROPOSED
VRV POSITIONS

Scale 1:50 @ A1

Date 07.02.13

Drawn L.R.

Checked G.N.T.

Drawing Status



PLANNING

Revision	0	
----------	---	--

Drawing No. TP

TPS/11GS/R/VRV/P

THIS DRAWING MUST NOT BE REPRODUCED WITHOUT PRIOR CONSENT.
DO NOT SCALE FROM THIS DRAWING.
THIS DRAWING IS COPYRIGHT. ©
GENERAL NOTES

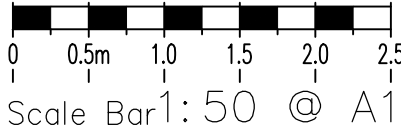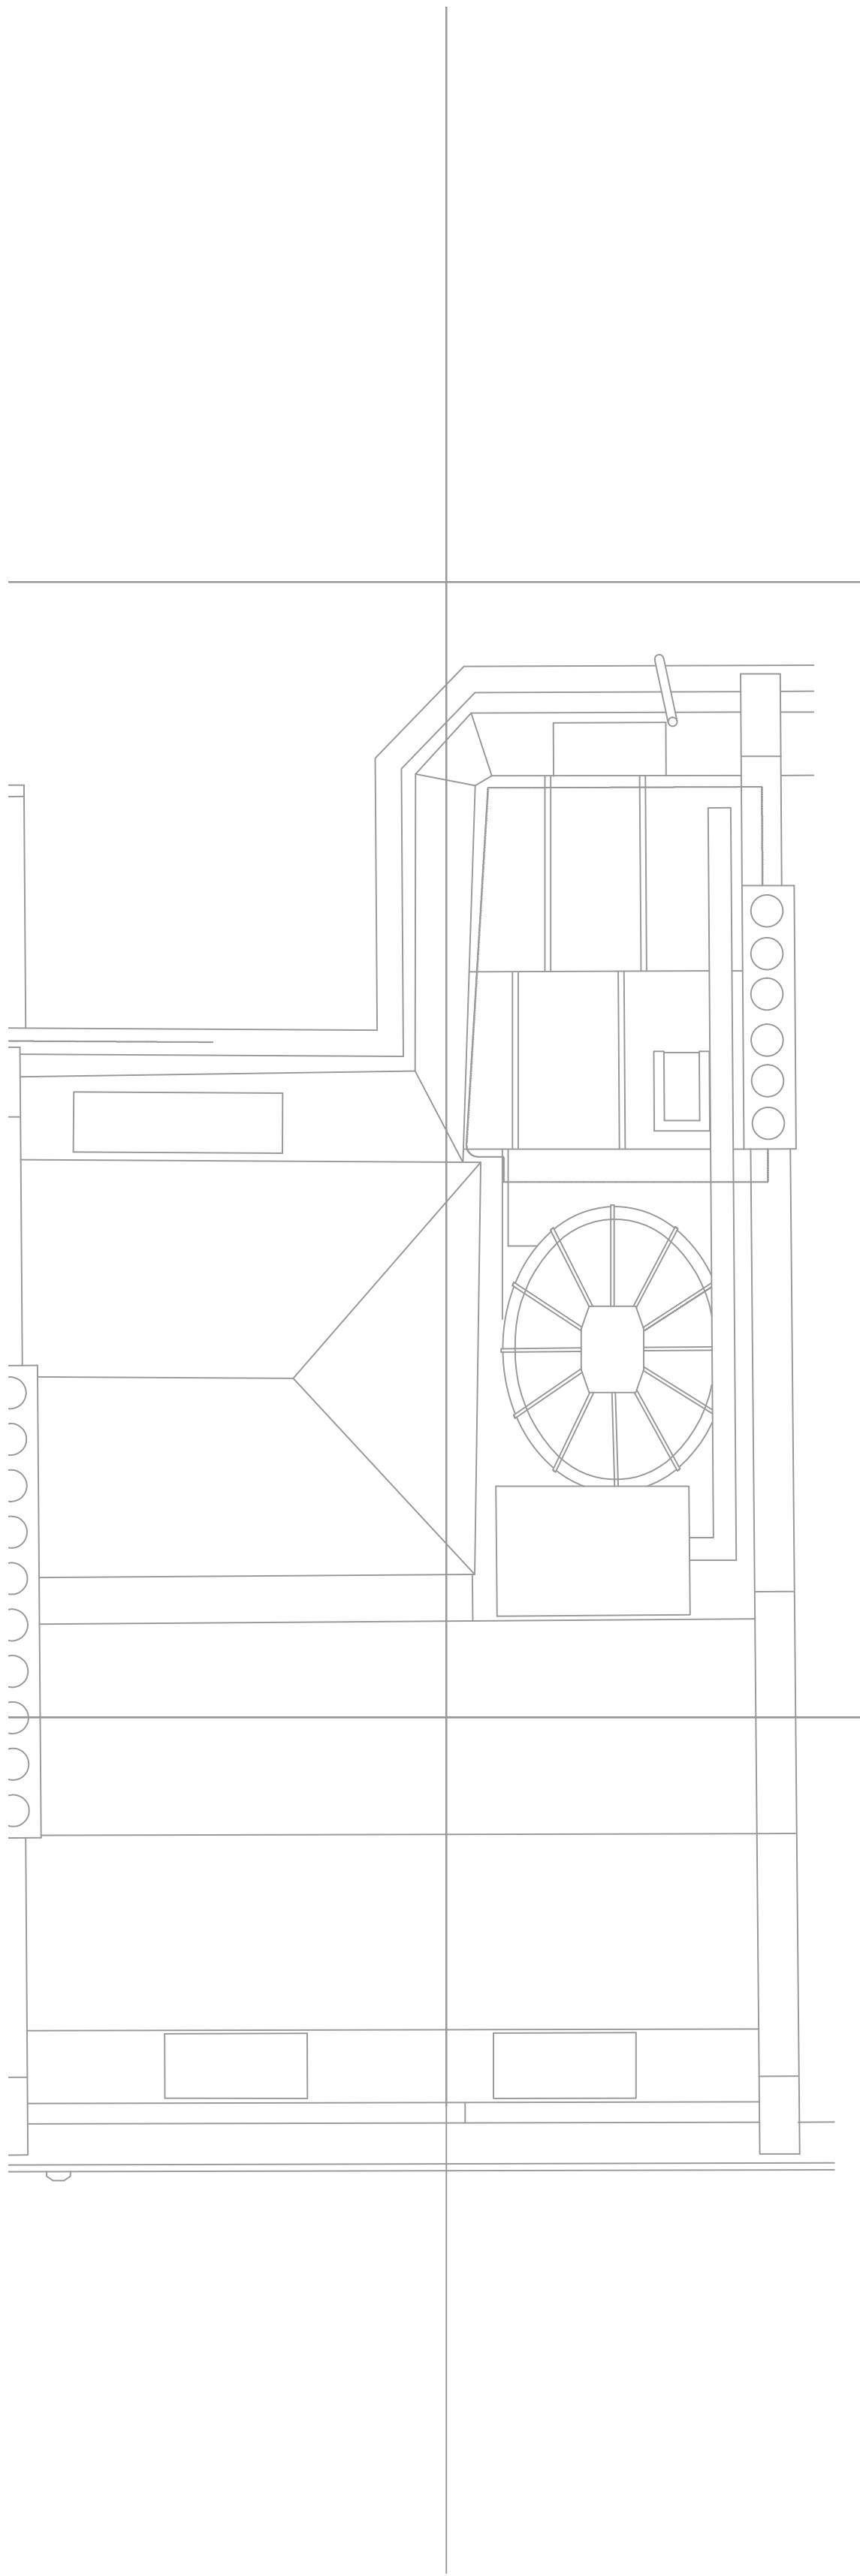

PLANNING

0	FEB.13	PLANNING ISSUE
Rev	Date	Description

TPS

Taylor Project Services LLP

No.1 Cornhill
London EC3V 3ND
Tel 020 7743 6602
www.taylorprojectservices.com

Client:



**THE
BEDFORD
ESTATES**
29a Montague Street
London
WC1B 5PL
Tel: 0171 406 2865
Fax: 0171 255 1729

Project
11 GOWER STREET
LONDON
WC1

Drawing Title
ROOF LEVEL
EXISTING SERVICES LAYOUT

Scale	1:50 © A1	Date	07.02.13
Drawn	L.R.	Checked	G.N.T.

Drawing Status
PLANNING


Revision	0																		
----------	---	--	--	--	--	--	--	--	--	--	--	--	--	--	--	--	--	--	--

Drawing No.
TPS/11GS/R/E

0	JAN.13	PLANNING ISSUE
Rev	Date	Description

Taylor Project Services LLP

Client:



**THE
BEDFORD
ESTATES**

29a Montague Street
London
WC1B 5BL
Tel: 0171 656 2885
Fax: 0171 255 1729

Project

11 GOWER STREET
LONDON
WC1

Drawing Title

PROPOSED
REAR ELEVATION

Scale 1:50 @ A1	Date 07.12.12
Drawn L.R.	Checked G.N.T.

Drawing Status

PLANNING

[illegible]

Drawing No. TPS/11GS/EL/R/P



0	JAN.13	PLANNING ISSUE
Rev	Date	Description

Taylor Project Services LLP

No.1 Cornhill
London EC3V 3ND
Tel 020 7743 6602
www.taylorprojectservices.com

Client:



19a Montague Street
London
WC1B 5BL
Tel: 0171 636 2885
Fax: 0171 255 1729

Project

11 GOWER STREET
LONDON
WC1

Drawing Title

EXISTING
REAR ELEVATION

Scale 1:50 @ A1

Date 07.12.12

Drawn L.R.

G.N.T.

Drawing Status



PLANNING

Revision	0
----------	---

D

Drawing No.

TPS/11GS/EL/R/E

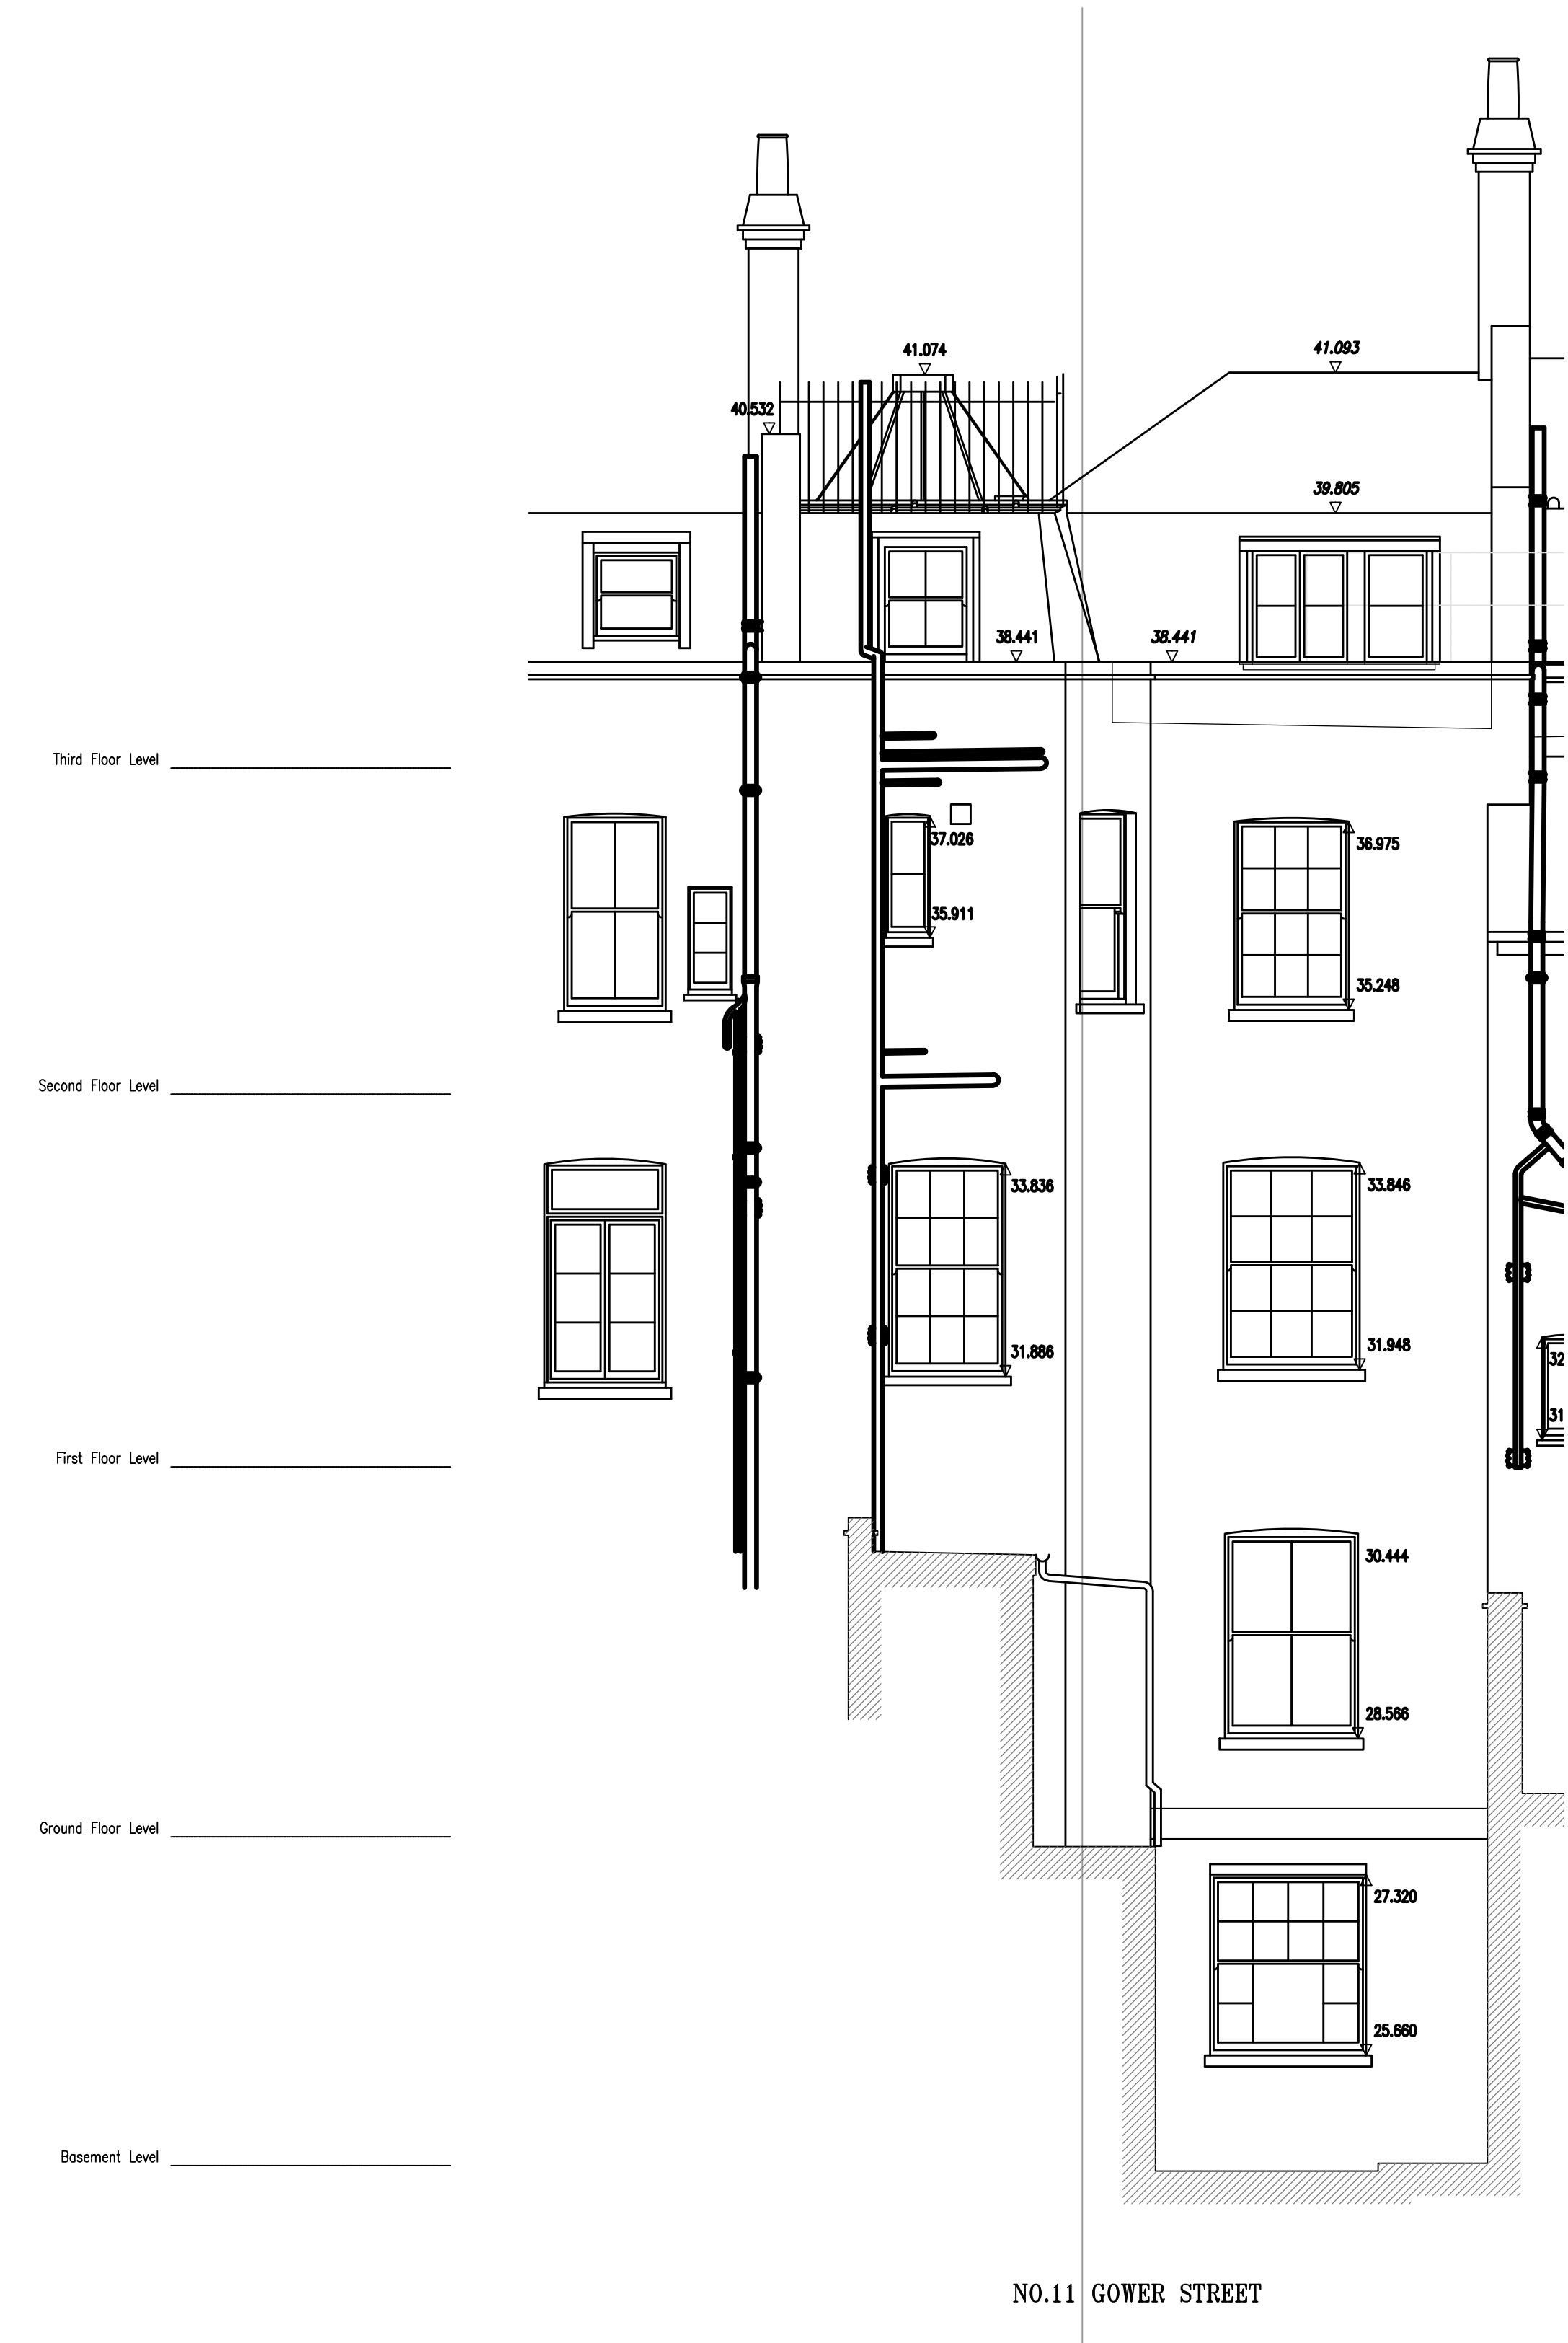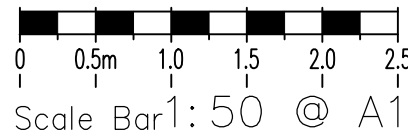

PLANNING

TPS

Taylor Project Services LLP

No.1 Cornhill
London EC3V 3ND
Tel 020 7743 6602
www.taylorprojectservices.com

Montague Street
London
WC1B 5BL
t: 0171 636 2885
f: 0171 255 1729

11 GOWER STREET
LONDON
WC1


PROPOSED
FRONT ELEVATION

Checked G.N.T.

PLANNING

[illegible]

TPS/11GS/EL/F/P

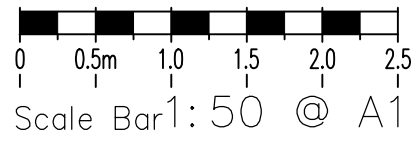

PLANNING

TPS

Taylor Project Services LLP

No.1 Cornhill
London EC3V 3ND
Tel 020 7743 6602
www.taylorprojectservices.com



Scale	1:50 @ A1	Date	12.02.13
Drawn	L.R.	Checked	G.N.T.


[illegible]

A graphical scale bar for drawing A1 at a scale of 1:50. The bar is divided into five equal segments, each representing 0.5 meters. The total length of the bar is 2.5 meters. The scale is labeled as 'Scale Bar 1:50 @ A1'.




THIS DRAWING MUST NOT BE REPRODUCED WITHOUT PRIOR CONSENT.
DO NOT SCALE FROM THIS DRAWING.
THIS DRAWING IS COPYRIGHTED


GENERAL NOTES

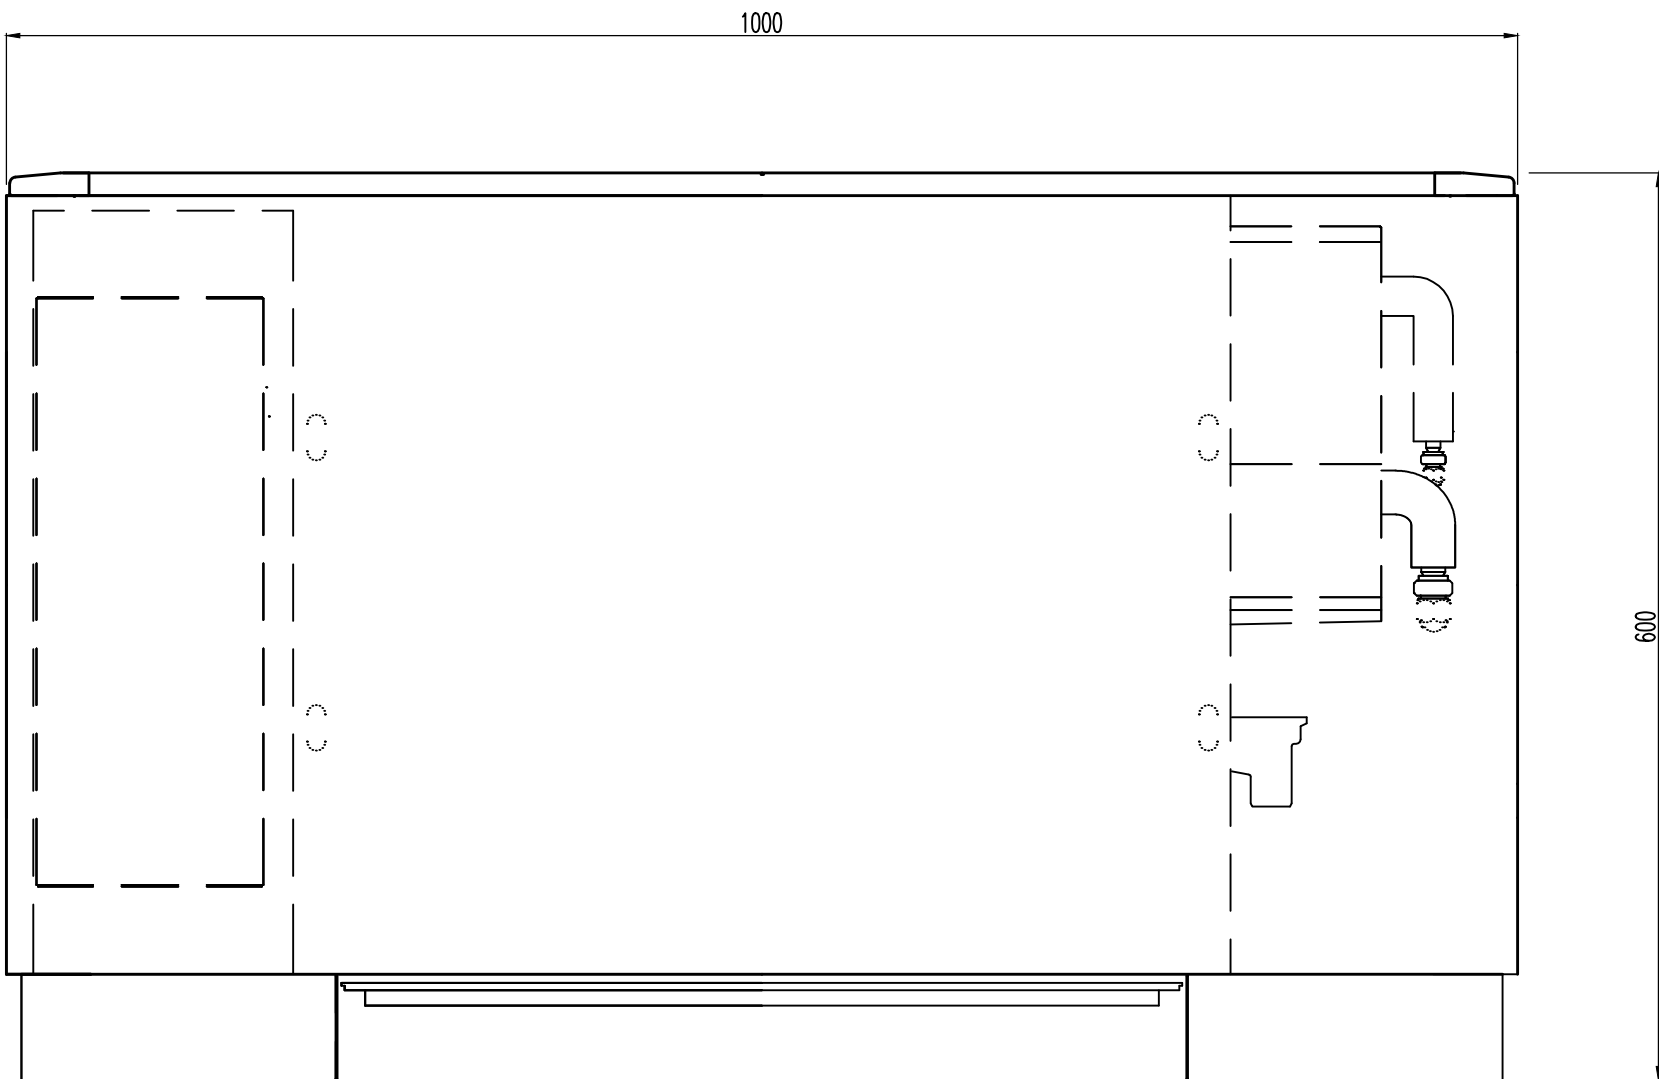

FRONT VIEW

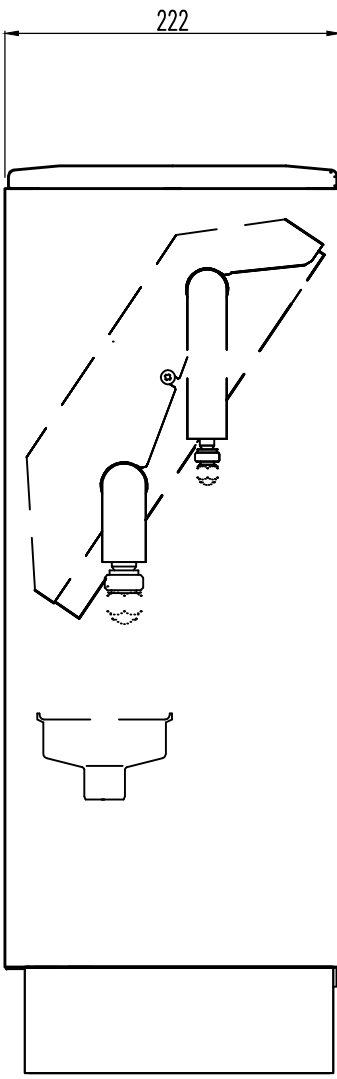


SECTION

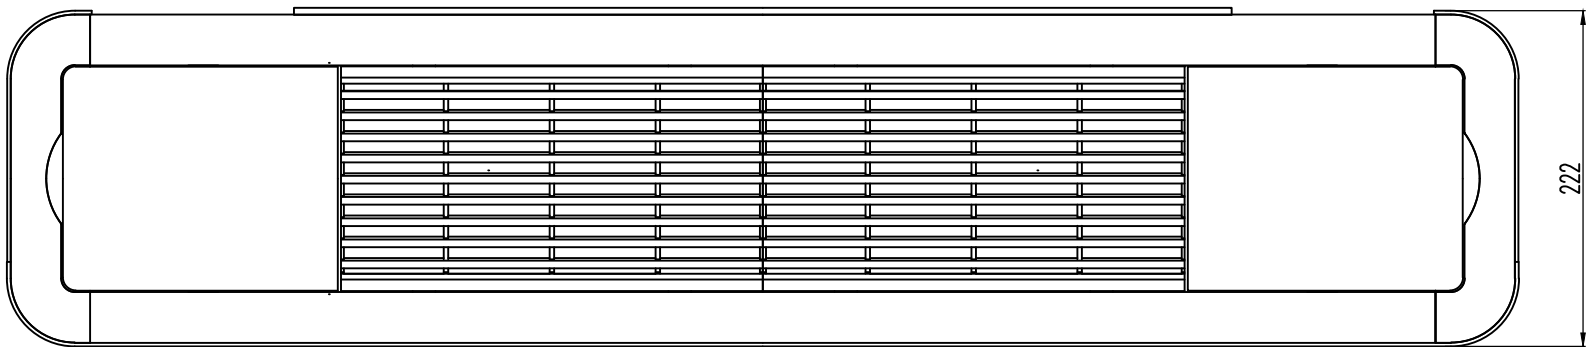


PLAN


DAIKIN PROPRIETARY METAL CASED VRV UNITS

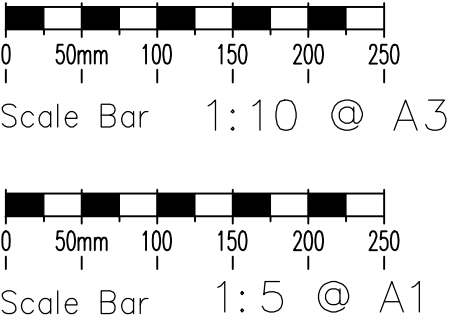


PLANNING		
0	FEB.13	PLANNING ISSUE
Rev	Date	Description
<div><div>TPS</div><div>Taylor Project Services LLP</div><div>No.1 Cornhill London EC3V 3ND Tel 020 7743 6602 www.taylorprojectservices.com</div></div>		
<div><div>Client</div><div><div>THE BEDFORD ESTATES</div><div>29a Montague Street London WC1B 5BT Tel 0171 636 2885 Fax 0171 255 1729</div></div></div>		
<div><div>Project</div><div>11 GOWER STREET LONDON WC1</div></div>		
<div><div>Drawing Title</div><div>VRV STANDARD CASING DETAIL</div></div>		
Scale 1:5 @ A1		Date 12.02.13
Drawn R.J.L.		Checked G.N.T.
Drawing Status PLANNING		
Revision	0	
Drawing No. TPS/11GS/VRV/M		

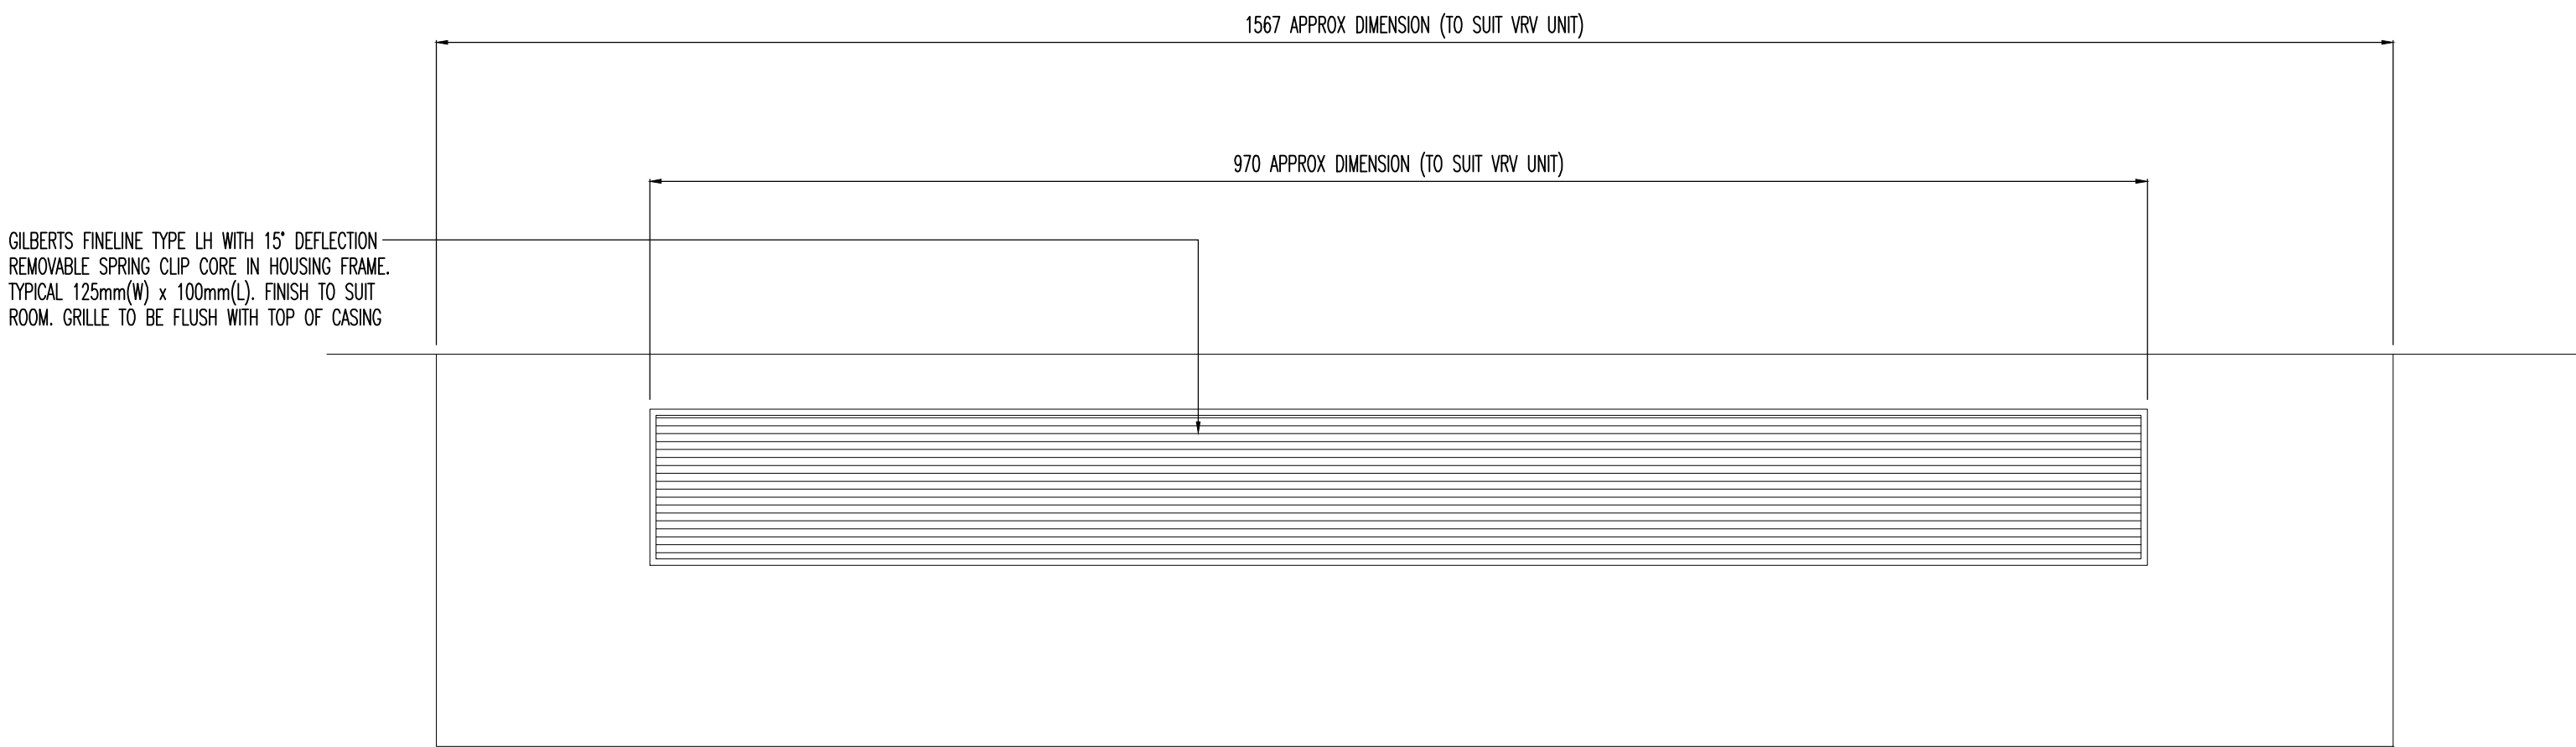


TOP VIEW

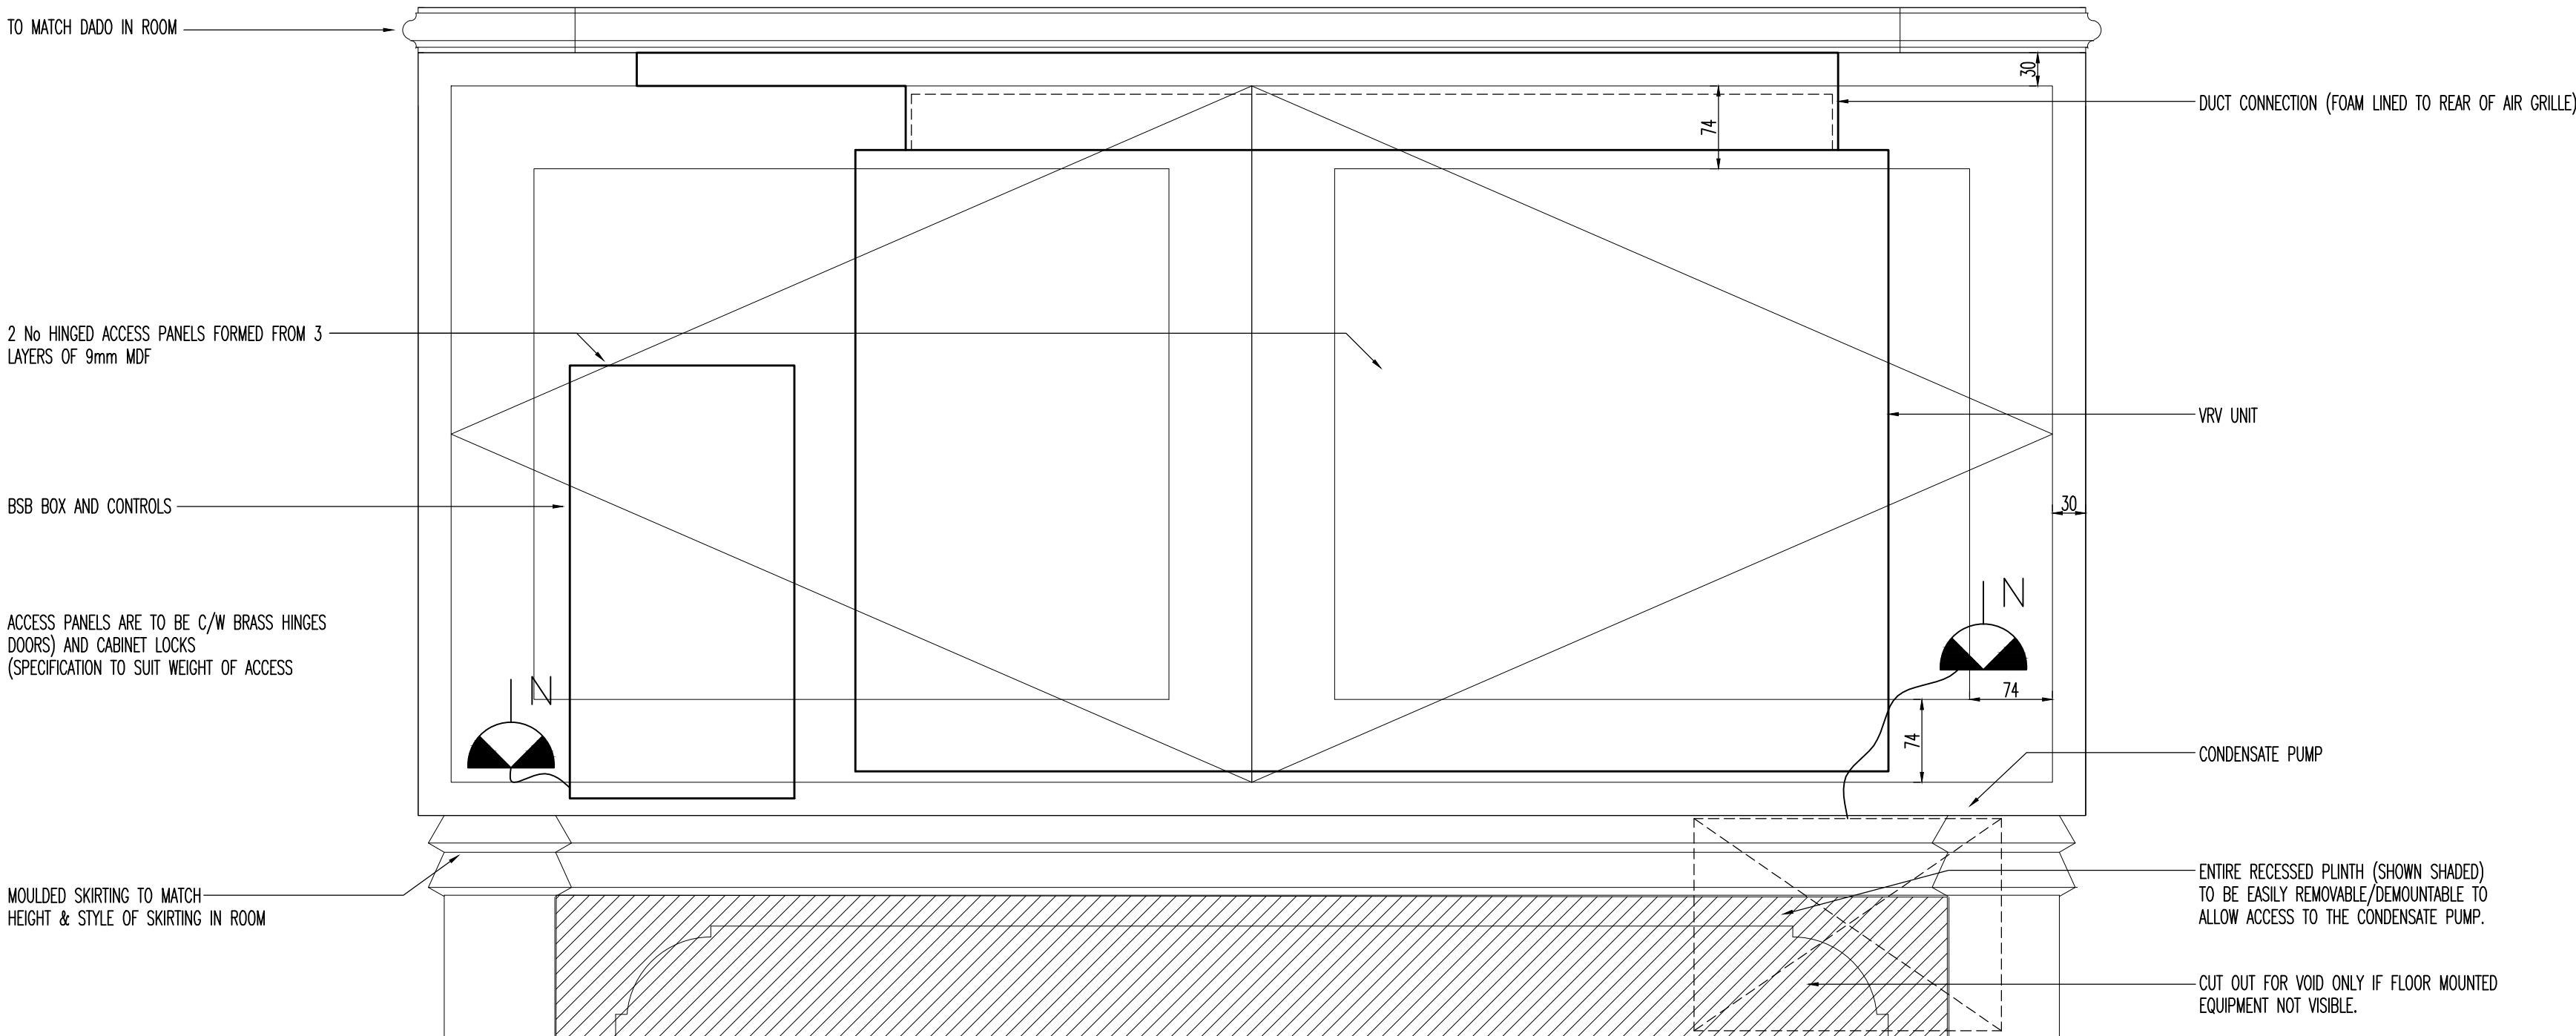


FRONT VIEW

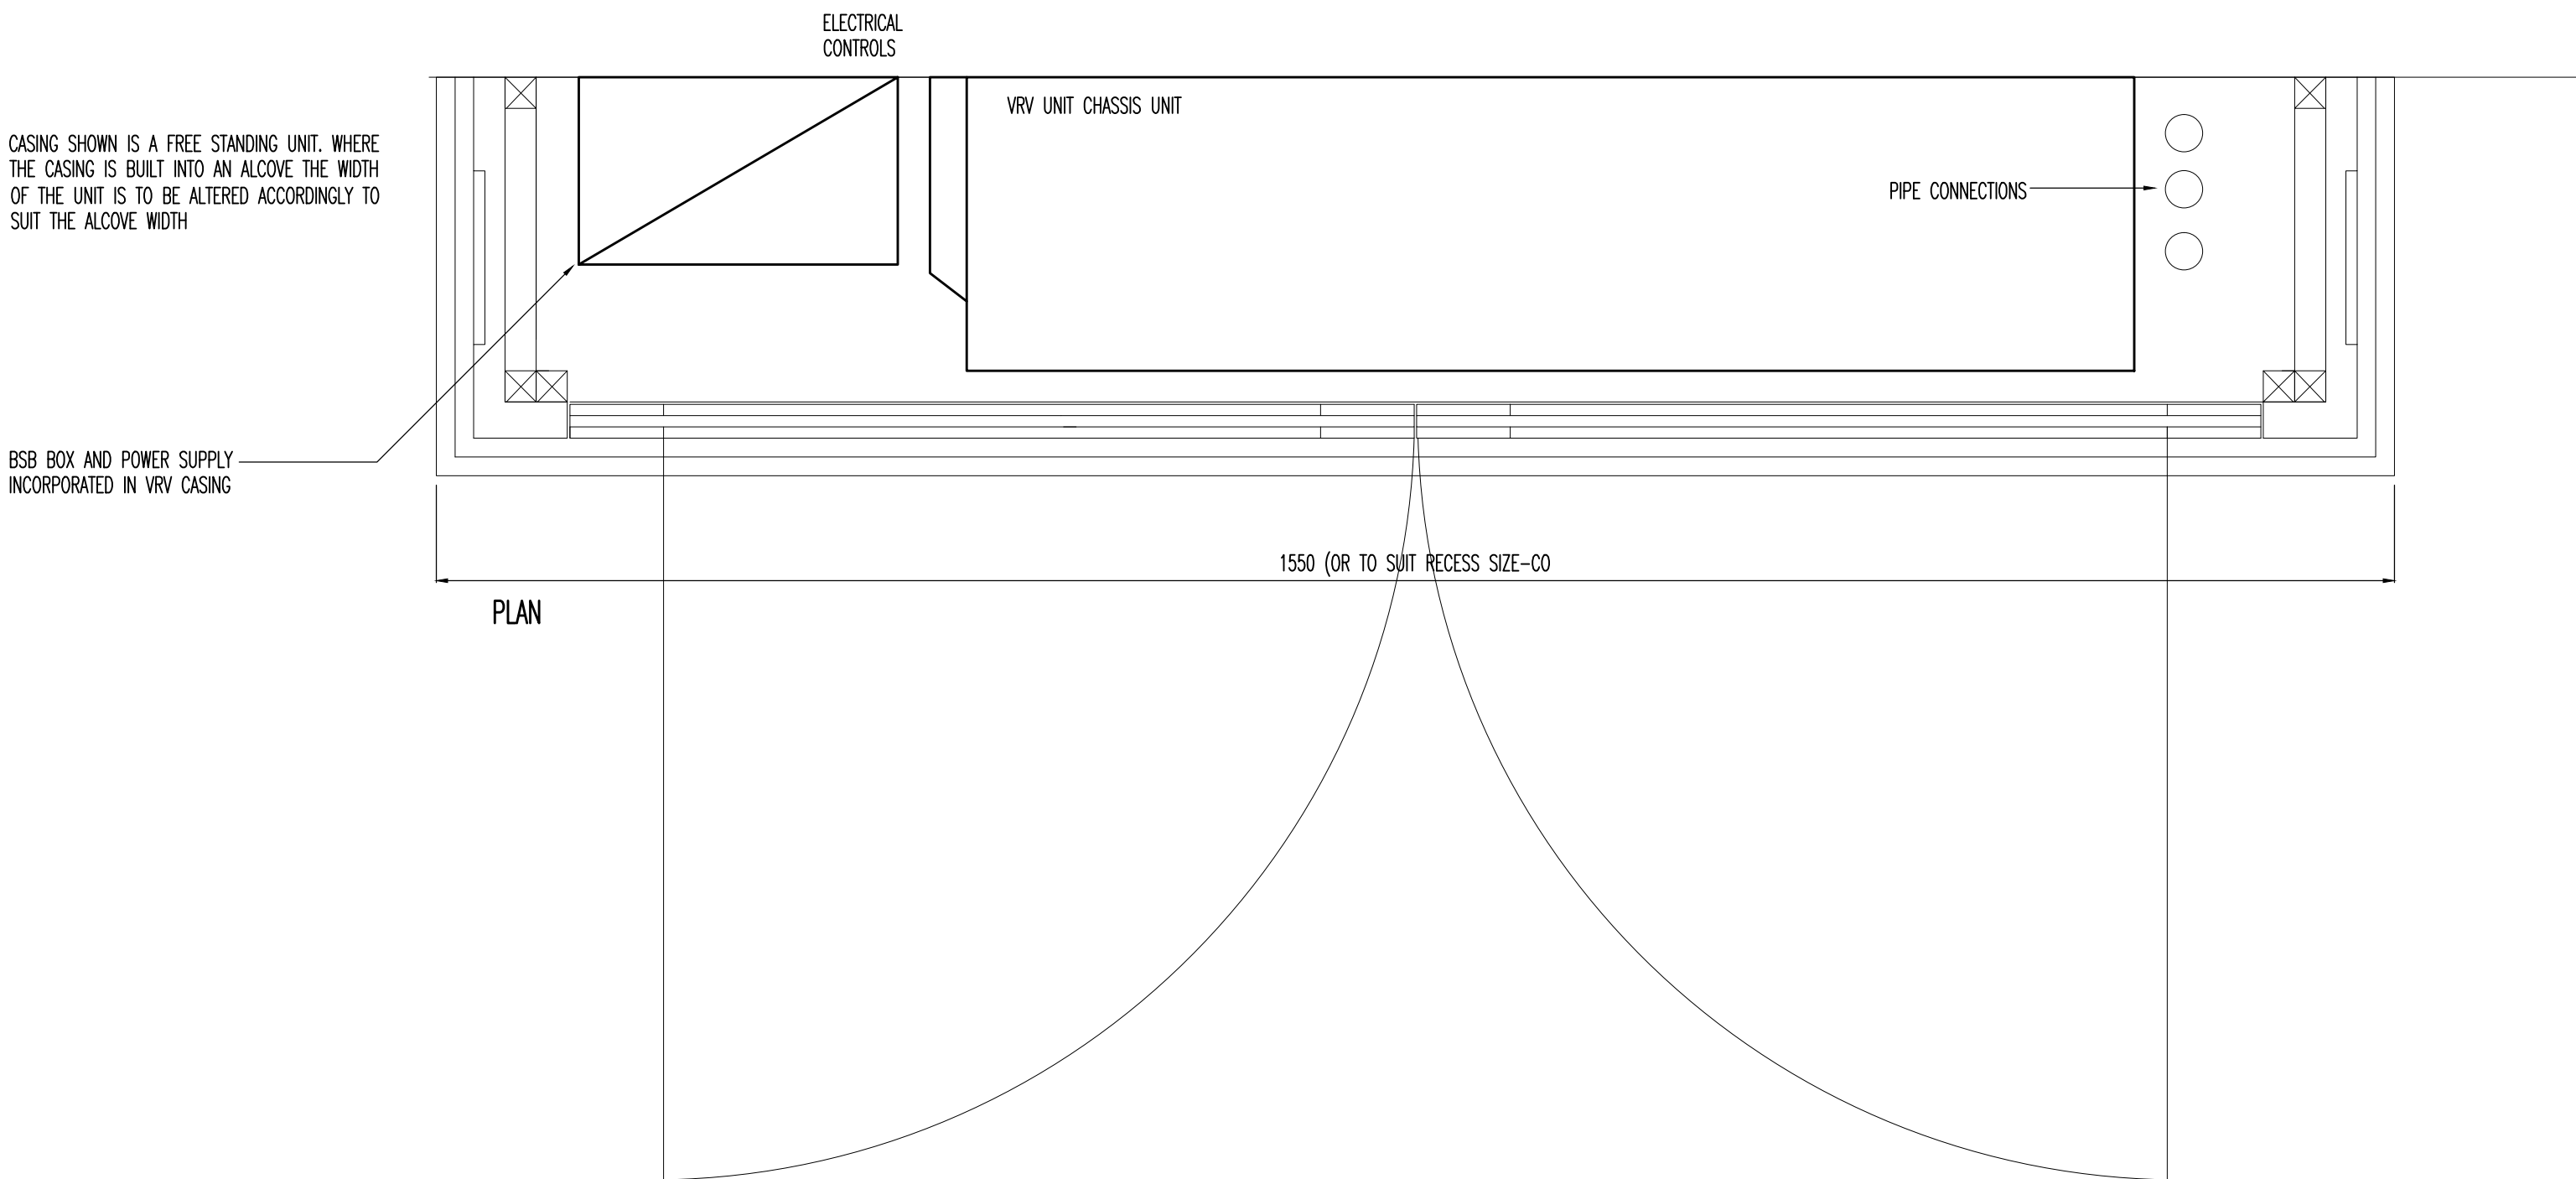


PLAN

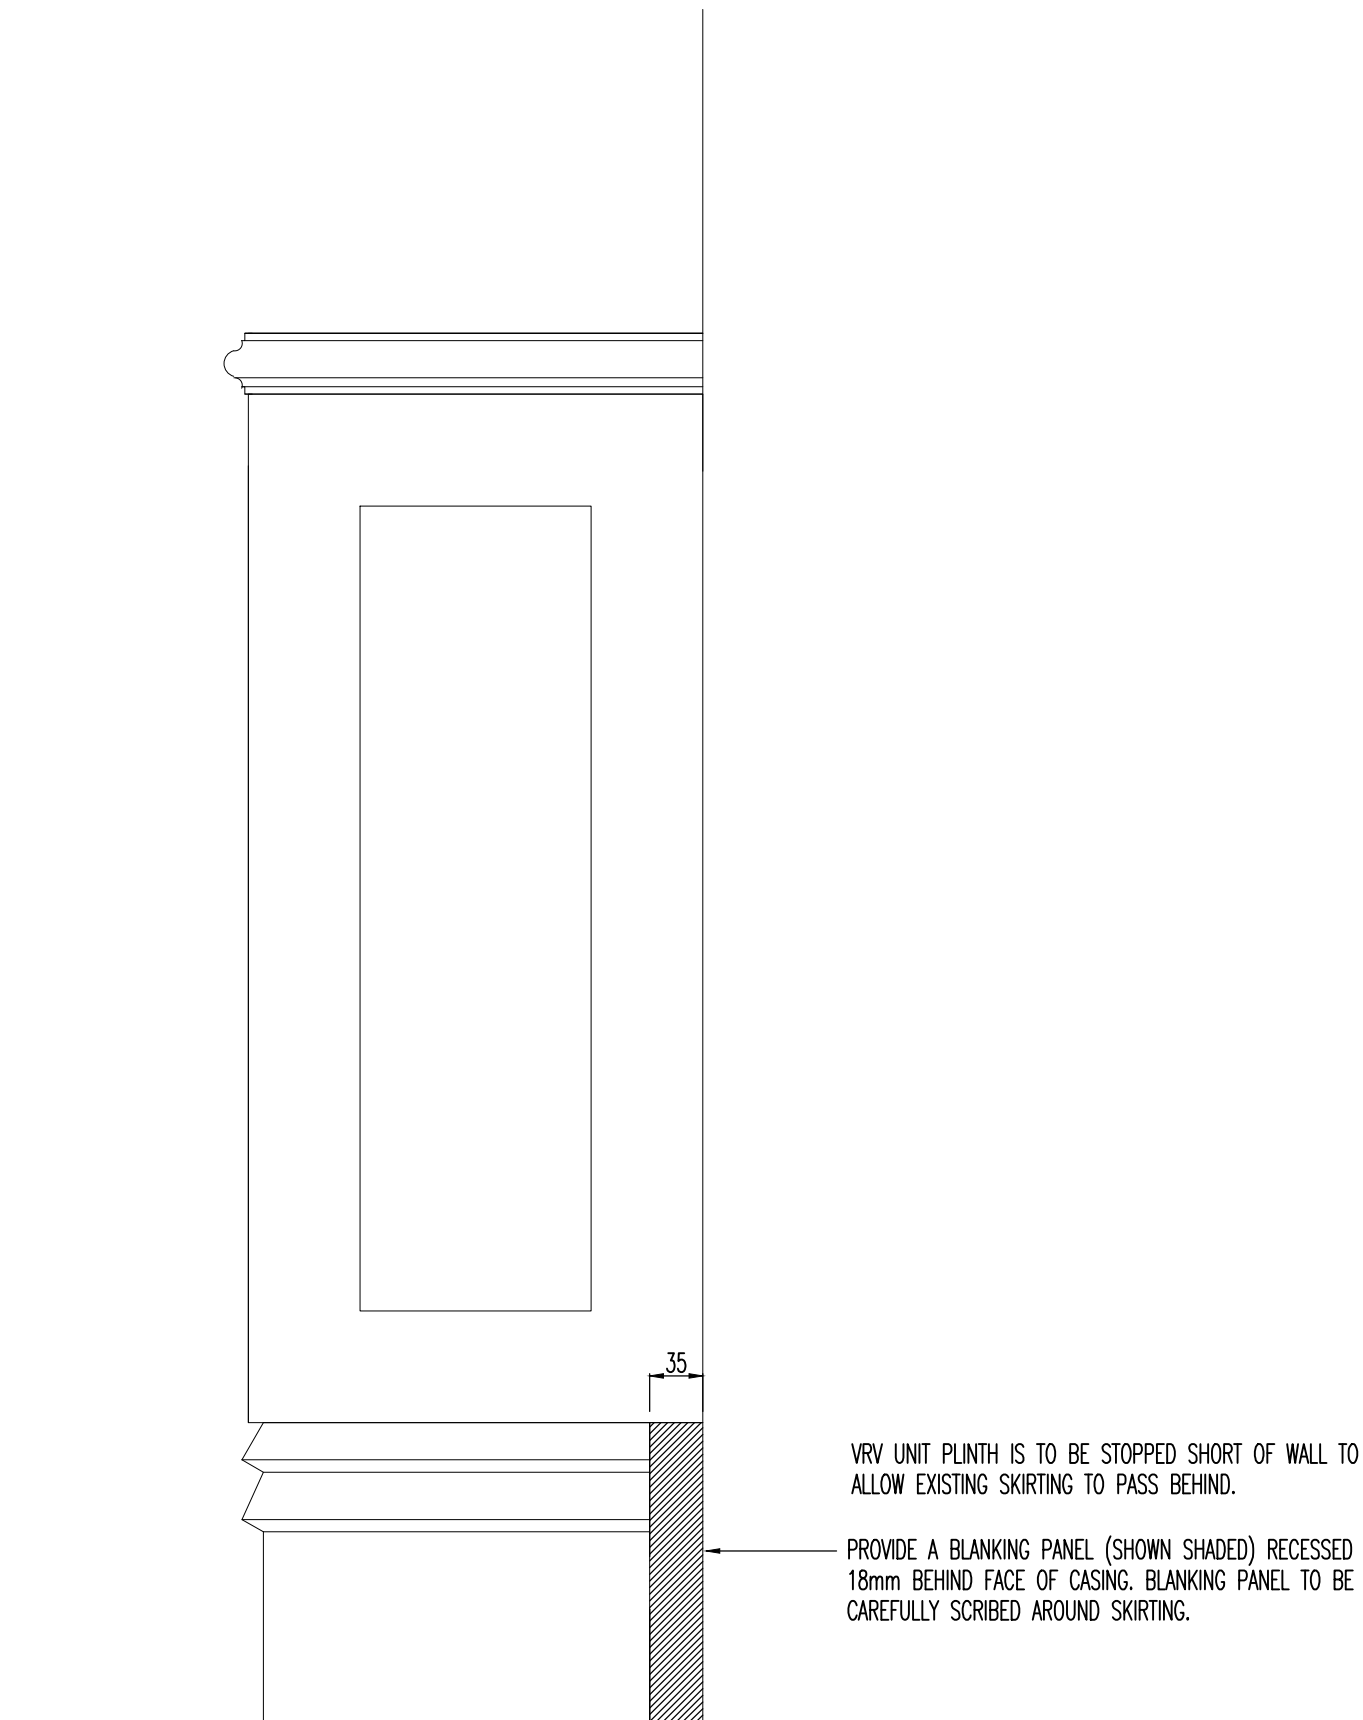

SIDE VIEW

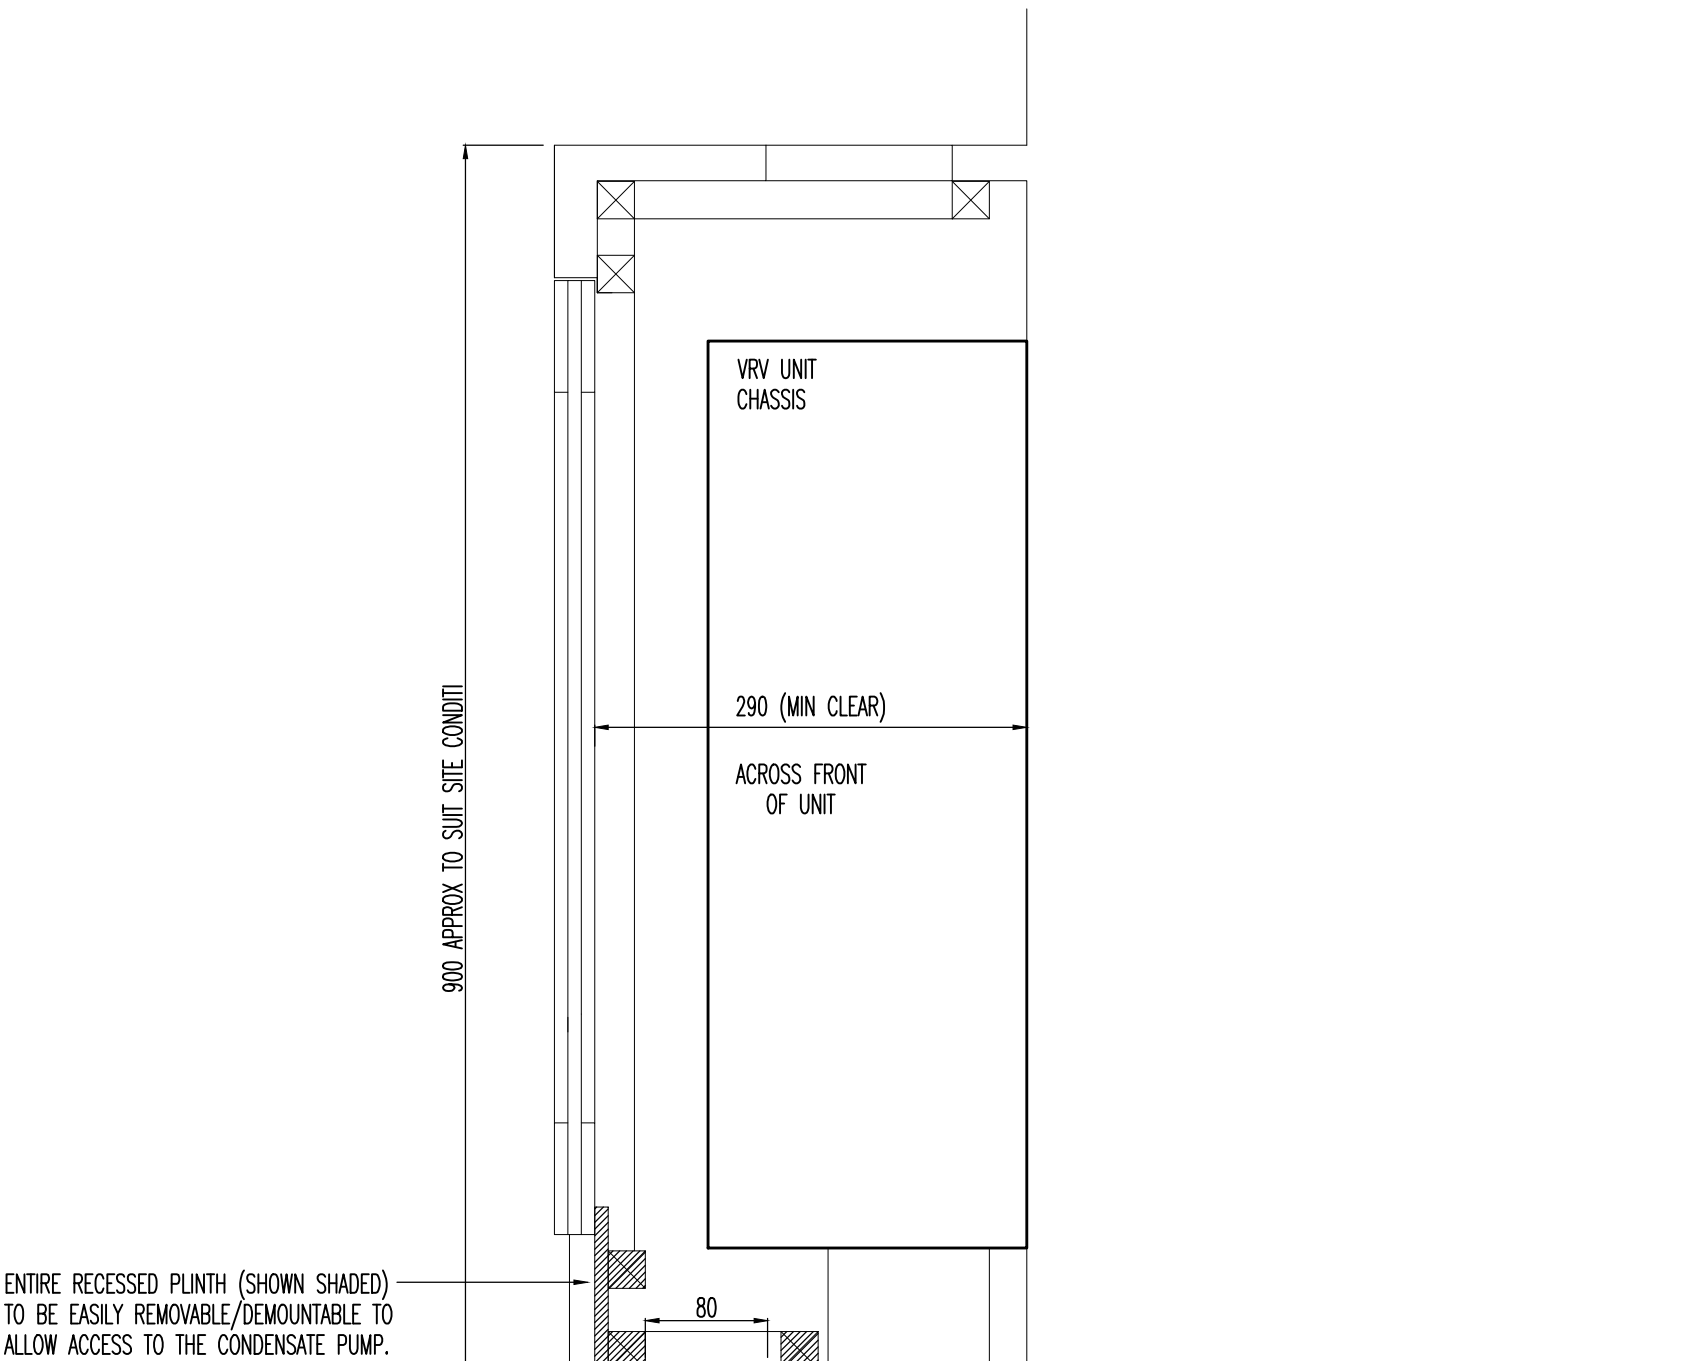

SECTION

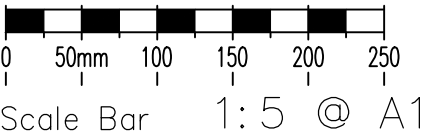

THIS DRAWING MUST NOT BE REPRODUCED WITHOUT PRIOR CONSENT.
DO NOT SCALE FROM THIS DRAWING.
THIS DRAWING IS COPYRIGHTED

GENERAL NOTES

PLANNING

0	FEB.13	PLANNING ISSUE
Rev	Date	Description

TPS
Taylor Project Services LLP
No.1 Cornhill
London EC3V 3ND
Tel 020 7743 6602
www.taylorprojectservices.com

Client

THE BEDFORD ESTATES
29a Montague Street
London WC3B 5BT
Tel 0171 636 2885
Fax 0171 286 1729

Project

11 GOWER STREET
LONDON
WC1

Drawing Title

VRV JOINERY CASING DETAIL

Scale	1:5 @ A1	Date	12.02.13
Drawn	R.J.L.	Checked	G.N.T.



Drawing Status

PLANNING

Revision	0																		
----------	---	--	--	--	--	--	--	--	--	--	--	--	--	--	--	--	--	--	--

Drawing No.

TPS/11GS/VRV/J

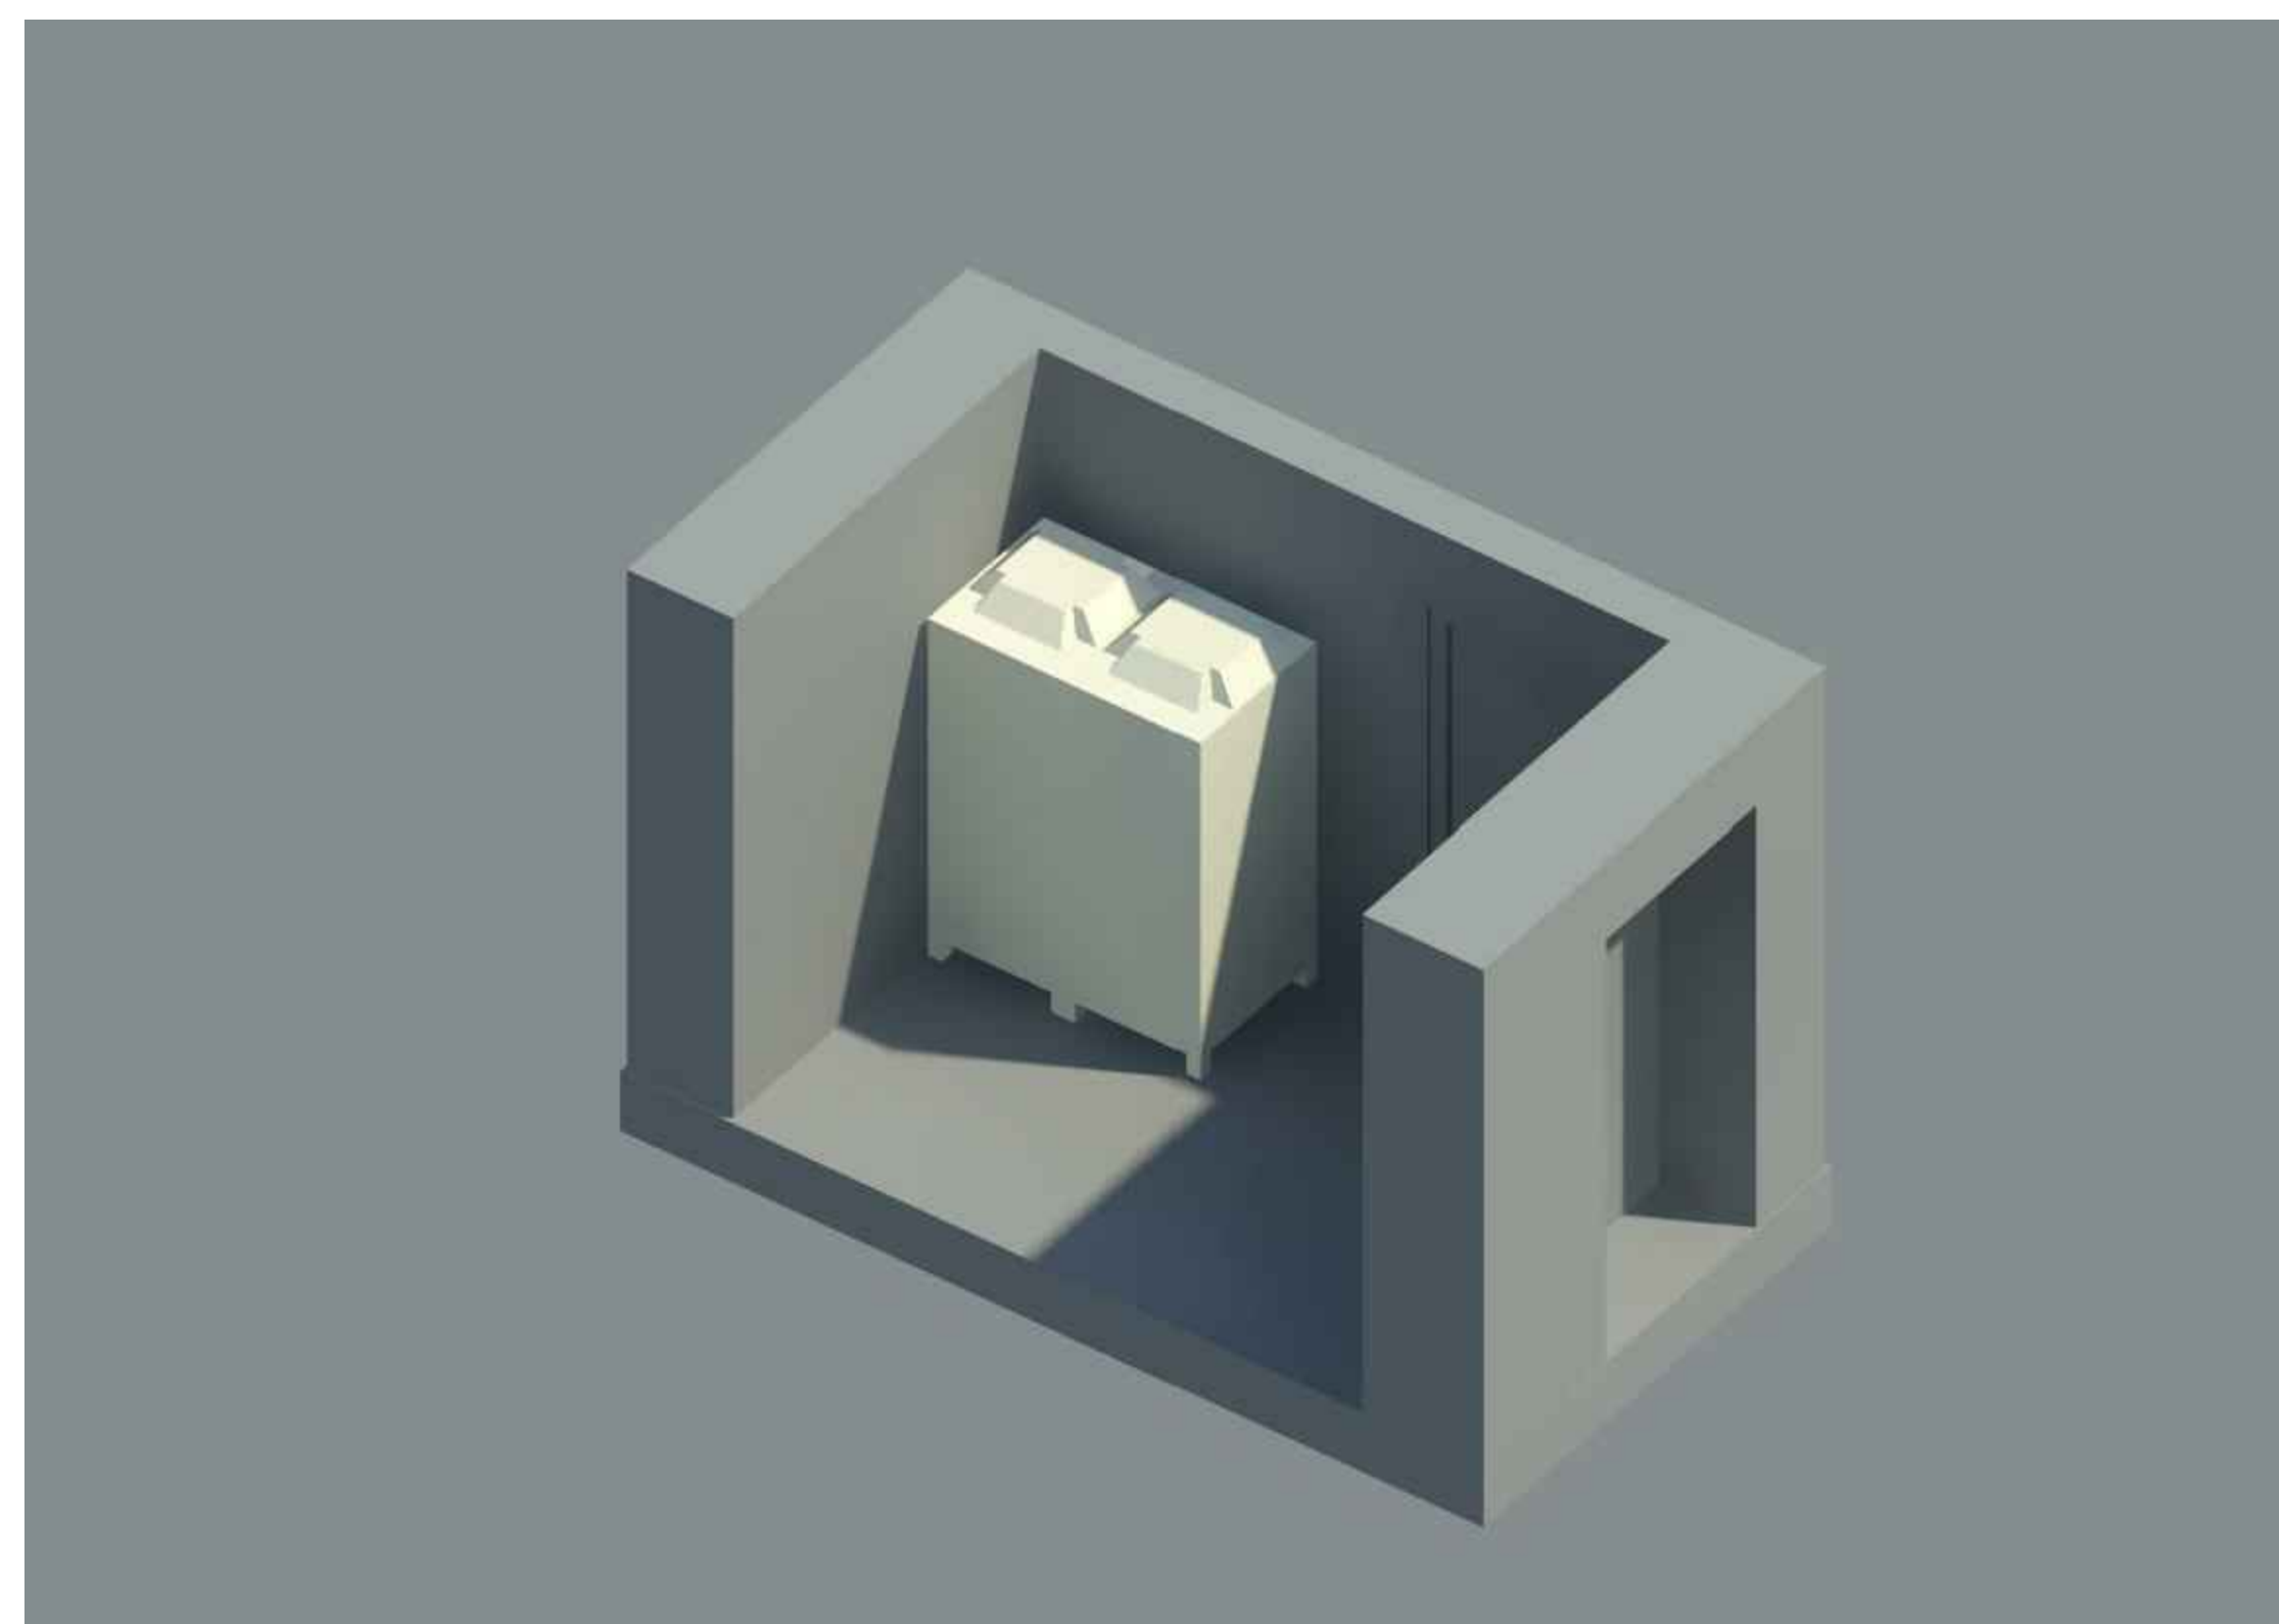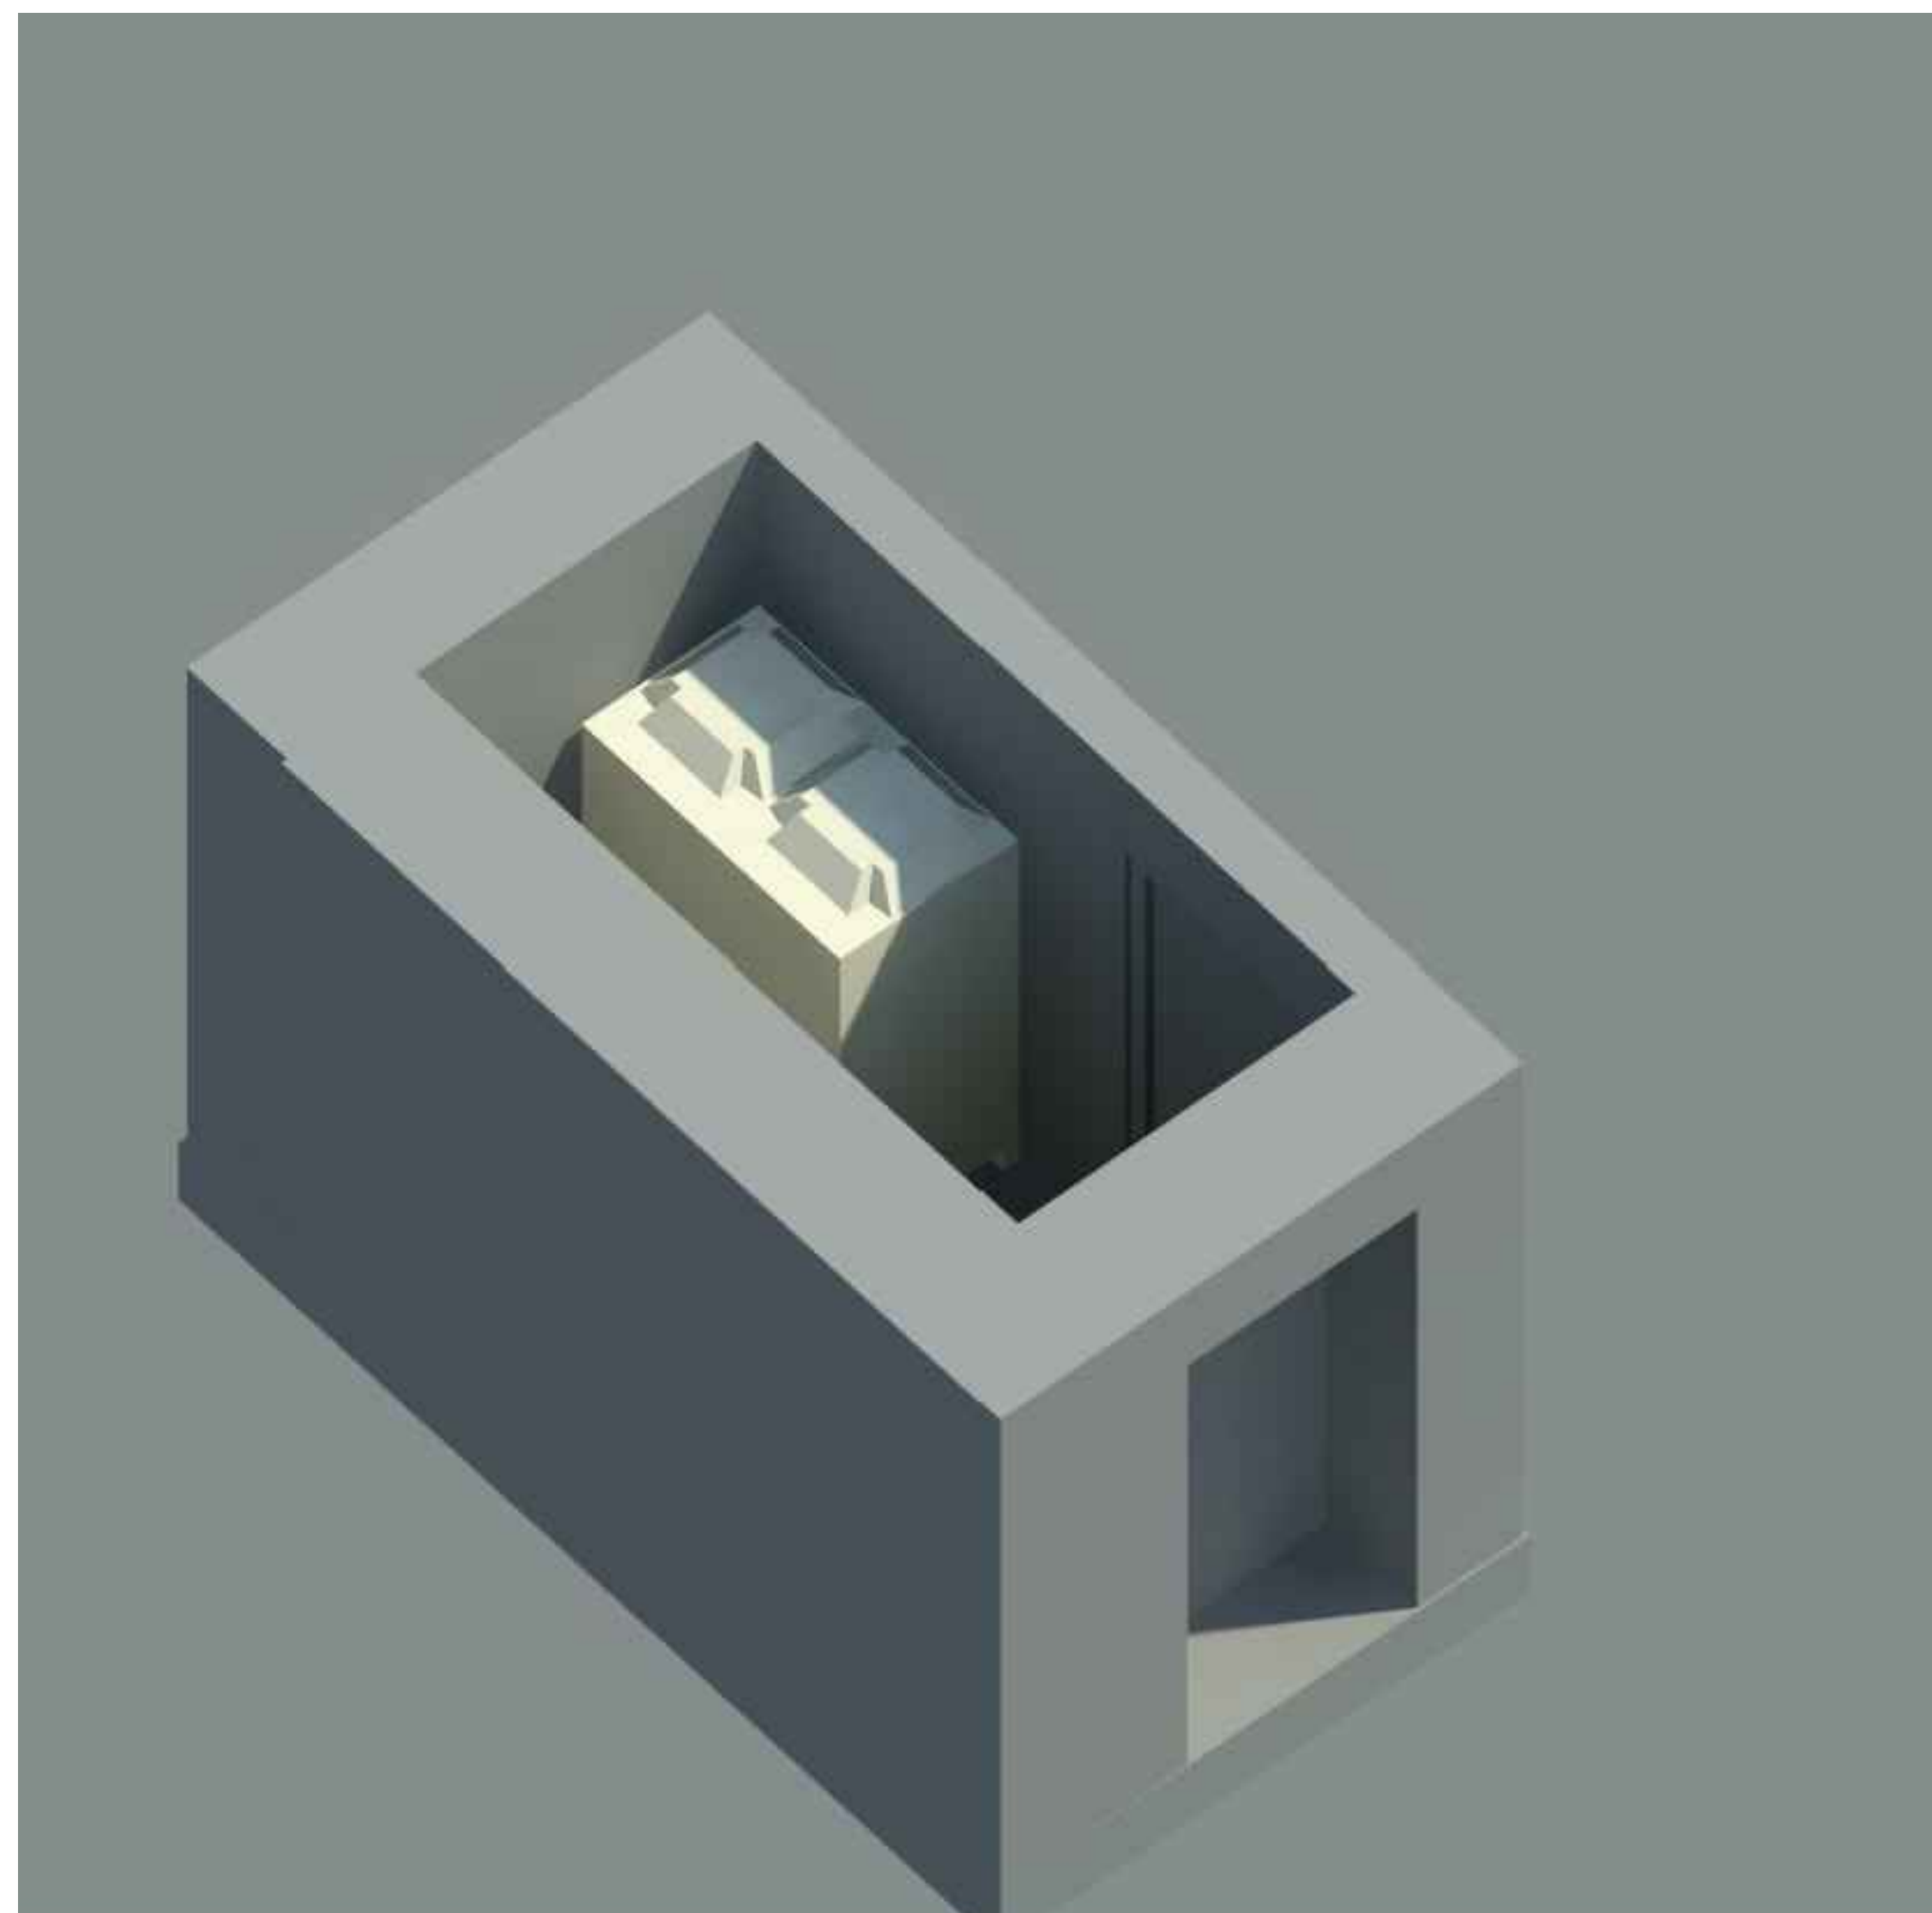

\TPS\

THIS DRAWING MUST NOT BE REPRODUCED WITHOUT PRIOR CONSENT.
DO NOT SCALE FROM THIS DRAWING.
THIS DRAWING IS COPYRIGHT. ©

GENERAL NOTES

PLANNING


0	FEB.13	PLANNING ISSUE
Rev	Date	Description

TPS

Taylor Project Services LLP

No.1 Cornhill
London EC3V 3ND
Tel 020 7743 6602
www.taylorprojectservices.com

Client:

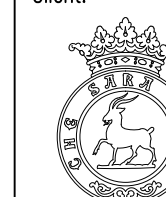

THE
BEDFORD
ESTATES

29a Montague Street
London
WC1B 5BL
Tel: 0171 636 2885
Fax: 0171 255 1729

Project

11 GOWER STREET
LONDON
WC1

Drawing Title

PROPOSED
INTERNAL LIGHTWELL
CONDENSER POSITION

Scale 1:50 @ A1

Date	07.02.13
------	----------

Drawn L.R.


Checked	G.N.T.
---------	--------

Drawing Status	
----------------	--


PLANNING

[illegible]


Drawing No.	TPS/11GS/LW
-------------	-------------

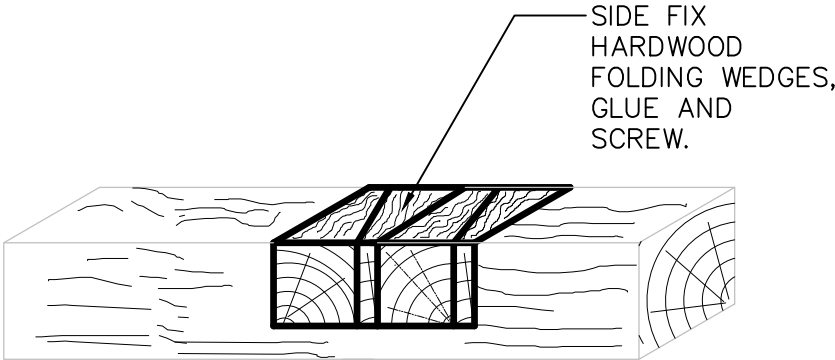


NOTCH REPAIR DETAIL
FOR LONG NOTCH
FOR NOTCHES GREATER THAN 25mm DEEP.

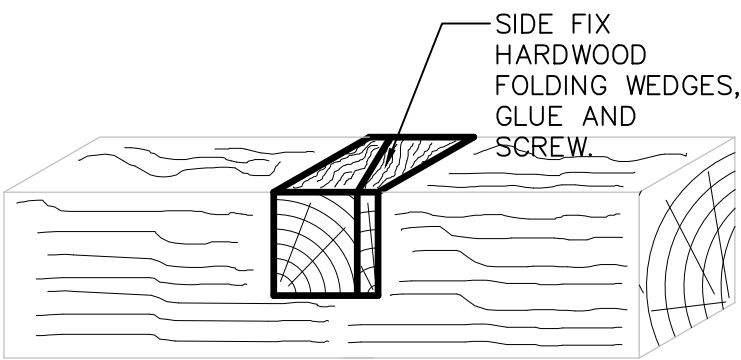


NOTCH REPAIR DETAIL 2
FOR NOTCHES GREATER THAN 25mm DEEP.

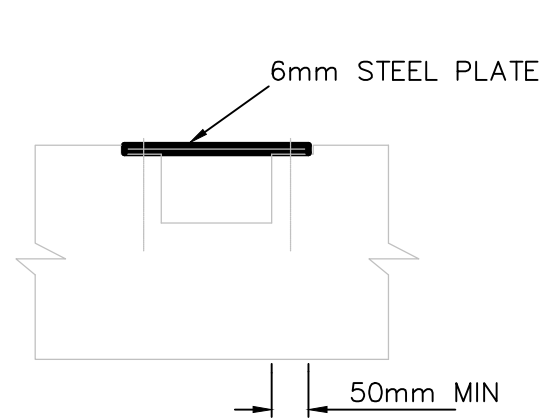


NOTCH REPAIR DETAIL 1
FOR NOTCHES UPTO 25mm DEEP AND OVER SERVICES

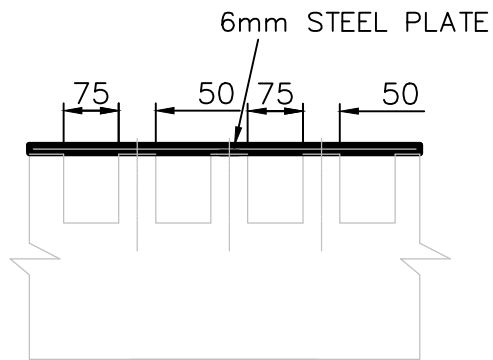

MULTI-NOTCH DETAIL 2
FOR NOTCHES UPTO 25mm DEEP AND OVER SERVICES

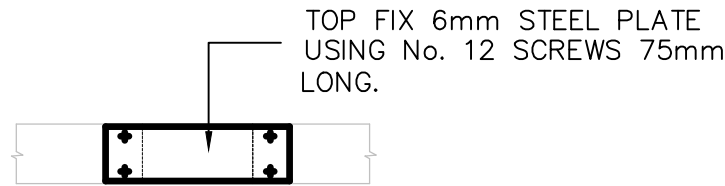

PLAN ON NOTCH REPAIR

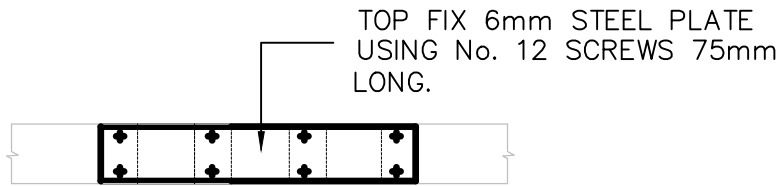

PLAN ON MULTI-NOTCH REPAIR