


16 17 18 19 20 21 22 23 24 25 26 27 28 29 30 31 32 33 34 35 36 (

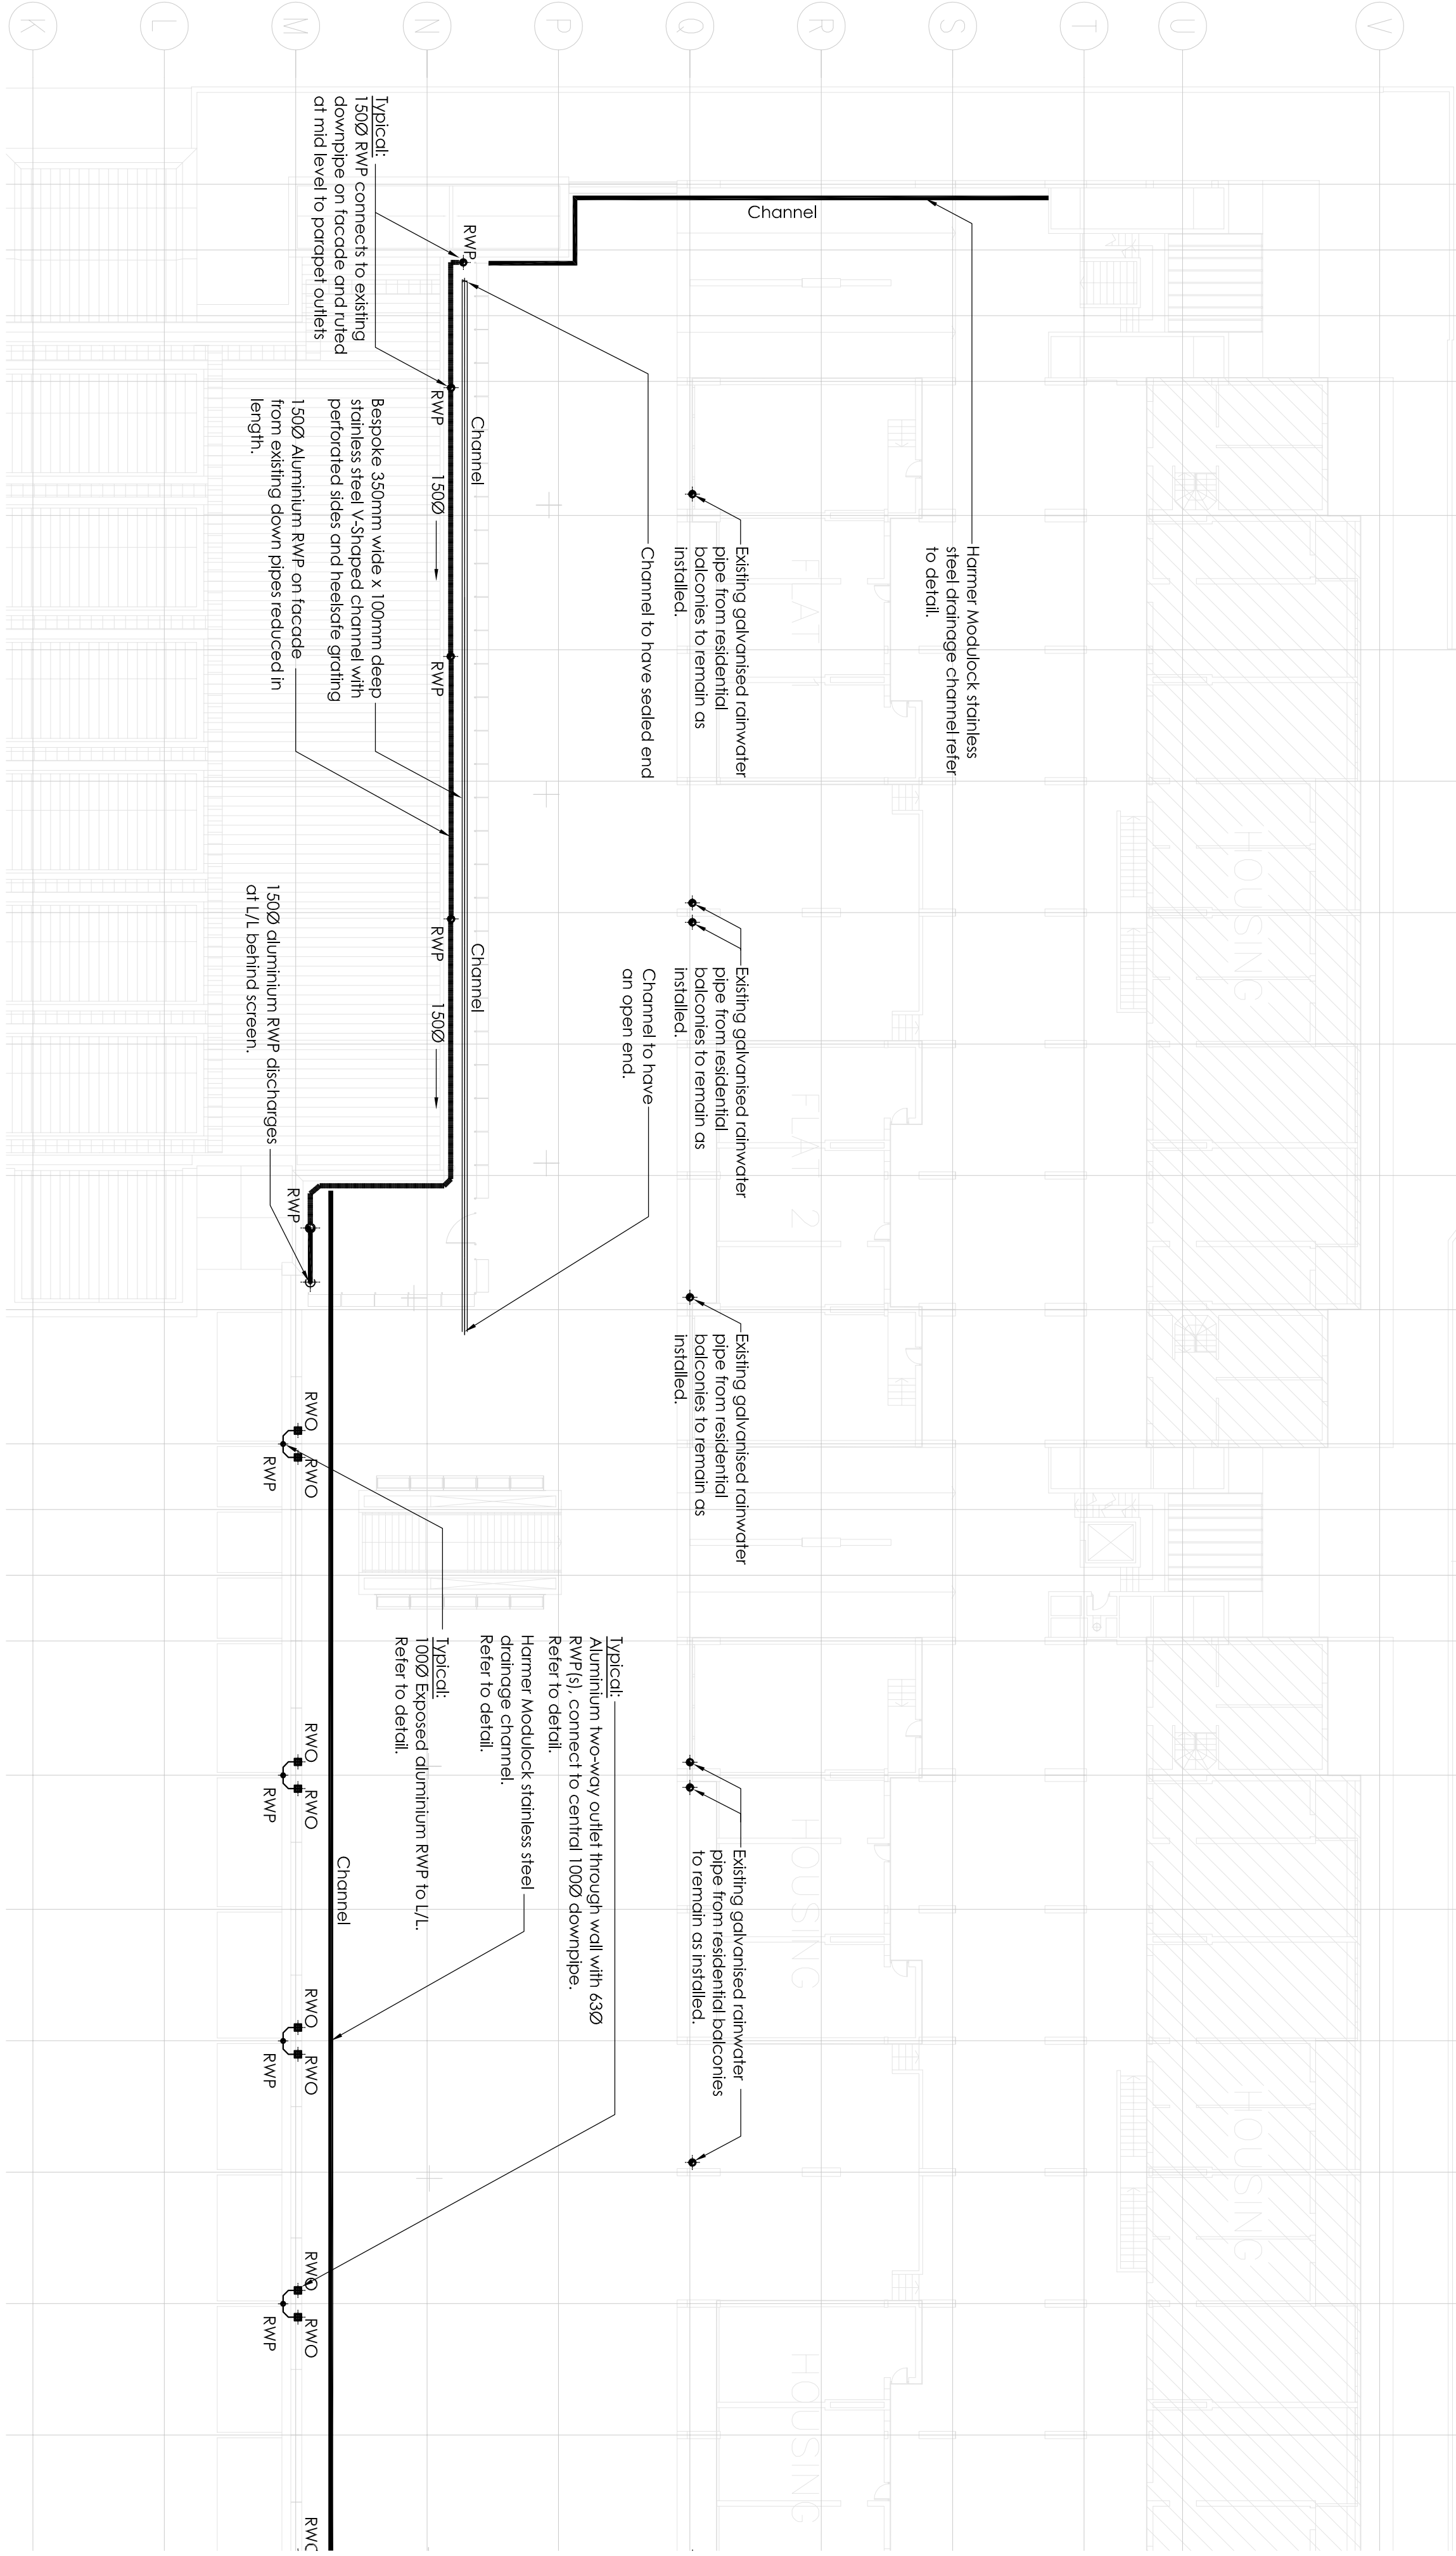

For continuation refer to drawing 53530/P/1/103

Important:

The drawing is the copyright © of Chapman BDSP and shall not be copied or reproduced without permission.

This drawing shall not be scaled.

Unless stated otherwise, all dimensions are in millimetres.

Where applicable, all dimensions shall be checked by the contractor onsite, prior to commencement of any works.

This drawing shall be read in conjunction with all other drawings and the service specification document(s).

All materials and workmanship shall conform with the relevant British & European Standards, Specifications and Codes of Practice.

Notes:

1. Rainwater outlet noted as existing (EX) shall remain

Client

Watts Group

Project

The Brunswick
Bloomsbury WC1

Production software

Autocad

Client

Watts Group

Project

The Brunswick
Bloomsbury WC1

Production software

Autocad

Chapman
BDSP

www.chapmanbdsp.com | info@chapmanbdsp.com

Status

Tender Issue

Drawing title

Podium Level
Drainage Layout
Sheet 1 of 4

Drawn

DB

Engineer

DB

Approved

DBU

Date m/d/y

Apr'13

Scale @ A1

1:200

File/BIM ref

53530-P/1/101

Drawing number

53530/P/1/101

Revision

T2

For continuation refer to drawing 53530/P/1/102