


For continuation refer to drawing 53530/P/1/101

**Important:**  
The drawing is the copyright © of Chapman BOSP and shall not be copied or reproduced without permission.  
This drawing shall not be scaled.  
Unless stated otherwise, all dimensions are in millimetres.  
Where applicable, all dimensions shall be checked by the contractor onsite, prior to commencement of any works.  
This drawing shall be read in conjunction with all other drawings and the services specification document(s).  
All materials and workmanship shall conform with the relevant British & European standards, Specifications and Codes of Practice.

Notes:

1. Rainwater outlet noted as existing (EX) shall remain

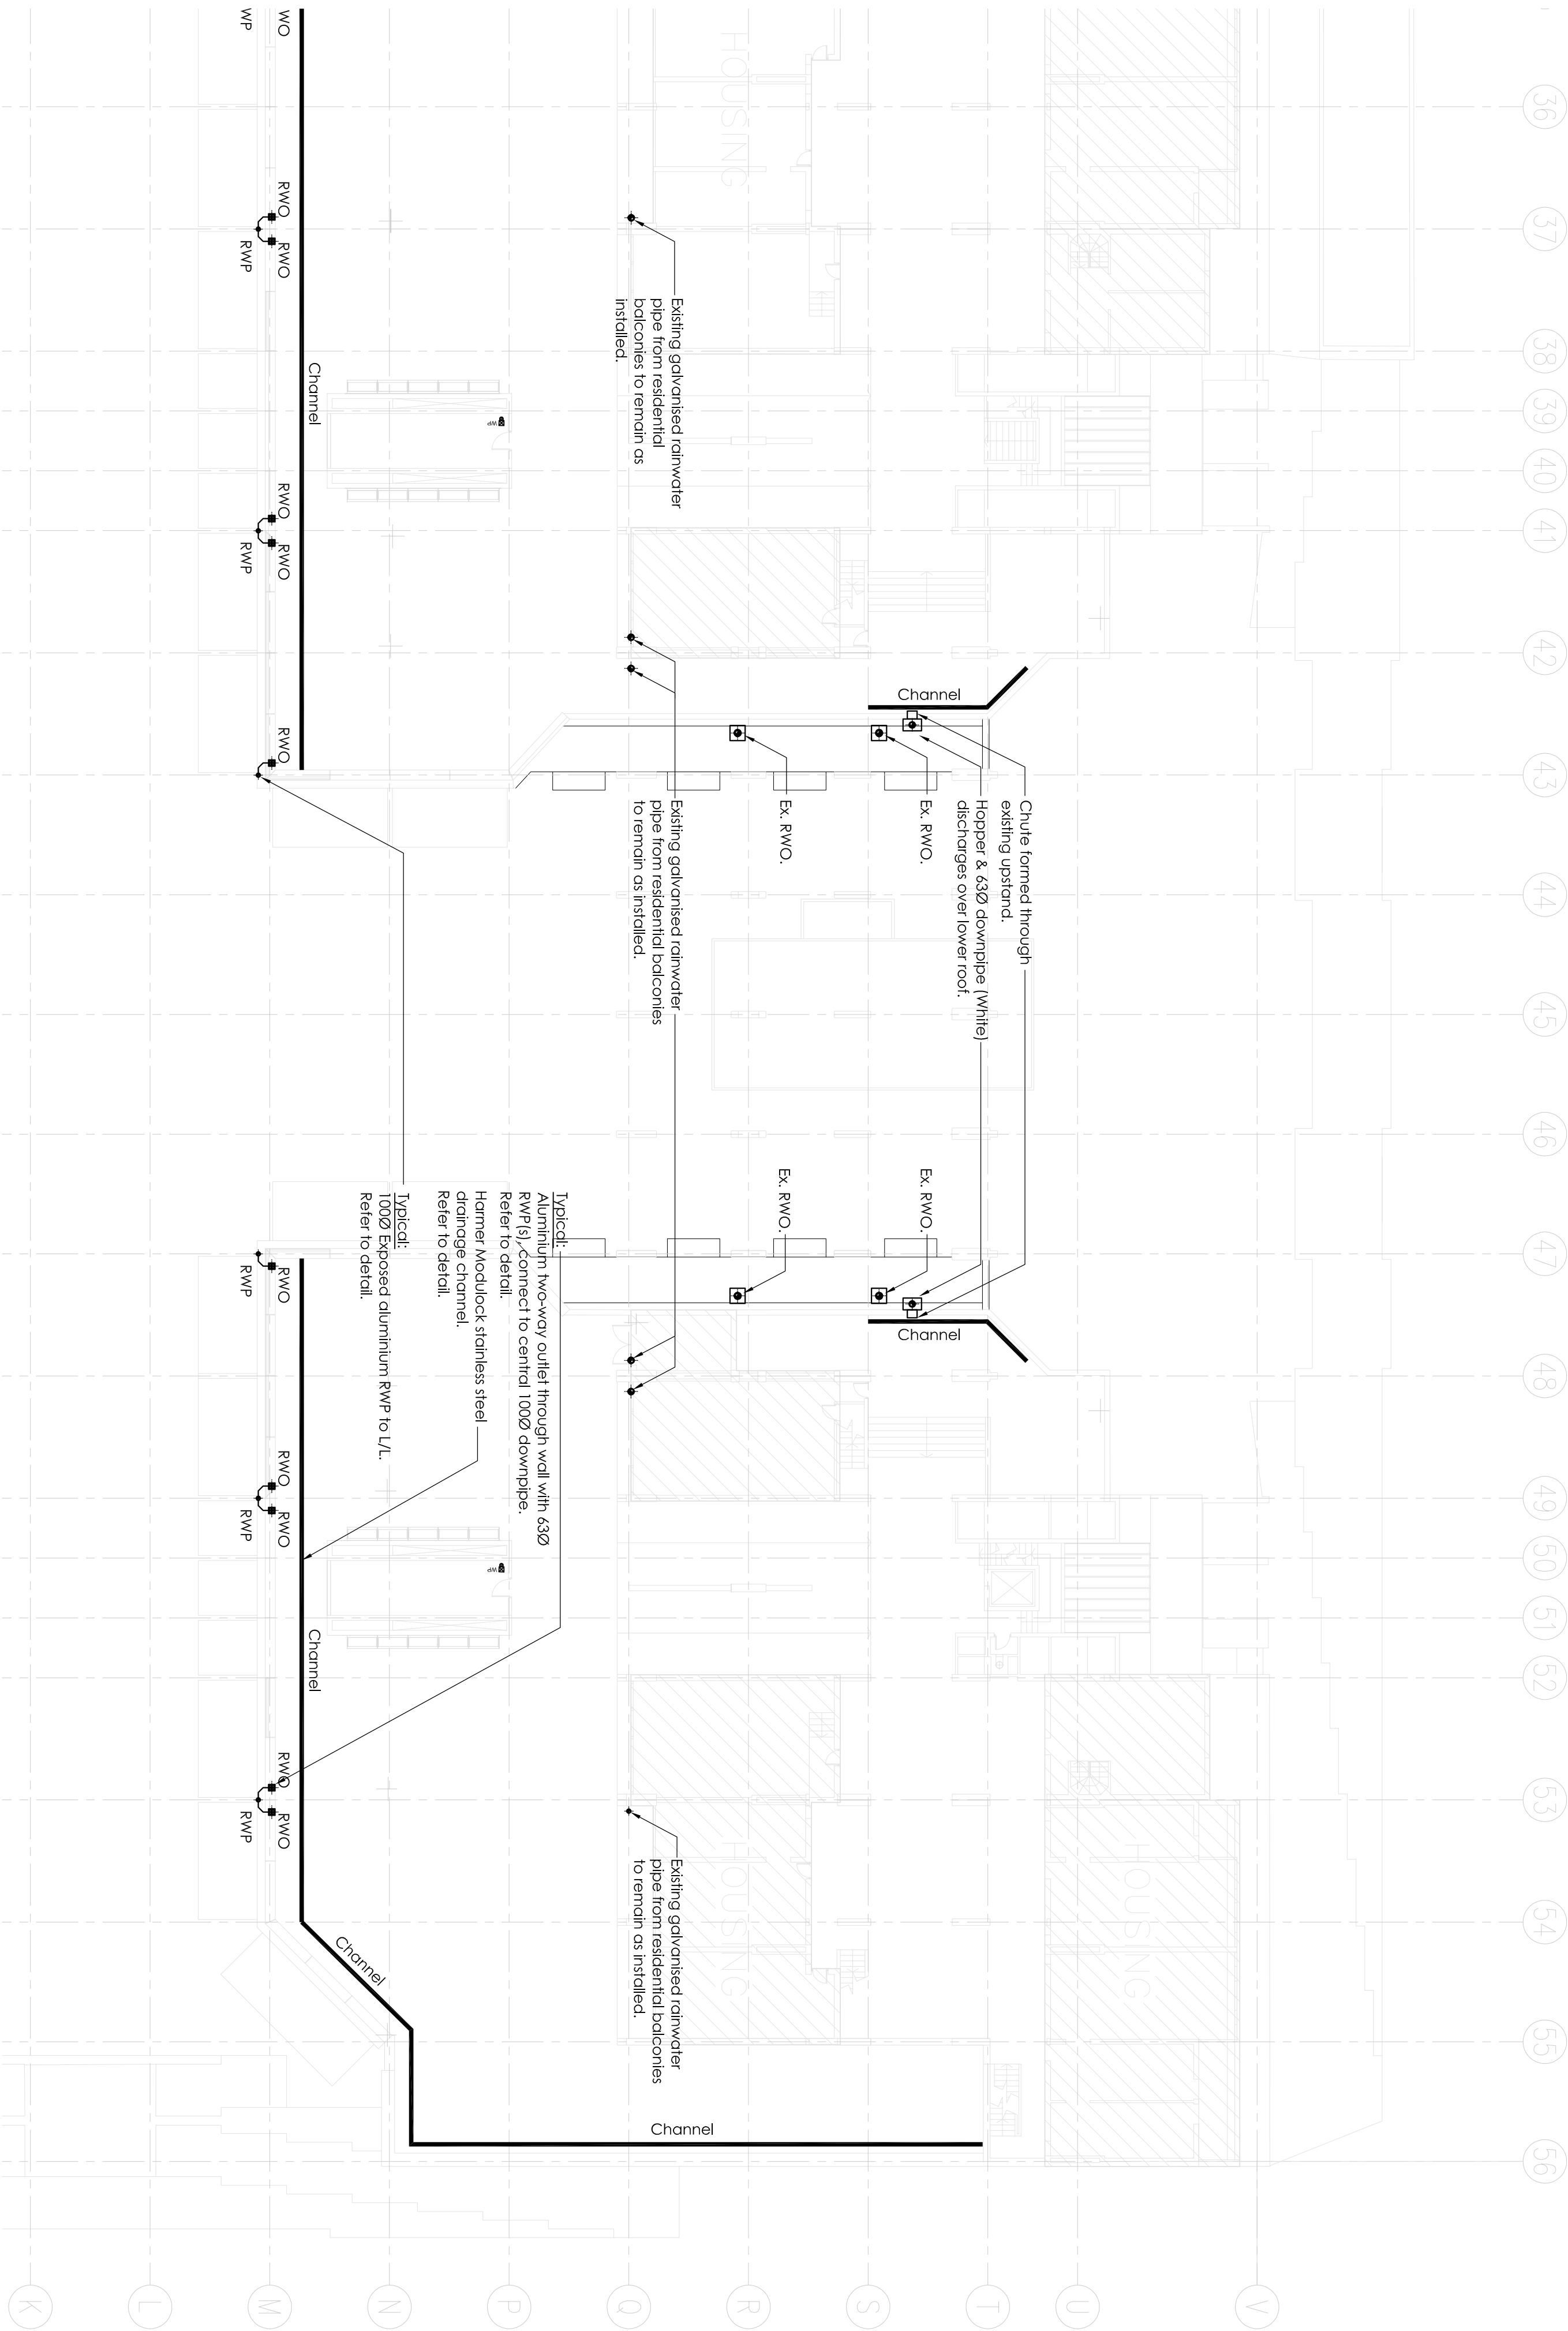

For continuation refer to drawing 53530/P/1/104

Client					Watts Group				
Project					The Brunswick Bloomsbury WC1				
T2	May 13	Tender Issue	DB	DBU	<div>Chapman + BDSP</div> <div>www.chapmanbdsp.com   info@chapmanbdsp.com</div>				
T1	Apr 13	Tender Issue	DB	DBU					
Rev	Date	Description	Dim	Chud					
Reference files					Status				
Production software					Autocad				
Drawing title					Podium Level Drainage Layout Sheet 2 of 4				
Drawn					Engineer				
DB					Approved				
Scale @ A1					Date origin				
1:200					Apr 13				
Drawing number					Revision				
53530/P/1.102					T2				