


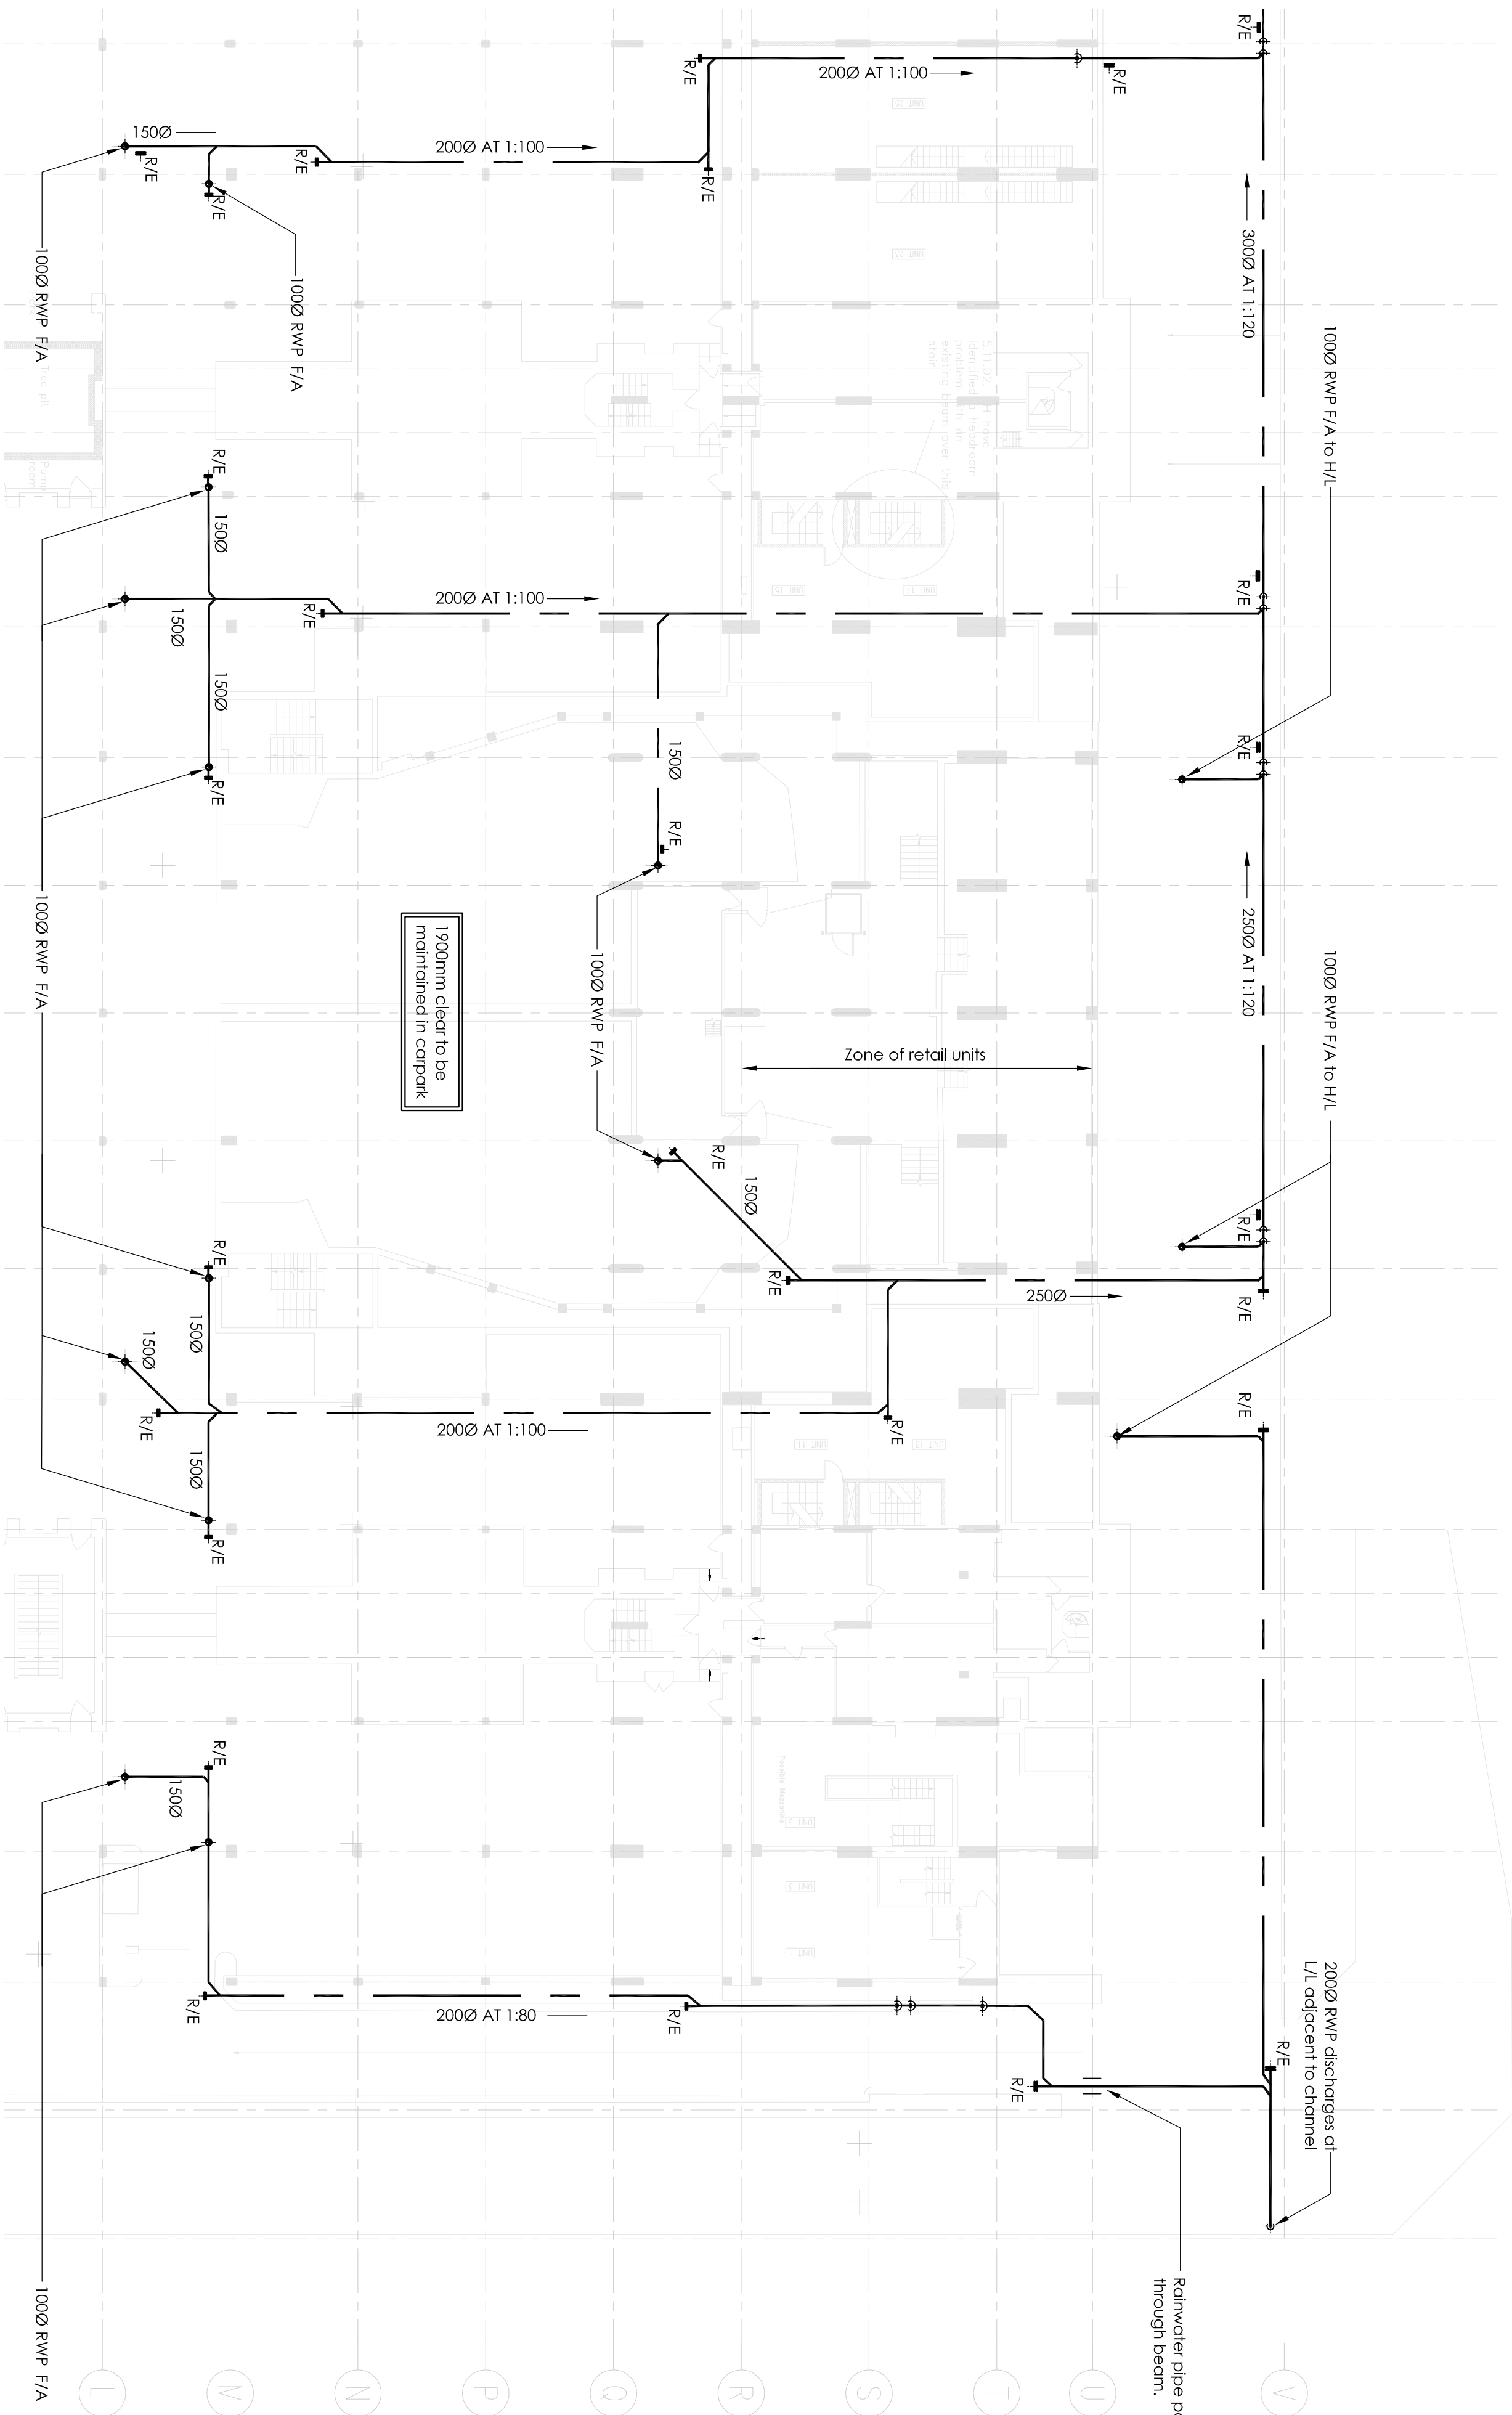

important:

or reproduced without permission

This drawing shall not be scaled.

Unless stated otherwise, all dimensions are in mm.

onsite, prior to commencement of any works.

services specification document(s)

European Standards, Specifications and Codes of Practice.

Notes:

1. All existing syphonic drainage at carpark level is to be stripped out and replaced with a gravity system.
2. Any changes in pipe sizes are to be done with level invert to maintain head room within carpark.

For continuation refer to drawing 53530/P/B/104

Rev	Date	Description	Dim	Chkd
T2	May'13	Tender Issue	D8	DBU
T1	Apr'13	Tender Issue	D8	DBU

Client	Watts Group
Project	The Brunswick Bloomsbury WC1

**Chapman
+BDSP**

www.chapmanbdsp.com | info@chapmanbdsp.com

Drawing title			
Upper Carpark Drainage Layout Sheet 2 of 4			
Drawn	Engineer	Approved	Date origin
DB	DB	DBU	Apr 13
Scale @ A1			
File Ref of			
53530-H-102			