

EXISTING & PROPOSED FLOOR PLANS (FULL VERSION)

25. MAR. 2013

OMD

OFFICE REFURBISHMENT

MINERVA HOUSE 1-4 NORTH CRESCENT LONDON, WC1E 7ER

triflecreative*

+ 44 7796 147 117
hello@triflecreative.com
<http://www.triflecreative.com>

DRAWING LIST



SHEET NO	DRAWING NO	DRAWING TITLE	SCALE
001	-	COVER	NONE
002	OMD-LI-01	DRAWING LIST	NONE
003	OMD-FL-01	EXISTING FLOOR PLAN	A0: 1 / 50
004	OMD-FL-02	PROPOSED FLOOR PLAN	A0: 1 / 50
005	OMD-FL-03	PROPOSED FURNITURE PLAN	A0: 1 / 50
006	OMD-FL-04	PROPOSED BUILDING WORK PLAN	A0: 1 / 50
007	OMD-CE-01	EXISTING CEILING LEVEL PLAN	A0: 1 / 50
008	OMD-CE-02	PROPOSED CEILING LEVEL PLAN	A0: 1 / 50
009	OMD-CE-03	PROPOSED CEILING BUILDING WORK PLAN	A0: 1 / 50
010	OMD-ME-01	EXISTING AC PLAN	A0: 1 / 50
011	OMD-ME-02	PROPOSED AC PLAN	A0: 1 / 50
012	OMD-ME-03	EXISTING FIRE ALARM PLAN	A0: 1 / 50
013	OMD-ME-04	PROPOSED FIRE ALARM PLAN	A0: 1 / 50
014	OMD-ME-05	EXISTING CCTV/ DOOR ACCESS PLAN	A0: 1 / 50
015	OMD-ME-06	PROPOSED CCTV/DOOR ACCESS PLAN	A0: 1 / 50
016	OMD-ME-07	EXISTING HEATING/ PLUMBING/ WASTE PLAN	A0: 1 / 50
017	OMD-ME-08	PROPOSED HEATING/ PLUMBING/ WASTE PLAN	A0: 1 / 50
018	OMD-ME-09	EXISTING CEILING LIGHTING PLAN	A0: 1 / 50
019	OMD-ME-10	PROPOSED CEILING LIGHTING PLAN	A0: 1 / 50
020	OMD-ME-11	EXISTING ELECTRIC POWER PLAN	A0: 1 / 50
021	OMD-ME-12	PROPOSED ELECTRIC POWER PLAN	A0: 1 / 50
022	OMD-ME-13	EXISTING DATA PLAN	A0: 1 / 50
023	OMD-ME-14	PROPOSED DATA PLAN	A0: 1 / 50
024	OMD-ME-15	ISOLATION OF EXISTING WALL LIGHTS/ SOCKETS	A0: 1 / 50

[illegible]

PROJECT TITLE		DRAWING TITLE		CLIENT APPROVAL		REVISION		DRAWN BY		DATE		triflecreative* + 44 7796 147 117 hello@triflecreative.com http://www.triflecreative.com	
OMD OFFICE REFURBISHMENT		DRAWING LIST						JEAN-YOUNG IM		21. MAR. 2013			
								CHECKED BY		SCALE			
								APPROVED BY		A0 : 1 / 50			
SITE		DRAWING REFERENCE						EMMA MORLEY		DRAWING NO.		SHEET NO.	
MINERVA HOUSE 1-4 NORTH CRESCENT LONDON,WC1E 7ER										OMD-LI-01			




- STUD WALL TO BE DEMOLISHED
- STUD + GLASS WALL TO BE DEMOLISHED
- GLASS WALL TO BE DEMOLISHED

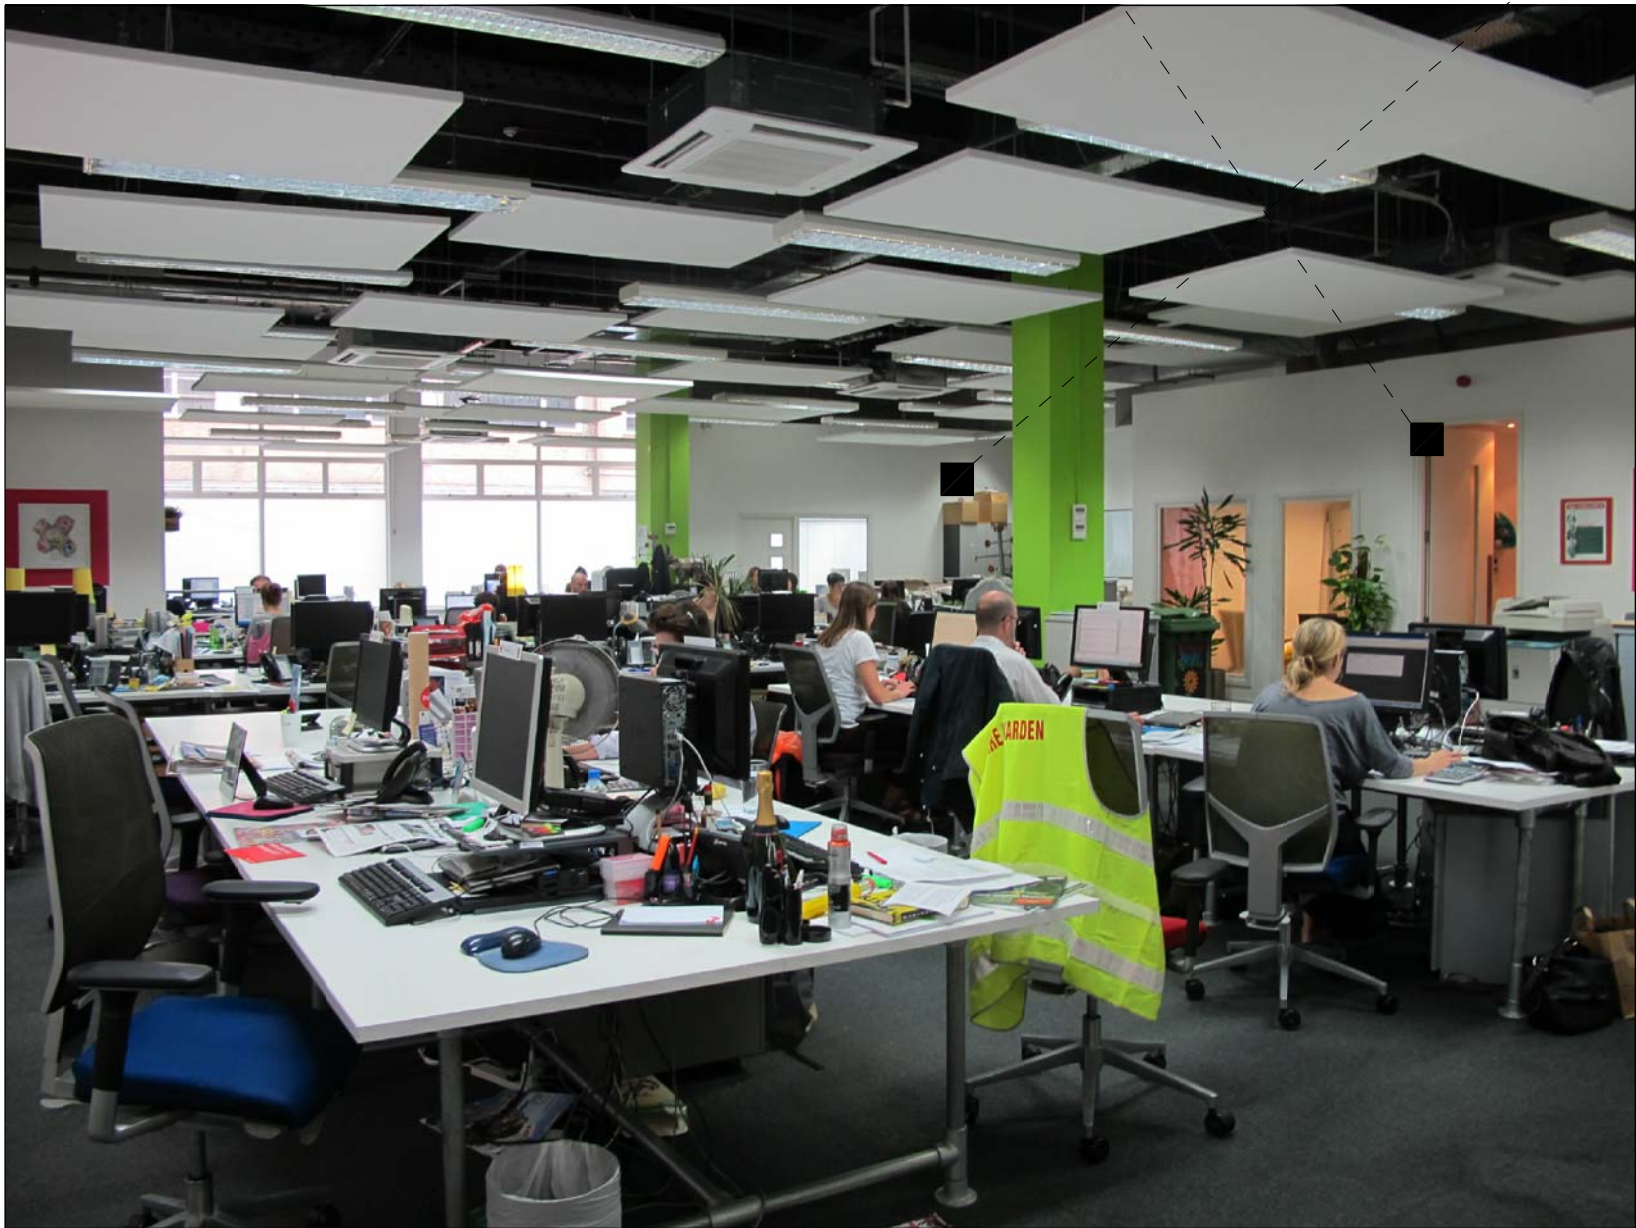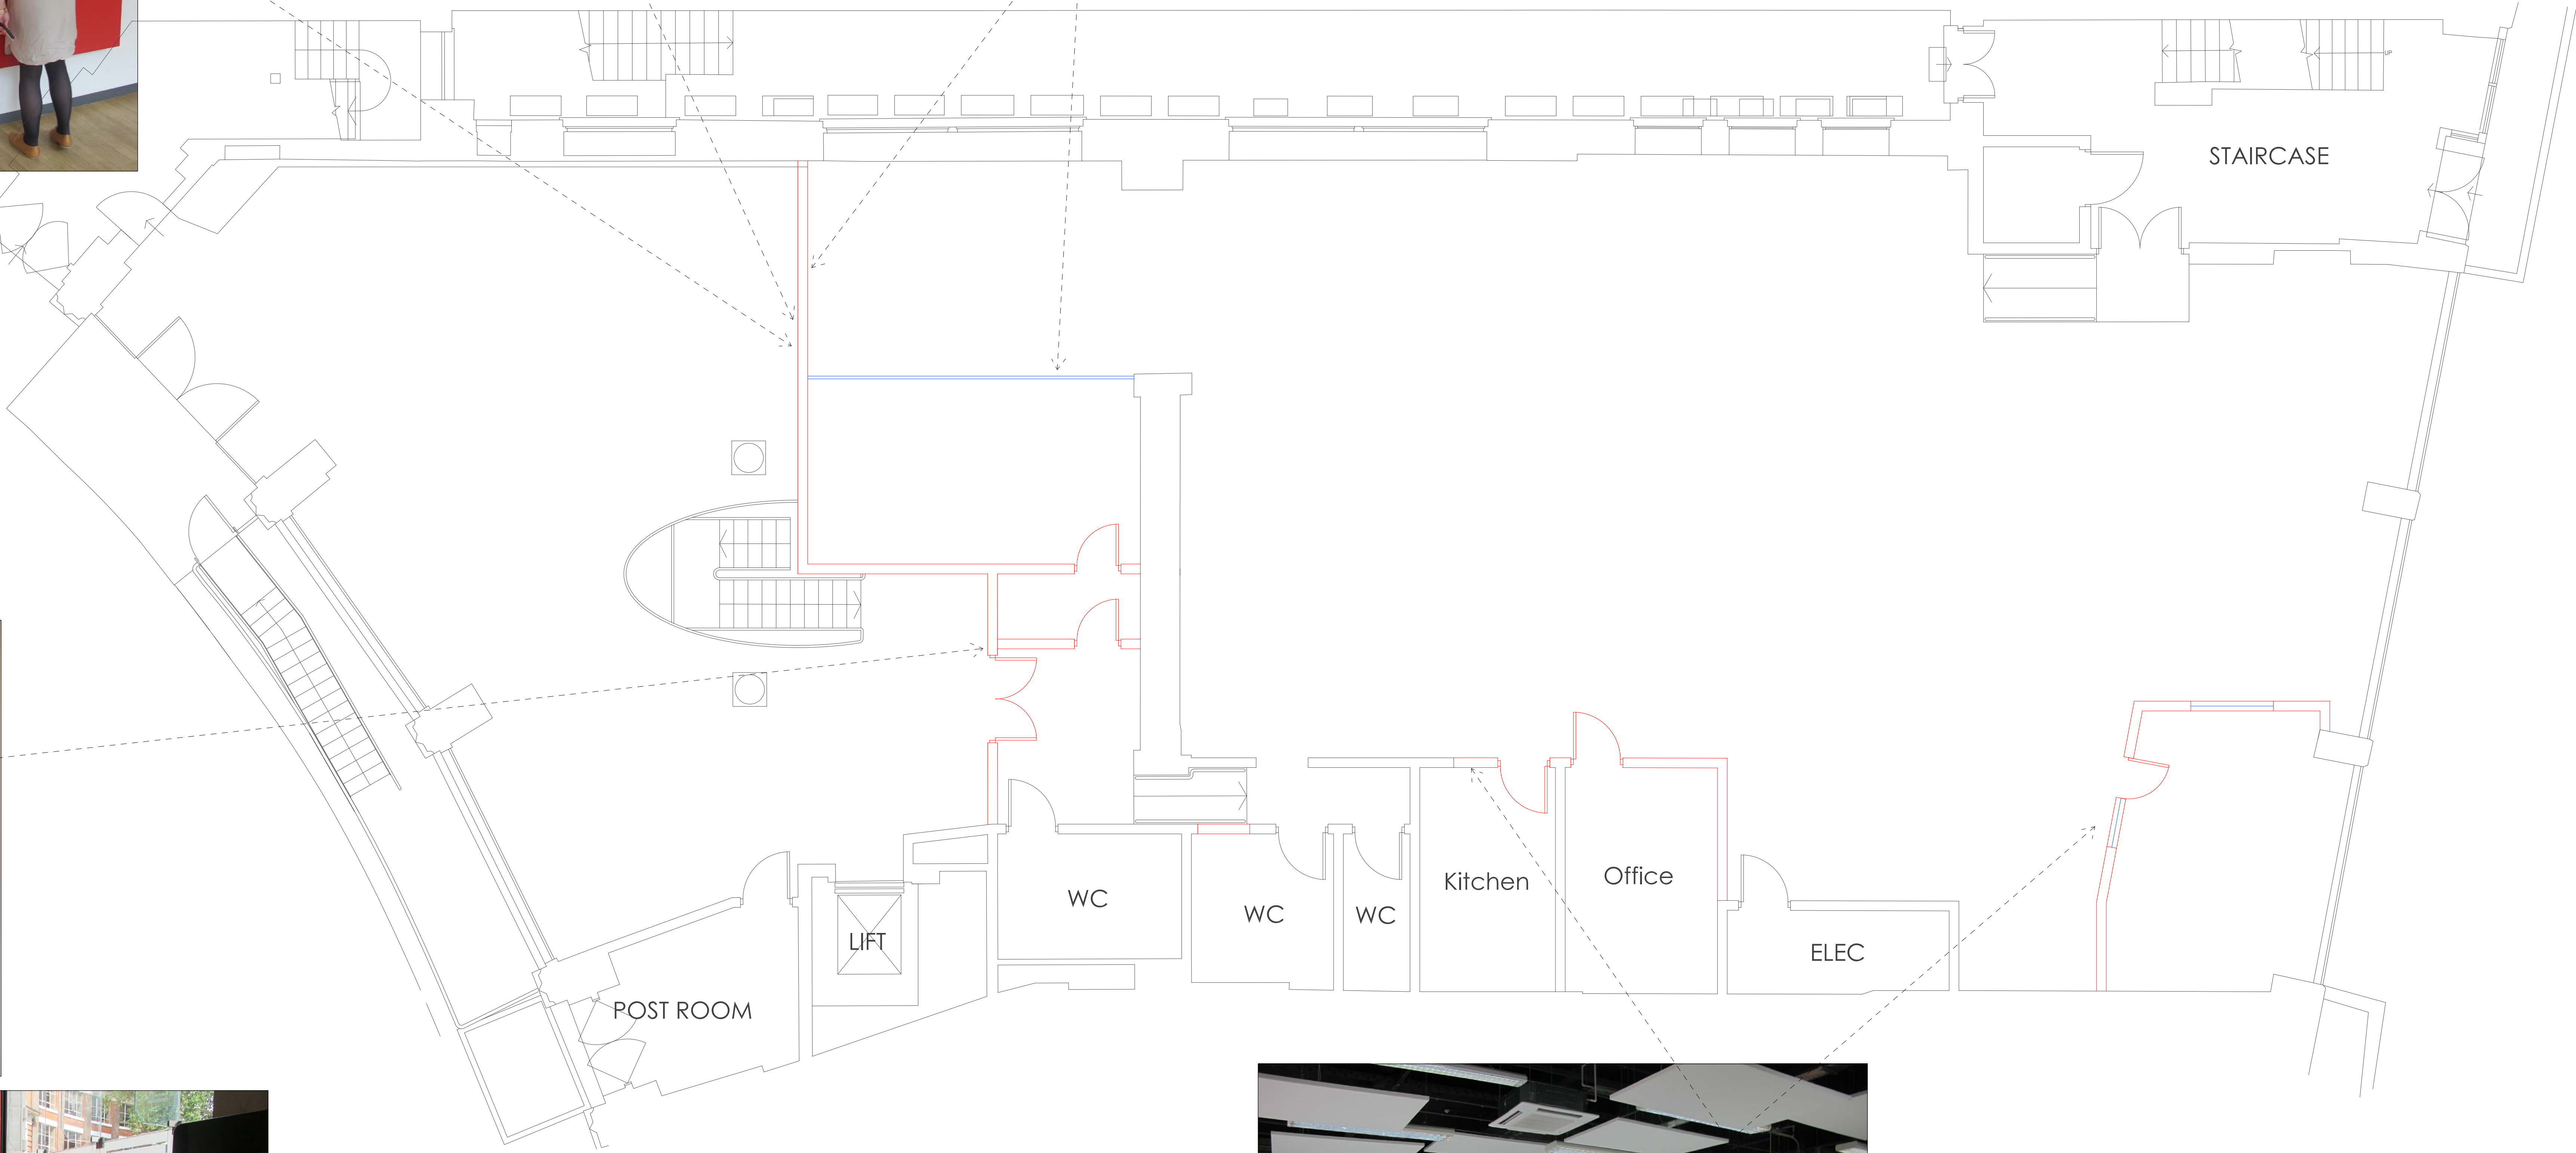

* NOTE
ALL STUDWALLS (NONE LOAD BEARING) BEING REMOVED OUR CONSTRUCTED OF 75X50 @ 400C/C WITH 15MM SOUNDBLOCK WITH 2MM THISTLE MULTI FINISH COAT AND PAINTED.

PROJECT TITLE		DRAWING TITLE		CLIENT APPROVAL		REVISION		DRAWN BY		DATE		triflecreative* + 44 7796 147 117 hello@triflecreative.com http://www.triflecreative.com
OMD		EXISTING						JEAN-YOUNG IM		21. MAR. 2013		
OFFICE REFURBISHMENT		FLOOR PLAN								A0 : 1 / 50		
SITE		DRAWING REFERENCE						APPROVED BY		DRAWING NO.		
MINERVA HOUSE 1-4 NORTH CRESCENT LONDON,WC1E 7ER								EMMA MORLEY		OMD-FL-01		SHEET NO.

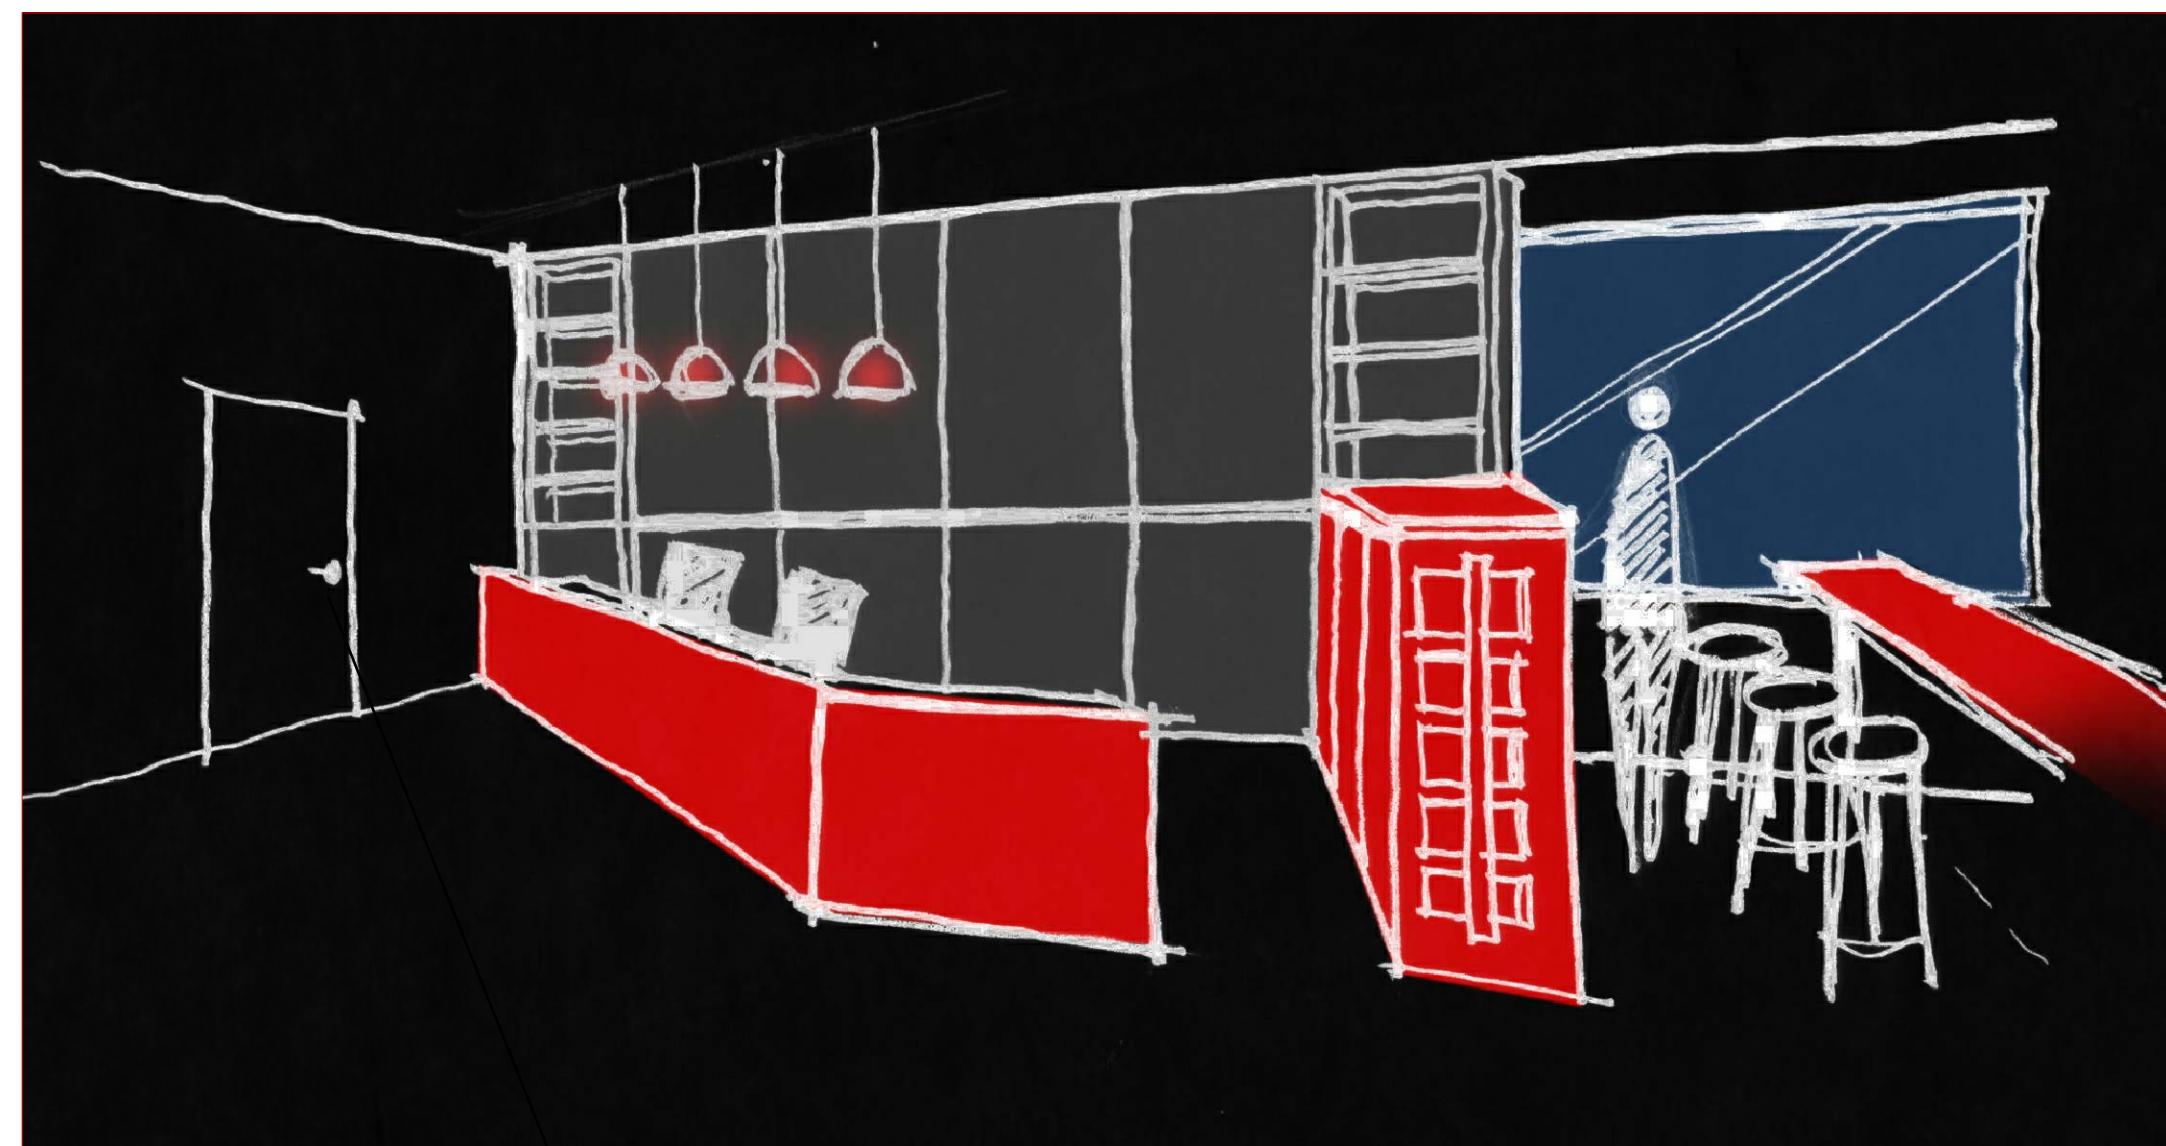

RECEPTION AREA



MULTI-SCREEN WALL





KITCHEN



BAR & STOOL




STEP SEAT +
RAISED PLATFORM

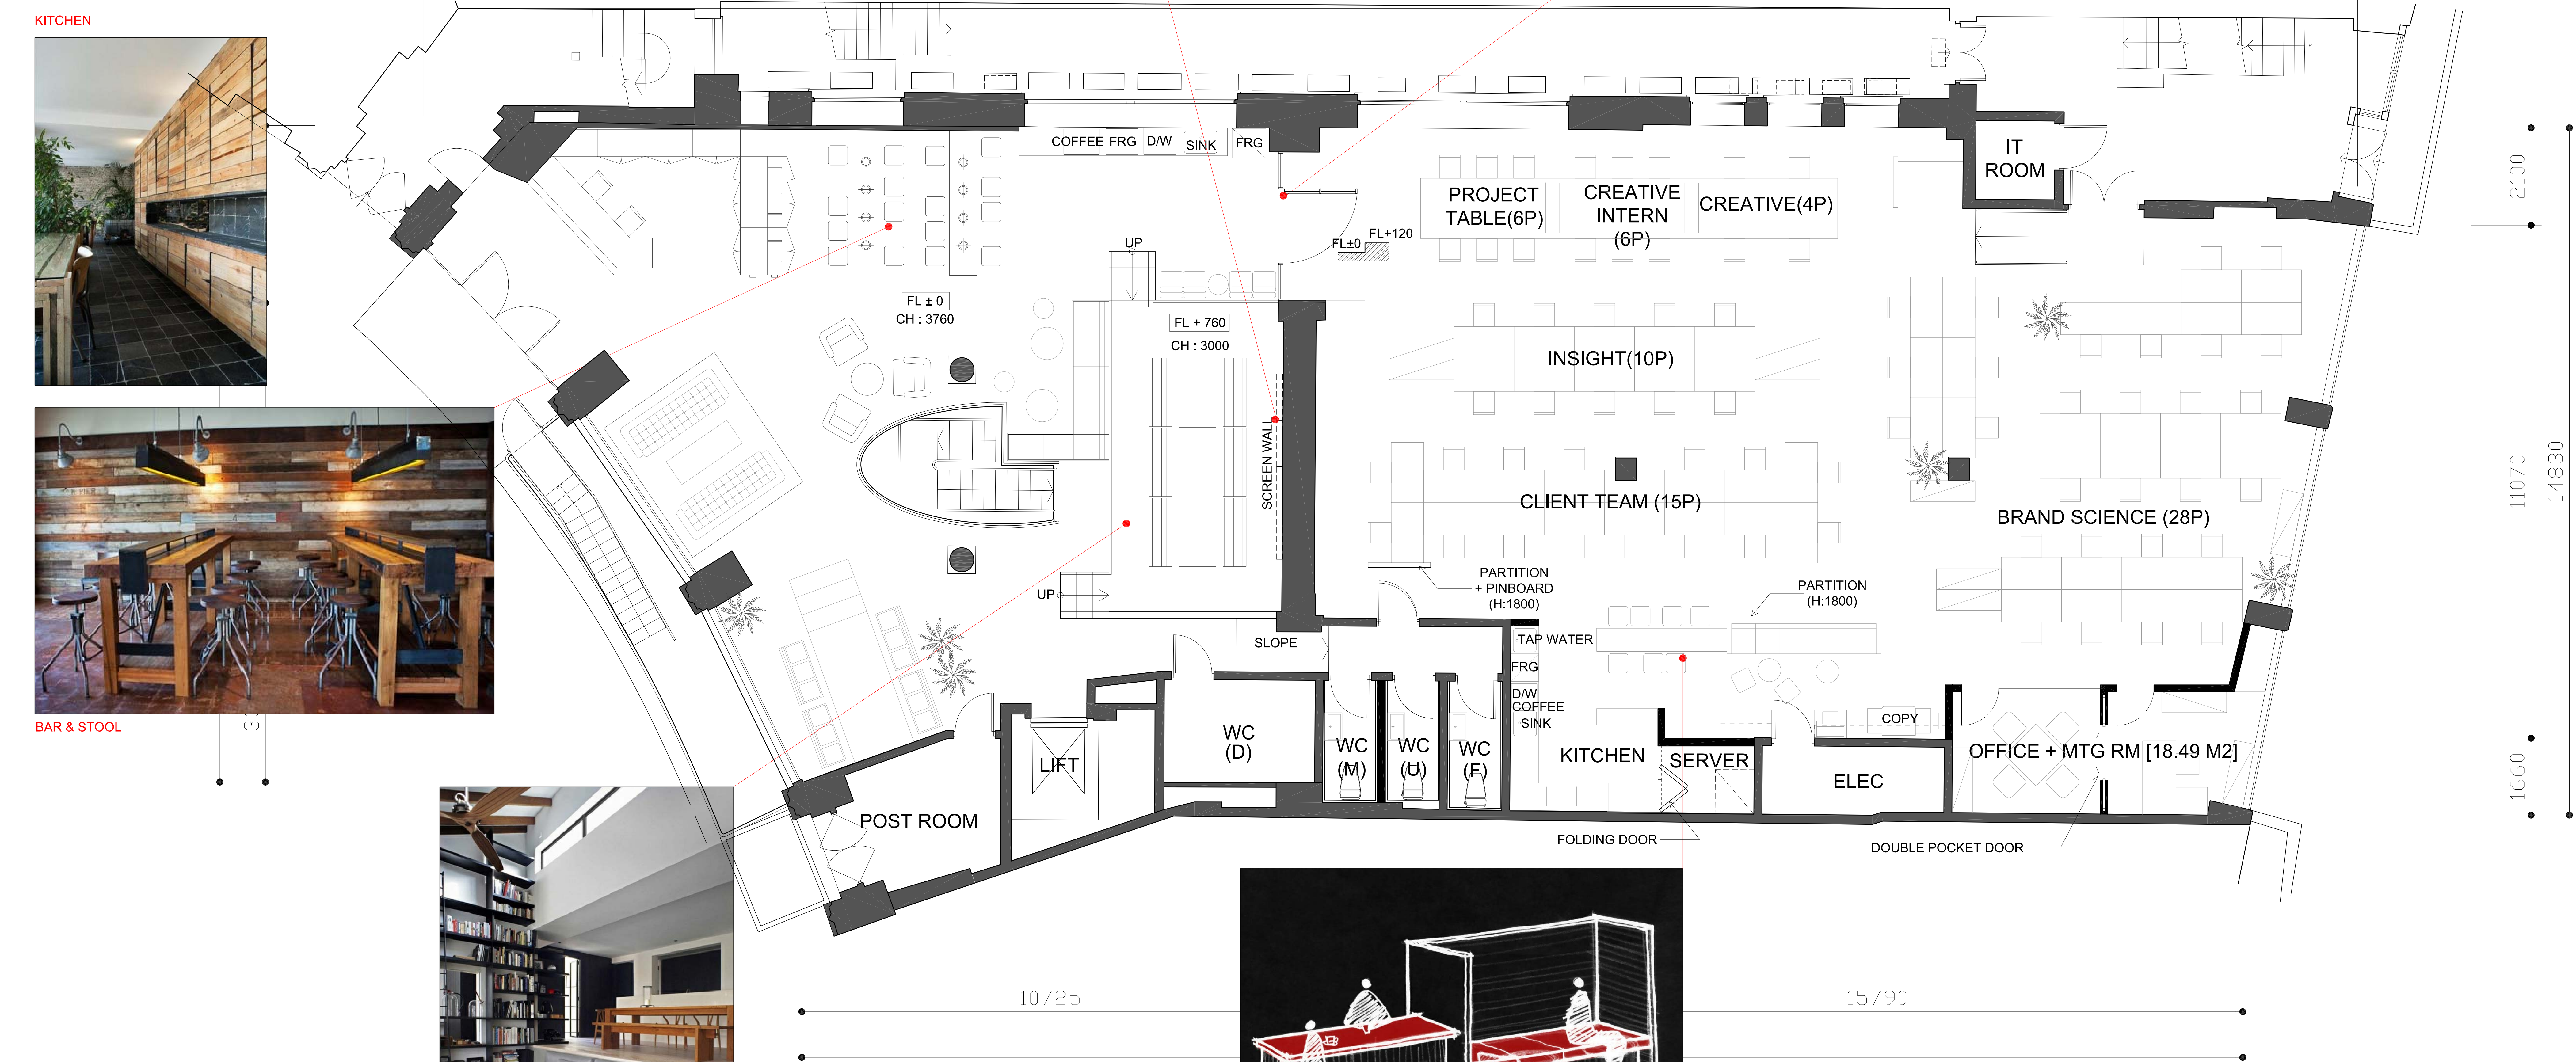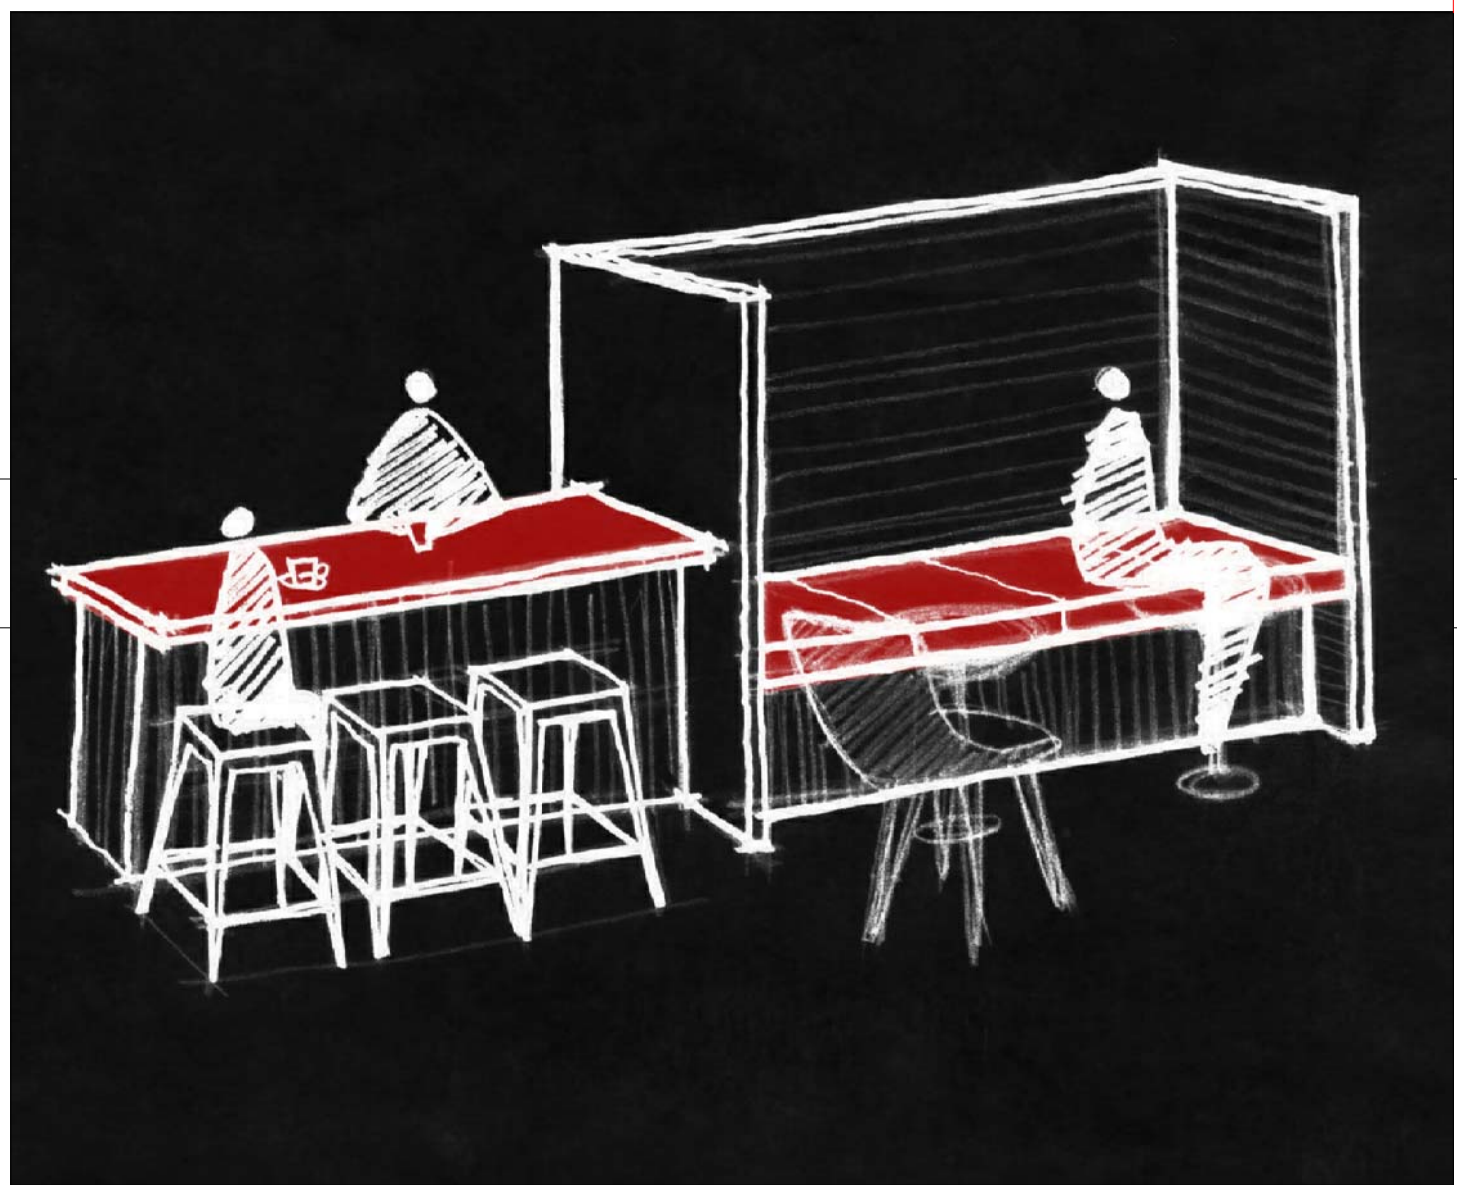

* NOTE
ALL STUDWALLS (NONE LOAD BEARING) WILL BE CONSTRUCTED WITH 75X50 @ 400C/C WITH 15MM SOUNDBLOC WITH 2MM THISTLE MULTI FINISH COAT. ALL MANUFACTURED BY BRITISH GYPSUM AND WILL MEET BS 5492.

FIRE RATED GLASS WILL ALSO BE USED FOR DOOR OPENINGS/PARTITIONS AND MEET ALL BS STANDARDS.

PROJECT TITLE		DRAWING TITLE		CLIENT APPROVAL		REVISION						DRAWN BY		DATE		triflecreative* + 44 7796 147 117 hello@triflecreative.com http://www.triflecreative.com			
OMD OFFICE REFURBISHMENT		PROPOSED FLOOR PLAN				17 DEC 2012		06		25 FEB 2013		11		19 MAR 2013				21. MAR. 2013	
						02		07 JAN 2013		07		04 MAR 2013							
						03		14 JAN 2013		08		06 MAR 2013							
						04		25 JAN 2013		09		11 MAR 2013							
SITE		DRAWING REFERENCE				05		21 FEB 2013		10						A0 : 1 / 50			
MINERVA HOUSE 1-4 NORTH CRESCENT LONDON,WC1E 7ER		OMDGRFL_OPT01_V12_MAR19														DRAWING NO. OMD-FL-02			
																SHEET NO.			

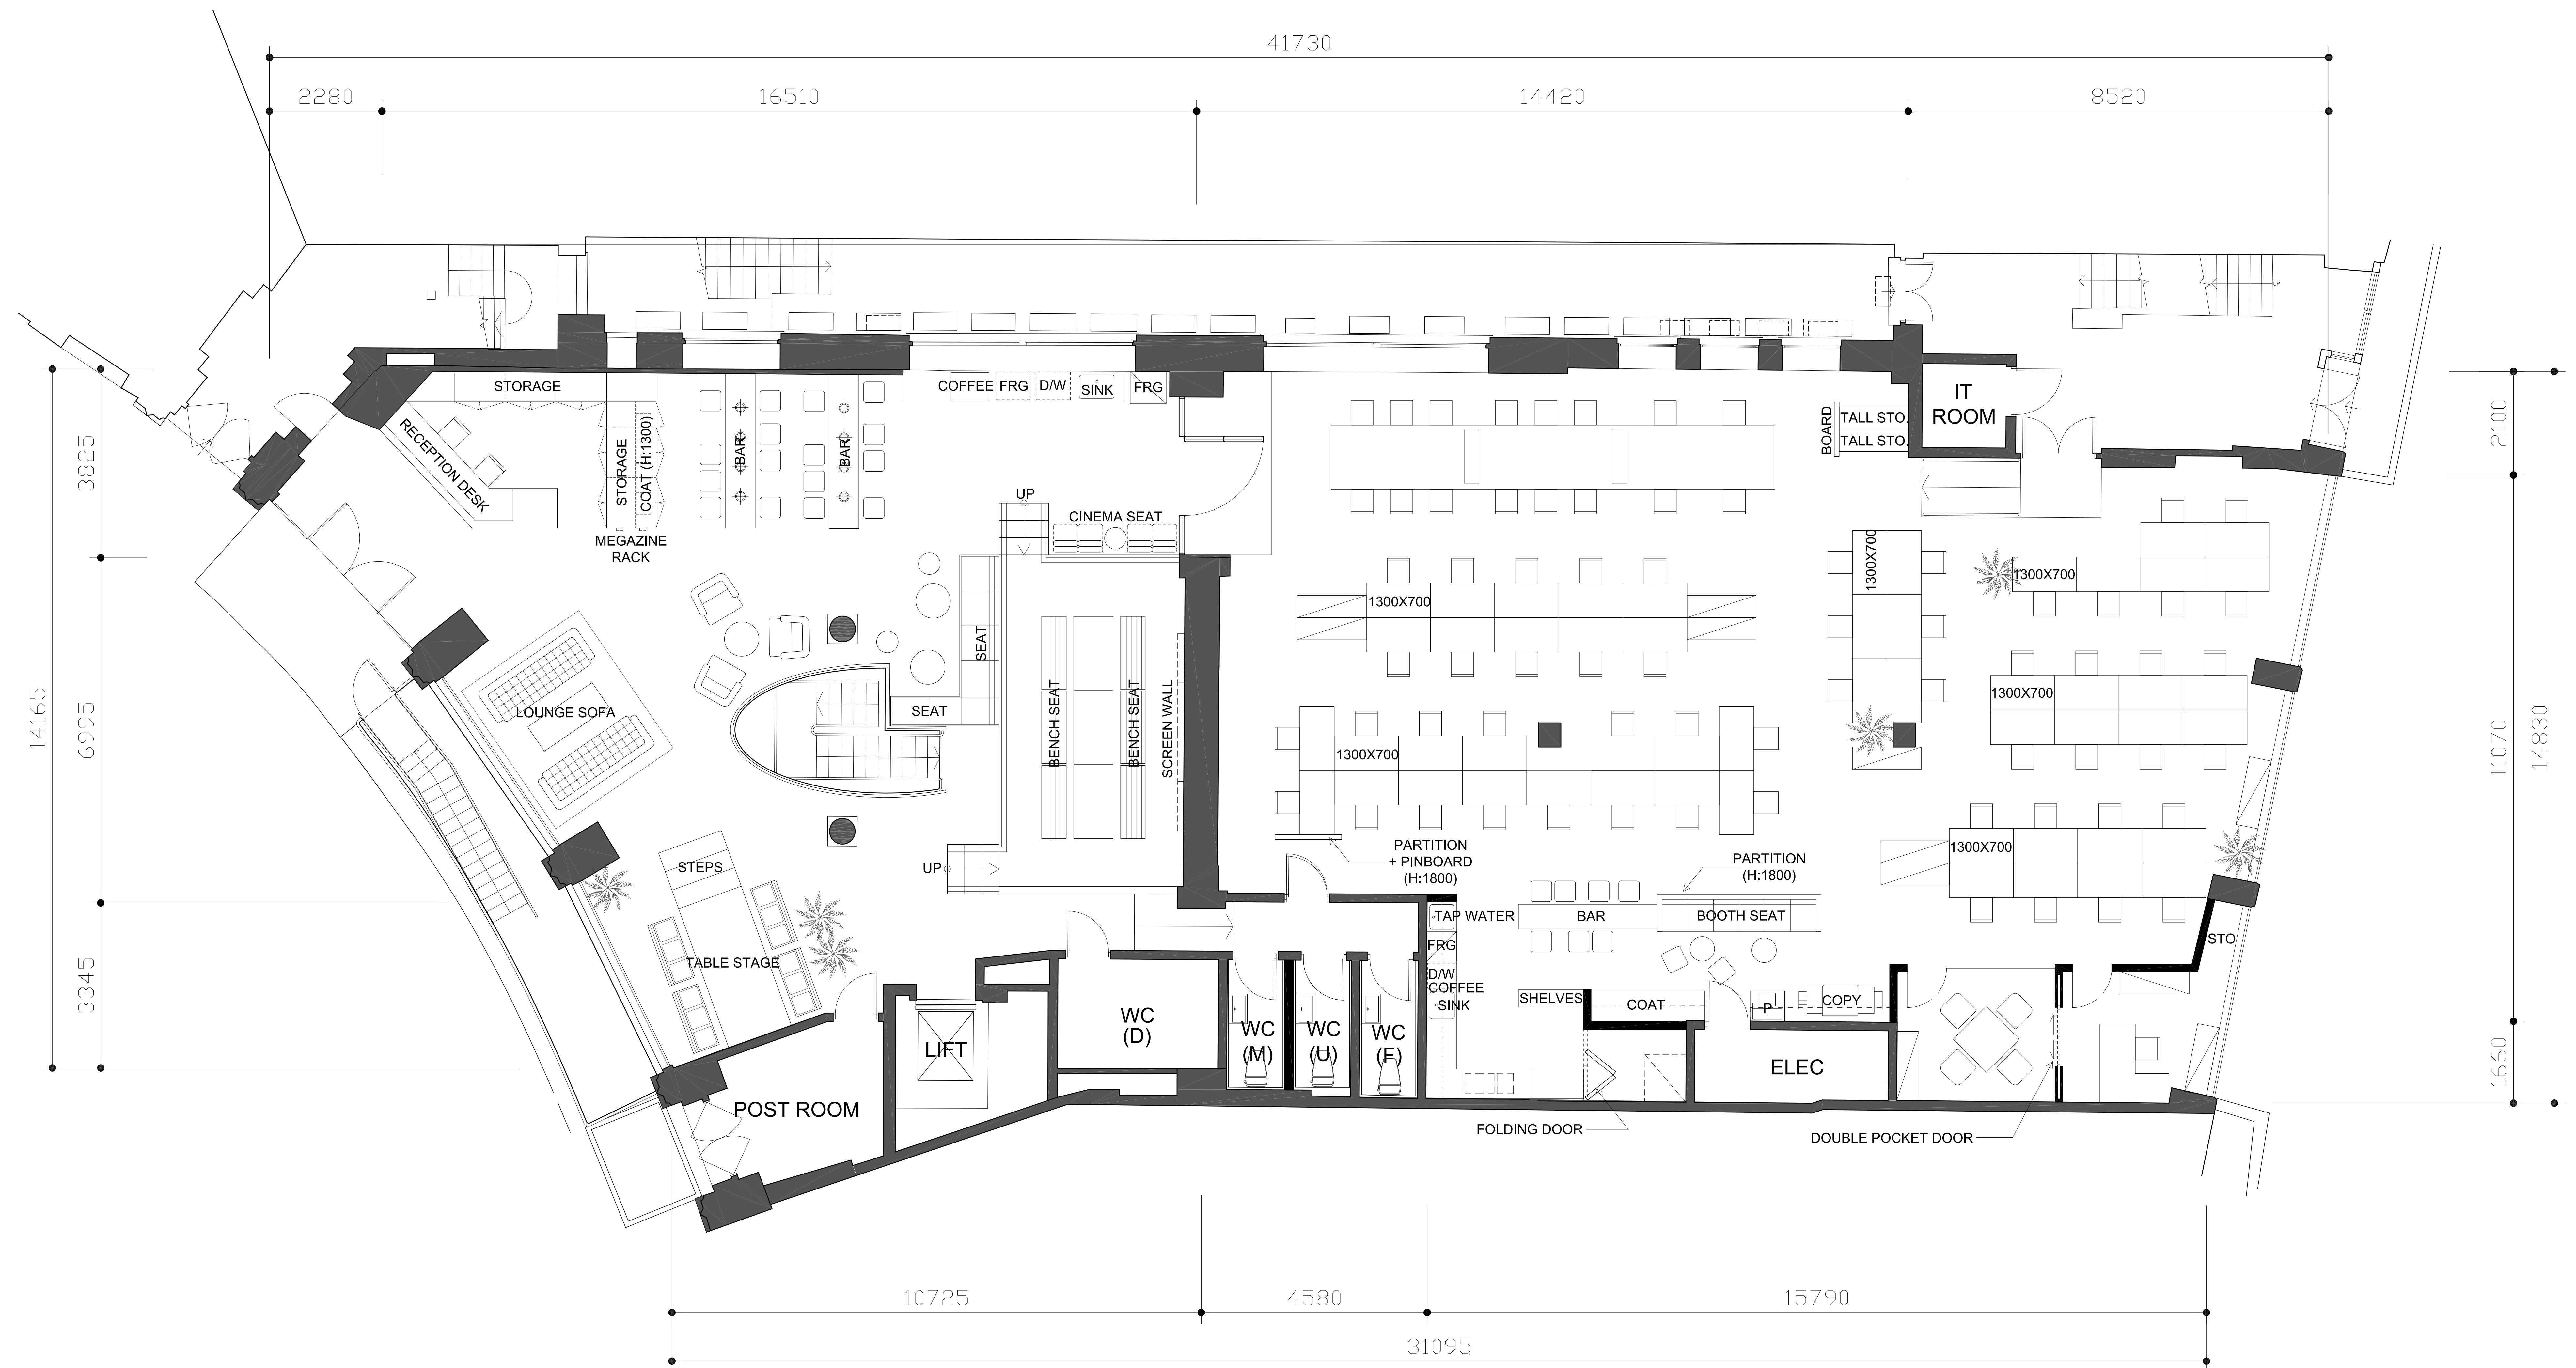

PROJECT TITLE		DRAWING TITLE		CLIENT APPROVAL		REVISION								DRAWN BY		DATE		triflecreative* + 44 7796 147 117 hello@triflecreative.com http://www.triflecreative.com					
OMD OFFICE REFURBISHMENT		PROPOSED FURNITURE PLAN				17 DEC 2012		06		25 FEB 2013		11		19 MAR 2013		21. MAR. 2013							
						02		07 JAN 2013		07		04 MAR 2013											
						03		14 JAN 2013		08		06 MAR 2013											
						04		25 JAN 2013		09		11 MAR 2013											
SITE		DRAWING REFERENCE				05		21 FEB 2013		10		18 MAR 2013						A0 : 1 / 50					
MINERVA HOUSE 1-4 NORTH CRESCENT LONDON,WC1E 7ER		OMDGRFL_OPT01_V12_MAR19														APPROVED BY		EMMA MORLEY		DRAWING NO. OMD-FL-03		SHEET NO.	




CASSETTE TYPE A/C UNIT




CEILING MOUNT TYPE A/C UNIT



SMALL A/C UNIT

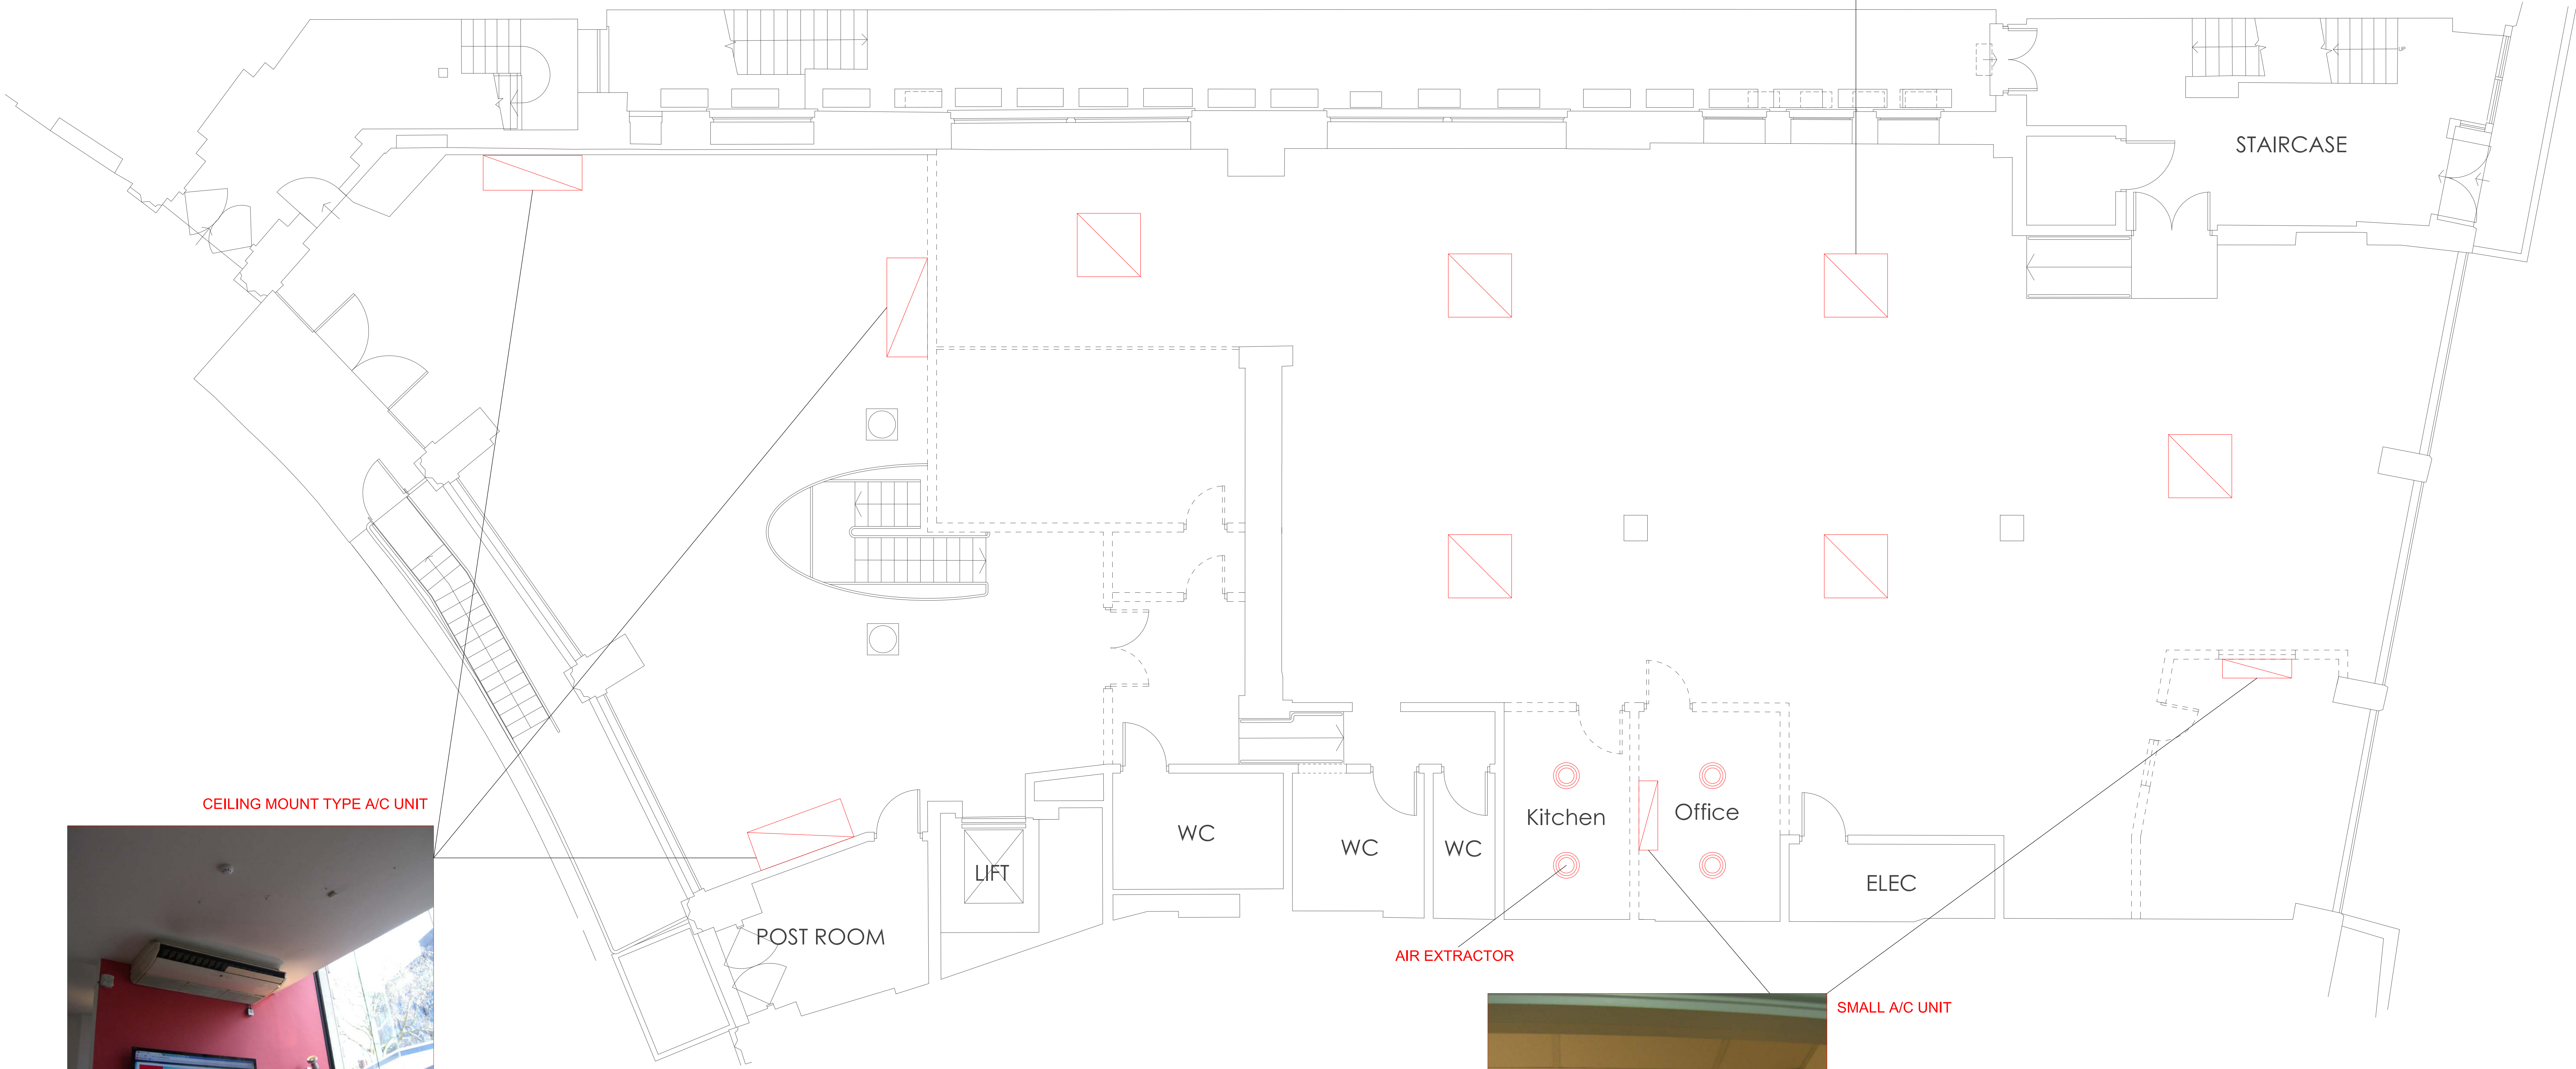

PROJECT TITLE		DRAWING TITLE		CLIENT APPROVAL		REVISION						DRAWN BY		DATE		triflecreative* + 44 7796 147 117 hello@triflecreative.com http://www.triflecreative.com			
OMD OFFICE REFURBISHMENT		EXISTING A/C PLAN												21. MAR. 2013					
														CHECKED BY				SCALE	
														APPROVED BY				A0 : 1 / 50	
SITE		DRAWING REFERENCE										EMMA MORLEY		DRAWING NO.		SHEET NO.			
MINERVA HOUSE 1-4 NORTH CRESCENT LONDON,WC1E 7ER														OMD-ME-01					

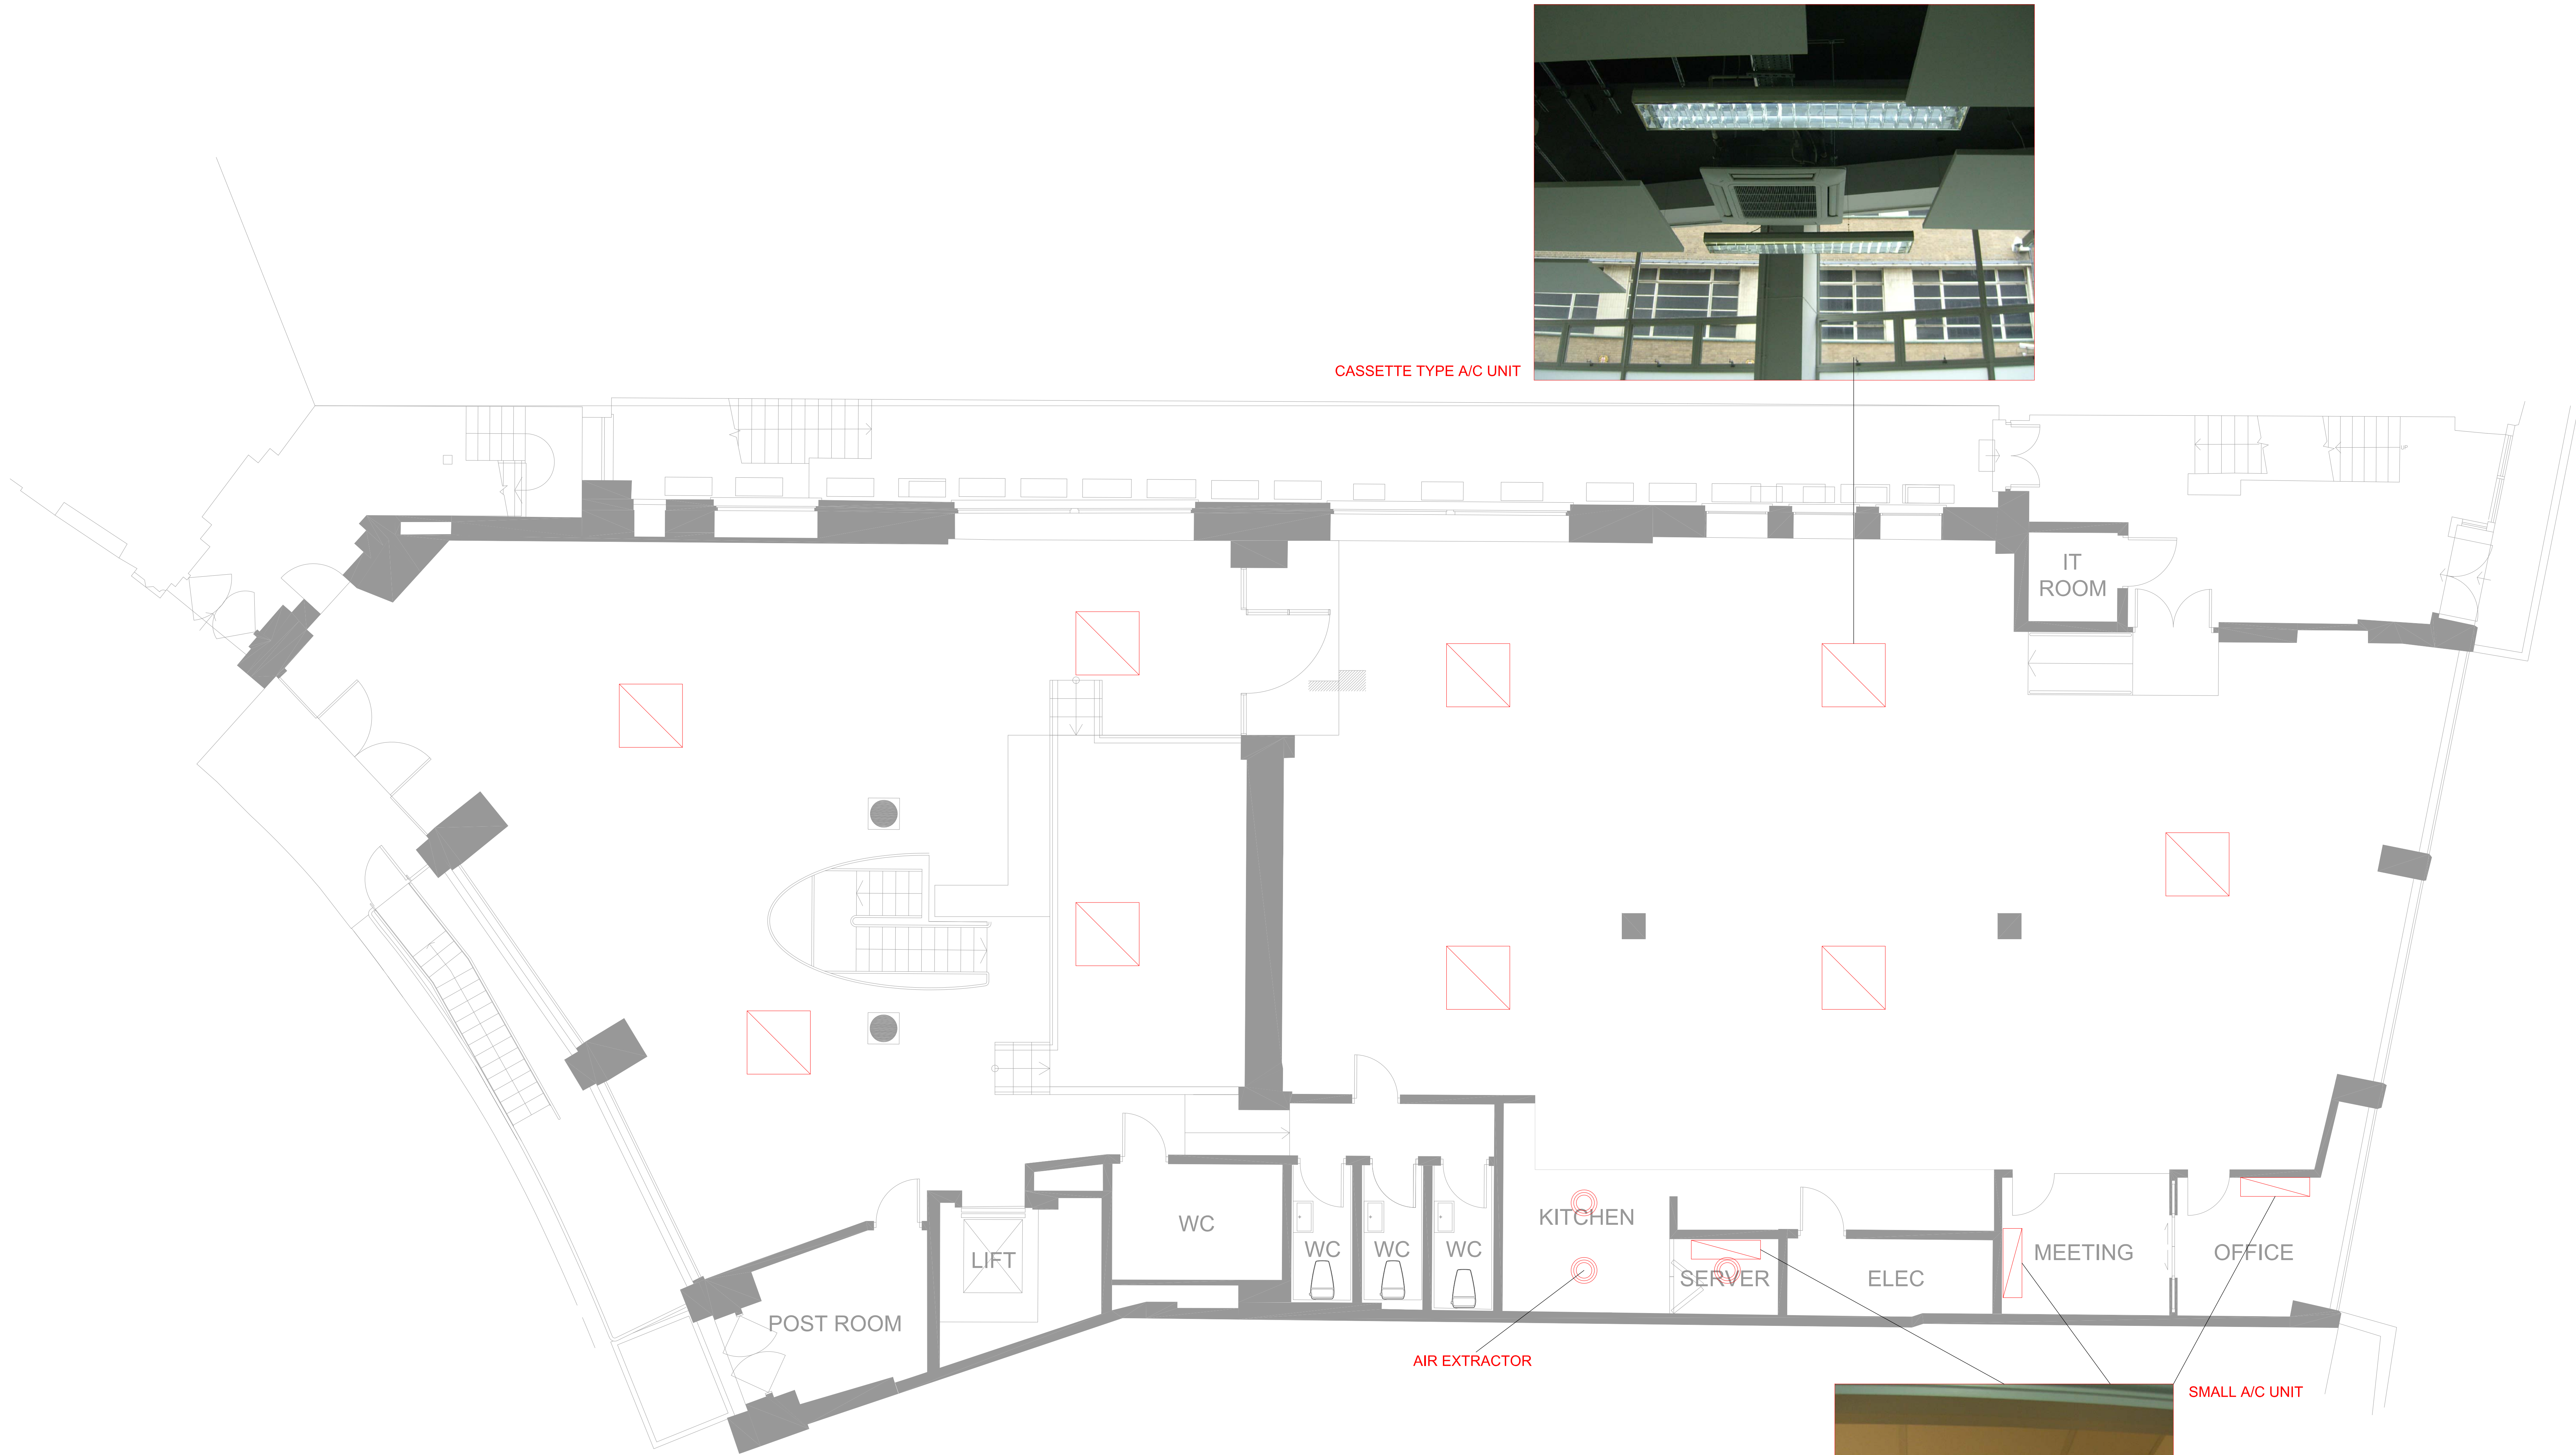


* NOTE

NEW AIR CONDITIONING UNITS @ RECEPTION AREA
3 X MITSUBISHI PLA-RP125BA CASSETTE TYPE SPLIT AIR CONDITIONING UNITS
GIVING A TOTAL OF 36.9 KW OF COOLING 42.0 KW OF HEATING
INCLUDING NEW ELECTRICAL SUPPLIES


4 X AIR CONDITIONING UNITS @ RECEPTION + KITCHEN

CONTRACTOR TO CHECK RECESS-CEILING MEASUREMENTS TO
SEE IF UNITS AC UNITS FIT

PROJECT TITLE		DRAWING TITLE		CLIENT APPROVAL		REVISION						DRAWN BY		DATE		triflecreative* + 44 7796 147 117 hello@triflecreative.com http://www.triflecreative.com			
OMD OFFICE REFURBISHMENT		PROPOSED A/C PLAN												21. MAR. 2013					
														CHECKED BY				SCALE	
														APPROVED BY				A0 : 1 / 50	
SITE		DRAWING REFERENCE										EMMA MORLEY		DRAWING NO.		SHEET NO.			
MINERVA HOUSE 1-4 NORTH CRESCENT LONDON,WC1E 7ER														OMD-ME-02					

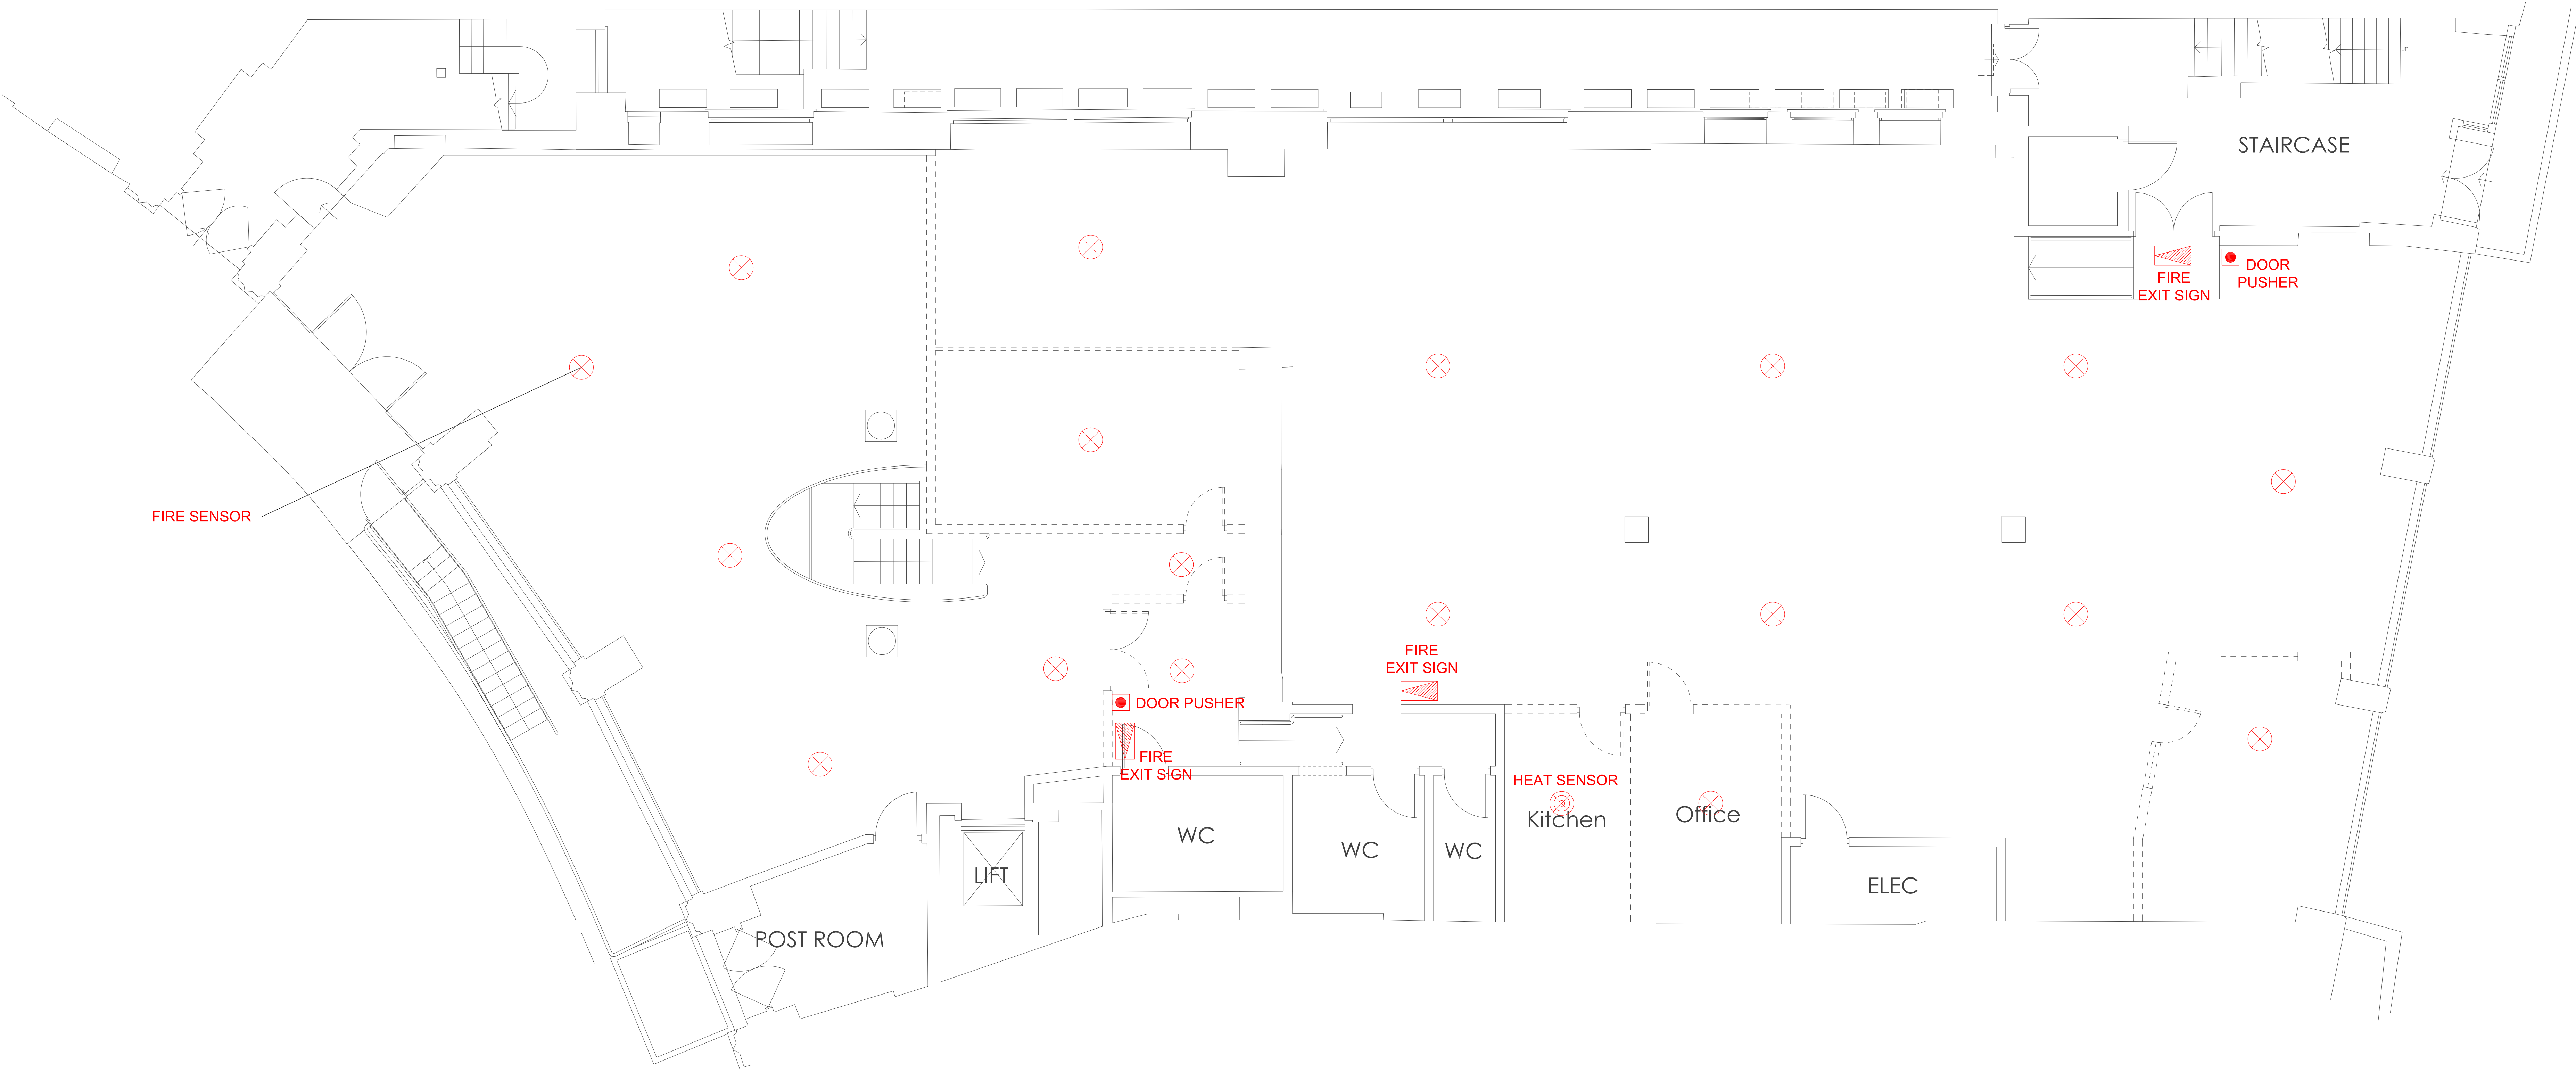


PROJECT TITLE		DRAWING TITLE		CLIENT APPROVAL		REVISION						DRAWN BY		DATE		triflecreative* + 44 7796 147 117 hello@triflecreative.com http://www.triflecreative.com
OMD		EXISTING										JEAN-YOUNG IM		21. MAR. 2013		
OFFICE REFURBISHMENT		FIRE ALARM PLAN												SCALE		
SITE		DRAWING REFERENCE										APPROVED BY		A0 : 1 / 50		
MINERVA HOUSE 1-4 NORTH CRESCENT LONDON,WC1E 7ER												EMMA MORLEY		DRAWING NO.		
														SHEET NO.		
														OMD-ME-03		

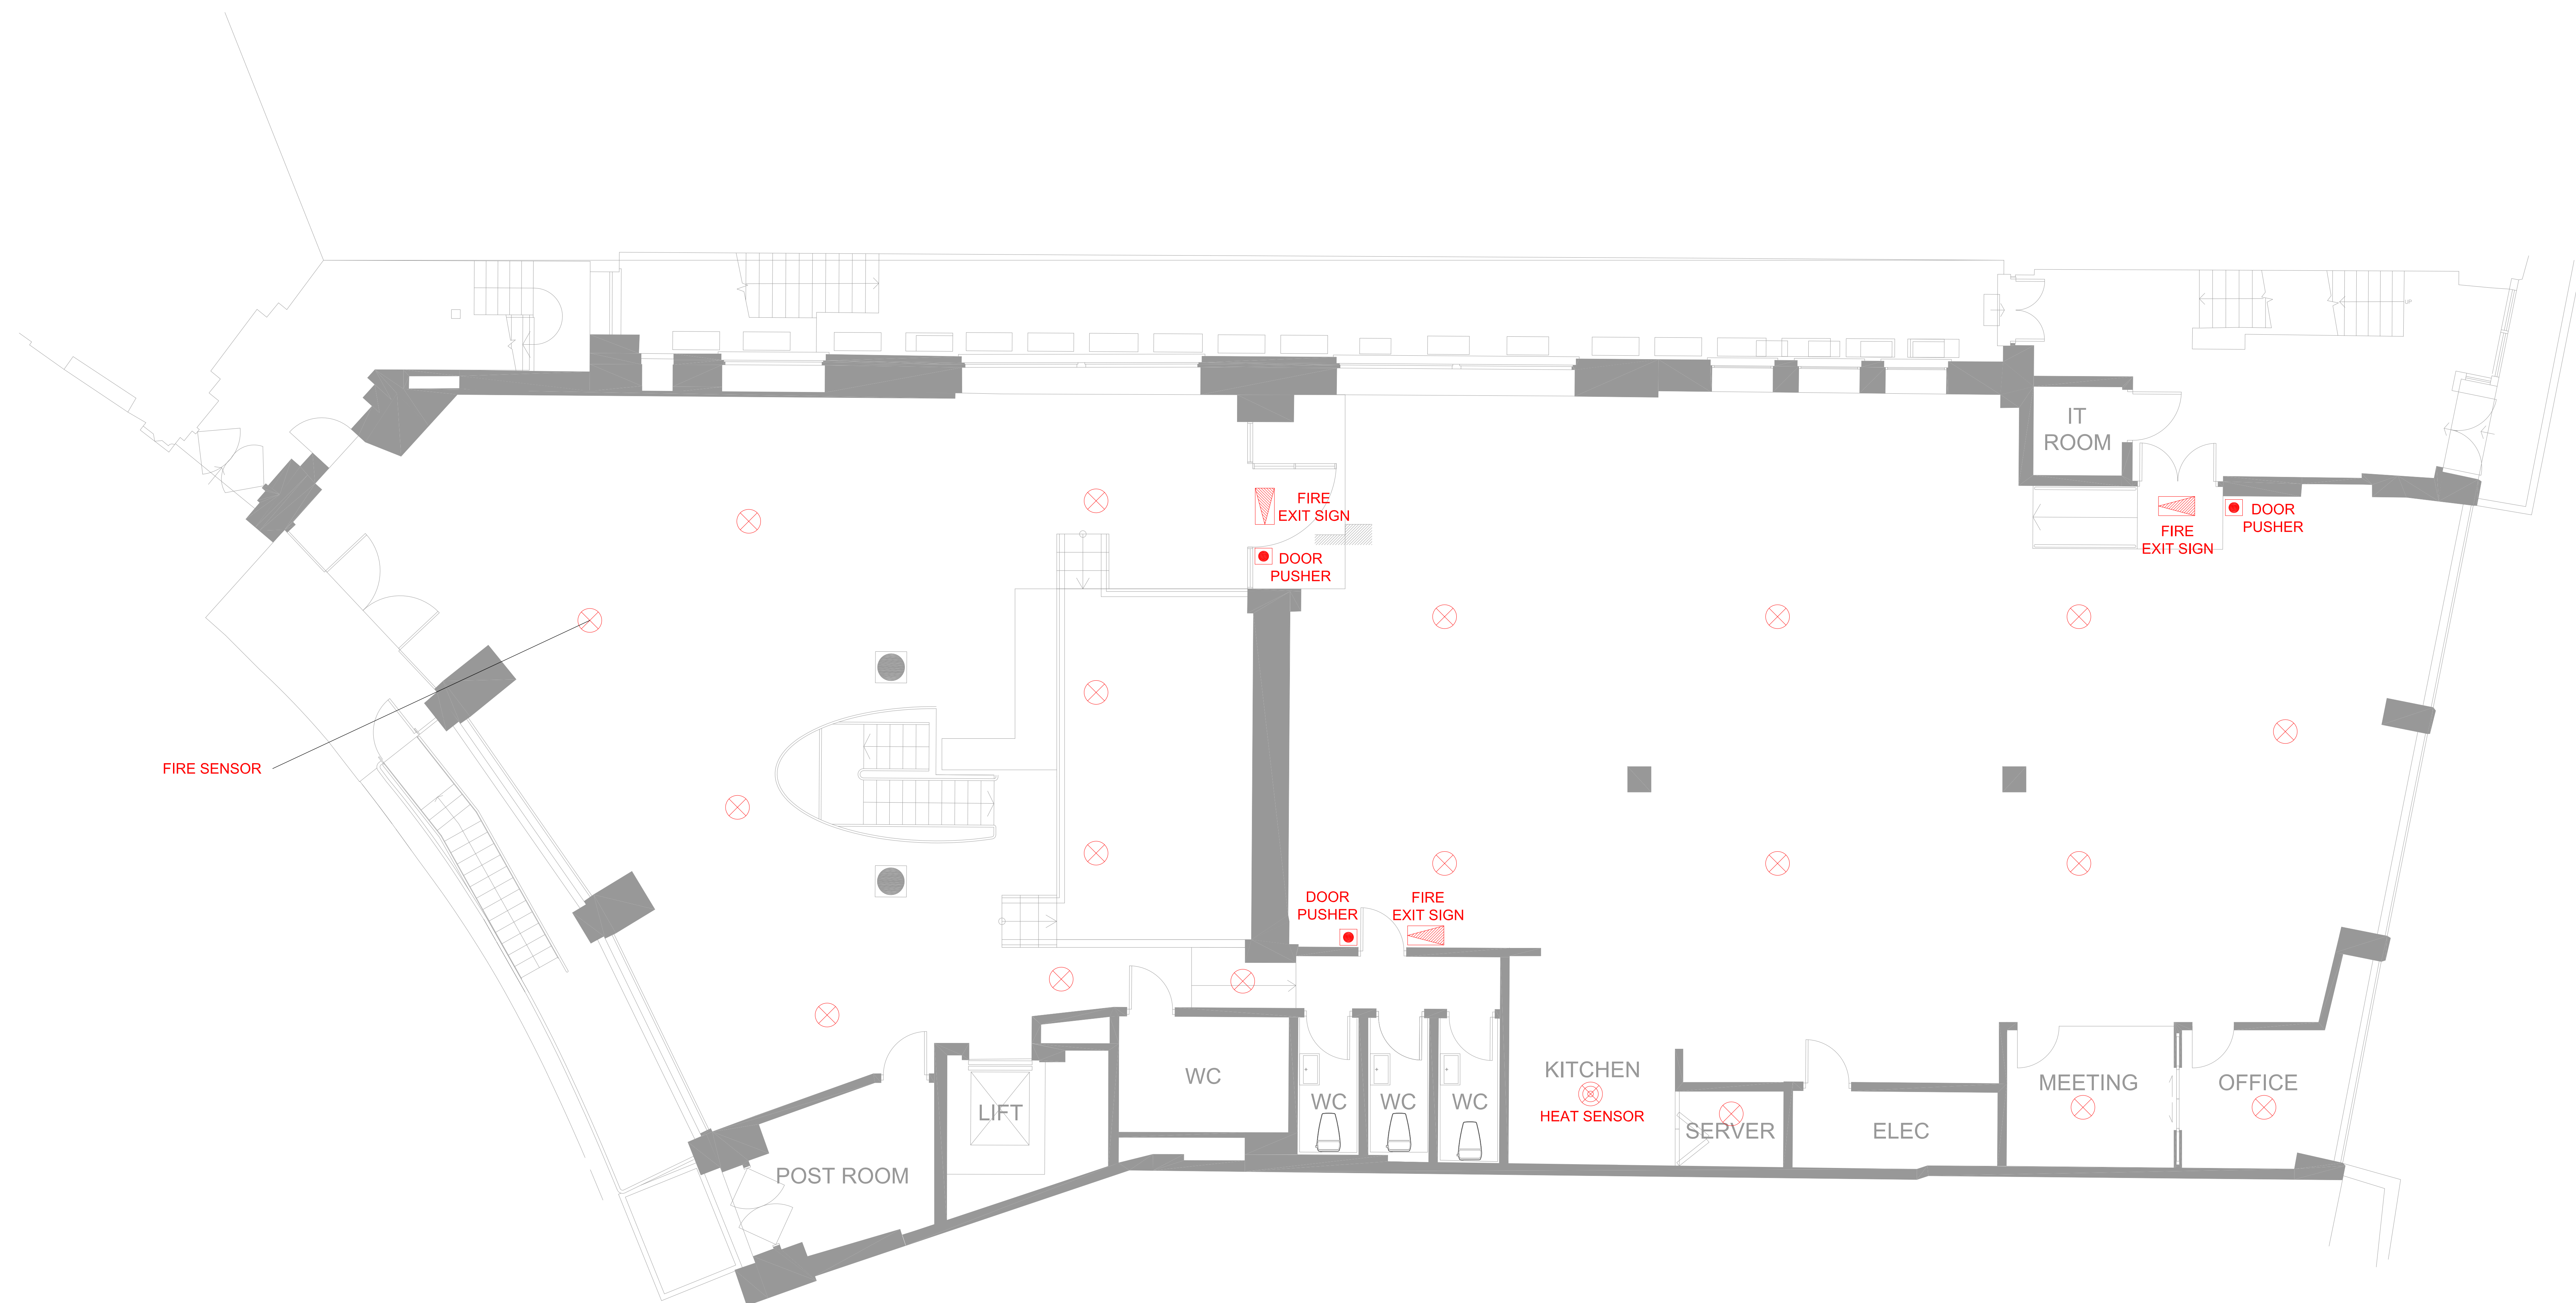

PROJECT TITLE		DRAWING TITLE	CLIENT APPROVAL	REVISION								DRAWN BY		DATE		triflecreative* + 44 7796 147 117 hello@triflecreative.com http://www.triflecreative.com		
OMD												JEAN-YOUNG IM		21. MAR. 2013				
OFFICE REFURBISHMENT												CHECKED BY		SCALE				
SITE												DRAWING REFERENCE		A0 : 1 / 50				
MINERVA HOUSE 1-4 NORTH CRESCENT LONDON,WC1E 7ER											APPROVED BY		EMMA MORLEY		DRAWING NO.		SHEET NO.	
															OMD-ME-04			




PROJECT TITLE		DRAWING TITLE		CLIENT APPROVAL		REVISION						DRAWN BY		DATE		triflecreative* + 44 7796 147 117 hello@triflecreative.com http://www.triflecreative.com
OMD OFFICE REFURBISHMENT		EXISTING CCTV / DOOR ACCESS PLAN										JEAN-YOUNG IM		21. MAR. 2013		
												CHECKED BY		SCALE		
												APPROVED BY		A0 : 1 / 50		
												EMMA MORLEY				
SITE		DRAWING REFERENCE										DRAWING NO.		SHEET NO.		
MINERVA HOUSE 1-4 NORTH CRESCENT LONDON,WC1E 7ER												OMD-ME-05				

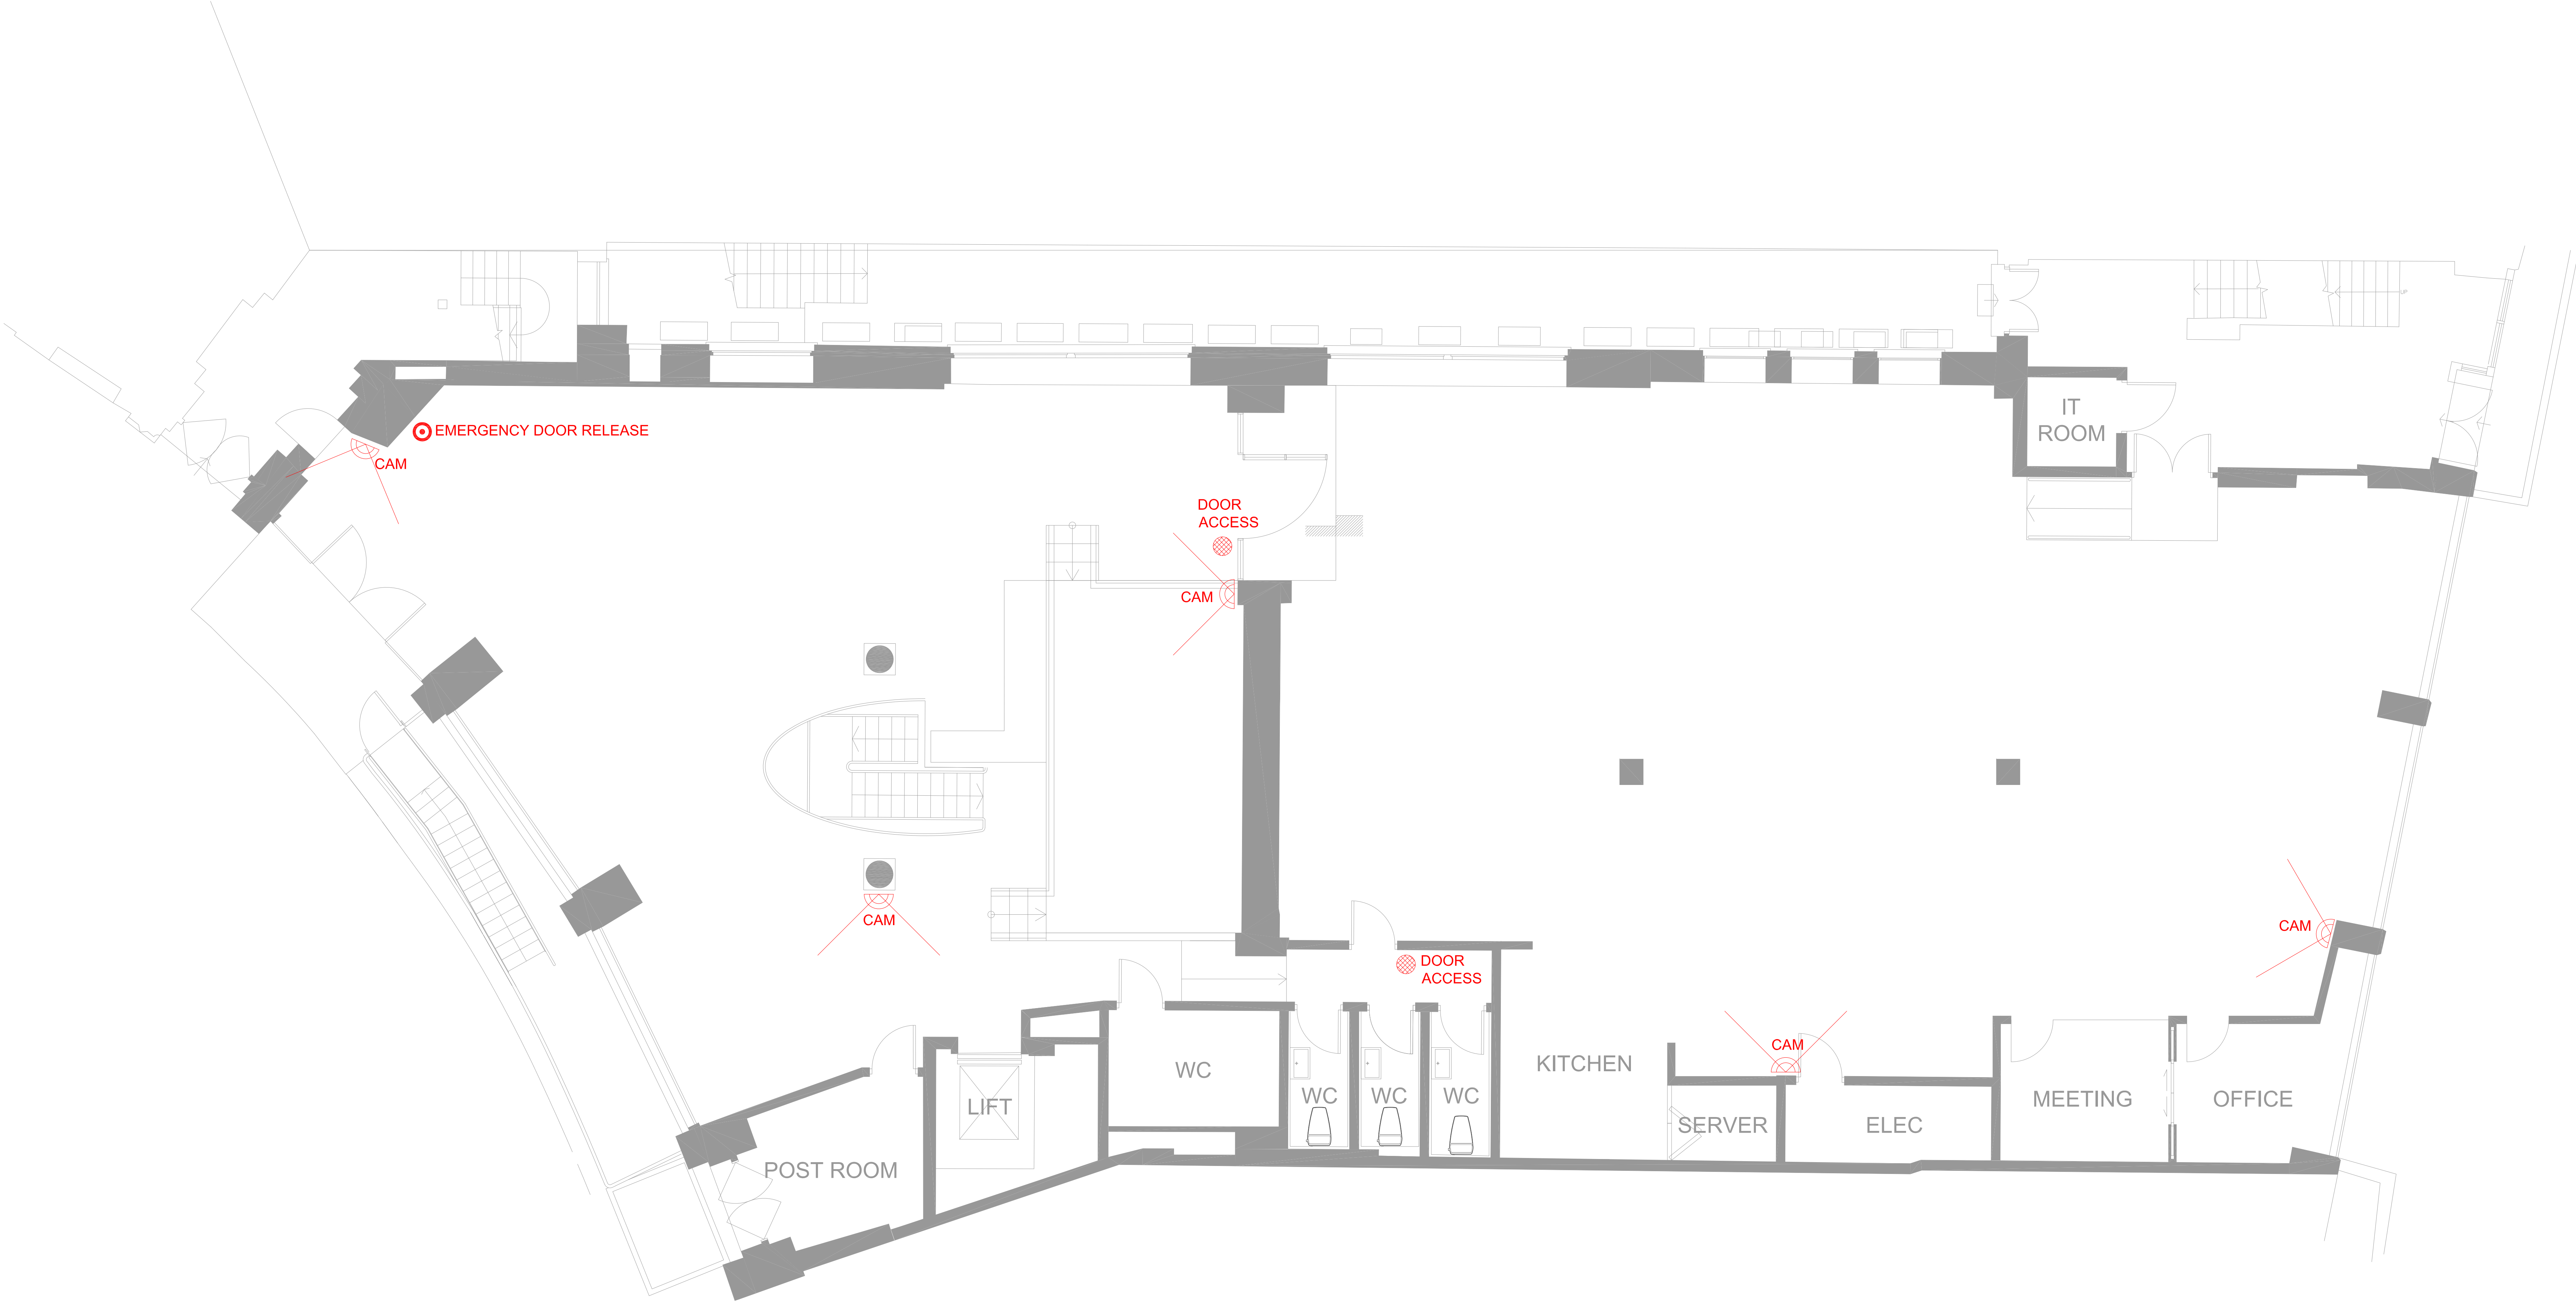


*NOTE

TRIGION SECURITY TO CONFIRM FINAL POSITIONING OF CCTV CAMERAS



PROJECT TITLE		DRAWING TITLE		CLIENT APPROVAL		REVISION						DRAWN BY		JEAN-YOUNG IM		DATE		21. MAR. 2013		triflecreative* + 44 7796 147 117 hello@triflecreative.com http://www.triflecreative.com	
OMD OFFICE REFURBISHMENT		PROPOSED CCTV / DOOR ACCESS PLAN												CHECKED BY		SCALE		A0 : 1 / 50			
														APPROVED BY		EMMA MORLEY		DRAWING NO.			
SITE		DRAWING REFERENCE														OMD-ME-06					
MINERVA HOUSE 1-4 NORTH CRESCENT LONDON,WC1E 7ER																					

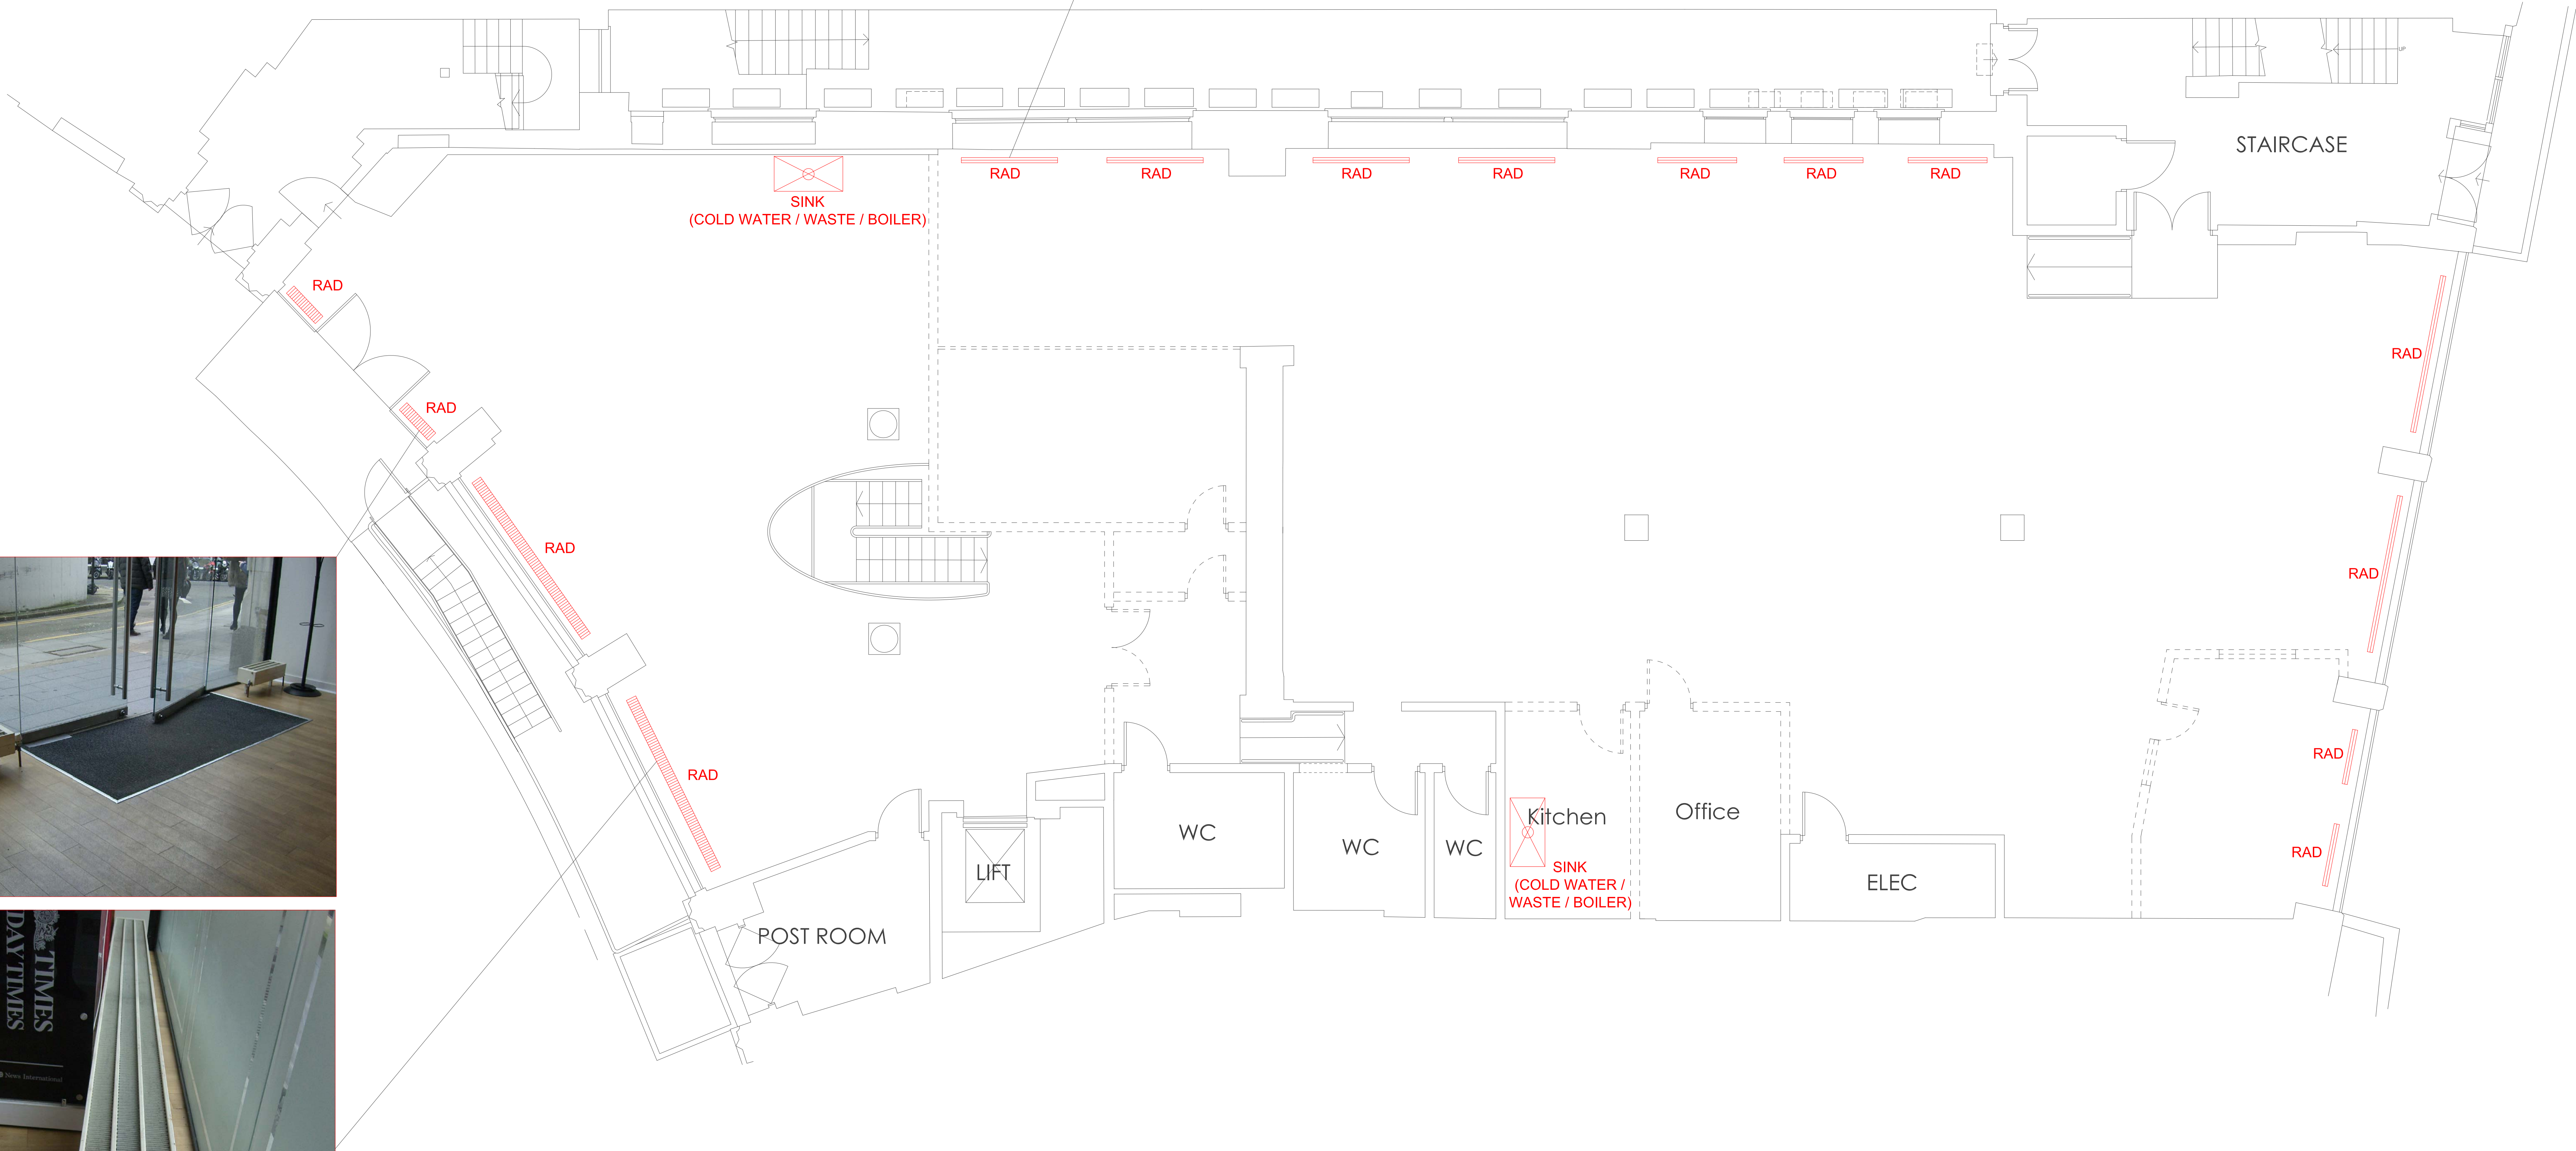

PROJECT TITLE		DRAWING TITLE		CLIENT APPROVAL		REVISION						DRAWN BY		DATE		triflecreative* + 44 7796 147 117 hello@triflecreative.com http://www.triflecreative.com
OMD		EXISTING HEATING /										JEAN-YOUNG IM		21. MAR. 2013		
OFFICE REFURBISHMENT		PLUMBING/ WASTE												A0 : 1 / 50		
SITE		DRAWING REFERENCE										EMMA MORLEY		SHEET NO.		
MINERVA HOUSE 1-4 NORTH CRESCENT LONDON,WC1E 7ER														OMD-ME-07		

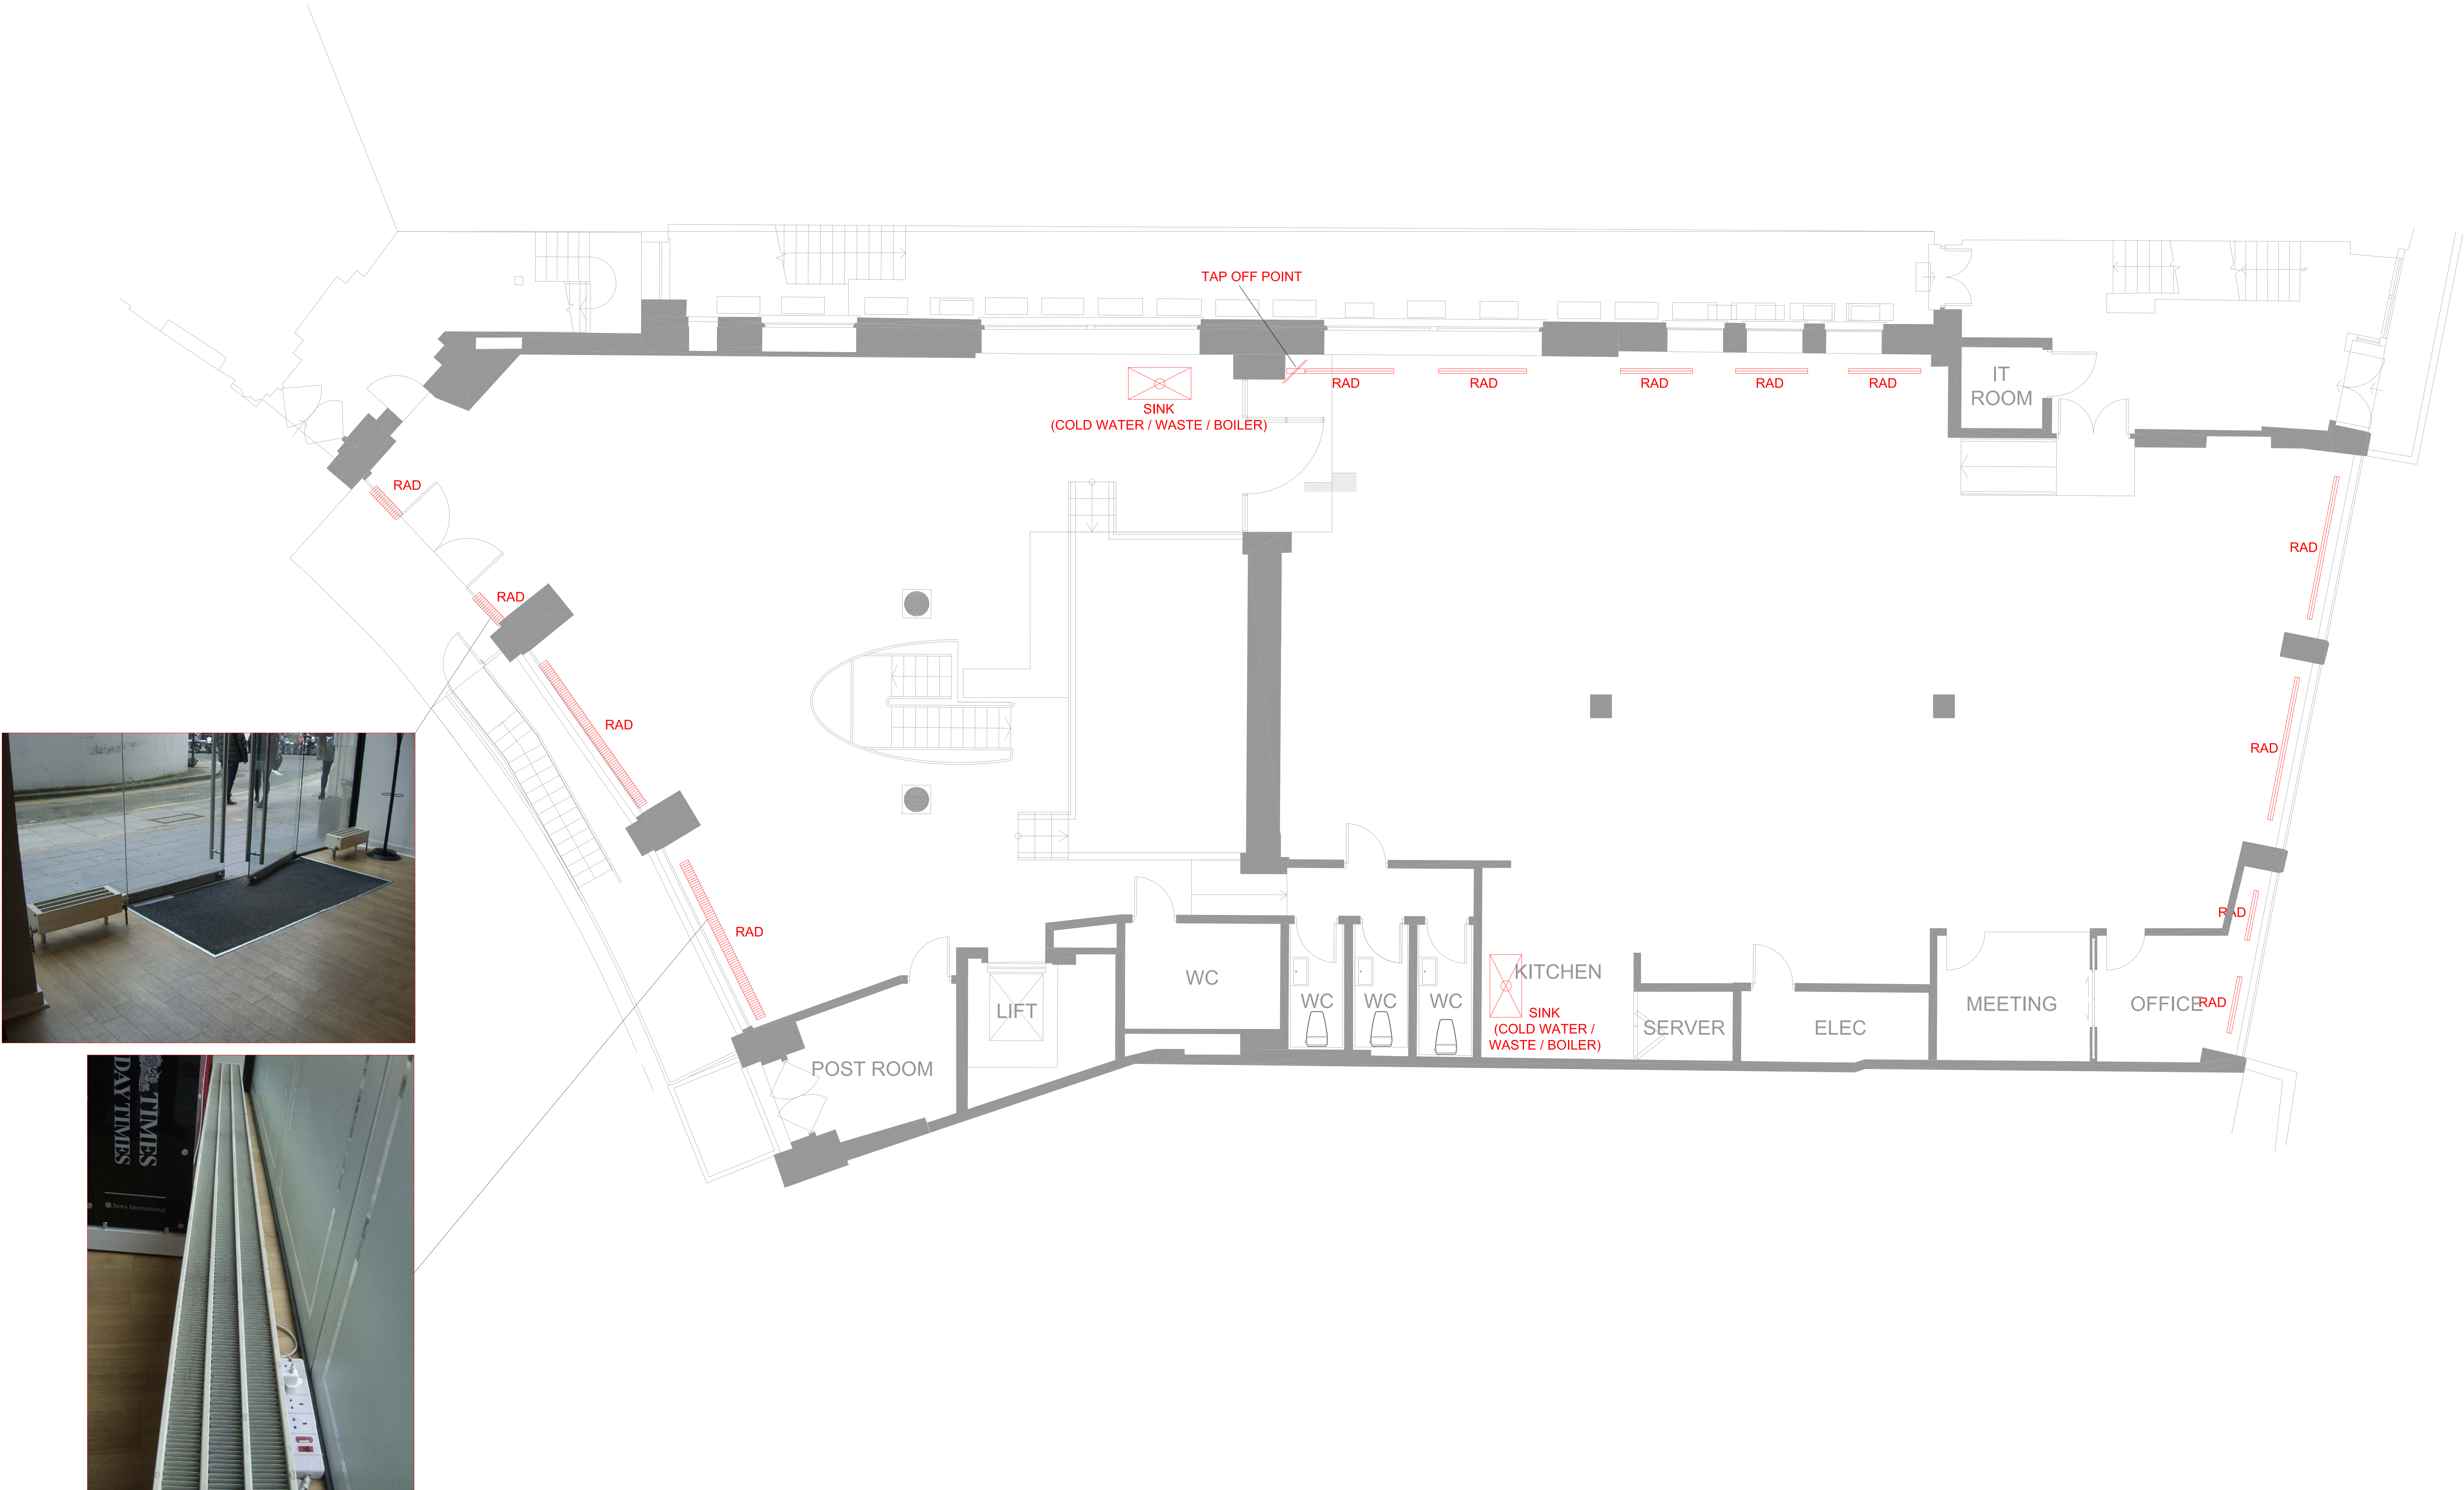


PROJECT TITLE		DRAWING TITLE		CLIENT APPROVAL		REVISION						DRAWN BY		DATE		triflecreative* + 44 7796 147 117 hello@triflecreative.com http://www.triflecreative.com	
OMD		PROPOSED HEATING /										JEAN-YOUNG IM		21. MAR. 2013			
OFFICE REFURBISHMENT		PLUMBING/ WASTE												A0 : 1 / 50			
SITE		DRAWING REFERENCE										EMMA MORLEY		SHEET NO.			
MINERVA HOUSE 1-4 NORTH CRESCENT LONDON,WC1E 7ER														OMD-ME-08			

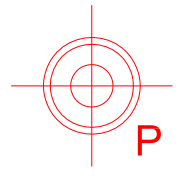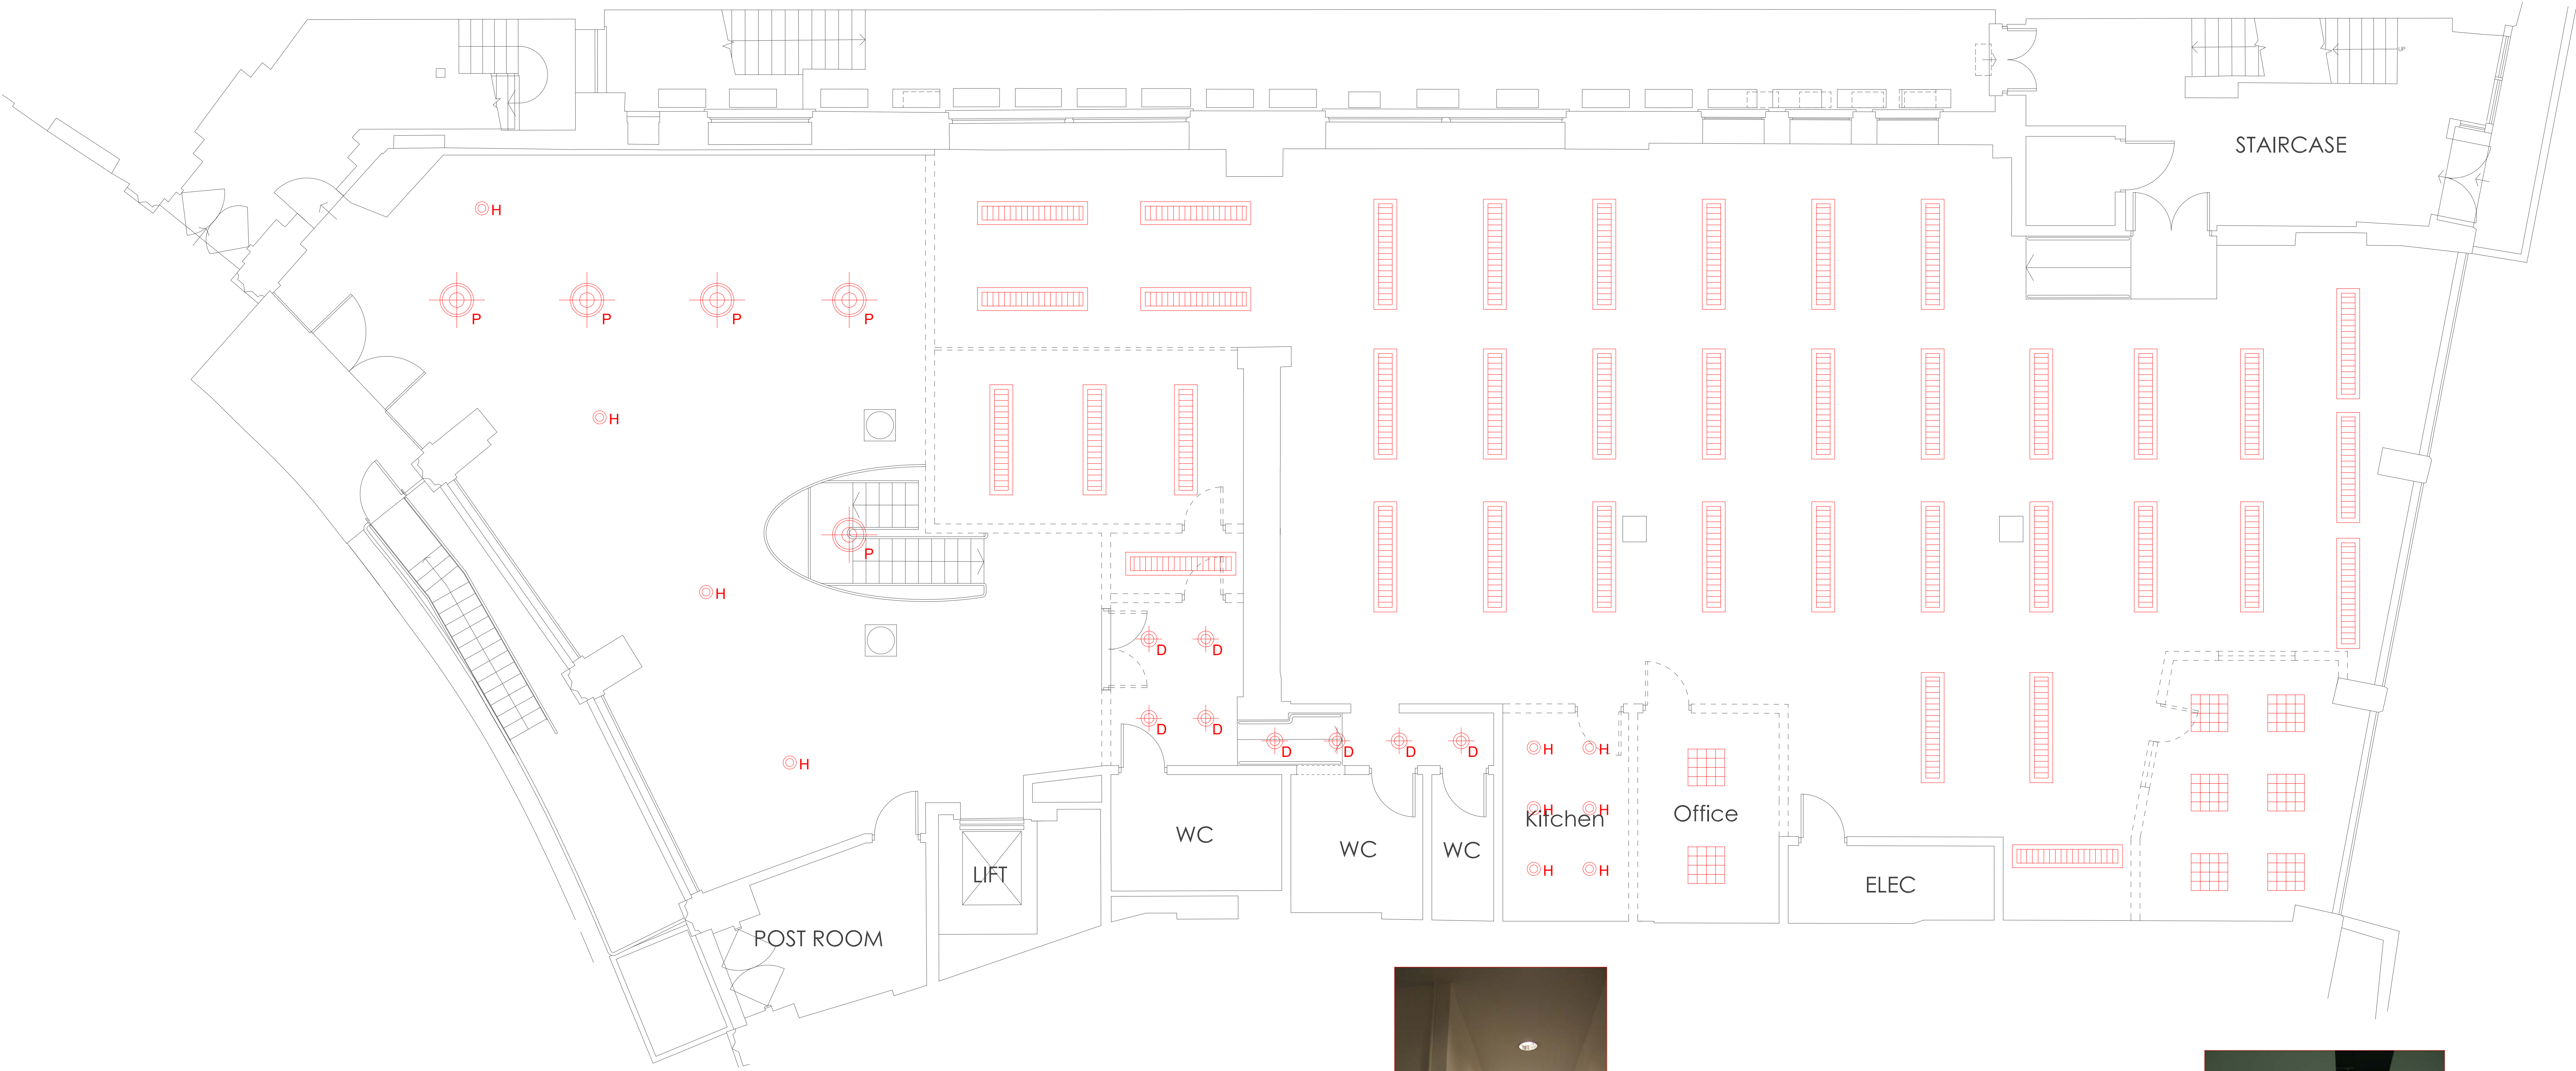

PENDANT LIGHT



 
DOWN LIGHT



FLUORESCENT LIGHT



 DOWN LIGHT
(HALOGEN LAMP)



FLUORESCENT LIGHT
(SQUARE/ RECESSED)



PROJECT TITLE

OMD
OFFICE REFURBISHMENT

SITE
MINERVA HOUSE 1-4 NORTH CRESCENT LONDON,WC1E 7ER

DRAWING TITLE

EXISTING
CEILING LIGHTING PLAN

DRAWING REFERENCE

CLIENT APPROVAL

REVISION

DRAWN BY

JEAN-YOUNG IM

CHECKED BY

APPROVED BY

EMMA MORLEY

DATE

21. MAR. 2013

SCALE

A0 : 1 / 50


DRAWING NO.

 
OMD-ME-09

SHEET NO.

triflecreative*

+ 44 7796 147 117
hello@triflecreative.com
http://www.triflecreative.com

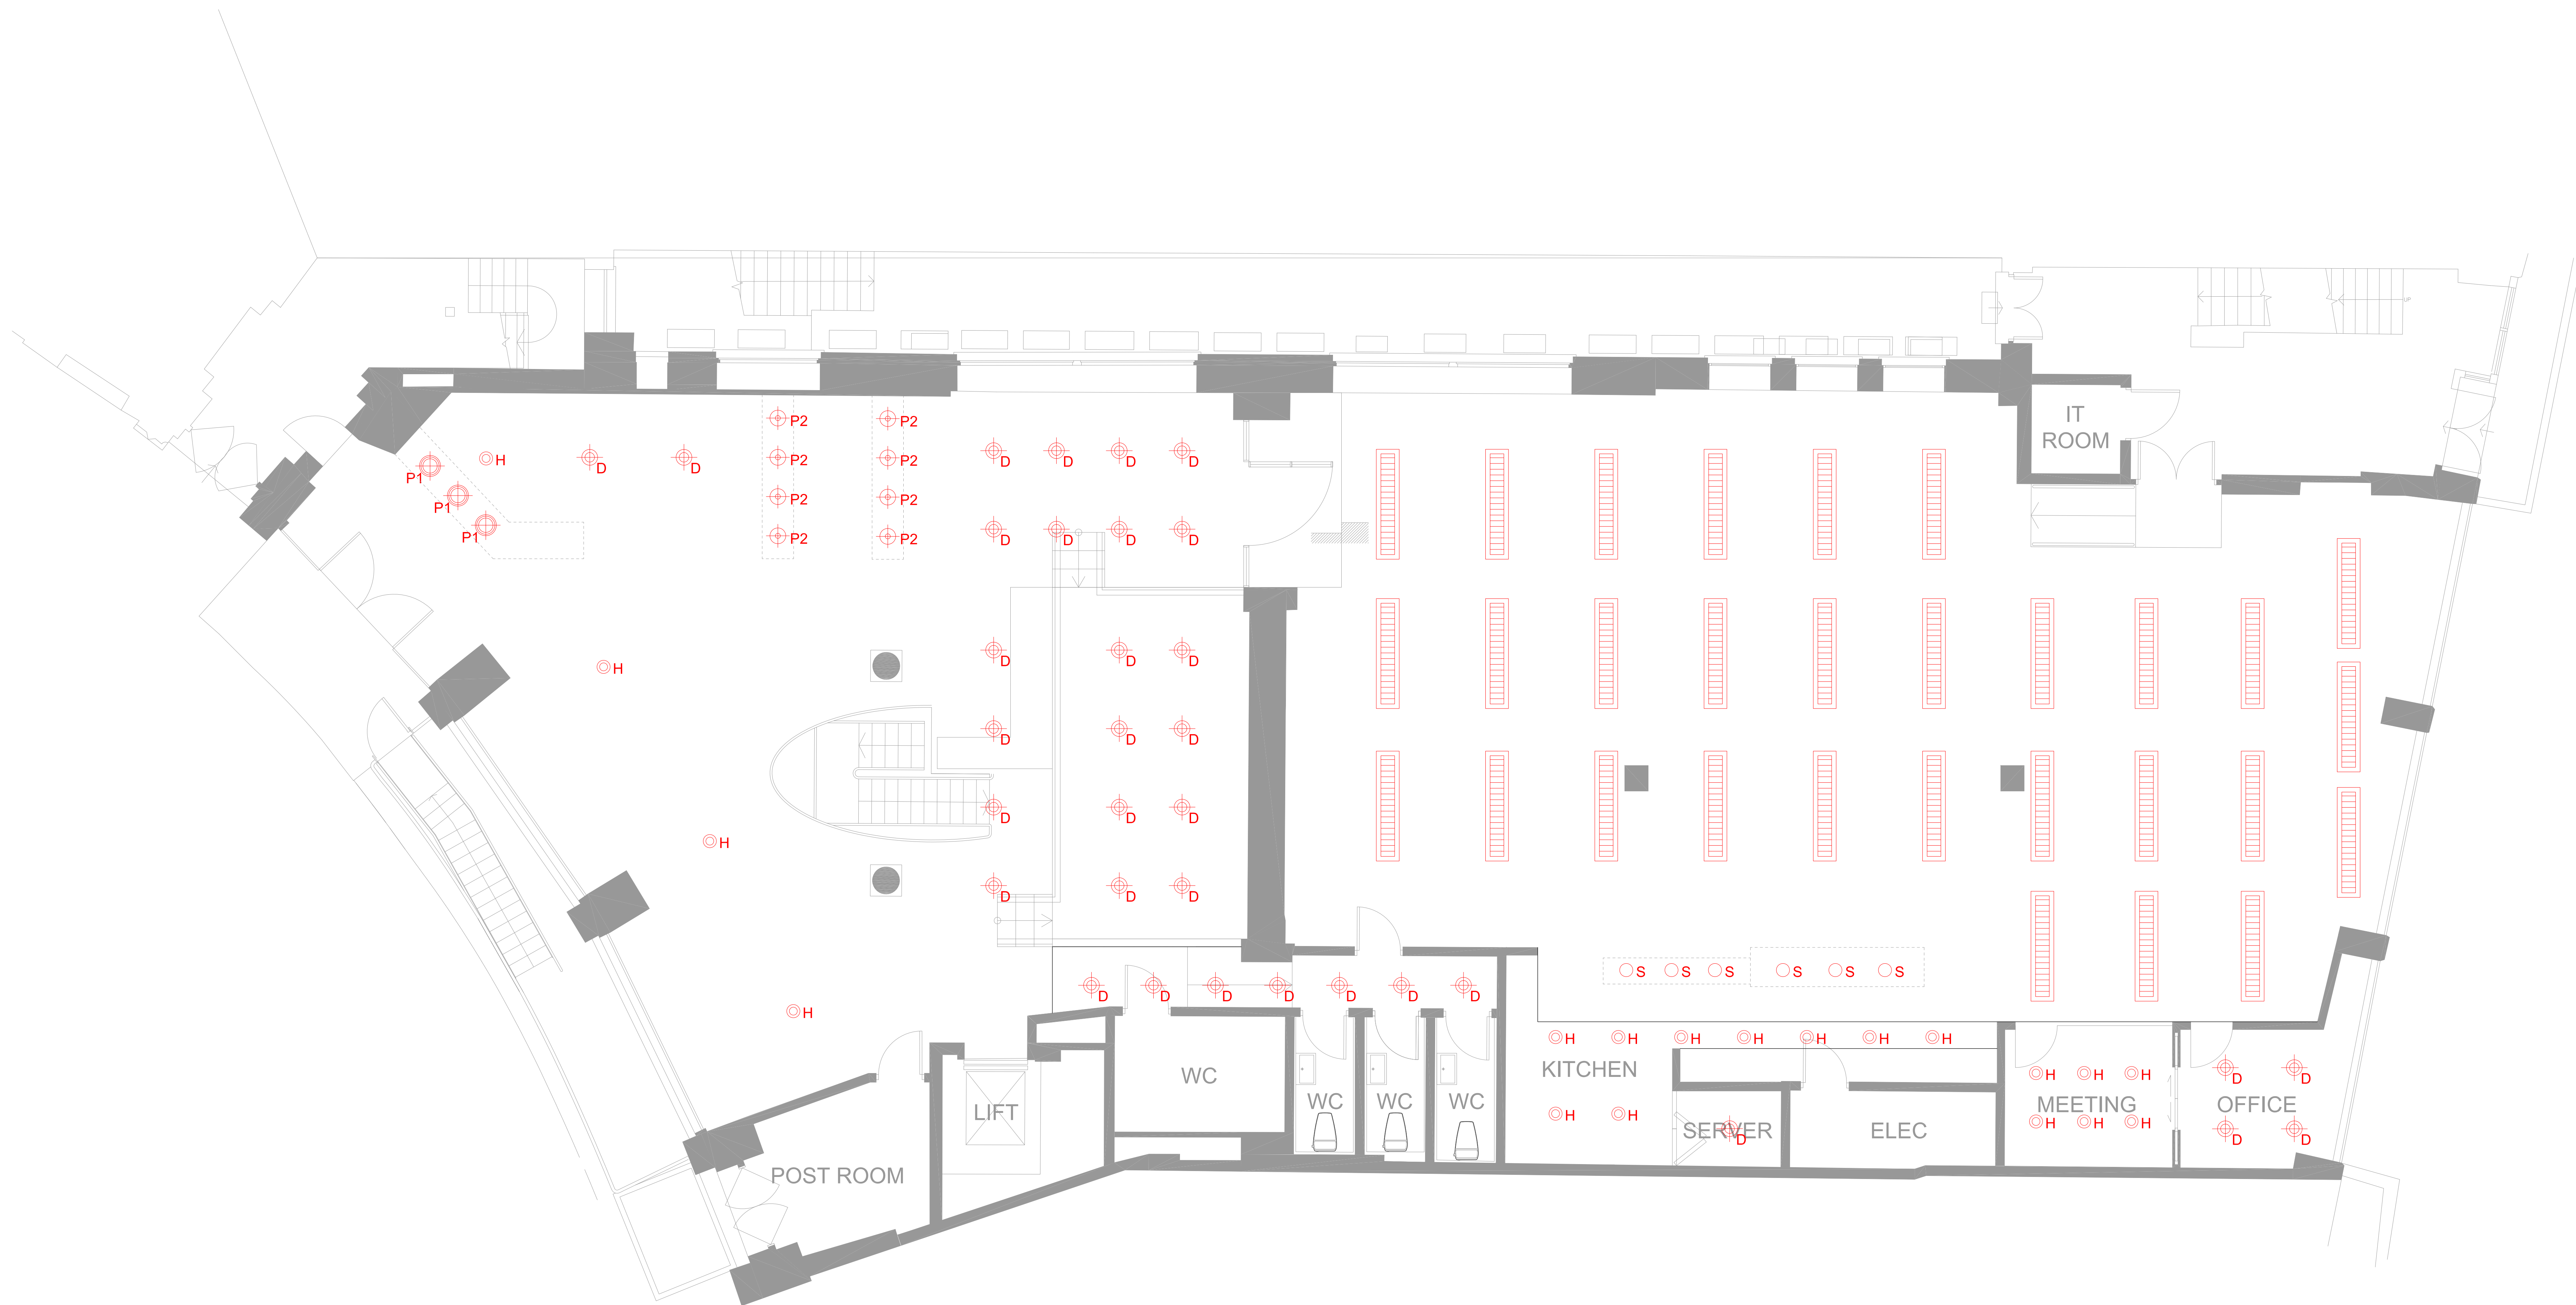

- 

 
PENDANT LIGHT 1

PENDANT LIGHT 2

PENDANT LIGHT 3


DOWN LIGHT

DOWN LIGHT (HALOGEN LAMP)

SPOT LIGHT
- 

FLUORESCENT LIGHT (SUSPENDING)
- 


PROJECT TITLE		DRAWING TITLE		CLIENT APPROVAL		REVISION						DRAWN BY		DATE		triflecreative* + 44 7796 147 117 hello@triflecreative.com http://www.triflecreative.com
SITE		DRAWING REFERENCE										CHECKED BY		SCALE		
MINERVA HOUSE 1-4 NORTH CRESCENT LONDON,WC1E 7ER												APPROVED BY		A0 : 1 / 50		
OMD OFFICE REFURBISHMENT		PROPOSED CEILING LIGHTING PLAN										JEAN-YOUNG IM		17. APR. 2013		
														OMD-ME-10		

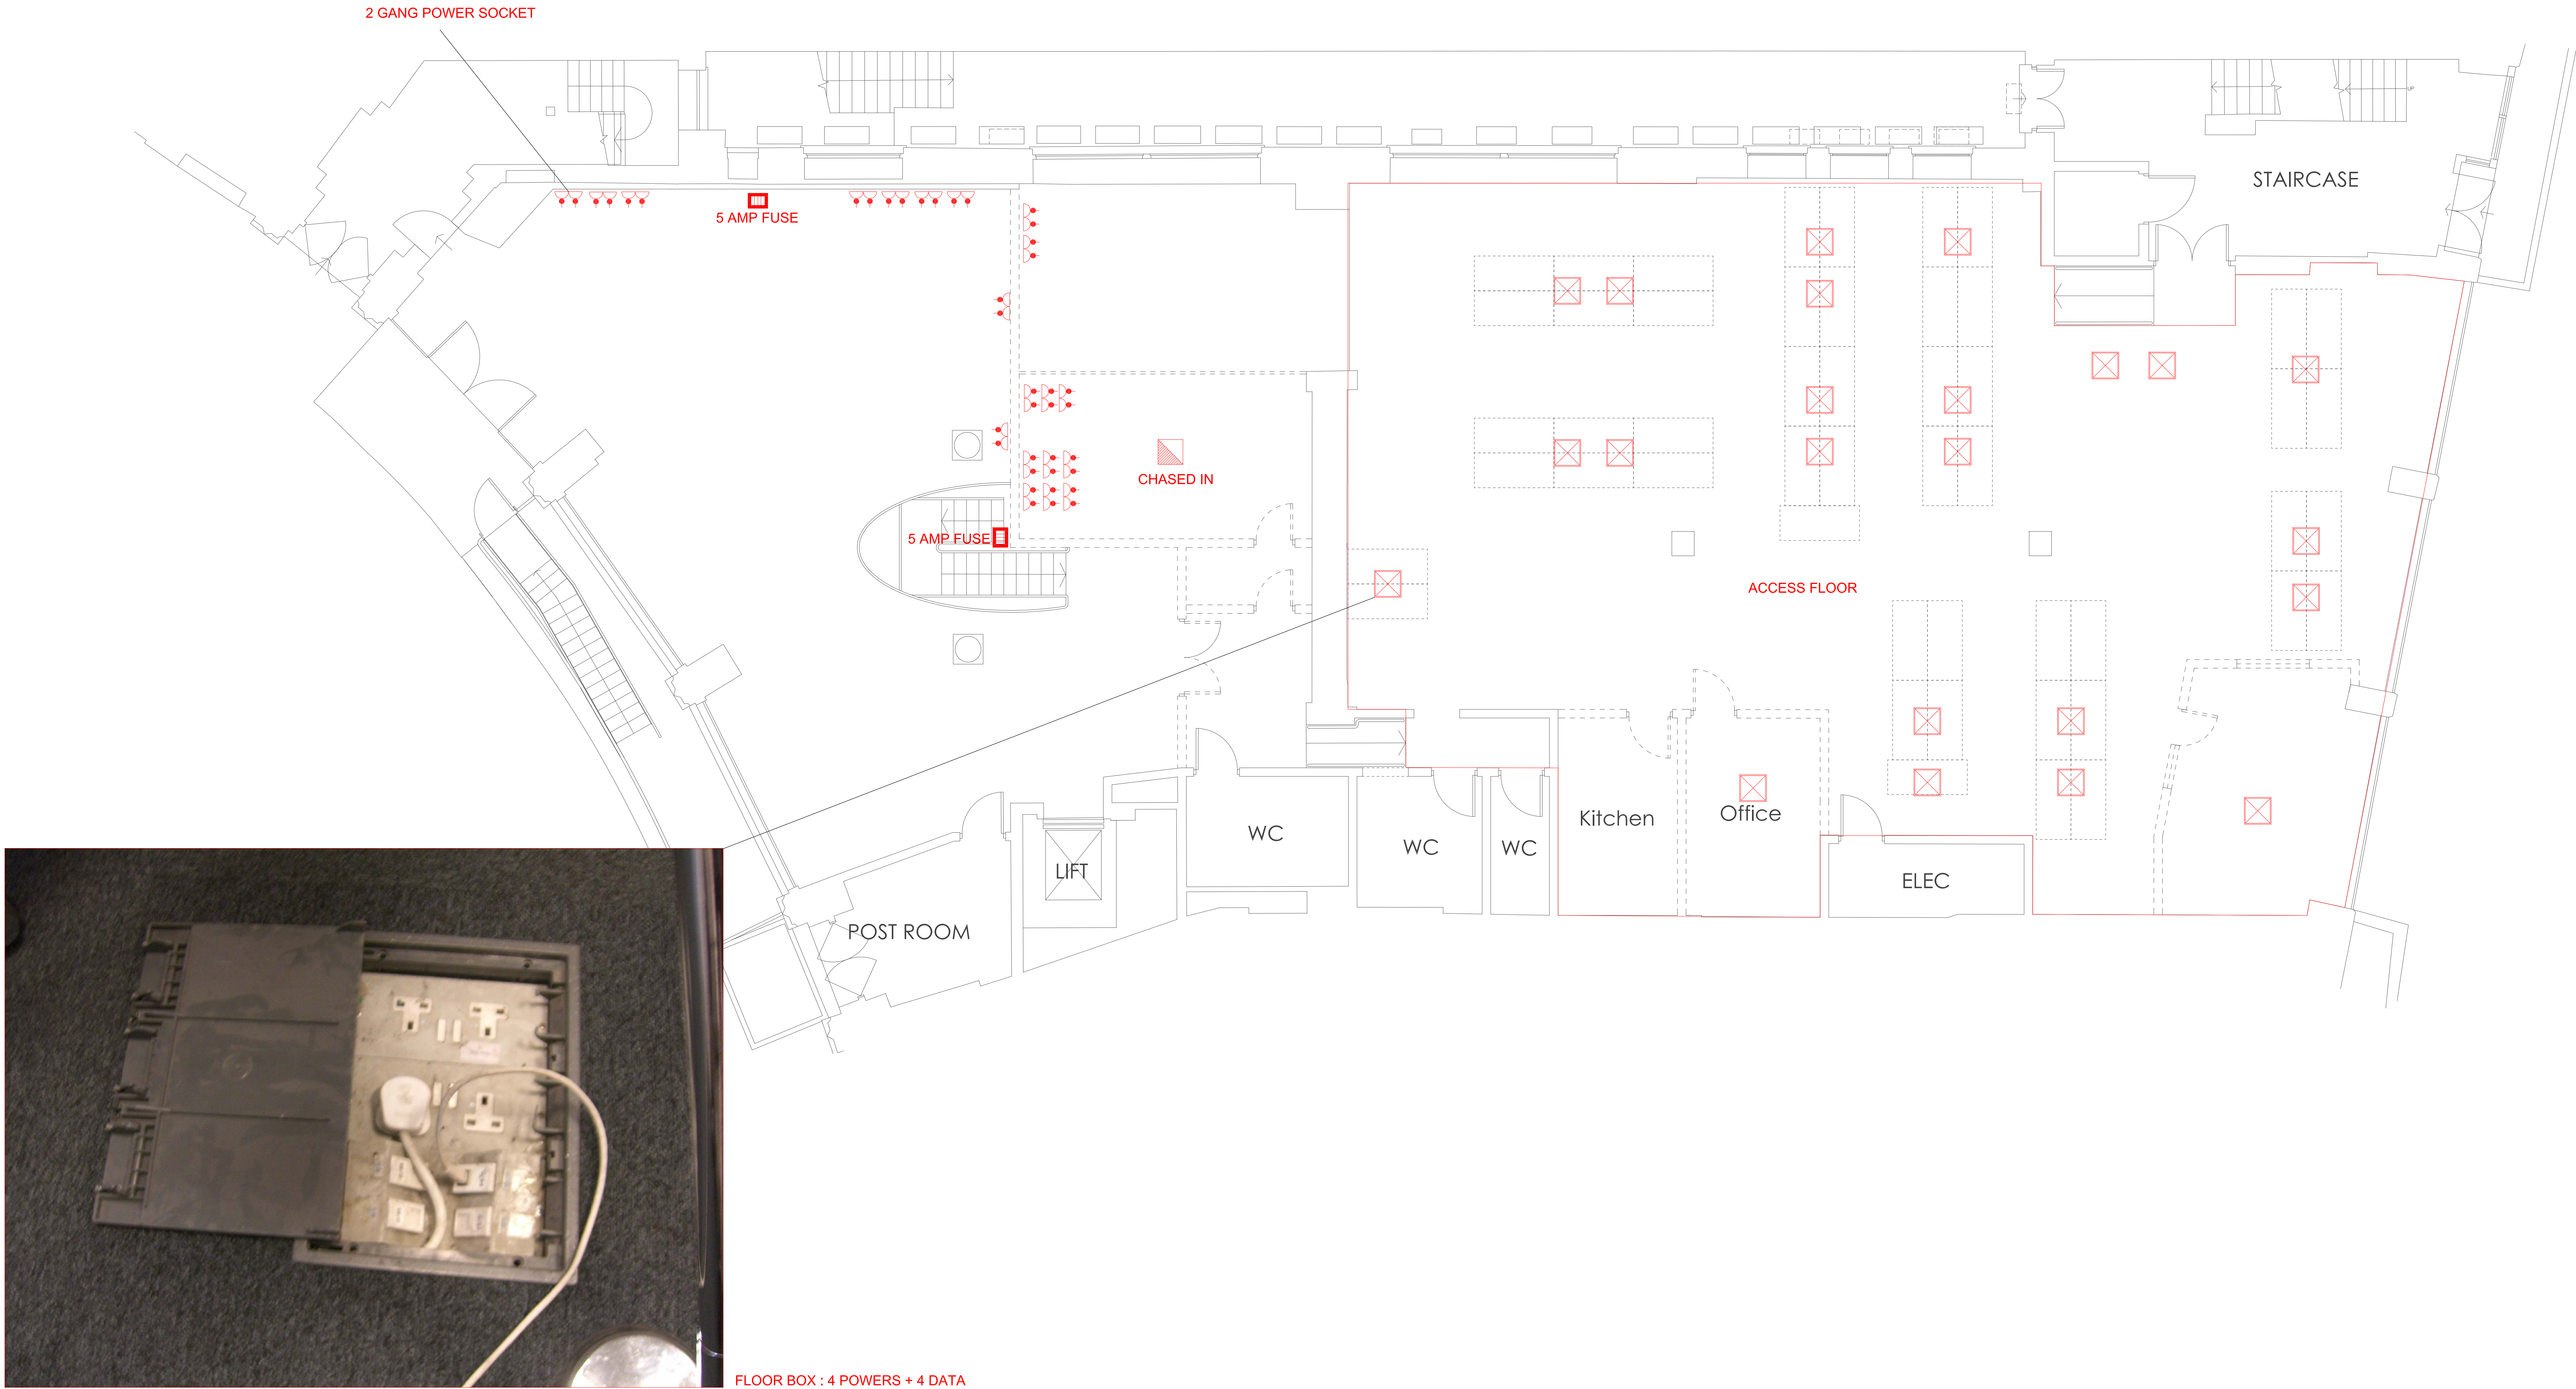

PROJECT TITLE		DRAWING TITLE		CLIENT APPROVAL		REVISION						DRAWN BY		JEAN-YOUNG IM		DATE		21. MAR. 2013		triflecreative* + 44 7796 147 117 hello@triflecreative.com http://www.triflecreative.com			
OMD OFFICE REFURBISHMENT		EXISTING ELECTRIC POWER PLAN												CHECKED BY		SCALE		A0 : 1 / 50					
														APPROVED BY		EMMA MORLEY		DRAWING NO.				SHEET NO.	
																		OMD-ME-11					
SITE		DRAWING REFERENCE																					
MINERVA HOUSE 1-4 NORTH CRESCENT LONDON,WC1E 7ER																							


4 SOCKETS PER WORK DESK
(EXCEPT CREATIVE INTERN & PROJECT TEAM)

OFFICE DESK : 58P
RECEPTION : 2P

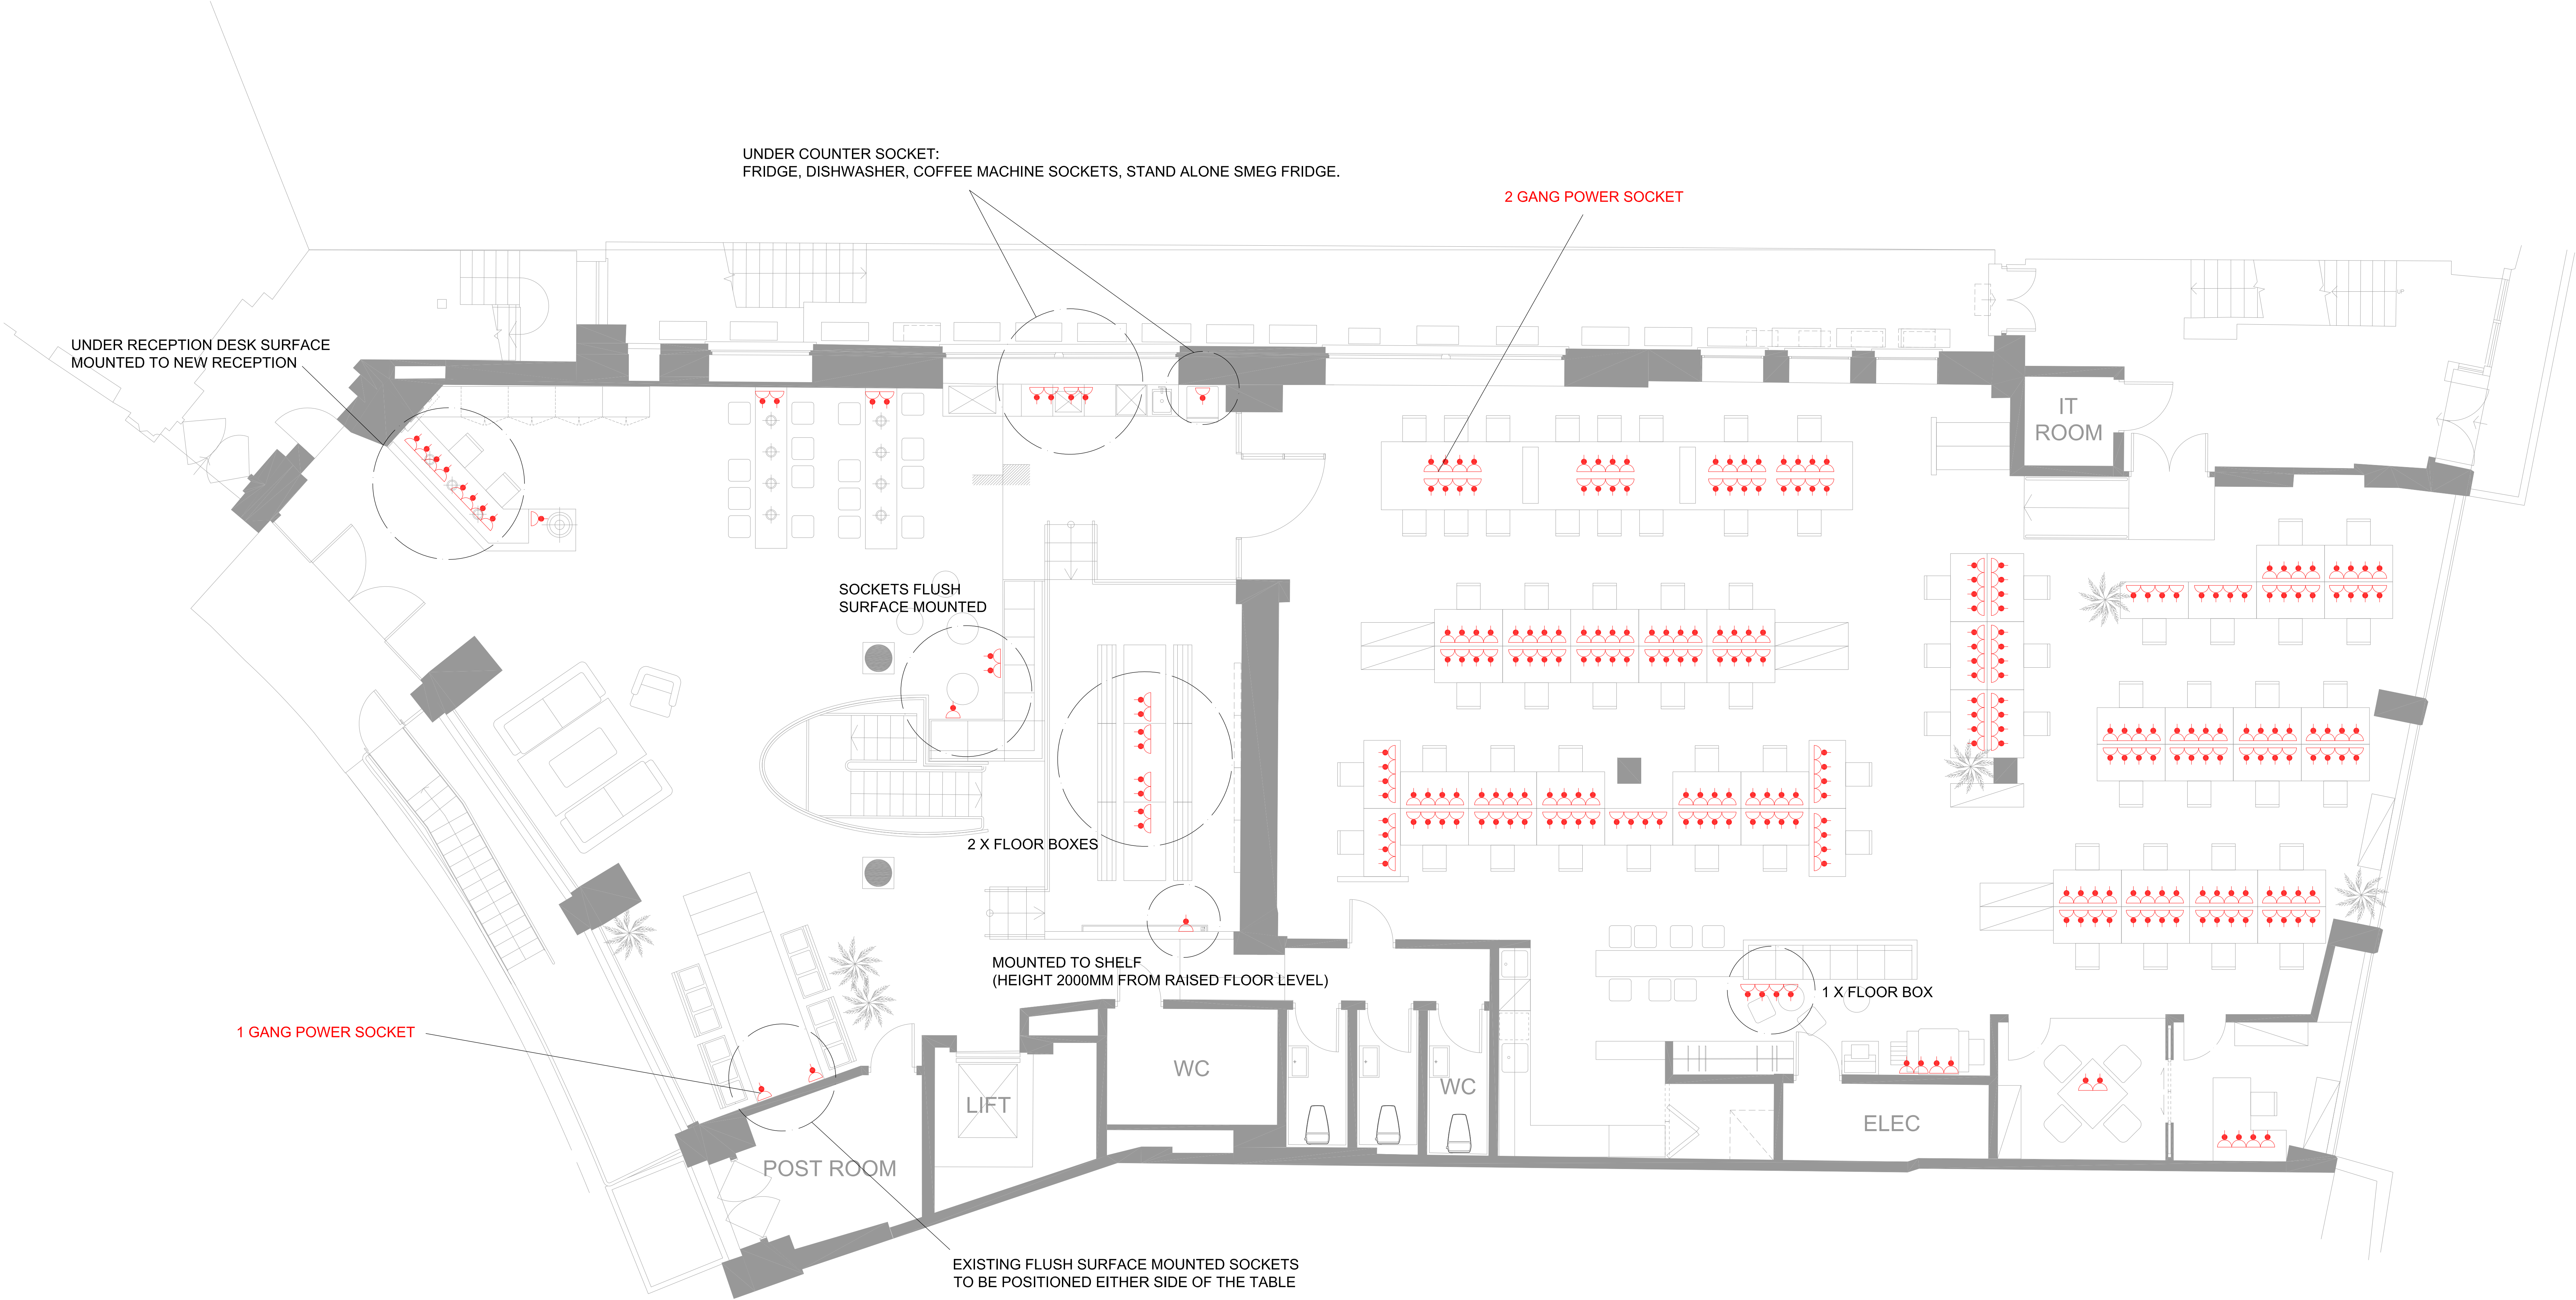

* NOTE
A/V POWER SIWTTCHES AND SERVICES TO BE CONFIRMED

PROJECT TITLE		DRAWING TITLE		CLIENT APPROVAL		REVISION						DRAWN BY		DATE		triflecreative* + 44 7796 147 117 hello@triflecreative.com http://www.triflecreative.com			
OMD OFFICE REFURBISHMENT		PROPOSED ELECTRIC POWER PLAN												17. APR. 2013					
														CHECKED BY				SCALE	
														APPROVED BY				A0 : 1 / 50	
SITE		DRAWING REFERENCE										EMMA MORLEY		DRAWING NO.		SHEET NO.			
MINERVA HOUSE 1-4 NORTH CRESCENT LONDON,WC1E 7ER														OMD-ME-12					

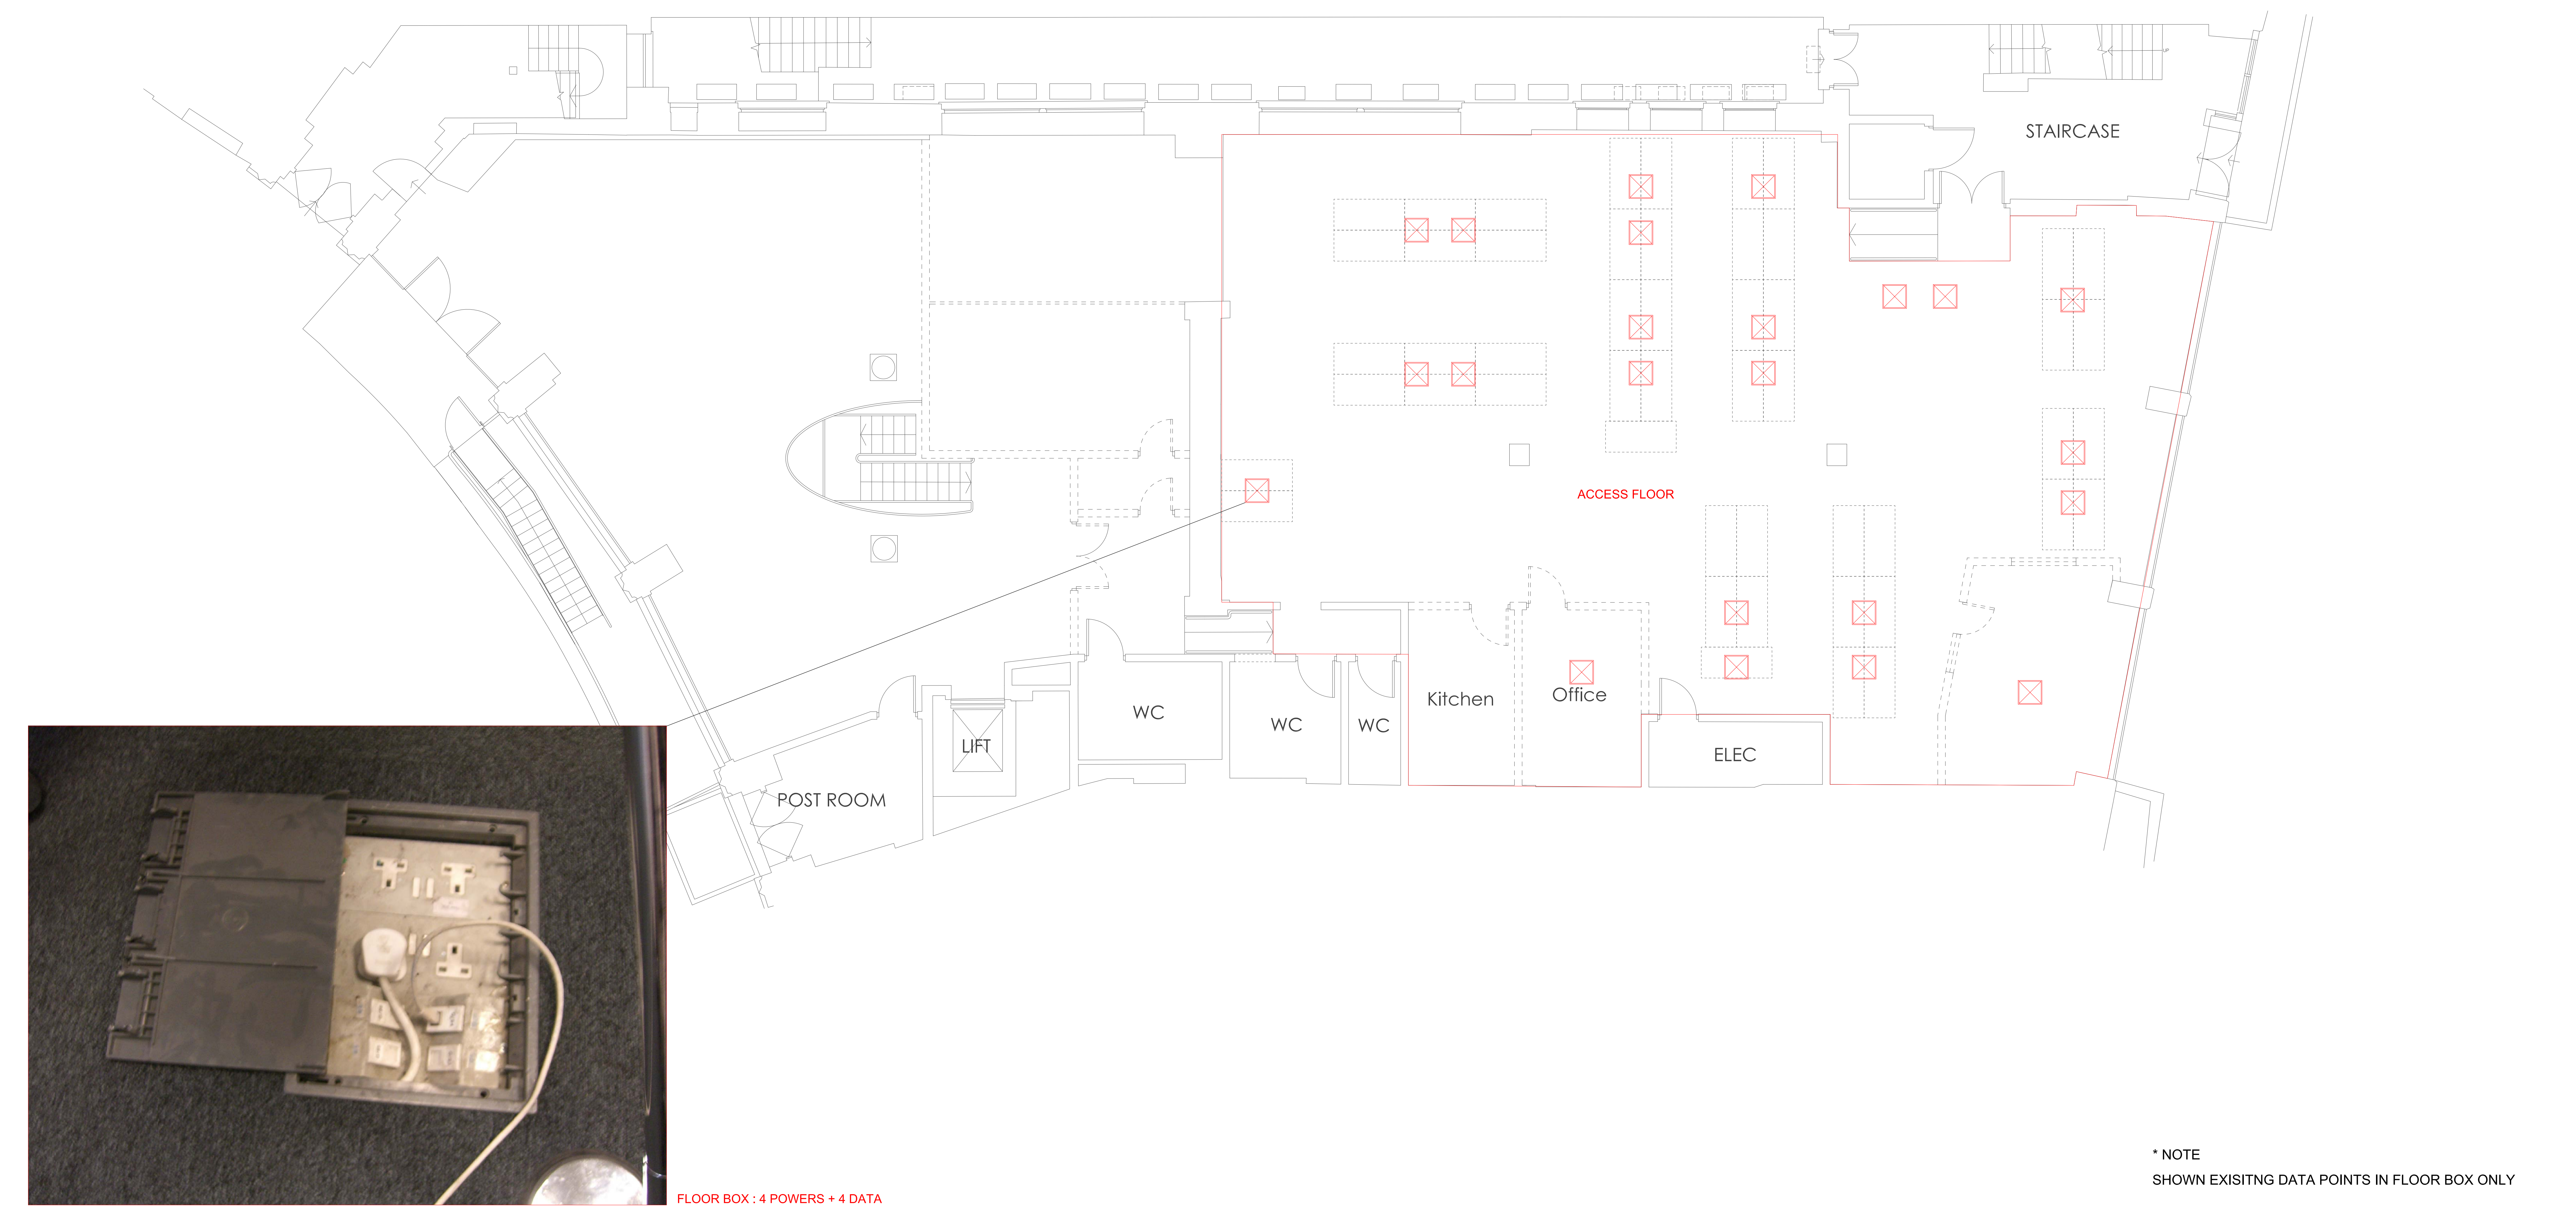


PROJECT TITLE		DRAWING TITLE		CLIENT APPROVAL		REVISION						DRAWN BY		DATE		triflecreative* + 44 7796 147 117 hello@triflecreative.com http://www.triflecreative.com	
OMD		EXISTING DATA PLAN										JEAN-YOUNG IM		22. MAR. 2013			
OFFICE REFURBISHMENT														SCALE			
														A0 : 1 / 50			
SITE		DRAWING REFERENCE												DRAWING NO.			
MINERVA HOUSE 1-4 NORTH CRESCENT LONDON,WC1E 7ER														OMD-ME-13			



1 SOCKET PER WORK DESK
(INCLUDING CREATIVE INTERN & PROJECT TEAM)

OFFICE DESK : 58P
RECEPTION : 2P
CREATIVE INTERN & PROJECT TEAM :12P


PRINTER & COPY : 3 POINTS
A/V : 3 POINTS

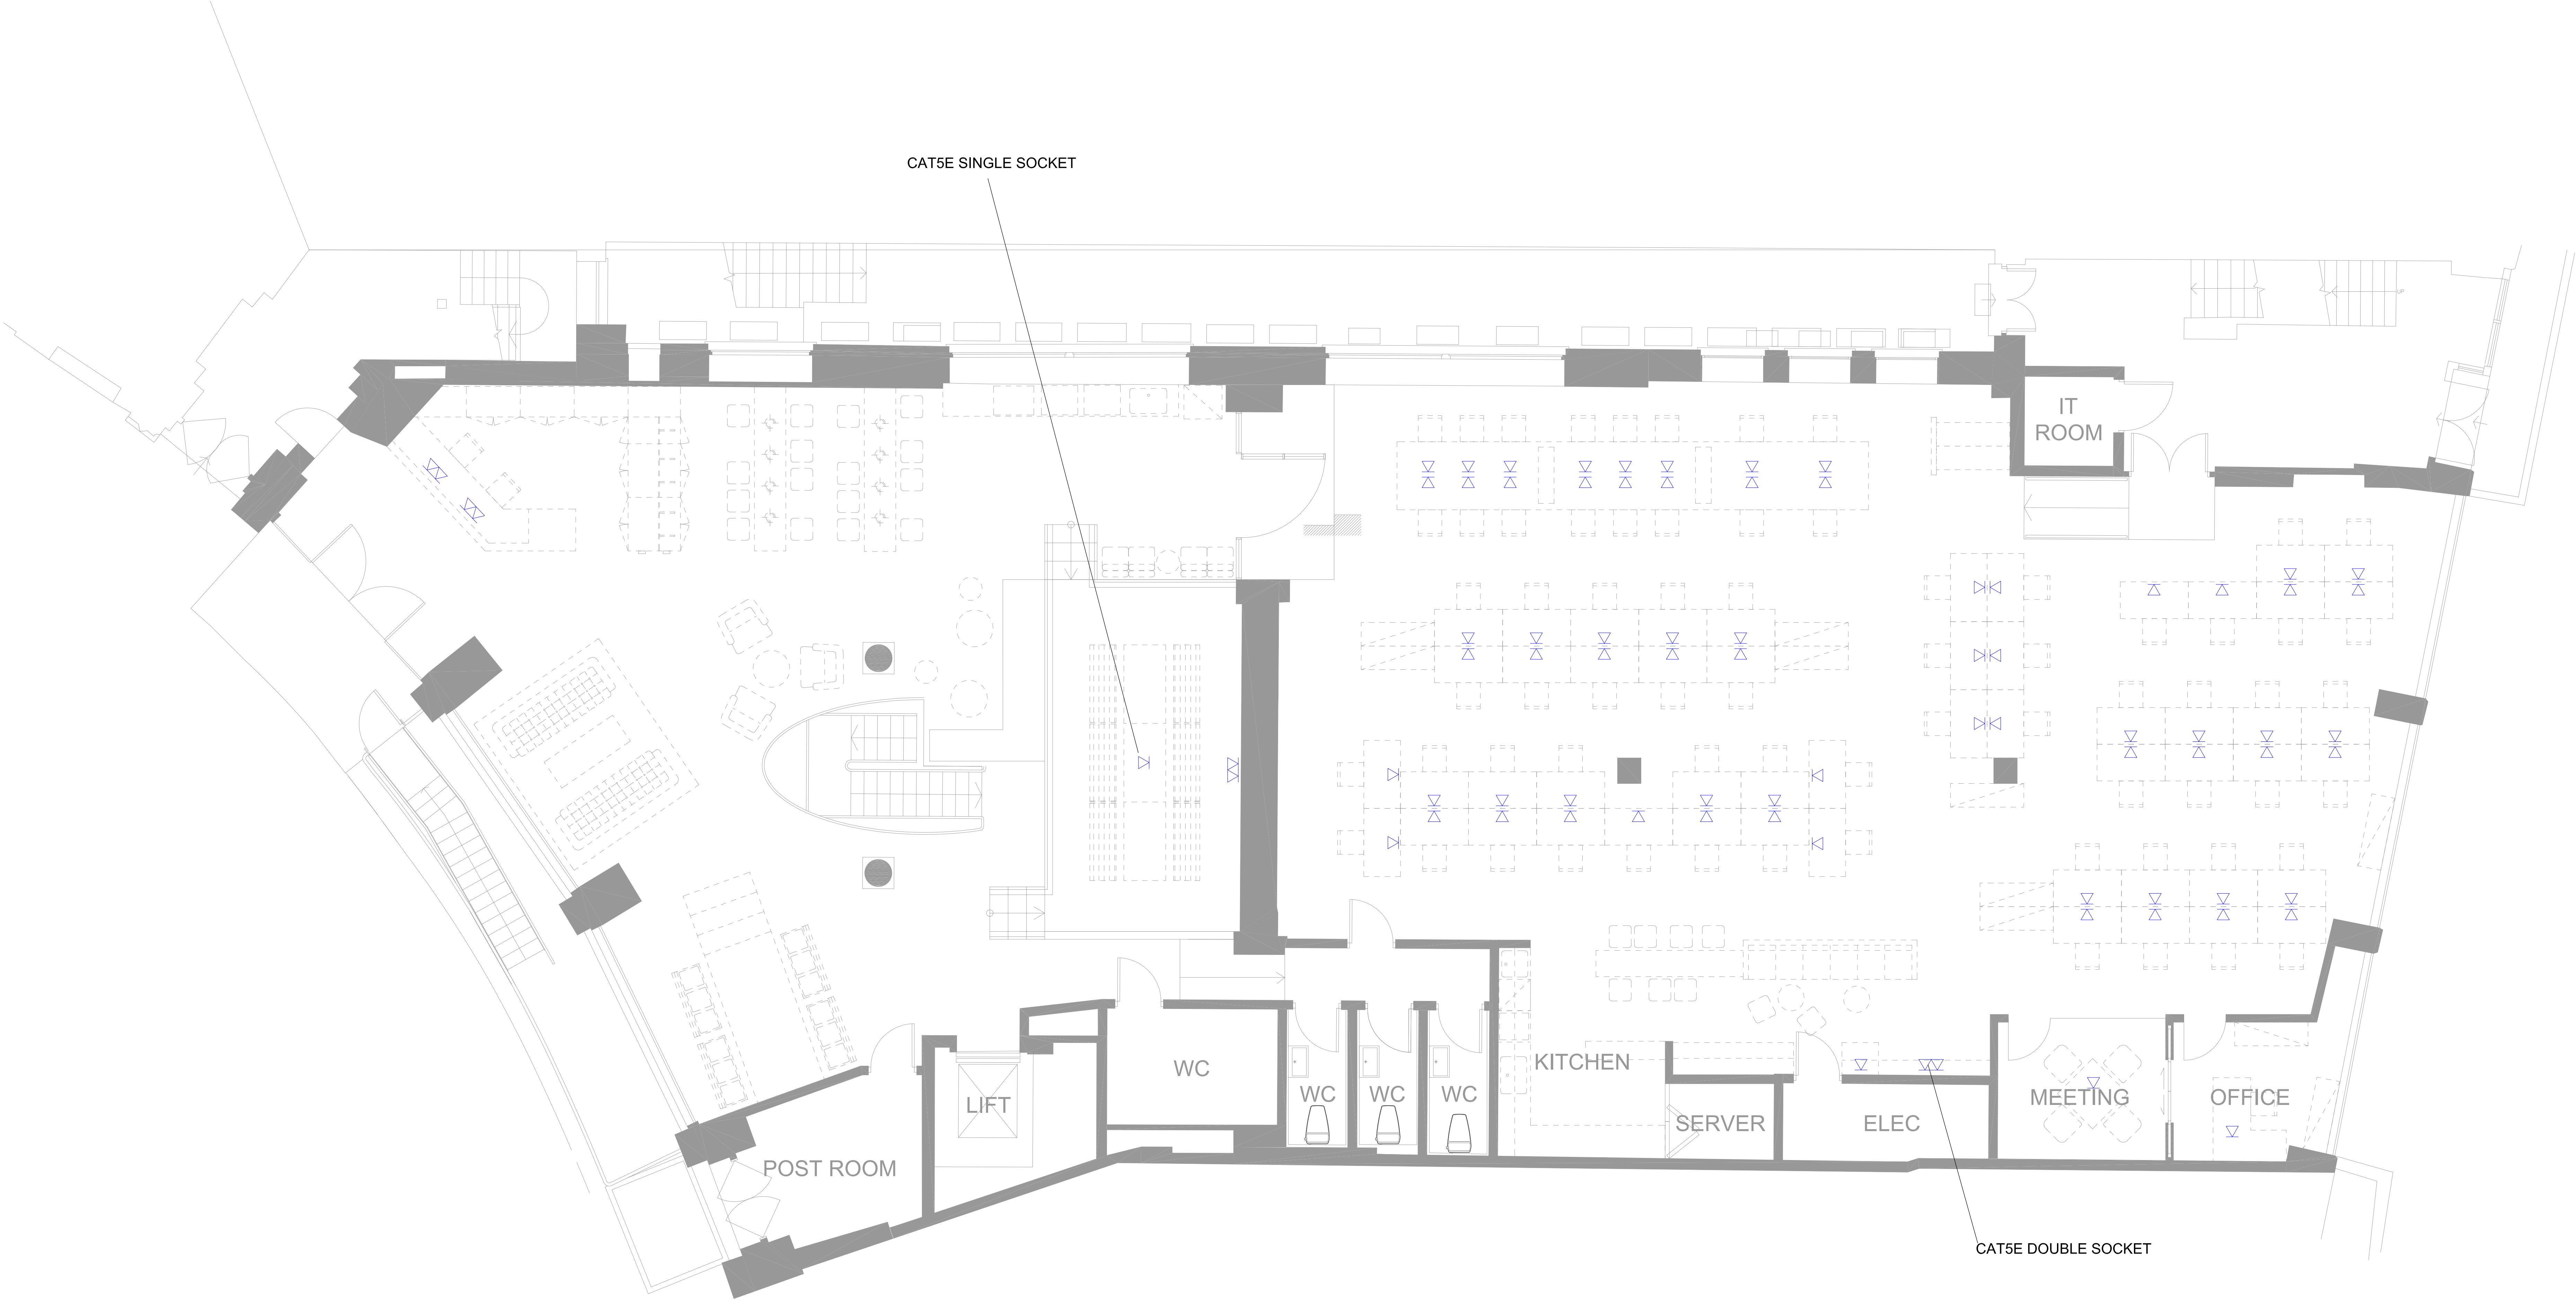


PROJECT TITLE		DRAWING TITLE		CLIENT APPROVAL		REVISION						DRAWN BY		DATE		triflecreative* + 44 7796 147 117 hello@triflecreative.com http://www.triflecreative.com			
OMD OFFICE REFURBISHMENT		PROPOSED DATA PLAN												25. MAR. 2013					
														CHECKED BY				SCALE	
														APPROVED BY				A0 : 1 / 50	
SITE		DRAWING REFERENCE										EMMA MORLEY		DRAWING NO.		SHEET NO.			
MINERVA HOUSE 1-4 NORTH CRESCENT LONDON,WC1E 7ER														OMD-ME-14					

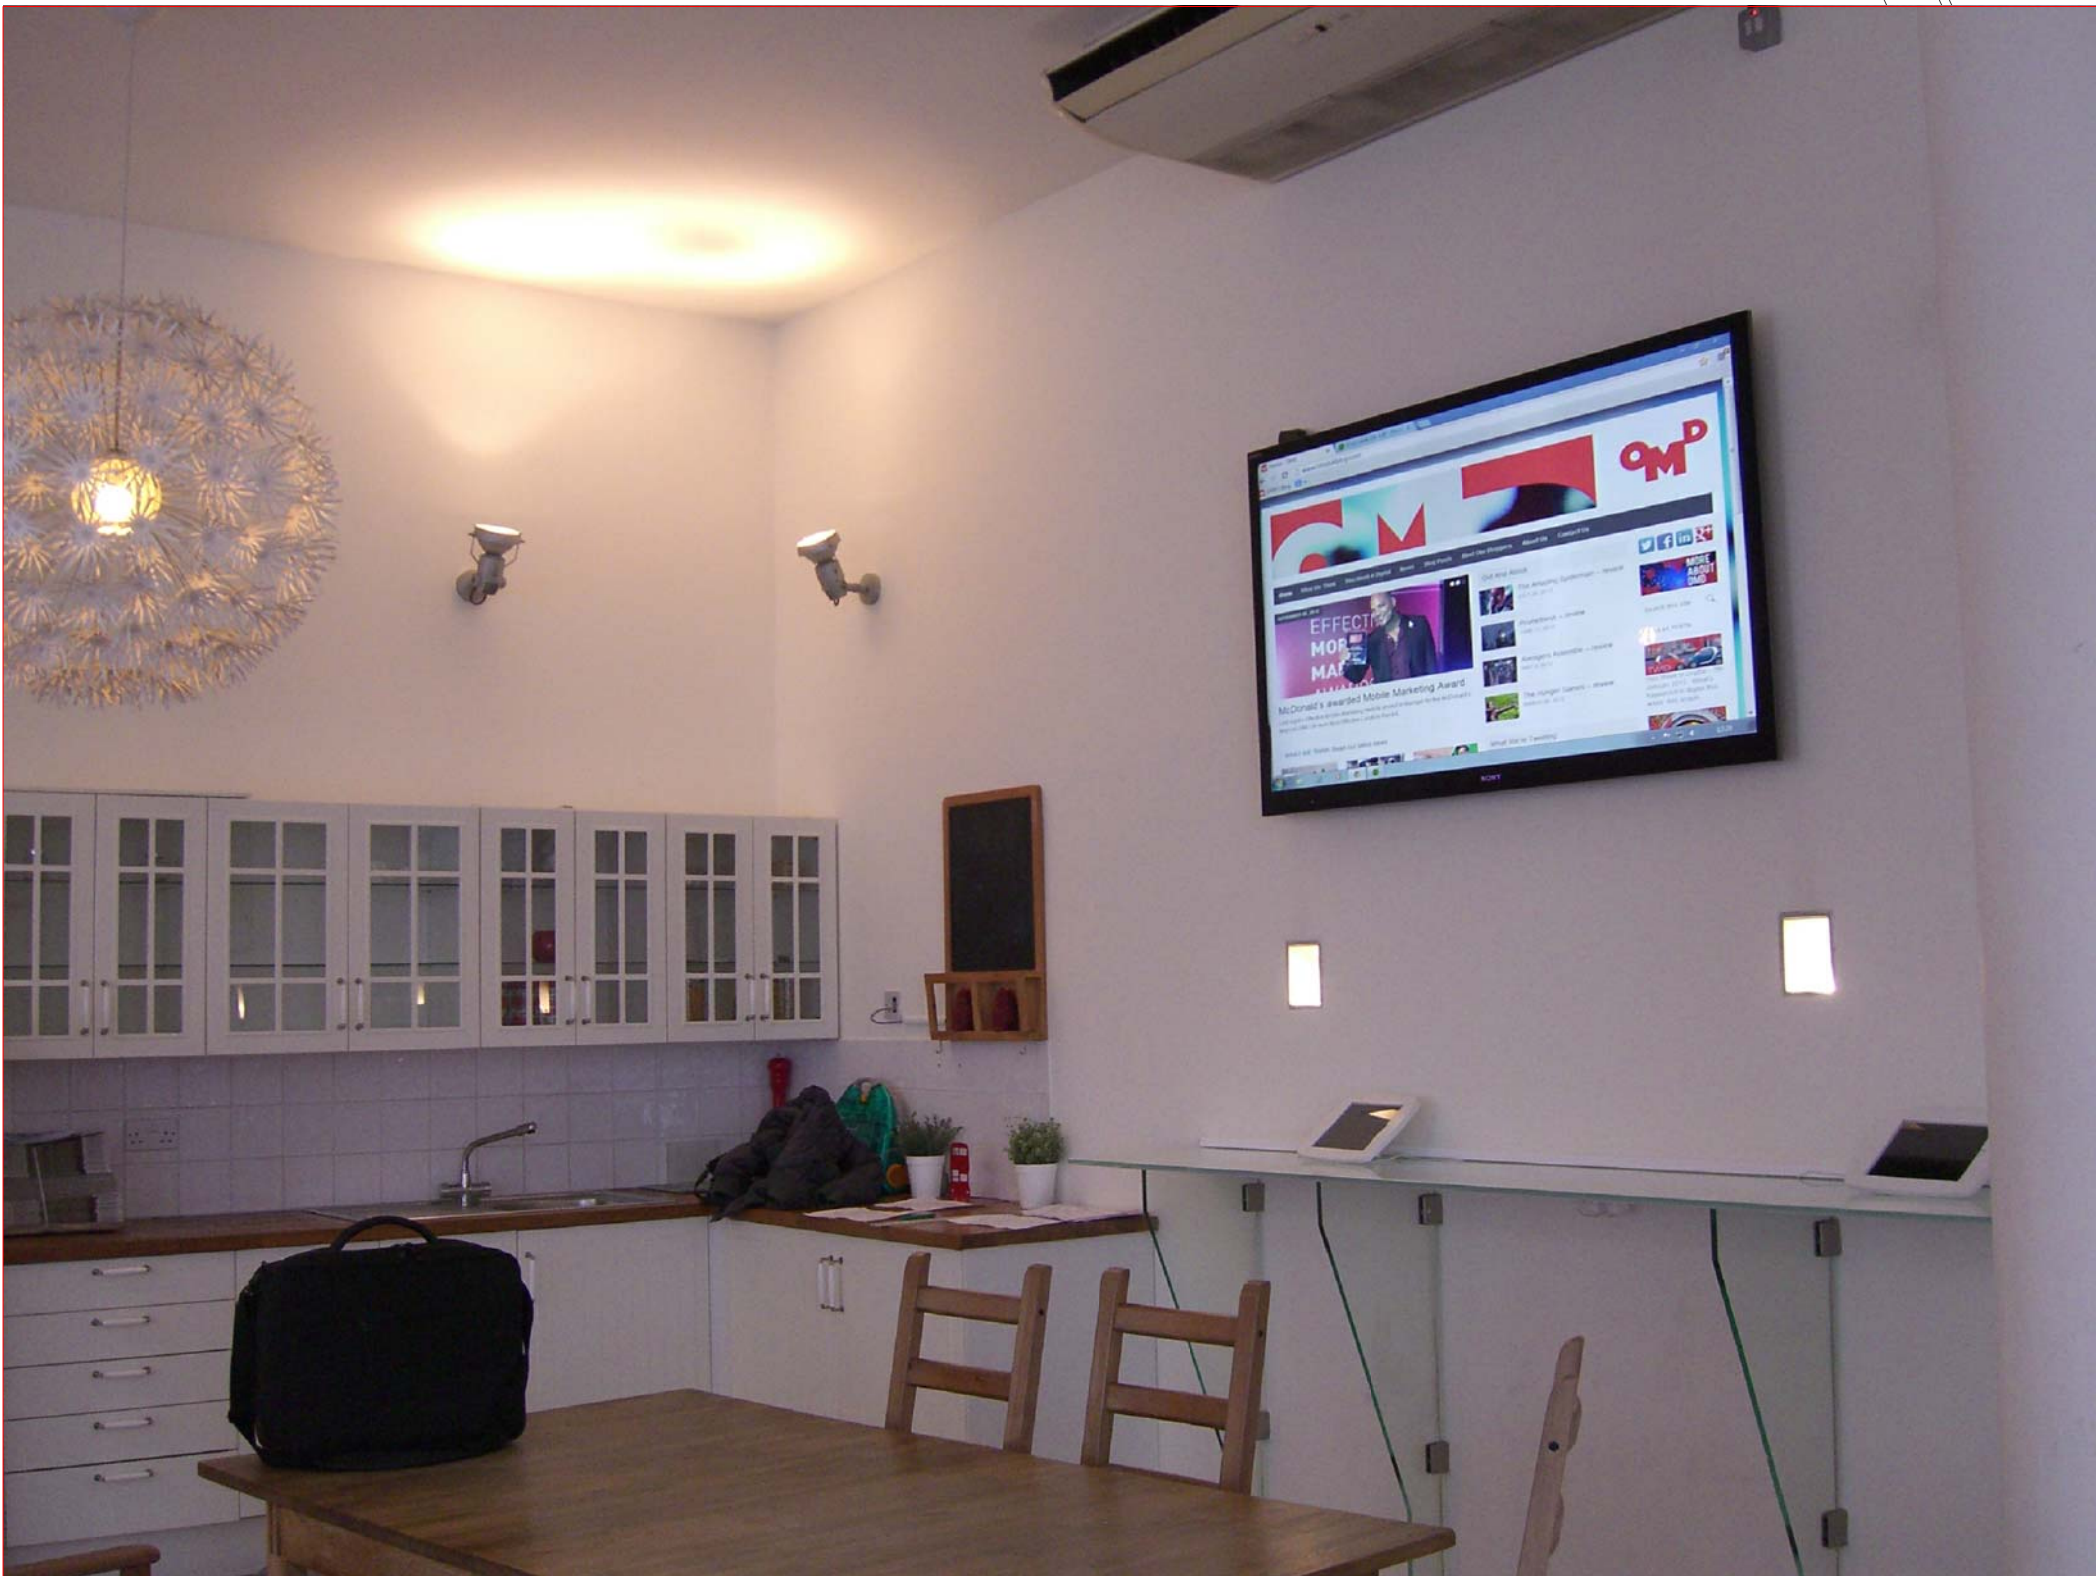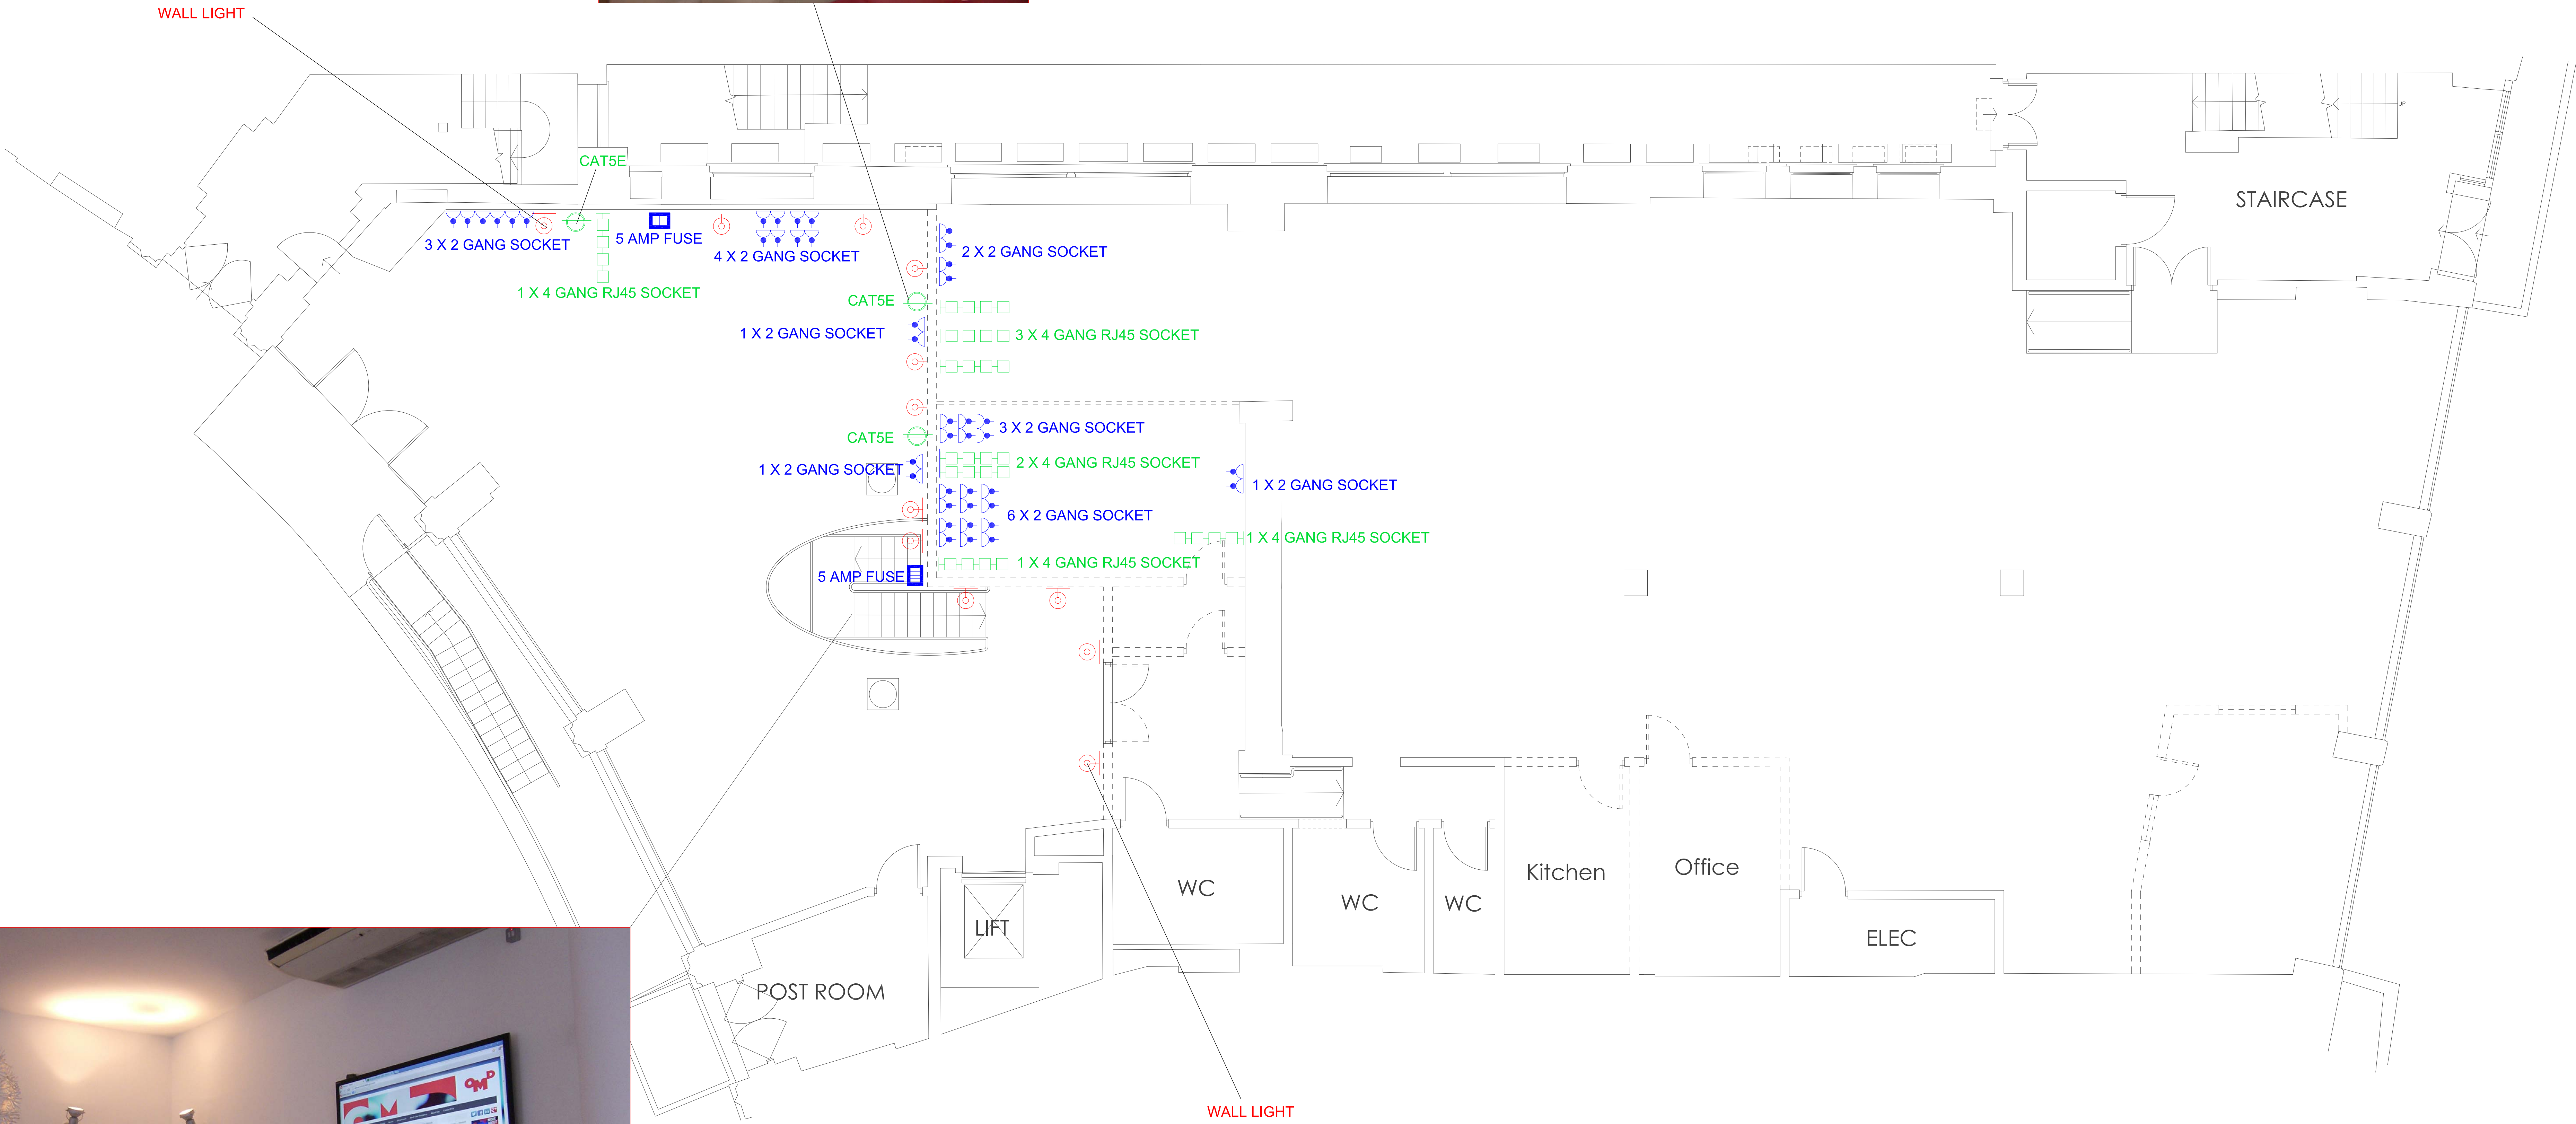


PROJECT TITLE		DRAWING TITLE		CLIENT APPROVAL		REVISION						DRAWN BY		DATE		triflecreative* + 44 7796 147 117 hello@triflecreative.com http://www.triflecreative.com			
OMD OFFICE REFURBISHMENT		ISOLATION OF EXISTING WALL LIGHTS/ SOCKETS												21. MAR. 2013					
														CHECKED BY				SCALE	
														APPROVED BY				A0 : 1 / 50	
SITE		DRAWING REFERENCE										EMMA MORLEY		DRAWING NO.		SHEET NO.			
MINERVA HOUSE 1-4 NORTH CRESCENT LONDON,WC1E 7ER														OMD-ME-15					

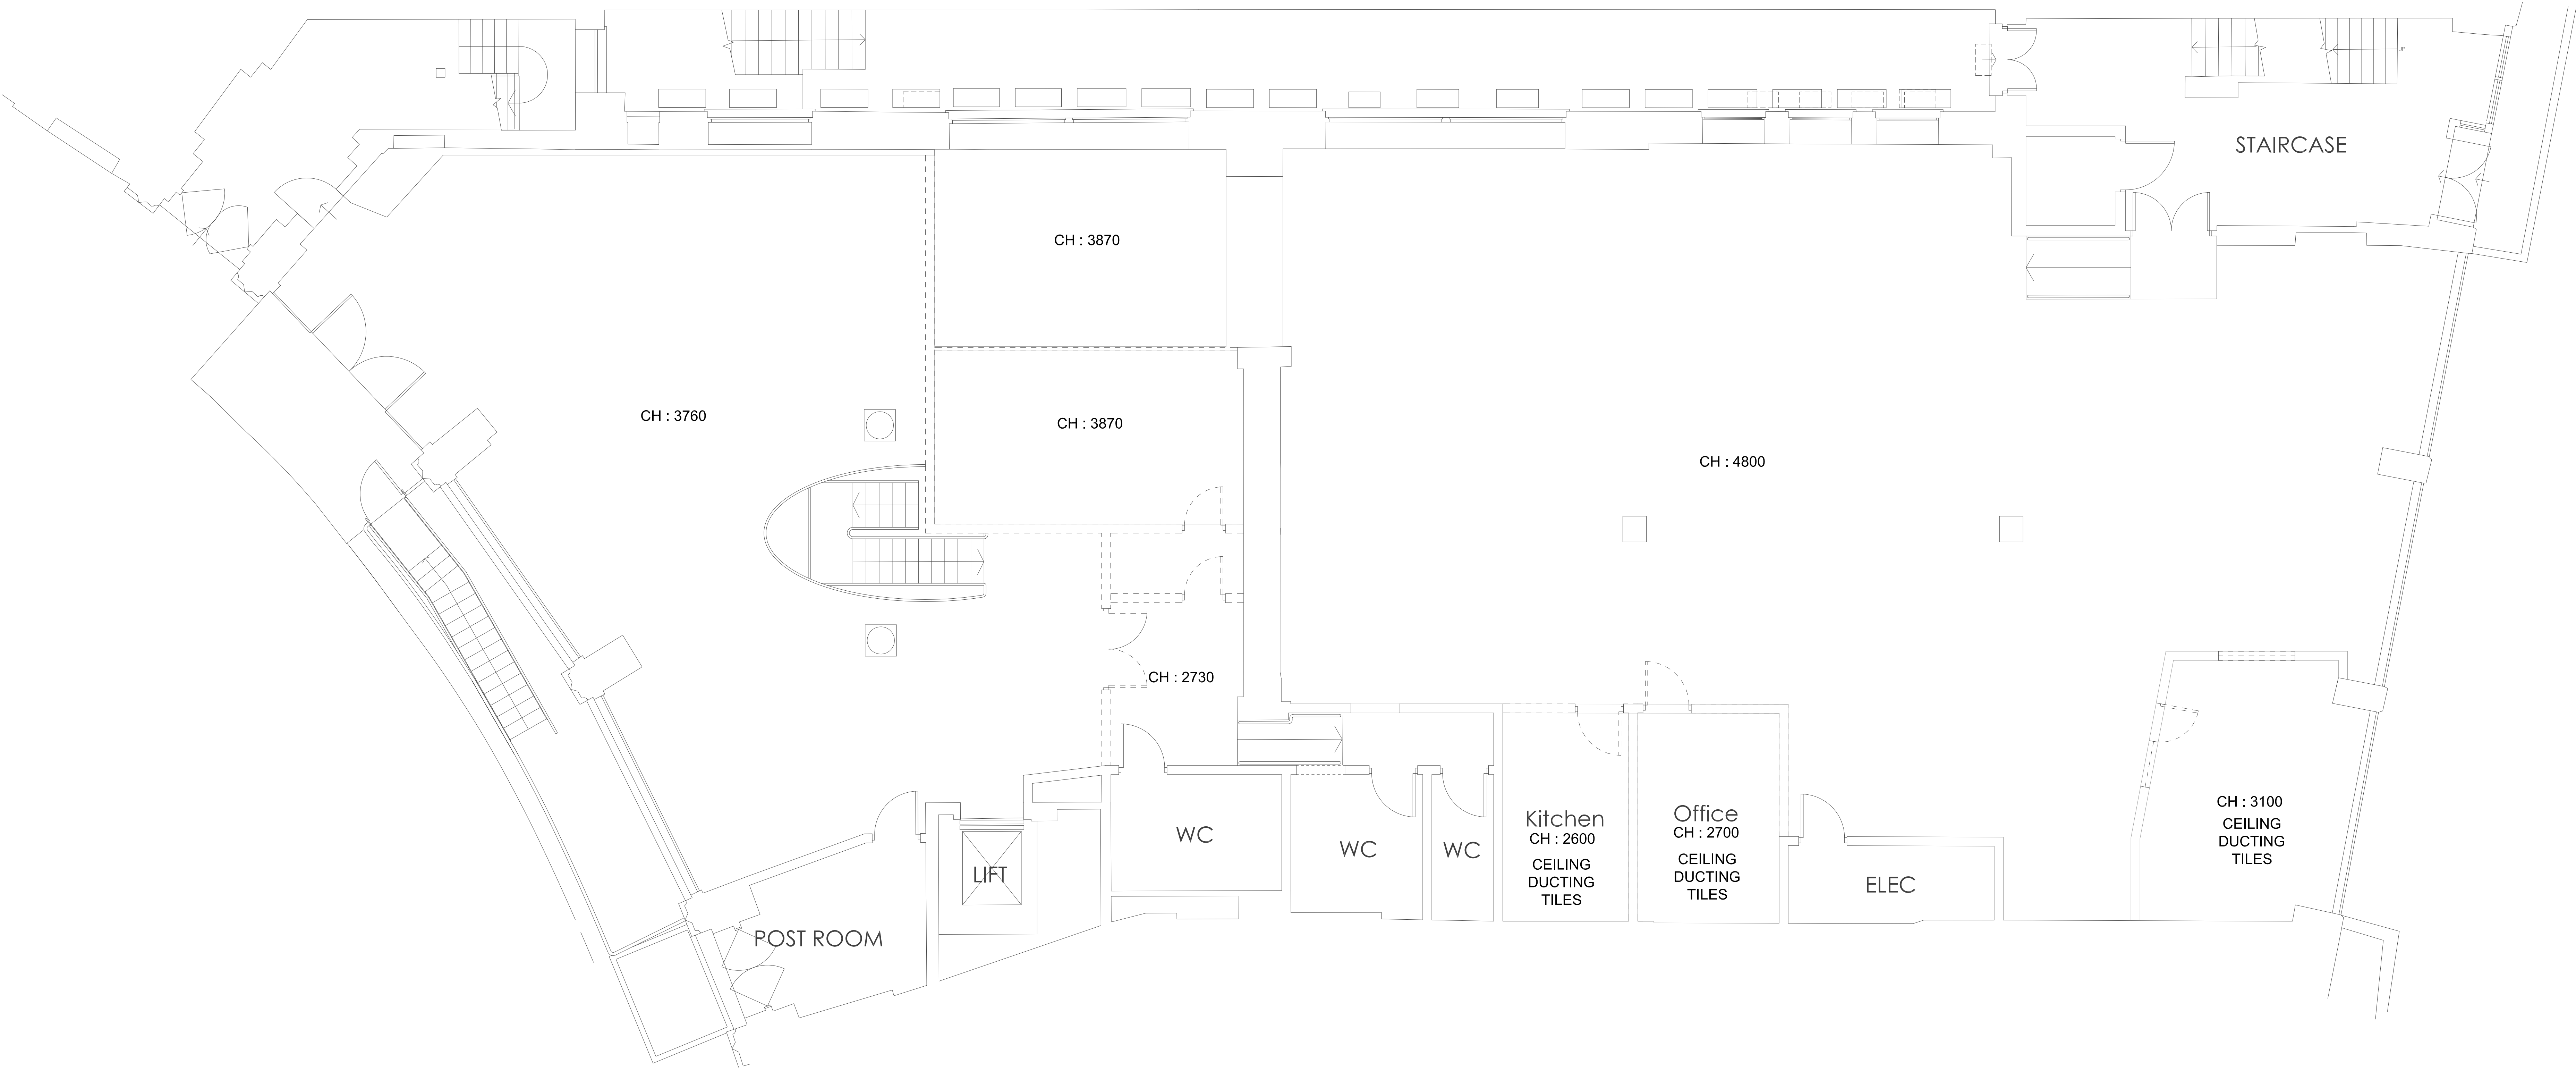

PROJECT TITLE		DRAWING TITLE		CLIENT APPROVAL		REVISION						DRAWN BY		DATE		triflecreative* + 44 7796 147 117 hello@triflecreative.com http://www.triflecreative.com	
OMD OFFICE REFURBISHMENT		EXISTING CEILING LEVEL PLAN										JEAN-YOUNG IM		21. MAR. 2013			
												CHECKED BY		SCALE			
												APPROVED BY		A0 : 1 / 50			
												EMMA MORLEY					
SITE		DRAWING REFERENCE												DRAWING NO.		SHEET NO.	
MINERVA HOUSE 1-4 NORTH CRESCENT LONDON,WC1E 7ER														OMD-CE-01			

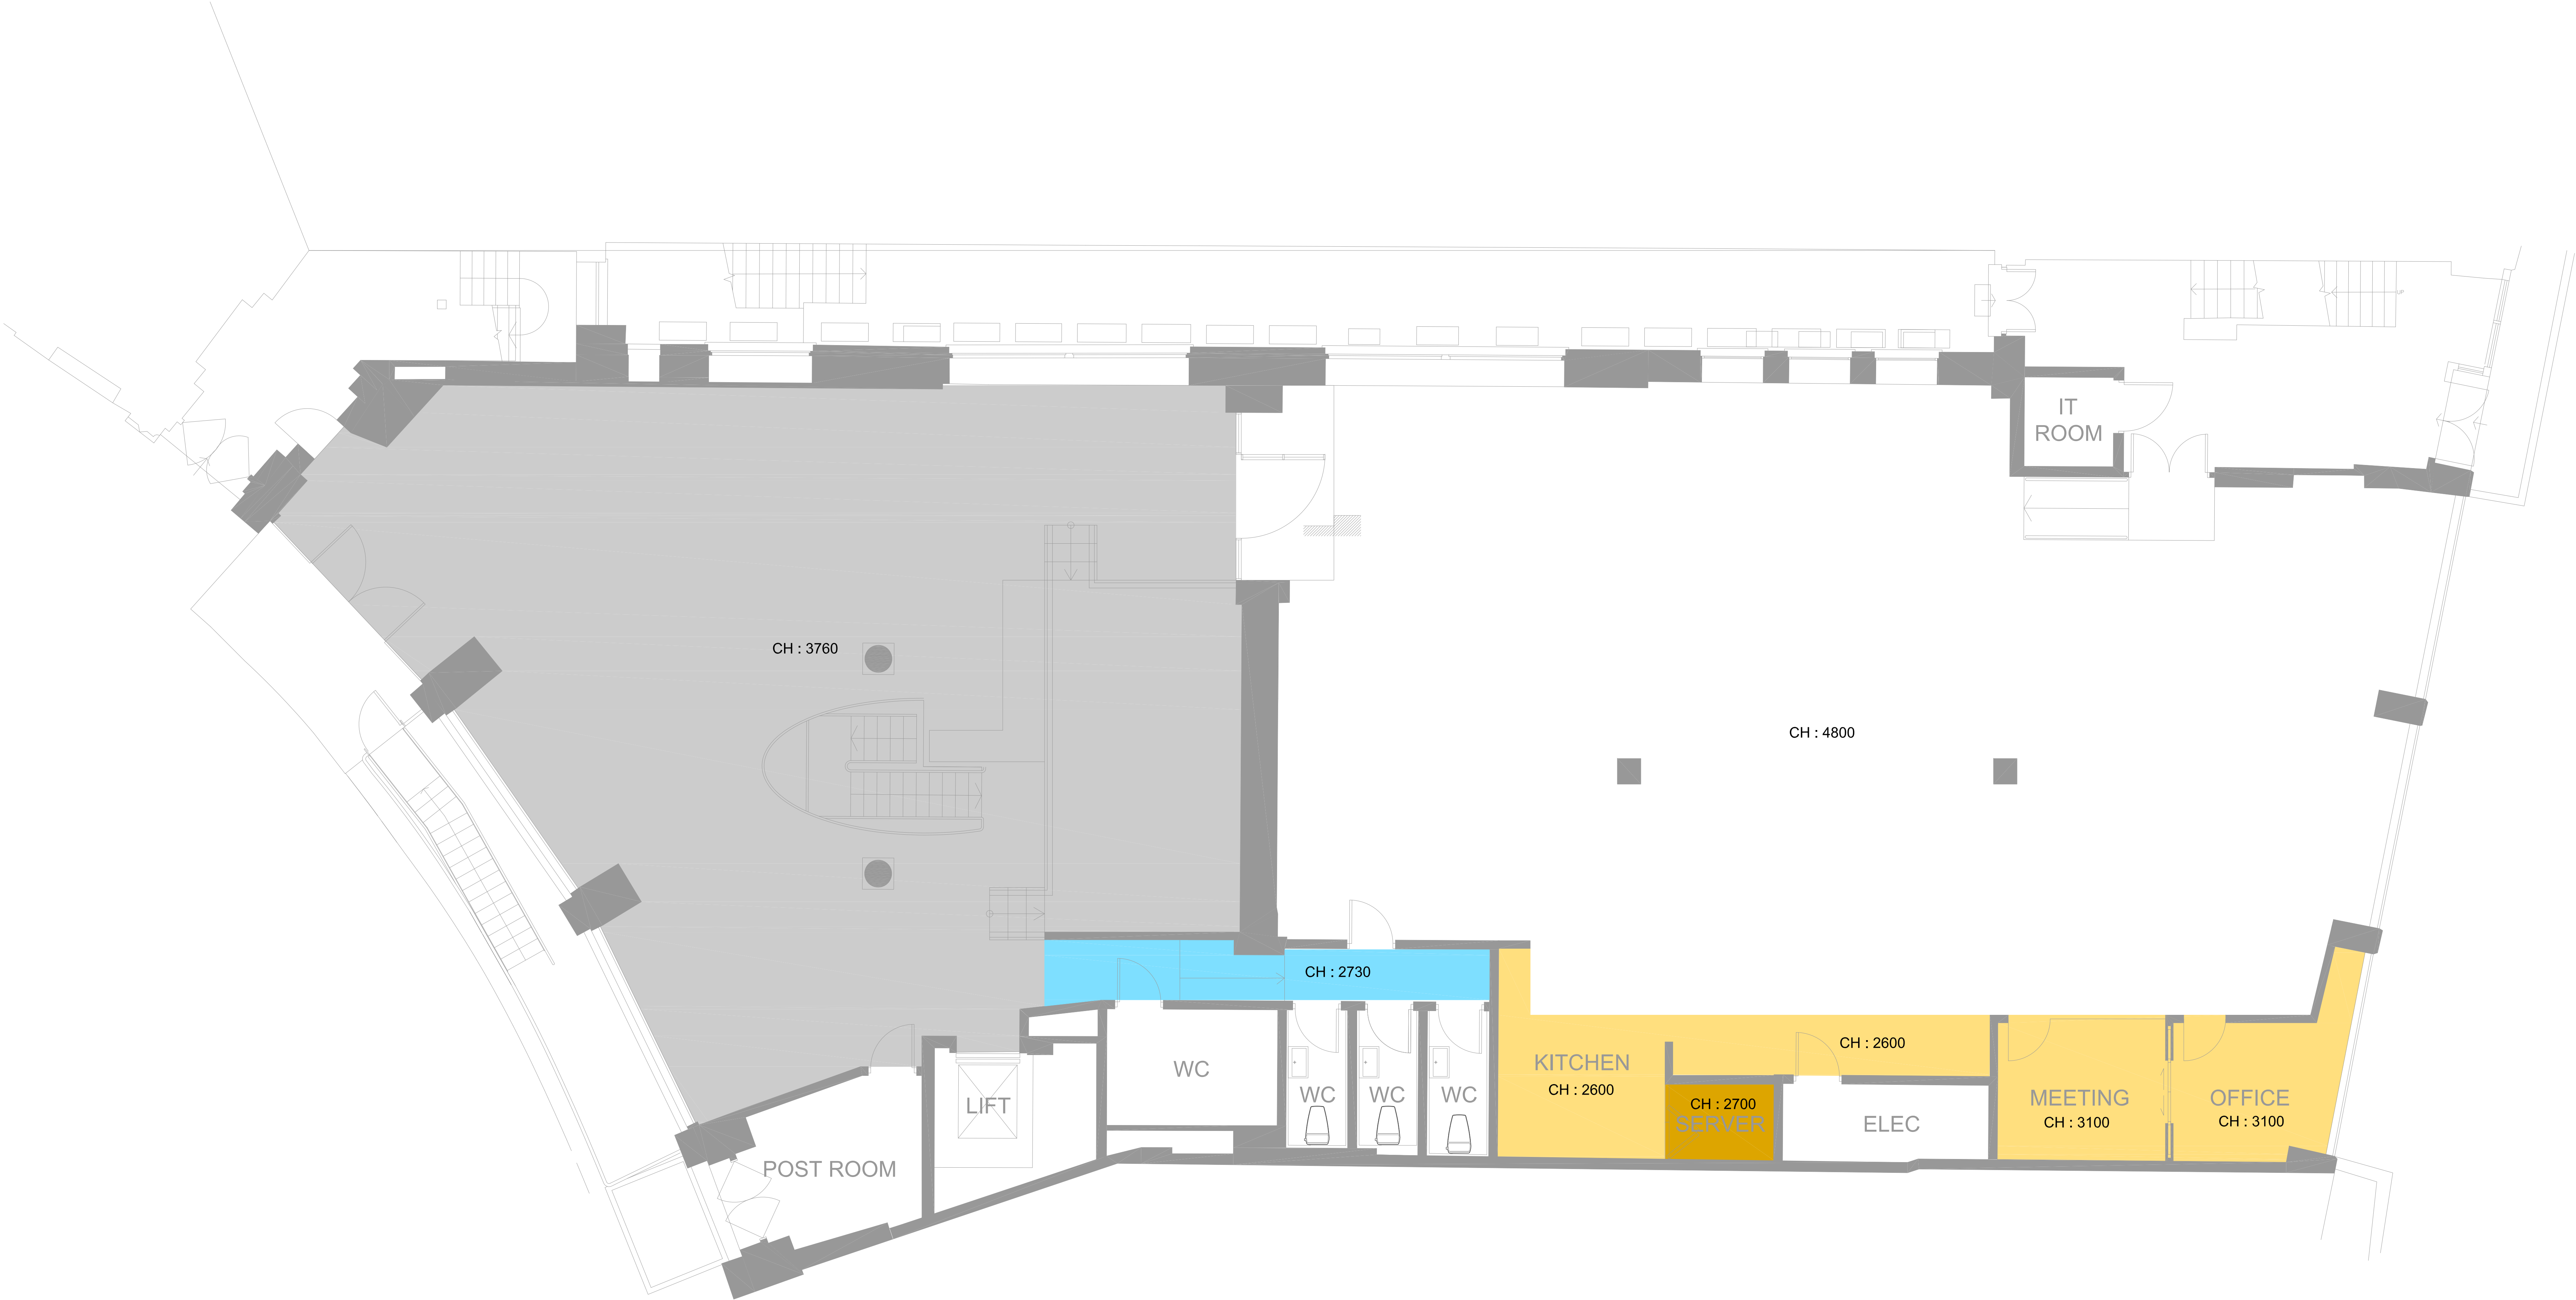

PROJECT TITLE		DRAWING TITLE		CLIENT APPROVAL		REVISION						DRAWN BY		DATE		triflecreative* + 44 7796 147 117 hello@triflecreative.com http://www.triflecreative.com	
OMD OFFICE REFURBISHMENT		PROPOSED CEILING LEVEL PLAN										JEAN-YOUNG IM		21. MAR. 2013			
												CHECKED BY		SCALE			
												APPROVED BY		A0 : 1 / 50			
												EMMA MORLEY		OMD-CE-02			
SITE		DRAWING REFERENCE															
MINERVA HOUSE 1-4 NORTH CRESCENT LONDON,WC1E 7ER																	

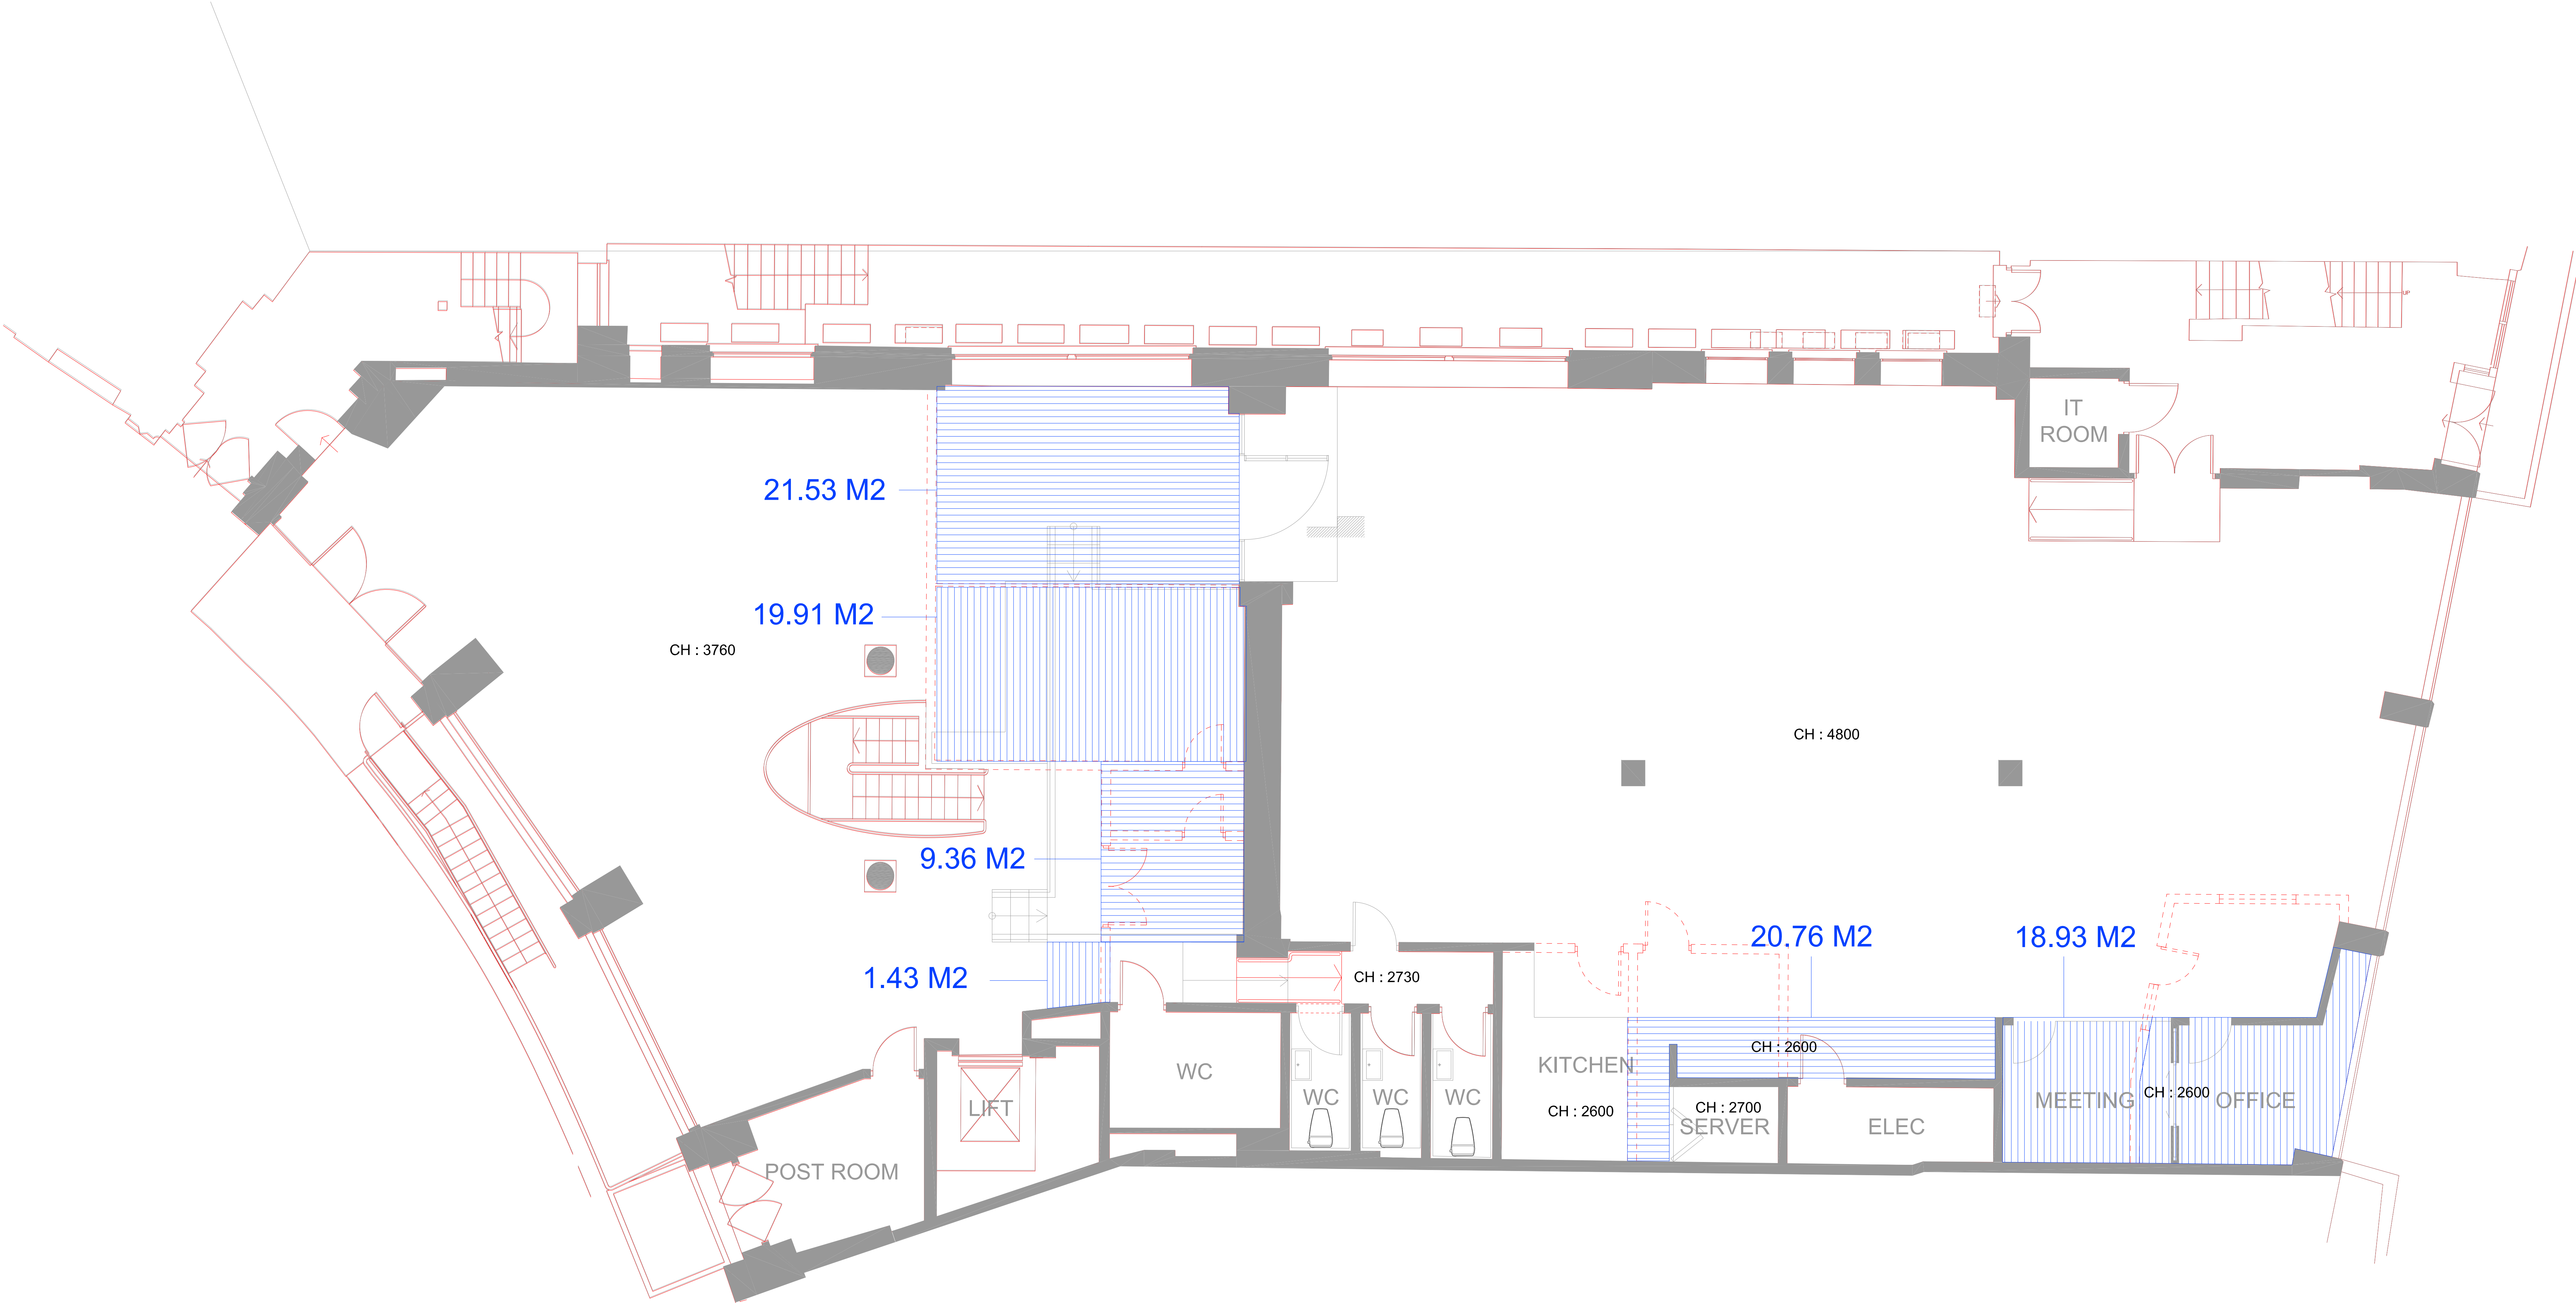

PROJECT TITLE		DRAWING TITLE		CLIENT APPROVAL		REVISION						DRAWN BY		DATE		triflecreative* + 44 7796 147 117 hello@triflecreative.com http://www.triflecreative.com
OMD		PROPOSED CEILING										JEAN-YOUNG IM		21. MAR. 2013		
OFFICE REFURBISHMENT		BUILDING WORK PLAN												A0 : 1 / 50		
SITE		DRAWING REFERENCE										APPROVED BY		DRAWING NO.		
MINERVA HOUSE 1-4 NORTH CRESCENT LONDON,WC1E 7ER												EMMA MORLEY		OMD-CE-03		