


Notes :

1. This Drawing is to be read in conjunction with all relevant Architect's Engineer's and specialists' drawings and specifications. Any discrepancies from the information indicated on these drawings shall immediately be brought to the attention of the engineer.
2. Do not scale from this drawing in either paper or digital form. Use written dimensions only. To check drawing has been printed to the intended scale this bar should be 50mm long @ A1 or 25mm long @ A3.
3. Health & Safety : All specific drawing notes are to be read in conjunction with the project "Information Pack" and "Site Rules".
4. Details of the landscape layout are taken from drawing "0903EB_402B" issued by Meadow Croft Griffin Architects.

DRAINAGE KEY

	Gravel Trench
	Gravel Around trees

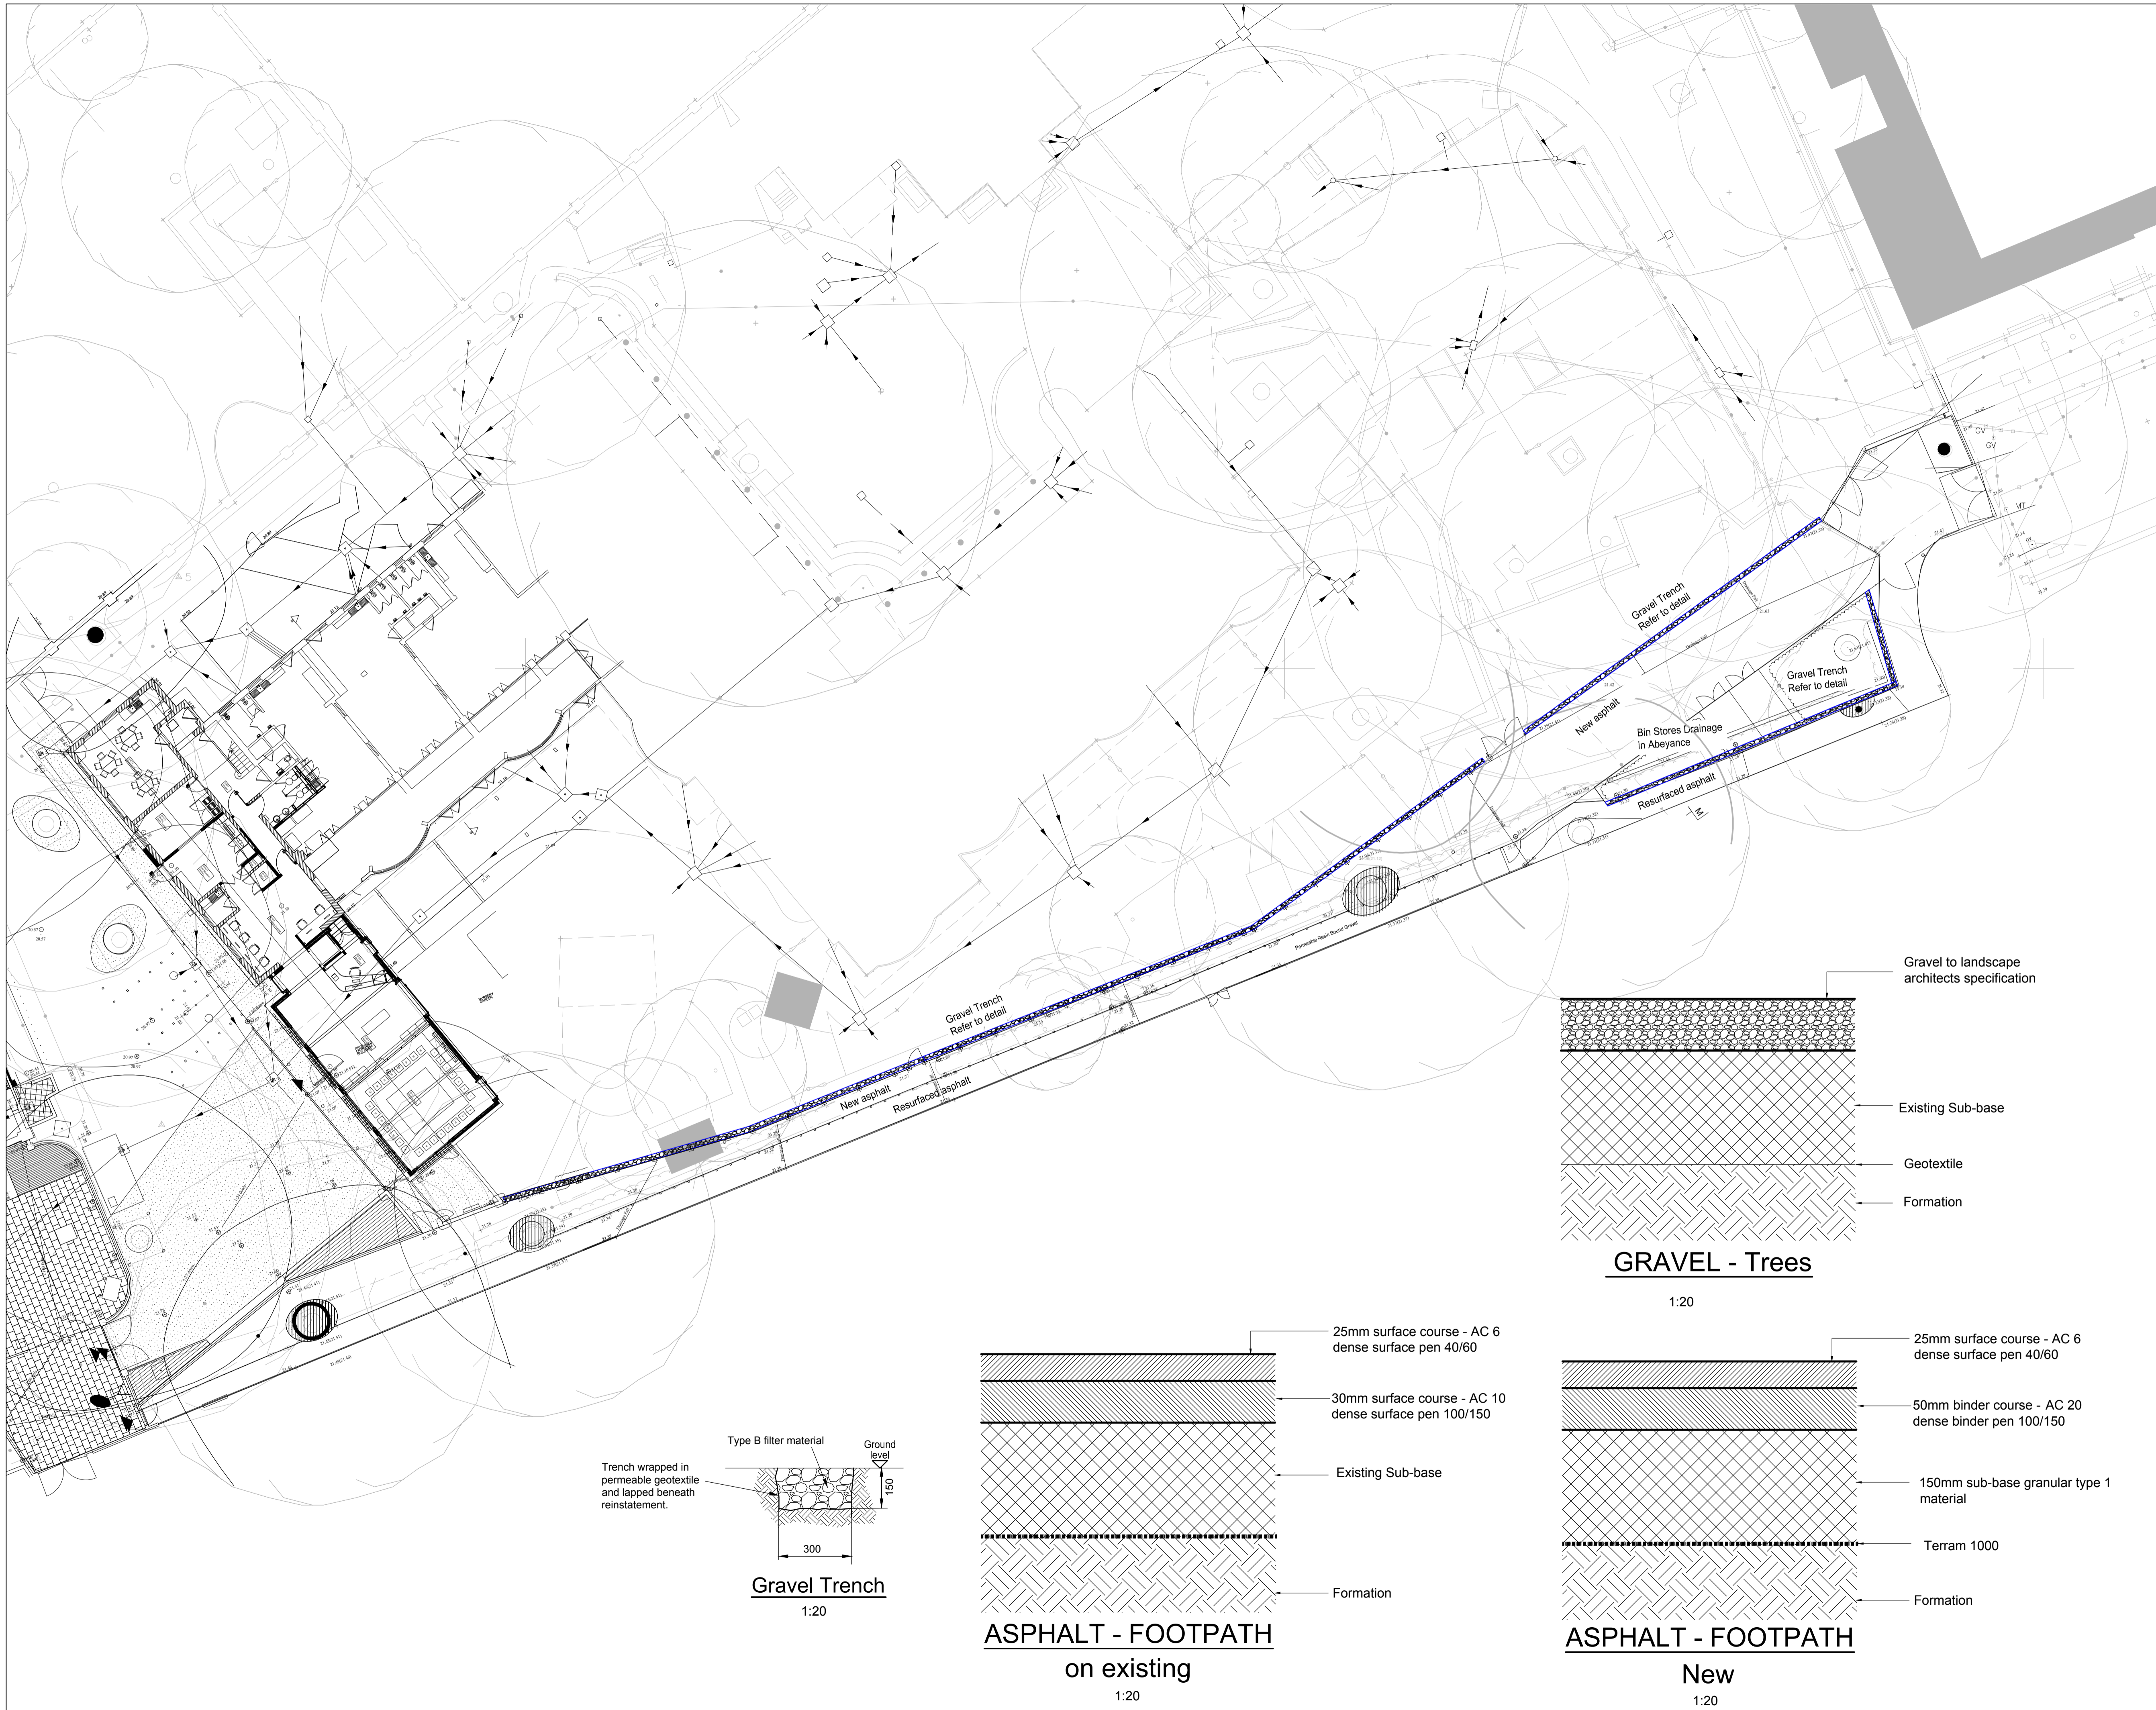

CONSTRUCTION ISSUE

C1	16-04-13	SG	SG	Issued for Construction
T3	17-08-12	SG	SG	Issued for Tender-Revised Layout
T2	24-08-12	SG	SG	Issued for Tender-Revised Layout
T1	09-08-12	SG	SG	Issued for Tender
Rev	Date	Drawn	Eng	Amendment

CORAM CAMPUS BLOOMSBURY PHASE 2 DRAINAGE LAYOUT

Drawn	SG	Eng	DL
Scales	1:200 at A1		
Drawing No	20936-D02	Rev	C1