



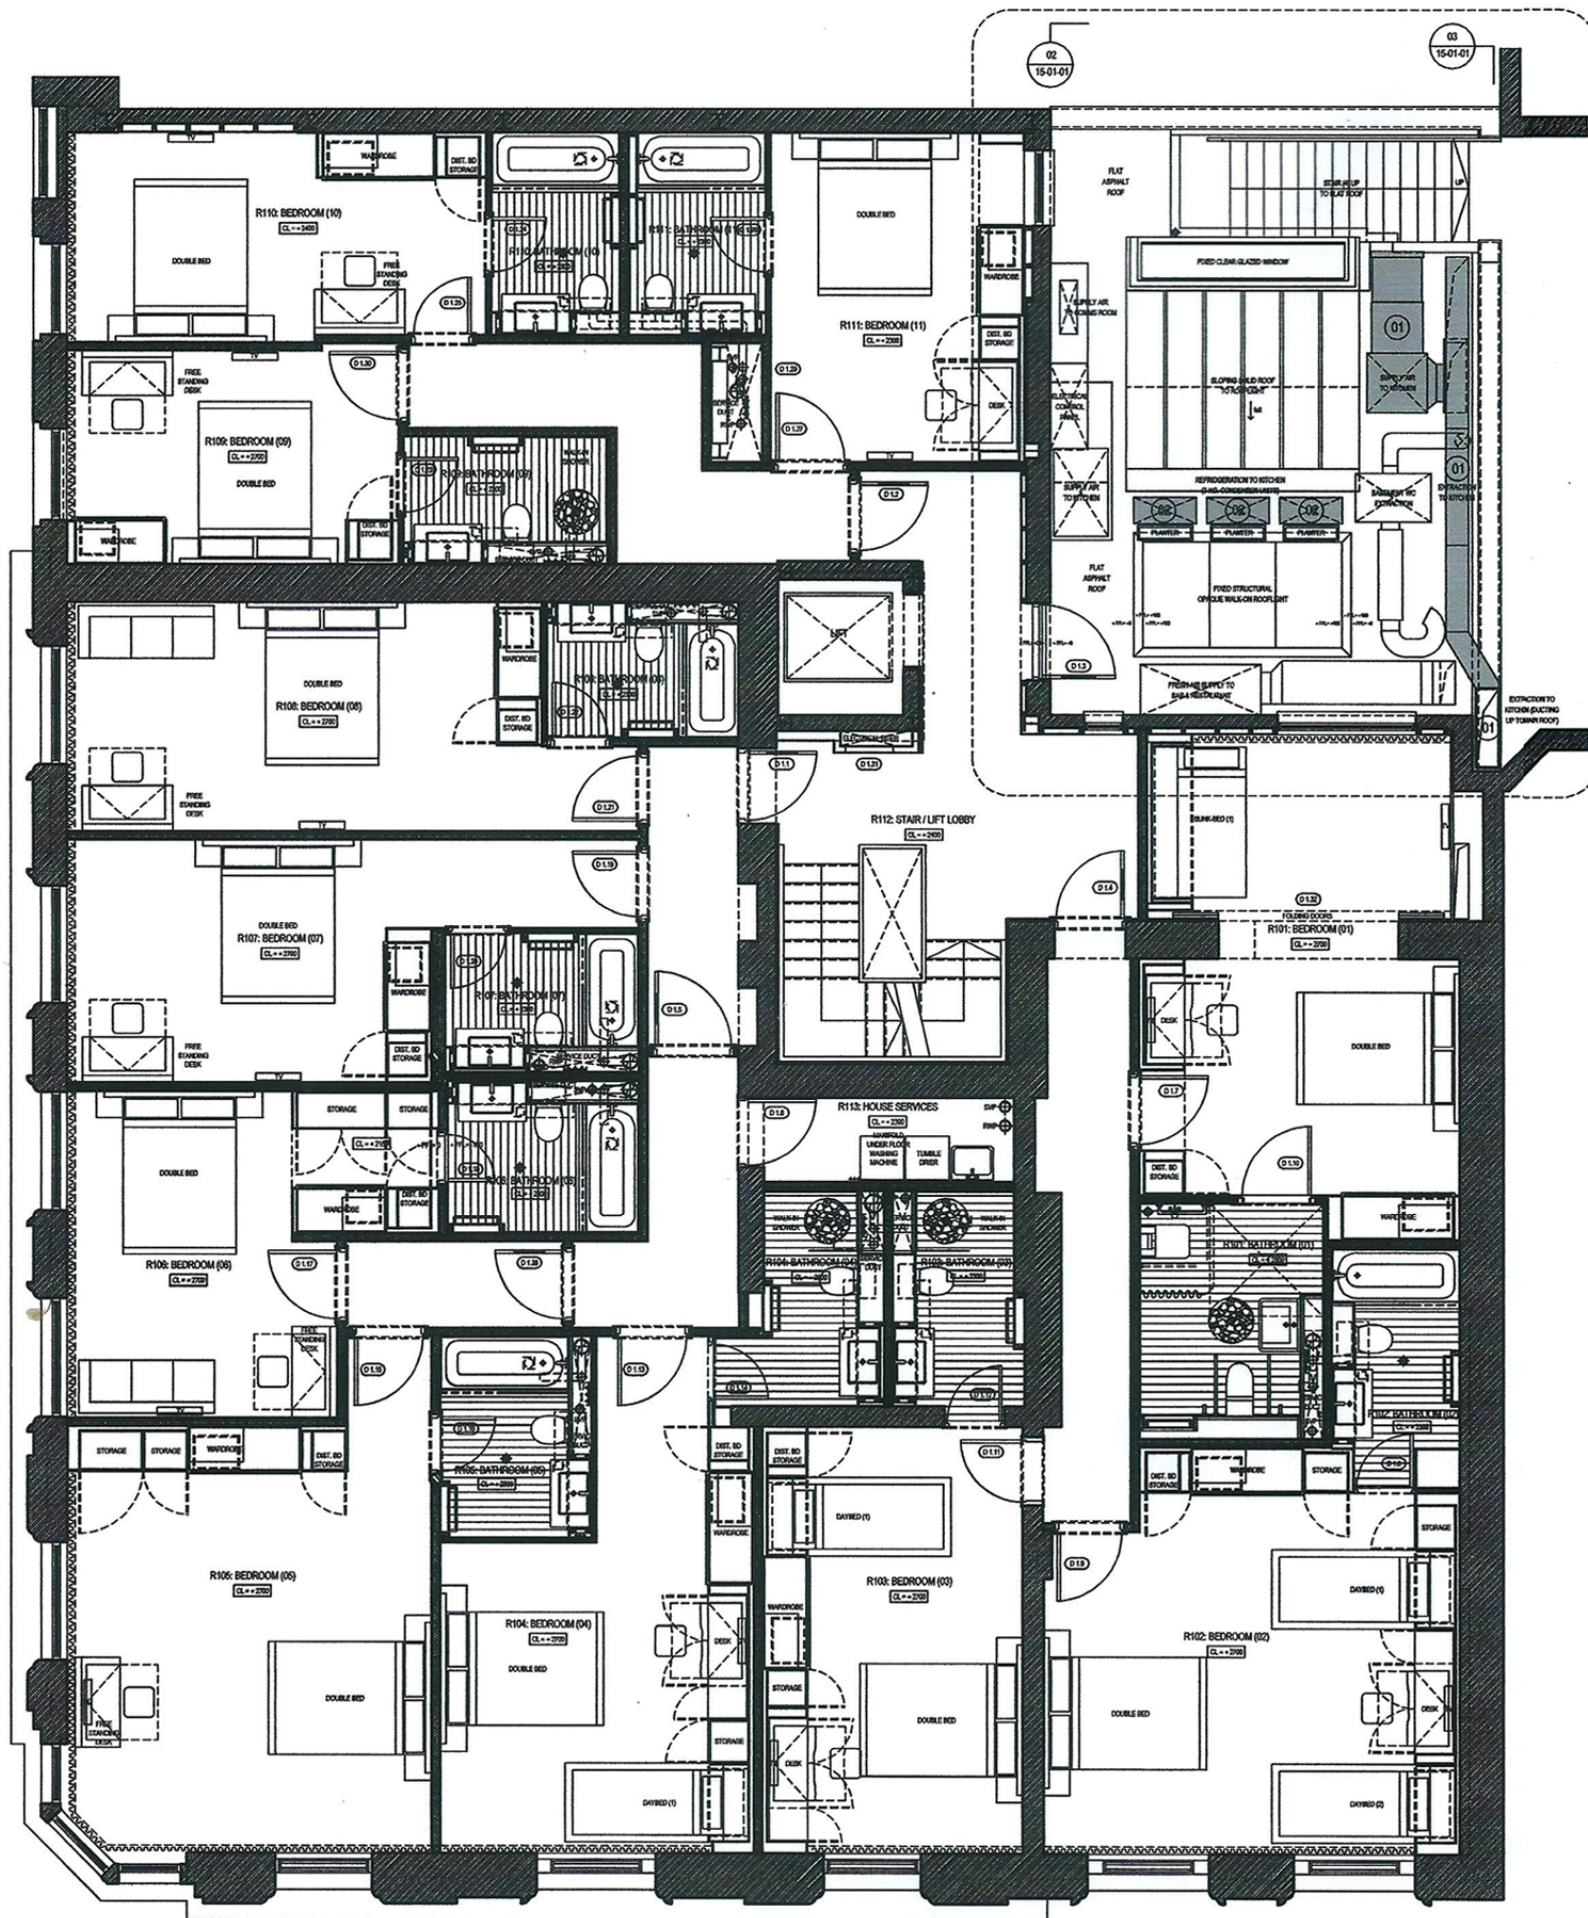


01 FIRST FLOOR: GENERAL ARRANGEMENT PLAN 01 (SHOWING PLANT EQUIPMENT LOCATION TO FLAT ROOF)
Scale 1:50 (@A1 SIZE)

REFER TO DETAILED PLANT EQUIPMENT PLAN AND ELEVATIONS DRAWING 15-01-02

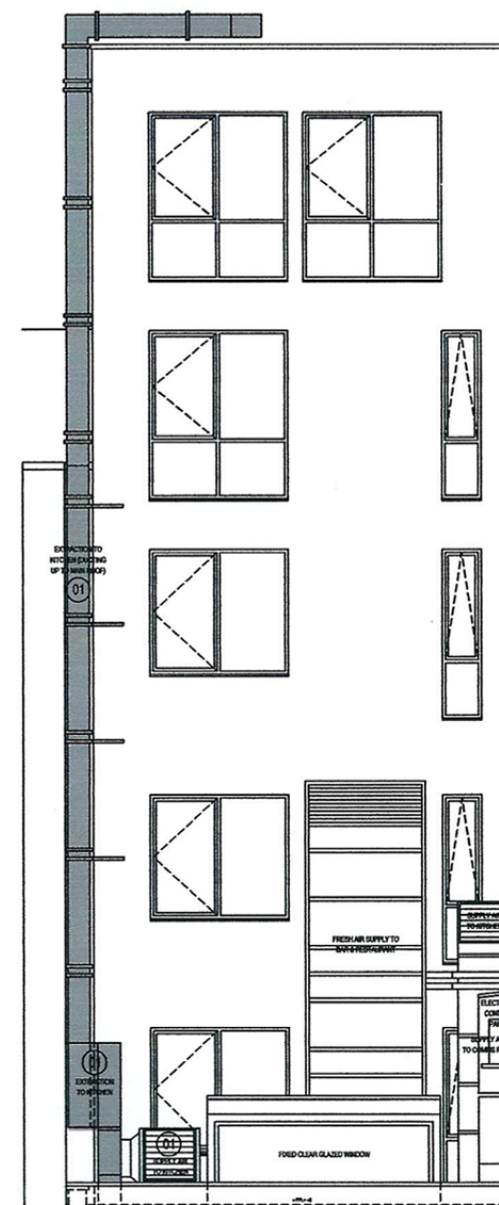


02 REAR ELEVATION 02 (15-01-02)
Scale 1:50 (@A1 SIZE)

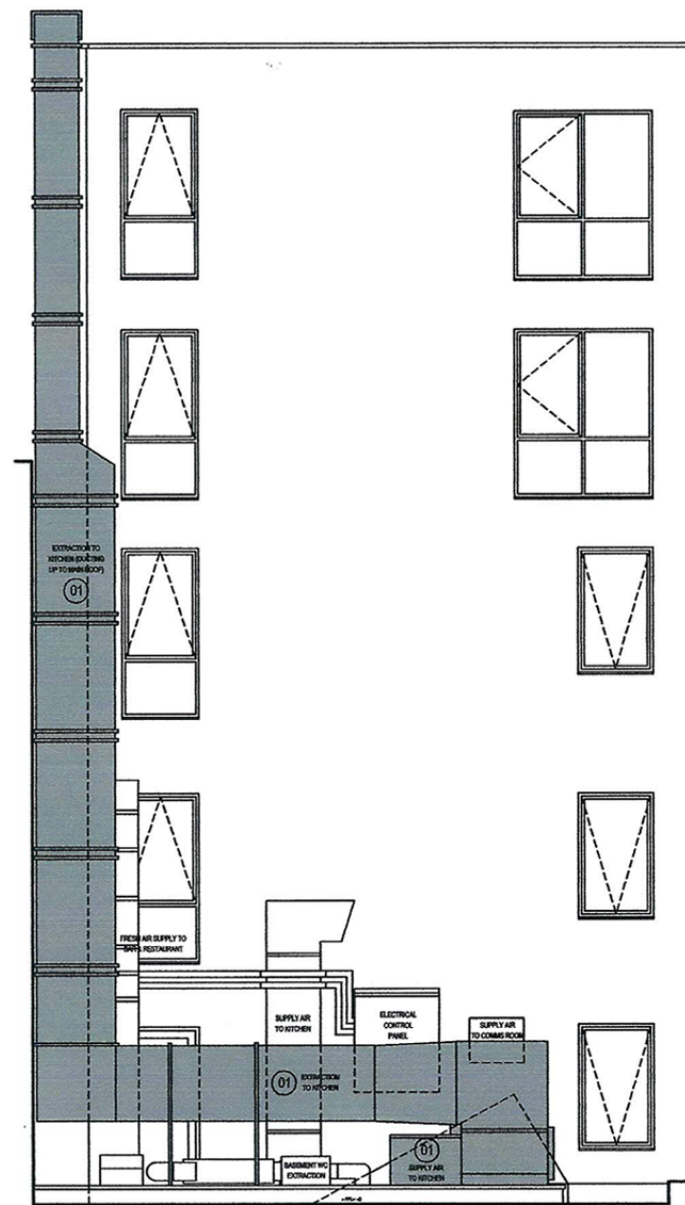

03 SIDE ELEVATION 03 (15-01-02)
Scale 1:50 (@A1 SIZE)

KEY:

 - DENOTES PLANT EQUIPMENT FORMING APPLICATION:
- 01 KITCHEN SUPPLY AIR & EXTRACTION PLANT AND DUCTING
- 02 3 NO. REFRIDGERATION CONDENSER UNITS TO KITCHEN



03.12.12 ISSUE FOR PLANNING
rev date reason by

seary architects

Unit 6, Masons Yard
177 Westbourne Street
Hove
East Sussex BN3 5FB
t: +44 (0) 1273 201 830
e: steve@searyarchitects.co.uk
w: www.searyarchitects.co.uk

project: Megaro Hotel
client: Mr A Megaro
drawn: First Floor: GA Plan 01, Rear Elevation 02 and Side Elevation 03
date: 15-01-01
scale: 1:50 (@A1 SIZE)
project no: 0612
rev: 03.12.12
status: PLANNING