

 Square profile modular lighting system.


 Square profile modular lighting system fixed to soffit.

 Globe pendant light fitting

 Fluorescent downlighter.

 Wall/Ceiling mounted light fitting

 Area with dropped plasterboard ceiling concealing services and providing 60 minute fire separation from ground floor

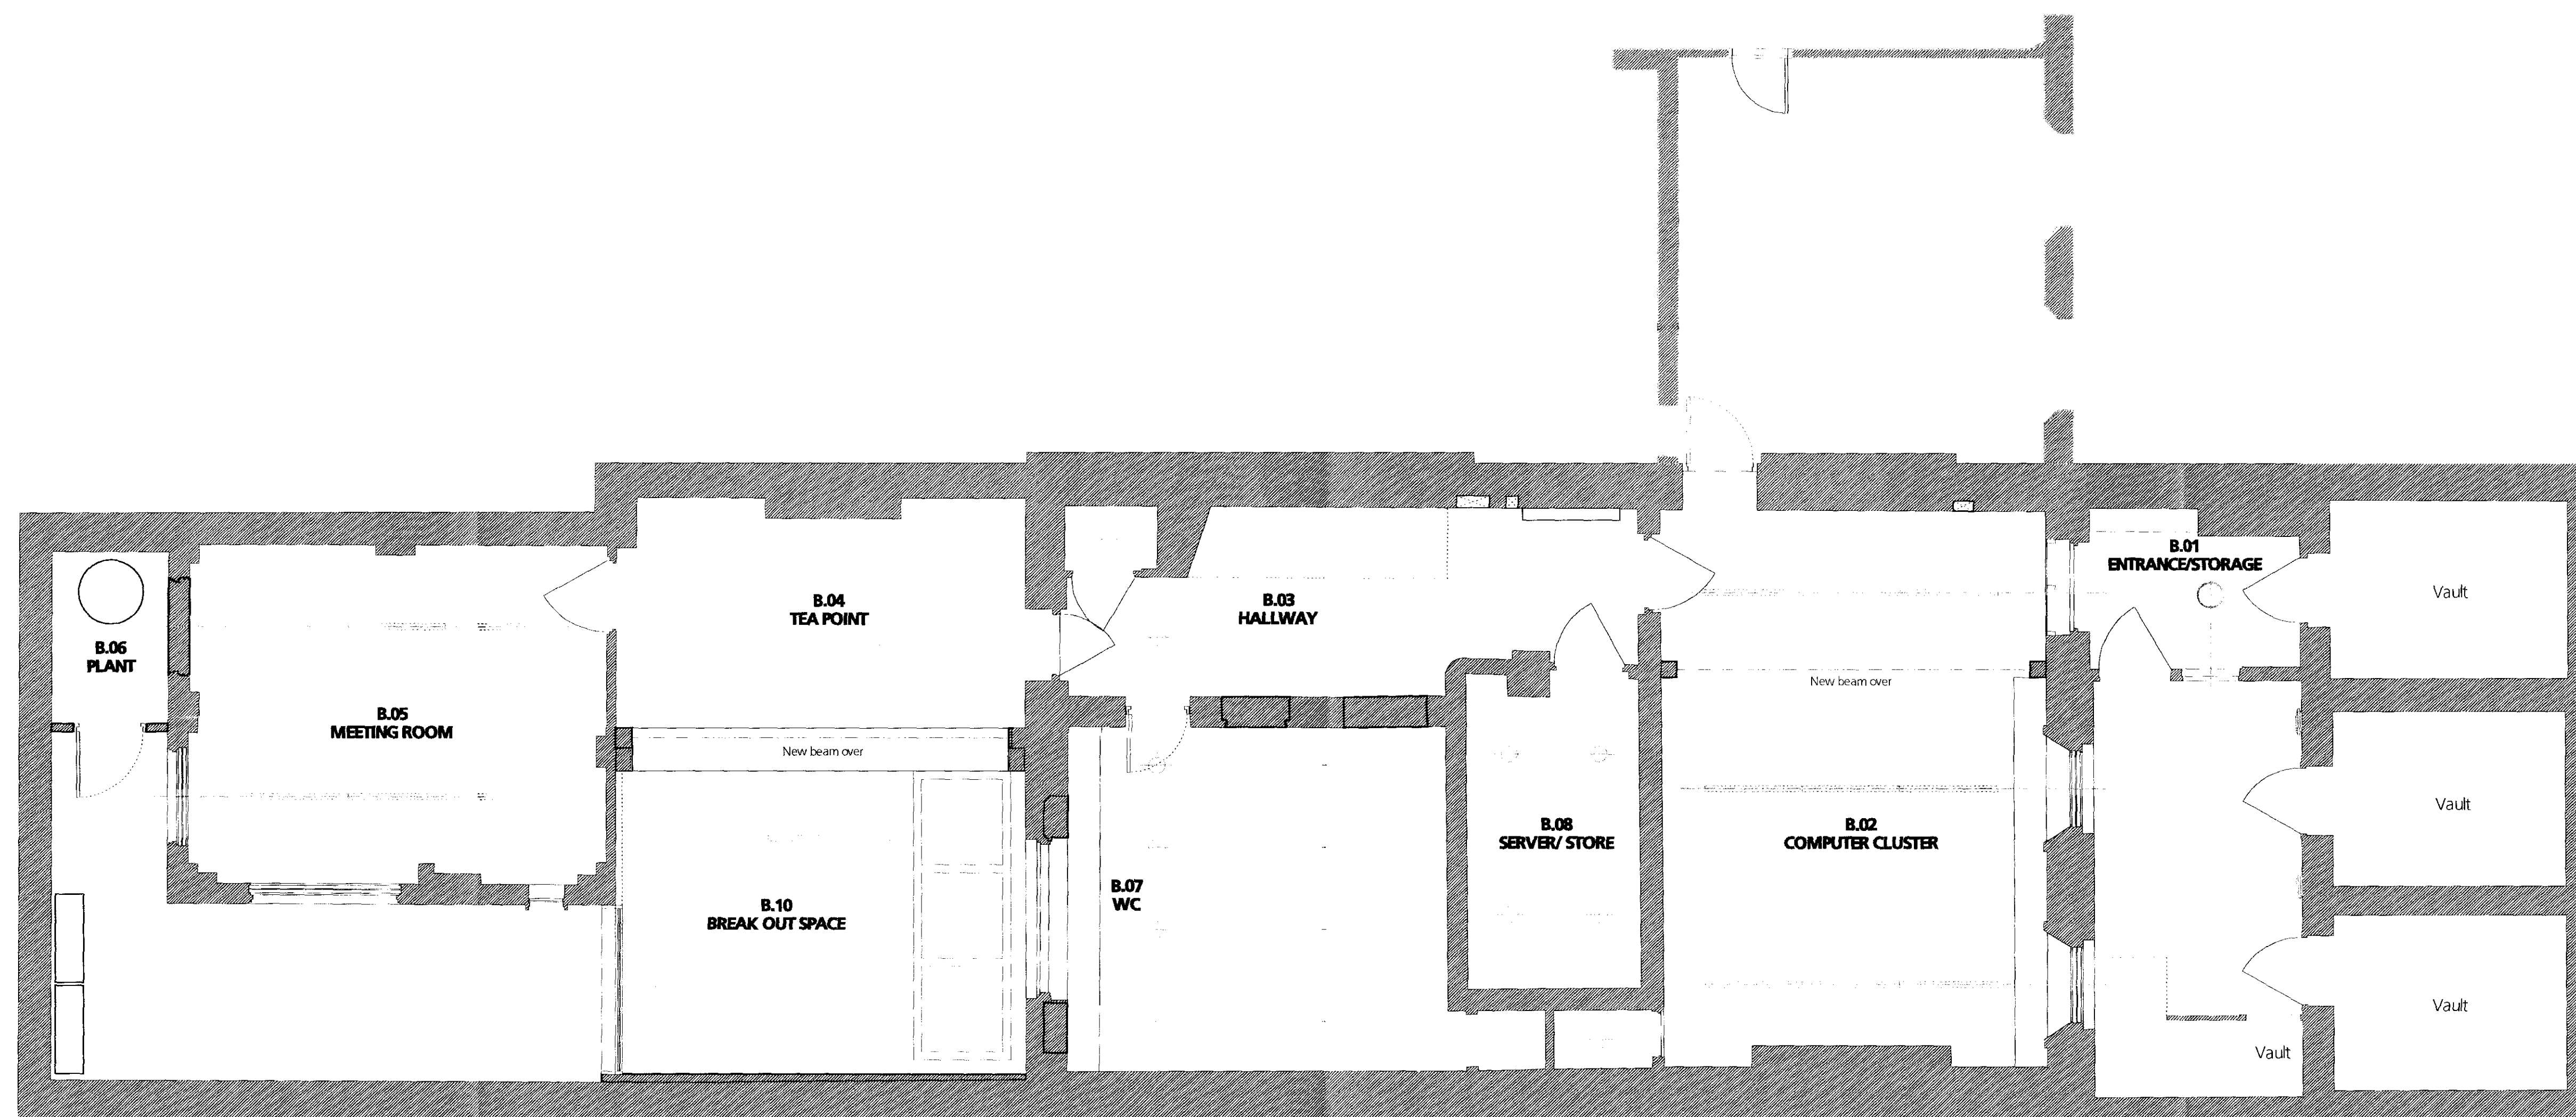

1 Lower Ground Floor Reflected Ceiling Plan
1:100 @ A3 & 1:50 @ A1

Revision	Date	Amendment	Notes
-	-	-	-

Client: University College London
 Project: 31 Tavistock Square, London, WC1H 9EZ
 Drawing: Proposed Lower Ground Floor Reflected Ceiling Plan

Scale: 1:50@A1 1:100@A3
 Date: March 2012

Status: PLANNING
 Drawn: AL

Project N°: 479
 Drawing N°: 479/PL/140

burwell deakins : architects

t 020 8305 6010
 f 020 8305 6020
 e info@burwelldeakins.com
 w www.burwelldeakins.com
 a unit 001 california building deals gateway london SE13 7TF

NOTES: THIS DRAWING IS THE PROPERTY OF BURWELL DEAKINS ARCHITECTS. IT IS TO BE USED FOR THE PROJECT AND SITE SPECIFICALLY IDENTIFIED. ANY REUSE OR MODIFICATION OF THIS DRAWING WITHOUT THE WRITTEN CONSENT OF BURWELL DEAKINS ARCHITECTS IS STRICTLY FORBIDDEN. THE DRAWING IS THE PROPERTY OF BURWELL DEAKINS ARCHITECTS. IT IS TO BE USED FOR THE PROJECT AND SITE SPECIFICALLY IDENTIFIED. ANY REUSE OR MODIFICATION OF THIS DRAWING WITHOUT THE WRITTEN CONSENT OF BURWELL DEAKINS ARCHITECTS IS STRICTLY FORBIDDEN.