

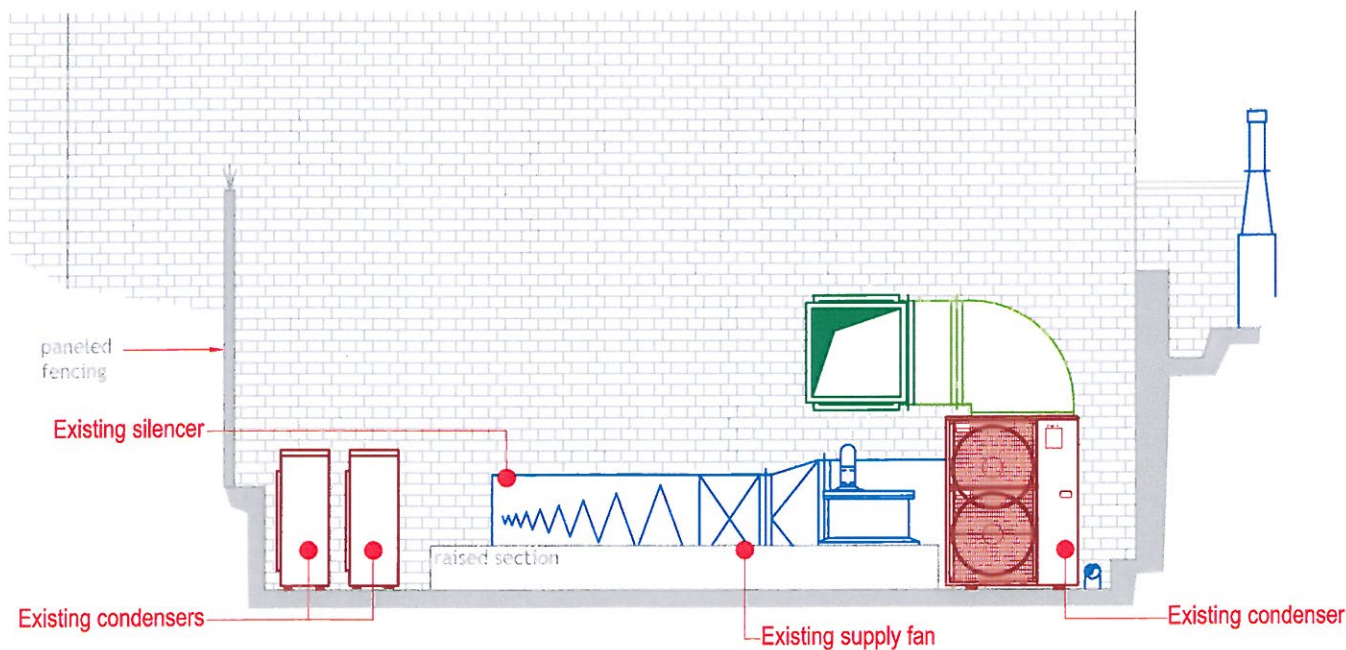


External Plant Area

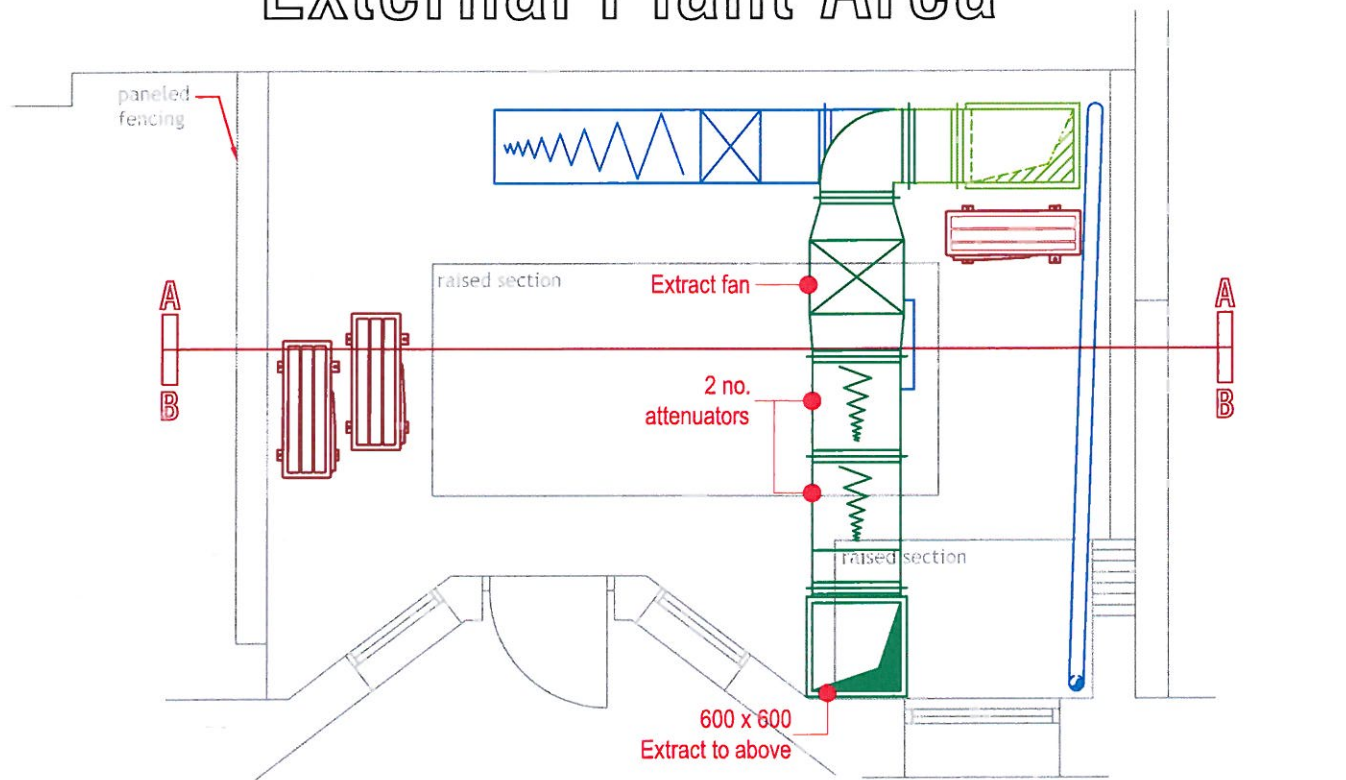

Section A - A

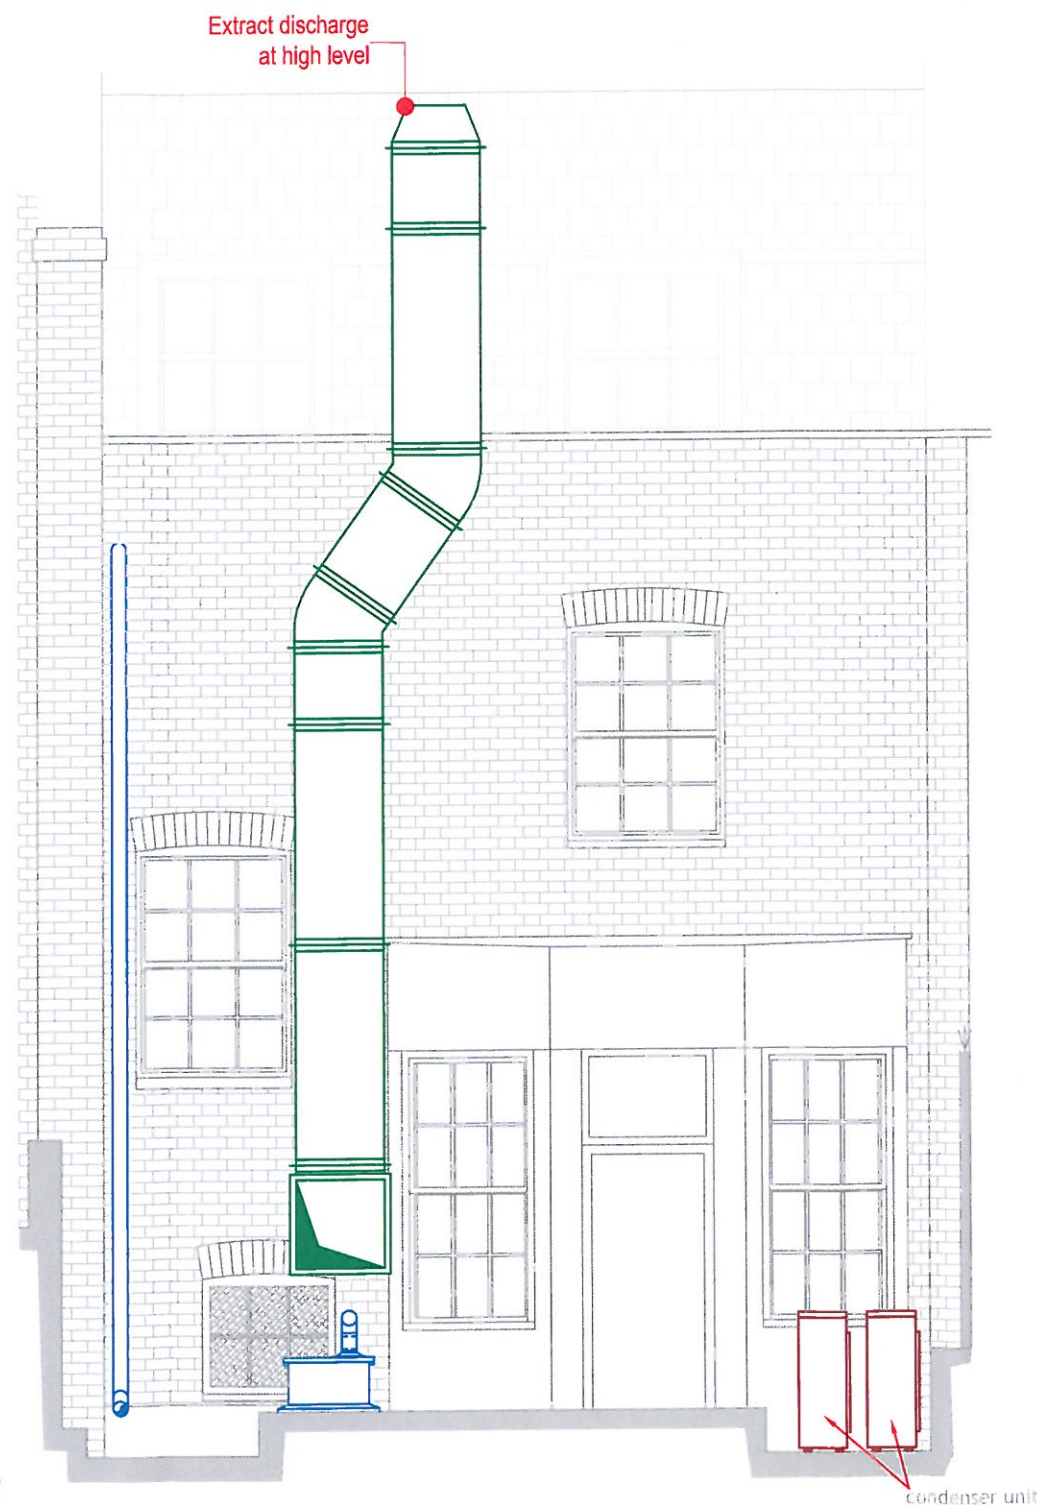

Section B - B

Existing Extract

New Extract

B 20-11-12 RL Full height shown for section B-B.
A 01-11-12 RL Attenuators added.

No.	Date	Rev. By	Revision Description
-----	------	---------	----------------------

Client:

Benito's Hat

Project :

Benito's Hat
Goodge Street

Drawing Title :

Ventilation Layout
Option 2

Drawing No.:	Rev:
001-020-02	B

Scale: 1:50 @ A3

Drawn By: RL	Date: 21-08-12
--------------	----------------

chapman
ventilation

Unit 2 Little Mundells
Welwyn Garden City
Hertfordshire AL7 1EW
Tel: 01707 372858 Fax: 01707 325001
E-mail: info@chapmanventilation.co.uk
Web: www.chapmanventilation.co.uk

Copyright of this drawing resides with Chapman Ventilation Limited ©