


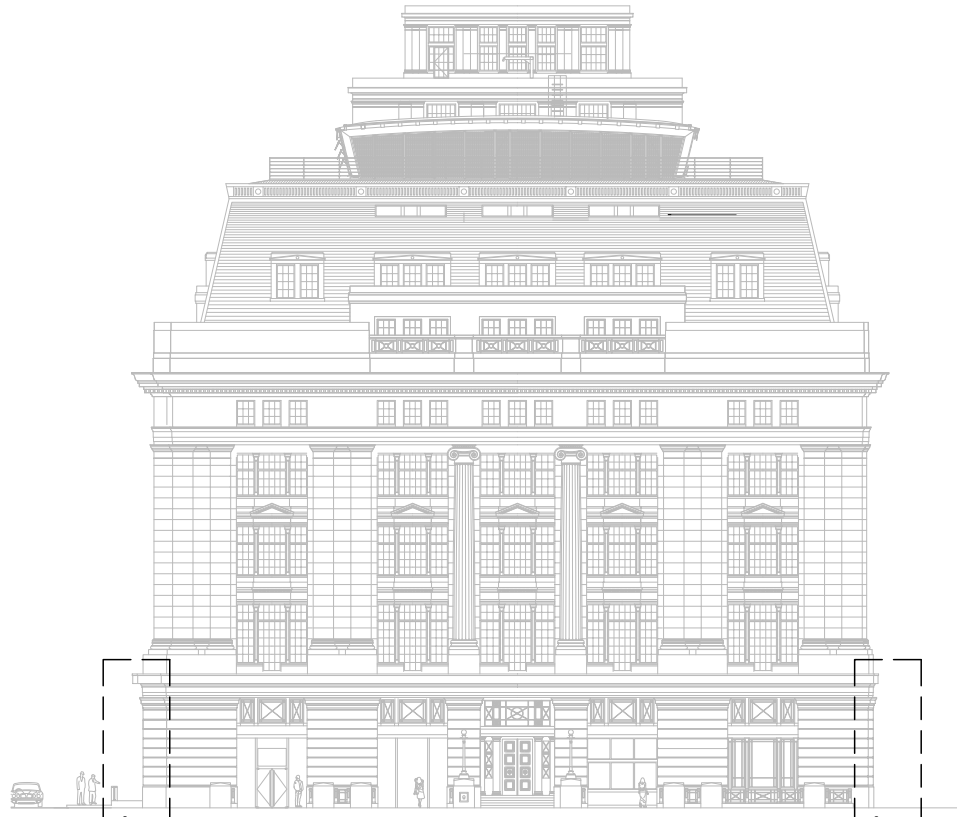


Refer to South East inset
for enlargement

East Elevation (Scale 1:100)


100mm 200mm
1:100 Scale Bar

Refer to North East inset
for enlargement

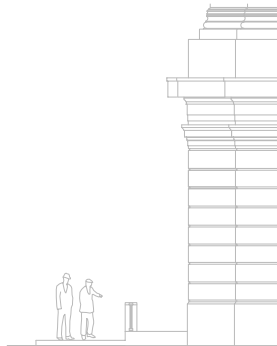

South East Elevation (Scale 1:50)

100mm 200mm
1:50 Scale Bar

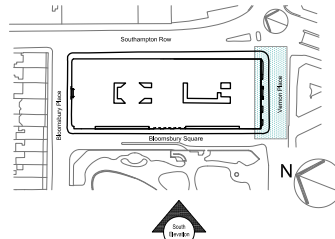

Location Plan (scale 1:1250)



North East Elevation (Scale 1:50)

100mm 200mm
1:50 Scale Bar


This Drawing References:			
Type:	130, 132		
Architect (Amap)	0770/01424 Rev C4	Issued	13-11-02
Architect (Amap)	0770/01423 Rev C4	Issued	24-09-02
Architect (Amap)	0770/01423 Rev C5	Issued	13-11-02
Architect (Amap)	0770/01421 Rev C5	Issued	24-09-02
Architect (Amap)	0770/01425 Rev B1C	Issued	13-09-12
Architect (Amap)	0770/01426 Rev B1C	Issued	13-09-12

Rev	Description	Approved	No.	Date
01	Preliminary Issue	-	-	10-09-12


Global Fire & Security Ltd
19 Napier Road
Bromley, Kent, UK
BR2 9JA
TEL: +44 (0) 208 313 3336
FAX: +44 (0) 208 313 3339
E-mail: sales@globalfiresecurity.co.uk

Project Name:
Victoria House
Southampton Row
London WC1B 4BA
Drawing Title:
Existing Building
East Elevation

Drawn by: GFS (FMC) Scale: as indicated @A0
Checked by: GFS (AG) Version: Planning
Approved by: - Date: August 2012
Print name: -
Drawing No. -

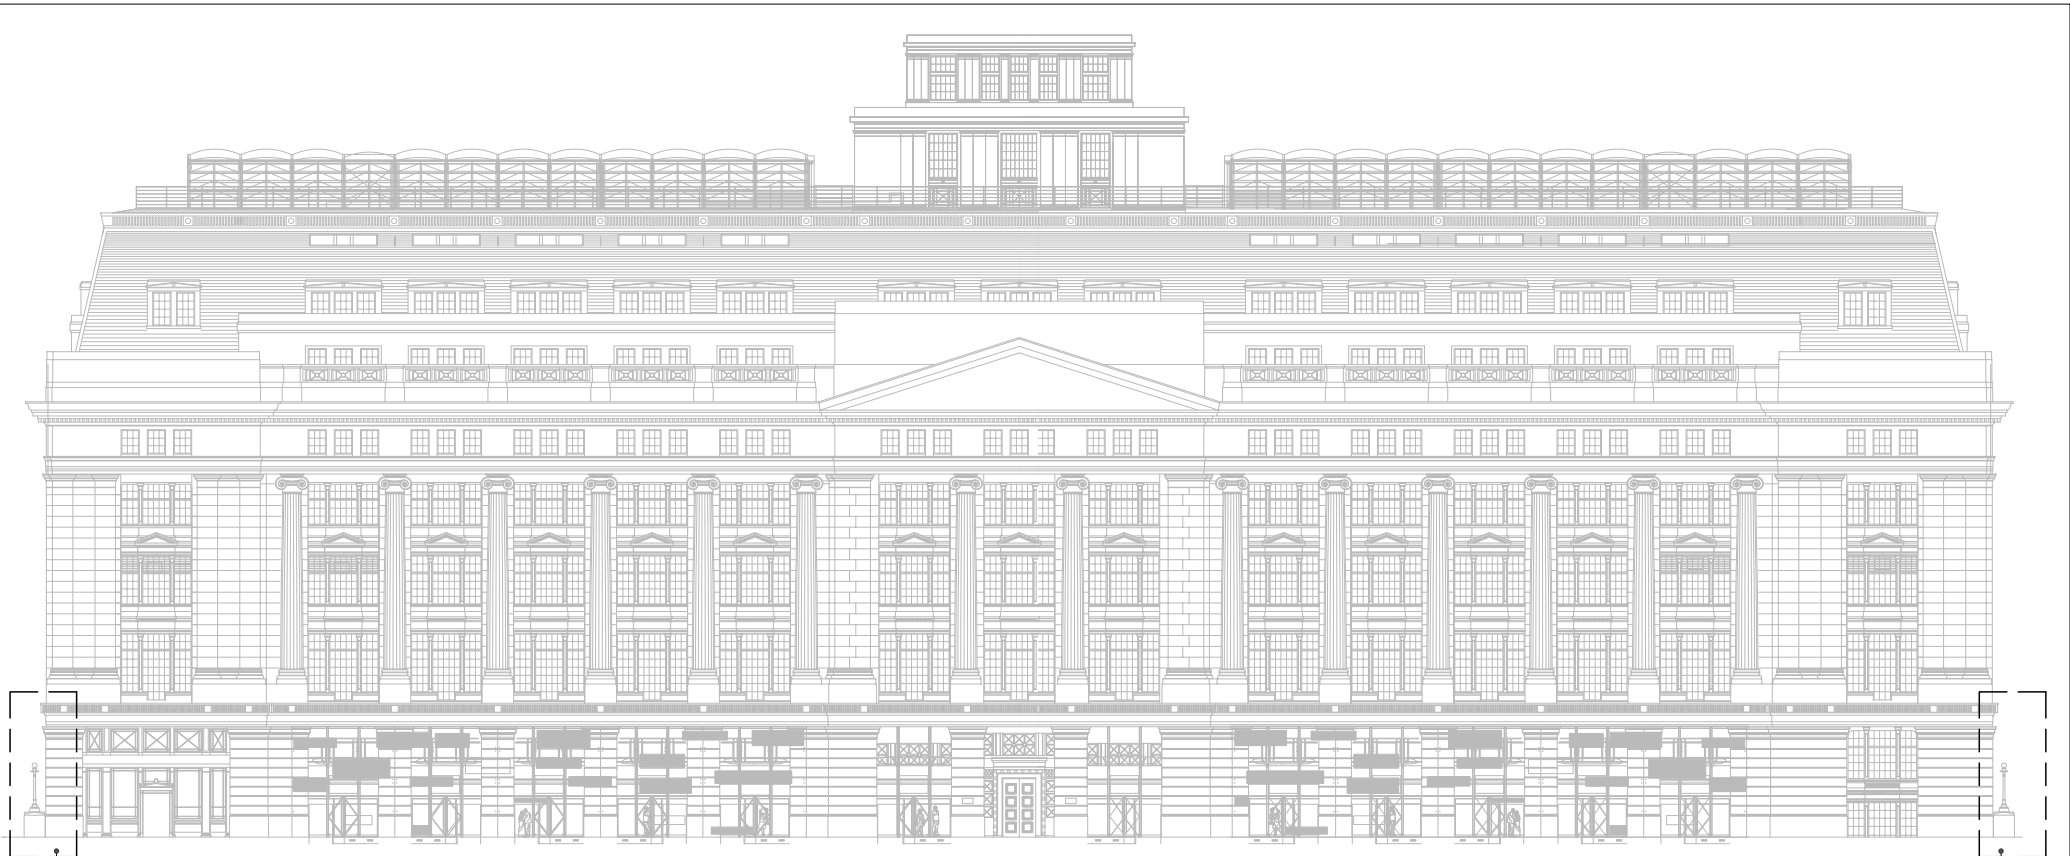


Refer to North East Inset
for enlargement


North Elevation (Scale 1:100)




Refer to North West Inset
for enlargement

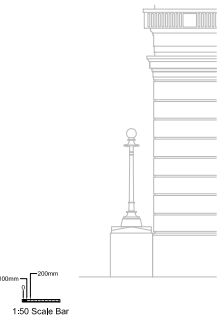

North East Elevation (Scale 1:50)


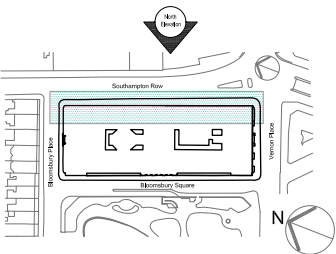


Location Plan (scale 1:1250)

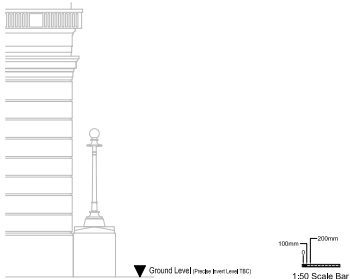

North West Elevation (Scale 1:50)

Rev	Description	Approval	No.	Date	This Drawing References:		This Drawing References:		Numerical/Circuit Conventions			Global Fire & Security Ltd 19 Napier Road Bromley, Kent, UK BR2 9JA TEL: +44 (0) 208 313 3336 FAX: +44 (0) 208 313 3339 Web: www.globalfiresecurity.com Email: sales@globalfiresecurity.com	Project Title: Victoria House Southampton Row London WC1B 4BA Drawing Title: Existing Building North Elevation	Drawn by: GFS (FMC) Checked by: GFS (AG) Approved by: - Drawing No. -	Scale: as indicated @A0 Version: Planning Date: September 2012
01	Preliminary Issue	-	-	10-09-12	Type:	Dwg. No:	Type:	Dwg. No:	EATF001	Connectivity					
					Architect	077001424 Rev C4 Issued 13-11-02	Architect	077001421 Rev C5 Issued 24-09-02	EATF002	Connectivity					
					Architect	077001423 Rev C4 Issued 24-09-02	Architect	077001422 Rev C3 Issued 13-11-02	EATF003	Connectivity					

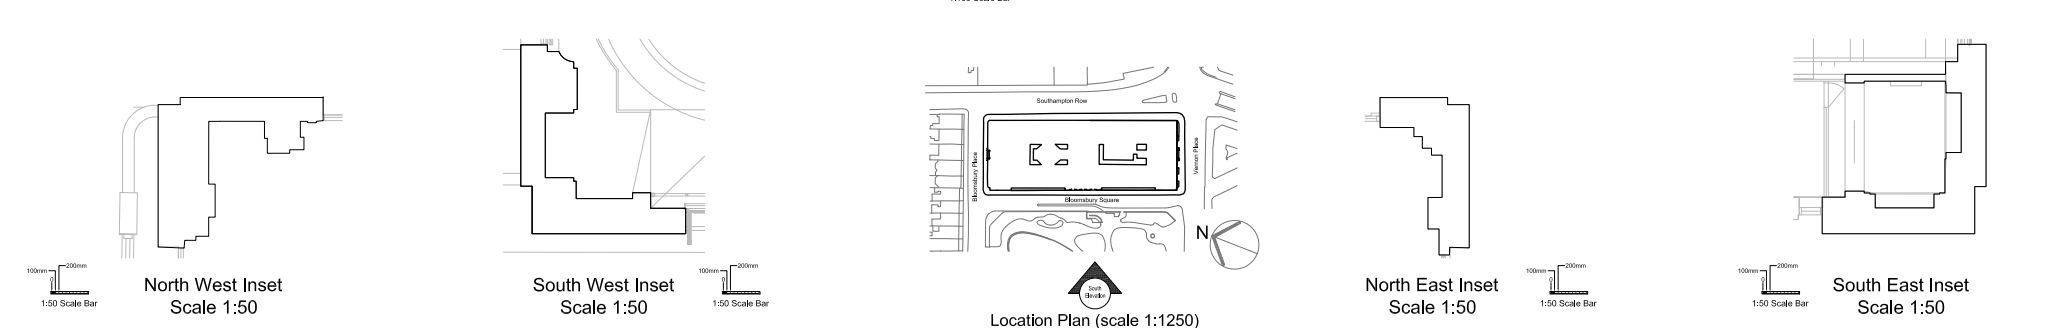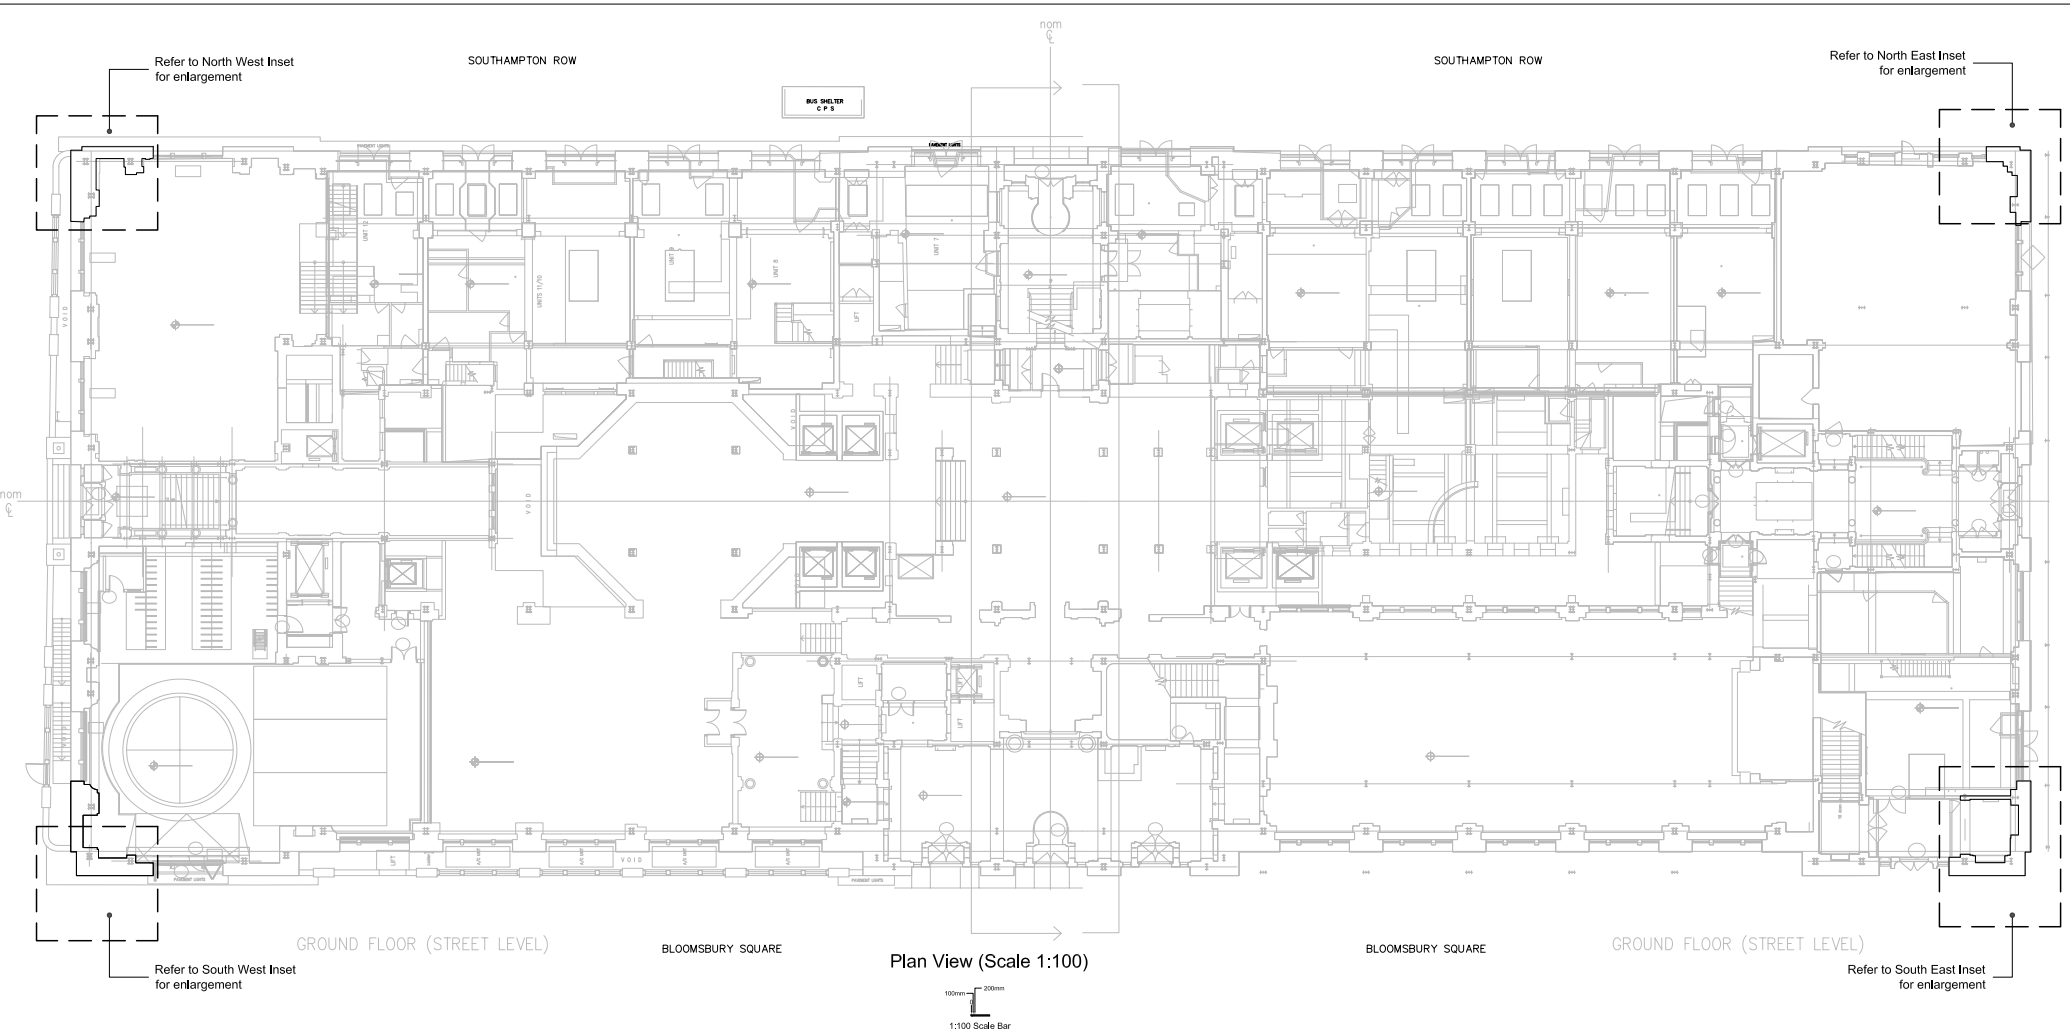

Rev	Description	Approved	No.	Date
01	Preliminary Issue	-	-	13-09-12


This Drawing References:				This Drawing References:			
Type:	Orig. No.	Type:	Orig. No.	Type:	Orig. No.	Type:	Orig. No.
Architect	0770/01/423 Rev C4	Architect	0770/01/423 Rev C5	Architect	0770/01/423 Rev C4	Architect	0770/01/423 Rev C5
(A/Map)	Issued 13-11-02	(A/Map)	Issued 24-08-12	(A/Map)	Issued 24-08-12	(A/Map)	Issued 12-09-12
Architect	0770/01/423 Rev C4	Architect	0770/01/170 Rev 1b	Architect	0770/01/423 Rev C5	Architect	0770/01/171 Rev 1b
(A/Map)	Issued 24-08-12	(A/Map)	Issued 12-09-12	(A/Map)	Issued 13-11-02	(A/Map)	Issued 12-09-12

NOTES:

Global Fire & Security Ltd
15 Napier Road
Bromley, Kent, UK
BR2 9DA
TEL: +44 (0) 208 313 3336
FAX: +44 (0) 208 313 3339
Web: www.globalfiresecurity.com
E-mail: sales@globalfiregroup.co.uk

Project No: Victoria House
Southampton Row
London WC1B 4BA
Drawing No: Existing Building
Plan View


Drawn by:	GFS (PMC)	Scale:	as indicated @A0
Checked by:	GFS (AG)	Version:	Planning
Approved by:	-	Date:	September 2012
Printed by:	-	Drawn by:	-

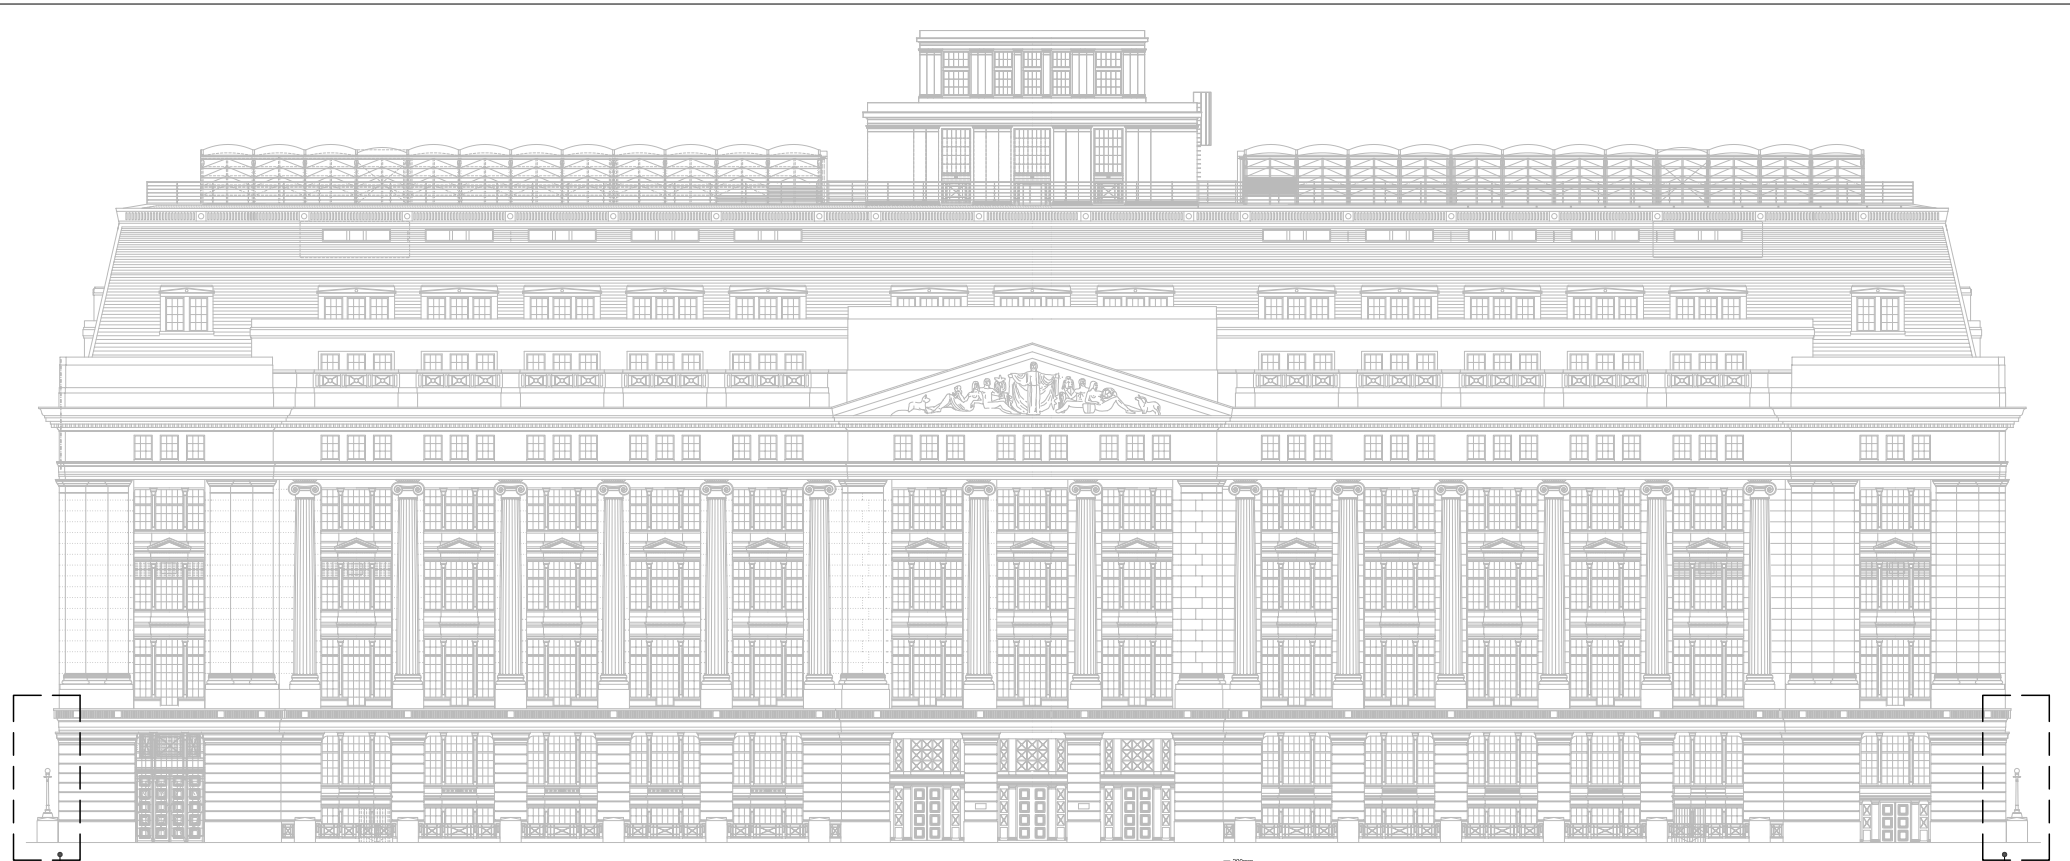


South Elevation (Scale 1:100)




Refer to South East inset
for enlargement

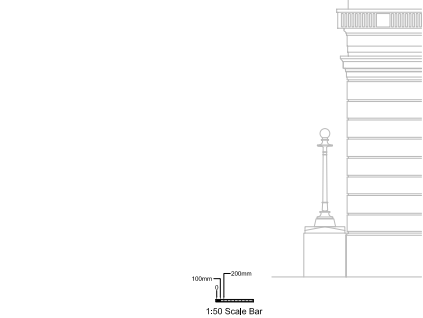

South West Elevation (Scale 1:50)

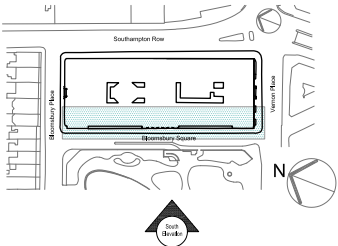

Location Plan (scale 1:1250)


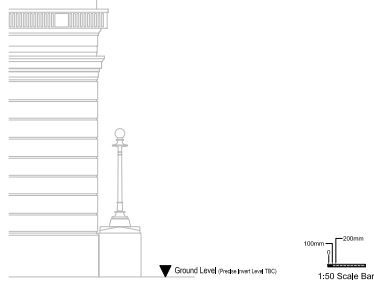


South East Elevation (Scale 1:50)

Rev	Description	Approved	No.	Date
01	Preliminary Issue	-	-	10-09-12

This Drawing References				This Drawing References			
Type:				Type:			
Architect	0770/01/424 Rev C4			Architect	0770/01/421 Rev C5		
(A&S)	Issued 13-1-10			(A&S)	Issued 24-09-02		
Architect	0770/01/423 Rev C4						
(A&S)	Issued 24-09-02						
Architect	0770/01/422 Rev C3						
(A&S)	Issued 13-1-10						


		Global Fire & Security Ltd 19 Napier Road Bromley, Kent, UK BR2 9JA TEL: +44 (0) 208 313 3336 FAX: +44 (0) 208 313 3339	Project Title: Victoria House Southampton Row London WC1B 4BA Drawing Title: Existing Building South Elevation	Drawn by: GFS (PNC)	Scale: as indicated @A0
				Checked by: GFS (AG)	Version: Planning
				Approved by: -	Date: September 2012
				Print name: -	
				Drawing No.:	

  


Rev	Description	Approved	No.	Date
01	Preliminary Issue	-	-	29-08-12



Drawing Title: Existing Building West Elevation	
Drawn by: GFS (FMC)	Scale: as indicated @A0
Checked by: GFS (AG)	Version: Planning
Approved by: - Print name: -	Date: August 2012
Drawing No. "	

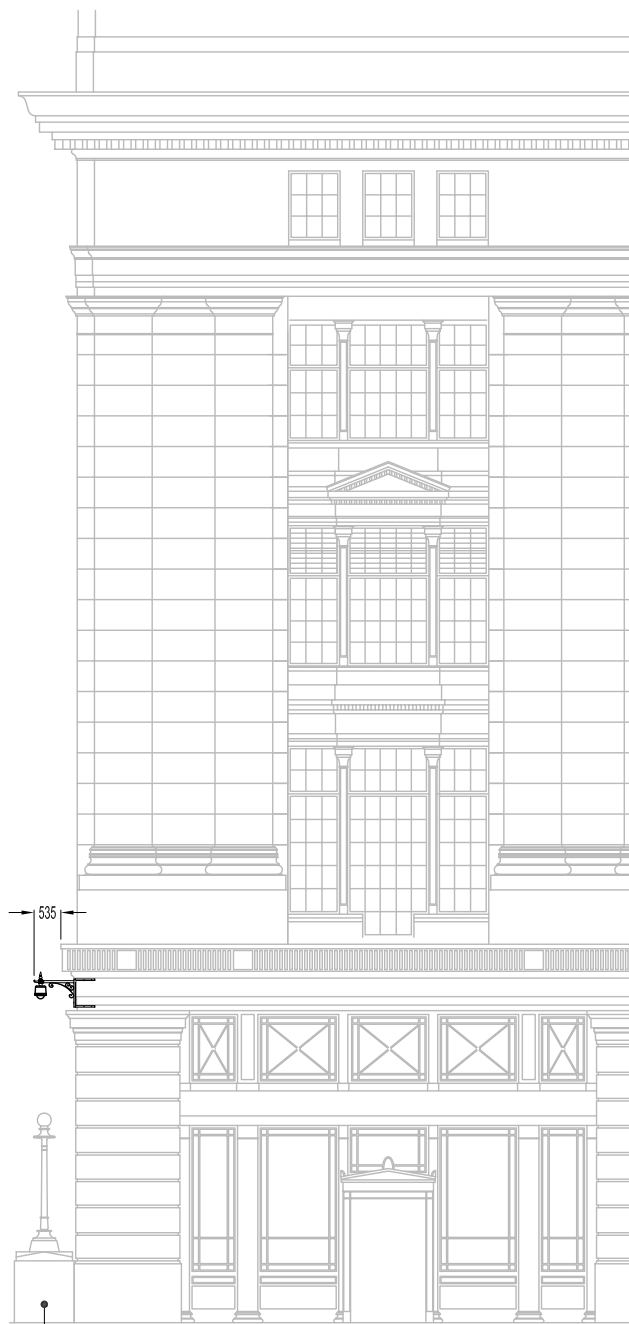

North East Elevation (Scale 1:50)

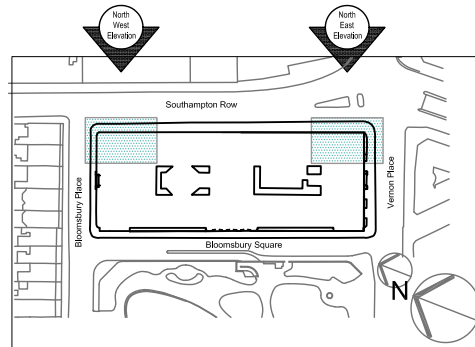

Location Plan (scale 1:1250)



North West Elevation (Scale 1:50)

- NOTES:
1. All Dimensions given in mm
 2. This drawing is for planning only, not for construction
 3. This drawing is copyright and may not be altered, traced, copied, photographed or used for any purpose other than that for which it is issued without written permission from Global Fire & Security Ltd

This Drawing References:	
Type:	Org. No:
Architect (Alsop)	0770/01/424 Rev C4 Issued 13-11-02
Architect (Alsop)	0770/01/423 Rev C4 Issued 24-09-02
Architect (Alsop)	0770/01/422 Rev C5 issued 13-11-02
Architect (Alsop)	0770/01/421 Rev C5 Issued 24-09-02

Numbering/Circuit Convention:	
ExtF001	Camera No. Floor External
ExtM001	Camera No. Movable External
SP2-1-1	Security From Power Supply Power Supply No. 1/1/1 Security Power Supply

Rev	Description	Approved	No.	Date
01	Preliminary Issue	-	-	10-02-12
02	Issued for Client Approval	-	-	13-02-12
03	Comments Incorporated & re-issued for approval	-	-	23-07-12
04	Comments Incorporated & re-issued for approval	-	-	19-09-12


Global Fire & Security Ltd
19 Napier Road
Bromley, Kent, UK
BR2 9JA
TEL: +44 (0) 208 313 3336
FAX: +44 (0) 208 313 3339
© Copyright 2007
Web: www.globalfiresecurity.com
E-mail: sales@gfs-group.co.uk

Project Title: Victoria House Southampton Row London WC1B 4BA	
Drawing Title: Exterior CCTV Layout Ground Floor (Proposed Services) Sheet 1 of 7	
Drawn by: GFS (FMC)	Scale: as indicated @A1
Checked by: GFS (AG)	Version: Planning
Approved by: -	Date: February 2012
Print name: -	Drawing No: GFS-VICH-LEVEL 00-001 Rev 04