 


Note
ALL DIMENSIONS TO BE VERIFIED ON SITE BEFORE SETTING OUT OR MAKING ANY SHOP DRAWINGS. THIS DRAWING IS TO BE READ IN CONJUNCTION WITH THE CONSULTANT ENGINEER'S SPECIFICATION.

Orientation

Rev./Date	REVISIONS
P 10.10.12	PRELIMINARY ISSUE
P1 25.10.12	PLANNING ISSUE



ME7

ME7 Ltd.
Unit 2, Rays Farm Barns, Roman Road
Ingatestone, Essex CM4 9EH
Email: jb@me7.eu
Web: www.me7.eu
Tel: +44(0)1277 353225
M&E Consultants Energy Consultants



Description
**ROOF PLAN
VENTILATION TERMINATION LAYOUT**




Project
**1 RADLETT PLACE
ST. JOHNS WOOD
LONDON
NW8**

Architect
SHH Architects
1 Vencourt Place
Ravenscourt Park
Hammersmith, London, W6 9NU
Tel : 0208 600 4171

xref 700(SK)024 (H) Second Floor
Scale A1 @ 1:100 Drawn SS / SBJ
Date October 2012 Checked

Issue
PRELIMINARY

Project No.	Services	Dwg No.	Rev.
507	M	6	P1

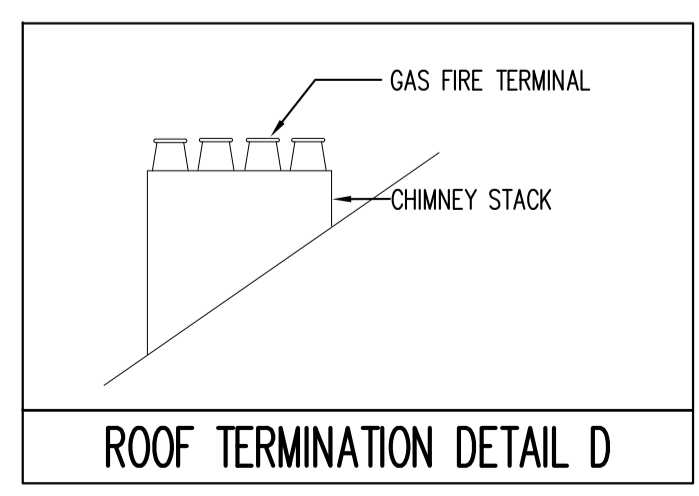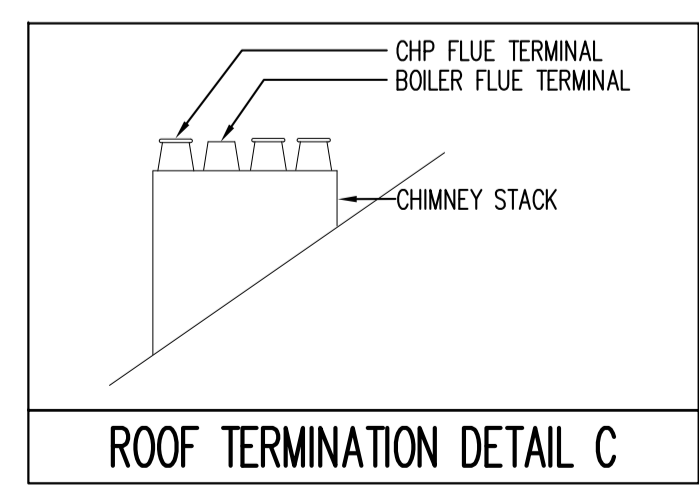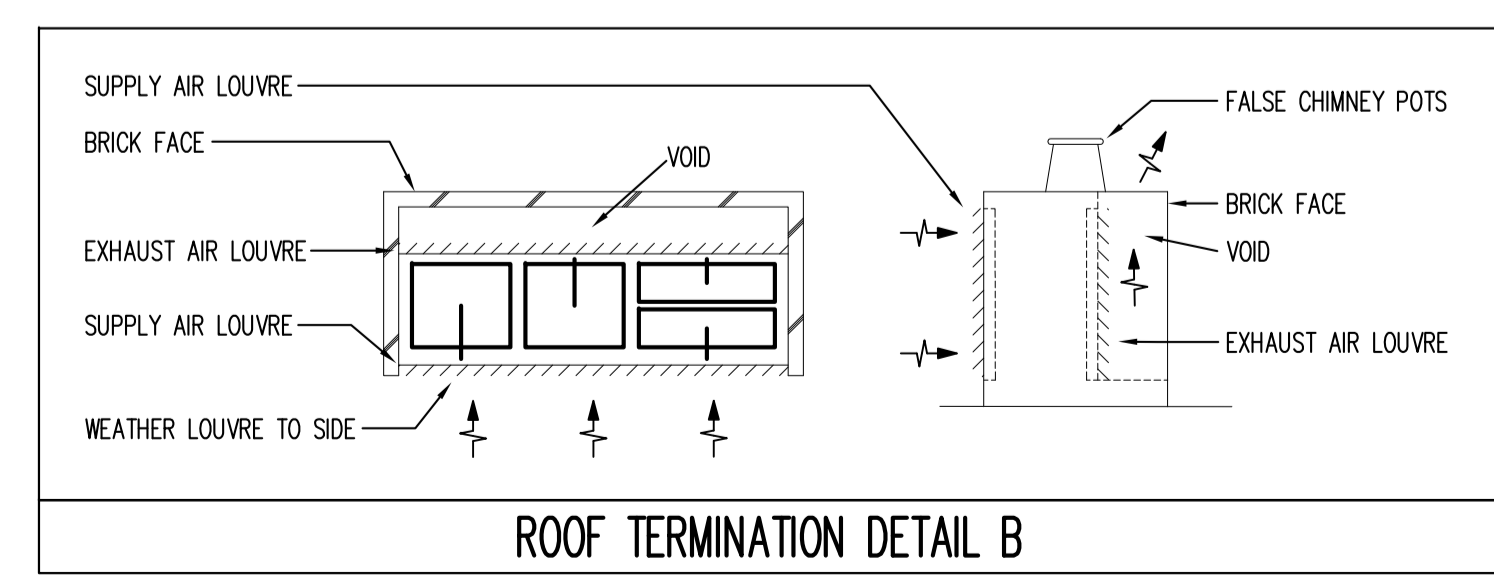

Second