


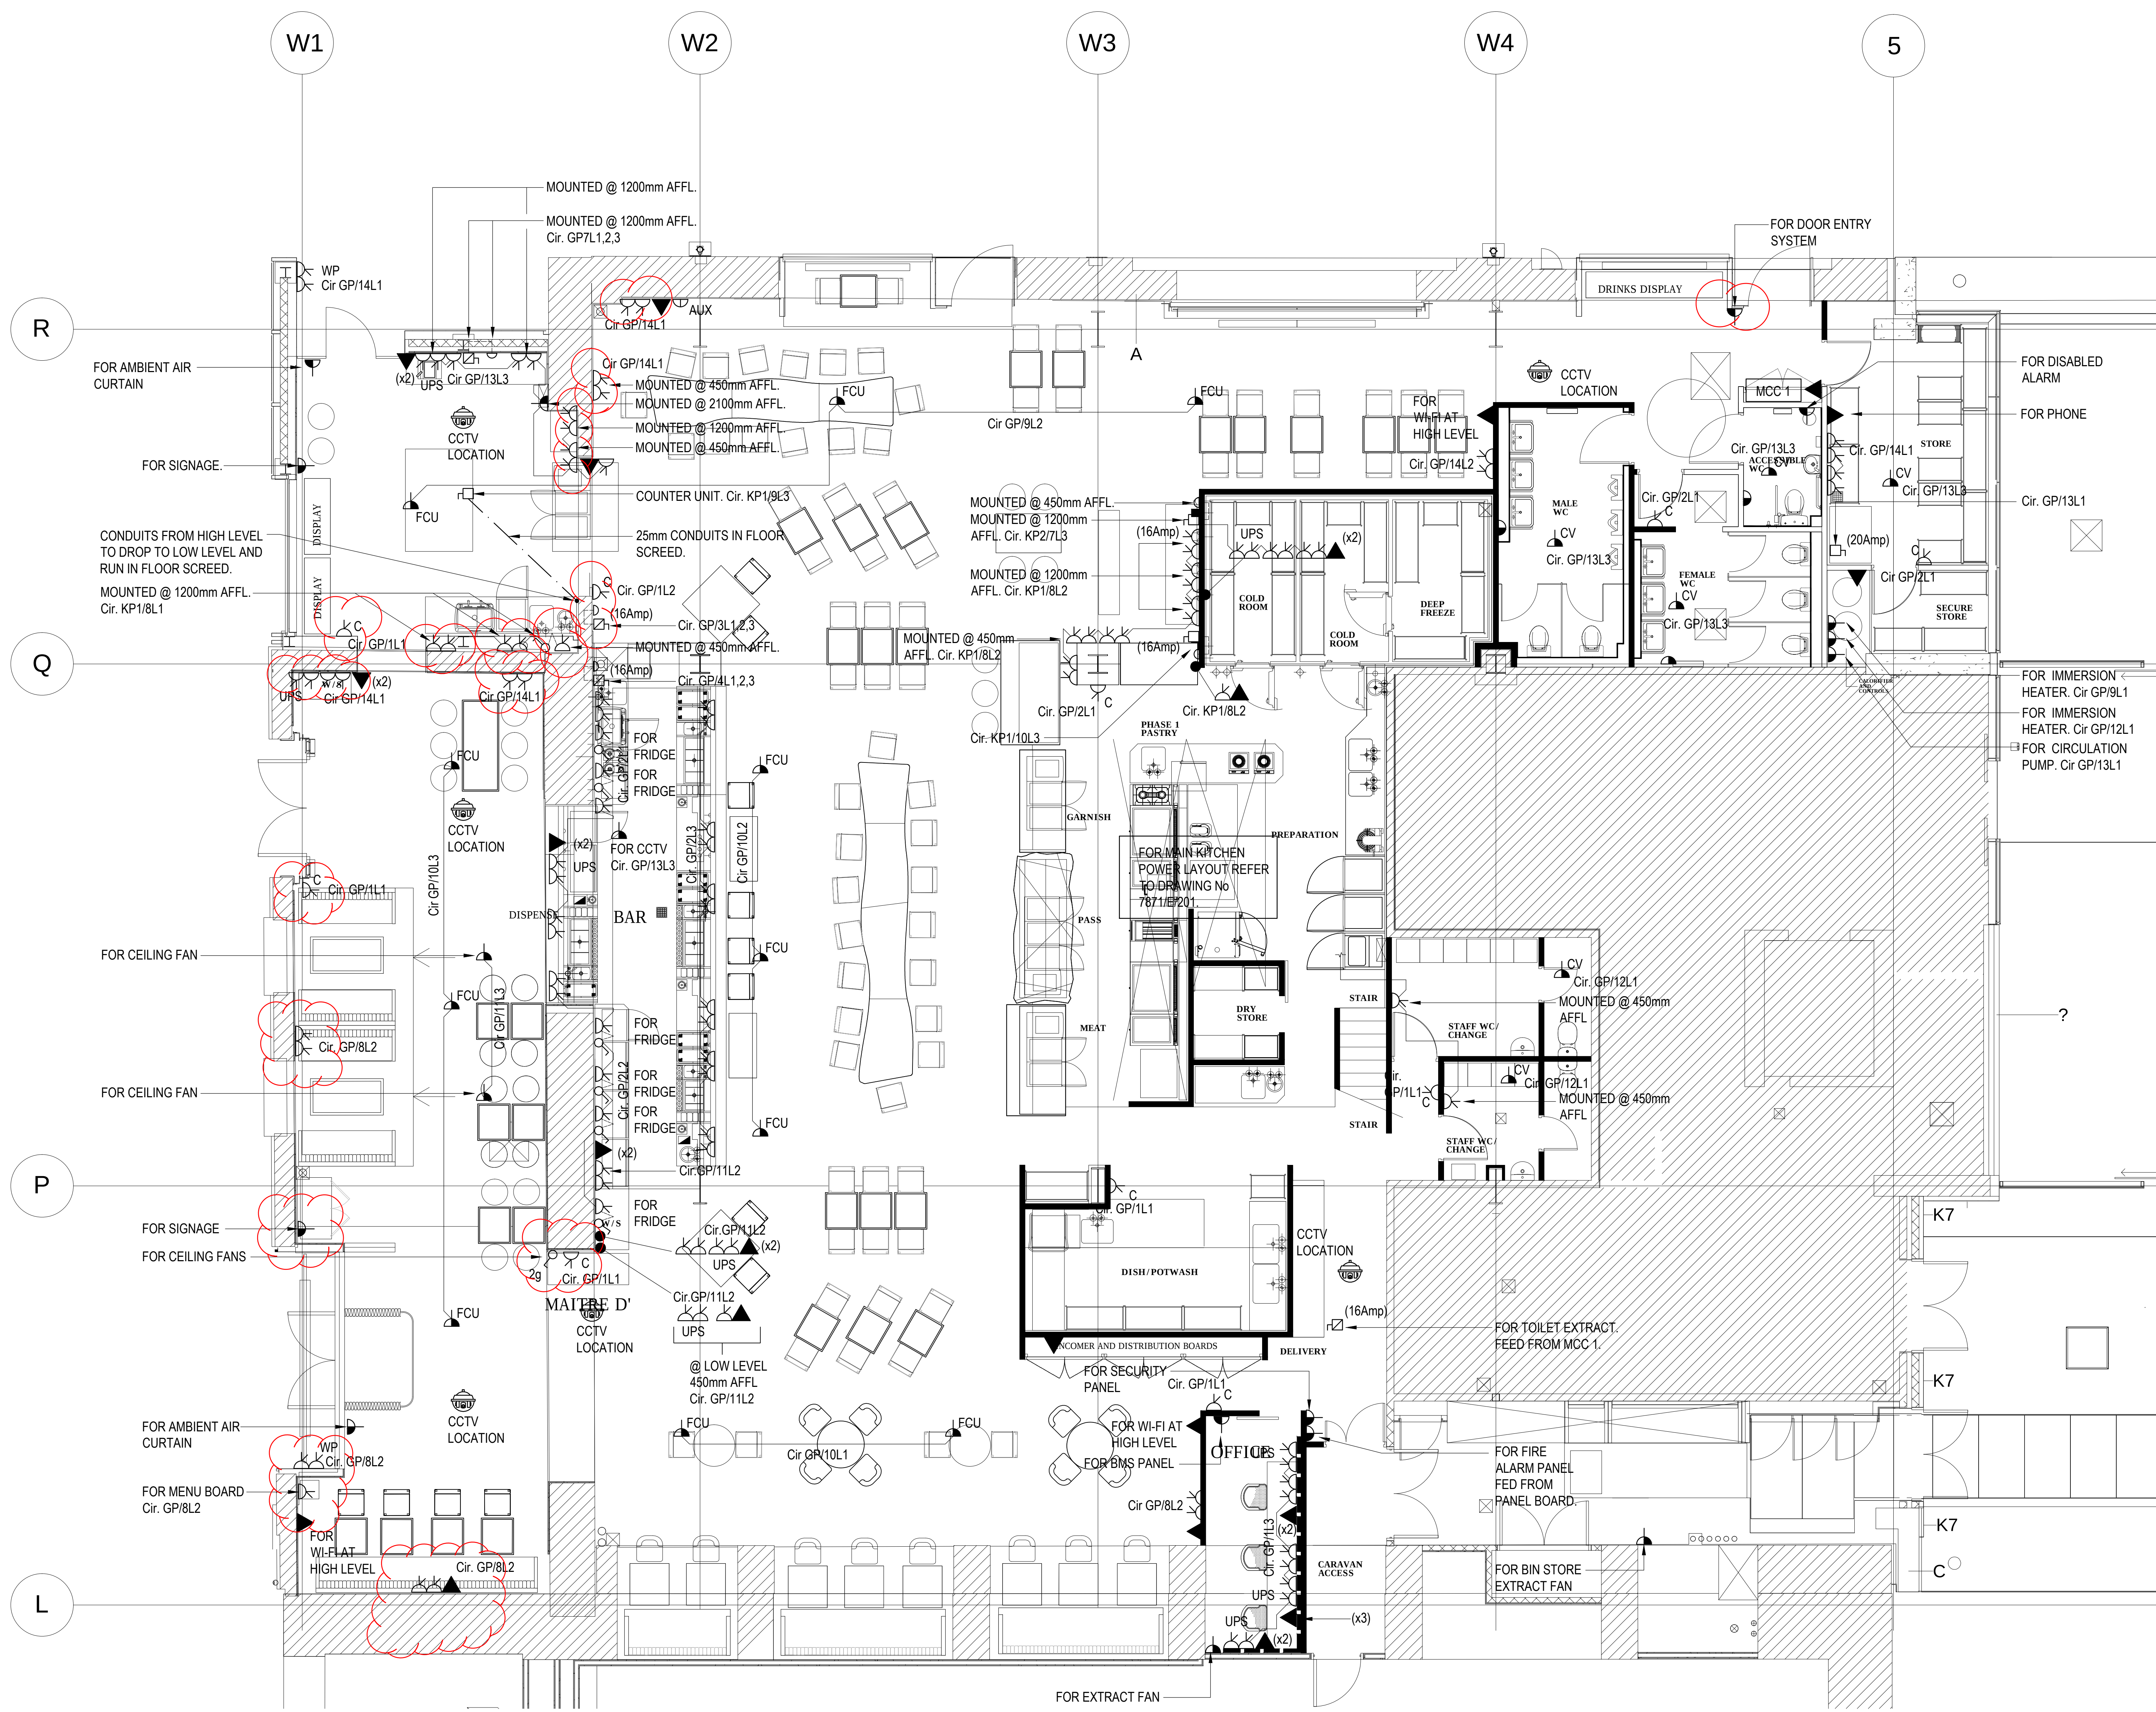

- LEGEND:
- 3 COMPARTMENT DADO TRUNKING.
 - SINGLE SWITCHED SOCKET OUTLET MOUNTED AT LOW LEVEL WITH SWITCH MOUNTED ABOVE COUNTER.
 - TWIN SWITCHED SOCKET OUTLET (7%) DENOTES NUMBER OF OUTLETS.
 - TWIN DATA OUTLET (7%) DENOTES NUMBER OF OUTLETS.
 - CLEANERS SOCKET OUTLET.
 - FUSED CONNECTION UNIT FOR FAN COIL UNIT @ HIGH LEVEL.
 - FUSED CONNECTION UNIT FOR CONSTANT VOLUME DAMPER @ HIGH LEVEL.
 - SINGLE PHASE ISOLATOR (SIZE AS NOTED).
 - 3 PHASE ISOLATOR (SIZE AS NOTED).
 - FLEX OUTLET PLATE.
 - CONDUIT & BACK BOX ONLY c/w COVER PLATE (FOR FUTURE).
 - WP DENOTES WEATHER PROOF.
 - AUX PHONO/DJ SOCKET OUTLET (BACK PLATE ONLY).
 - UPS STANDARD TWIN SOCKET OUTLET c/w STAND ALONE UPS OUTLETS.

T2	STAGE E TENDER ISSUE	G.S.	D.L.H.	14/06/12
T1	STAGE E TENDER ISSUE	G.S.	D.L.H.	28/06/12
P1	STAGE D ISSUE	G.S.	N.E.	01/06/12
W1	STAGE D ISSUE	G.S.	N.E.	01/06/12

This document is based on an original copyright work created by a company in the Granta group of companies (Granta) or a third party (Others) drawing the layout of the relevant part of the building and/or the schematic of the layout and/or fittings in the relevant part of the building or to the relevant part of the building. All property rights including copyright in any drawings created by Granta or technical additions to that drawing made by Granta are owned by Granta. The contents of this document may not be reproduced, copied, stored in any retrieval system in any form or passed to any third party without the express written consent of both Granta and the relevant Others. Granta does not accept any responsibility or liability for any errors in the dimensions or scale shown in the drawing.

Client

URBAN HOTELS GROUP

Job

GRANARY SQUARE
KITCHEN AND BAR
KINGS CROSS

Description

ELECTRICAL INSTALLATION
SMALL POWER LAYOUT

Dwg. No.	Rev	Scale
7871/E/200	T1	1:100 @ A0
Date	Drawn	Checked
APRIL 2012	D.L.H.	D.L.H.

DAVIS, WILLIS
AND ASSOCIATES
LIMITED

2 Regents Wharf
All Saints Street
London N1 9RL
Tel: 020 7837 6433
Fax: 020 7520 8100
email: csl@gwa.com

Building services
engineers