




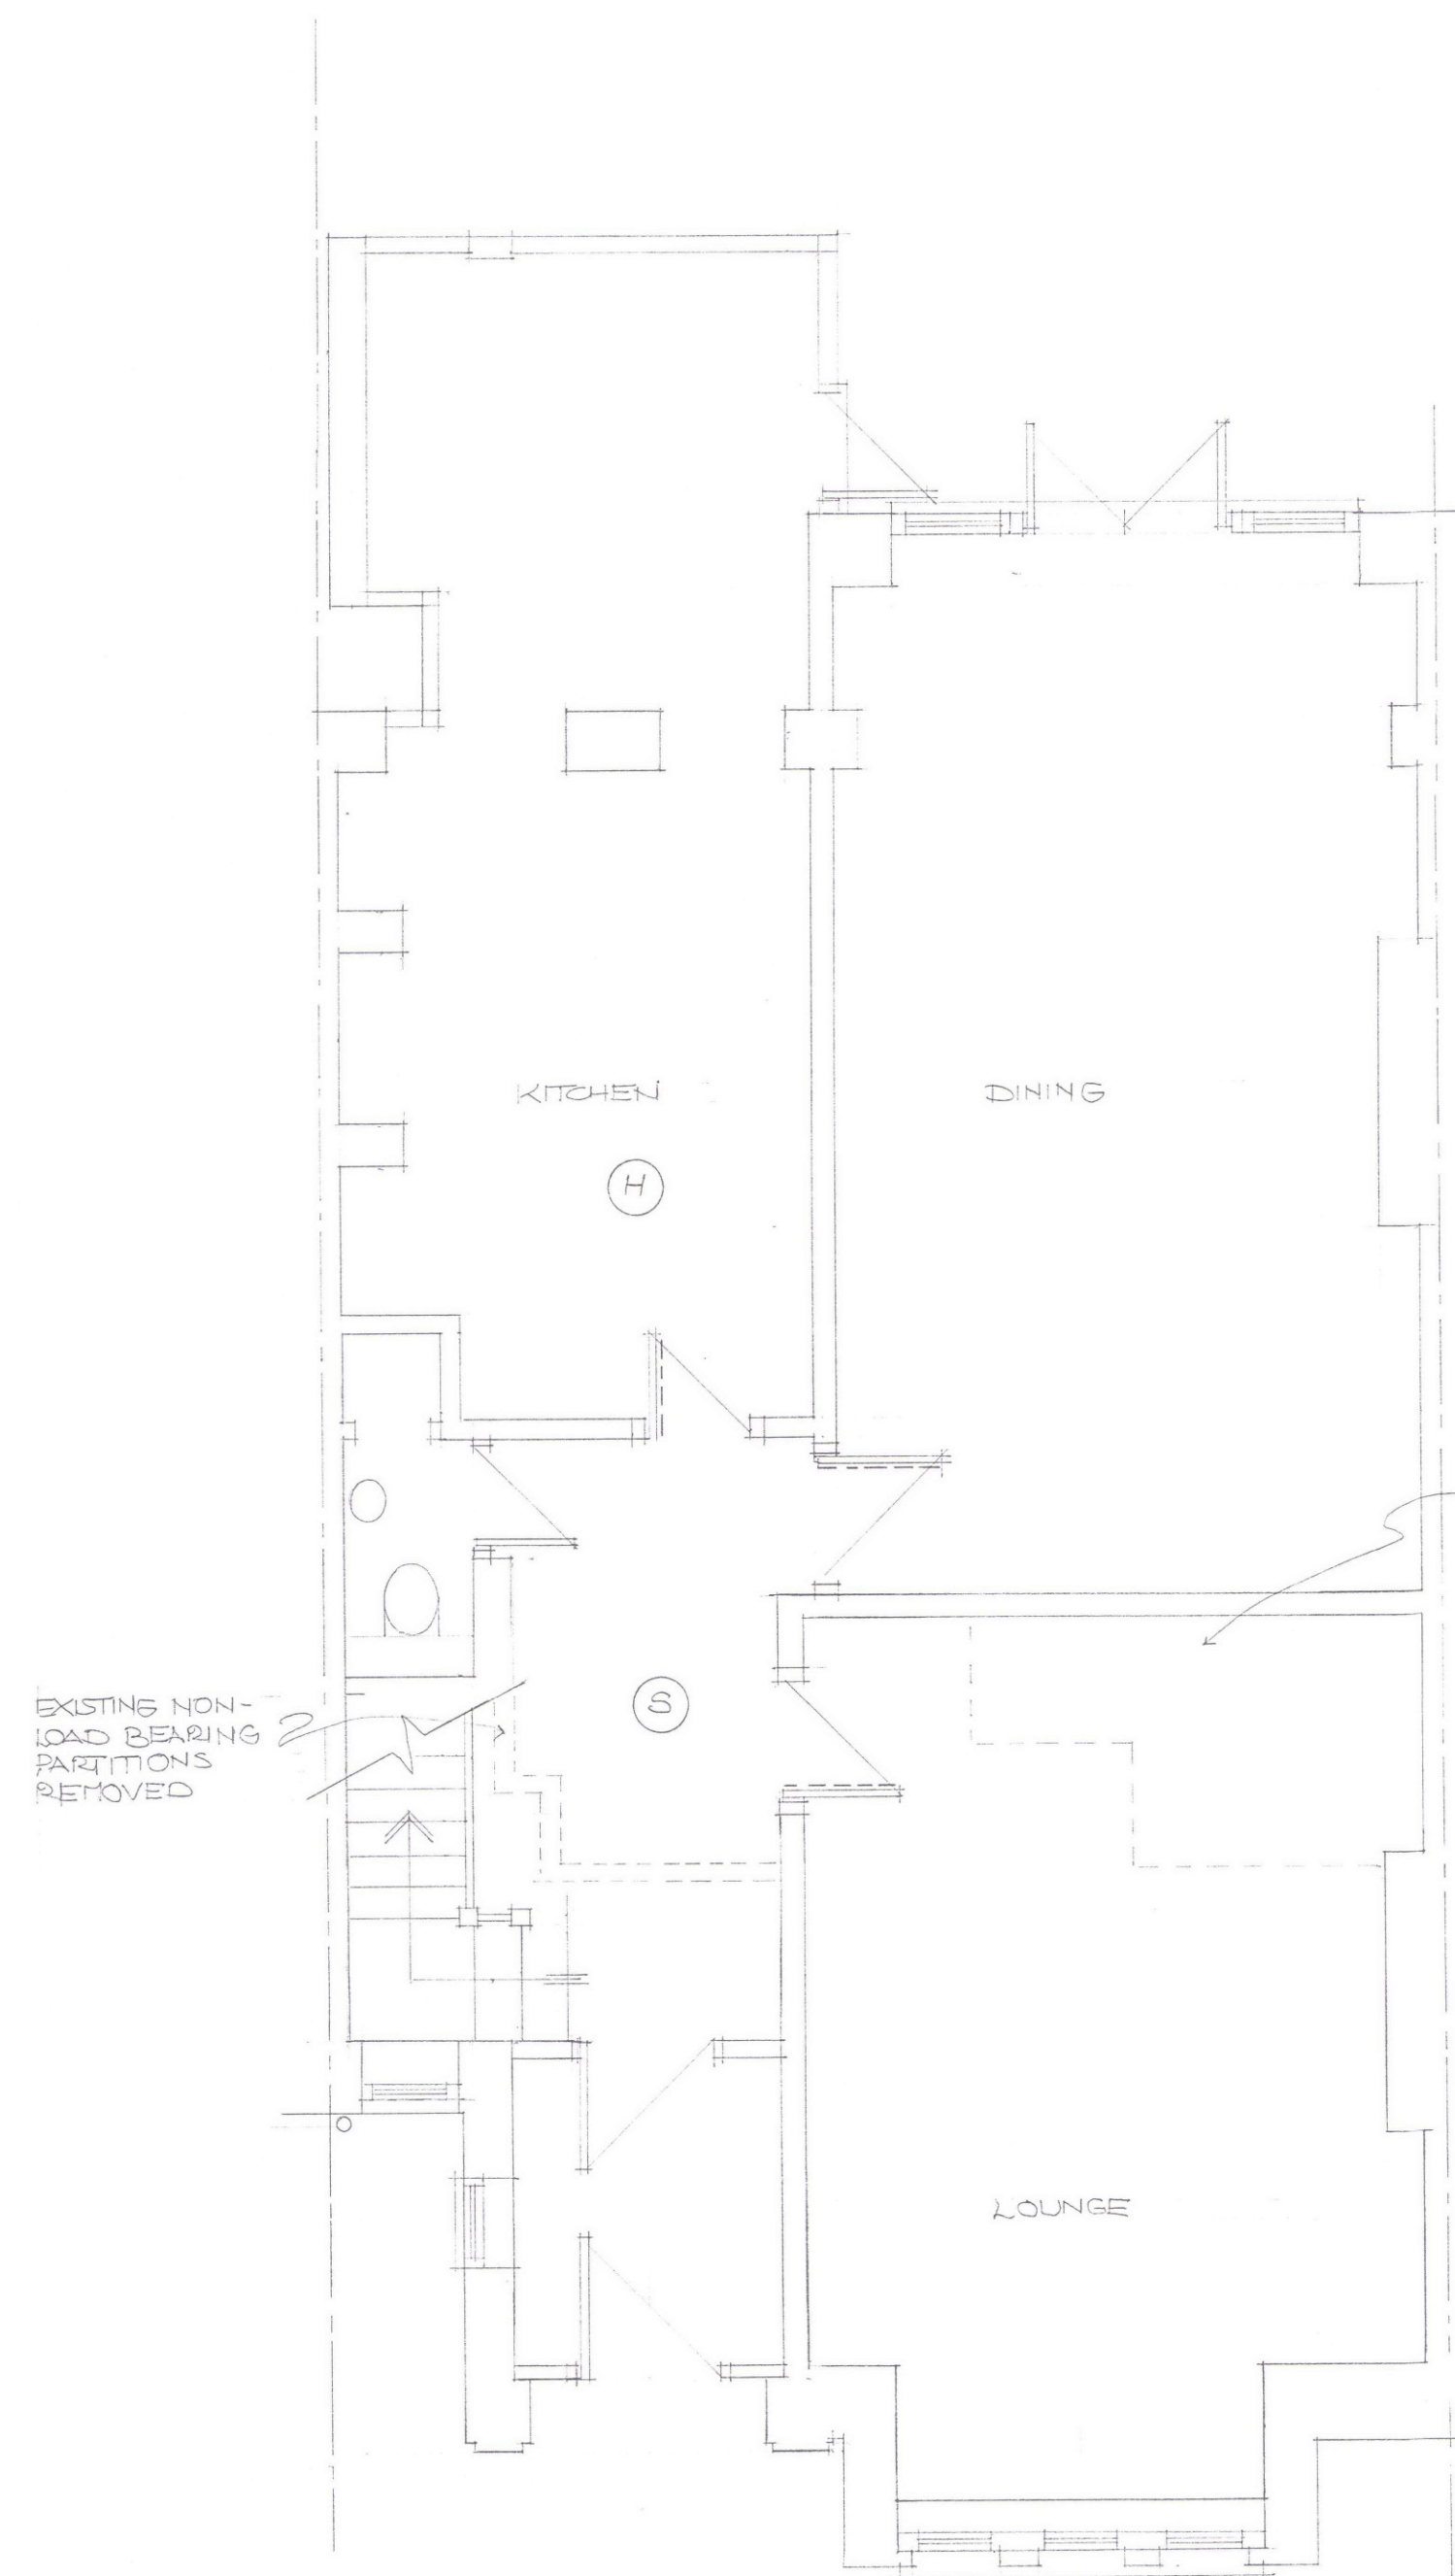


GROUND FLOOR PLAN

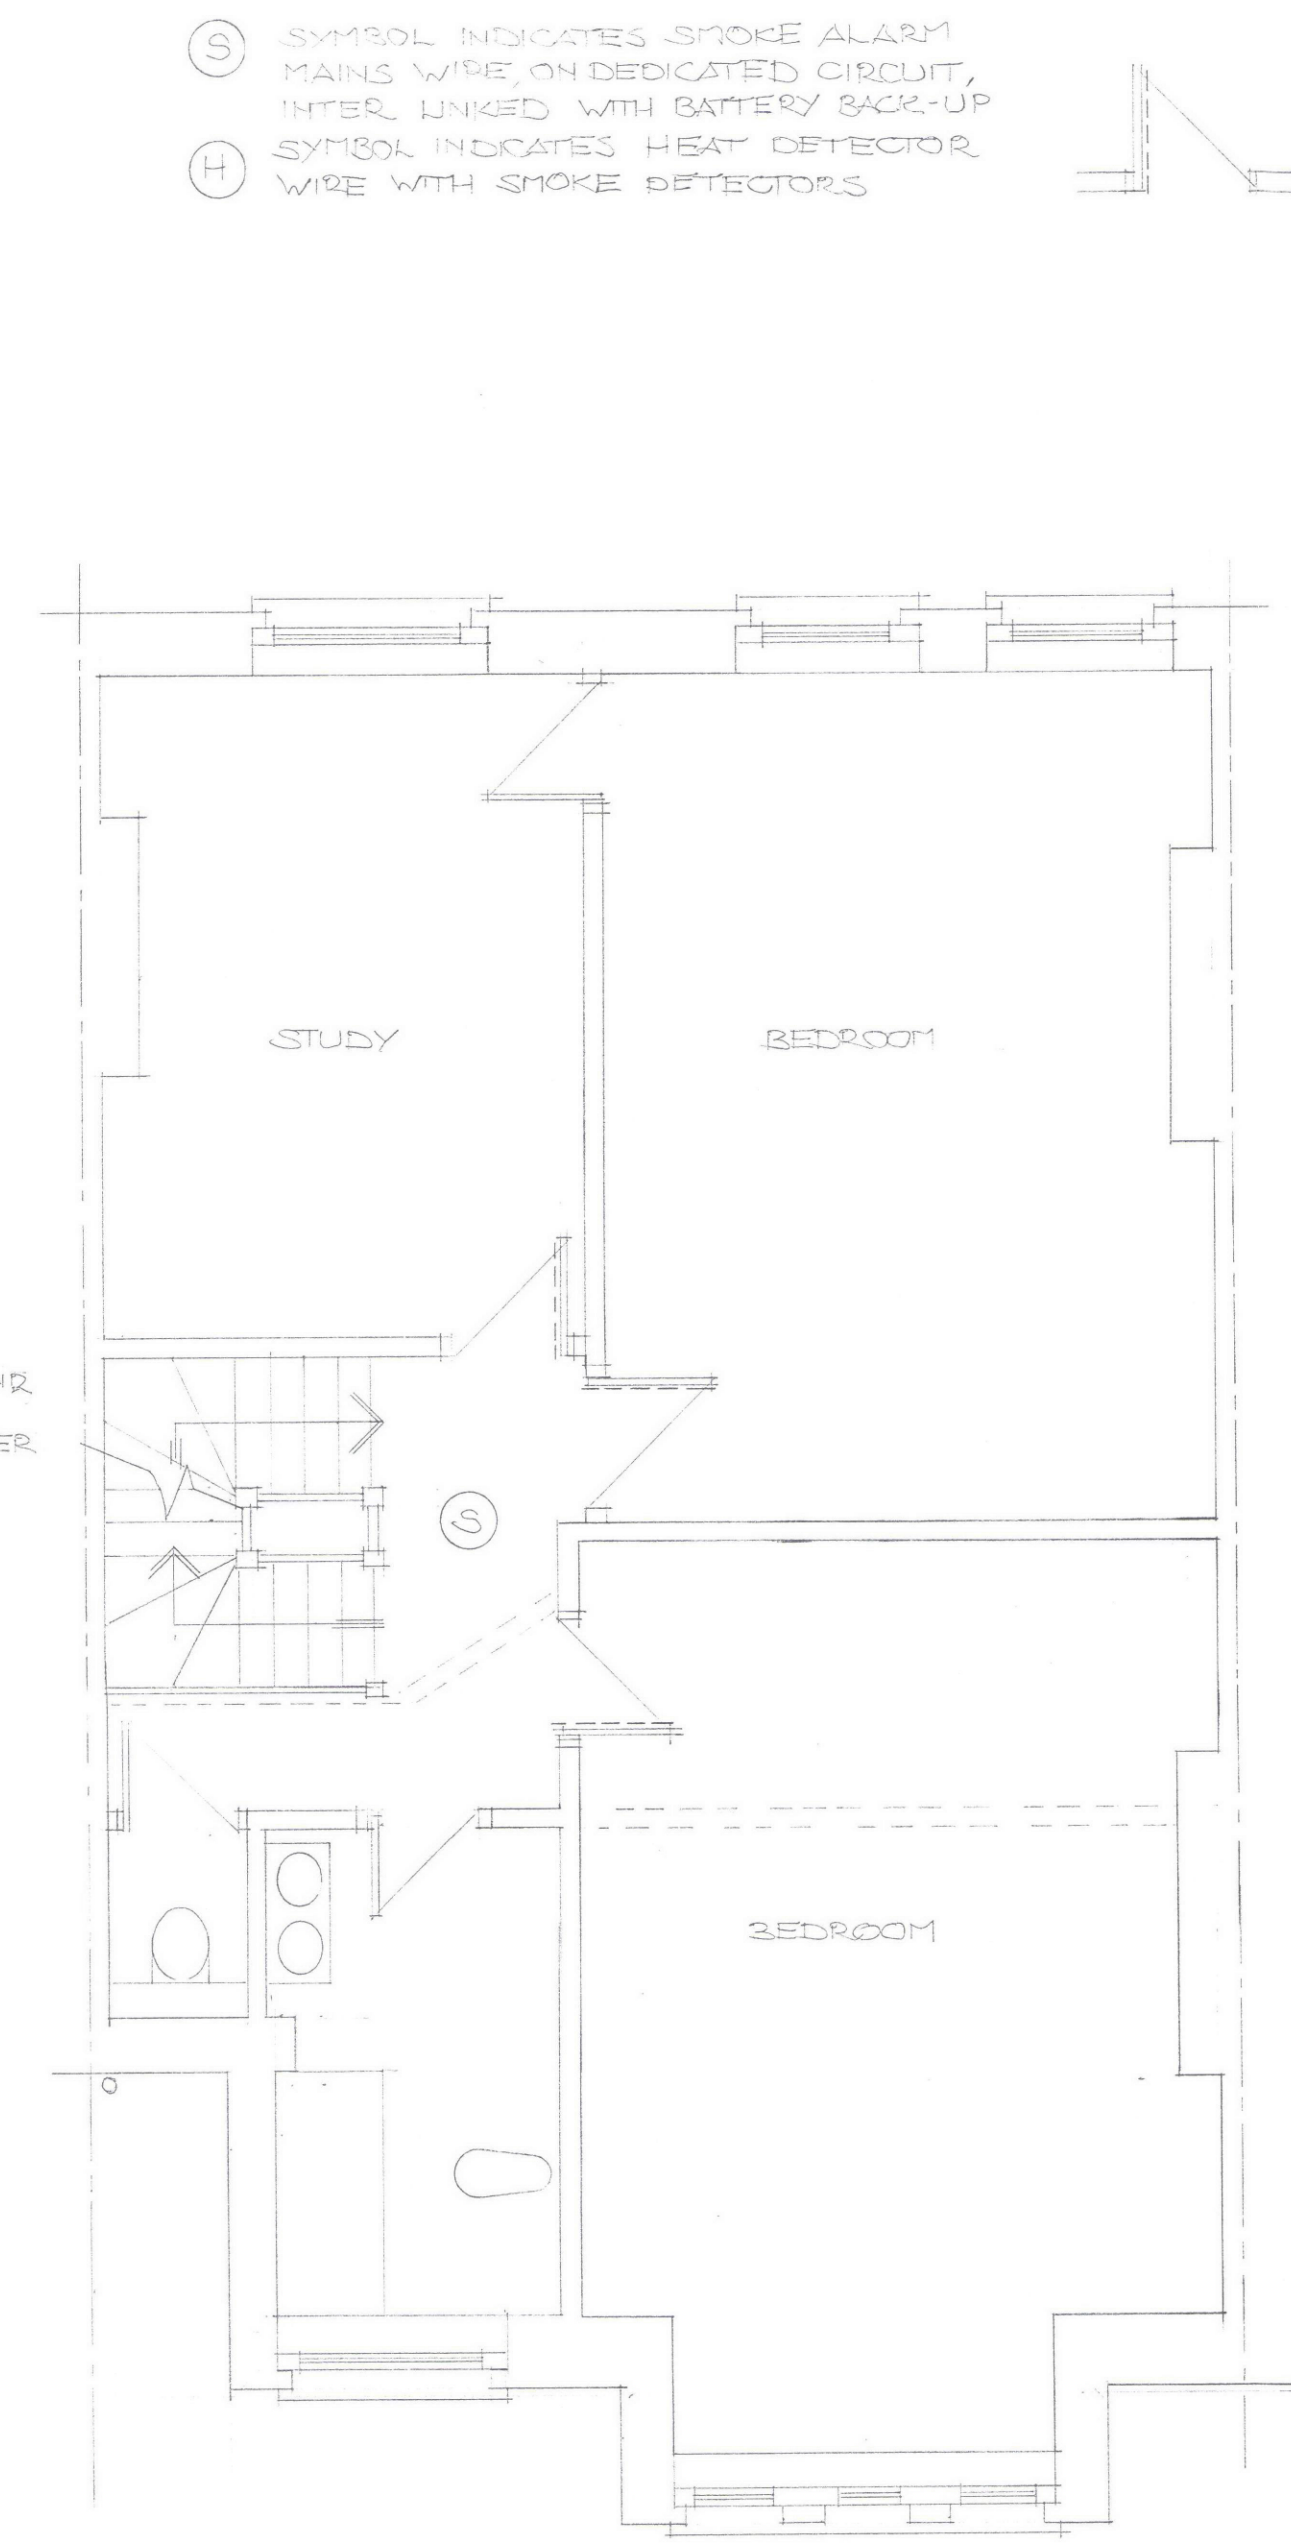

FIRST FLOOR PLAN

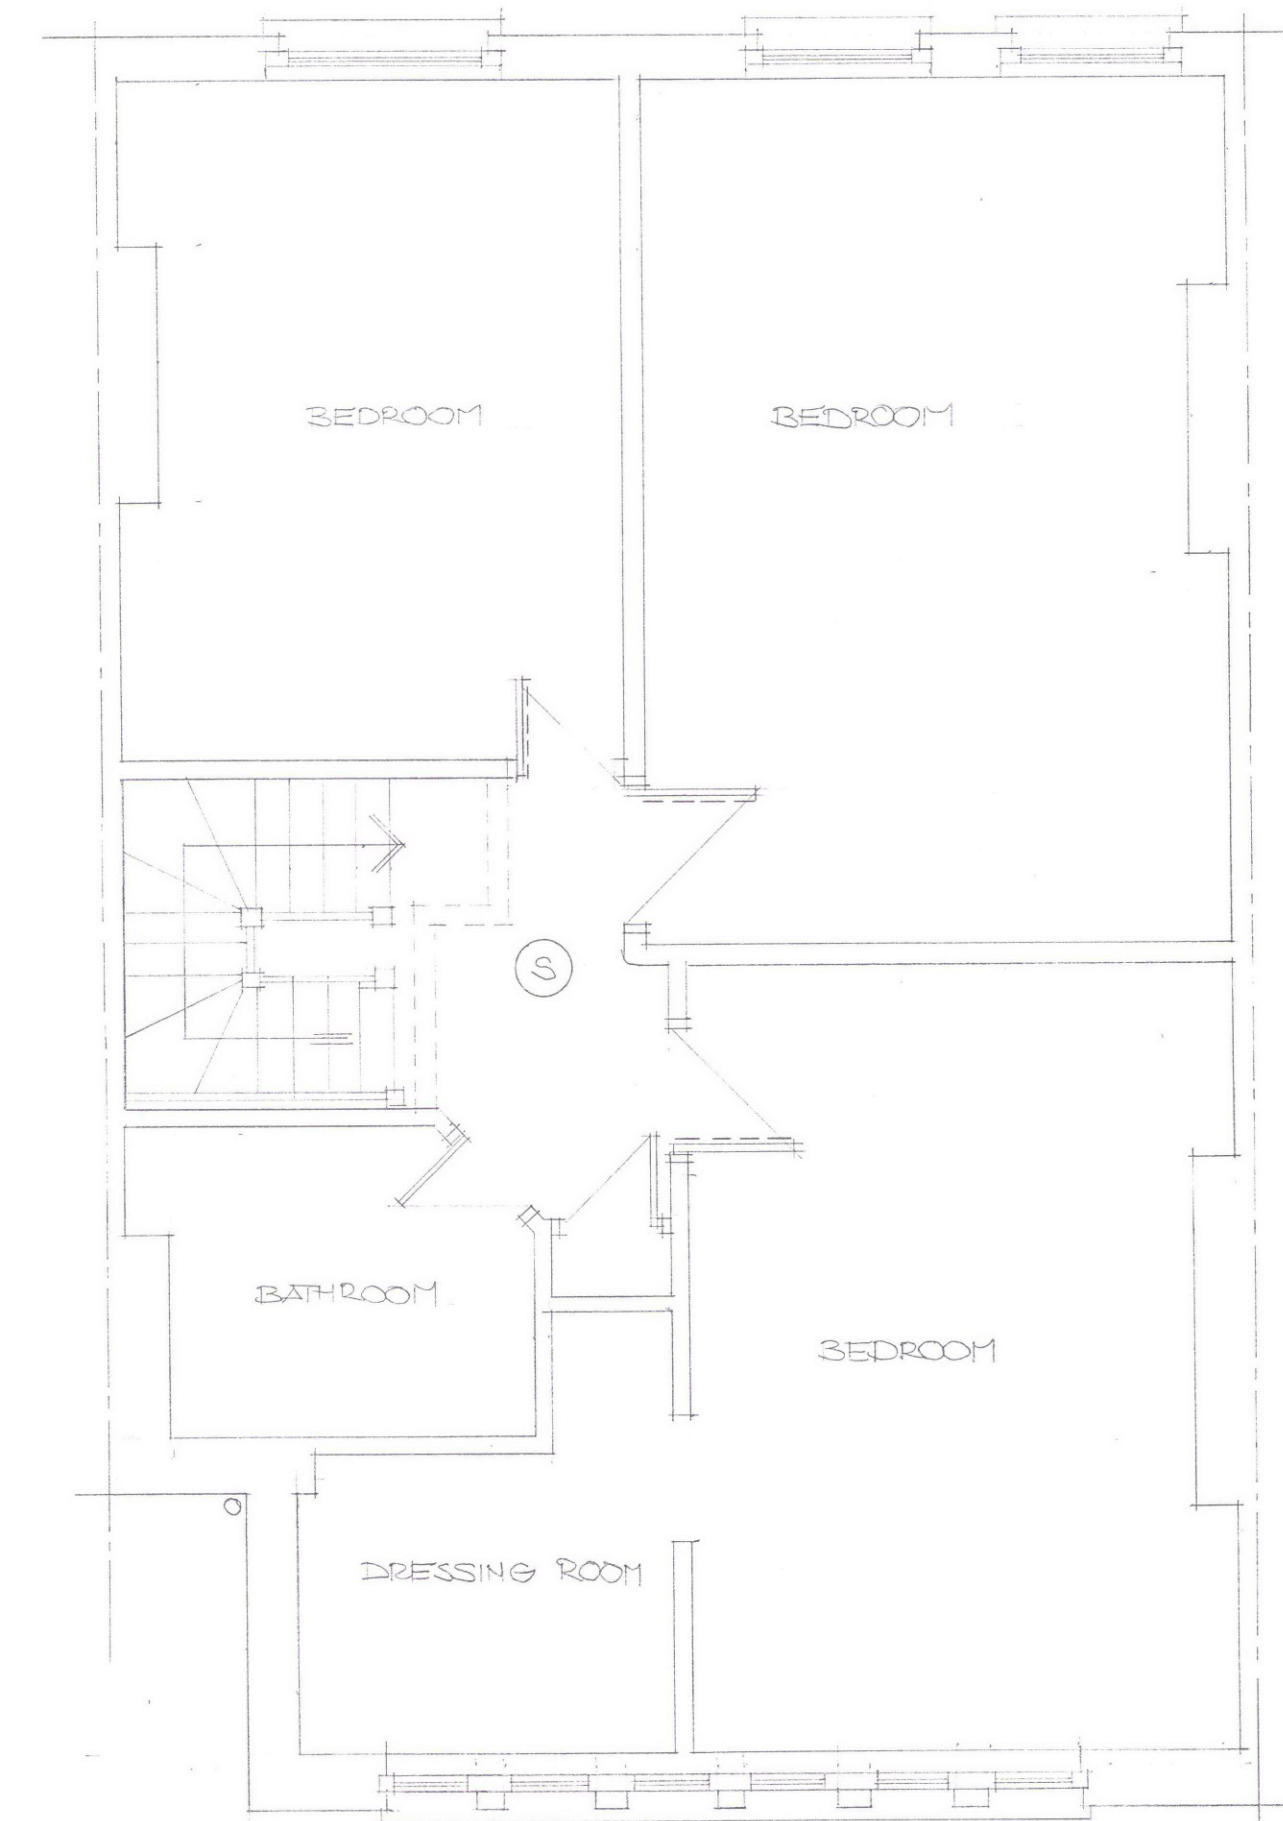


SECOND FLOOR PLAN

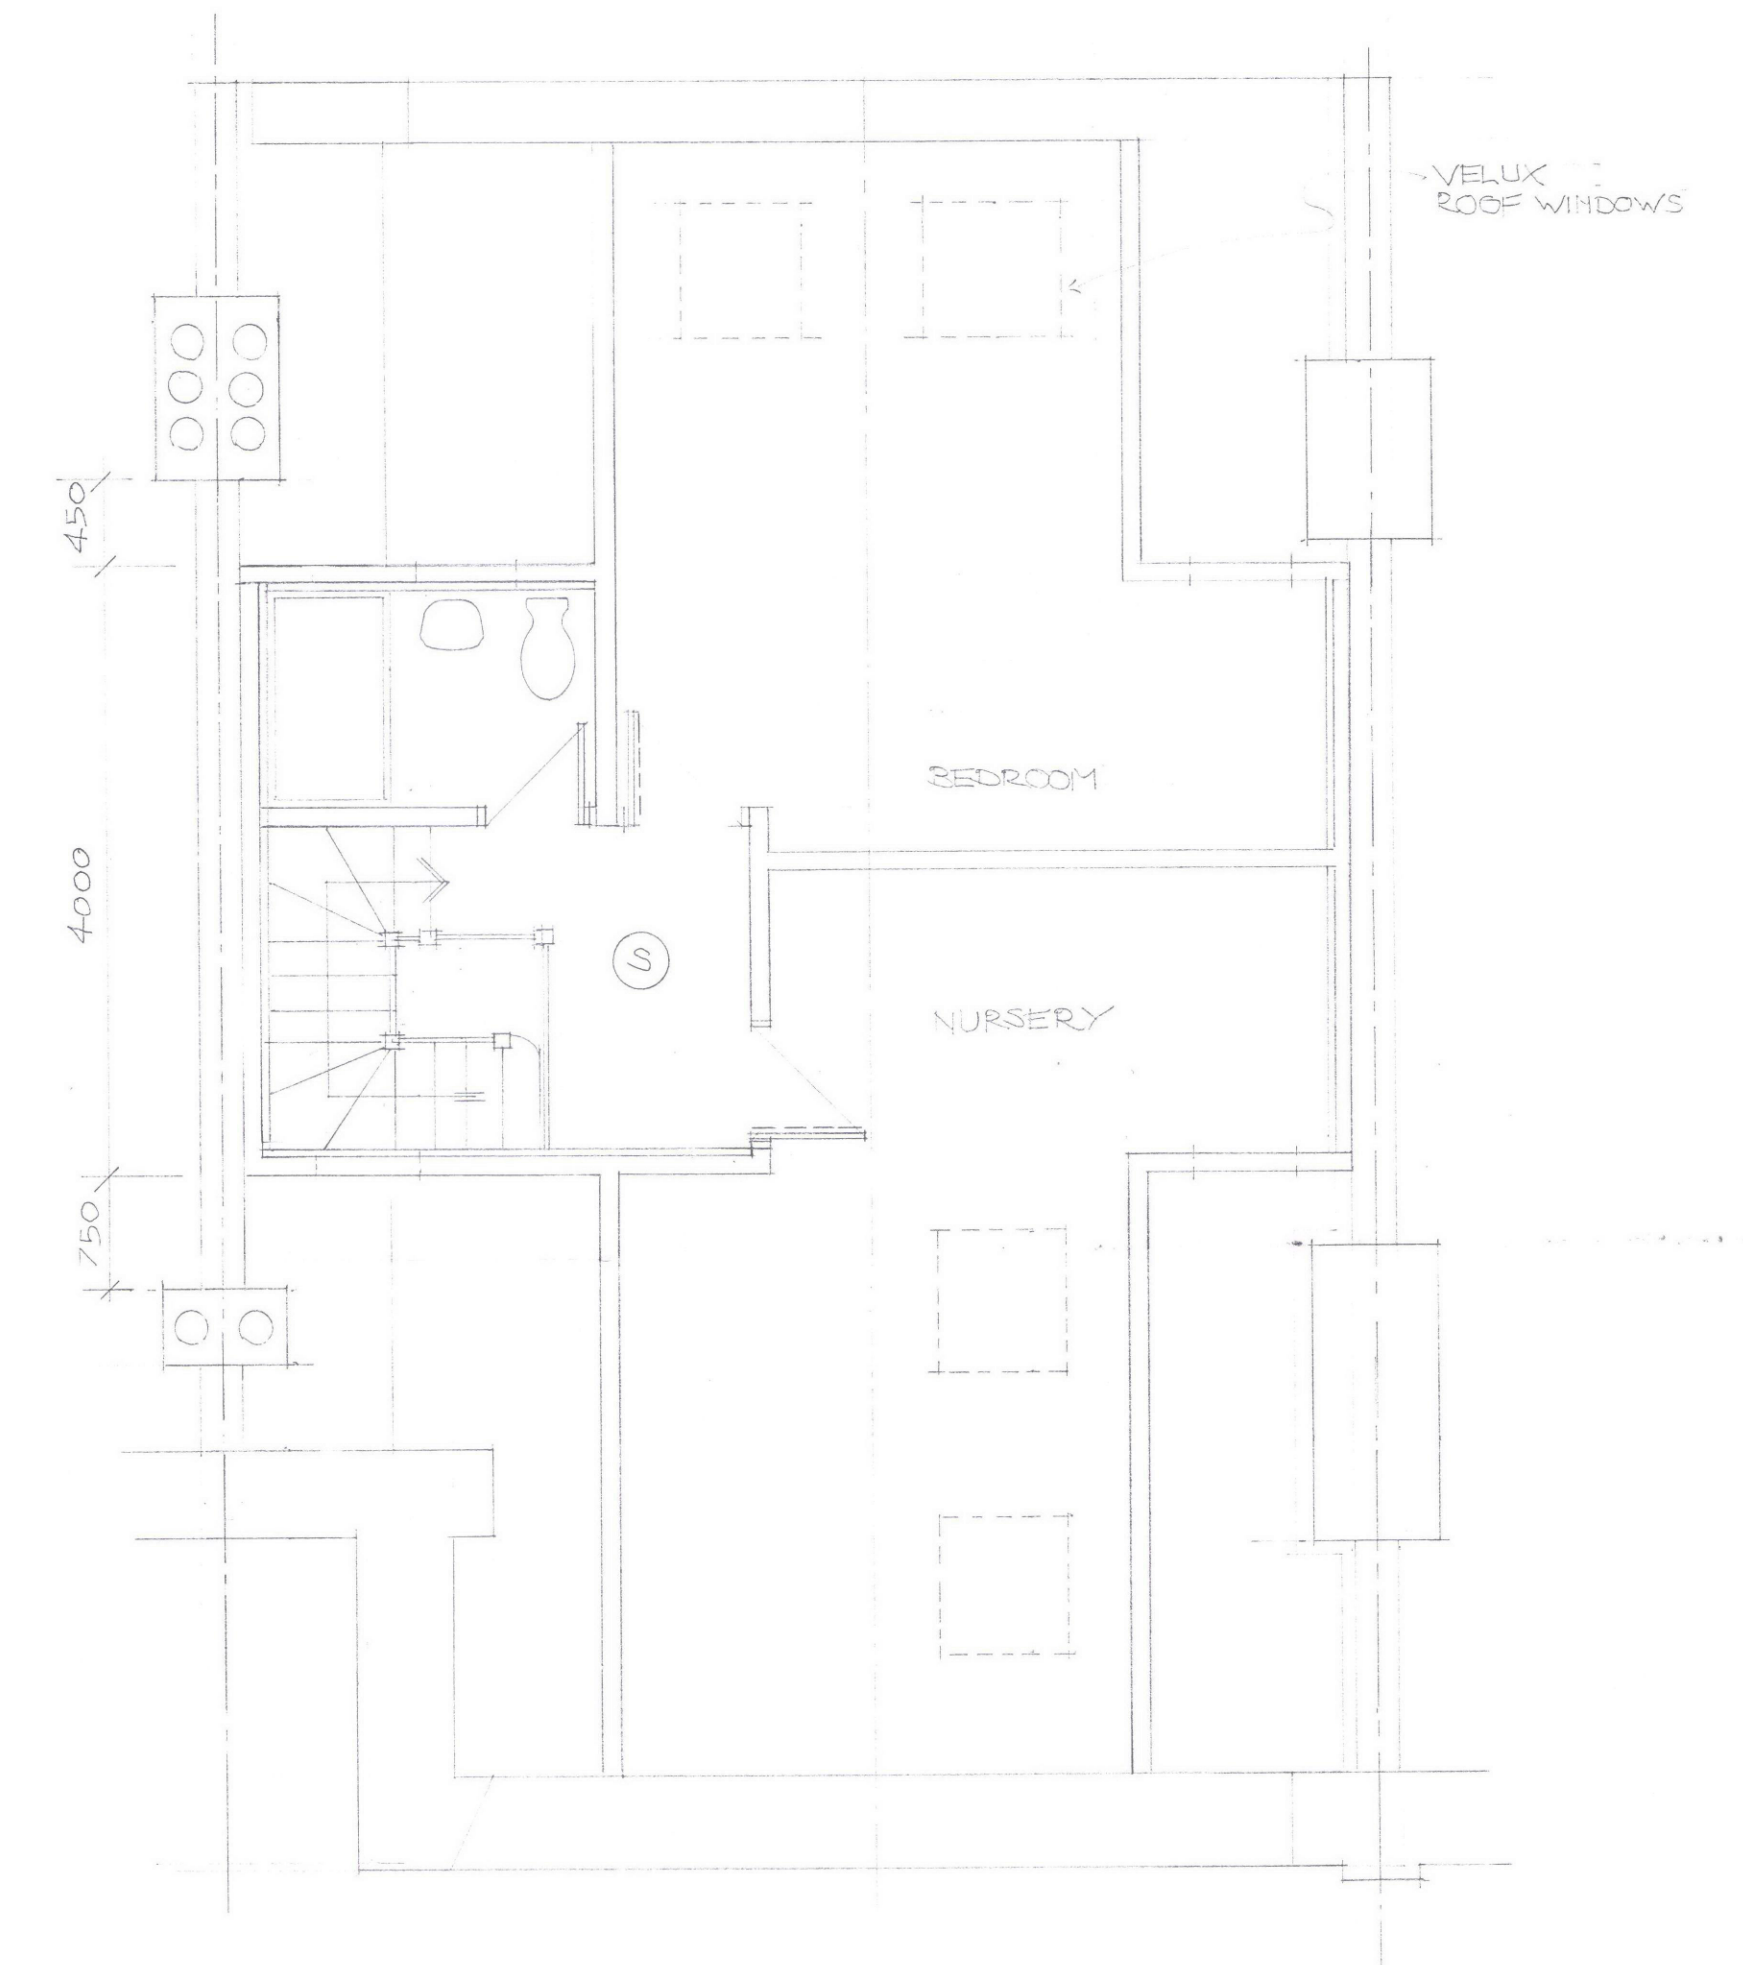

ROOF PLAN

- Ⓢ SYMBOL INDICATES SMOKE ALARM MAINS WIRE ON DEDICATED CIRCUIT, INTER LINKED WITH BATTERY BACK-UP
- Ⓜ SYMBOL INDICATES HEAT DETECTOR WIRE WITH SMOKE DETECTORS

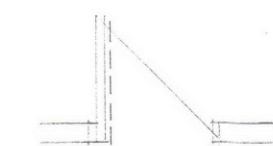

⋯ DOTTED LINE BY 100% INDICATES HALF HOUR FIRE DOOR WITH 20MM STOPS.

PROPOSED FLOOR LAYOUTS

SCALE 1:50