
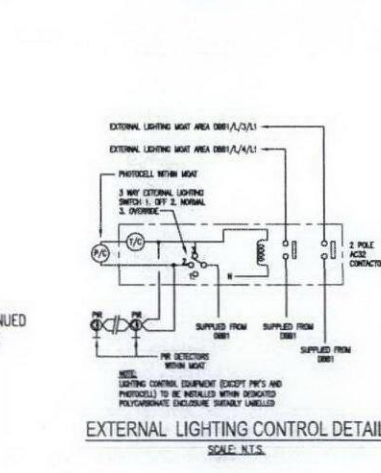
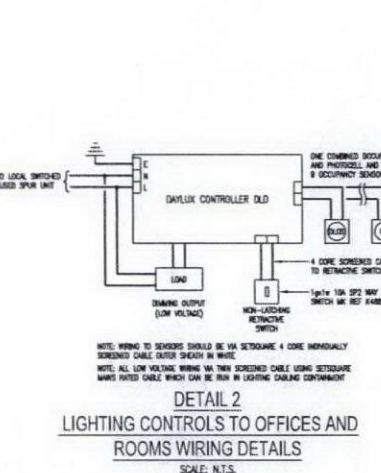
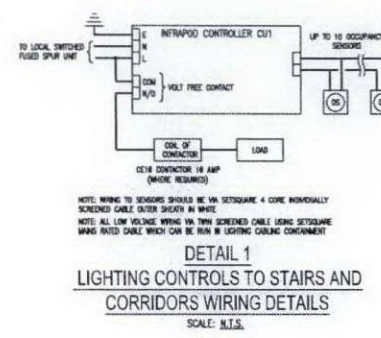
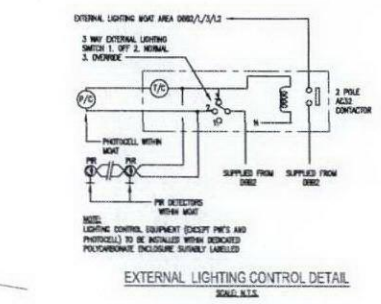


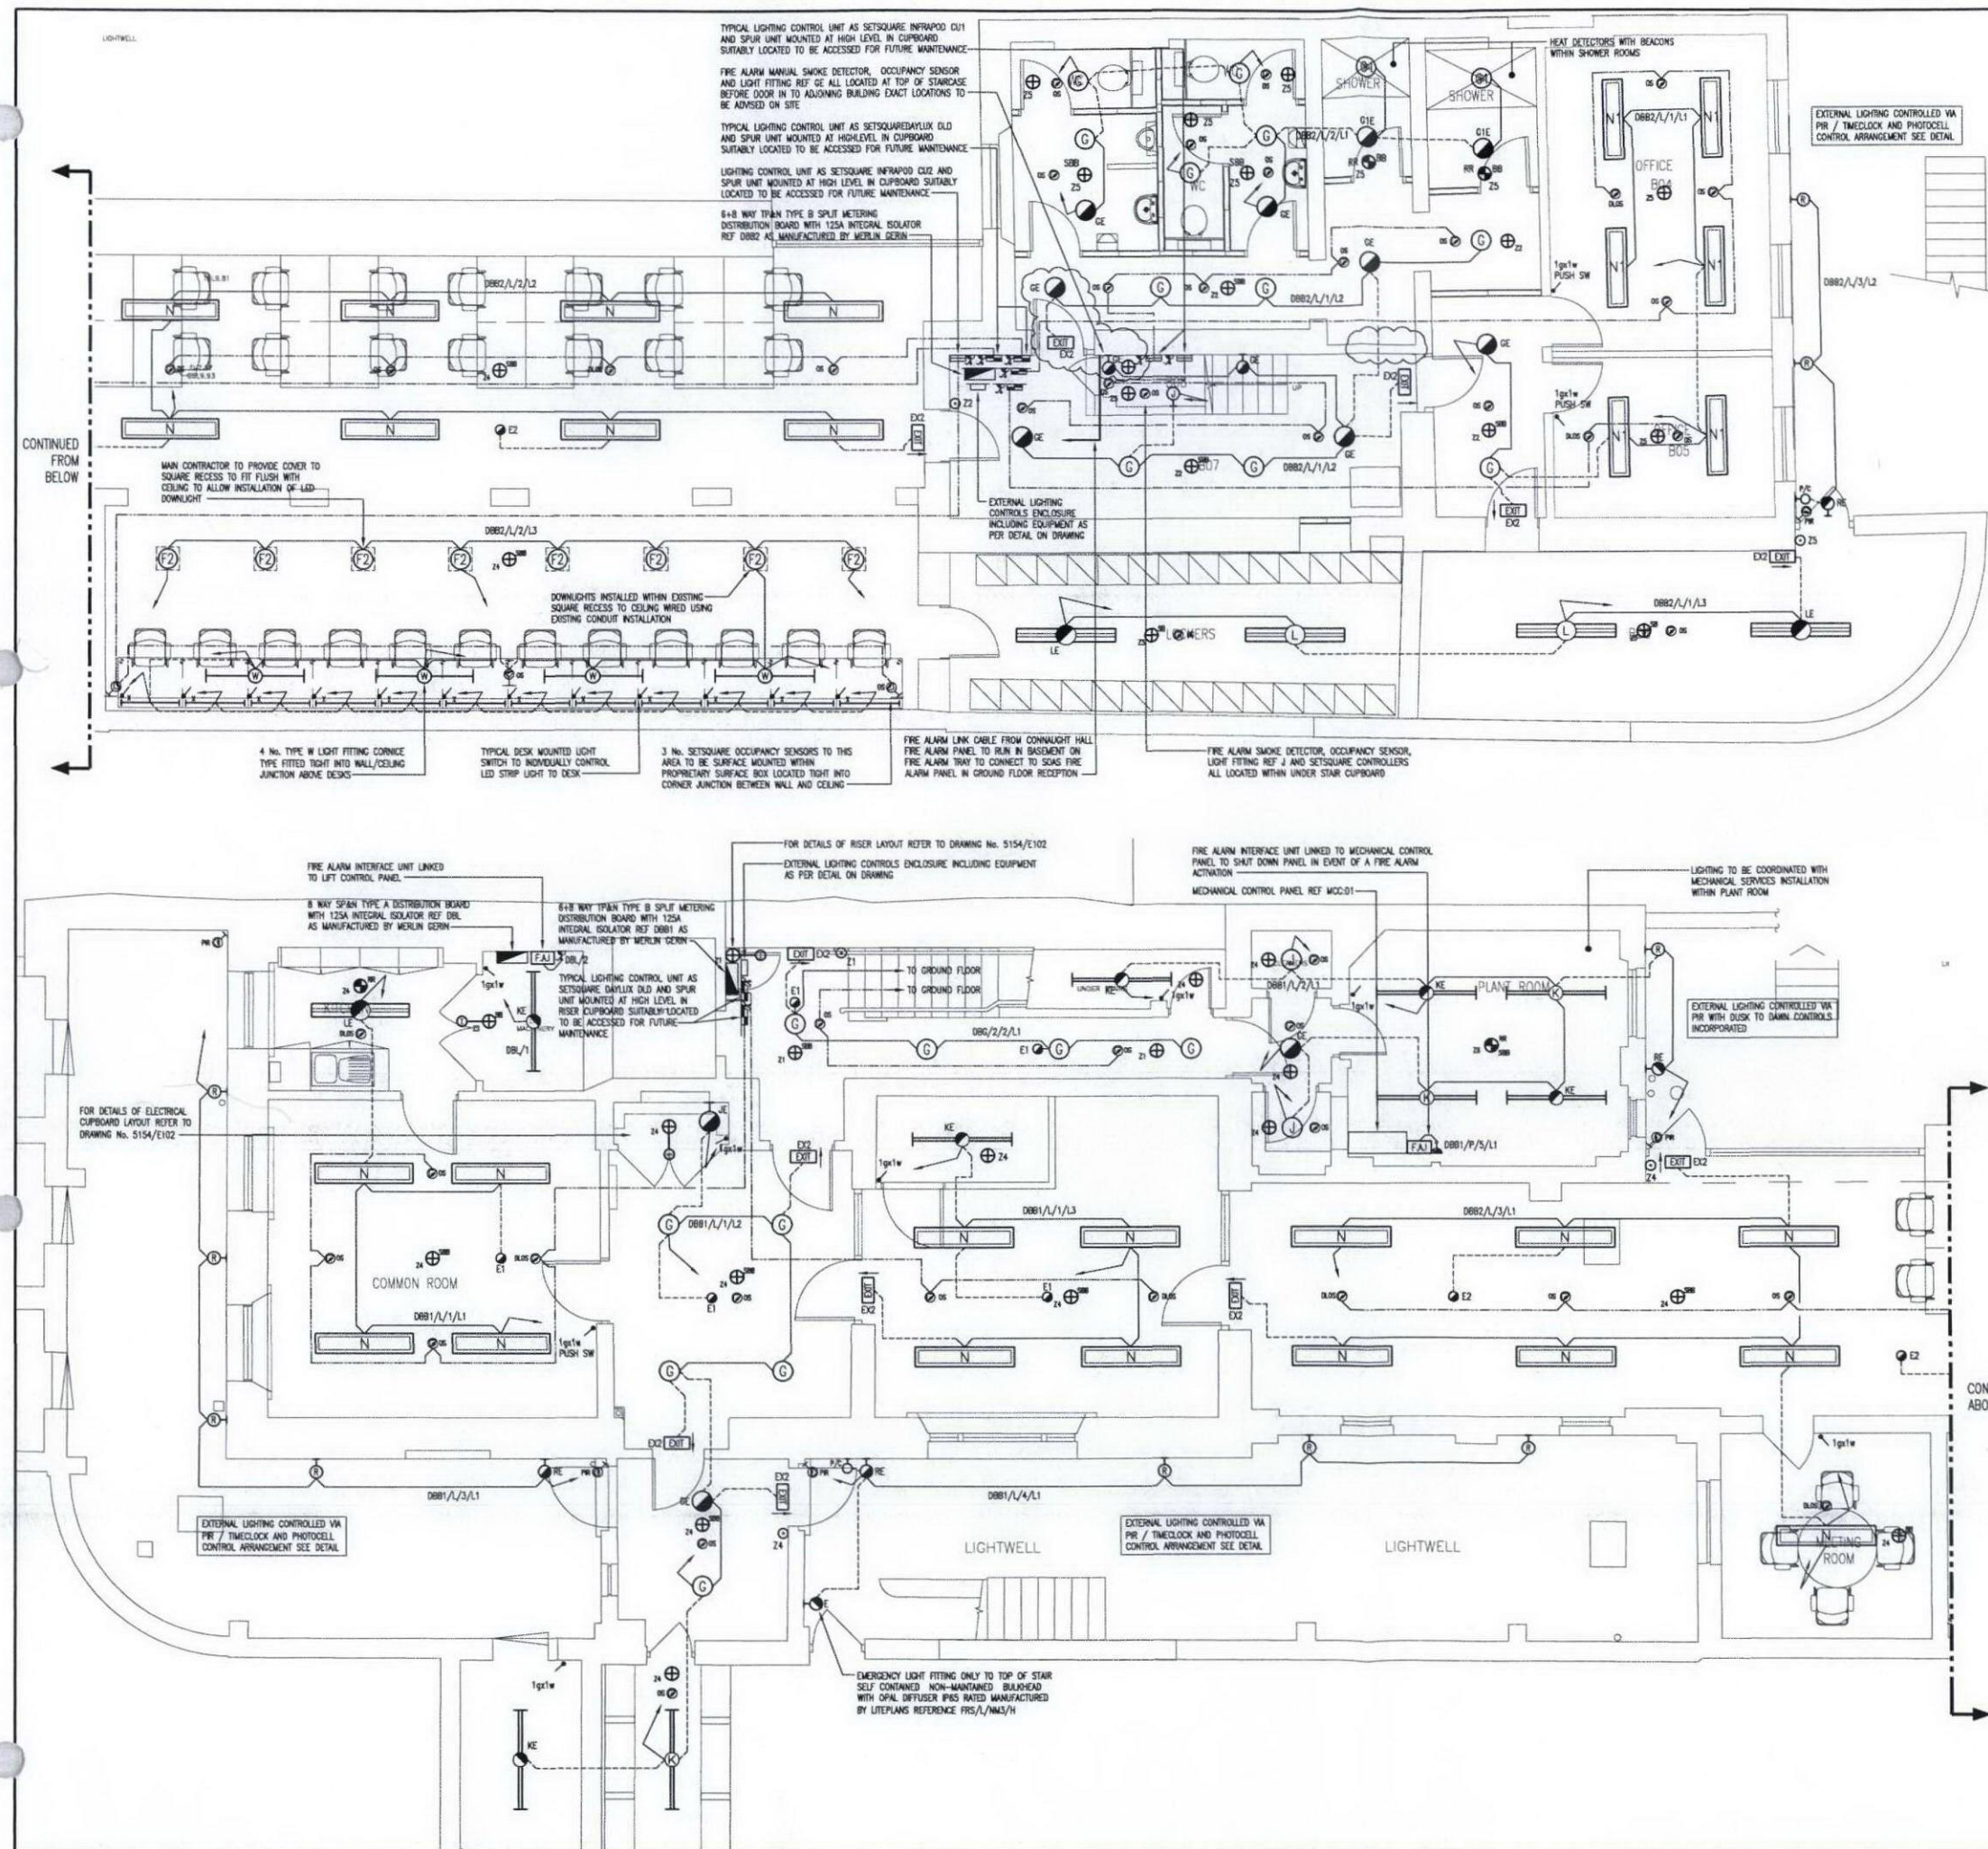

- NOTES:**
- THIS DRAWING IS THE PROPERTY OF HITEK CONSULTANTS LIMITED AND IS PROTECTED UNDER THE COPYRIGHTS DESIGNS AND PATENTS ACT 1988. ALL RIGHTS RESERVED. THIS DRAWING IS ISSUED ON CONDITION THAT IT IS NOT COPIED, REPRODUCED OR REPRODUCED, WHOLLY OR IN PART, WITHOUT THE CONSENT OF HITEK CONSULTANTS LIMITED.
 - DO NOT SCALE FROM THIS DRAWING. ALL DIMENSIONS AND SETTING OUT TO BE TAKEN FROM ARCHITECTURAL DRAWINGS.
 - THIS DRAWING SHALL BE READ IN CONJUNCTION WITH THE ARCHITECTS, STRUCTURAL ENGINEERS AND ALL OTHER SERVICES DRAWINGS AND SPECIFICATIONS.
 - THE INFORMATION CONTAINED ON THIS DRAWING HAS BEEN PRODUCED FROM A NON DESTRUCTIVE VISUAL SURVEY AND RECORD DOCUMENTATION ONLY. IT IS THE CONTRACTORS RESPONSIBILITY TO VERIFY ALL INFORMATION PRIOR TO ANY SERVICES BEING INSTALLED AND STRIPPED OUT.
 - LIGHTING TO BE WIRED USING TRUNKING AND UPVC CONDUITS, AND ROUTED THROUGH JOISTED FLOOR VOIDS USING 6242B CABLES (COLOUR TO HARMONISED STANDARDS) AND SLIDE TYPE PUSHERS IN CEILING ROSES. PART OF BASEMENT TO BE CARRIED OUT IN LSF SINGLE CORE 6491B CABLES.
 - LIGHTING CONTROL SYSTEMS TO BE BY SETSQUARE AS DETAIL ON THE DRAWINGS. THE ELECTRICAL CONTRACTOR IS TO ALLOW FOR SETSQUARE TO COMMISSION THE INSTALLATION WHEN COMPLETE. THIS WILL PROVIDE THE CLIENT WITH A THREE YEAR GUARANTEE TO THE EQUIPMENT.
 - ALL ACCESSORIES TO BE MK WHITE LOGIC RANGE WITH THE EXCEPTION OF THE GROUND FLOOR RECEPTION, GALLERY AREAS, AND STAIRCASES WHICH ARE TO BE MK EDGE RANGE ANTIQUE BRONZE FINISH UNLESS STATED OTHERWISE.
 - THE ELECTRICAL CONTRACTOR ON COMPLETION OF THE FIRE ALARM WORKS ARE TO EMPLOY THE SERVICES OF THE SYSTEM MAINTAINER HONEYWELL BUILDING SOLUTIONS CONTACT PAUL CHARLES 07769 836197 TO RE-COMMISSION THE SYSTEM.
 - ALL SMOKE DETECTOR COVERS USED DURING THE WORKS TO PREVENT FALSE ALARMS ARE TO BE REMOVED FROM THE SMOKE DETECTORS ON COMPLETION OF THE PROJECT WORKS.
 - ALL LIGHTING ACCESSORIES TO BE MK WHITE LOGIC GRID SWITCH RANGE WITH THE EXCEPTION OF DINNAR SWITCHES WHICH ARE TO BE SETSQUARE RD WHITE AND AREAS SUCH AS GROUND FLOOR RECEPTION, GALLERY AREAS AND STAIRCASES ARE TO BE MK EDGE RANGE ANTIQUE BRONZE FINISH UNLESS STATED OTHERWISE.
 - FOR SCHEDULE OF LUMINAIRE REFER TO ELECTRICAL SPECIFICATION.
 - SMALL POWER TO BE WIRED USING GALVANISED TRUNKING AND 20mm UPVC CONDUIT, OR ROUTED WITHIN JOISTED FLOOR VOID USING 6242B CABLE (COLOURS TO HARMONISED STANDARDS). PART OF BASEMENT TO BE CARRIED OUT USING LSF SINGLE CORE 6491B CABLES.
 - ALL LIGHT SWITCHES, SOCKETS, SPURS ETC. ARE TO BE SUITABLY LABELLED USING DYMO MACHINE OR SIMILAR DETAILING CIRCUIT REFERENCE.
 - ALL UNSTRUTTED SUPPORTS TO HAVE END CAPS FITTED AND DROP RODS CUT BACK AS FAR AS POSSIBLE AND PROTECTION CAPS FITTED.
 - ELECTRICAL CONTRACTORS TO CO-ORDINATE ALL MECHANICAL AND ELECTRICAL SERVICES TO ENSURE ALL THE SERVICES SUITABLY INTEGRATE TO PREVENT ANY CLASHES AND ALLOW FOR ANY FUTURE MAINTENANCE ACCESS.

Rev	Date	Details	By	Chd
C	MAY 2012	REVISED AS INDICATED	TTJ	TTJ
B	APR 2012	REVISED AS INDICATED - CIRCUIT REFERENCES REVISED	TTJ	TTJ
A	MAR 2012	CONSTRUCTION ISSUE WHOLE DRAWING REVISED	TTJ	TTJ

HITEK Consultants Ltd
Chartered Building Services Consulting Engineers
Barn A, The Stables
Parsonage Farm
Hollow Hill Lane
Iwer, Bucks
SL0 0JW

**53 GORDON SQUARE
LONDON
WC1H 0PD**

SCHOOL OF ORIENTAL & AFRICAN STUDIES

TUFFIN FERRABY TAYLOR

**BASEMENT PROPOSED
LIGHTING, EMERGENCY LIGHTING
& FIRE ALARM LAYOUT**

Scale	1:50 @ A1	Drawing no.	5154/E200
Date	AUG 2011	Revision	C
Designed	TTJ	Calc ref	5154E200C
Drawn	CAM	Checked	TTJ

THIS DRAWING REMAINS THE PROPERTY OF HITEK CONSULTANTS LIMITED. COPIES OF THIS DRAWING FOR PARTS THEREOF ARE PROVIDED WITHOUT EXPRESS PERMISSION.