

Dividing wall between flats within Block.

3/4" service pipe-work enters the flat through external wall.

3/4" service pipe-work runs at low level through toilet.


Internal wall between kitchen and toilet.



3/4" service pipe-work runs at low level through toilet into adjoining kitchen.

Dividing wall between flats within blocks. Utility void evident in this area.

3/4" service pipe-work runs within kitchen cupboards. Meters to be installed as indicated on floor plans and is dependent upon existing meter position.

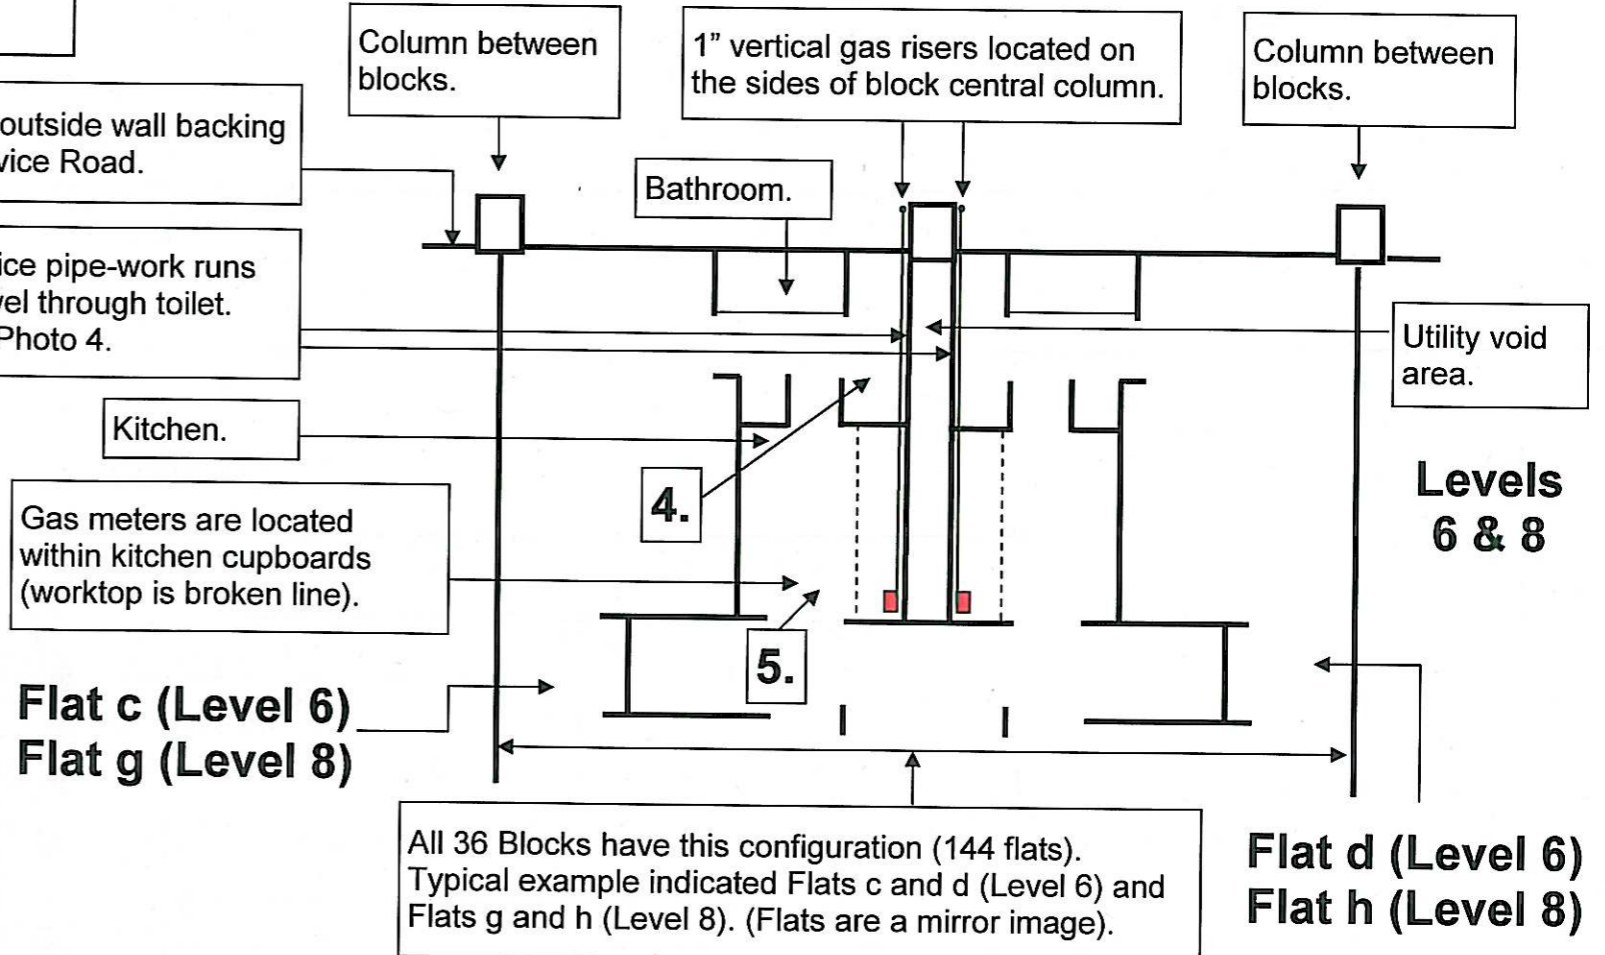

Blocks A, B, C, D & E, Rowley Way, NW8 (sheet 3 of 3).

Scale: 1:100

Proposed internal pipe-work and gas meter locations. To be read in conjunction with Capita drawing CS/055613 for Application Reference 2012/1718/L.