
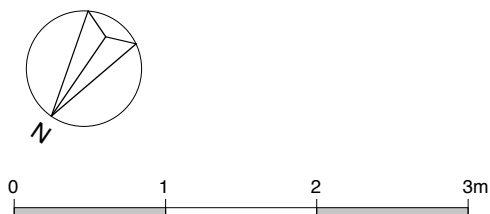


ELECTRICAL LEGEND	
	one way light switch
	two way light switch
	dimmer switch
	13A s.socket outlet (double)
	13A fused connection
	5A lighting socket outlet
	floor mounted socket
	shaver socket
	luminare (letter denot.type)
	TV FM socket outlet
	distribution fuseboard
	door operated switch
	heat detector
	thermostat
	fire alarm bell
	panic button
	telephone socket
	intercom socket
	audio/video socket
	pendant light
	recessed downlighter
	surface mounted light
	smoke detector
	wall recessed mini spotlight

New cavity wall of fairfaced reclaimed brickwork - to match existing, blockwork and plaster internally.

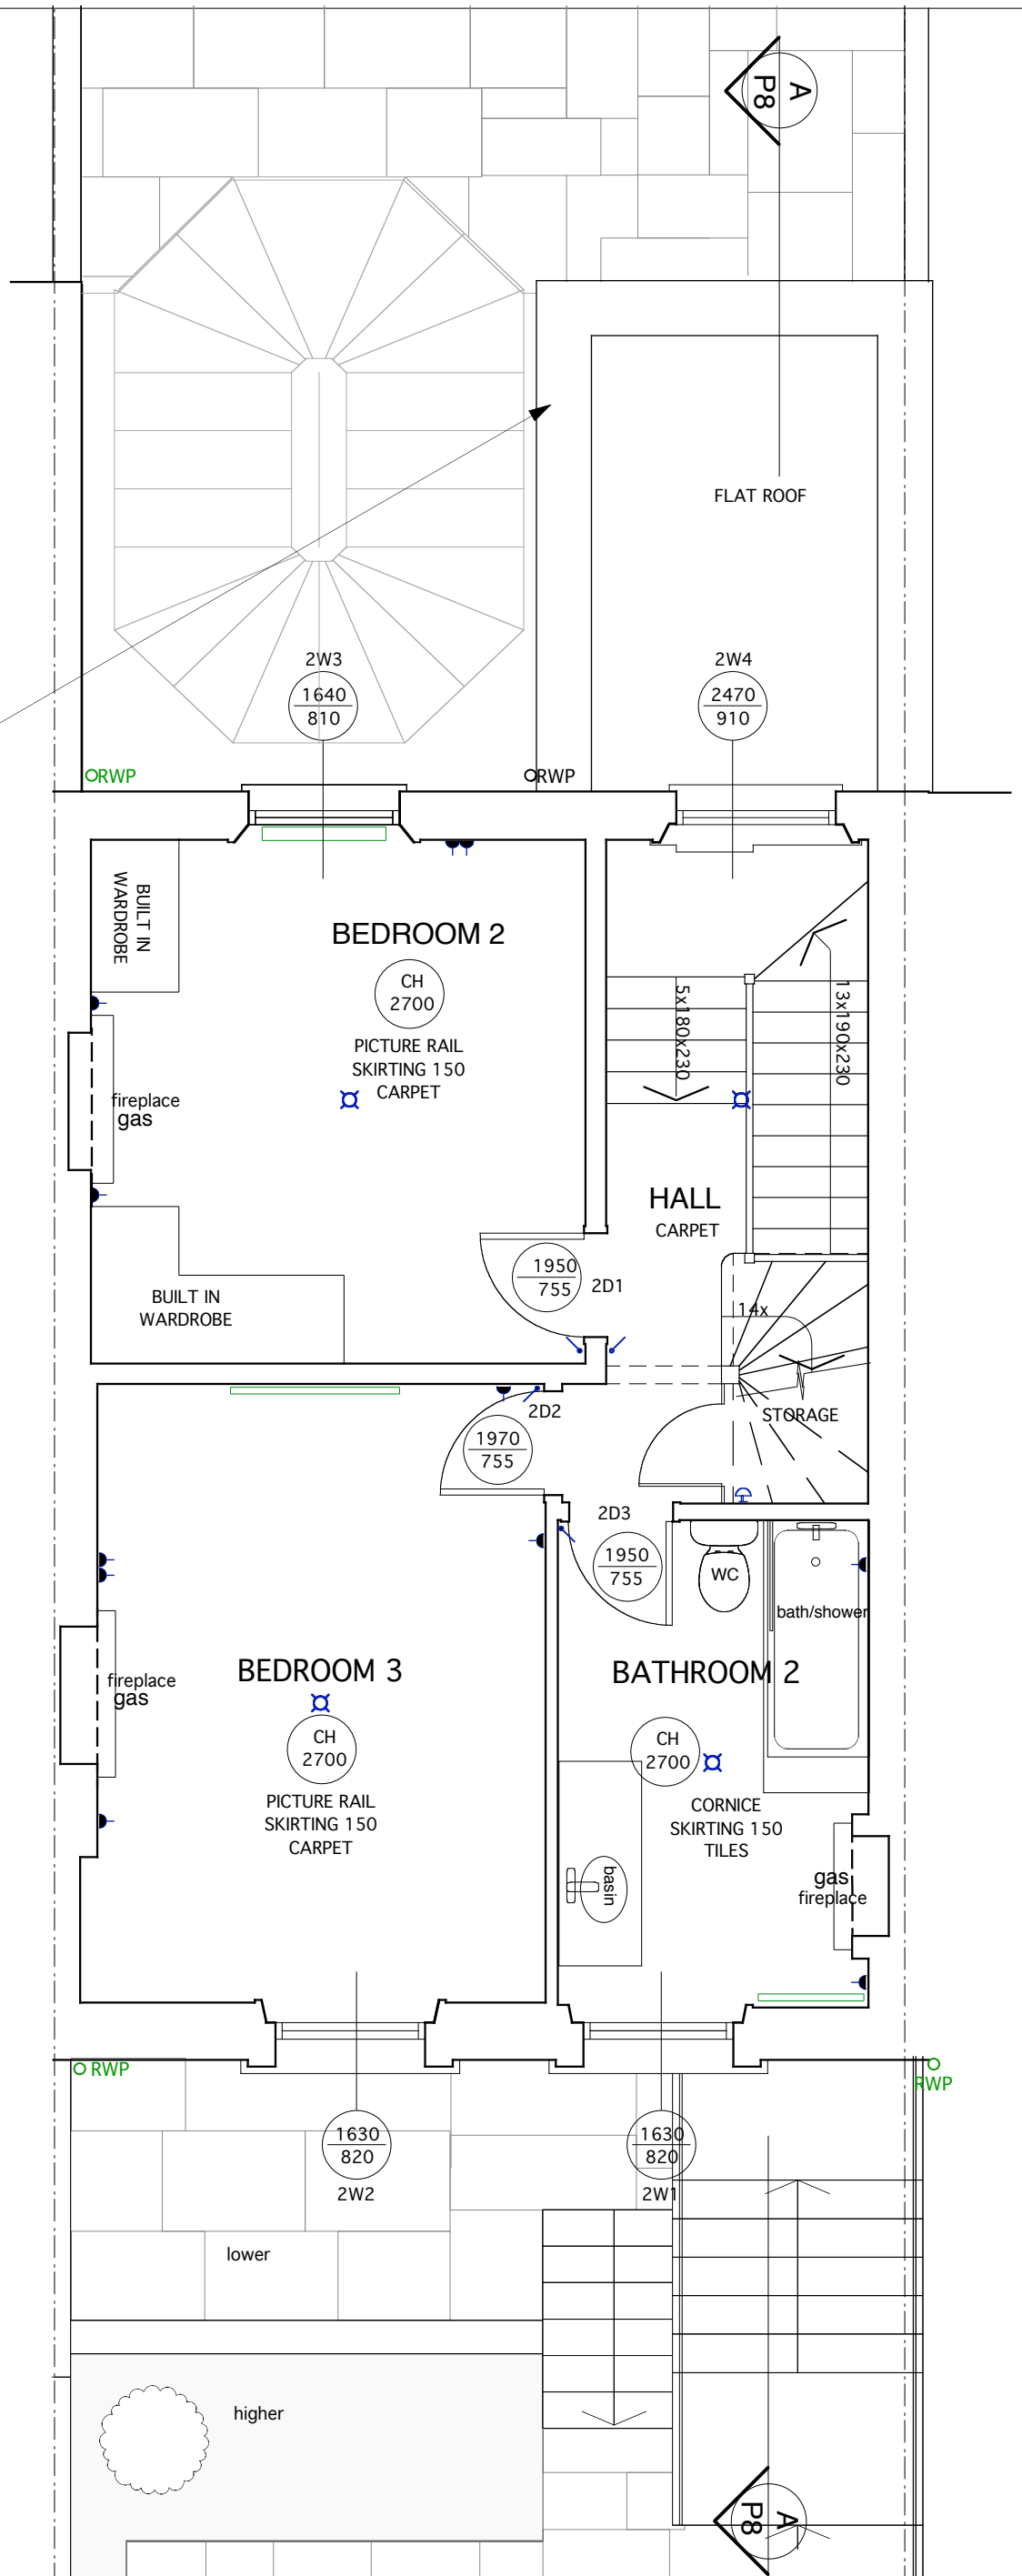

REV.A (03.02.2011) Drawing updated
REV.B (27.02.2012) Drawing updated.Planning issue.
REV.C (22.04.2012) Rear extension omitted. Planning issue.
REV.D (26.04.2012) Drawing revised Planning issue.

ALL DIMENSIONS
TO BE CHECKED ON SITE
DO NOT SCALE

DRAWING	SECOND FLOOR - PROPOSED
PROJECT	89 BELSIZE LANE MAIN
CLIENT	MR. & MRS. A. & J. BEECROFT

TAG
ARCHITECTS

TAG ARCHITECTS
14 BELSIZE CRESCENT, HAMPSTEAD, LONDON NW3 5QU
TEL : 020 7431 7974

DATE 01.12	SCALE 1:50 @A3
JOB 119	DRAWING P4D