




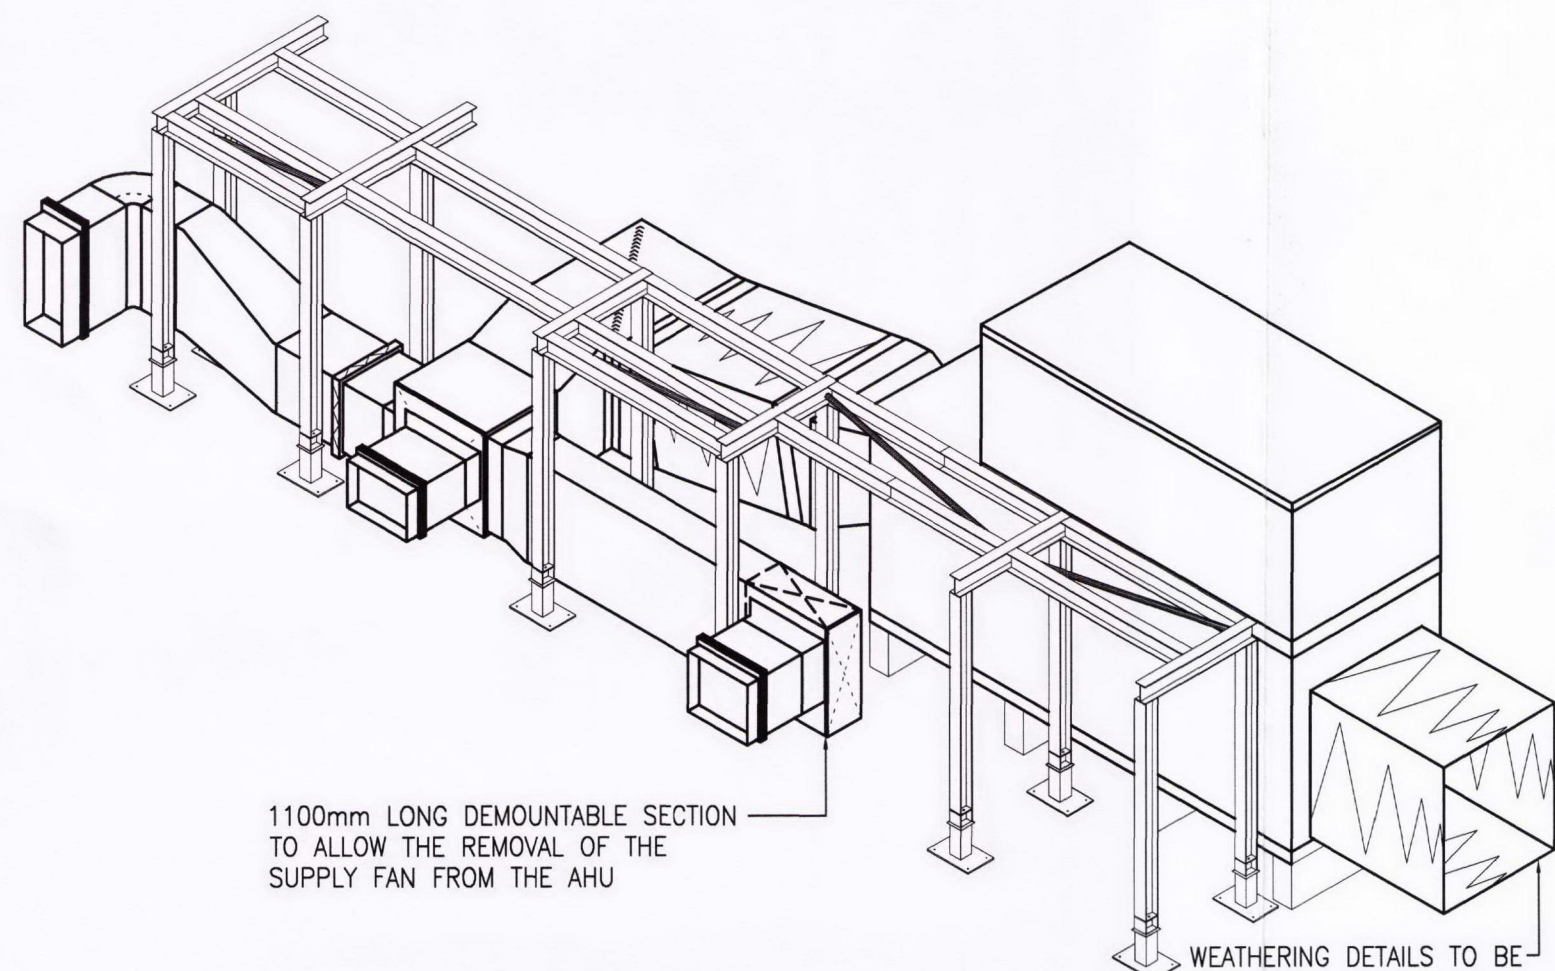


SUPPLY DUCTWORK ISOMETRIC

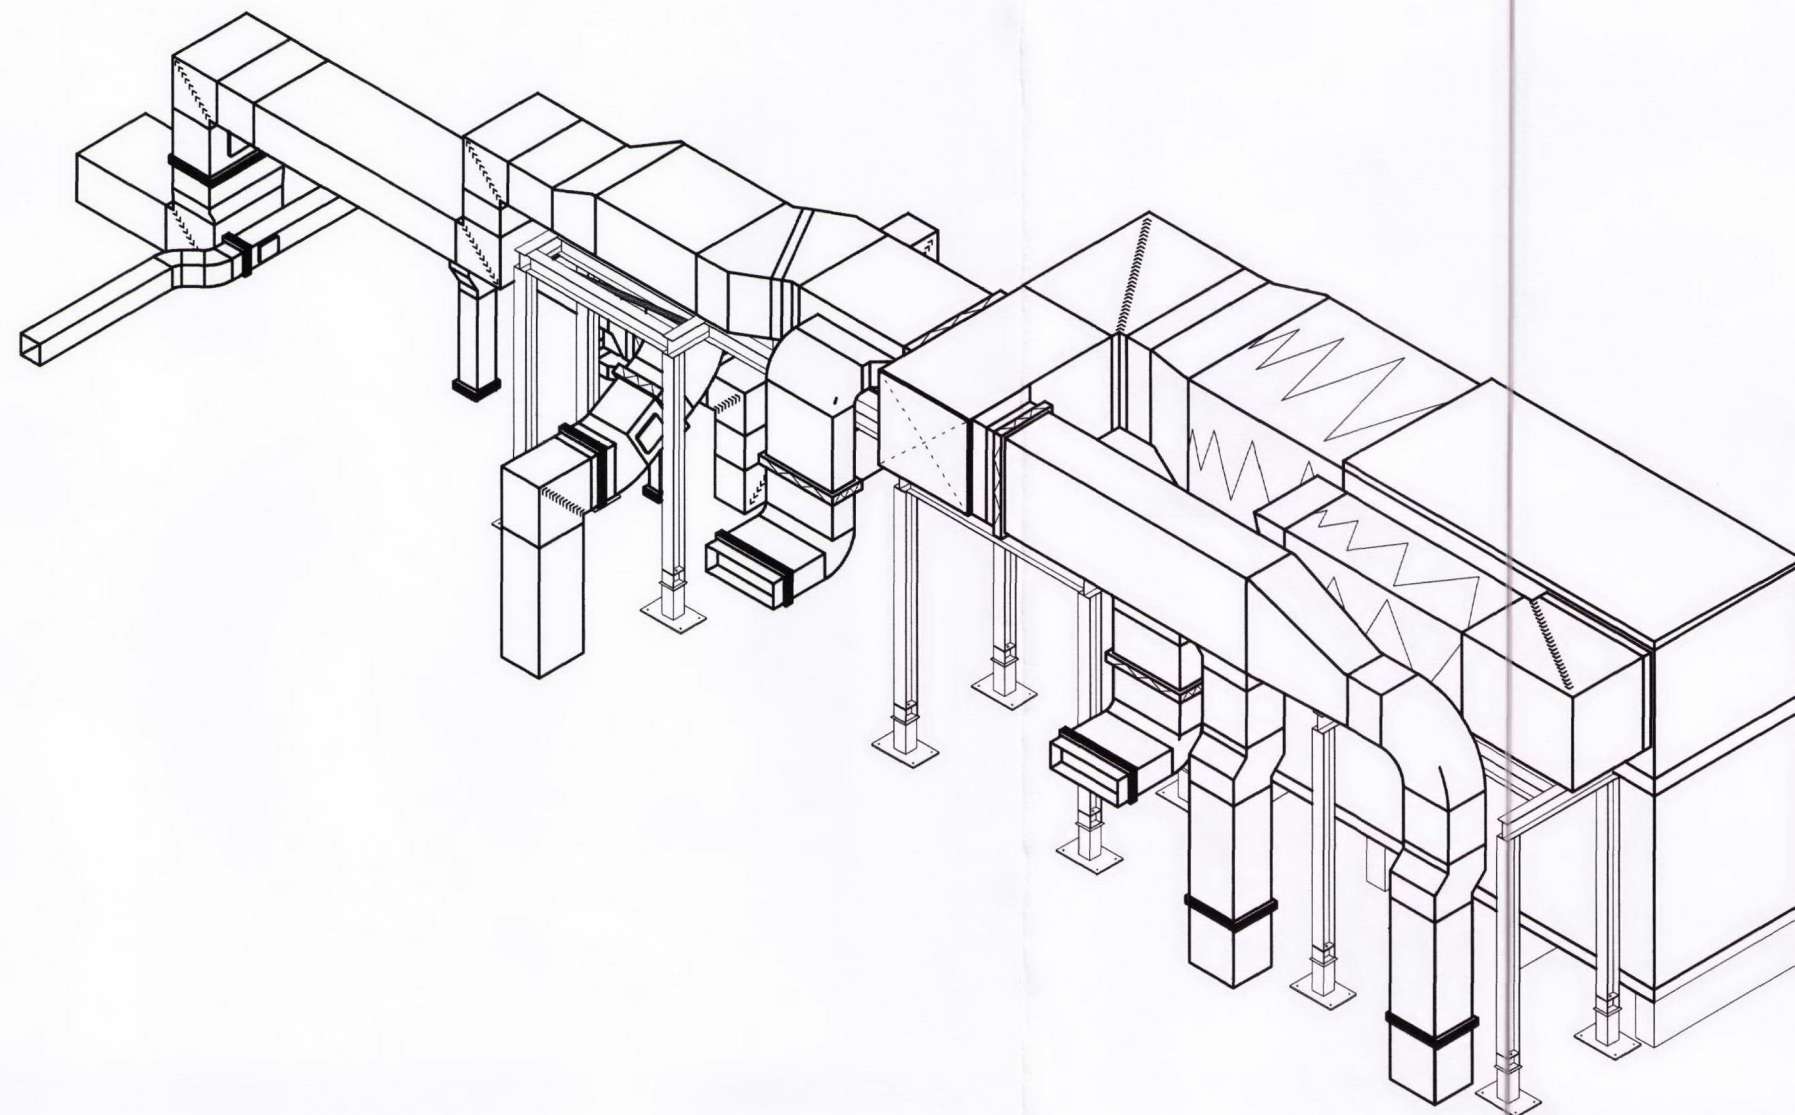

EXTRACT DUCTWORK ISOMETRIC

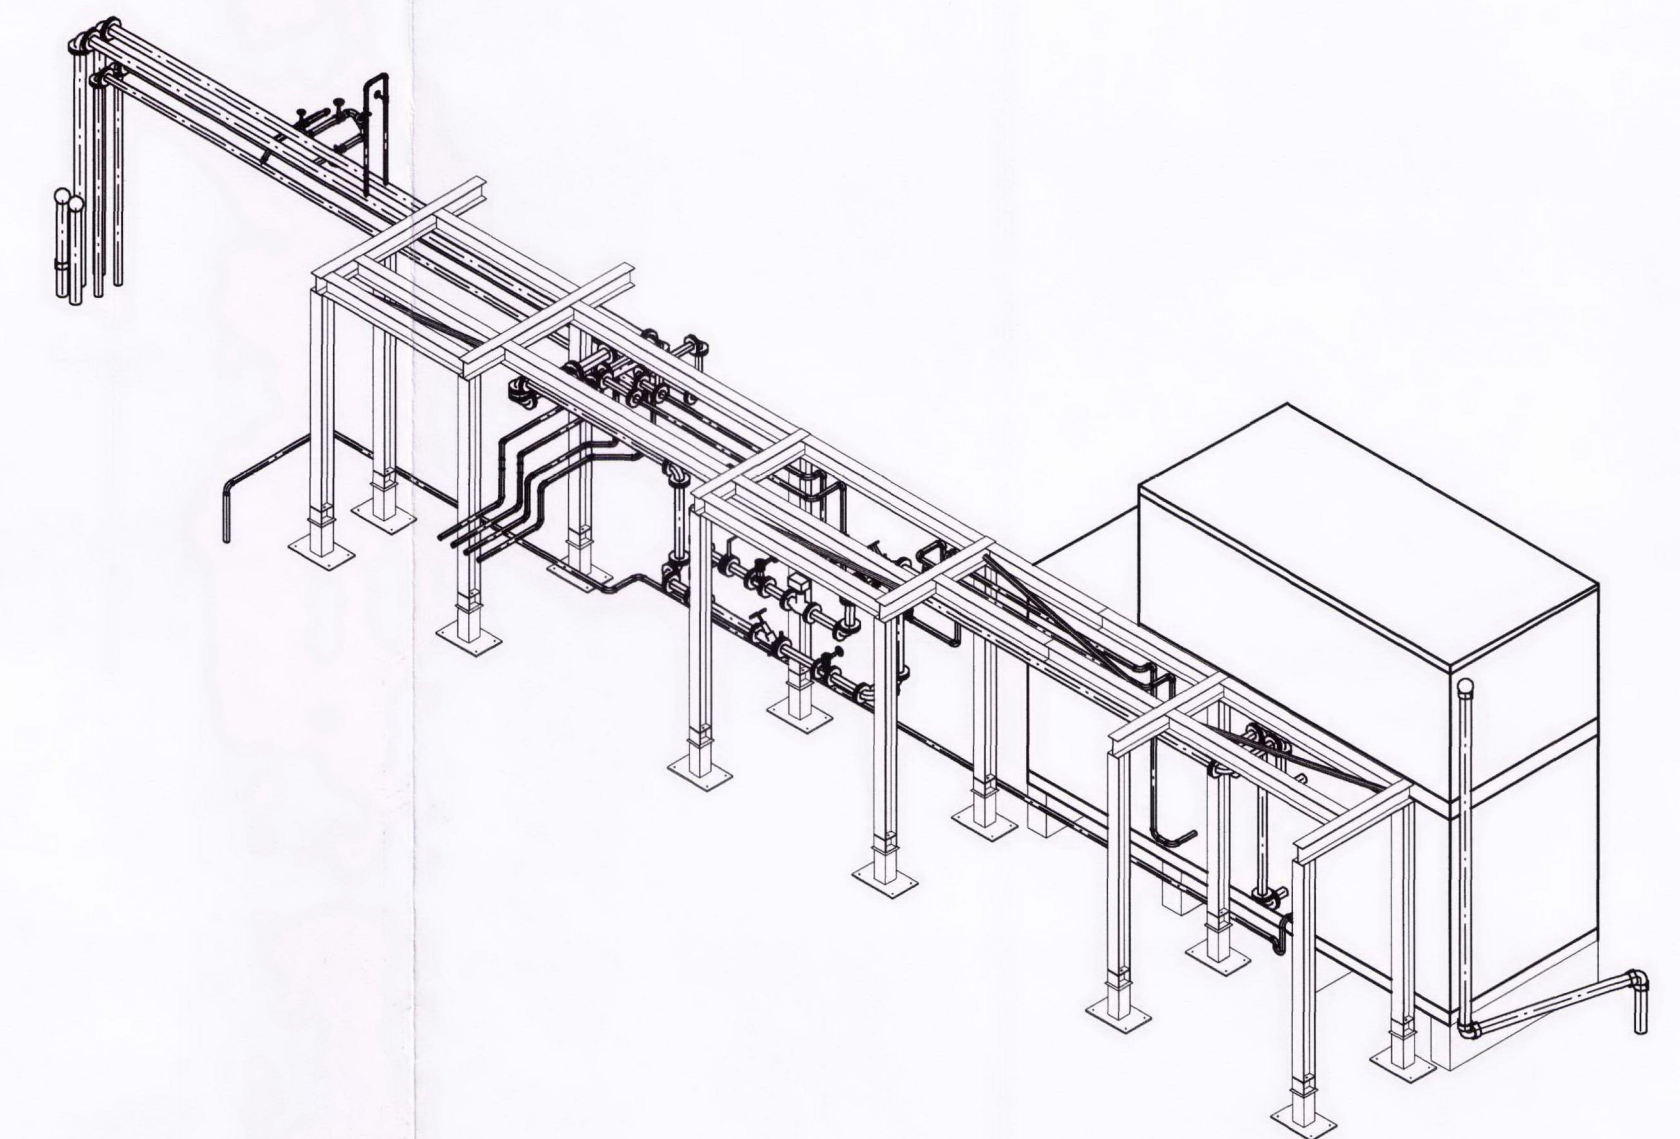

PIPEWORK ISOMETRIC

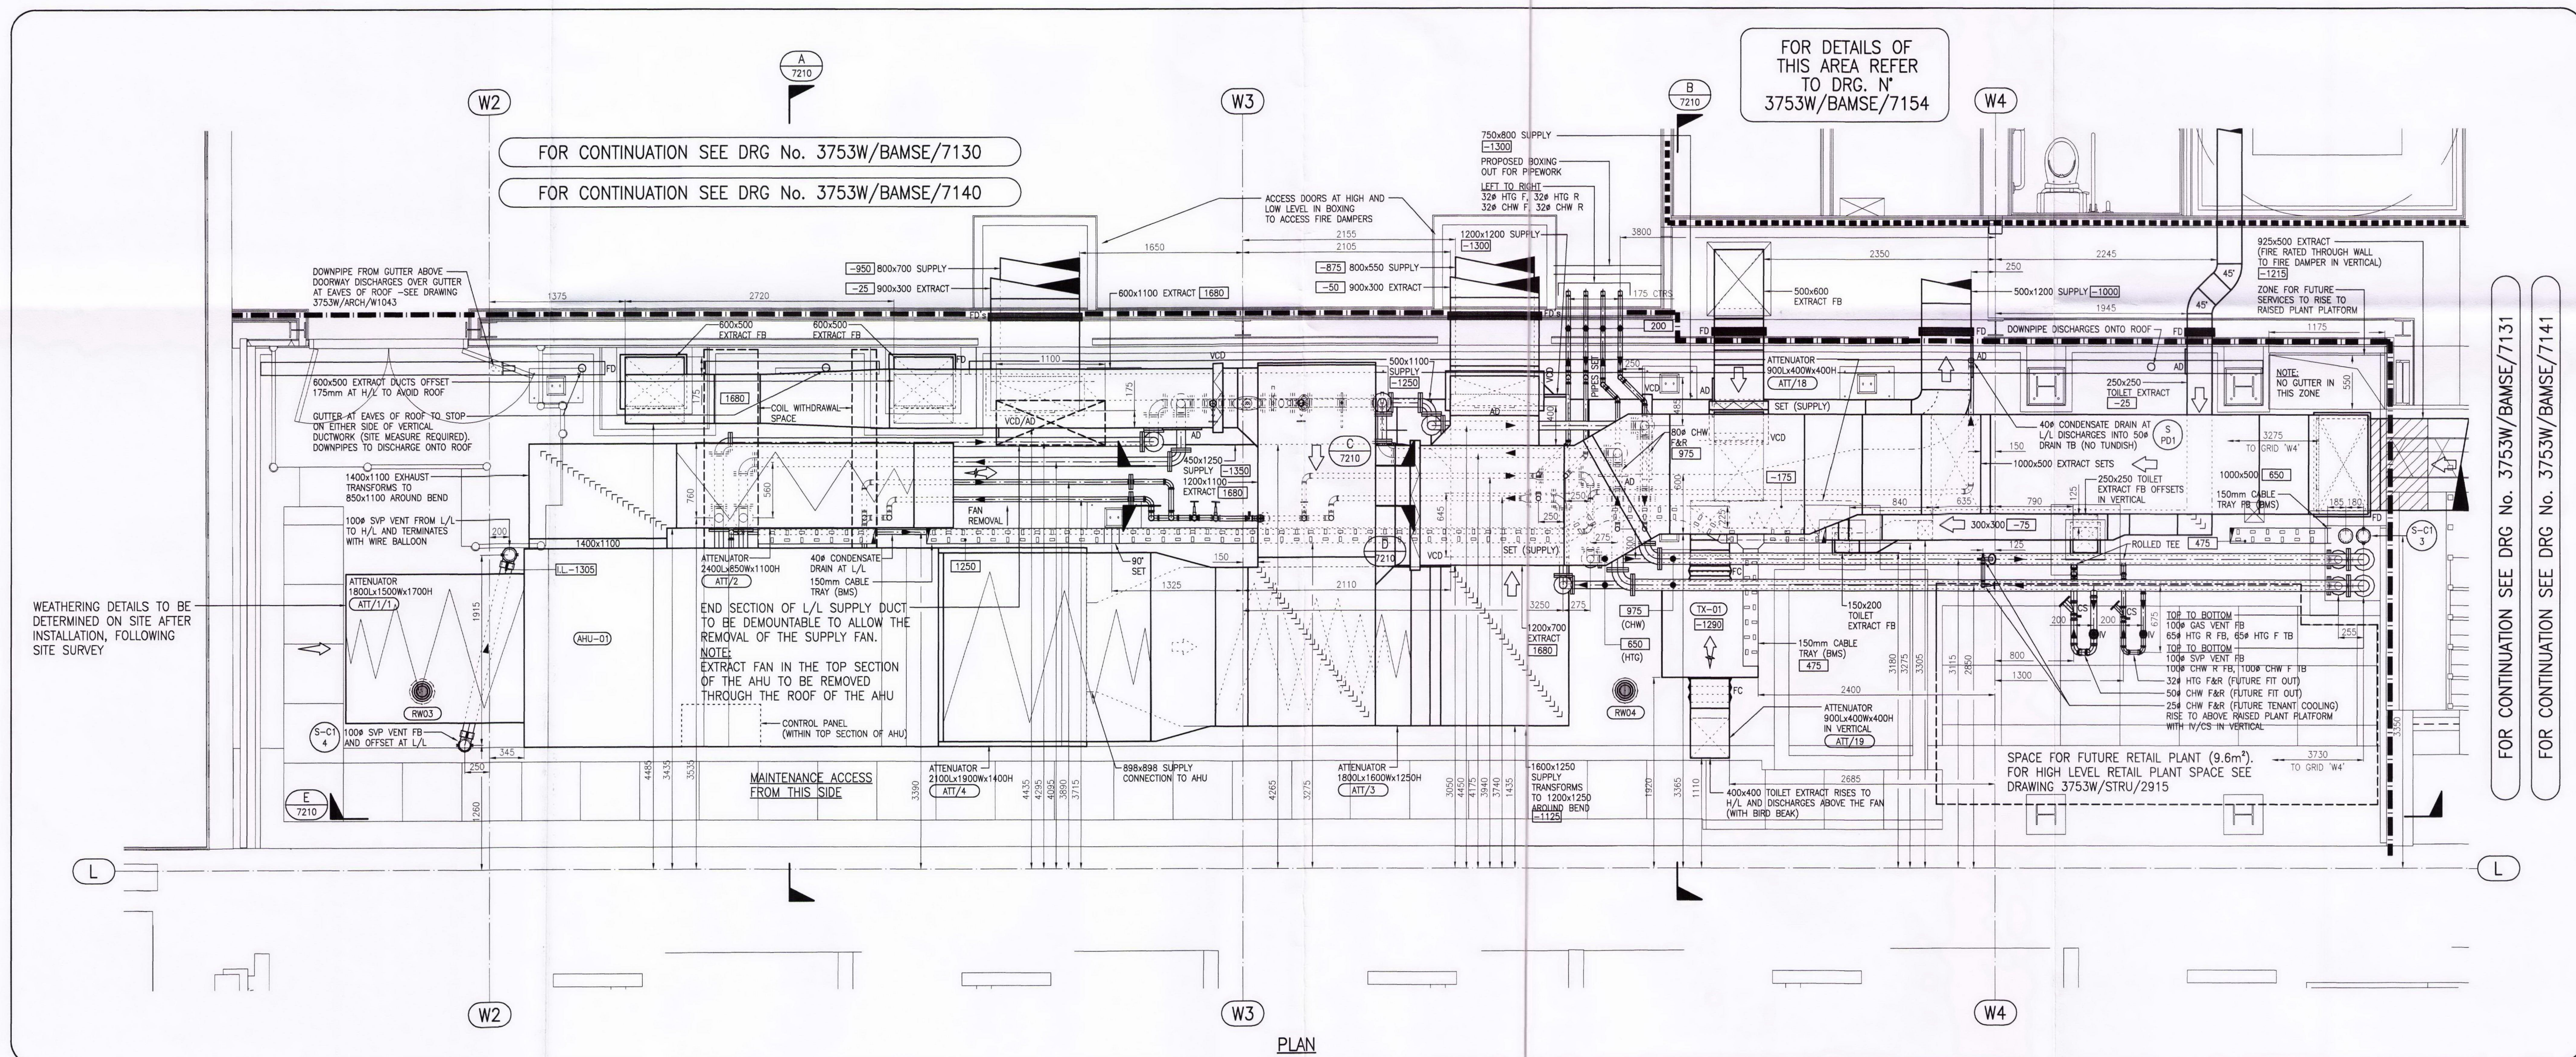


PLAN

- Notes:
1. FOR SYMBOLS LEGEND AND ABBREVIATIONS REFER TO DRAWING 3753W/BAMSE/7000.
 2. THIS DRAWING IS TO BE READ IN CONJUNCTION WITH THE ARCHITECTS & STRUCTURAL ENGINEERS DRAWINGS, THE PROJECT SCHEDULES & SPECIFICATIONS.
 3. THIS DRAWING IS TO BE READ IN CONJUNCTION WITH THE RELEVANT DETAILS & SCHEMATICS. REFER TO DRAWING NUMBERS 3753W/BAMSE/7001 - 7049.
 4. DRAIN COCKS TO BE FITTED ON ALL LOW POINTS & AIR VENTS FITTED ON ALL HIGH POINTS OF LTHW PIPEWORK.

SOFFIT LEVEL	N/A
CEILING LEVEL	N/A
DATUM LEVEL	33.789
FINISHED FLOOR LEVEL	VARIES
STRUCTURAL SLAB LEVEL	VARIES

SERVICES DATUM LEVELS
ALL SERVICES ABOVE DATUM DENOTED THUS: -
[1000] DISTANCE IN mm TO U/S OF RECTANGULAR &
FLAT OVAL DUCTS, ELECTRICAL BUSBARS,
CABLE LADDERS, TRAYS, TRUNKING, & Ø OF CIRC
DUCTS & PIPEWORK. LEVELS PREFIXED L.L. INDICATES
INVERT LEVEL OF SOIL, GRAVITY RAINWATER &
CONDENSATE PIPE ABOVE DATUM LEVEL.

CD	BS	29/02/12	JC	ISSUED FOR CONSTRUCTION. CMT COMMENTS INCORPORATED
CD	BS	20/01/12	JC	ISSUED FOR DRAFT CONSTRUCTION. DESIGN TEAM COMMENTS INCORPORATED
APD	PLM	14/10/11	JC	ISSUED FOR APPROVAL
REV	by	date	chkd	amendments

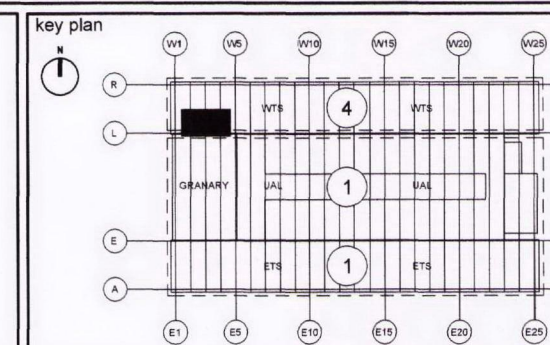

Environmental Services
Cost Planning
Feasibility Studies
3D Visualisation



project
**ARGENT ESTATES Ltd
KINGS CROSS - CONTRACT 4
WESTERN TRANSIT SHED**

title
**SECOND FLOOR PLANT DECK
CO-ORDINATED SERVICES
LAYOUT SHEET 1 of 5**

drawing status
CONSTRUCTION

contract no.	LN0217	scale	1:25 @ A0
client ref.		date	Dec.11
drawn by	BS	checked by	JC
drawing no.	3753W	BAMSE	7200
			CO