
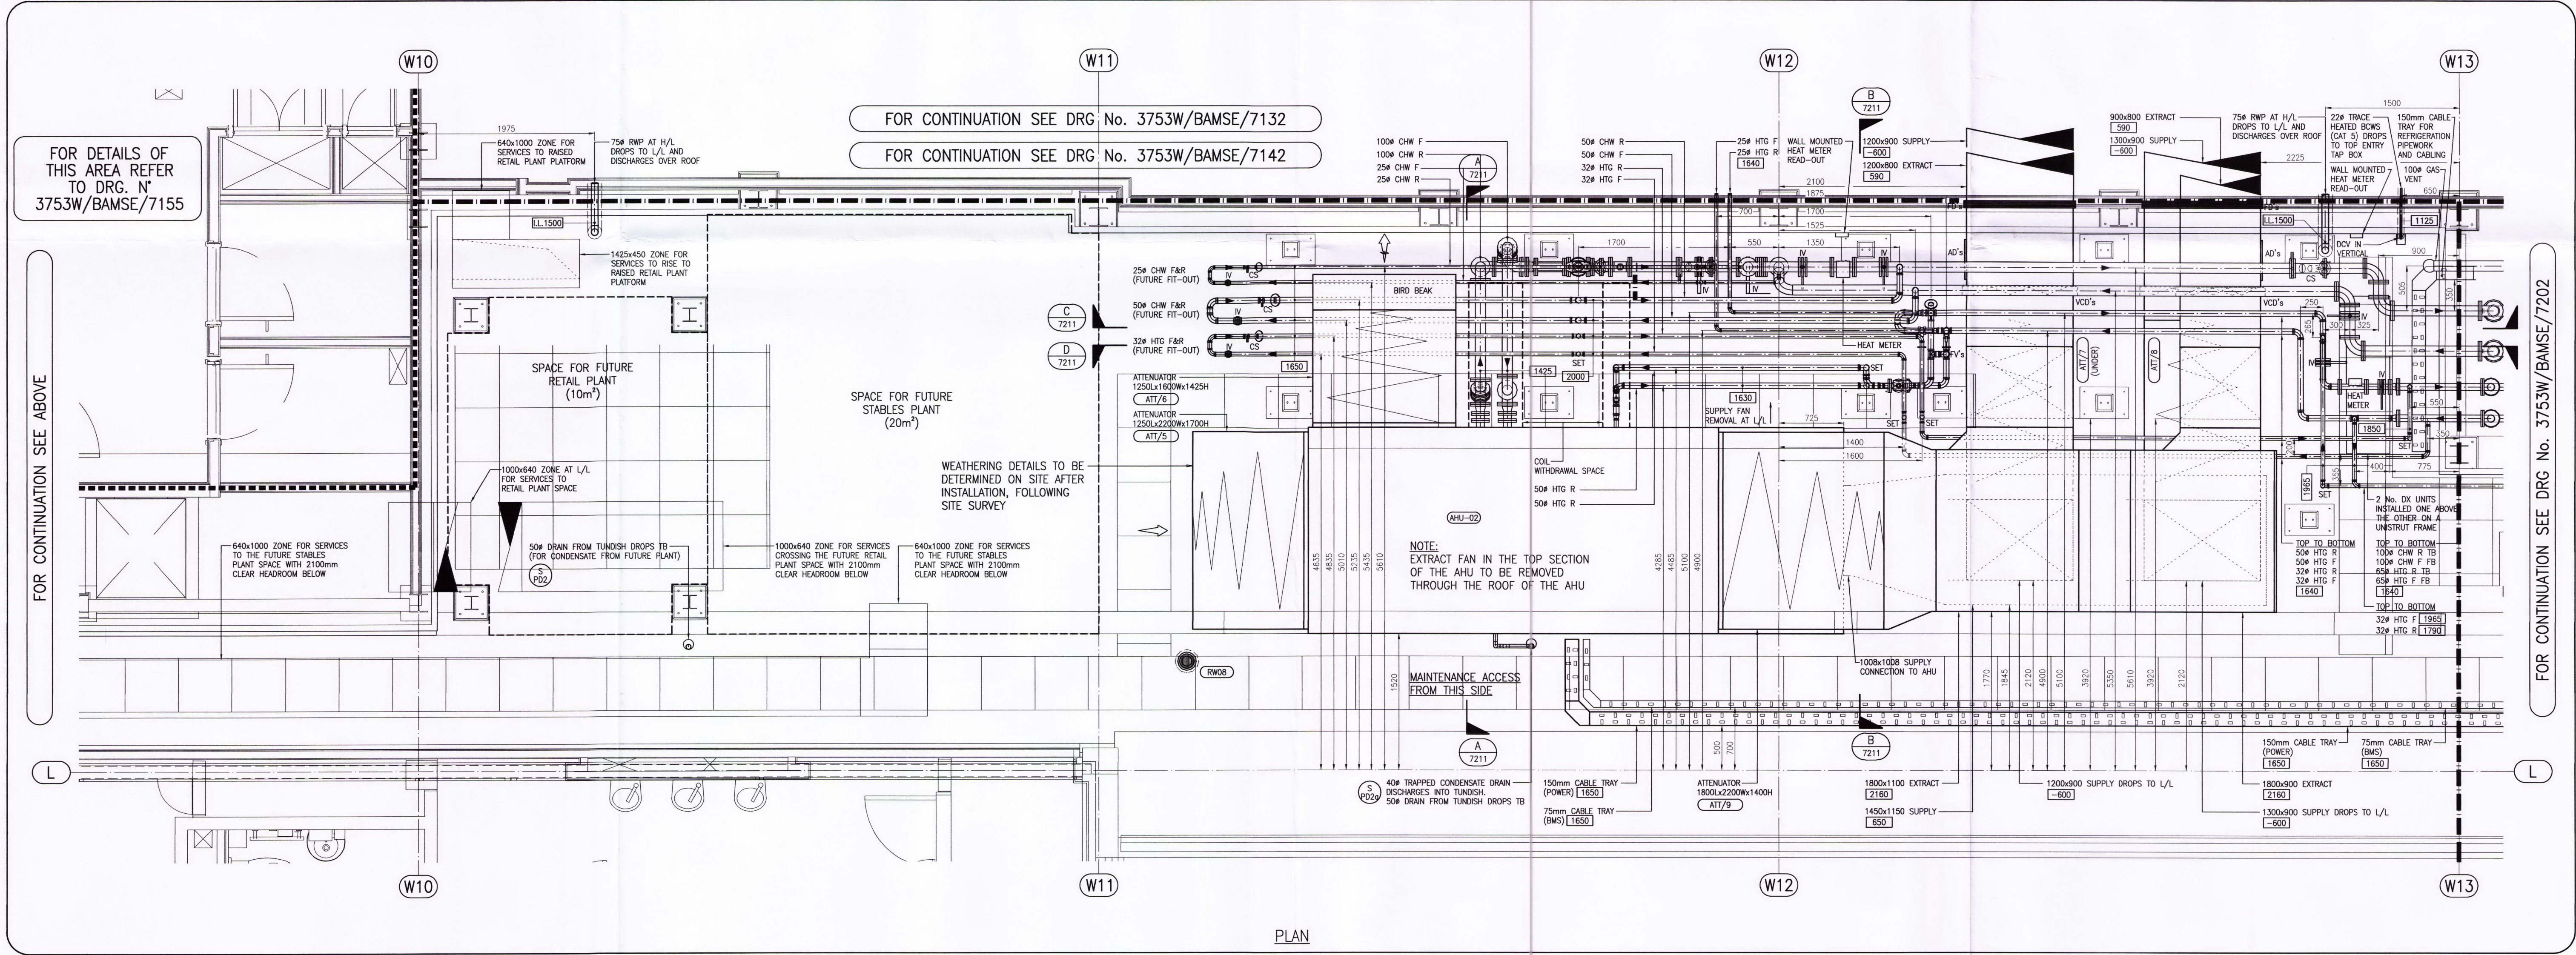
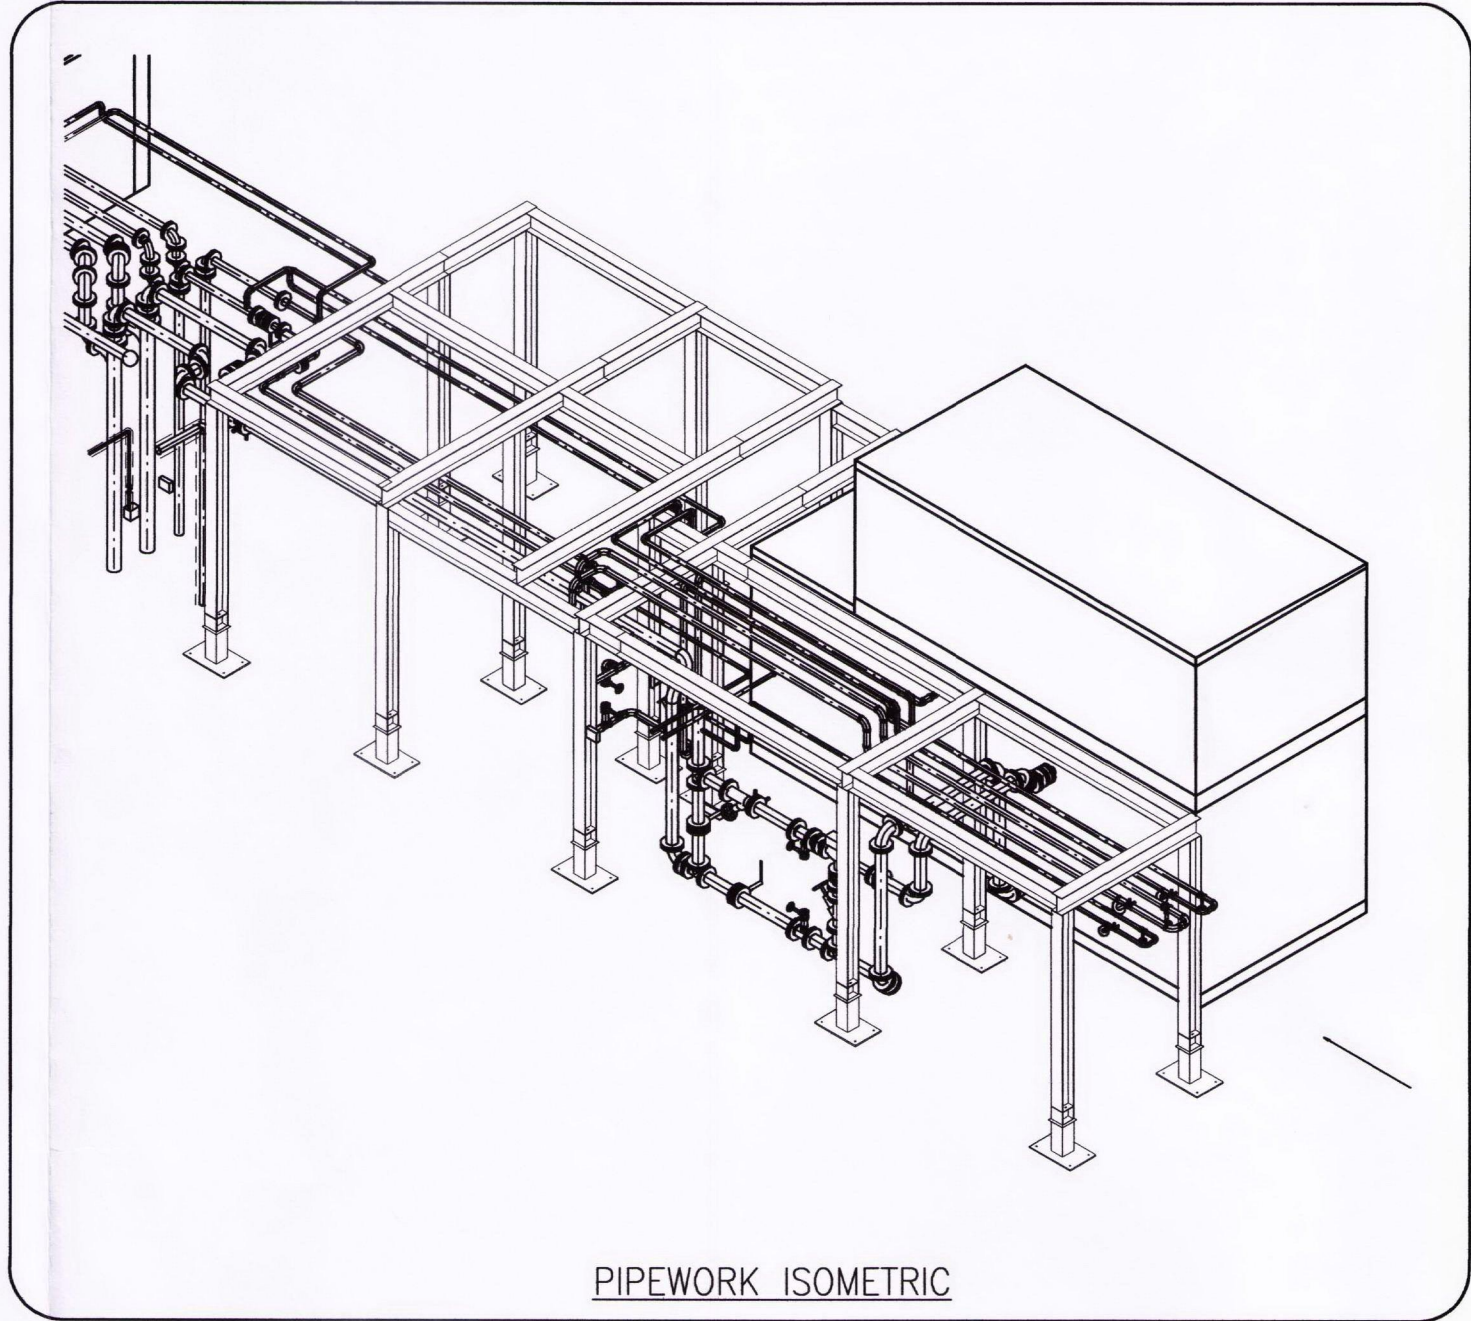
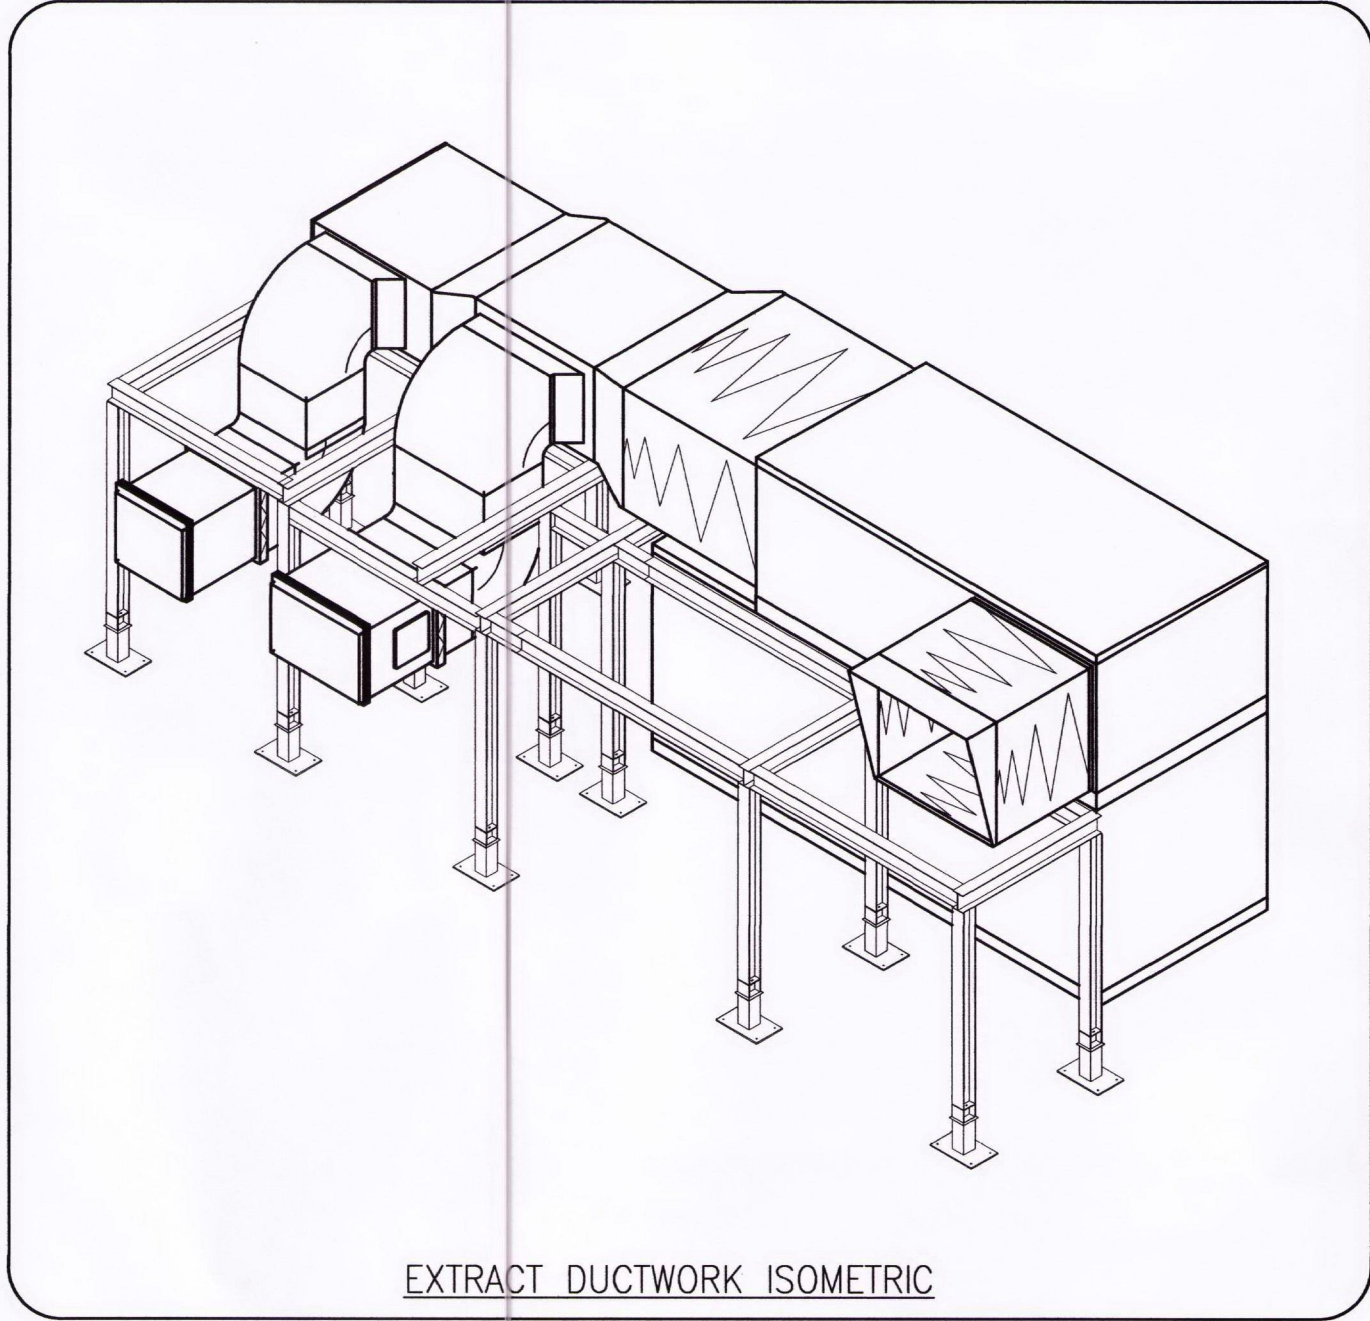
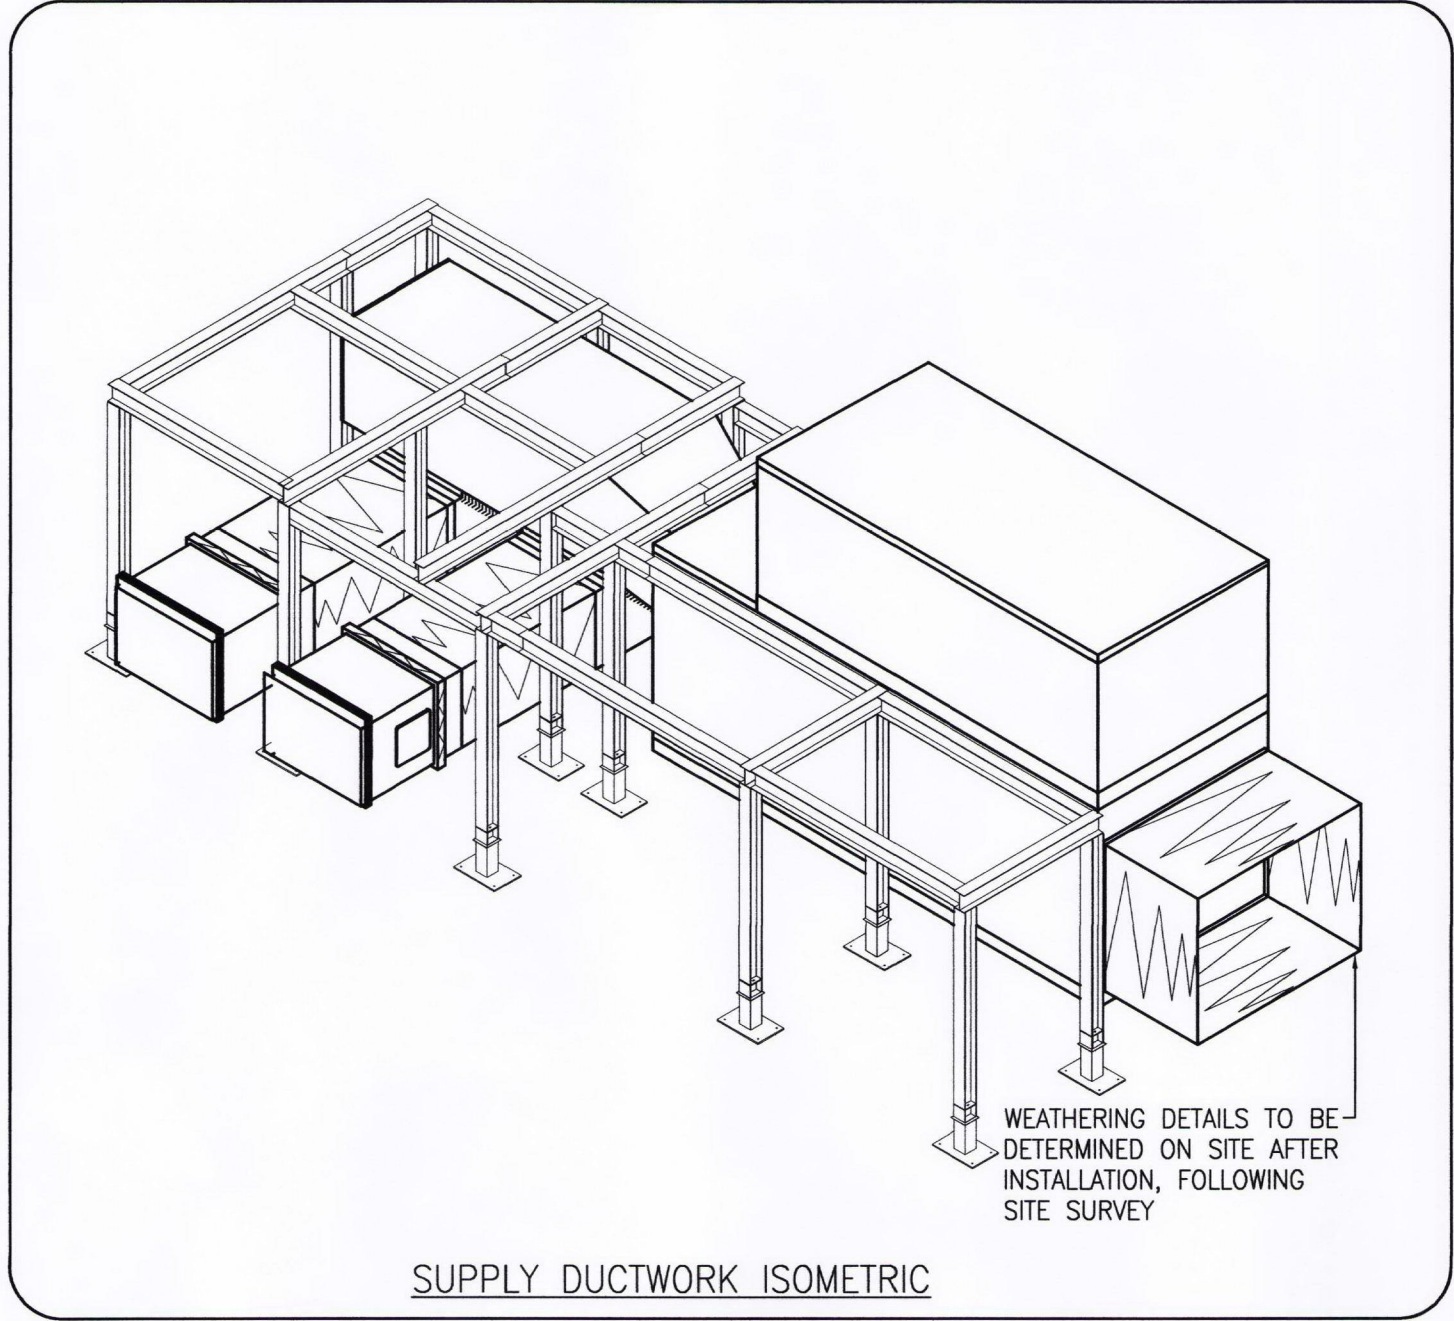


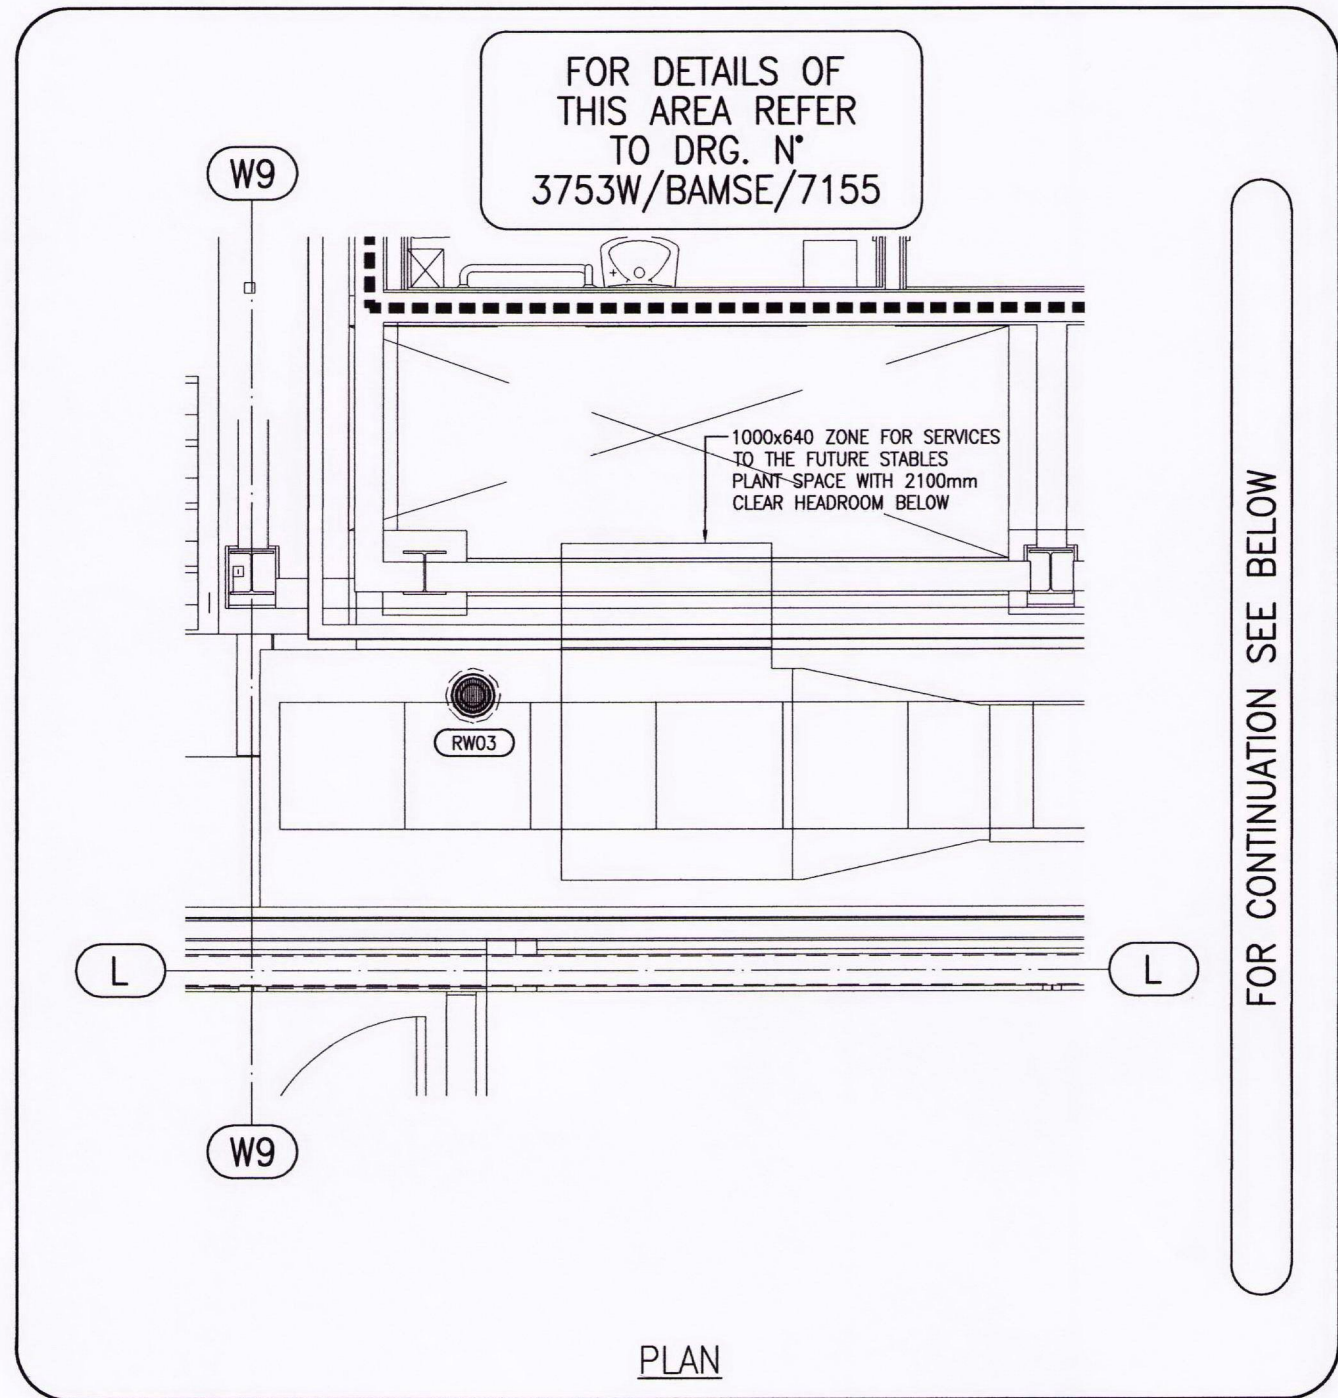


Notes:

- FOR SYMBOLS LEGEND AND ABBREVIATIONS REFER TO DRAWING 3753W/BAMSE/7000.
- THIS DRAWING IS TO BE READ IN CONJUNCTION WITH THE ARCHITECTS & STRUCTURAL ENGINEERS DRAWINGS, THE PROJECT SCHEDULES & SPECIFICATIONS.
- THIS DRAWING IS TO BE READ IN CONJUNCTION WITH THE RELEVANT DETAILS & SCHEMATICS. REFER TO DRAWING NUMBERS 3753W/BAMSE/7001 - 7049.
- DRAIN COCKS TO BE FITTED ON ALL LOW POINTS & AIR VENTS FITTED ON ALL HIGH POINTS OF LTHW PIPEWORK.

SOFFIT LEVEL	N/A
CEILING LEVEL	N/A
DATUM LEVEL	33.789
FINISHED FLOOR LEVEL	VARIABLE
STRUCTURAL SLAB LEVEL	VARIABLE

SERVICES DATUM LEVELS
ALL SERVICES ABOVE DATUM DENOTED THUS: -
[1000] DISTANCE IN mm TO U/S OF RECTANGULAR & FLAT DUAL DUCTS, ELECTRICAL BUSBARS, CABLE LADDERS, TRAYS, TRUNKING, & 6 OF CIRC DUCTS & PIPEWORK. LEVELS PREFIXED LL INDICATES INVERT LEVEL OF SOIL, GRAVITY RAINWATER & CONDENSATE PIPE ABOVE DATUM LEVEL.

CO	BS	29/02/12		ISSUED FOR CONSTRUCTION. CMT COMMENTS INCORPORATED
DD	BS	27/01/12	JC	ISSUED FOR DRAFT CONSTRUCTION. DESIGN TEAM COMMENTS INCORPORATED
APD	RJM	21/12/11	JC	ISSUED FOR APPROVAL
rev	by	date	chkd	amendments

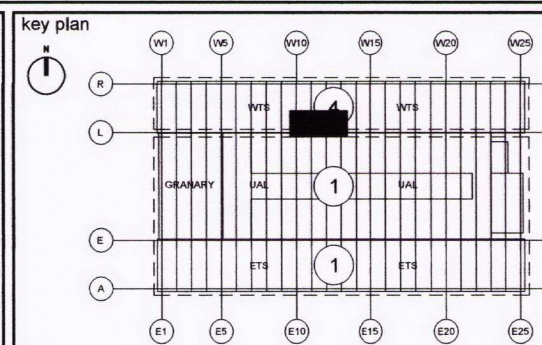

bam
Services Engineering

Environmental Services
Cost Planning
Feasibility Studies
3D Visualisation

Centrum
Guthrie Way, St Albans
Herts, AL1 2SD
Tel: 01763 296000
www.bam.co.uk

project
**ARGENT ESTATES Ltd
KINGS CROSS - CONTRACT 4
WESTERN TRANSIT SHED**

title
**SECOND FLOOR PLANT DECK
CO-ORDINATED SERVICES
LAYOUT SHEET 2 of 5**

drawing status CONSTRUCTION	
contract no. LN0217	scale 1:25 @ A0
client ref.	date Dec'11
drawn by BS	checked by JC
drawing no. 3753W	BAMSE
7201	C0