


NOTES:


This drawing is the copyright of DPCE and may not be copied, altered, or reproduced in any form or passed to a third party without their prior consent. Dimensions to be checked on site before commencing work. Any discrepancies shall be reported to the project architect immediately.

Do not scale from these drawings except for planning purposes. Use figured dimensions only.

Where applicable this drawing is to be read in conjunction with other consultants' drawings. All dimensions are in millimetres unless otherwise stated

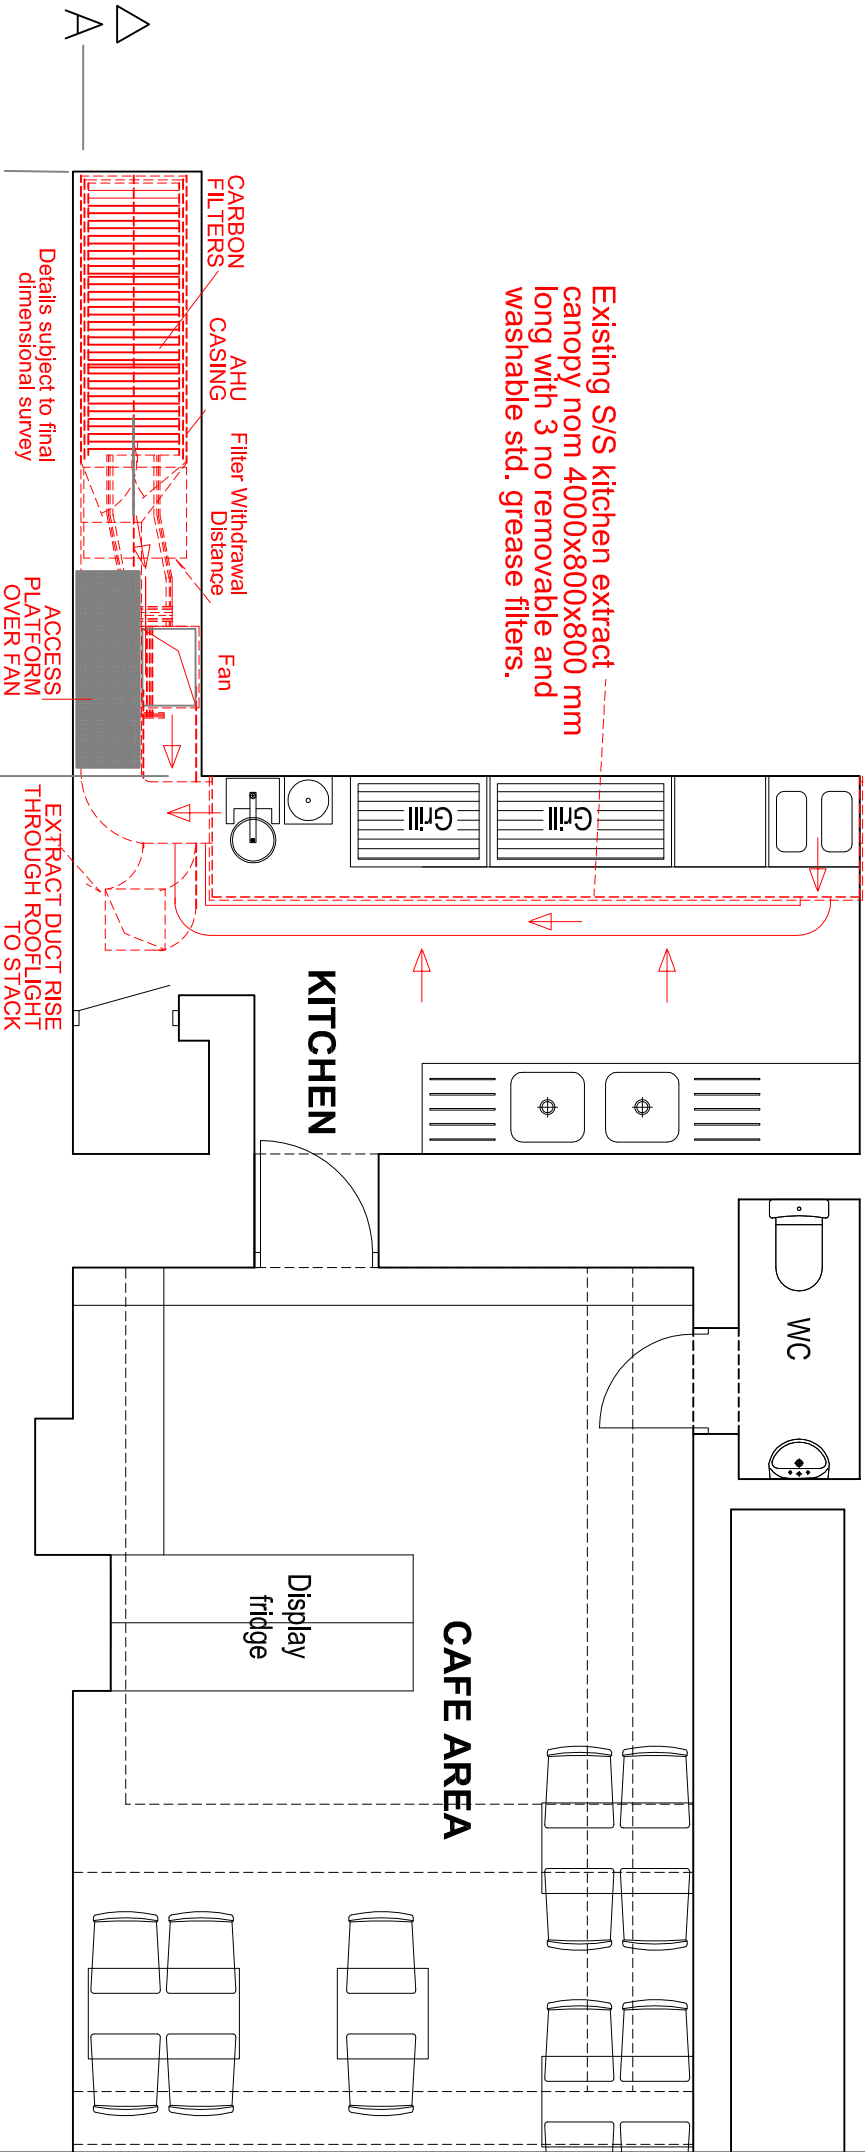

GROUND FLOOR PLAN SCALE 1: 100 @ A3

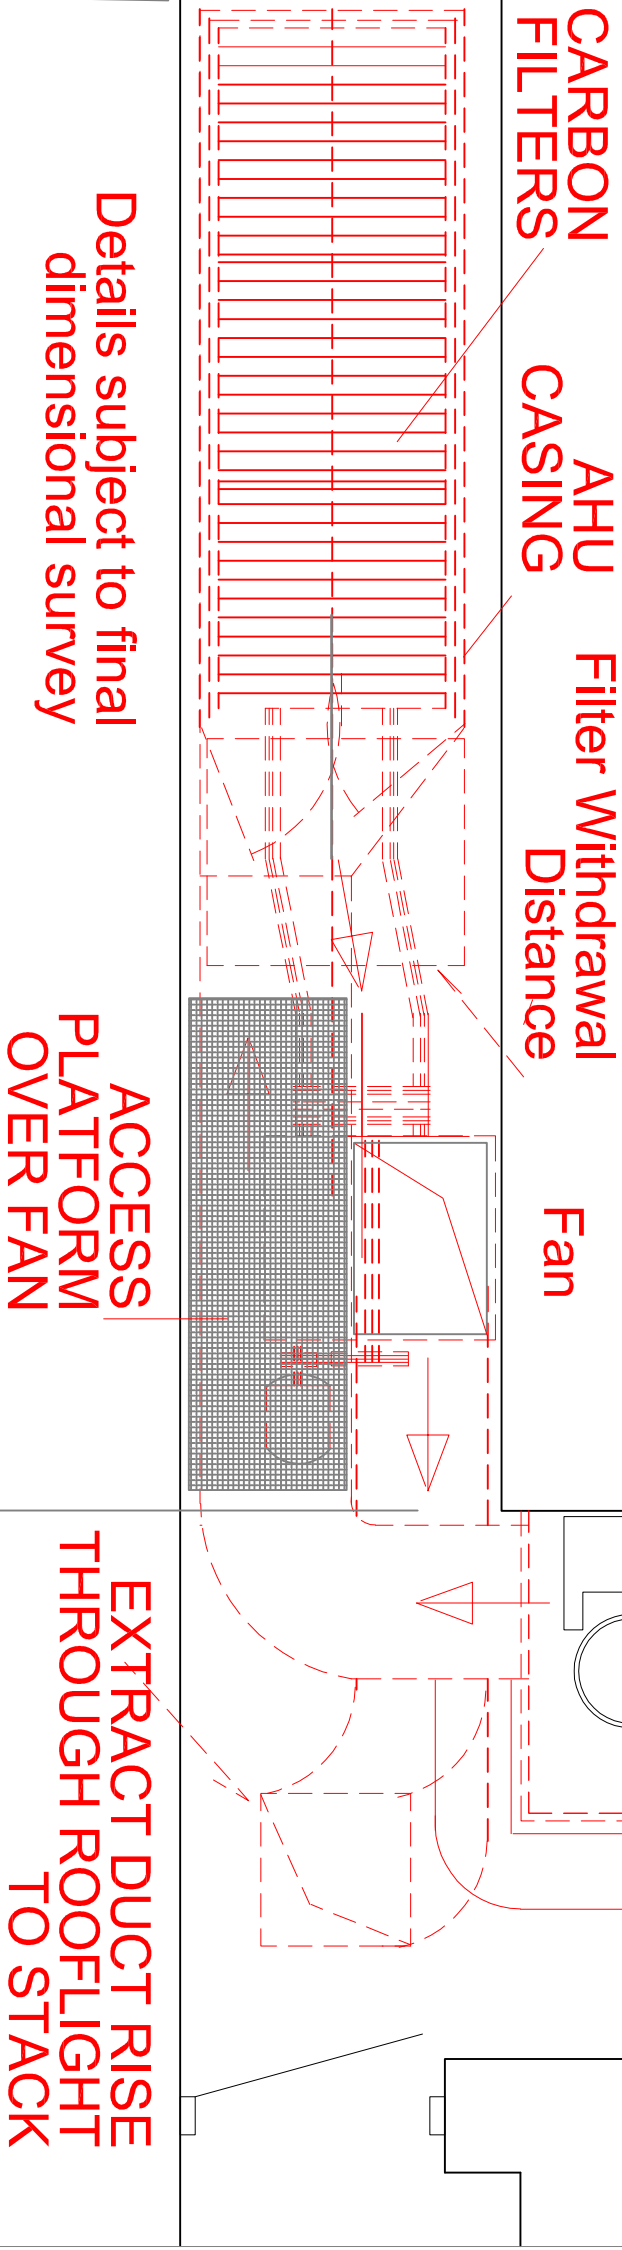

Details subject to final dimensional survey

EXTRACT DUCT RISE THROUGH ROOFLIGHT TO STACK

PLANT AREA DETAIL - SCALE 1:50 @A3

Issue: FOR PLANNING APPROVAL

Rev	Date	Amendment	Checked
-----	------	-----------	---------

**Douglas Price**  
Chartered Engineer & Surveyors  
Planning Supervisors - Project Managers  
Trent, Chelmsford Avenue, Chelmsford, Essex, CM1 3BB  
Telephone: 01246 776534 Fax: 01246 776662  
Email: enquiries@dpconsultants.co.uk

Contractor

Architects

Project Managers

For  
MR AYTHAN OVER

Project  
REVISED KITCHEN EXTRACT SYSTEM  
CRYSTAL CAFE  
66 MANSFIELD ROAD  
WEST SUSSEX  
HAMPTSTEAD

Drawing  
PROPOSED PLANT LAYOUT  
FOR PLANNING APPROVAL

Scale: 1:100 & 1:50 @ A3

Date 11/03/2017	Drawn JDP	Checked JDP/DPF	Scale: 1:100 & 1:50 @ A3
Job number 1011	Drawing number P	Revision 03	