


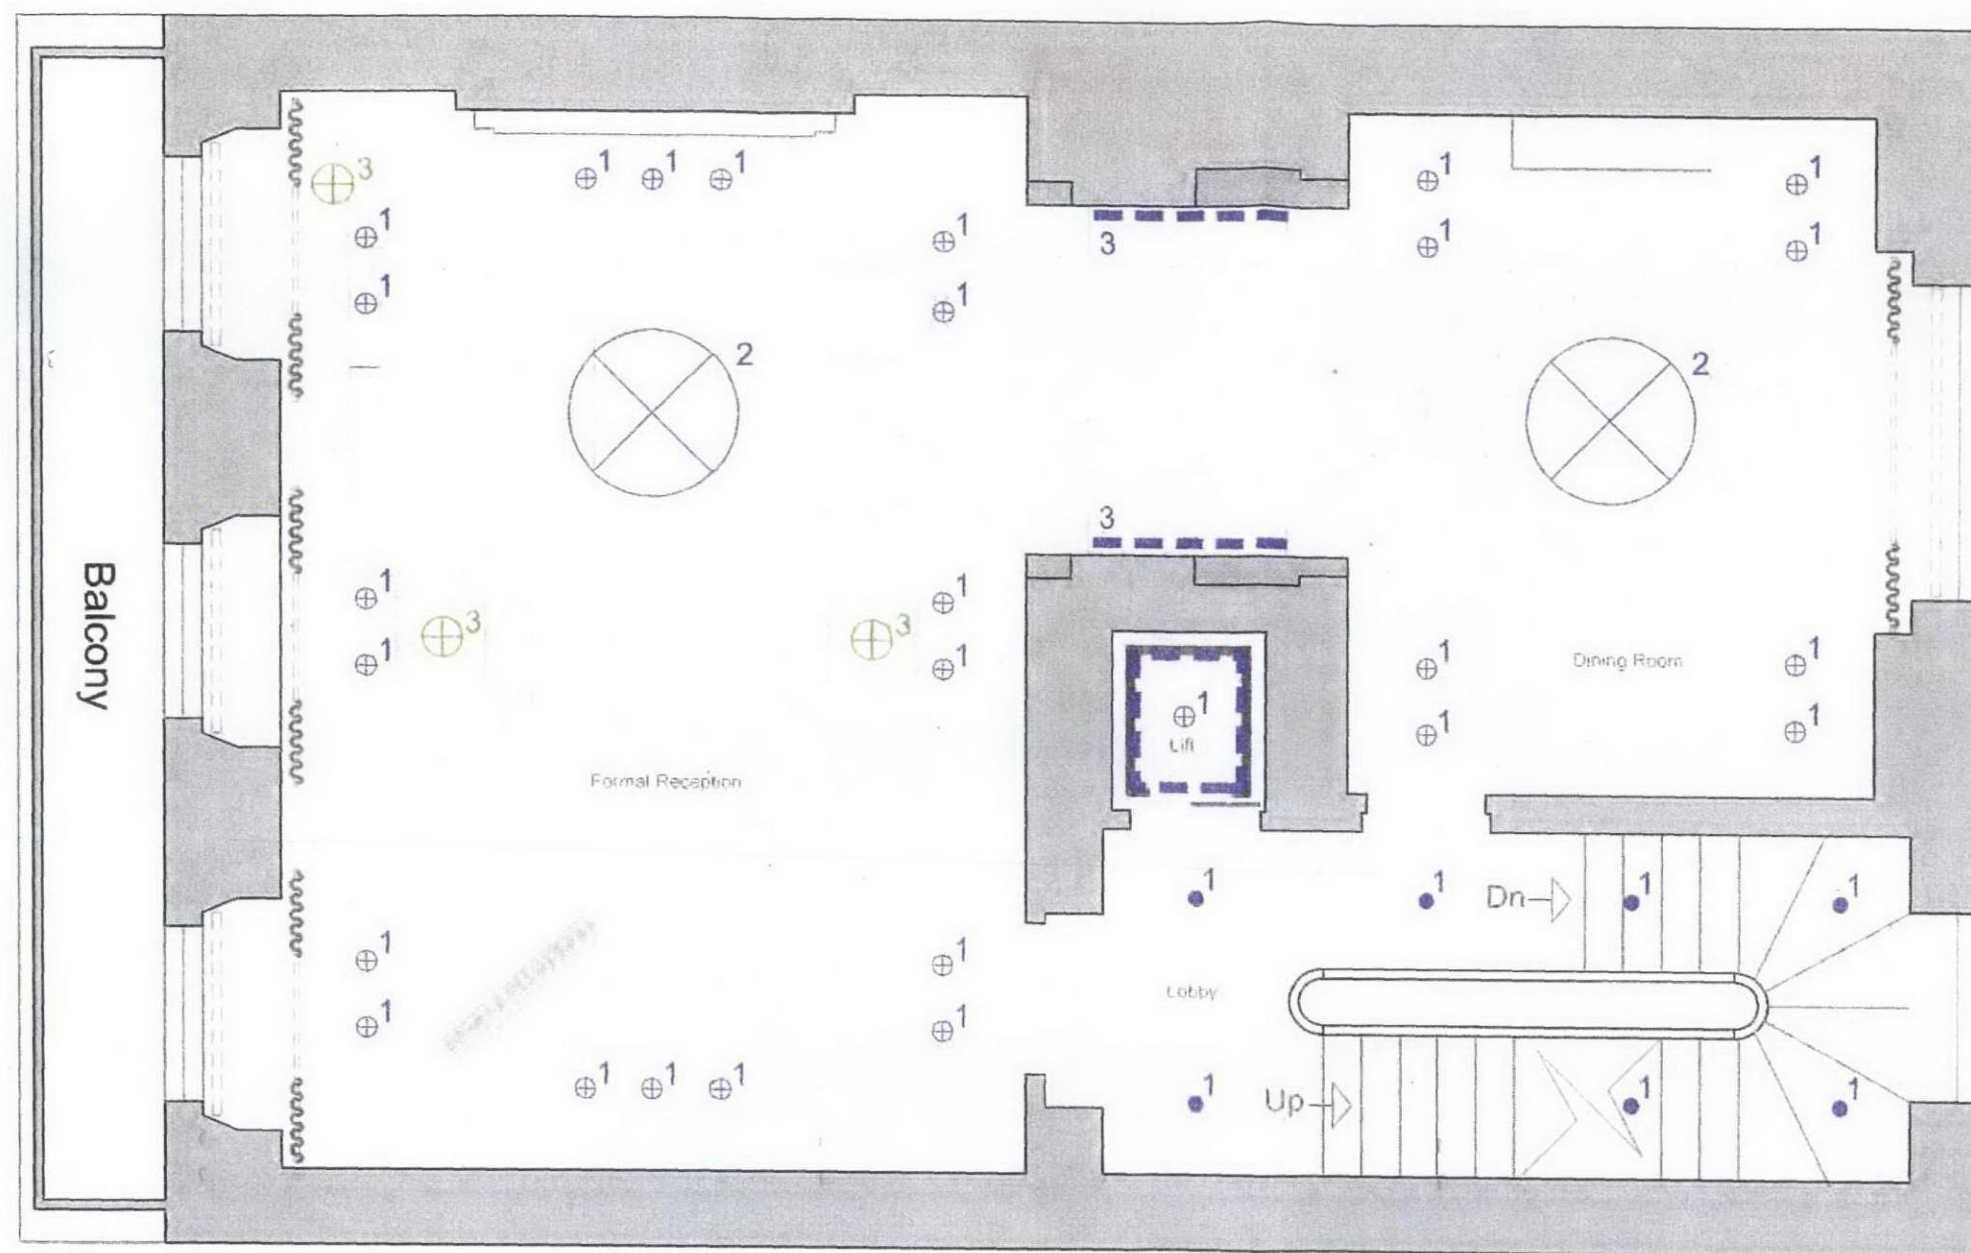

17 Chester Terrace - Proposed Lighting Layout
First Floor - 1/50@A3

⊕³ Lamp

--- Strip light TBC

⊕² Down-light (flush, counter sunk)

⌒ Wall light TBC

●¹ Down-light TBC

⊗¹ Pendant/chandelier light TBC

⊙¹ Flush floor up-light

Notes:

This drawing may not be copied, reproduced or given to any third parties for any reason what so ever without the written permission of HamishBenjamin Limited. Please note this drawing is protected under copyright and remains the property of HamishBenjamin at all times. All dimensions must be checked on site and not scaled from the drawing.

A	Value engineering exercise	10.03.09	BJ
Rev	Description	Date	By

Project

17 Chester Terrace
Regents Park. London

Client

Private Client

Job No.	Drg No.	Rev
09_020	006	

Title

Proposed Lighting Layout
First Floor
GA

Date	Scale
09_07_30	1/50@A3

Drawn By

Benjamin

HamishBenjamin

HamishBenjamin
5 Hartwood Road, Shepherd's Bush
London, W12 9NQ
Tel: 07834616560
Email: hamish@hamishbenjamin.com
benjamin@hamishbenjamin.com