


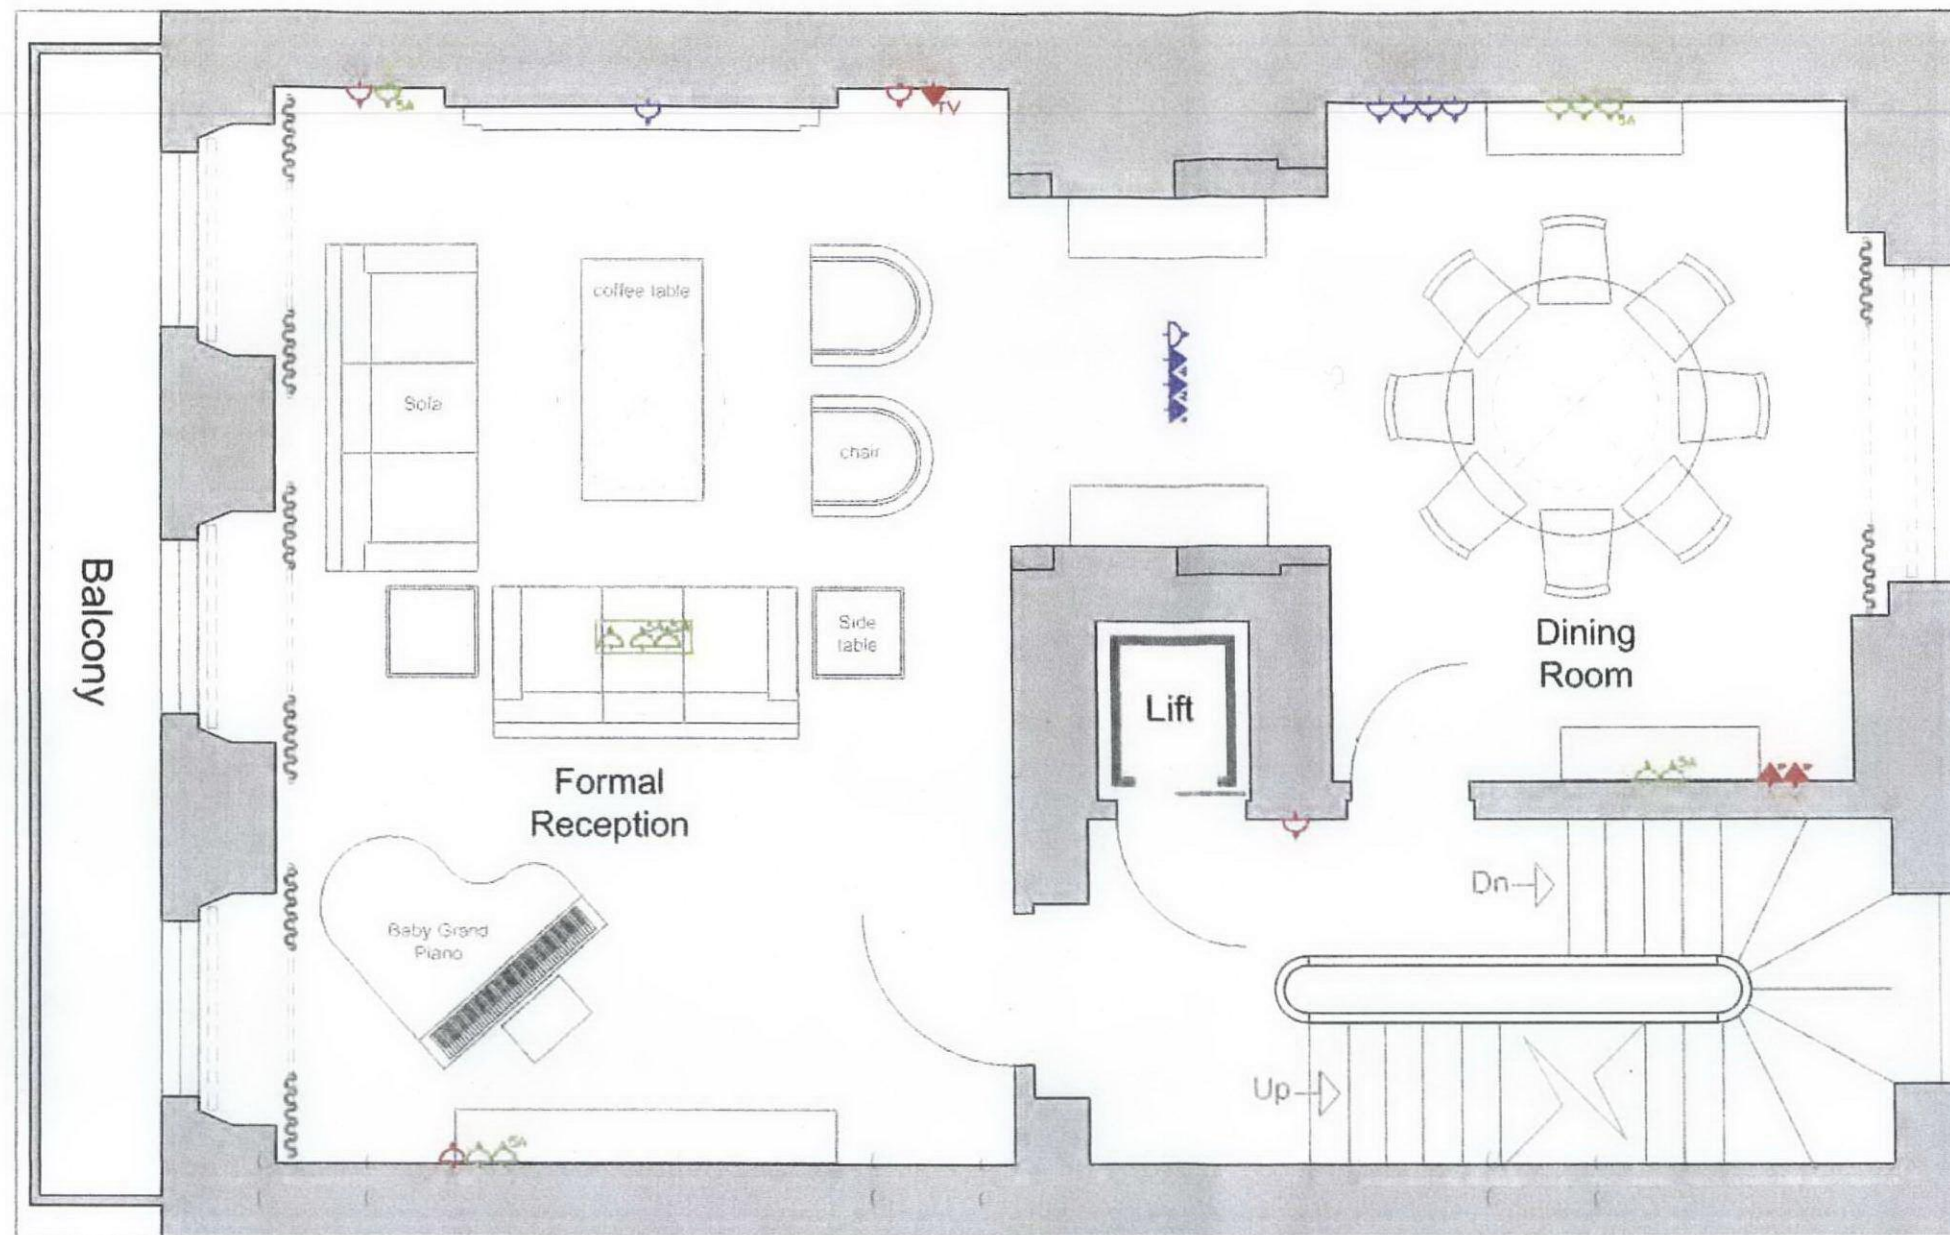

17 Chester Terrace - Proposed Small Power Plan
FIRST FLOOR - 1:50@A3



5 AMP	CEILING MOUNTED LUMINAIRE C/W 20 FLUORESCENT LAMP	SP	SECURITY PANEL	CV5	PLASMA / AMPLIFIER END OF CONDUIT	45A COCKER SWITCH WITH CONNECTION UNIT BELOW WORKTOP
DOUBLE SOCKET	WALL MOUNTED LUMINAIRE C/W 20 FLUORESCENT LAMP	TA	FIRE ALARM PANEL	AK	AK MASTERSEAL RCD EXTERNAL SOCKET TO IP56	SHAVESOCKET
SINGLE SOCKET	WALL MOUNTED LUMINAIRE C/W 20 FLUORESCENT LAMP	SC	SECURITY ALARM SOUNDER C/W FLASHING LIGHT	SC	SOUND CONTROLLER END OF UNIT	FUSED CONNECTION UNIT FOR UNDERFLOOR HEATING
FUSED CONNECTION UNIT 13AMP	PASSIVE INFRARED DETECTOR	HEA	HEA DETECTOR C/W SOUNDER BASE	✓	LIGHTING SWITCH	EXTRACT FAN WITH INTAKE AND EXTRACT
PHONE POINT	VIDEO ENTRY ANSWERING UNIT	SD	SMOKE DETECTOR C/W SOUNDER BASE	✓	FUSED CONNECTING UNIT 13A FOR TOWEL RAIL	
DATA POINT	VIDEO ENTRY CALL STATION	SD	SMOKE DETECTOR	✓	FUSED CONNECTING UNIT 13A FOR SHOWER PUMP	
TELEVISION POINT	VIDEO ENTRY PANEL	SD	WATERPROOF ISOLATOR	✓	FUSED CONNECTING UNIT 13A FOR BATH TUB	
DISTRIBUTION BOARD	SECURITY DOOR SENSOR	SD	AUTOMATIC BLIND CABLE	✓	FUSED CONNECTING UNIT 13A FOR EXTRACTOR FAN	
SUB	SECURITY KEY PAD	SD	EXTRACT FAN	✓	FUSED CONNECTING UNIT 13A FOR AIR CON UNIT	

Notes:

This drawing may not be copied, reproduced or given to any third parties for any reason what so ever without the written permission of HamishBenjamin Limited. Please note this drawing is protected under copyright and remains the property of HamishBenjamin at all times. All dimensions must be checked on site and not scaled from the drawing.

Rev	Description	Date	By
A	Value engineering exercise	10.03.09	BJ

Project
17 Chester Terrace
Regents Park, London

Client
Private Client

Job No.	Drg No.	Rev
09_02C	018	

Title
Proposed Small Power Plan
First Floor
GA

Date	Scale
09_07_30	1/50@A3

Drawn By
Benjamin

HamishBenjamin

HamishBenjamin
5 Hartswood Road, Shepherd's Bush
London, W12 9NQ
Tel: 07894616560
Email: hamish@hamishbenjamin.com
benjamin@hamishbenjamin.com