

00. INDEX

Drawing Number	Drawing Title	Description
B04025, B04023. B0424/00	Index	Index of Drawings.
B04025, B04023. B0424/01	Location Plan	Scale 1:1250 at A4.
B04025, B04023. B0424/02	Roof Plan	Drawing of block from above, showing equipment positions.
B04025, B04023. B0424/03	North east Elevation	Description and location of the antenna and dishes + mounting and measurements
B04025, B04023. B0424/04	South East Elevation 1	Description of Cable routes, loom sizes and entry points.
B04025, B04023. B0424/05	South East Elevation 2	Description of Cable routes, loom sizes and entry points.
B04025, B04023. B0424/06	South East Elevation 3	Description of Cable routes, loom sizes and entry points.
B04025, B04023. B0424/07	North West Elevations	Description of Cable routes, loom sizes and entry points. Description of both cabinet, mounting and measurements
B04025, B04023. B0424/08	Existing Equipments	Description, location and view of the existing equipment on site before install.
B04025, B04023. B0424/09	Antenna, Dish Sizes & Typical Mounting Heights	Sketch of the Antenna and Dishes + mounting, position and height.

Form No. SCC 013 SCC International – 1 Fieldings Road, Cheshunt, Herts, EN8 9TL, . Tel: 01992 642255. Website: www.scci.co.uk




Please consider the environment before printing this document – Recycle Wherever Possible



Drawing No.	B04025/B04023, B04024/00	Site Address:	89 (A-J) CROFTDOWN RD Inc. 74&76 (A-H) ST ALBANS RD LONDON NW5 1EY		
Date:	24 Jan 2012	Site Ref:	LBC 0824.0	Surveyed By:	G. Henebery
Number of Points:	26	System Type	9Wire IRS Sky Plus	Drawn By:	W. Kisala



02. Roof Plan

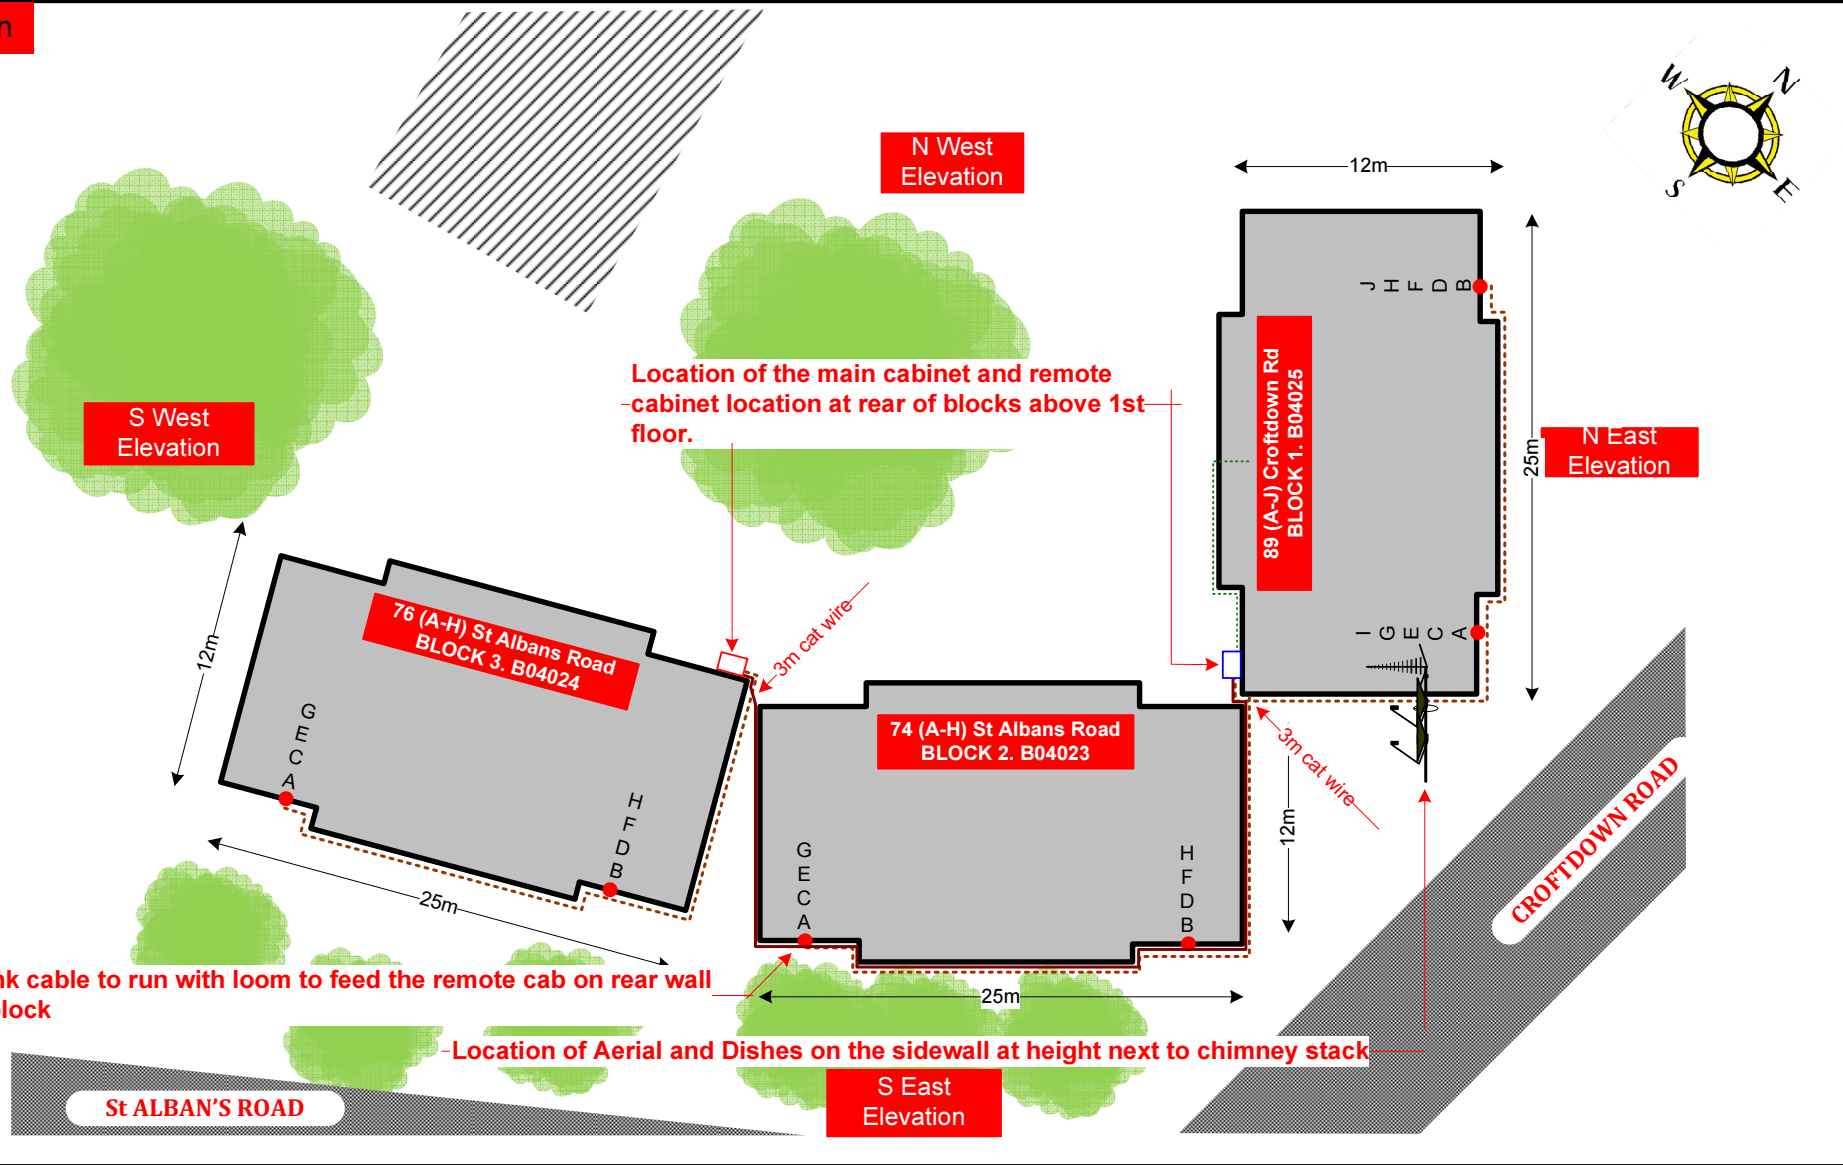

Form No. SCC 013 SCC International – 1 Fieldings Road, Cheshunt, Herts, EN8 9TL, . Tel: 01992 642255. Website: www.scci.co.uk

Please consider the environment before printing this document – Recycle Wherever Possible

Drawing No.	B04025/B04023, B04024/02	Site Address:	89 (A-J) CROFTDOWN RD Inc. 74&76 (A-H) ST ALBANS RD LONDON NW5 1EY		
Date:	24 Jan 2012	Site Ref:	LBC 0735.0	Surveyed By:	G. Henebery
Number of Points:	26	System Type	9Wire IRS Sky Plus	Drawn By:	W. Kisala



Each property will have two cables to lounge position.

Cable Harness sizes

2-4 cables = 15mm

6-8 cables = 20mm


10-14 cables = 30mm

16-18 Cables = 35mm

20 cables = 40mm


40 cables = 65mm

60 cables = 90mm

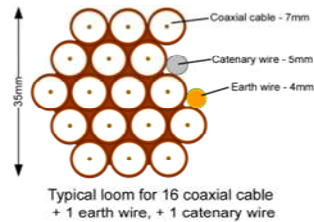

03. North East Elevation

89 (A-J) Croftdown Rd
BLOCK 1. B04025

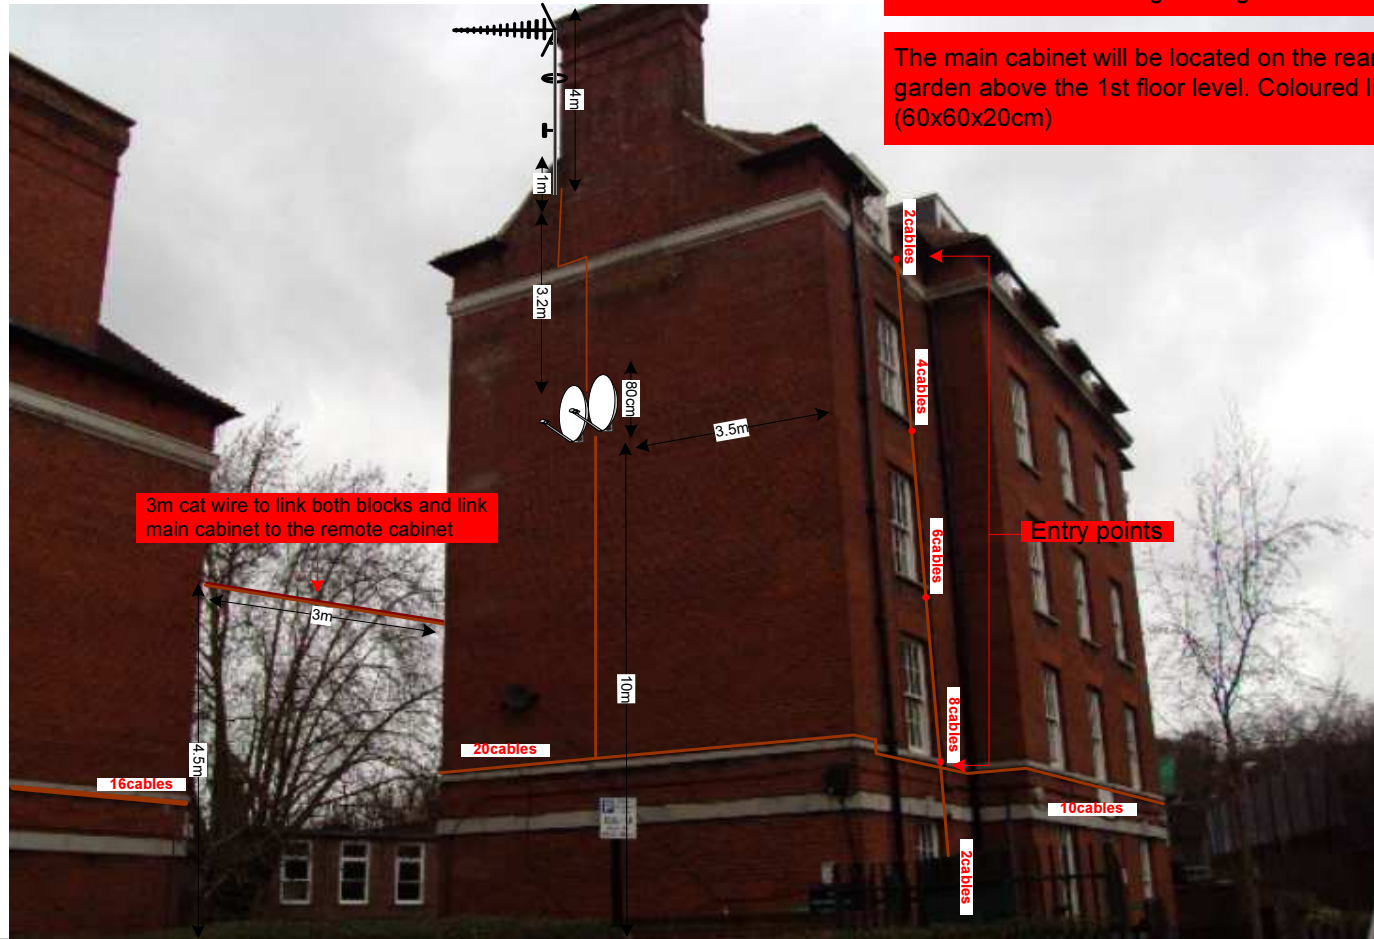

Drop cables to run around the rear of the block from the main cabinet above ground floor then feed flats with 2 cables at entry points. A catenary wire will be linking both building to run the cables to feed other blocks.

Antenna will be 4m pole and dishes of 80cm each. All equipments mounted on the sidewall of flats A,C,E,G and I. Mounted on wall using lashing kits.

The main cabinet will be located on the rear wall facing the garden above the 1st floor level. Coloured light grey (60x60x20cm)

Form No. SCC 013 SCC International – 1 Fieldings Road, Cheshunt, Herts, EN8 9TL, . Tel: 01992 642255. Website: www.scci.co.uk



Please consider the environment before printing this document – Recycle Wherever Possible



Drawing No.	B04025/B04023, B04024/03	Site Address:	89 (A-J) CROFTDOWN RD Inc. 74&76 (A-H) ST ALBANS RD LONDON NW5 1EY		
Date:	24 Jan 2012	Site Ref:	LBC 0735.0	Surveyed By:	G. Henebery
Number of Points:	26	System Type	9Wire IRS Sky Plus	Drawn By:	W. Kisala



Each property will have two cables to lounge position.

Cable Harness sizes

2-4 cables = 15mm

6-8 cables = 20mm


10-14 cables = 30mm

16-18 Cables = 35mm

20 cables = 40mm


40 cables = 65mm

60 cables = 90mm

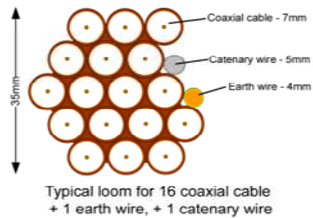

04. South East Elevation 1

74 (A-H) St Albans Road
BLOCK 2. B04023

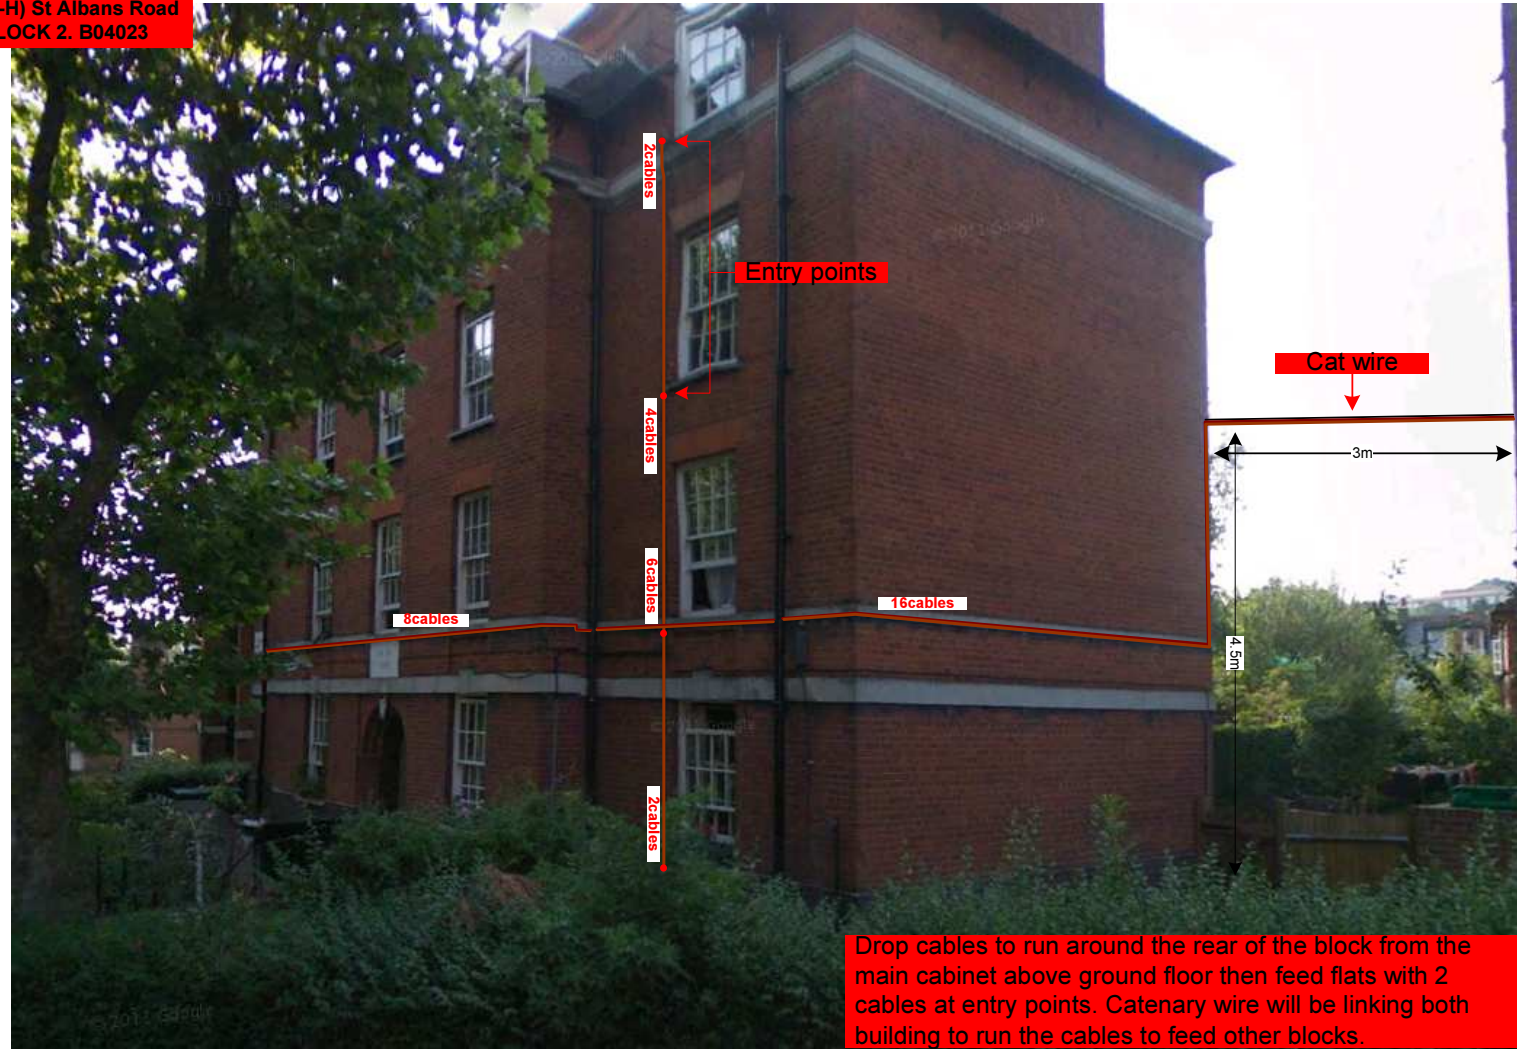

Drop cables to run around the rear of the block from the main cabinet above ground floor then feed flats with 2 cables at entry points. Catenary wire will be linking both building to run the cables to feed other blocks.

Form No. SCC 013 SCC International – 1 Fieldings Road, Cheshunt, Herts, EN8 9TL, . Tel: 01992 642255. Website: www.scci.co.uk



Please consider the environment before printing this document – Recycle Wherever Possible



Drawing No.	B04025/B04023, B04024/04	Site Address:	89 (A-J) CROFTDOWN RD Inc. 74&76 (A-H) ST ALBANS RD LONDON NW5 1EY		
Date:	24 Jan 2012	Site Ref:	LBC 0735.0	Surveyed By:	G. Henebery
Number of Points:	26	System Type	9Wire IRS Sky Plus	Drawn By:	W. Kisala



Each property will have two cables to lounge position.

Cable Harness sizes

2-4 cables = 15mm

6-8 cables = 20mm


10-14 cables = 30mm

16-18 Cables = 35mm

20 cables = 40mm

40 cables = 65mm

60 cables = 90mm

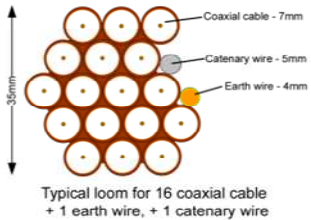

05. South East Elevation 2

76 (A-H) St Albans Road
BLOCK 3. B04024



Form No. SCC 013 SCC International – 1 Fieldings Road, Cheshunt, Herts, EN8 9TL, . Tel: 01992 642255. Website: www.scci.co.uk



Please consider the environment before printing this document – Recycle Wherever Possible



Drawing No.	B04025/B04023, B04024/05	Site Address:	89 (A-J) CROFTDOWN RD Inc. 74&76 (A-H) ST ALBANS RD LONDON NW5 1EY		
Date:	24 Jan 2012	Site Ref:	LBC 0735.0	Surveyed By:	G. Henebery
Number of Points:	26	System Type	9Wire IRS Sky Plus	Drawn By:	W. Kisala



Each property will have two cables to lounge position.

Cable Harness sizes

2-4 cables = 15mm

6-8 cables = 20mm


10-14 cables = 30mm

16-18 Cables = 35mm


20 cables = 40mm

40 cables = 65mm

60 cables = 90mm

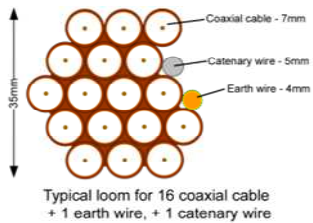

06. South East Elevation 3

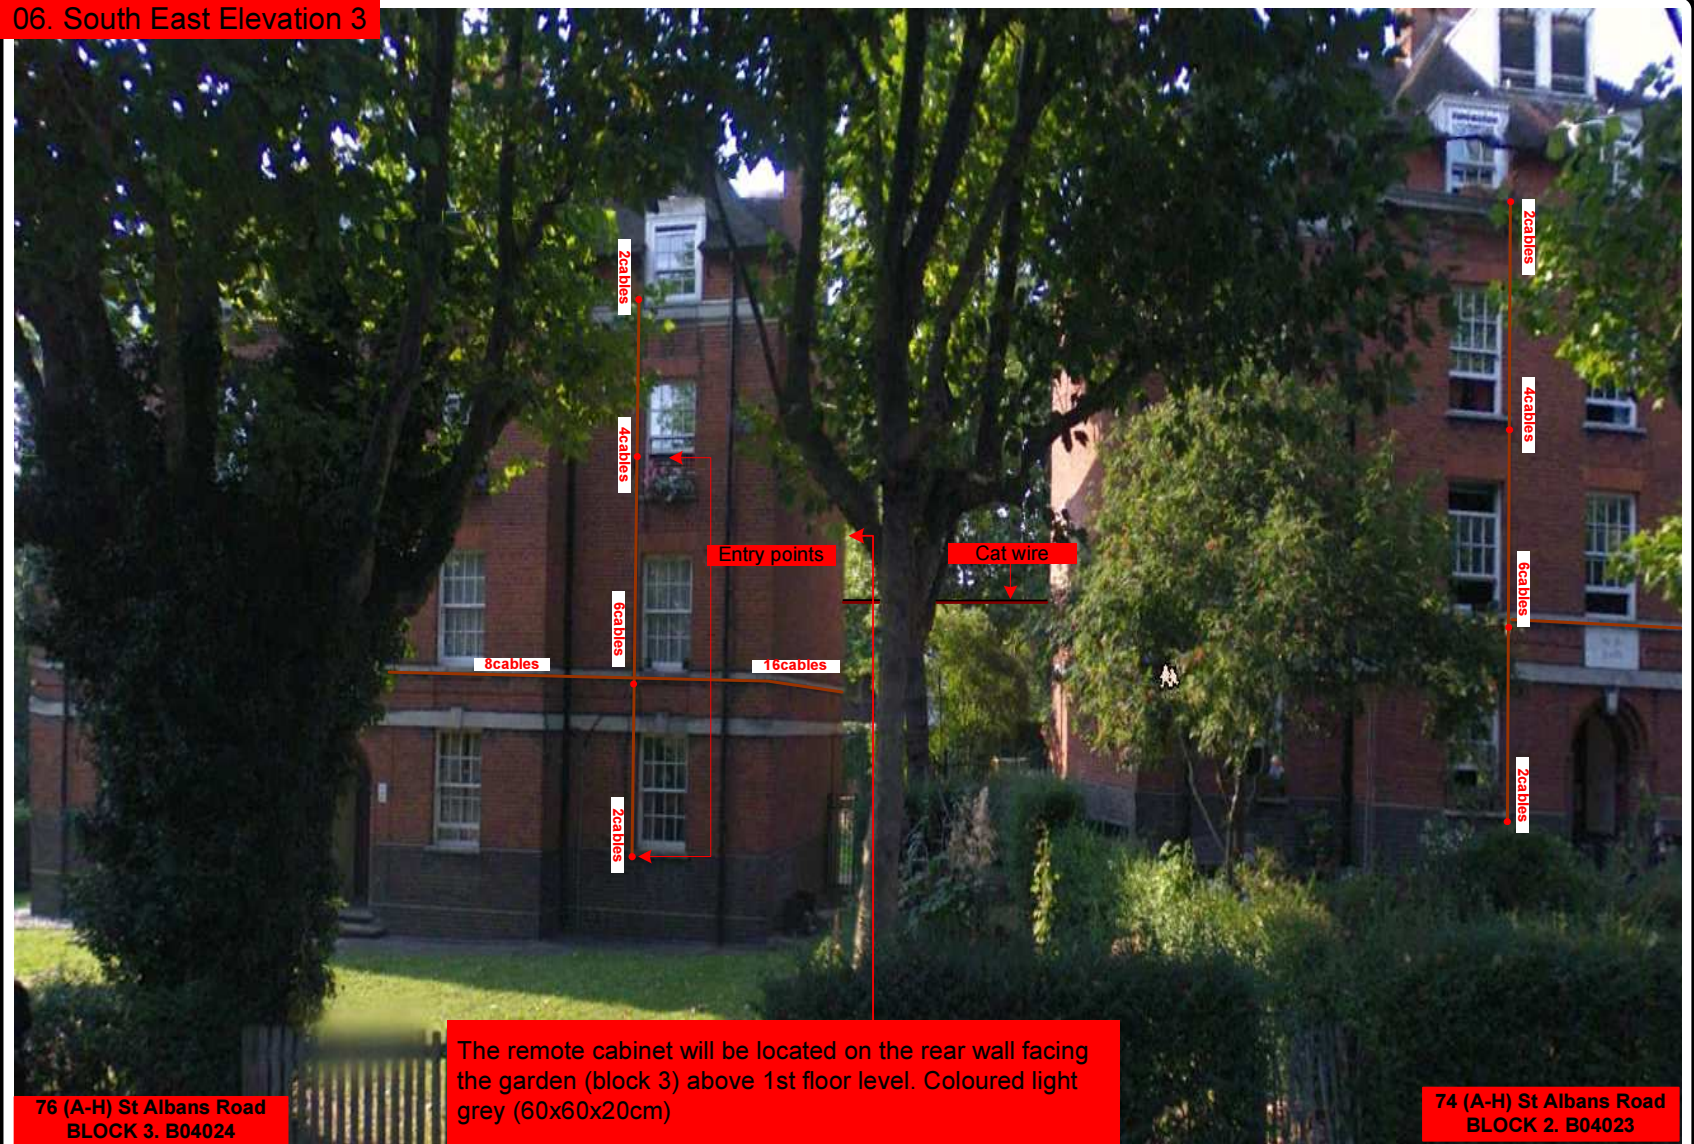

76 (A-H) St Albans Road
BLOCK 3. B04024

74 (A-H) St Albans Road
BLOCK 2. B04023

Form No. SCC 013 SCC International – 1 Fieldings Road, Cheshunt, Herts, EN8 9TL, . Tel: 01992 642255. Website: www.scci.co.uk



Please consider the environment before printing this document – Recycle Wherever Possible



Drawing No.	B04025/B04023, B04024/06	Site Address:	89 (A-I) CROFTDOWN RD Inc. 74&76 (A-H) ST ALBANS RD LONDON NW5 1EY		
Date:	11 Jan 2012	Site Ref:	LBC 0735.0	Surveyed By:	G. Henebery
Number of Points:	26	System Type	9Wire IRS Sky Plus	Drawn By:	W. Kisala



Each property will have two cables to lounge position.

Cable Harness sizes

2-4 cables = 15mm

6-8 cables = 20mm


10-14 cables = 30mm

16-18 Cables = 35mm

20 cables = 40mm

40 cables = 65mm

60 cables = 90mm

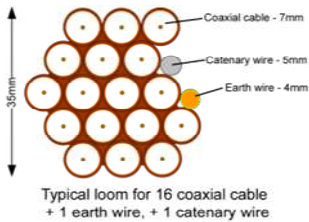

07. North West Elevations

89 (A-J) Croftdown Rd
BLOCK 1. B04025

74 (A-H) St Albans Road
BLOCK 2. B04023

76 (A-H) St Albans Road
BLOCK 3. B04024



The main cabinet will be located on the rear wall facing the garden of (block 1) 89(A-J) Croftdown Rd above 1st floor windows (light grey, sized 60x60x20cm)
The remote cabinet will be located on the rear wall facing the garden (block 3). 3m above the 1st floor level.
Coloured light grey (60x60x20cm)

Form No. SCC 013 SCC International – 1 Fieldings Road, Cheshunt, Herts, EN8 9TL, . Tel: 01992 642255. Website: www.scci.co.uk



Please consider the environment before printing this document – Recycle Wherever Possible



Drawing No.	B04025/B04023, B04024/07	Site Address:	89 (A-J) CROFTDOWN RD Inc. 74&76 (A-H) ST ALBANS RD LONDON NW5 1EY		
Date:	24 Jan 2012	Site Ref:	LBC 0735.0	Surveyed By:	G. Henebery
Number of Points:	26	System Type	9Wire IRS Sky Plus	Drawn By:	W. Kisala



Each property will have two cables to lounge position.

Cable Harness sizes

2-4 cables = 15mm

6-8 cables = 20mm


10-14 cables = 30mm

16-18 Cables = 35mm

20 cables = 40mm

40 cables = 65mm

60 cables = 90mm

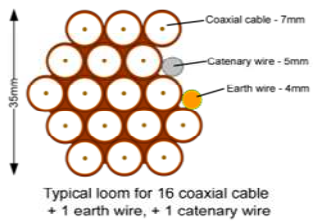

08. Existing Equipments



Form No. SCC 013 SCC International – 1 Fieldings Road, Cheshunt, Herts, EN8 9TL, . Tel: 01992 642255. Website: www.scci.co.uk



Please consider the environment before printing this document – Recycle Wherever Possible



Drawing No.	B04025/B04023, B04024/08	Site Address:	89 (A-J) CROFTDOWN RD Inc. 74&76 (A-H) ST ALBANS RD LONDON NW5 1EY		
Date:	24 Jan 2012	Site Ref:	LBC 0735.0	Surveyed By:	G. Henebery
Number of Points:	26	System Type	9Wire IRS Sky Plus	Drawn By:	W. Kisala




09. Antenna and Dishes Measurements

Digital TV,
FM & DAB Radio
Aerials

Antenna will be 4m pole and dishes of 80cm each. All equipments mounted on the sidewall of flats A,C,E,G and I Using lashing kits.

Note that the line of site can only be obtained on the present location (89 [A-J] Croftdown Rd BLOCK 1. B04025) the equipment wont be able to be installed on lolly pop due to trees and length on the blocks.

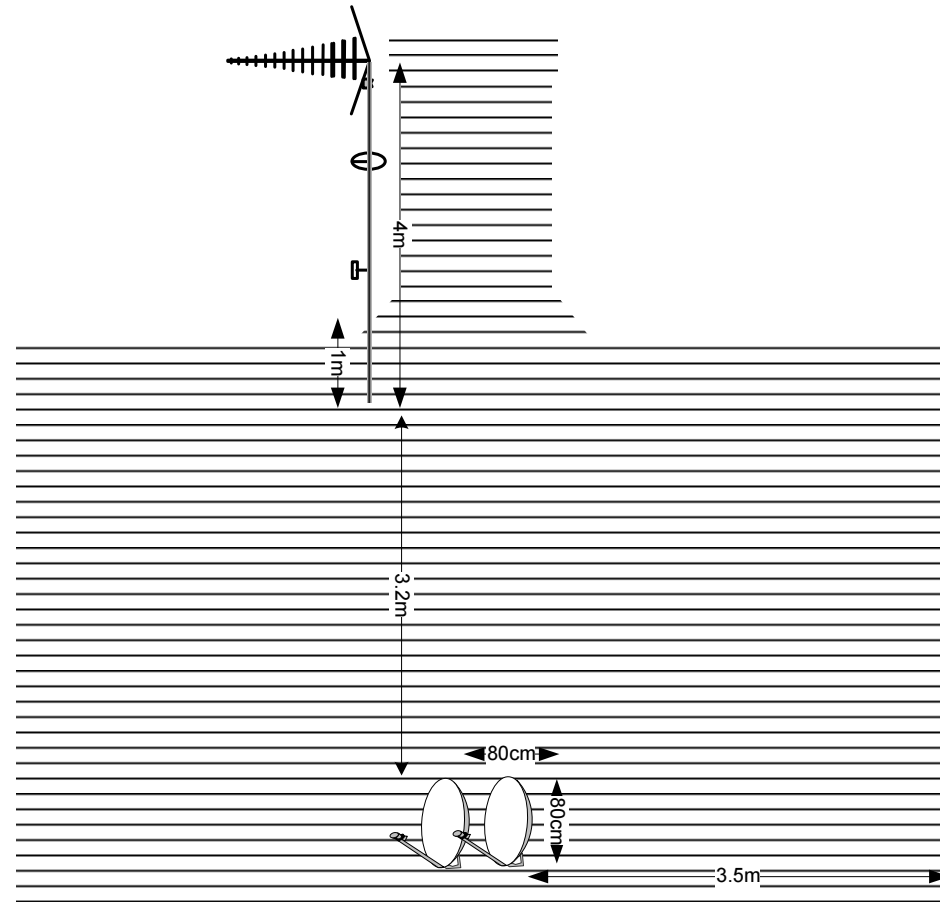

Form No. SCC 013 SCC International – 1 Fieldings Road, Cheshunt, Herts, EN8 9TL, . Tel: 01992 642255. Website: www.scci.co.uk



Please consider the environment before printing this document – Recycle Wherever Possible



Drawing No.	B04025/B04023, B04024/09	Site Address:	89 (A-J) CROFTDOWN RD Inc. 74&76 (A-H) ST ALBANS RD LONDON NW5 1EY		
Date:	24 Jan 2012	Site Ref:	LBC 0735.0	Surveyed By:	G. Henebery
Number of Points:	26	System Type	9Wire IRS Sky Plus	Drawn By:	W. Kisala

