

## 00. INDEX

Drawing Number	Drawing Title	Description
E04019/00	Index	Index of Drawings.
E04019/01	Location Plan	Scale 1:1250 at A4.
E04019/02	Roof Plan	Drawing of block from above, showing equipment positions.
E04019/03	Roof Elevation 1	Description and location of the antenna and dishes + mounting and measurements.
E04019/04	Roof Elevation 2	Description and location of the Main cabinet size, colour + measurements.
E04019/05	South Elevation	Description of Cable routes, loom sizes and entry points.
E04019/06	North Elevation	Description of Cable routes, loom sizes and entry points.
E04019/07	Existing Equipments	Description, location and view of the existing equipment on site before install.
E04019/08	Antenna, Dish Sizes & Typical Mounting Heights	Sketch of the Antenna and Dishes + mounting, position and height.

Form No. SCC 013 SCC International – 1 Fieldings Road, Cheshunt, Herts, EN8 9TL, . Tel: 01992 642255. Website: www.scci.co.uk




Please consider the environment before printing this document – Recycle Wherever Possible



Drawing No.	E04019/00	Site Address:	321-339 Holly Lodge Mansions, London, N6 6ED		
Date:	17 <sup>th</sup> Nov 11	Site Ref:	LBC	Surveyed By:	Paul Kenney
Number of Points:	18	System Type	9Wire IRS Sky Plus	Drawn By:	James Schroder



## 02. Roof Plan

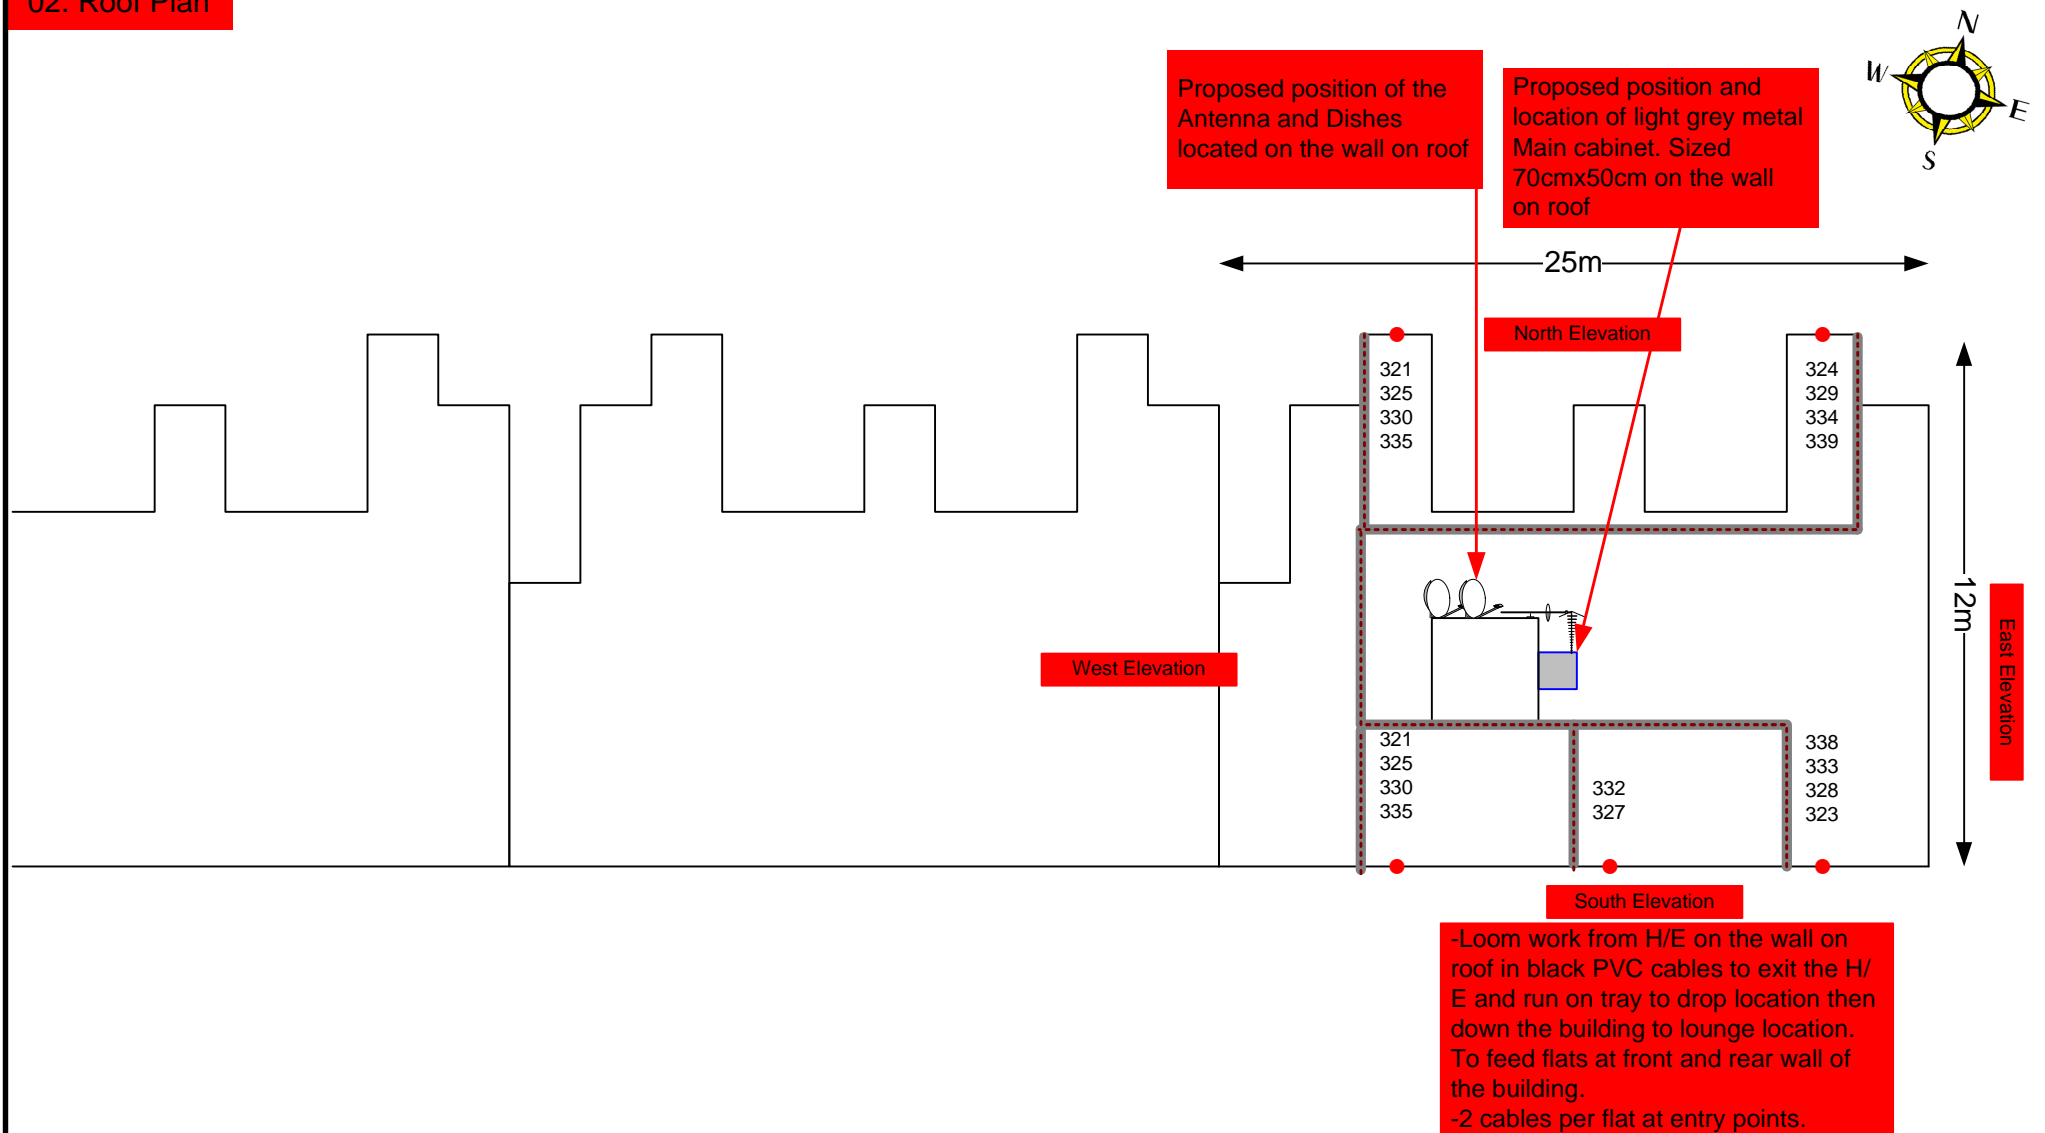

Form No. SCC 013 SCC International – 1 Fieldings Road, Cheshunt, Herts, EN8 9TL, . Tel: 01992 642255. Website: www.scci.co.uk


Drawing No. E04019/02 Site Address: 321-339 Holly Lodge Mansions, London, N6 6ED

Date: 17<sup>th</sup> Nov 11 Site Ref: LBC Surveyed By: Paul Kenney

Number of Points: 18 System Type: 9Wire IRS Sky Plus Drawn By: James Schroder



Please consider the environment before printing this document – Recycle Wherever Possible

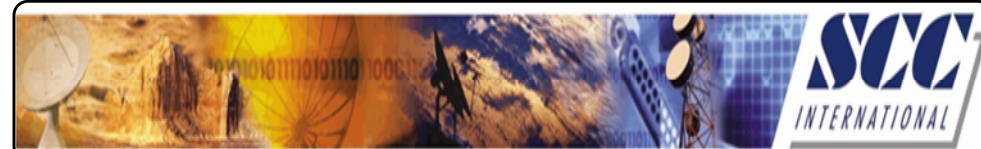

Each property will have two cables to lounge position.

#### Cable Harness sizes

2-4 cables = 15mm

6-8 cables = 20mm


10-14 cables = 30mm

16-18 Cables = 35mm

20 cables = 40mm

40 cables = 65mm

60 cables = 90mm

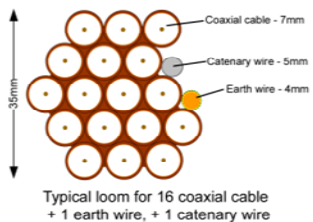

### 03. Roof Elevation 1



Form No. SCC 013 SCC International – 1 Fieldings Road, Cheshunt, Herts, EN8 9TL, . Tel: 01992 642255. Website: www.scci.co.uk

Drawing No.	E04019/03	Site Address:	321-339 Holly Lodge Mansions, London, N6 6ED		
Date:	17 <sup>th</sup> Nov 11	Site Ref:	LBC	Surveyed By:	Paul Kenney
Number of Points:	18	System Type	9Wire IRS Sky Plus	Drawn By:	James Schroder



Please consider the environment before printing this document – Recycle Wherever Possible





Each property will have two cables to lounge position.

Cable Harness sizes

2-4 cables = 15mm

6-8 cables = 20mm


10-14 cables = 30mm

16-18 Cables = 35mm

20 cables = 40mm

40 cables = 65mm

60 cables = 90mm

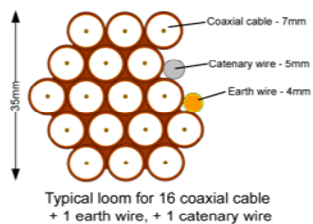

## 04. Roof Elevation 2



Form No. SCC 013 SCC International – 1 Fieldings Road, Cheshunt, Herts, EN8 9TL, . Tel: 01992 642255. Website: www.scci.co.uk

Drawing No.	E04019/04	Site Address:	321-339 Holly Lodge Mansions, London, N6 6ED
Date:	17 <sup>th</sup> Nov 11	Site Ref:	LBC
Number of Points:	18	System Type	9Wire IRS Sky Plus
		Surveyed By:	Paul Kenney
		Drawn By:	James Schroder



Please consider the environment before printing this document – Recycle Wherever Possible



Each property will have two cables to lounge position.

#### Cable Harness sizes

2-4 cables = 15mm

6-8 cables = 20mm


10-14 cables = 30mm

16-18 Cables = 35mm

20 cables = 40mm

40 cables = 65mm

60 cables = 90mm

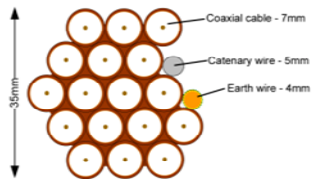

Typical loom for 16 coaxial cable  
+ 1 earth wire, + 1 catenary wire

#### 05. South Elevation



Form No. SCC 013 SCC International – 1 Fieldings Road, Cheshunt, Herts, EN8 9TL. . Tel: 01992 642255. Website: www.scci.co.uk

Drawing No.	E04019/05	Site Address:	321-339 Holly Lodge Mansions, London, N6 6ED
Date:	17 <sup>th</sup> Nov 11	Site Ref:	LBC
Number of Points:	18	System Type	9Wire IRS Sky Plus
		Surveyed By:	Paul Kenney
		Drawn By:	James Schroder



Please consider the environment before printing this document – Recycle Wherever Possible





Each property will have two cables to lounge position.

#### Cable Harness sizes

2-4 cables = 15mm

6-8 cables = 20mm


10-14 cables = 30mm

16-18 Cables = 35mm

20 cables = 40mm

40 cables = 65mm

60 cables = 90mm

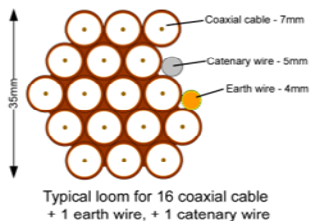

#### 06. North Elevation

-Loom work from H/E on the wall on roof in black PVC cables to exit the H/E and run on tray to drop location then down the building to lounge location. To feed flats at front and rear wall of the building.  
-2 cables per flat at entry points.



Form No. SCC 013 SCC International – 1 Fieldings Road, Cheshunt, Herts, EN8 9TL, . Tel: 01992 642255. Website: www.scci.co.uk



Please consider the environment before printing this document – Recycle Wherever Possible



Drawing No. E04019/06 Site Address: 321-339 Holly Lodge Mansions, London, N6 6ED

Date: 17<sup>th</sup> Nov 11 Site Ref: LBC Surveyed By: Paul Kenney

Number of Points: 18 System Type: 9Wire IRS Sky Plus Drawn By: James Schroder





Each property will have two cables to lounge position.

Cable Harness sizes

2-4 cables = 15mm

6-8 cables = 20mm


10-14 cables = 30mm

16-18 Cables = 35mm

20 cables = 40mm

40 cables = 65mm

60 cables = 90mm

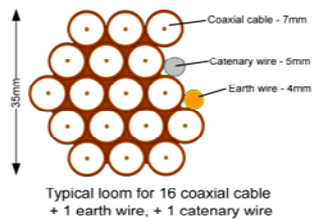

## 07. Existing Equipments



Form No. SCC 013 SCC International – 1 Fieldings Road, Cheshunt, Herts, EN8 9TL . Tel: 01992 642255. Website: www.scci.co.uk

Drawing No. E04019/07 Site Address: 321-339 Holly Lodge Mansions, London, N6 6ED

Date: 17<sup>th</sup> Nov 11 Site Ref: LBC Surveyed By: Paul Kenney

Number of Points: 18 System Type: 9Wire IRS Sky Plus Drawn By: James Schroder




Please consider the environment before printing this document – Recycle Wherever Possible



## 08. Antenna and Dishes Measurements

Digital TV,  
FM & DAB Radio  
Aerials

Proposed location of UHF Aerial on a 4m pole and 80cm dishes mounted on the rear wall above the Main entrance to block.

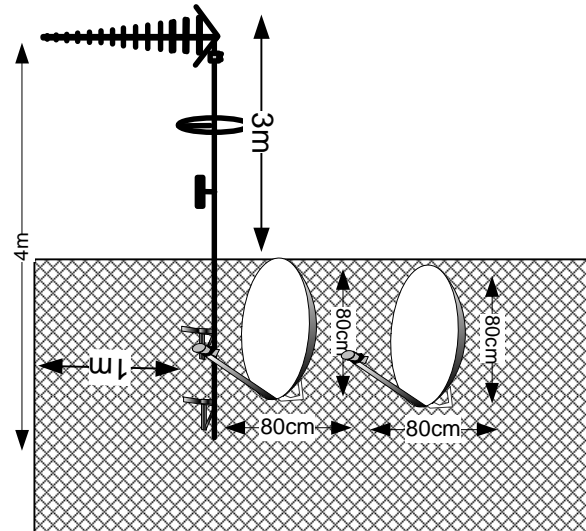

Form No. SCC 013 SCC International – 1 Fieldings Road, Cheshunt, Herts, EN8 9TL, . Tel: 01992 642255. Website: www.scci.co.uk

Drawing No.	E04019/08	Site Address:	321-339 Holly Lodge Mansions, London, N6 6ED		
Date:	17 <sup>th</sup> Nov 11	Site Ref:	LBC	Surveyed By:	Paul Kenney
Number of Points:	18	System Type	9Wire IRS Sky Plus	Drawn By:	James Schroder



Please consider the environment before printing this document – Recycle Wherever Possible

