


GABHAN O'KEEFFE ARCHITECTURAL INTERIORS

- Do not scale off this drawing, use figured dimensions only. All dimensions and levels to be checked on site and GOK to be notified of any discrepancies immediately.
- Issued only for purpose indicated.
- This drawing is to be read in conjunction with consultants drawings and specifications.
- This drawing is copyright of GOK and may not be copied, altered or reproduced in any way or passed to a third party without written permission from GOK.
- The main contractor should be conversant with the statutory obligations under the CDM regulations.
- The dimensions shown on this drawing have been based on the measurements provided by an independent survey company.



REVISIONS

Rev	Date	Description	Drawn	Chkd
T1	26.08.11	FIRST TENDER ISSUE	OK	GOK
11	04.08.11	FIRST ISSUE	OK	GOK


- GENERAL NOTES:
- ALL FACE PLATES TO BE SPACED 20mm APART
 - ALL CRESTRON SWITCHES TO BE 150mm FROM FFL TO CENTER OF SWITCH
 - ALL LUTRON PANELS AND GENERAL SWITCHES TO BE 125mm FROM FFL TO CENTER OF SWITCH OR TILL FURTHER NOTATION
 - ALL WALL LIGHT AND PICTURE LIGHT FITTINGS TO BE 1800mm FROM FFL TO CENTER OF SWITCH /OR TILL FURTHER NOTATION
 - ALL CABINERY SMALL POWER LOCATED WITHIN CABINERY AT 200mm FROM TOP EDGE OF SIKRING TO CENTER OF FACE PLATE, OR TILL FURTHER NOTATION
 - SMALL POWER LOCATED WITHIN FLOOR BOX TO BE RECESSED INTO FLOOR, REFER TO SMALL POWER DRAWING FOR SETTING OUT PURPOSES ONLY
 - UNDERFLOOR HEATING AND FCU UNITS TO BE CO-ORDINATED WITH M&E CONSULTANTS, REFER TO RELATED DRAWING

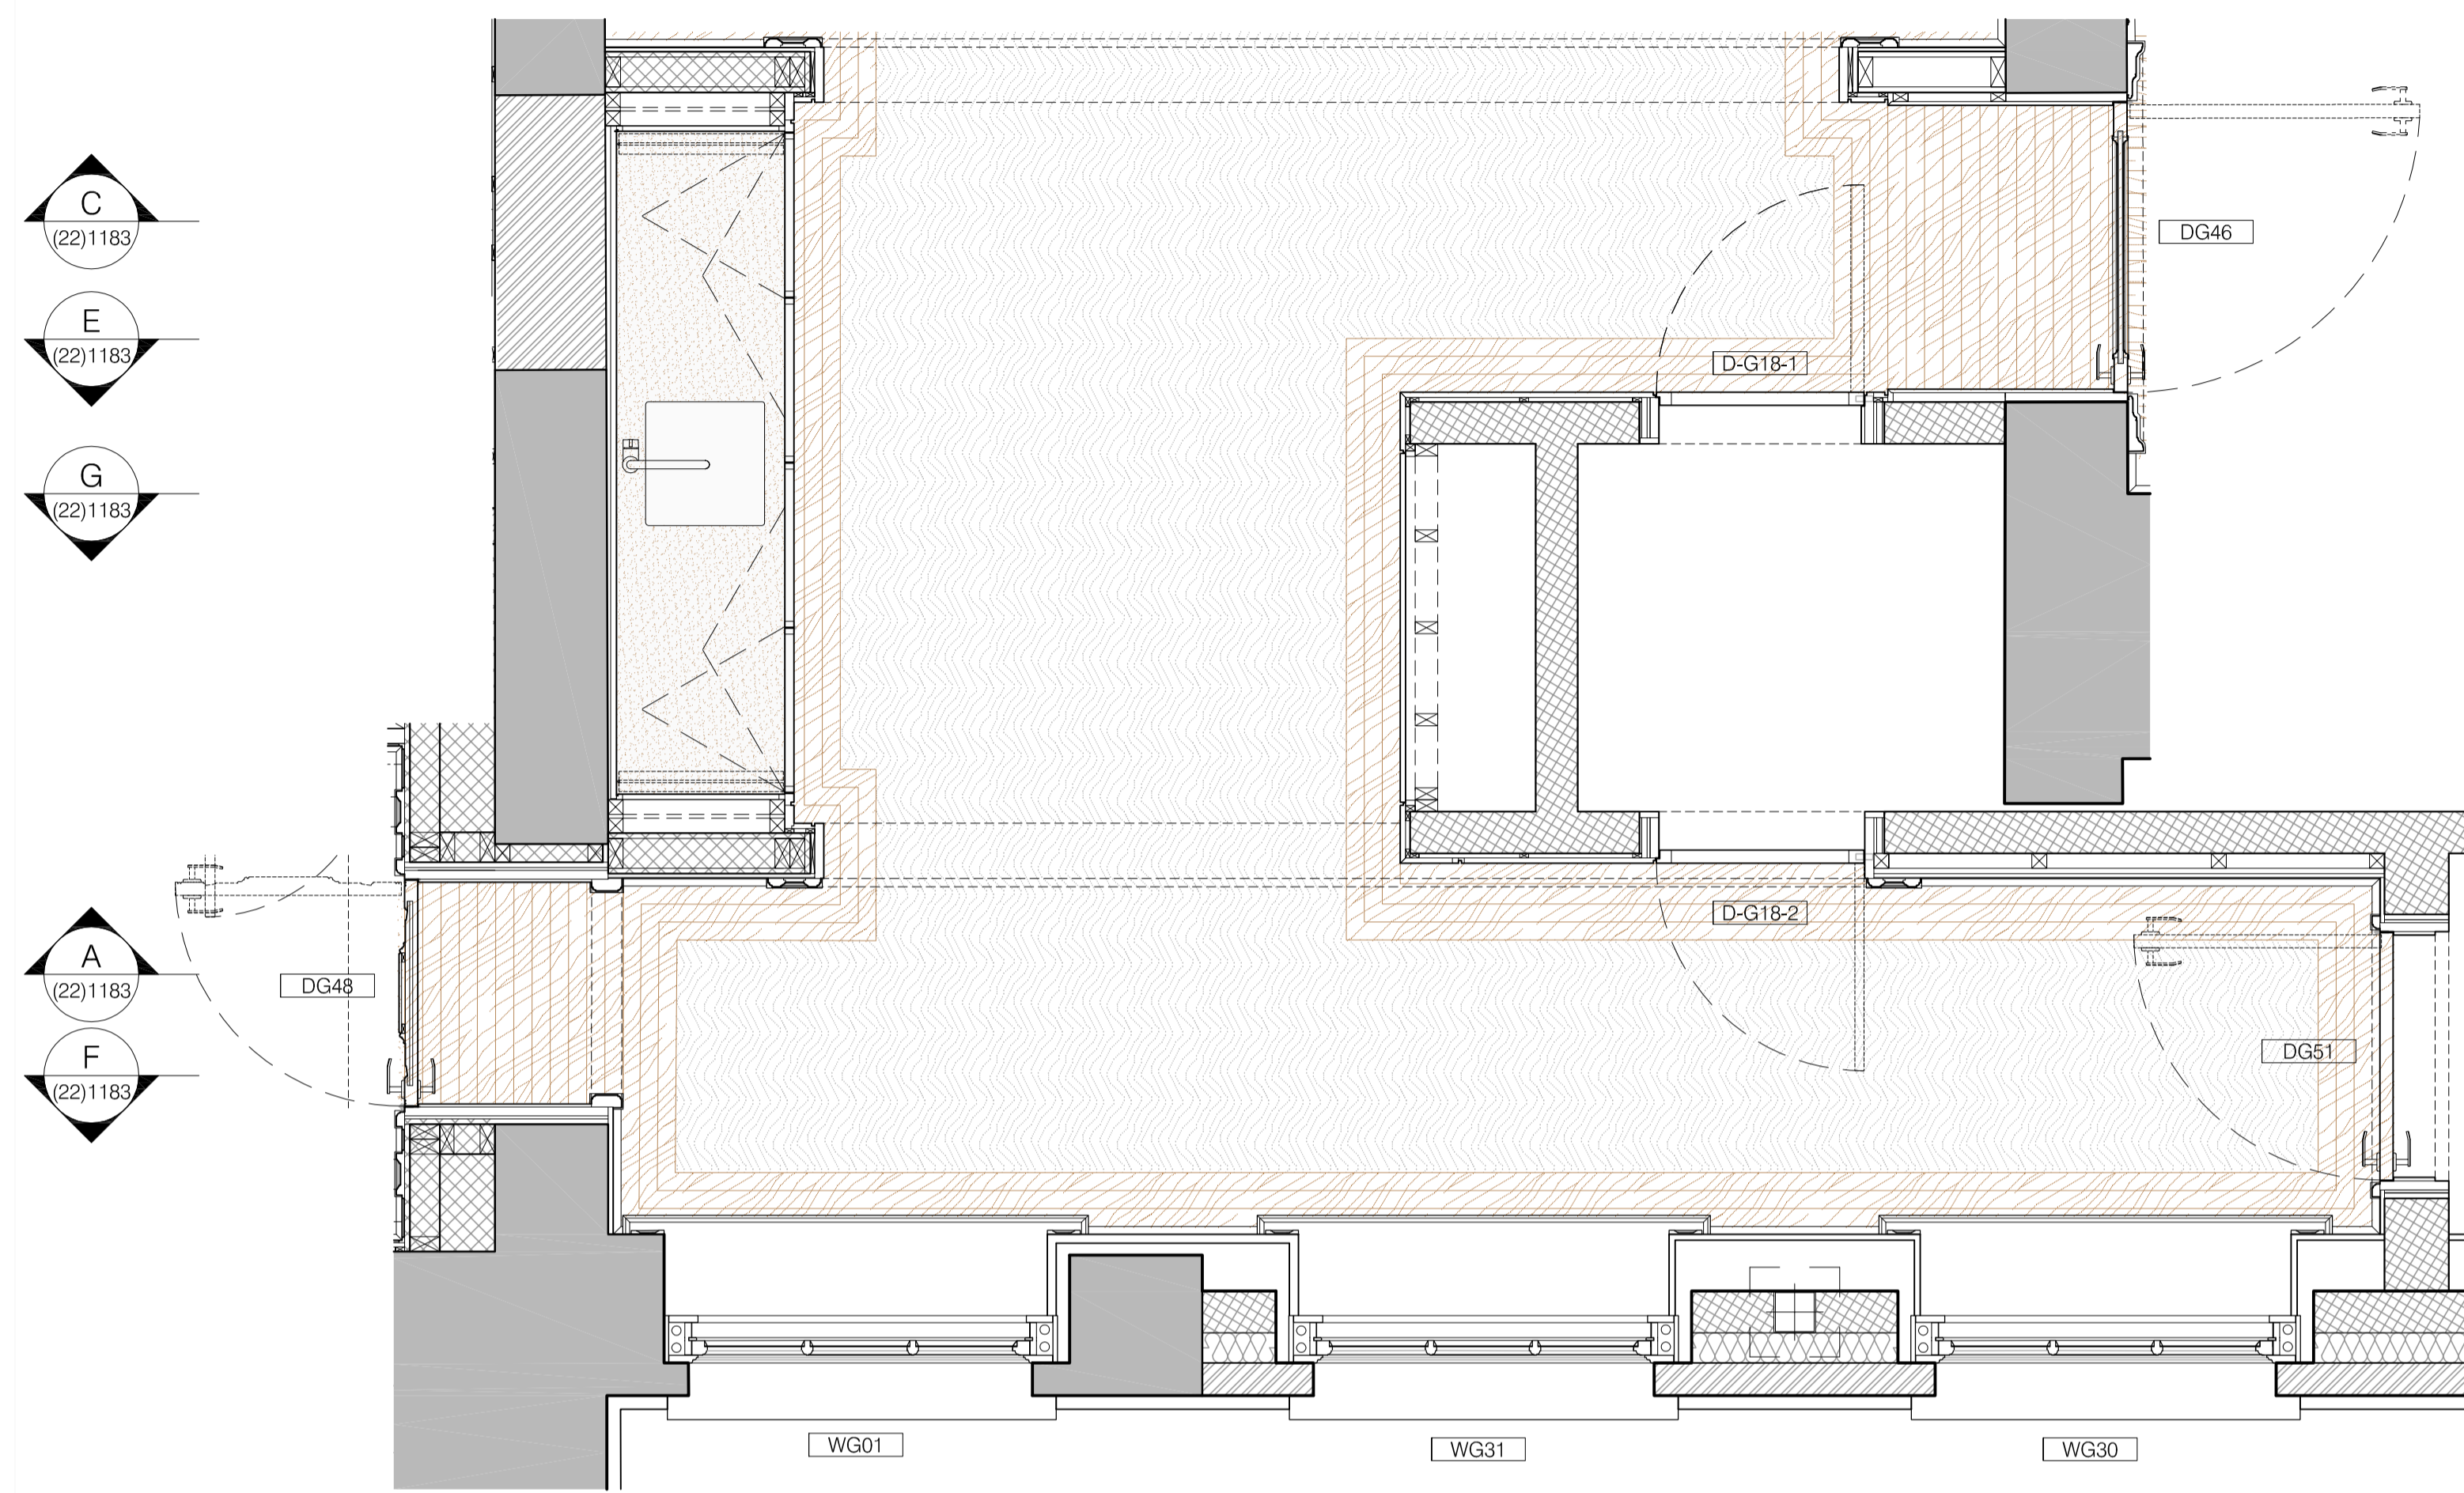

G18A SURVERY PLAN
Scale: 1:20 @ A1

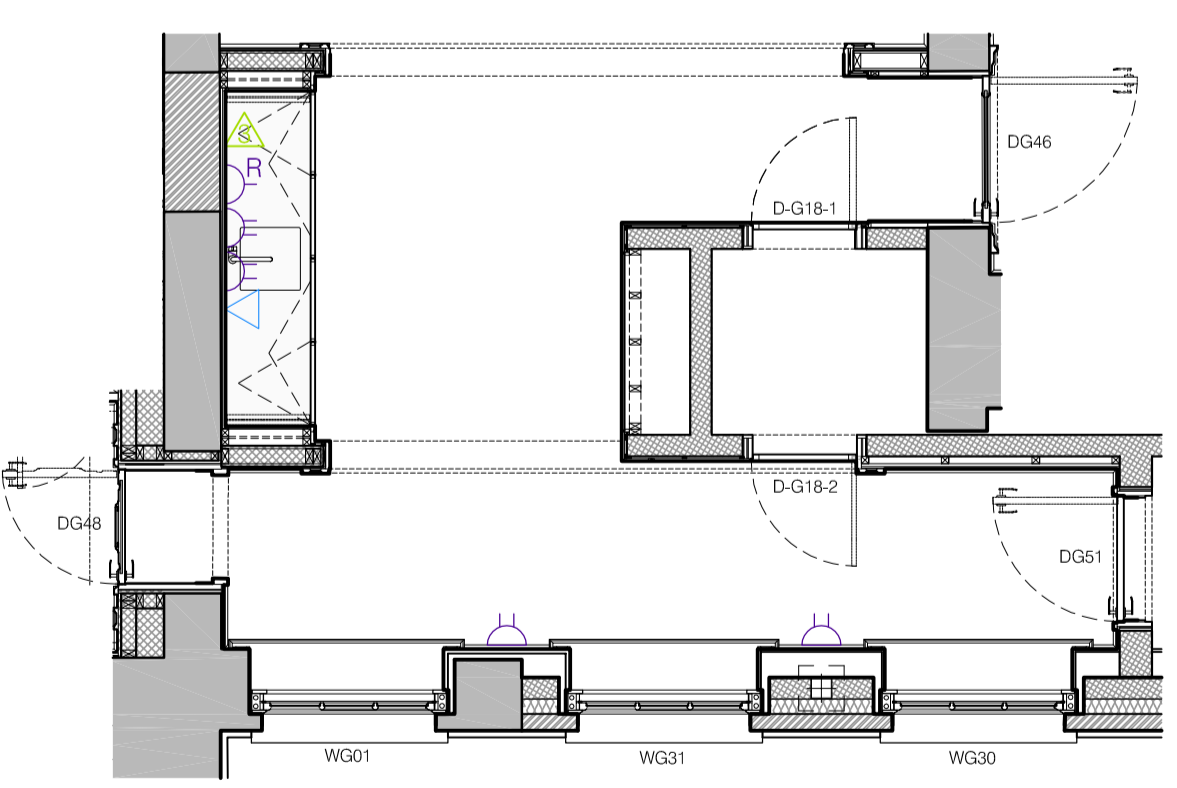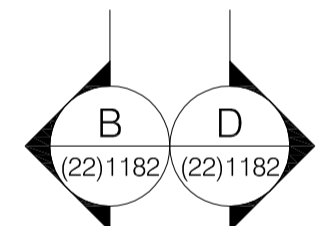

G18A SURVERY SMALL POWER PLAN
Scale: 1:50 @ A1

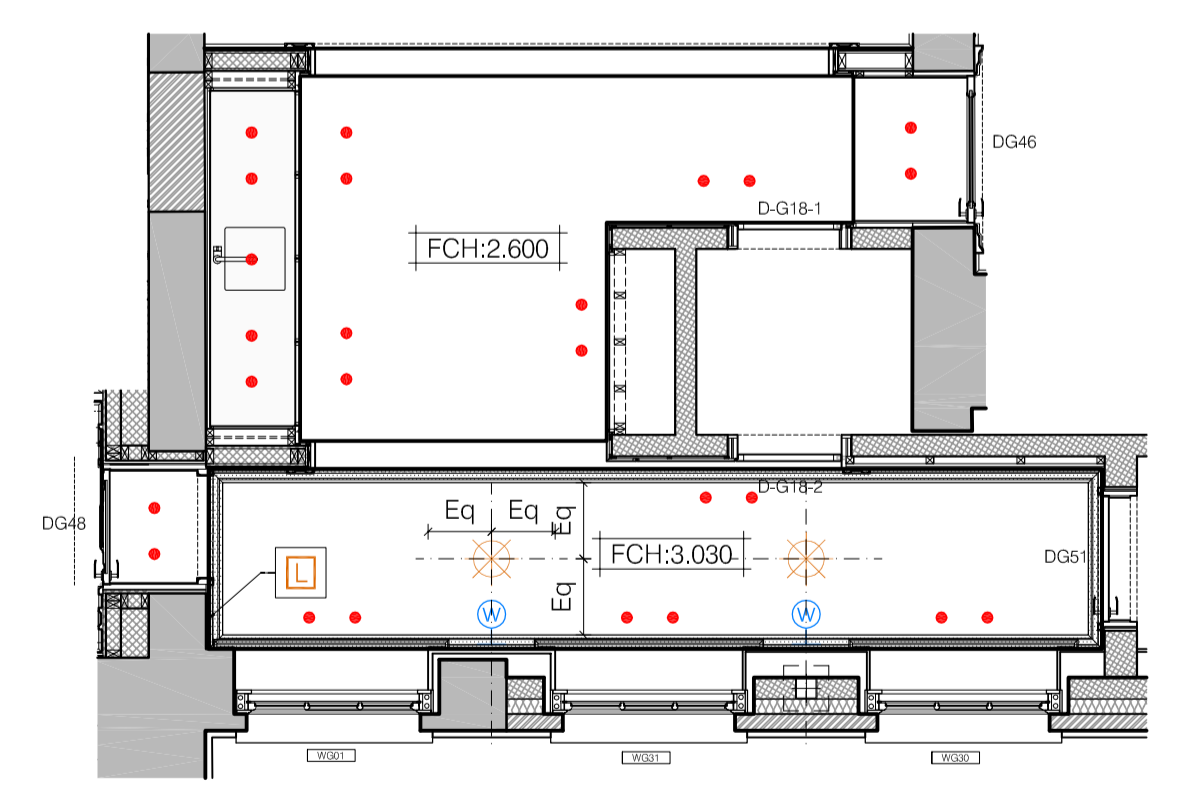


G18A SURVERY RCP & LIGHTING PLAN
Scale: 1:50 @ A1



G18A SURVERY ELEVATION B
Scale: 1:20 @ A1



G18A SURVERY ELEVATION D
Scale: 1:20 @ A1

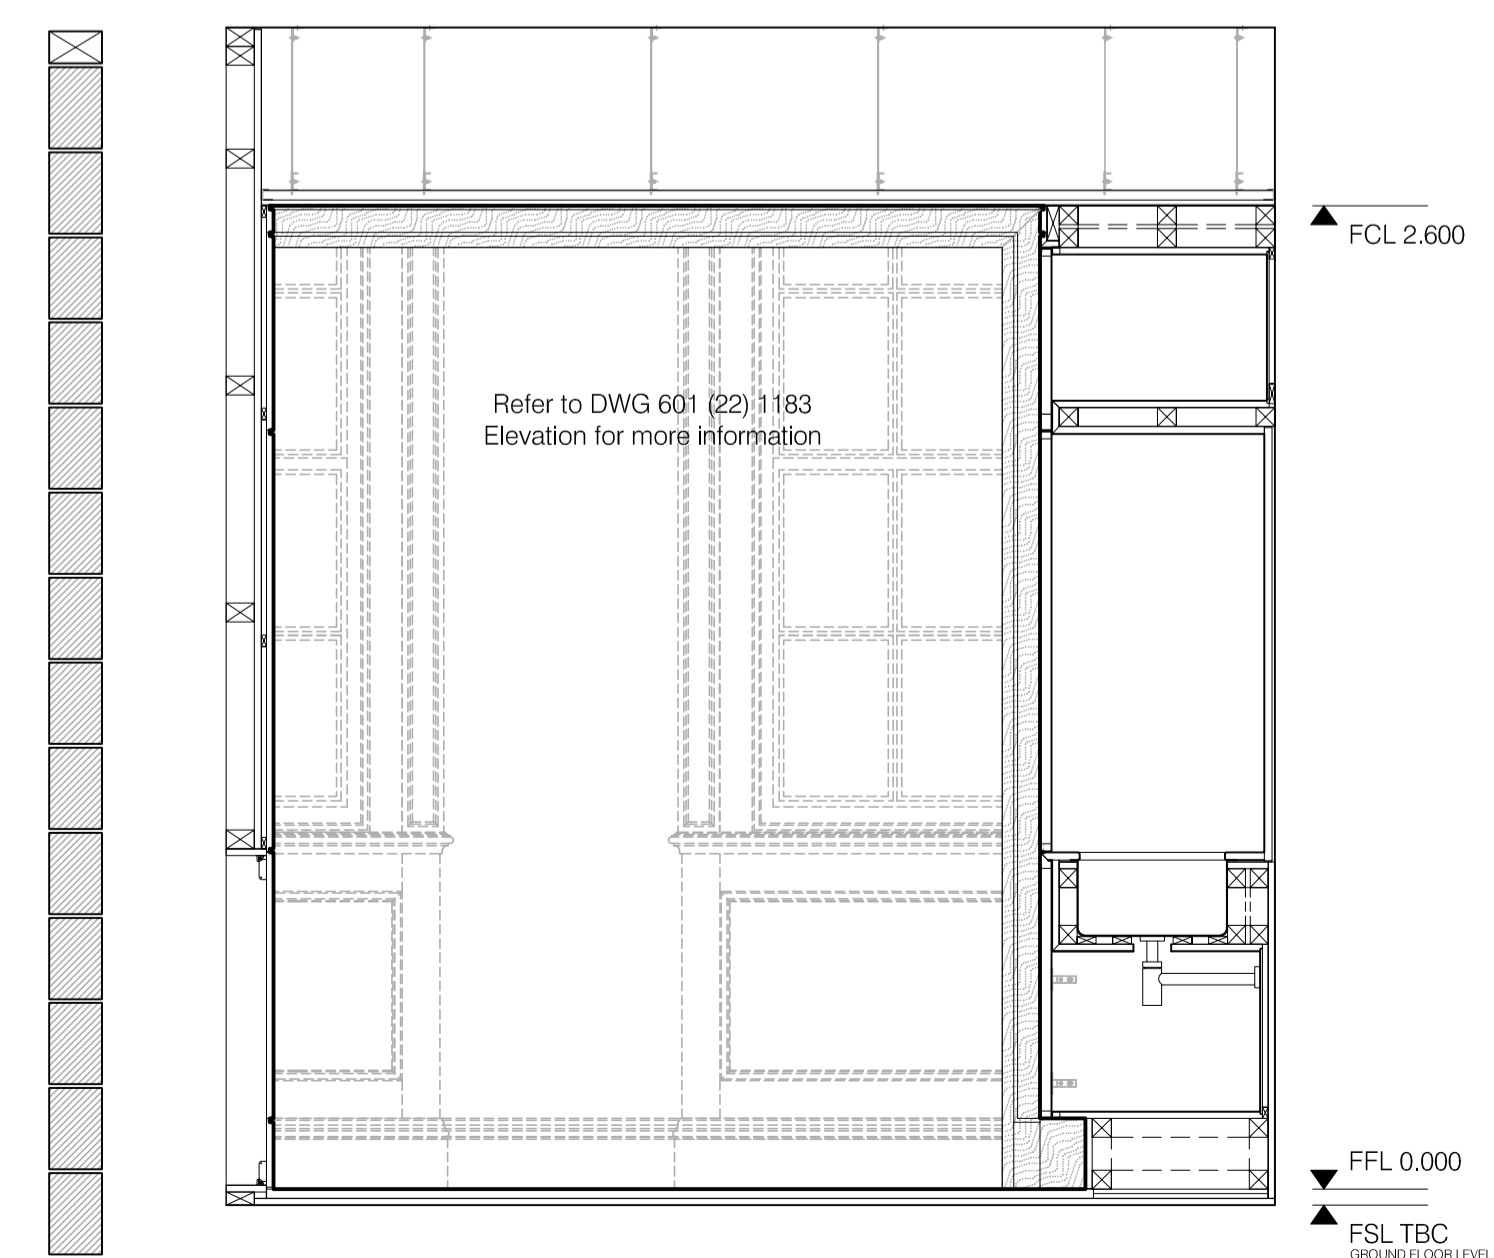

G18A SURVERY ELEVATION G
Scale: 1:20 @ A1

ITEM KEY

	CHANDELIER
	FIBER OPTIC DOWNLIGHTER
	WALL LIGHTS

	TELEPHONE POINT
	13A DOUBLE SOCKET OUTLET
	IPOD DOCK 3XCATS
	LUTRON KEY PAD

- NOTES:
- DRAWING TO BE READ IN CONJUNCTION WITH RELEVANT SCHEDULES
 - ALL DIMENSIONS SUBJECT TO CHECKING ON SITE
 - FOR SETTING OUT REFER TO ELEVATIONS OR TO BE CONFIRMED BY GABHAN O'KEEFFE STUDIO

TENDER

GABHAN O'KEEFFE ARCHITECTURAL AND INTERIOR DESIGN
3 KINNERTON PLACE SOUTH LONDON SW13 8EJ
Tel (020) 7828 1573 Fax (020) 7259 5674

PROJECT: 601	DRAWING TITLE: G18A SURVERY PLANS AND ELEVATIONS		
DATE: 09-08-11	DRAWN: OK	SCALE: AS SHOWN @ A1	REV: T1
PROJ. No: 601	SERIES: (22)	DRAWING No: 1182	