


© THIS DRAWING IS THE COPYRIGHT PROPERTY OF THURGOOD DESIGN LIMITED AND IS THEREFORE CONFIDENTIAL AND MUST NOT BE LENT, COPIED, REPRODUCED IN ANY WAY WHATSOEVER WITHOUT WRITTEN PERMISSION.

NOTES:

GENERAL LEGEND

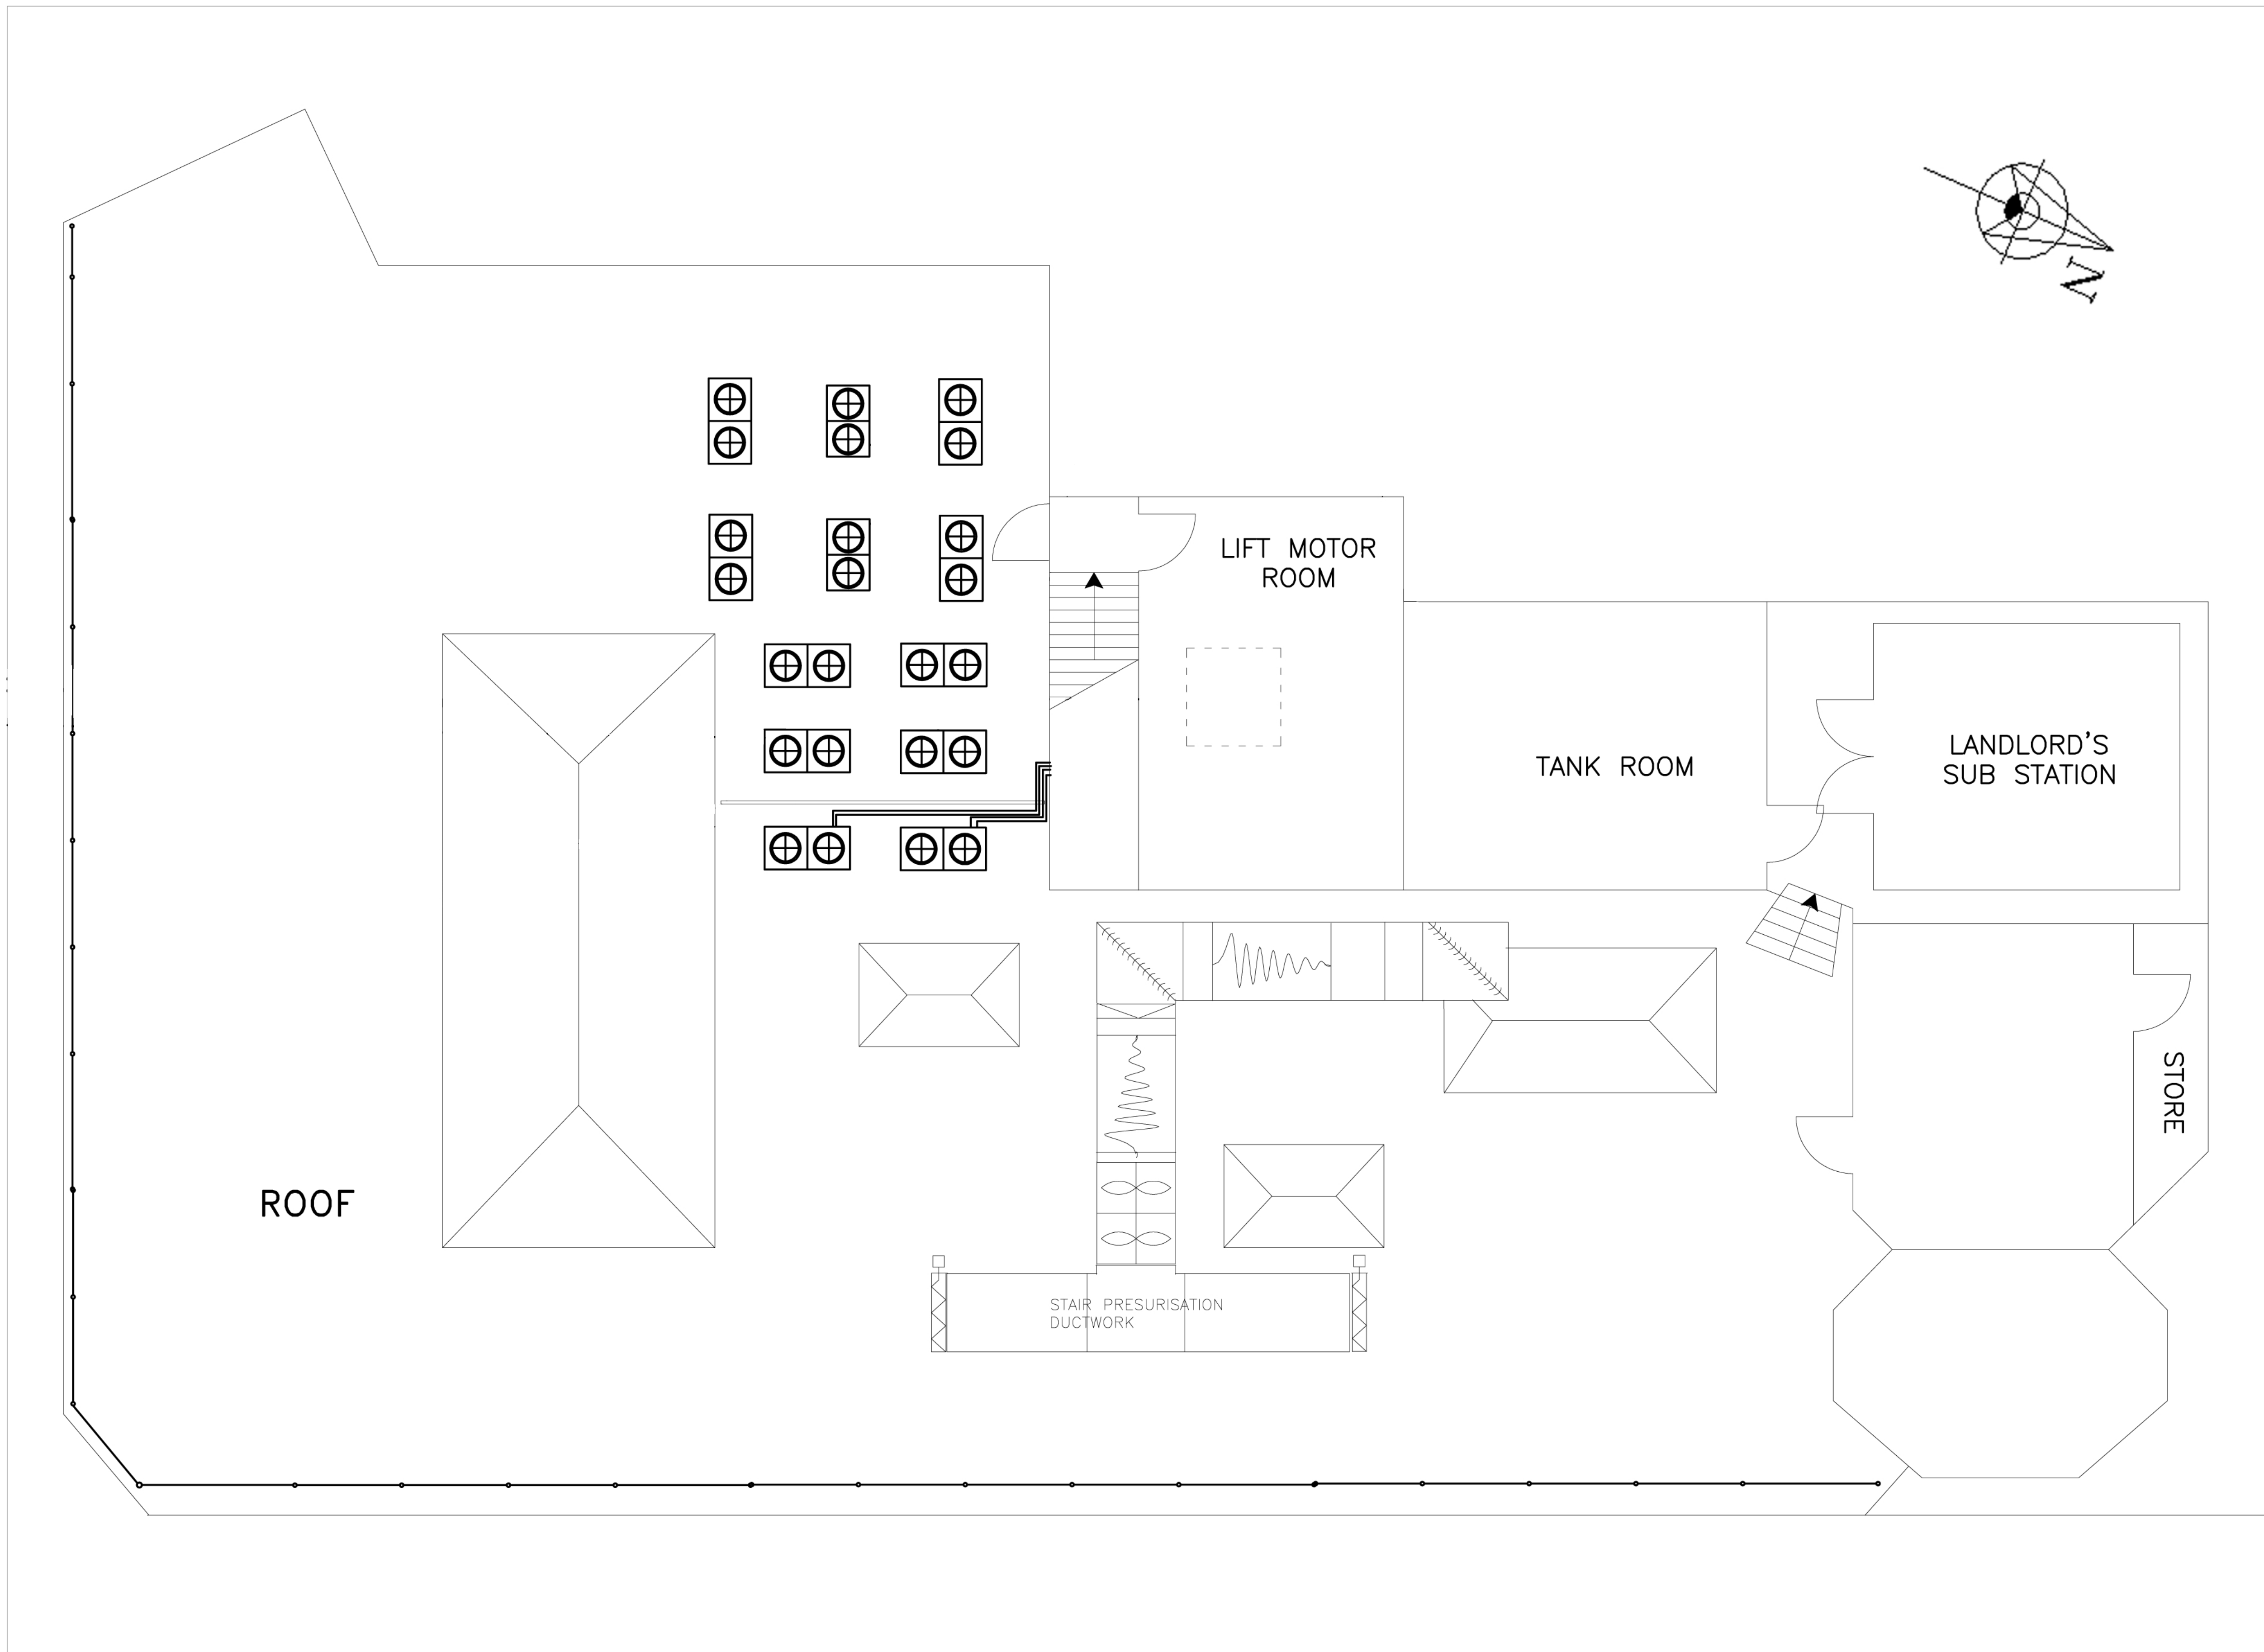

A	CONSTRUCTION ISSUE	4-10-10
T	VRV UNITS 2 PIPE NOT 3 PIPE	17-9-10
Rev	Description	Date

Drawing Status:
CONSTRUCTION

**THURGOOD
DESIGN
LIMITED
CONSULTING
ENGINEERS**

HADDINN HOUSE
58 WOODCOTE AVENUE
WALLINGTON
SURREY SM6 0QY
Tel. 020 8847 0404
Fax. 020 8847 0405
E-mail: pthurgood@tduk.net

Client: TRAGUS GROUP PLC

Architect:

Project: 67 KINGSWAY

Title: EXISTING ROOF PLAN

Drawn: MT	Chkd PT	Scale: 1:50@A1	Date: SEP 2010
Project N°/Drawing N° 323/M/06			Revision: A