


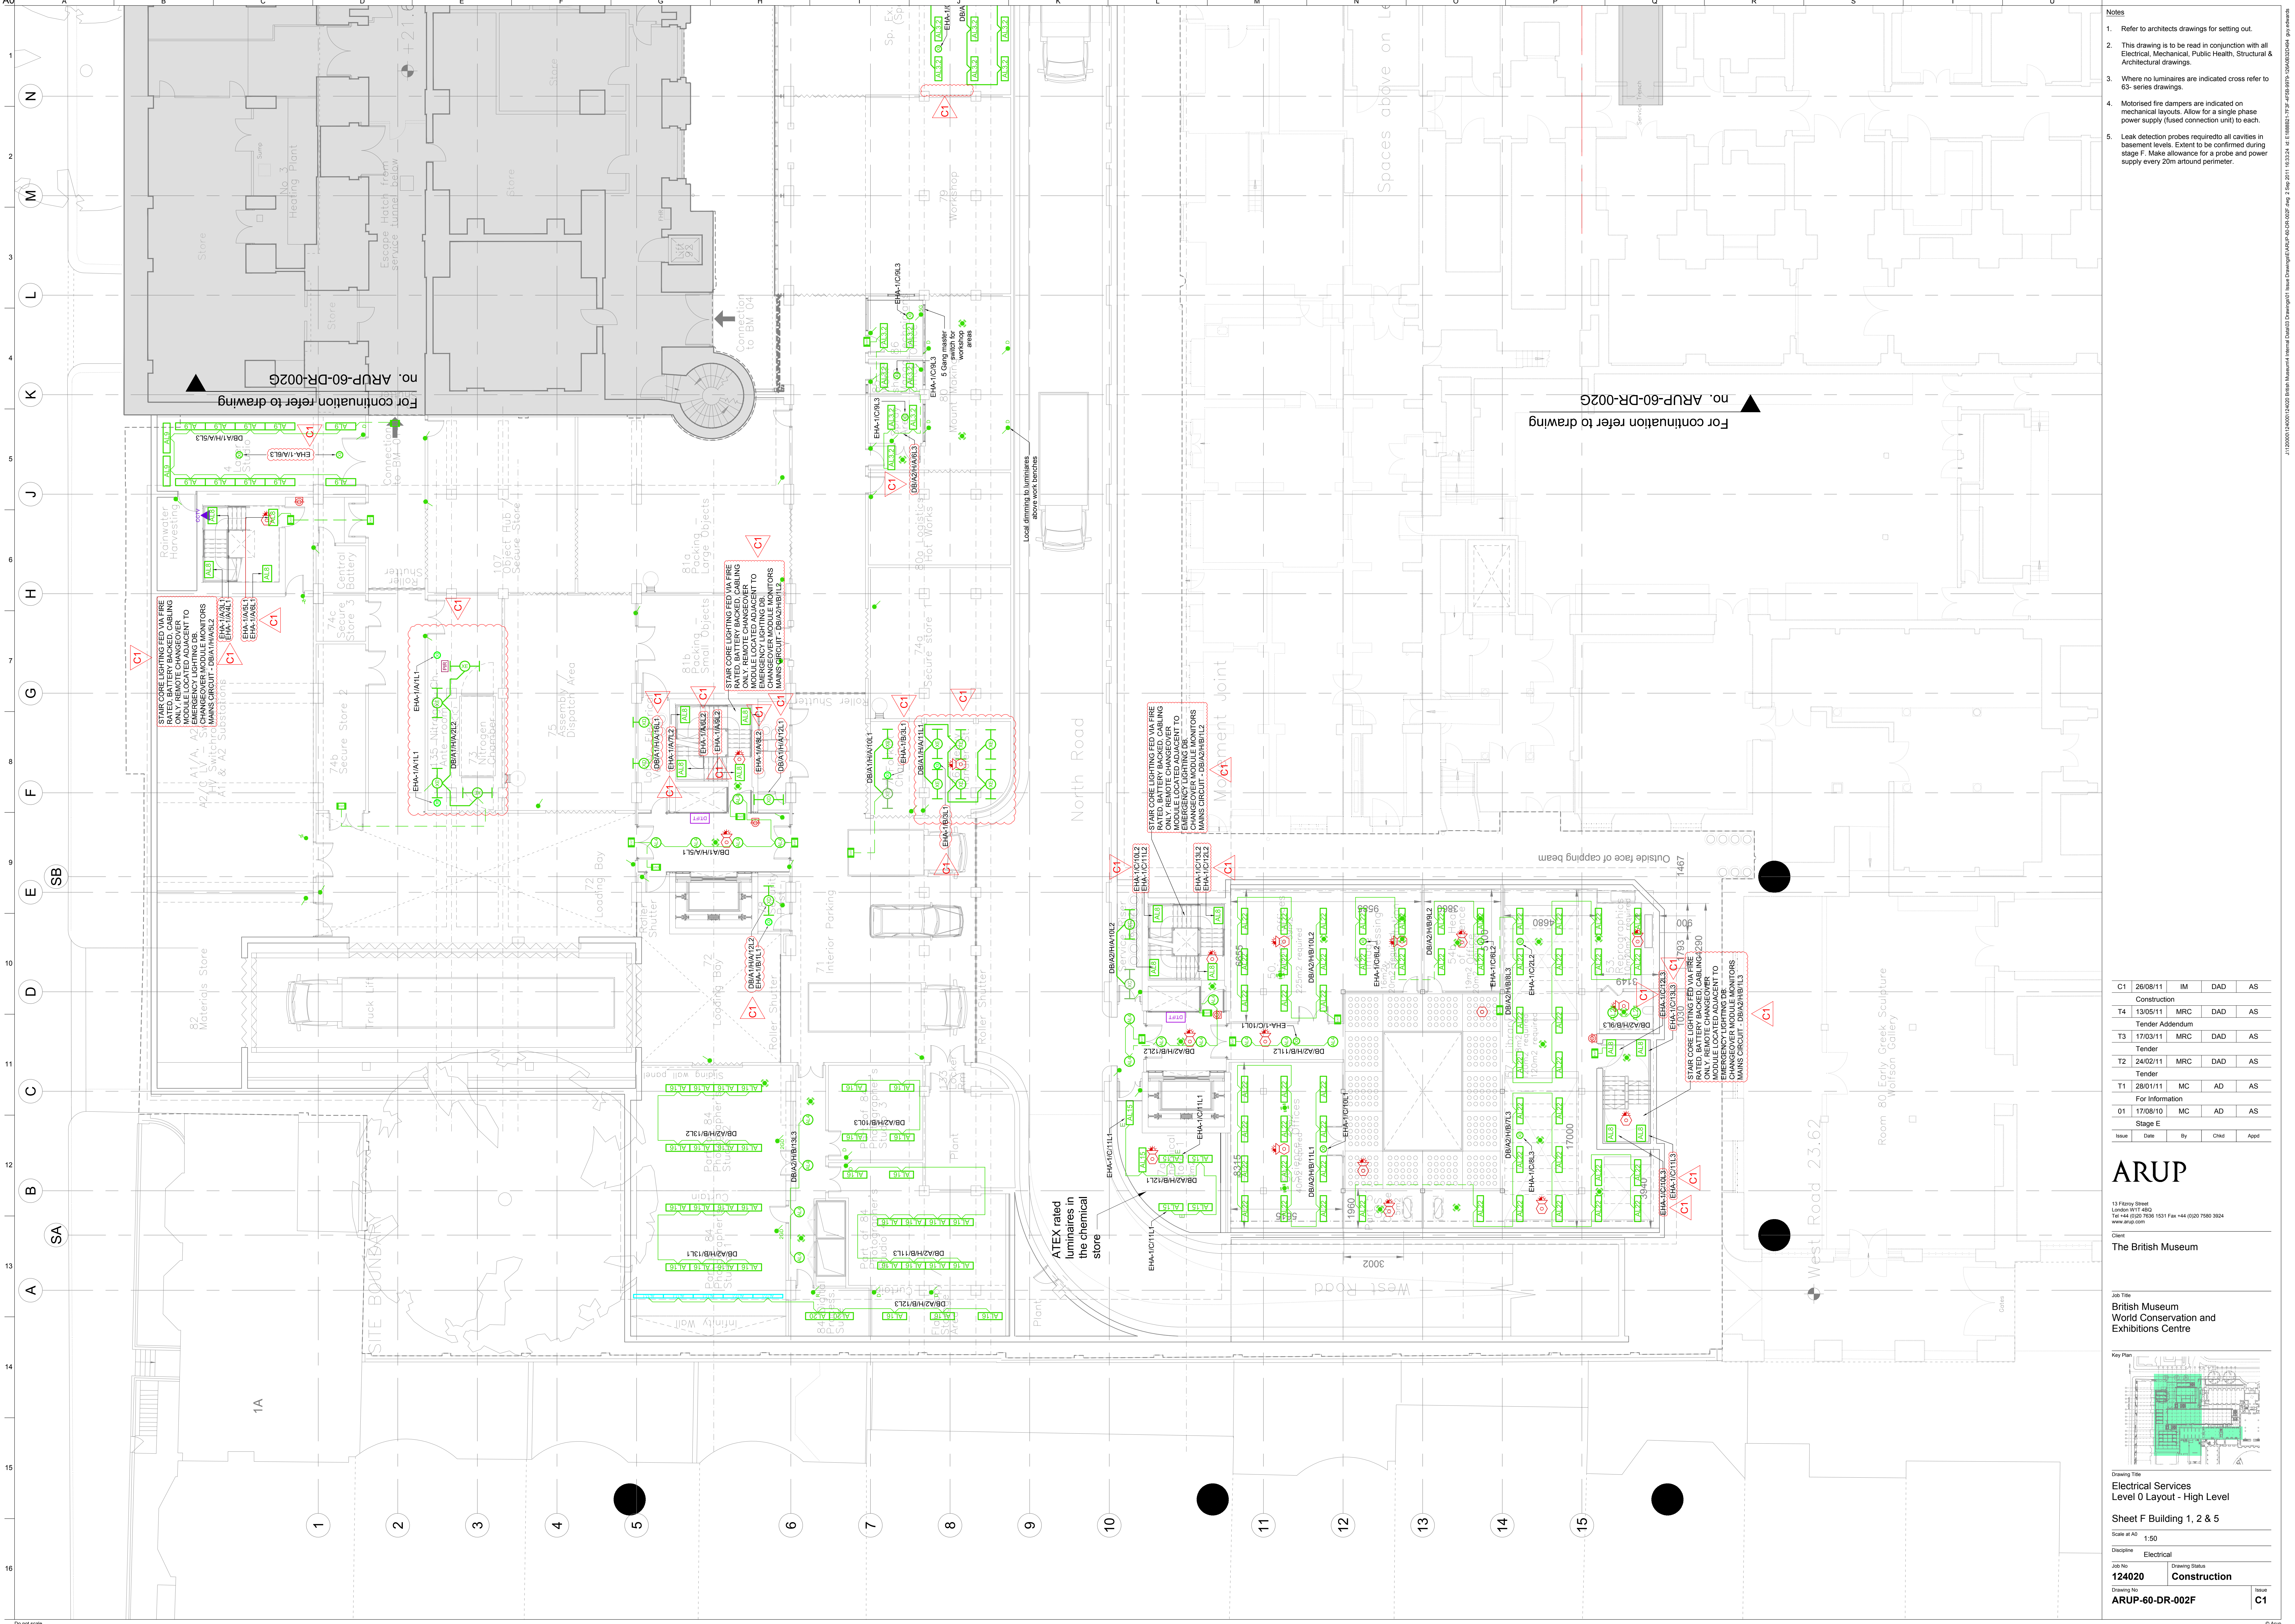

Notes

1. Refer to architects drawings for setting out.

2. This drawing is to be read in conjunction with all Electrical, Mechanical, Public Health, Structural & Architectural Drawings.

3. Where no luminaires are indicated cross refer to 655 series drawings.

4. Motorised fire dampers are indicated on mechanical layouts. Allow for a single phase power supply (fused connection unit) to each.

5. Leak detection probes required to all cavities in basement levels. Extent to be confirmed during stage F. Make allowance for a probe and power supply every 20m around perimeter.

13 Finsbury Street
London W1T 6BQ
Tel +44 (0)20 7551 1531 Fax +44 (0)20 7551 3024
www.arup.com

Client

The British Museum

Job Title

British Museum
World Conservation and
Exhibitions Centre

Key Plan

Drawing Title

Electrical Services
Level 0 Layout - High Level

Sheet F Building 1, 2 & 5

Scale at A0

1:50

Discipline

Electrical

Job No

124020

Drawing Status

Construction

Drawing No

ARUP-60-DR-002F

Issue

C1

C1

26/08/11

IM

DAD

AS

T4

13/05/11

MRC

DAD

AS

T3

17/03/11

MRC

DAD

AS

T2

24/02/11

MRC

DAD

AS

T1

28/01/11

MC

AD

AS

01

17/08/10

MC

AD

AS

Issue

Date

By

Chkd

Appd

ARUP

13 Finsbury Street
London W1T 6BQ
Tel +44 (0)20 7551 1531 Fax +44 (0)20 7551 3024
www.arup.com

Client

The British Museum

Job Title

British Museum
World Conservation and
Exhibitions Centre

Key Plan

Drawing Title

Electrical Services
Level 0 Layout - High Level

Sheet F Building 1, 2 & 5

Scale at A0

1:50

Discipline

Electrical

Job No

124020

Drawing Status

Construction

Drawing No

ARUP-60-DR-002F

Issue

C1

C1

26/08/11

IM

DAD

AS

T4

13/05/11

MRC

DAD

AS

T3

17/03/11

MRC

DAD

AS

T2

24/02/11

MRC

DAD

AS

T1

28/01/11

MC

AD

AS

01

17/08/10

MC

AD

AS

Issue

Date

By

Chkd

Appd