
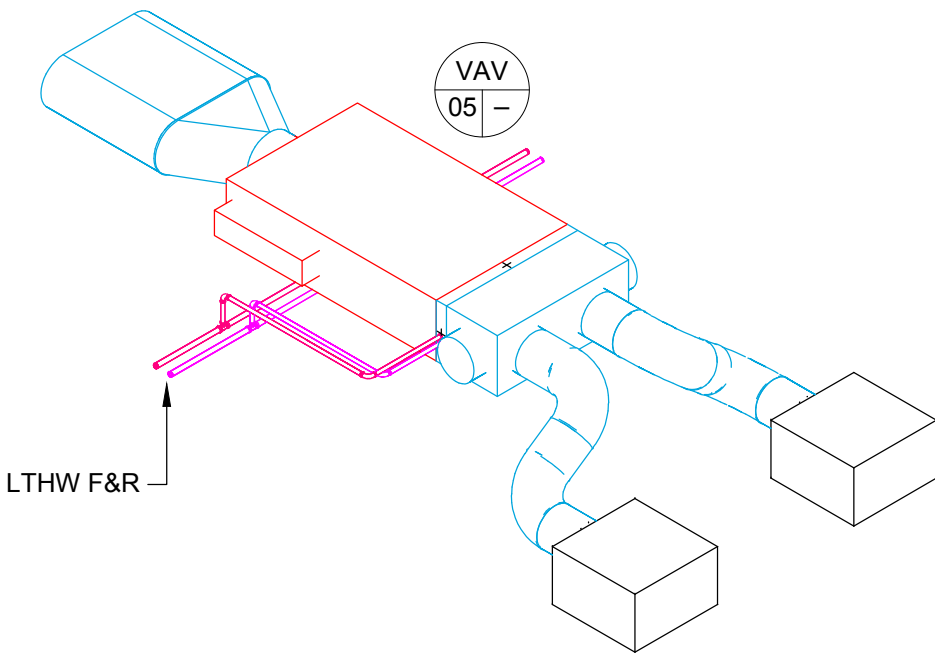
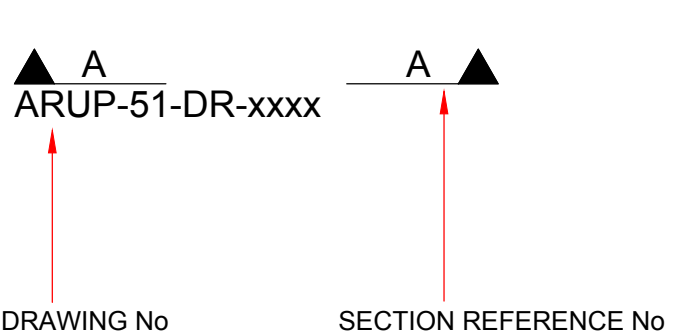
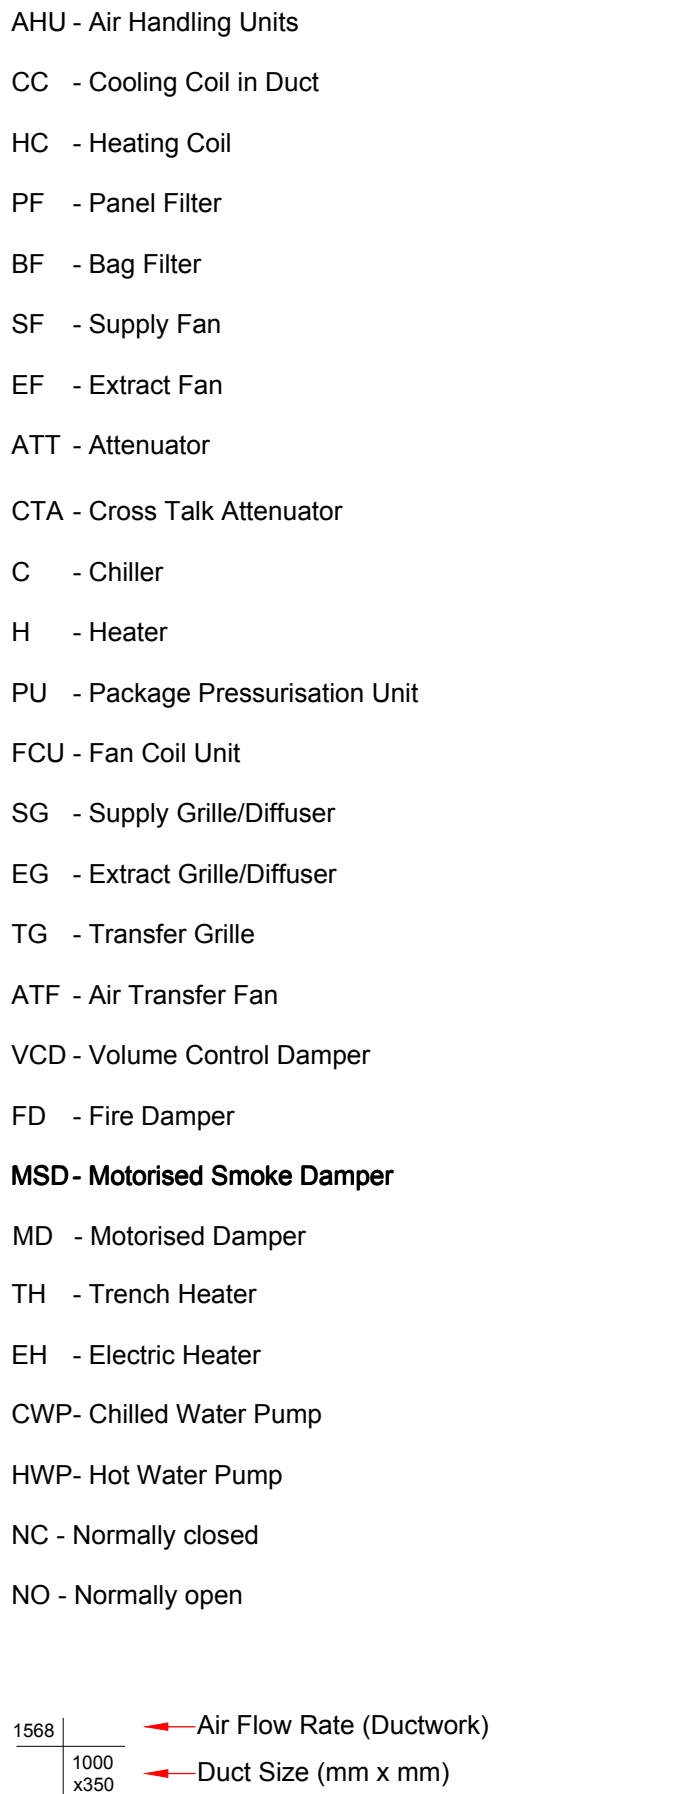
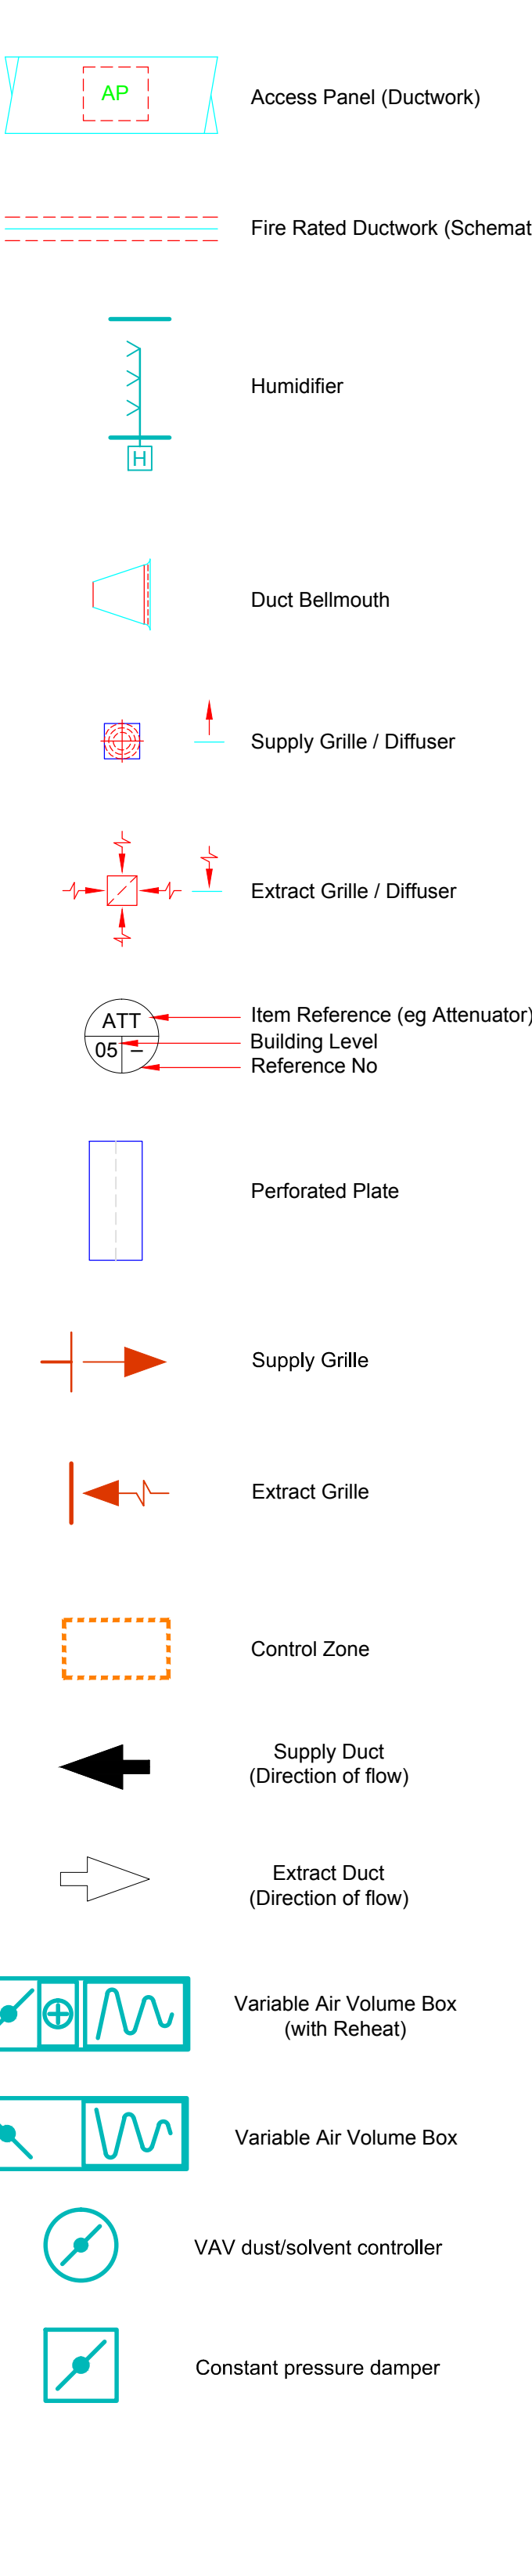
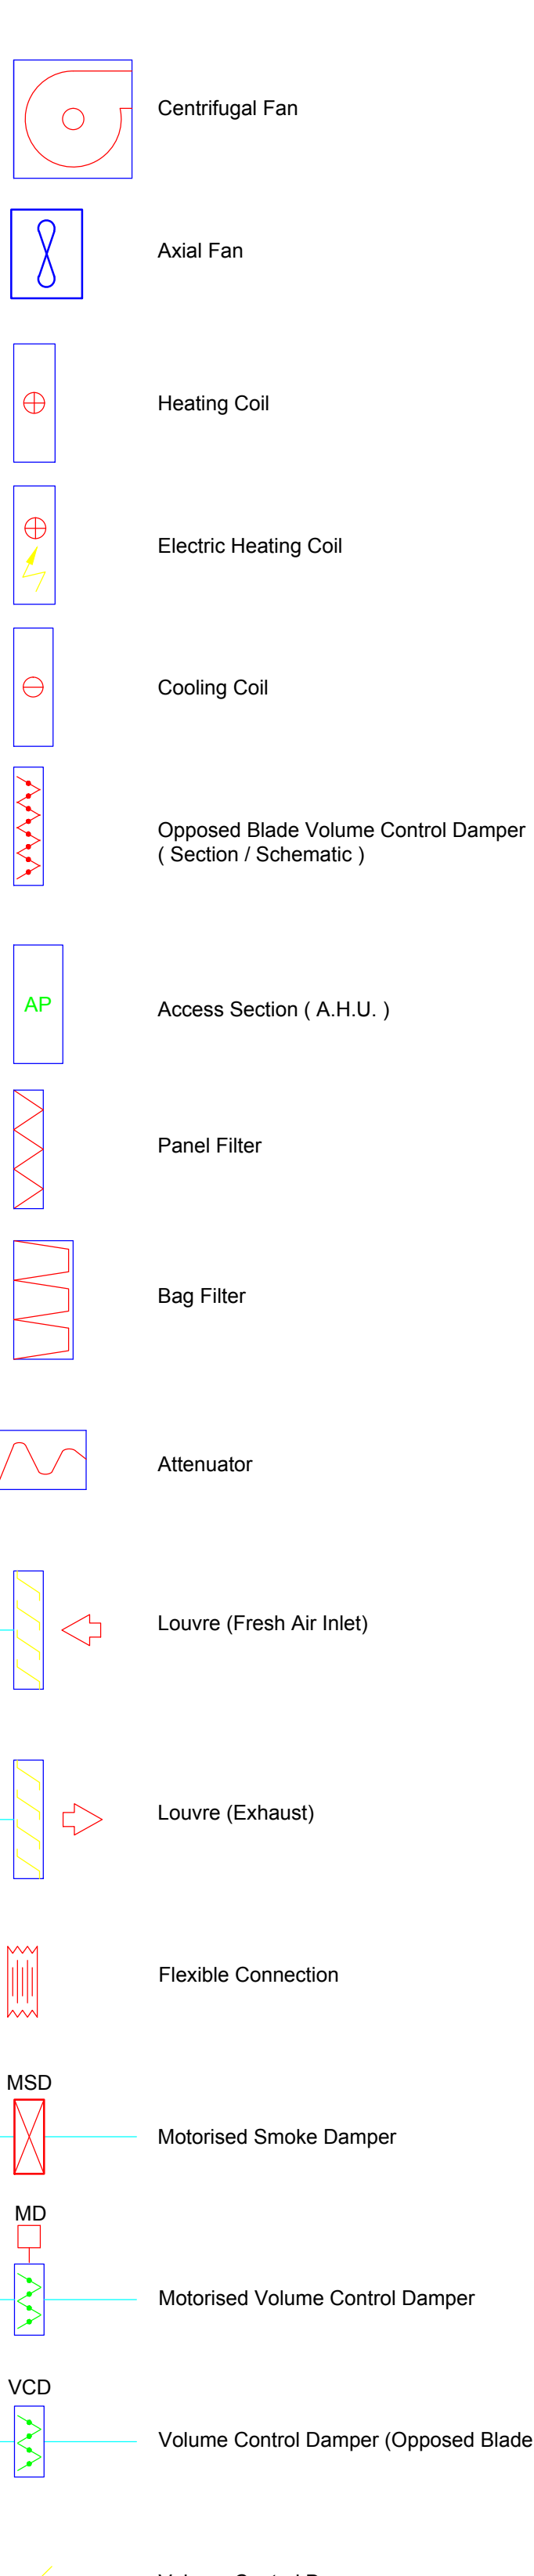


PIPEWORK LEGEND AND SYMBOLS

DUCTWORK LEGEND AND SYMBOLS

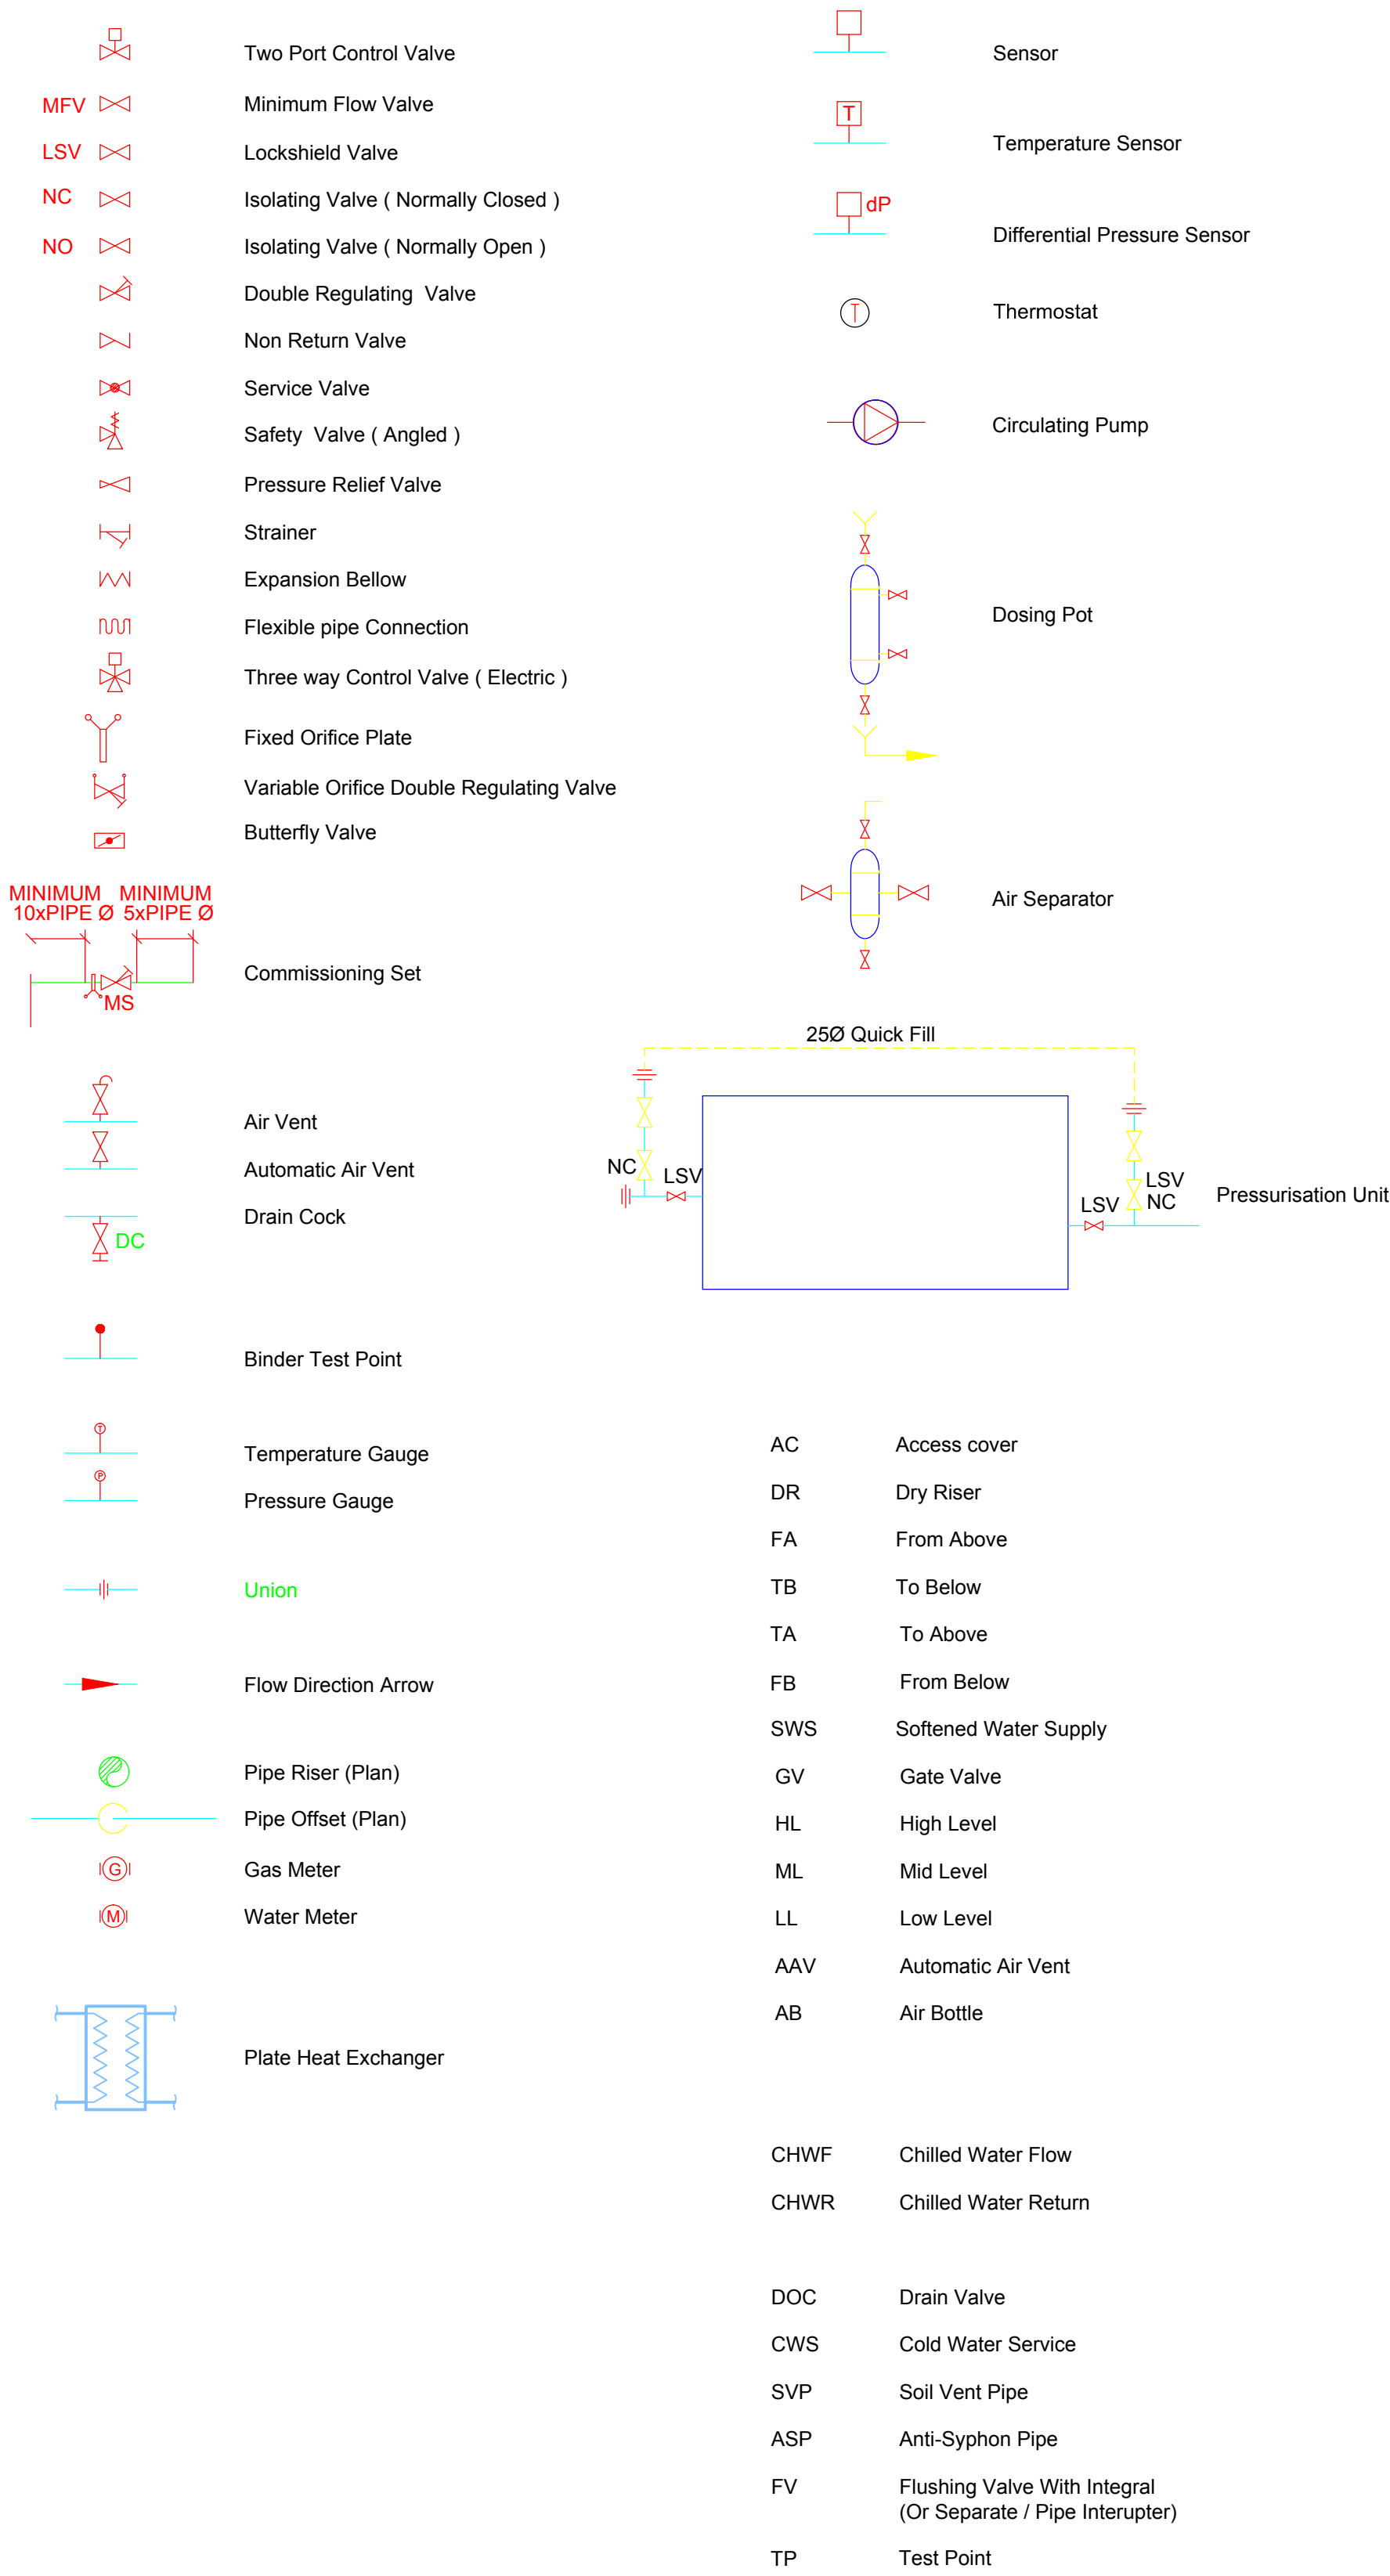

Typical VAV connection detail (NTS)

C1	26/08/11	RW	AD	AS
Construction				
T2	17/03/11	MO	AD	AS
Tender				
T1	28/01/11	MO	AD	AS
For Information				
O2	17/08/10	TB	AD	AS
Stage E				
O1	14/08/09	RW	AD	AS
Stage D Issue				
Issue	Date	By	Chkd	Appd

ARUP

13 Fitzroy Street  
London W1T 4BQ  
Tel +44 (0)20 7636 1531 Fax +44 (0)20 7580 3924  
www.arup.com

Client  
The British Museum

Job Title  
British Museum  
World Conservation and  
Exhibitions Centre

Drawing Title  
Mechanical Services  
Legend

Scale at A1  
N.T.S.

Discipline  
Mechanical

Drawing Status  
Construction

Job No	Drawing No	Issue
124020	ARUP-50-DR-SM00	C1