


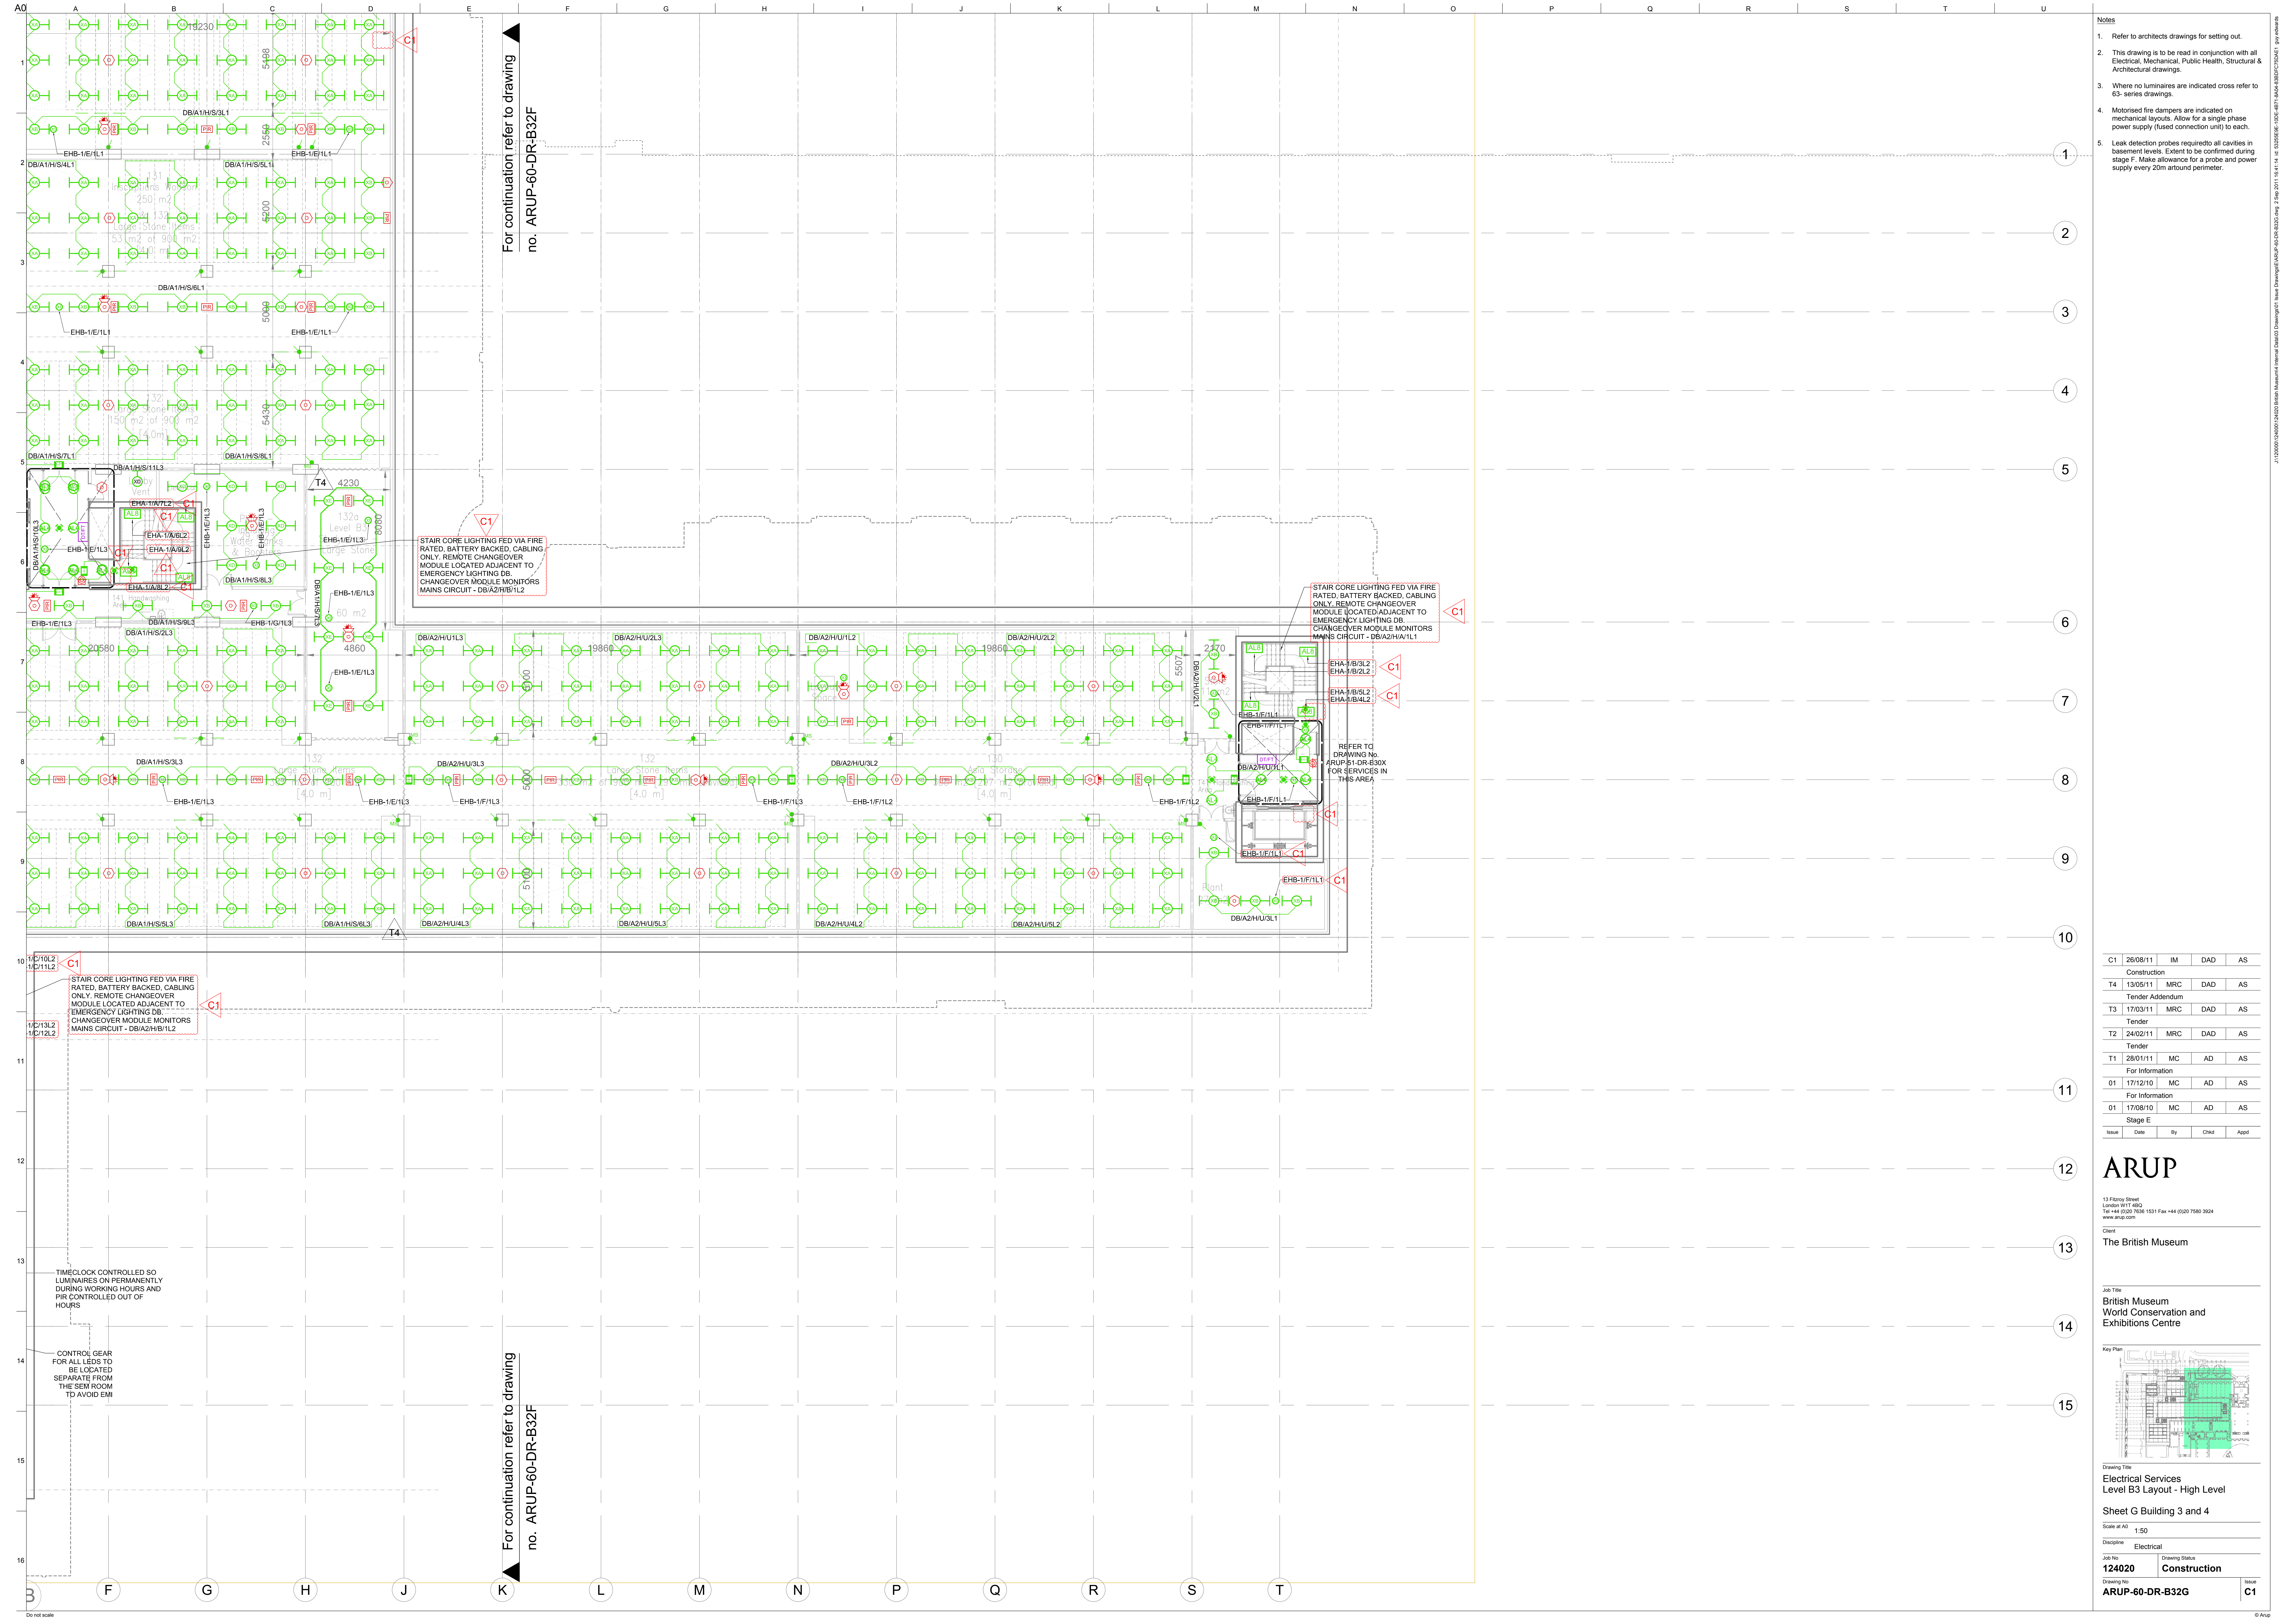

- Notes
1. Refer to architects drawings for setting out.
 2. This drawing is to be read in conjunction with all Electrical, Mechanical, Public Health, Structural & Architectural drawings.
 3. Where no luminaires are indicated cross refer to 65-series drawings.
 4. Motorised fire dampers are indicated on mechanical layouts. Allow for a single phase power supply (fused connection unit) to each.
 5. Leak detection probes required to all cavities in basement levels. Extent to be confirmed during stage F. Make allowance for a probe and power supply every 20m around perimeter.

C1	26/08/11	IM	DAD	AS
Construction				
T4	13/05/11	MRC	DAD	AS
Tender Addendum				
T3	17/03/11	MRC	DAD	AS
Tender				
T2	24/02/11	MRC	DAD	AS
Tender				
T1	28/01/11	MC	AD	AS
For Information				
O1	17/12/10	MC	AD	AS
For Information				
O1	17/08/10	MC	AD	AS
Stage E				
Issue	Date	By	Chkd	Appd

ARUP

13 Finsbury Street
London EC2A 1EJ
Tel: +44 (0)20 7551 1531 Fax: +44 (0)20 7551 3024
www.arup.com

Client
The British Museum

Job Title
**British Museum
World Conservation and
Exhibitions Centre**

Key Plan

Drawing Title
**Electrical Services
Level B3 Layout - High Level**

Sheet **G Building 3 and 4**

Scale at A0
1:50

Discipline
Electrical

Job No
124020

Drawing Status
Construction

Drawing No
ARUP-60-DR-B32G

Total
C1