


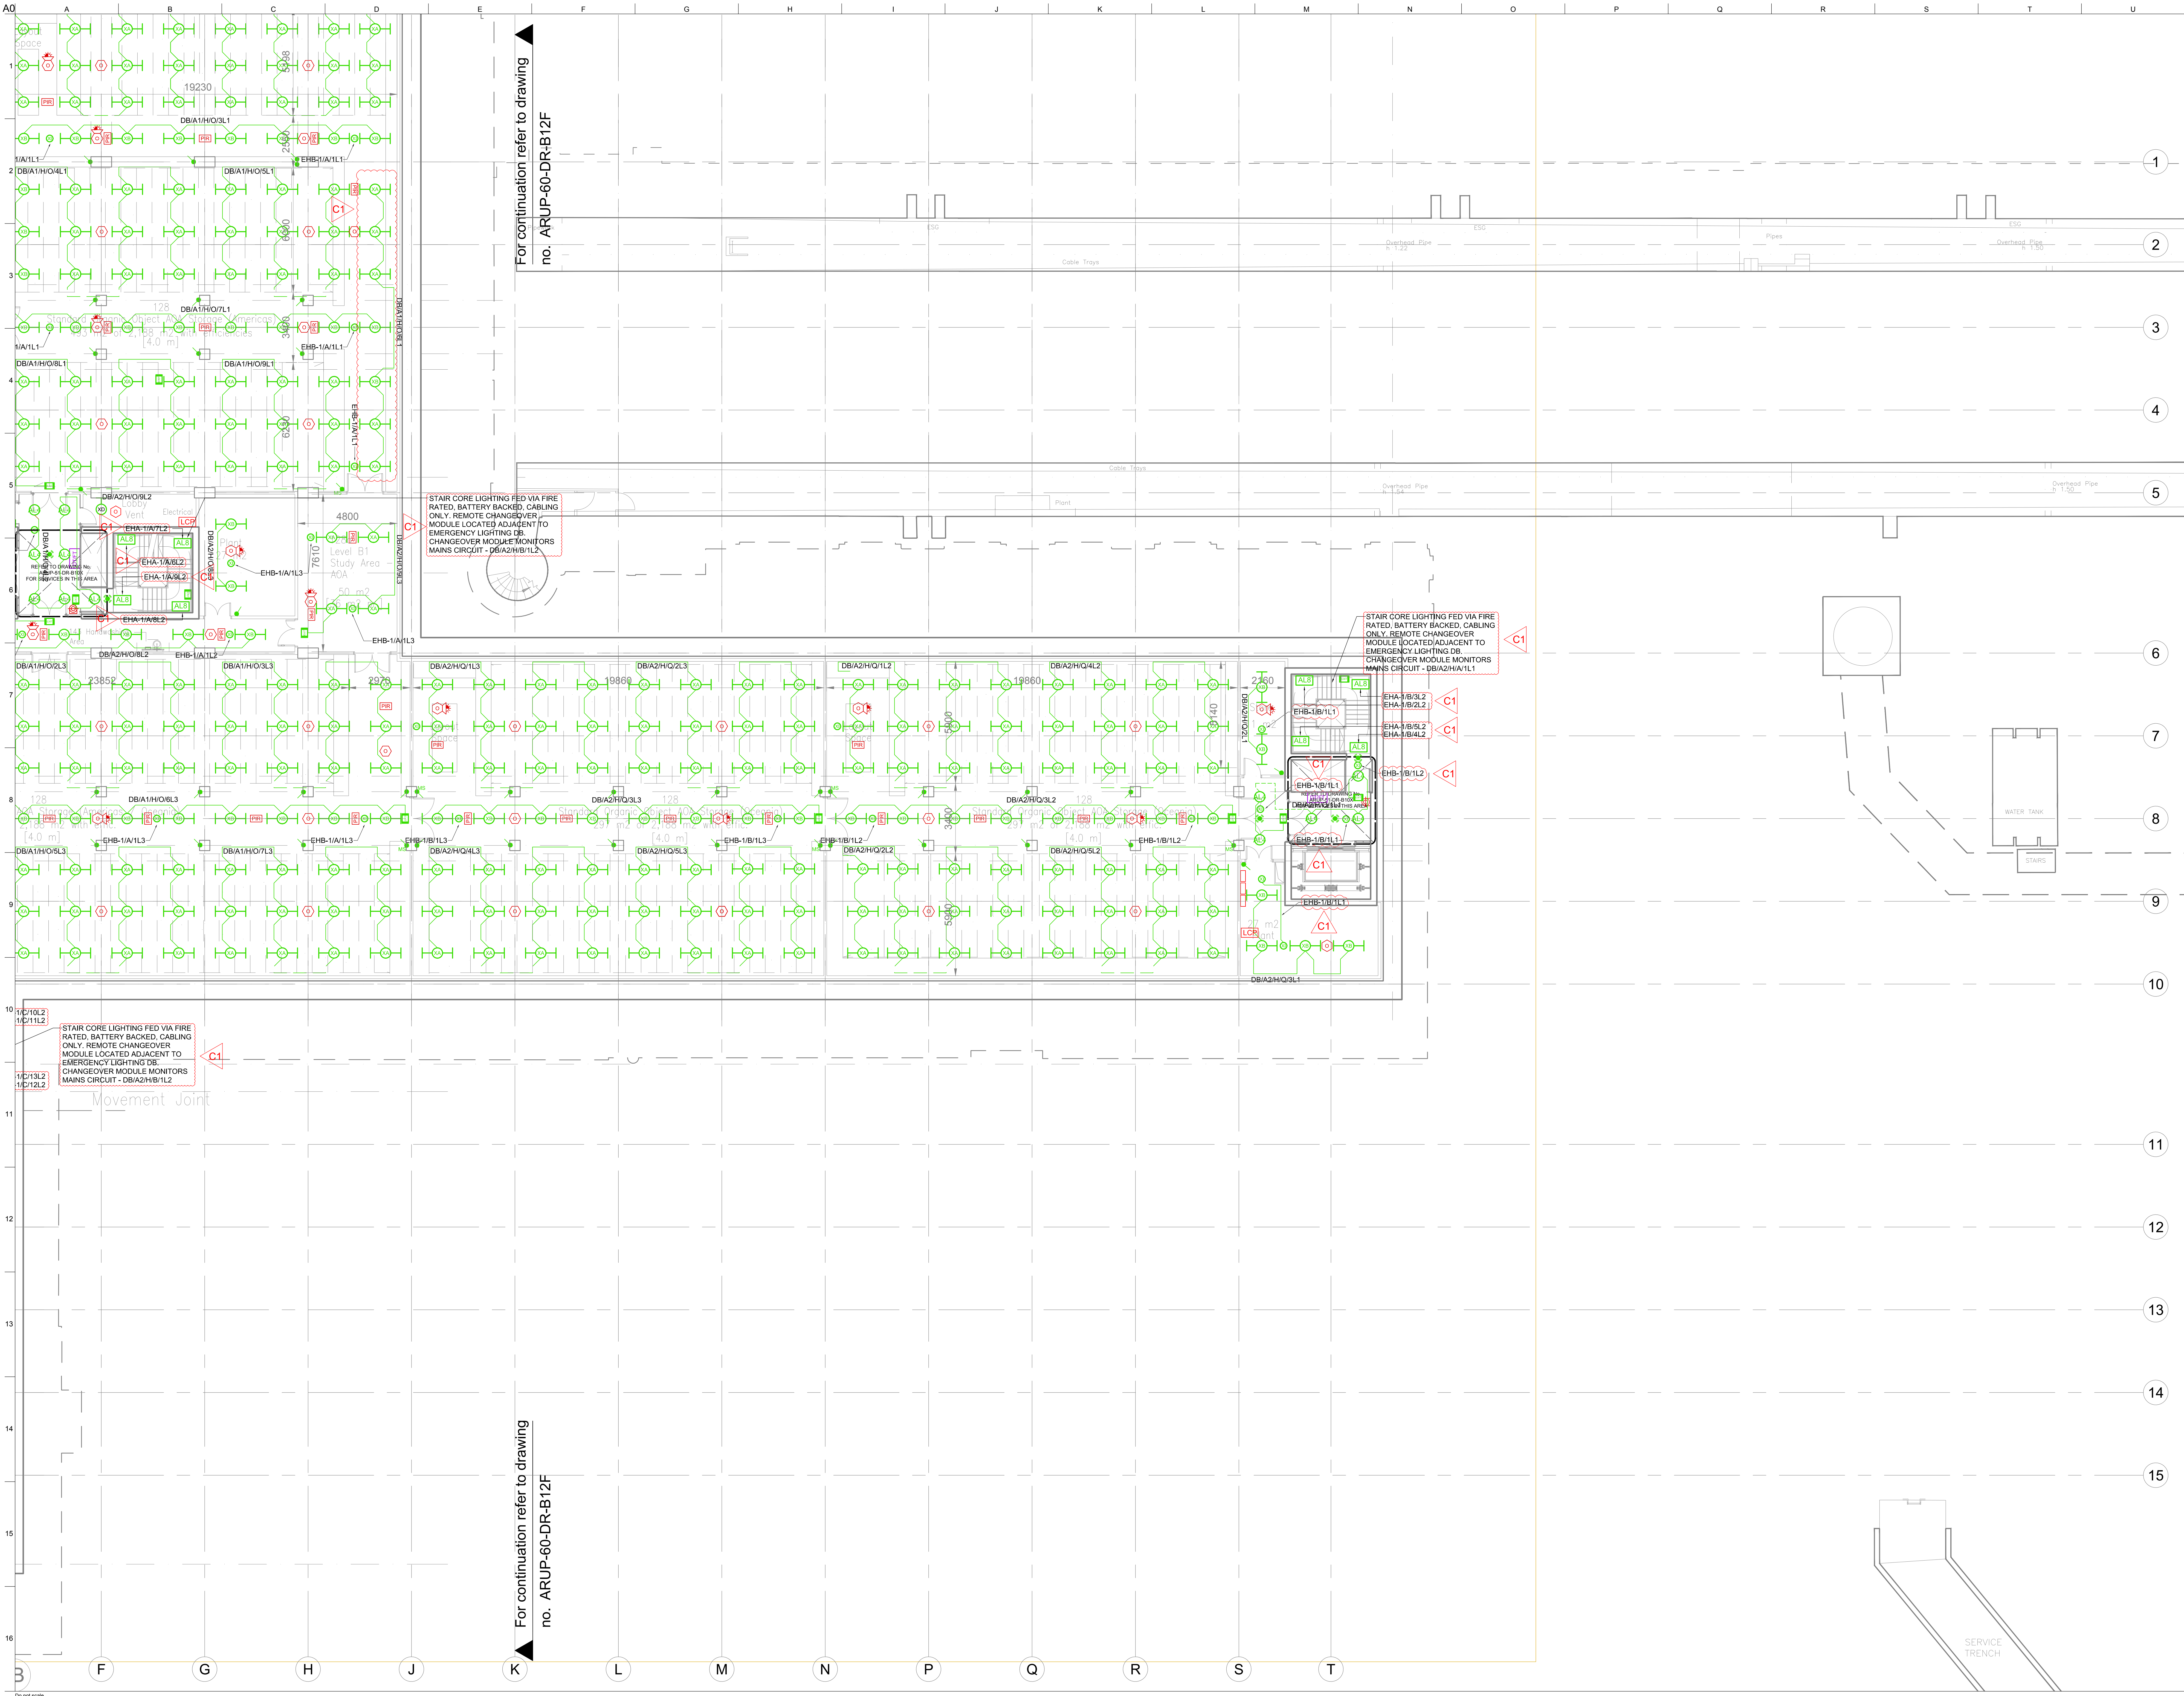

Notes

- Refer to architects drawings for setting out.
- This drawing is to be read in conjunction with all Electrical, Mechanical, Public Health, Structural & Architectural drawings.
- Where no luminaires are indicated cross refer to E5-series drawings.
- Motorised fire dampers are indicated on mechanical layouts. Allow for a single phase power supply (fused connection unit) to each.
- Leak detection probes required to all cavities in basement levels. Extent to be confirmed during stage F. Make allowance for a probe and power supply every 20m around perimeter.

C1	26/08/11	IM	DAD	AS
Construction				
T4	13/05/11	MRC	DAD	AS
Tender Addendum				
T3	17/03/11	MRC	DAD	AS
Tender				
T2	24/02/11	MRC	DAD	AS
Tender				
T1	28/01/11	MC	AD	AS
For Information				
01	17/12/10	MC	AD	AS
For Information				
01	17/08/10	MC	AD	AS
Stage E				
Issue	Date	By	Chkd	Appd

ARUP

13 Finsbury Street
London EC2A 7ES
Tel: +44 (0)20 7550 1531 Fax: +44 (0)20 7550 3024
www.arup.com

Client
The British Museum

Job Title
British Museum
World Conservation and
Exhibitions Centre

Key Plan

Drawing Title
Electrical Services
Level B1 Layout - High Level

Sheet G Building 3 and 4

Scale at A0
1:50

Discipline
Electrical

Job No
124020

Drawing No
ARUP-60-DR-B12G

Drawing Status
Construction

Issue
C1