

DO NOT SCALE FROM DRAWING
ALL DIMENSIONS TO BE CHECKED ON SITE

NOTES:

ALL MEASUREMENTS TAKEN TO EXISTING
SURFACE FINISHES UNLESS STATED OTHERWISE

ALL LEVELS IN METRES

ALL ARROWS POINT UP

ARBITRARY GRID

LEVELS RELATED TO ORDNANCE SURVEY
BY GPS OBSERVATION

LEGEND:

20.00F FLOOR LEVEL
20.00H WINDOW HEAD LEVEL
20.00S WINDOW SILL LEVEL
20.00C CEILING LEVEL
20.00SC SUSPENDED CEILING LEVEL
20.00B BEAM LEVEL
20.00D DOOR HEAD LEVEL

AB AIRBRICK
B BOLLARD
BH HEIGHT TO BEAM UNDERSIDE
BW BRICK WALL
BT BRITISH TELECOM
CATV CABLE TV
CB CUPBOARD
CPS CONCRETE PAVING SLABS
DK DROP KERB
ER EARTH ROD
FB FLOWER BED
FH FIRE HYDRANT
FW FOUL WATER
G GULLY
GV GAS VALVE
IC INSPECTION CHAMBER
IL INVERT LEVEL
LP LAMP POST
P POST
RE RODDING EYE
RG ROAD GULLY
RS ROAD SIGN
RWP RAIN WATER PIPE
SVP SOIL VENT PIPE
SW SURFACE WATER
TL TRAFFIC LIGHT
TOF TOP OF FENCE LEVEL
TOW TOP OF WALL LEVEL
TP TELEGRAPH POLE
V VENT
VP VENT PIPE
WM WATER METER
WP WASTE PIPE
WSV WATER STOP VALVE

FENCE TYPES
BW Barbed Wire
CB Close Board
CI Corrugated Iron
CL Chain Link
CPL Conc. Panel
CP Chestnut Paving


CW Chicken Wire
IW Interwoven
IR Iron Railing
OB Openboard
PR Post and Rail
PW Post and Wire

REVISIONS	DATE	BY
<div><div>matrix</div><div>SURVEYS</div><div>106 Sutton Court Road, London NW3 3JH T: 020 894 0822 E: enquiries@matrixsurveys.co.uk</div></div>		
PROJECT		
NEW END THEATRE 27 NEW END ROAD LONDON NW3 1JD		
TITLE		
GROUND FLOOR & SITE		
AS EXISTING		
SCALE	1/50@A1	DATE
DRAWN BY	RF	CHECKED BY
DRAWING No.	01	FILE No.

11/1604

SN

AUG 2011

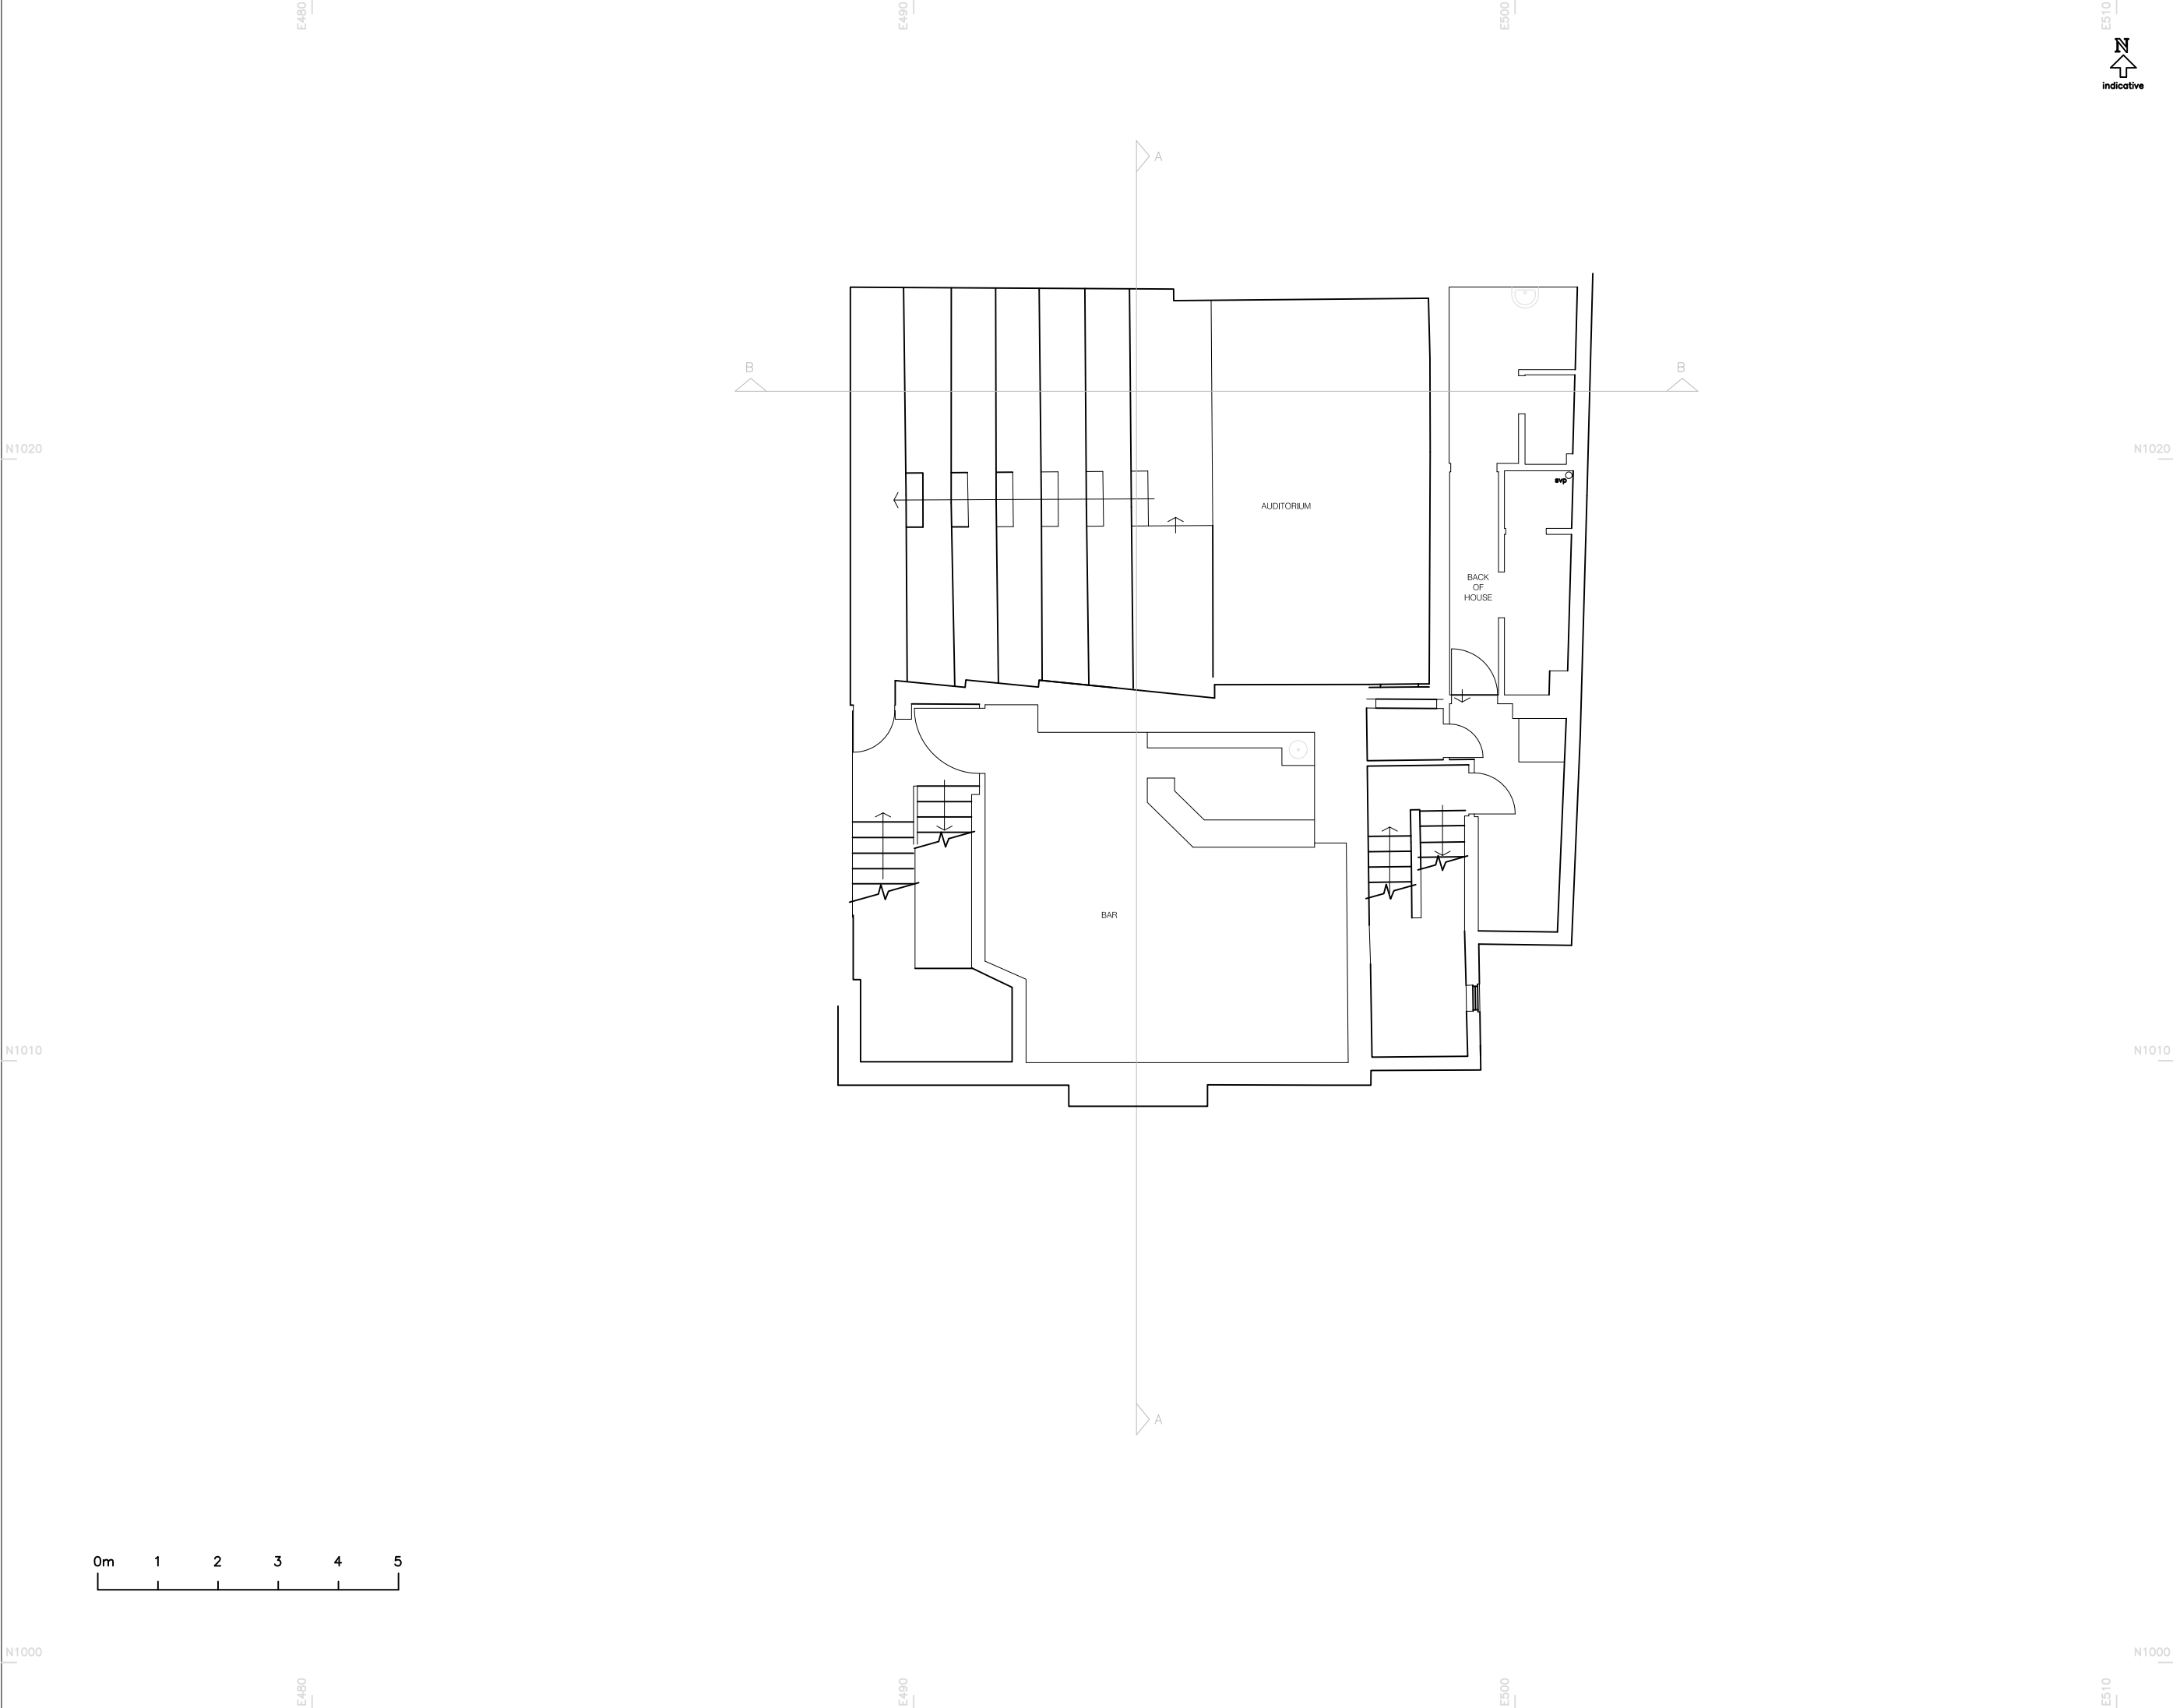

DO NOT SCALE FROM DRAWING
ALL DIMENSIONS TO BE CHECKED ON SITE

NOTES:

ALL MEASUREMENTS TAKEN TO EXISTING
SURFACE FINISHES UNLESS STATED OTHERWISE

ALL LEVELS IN METRES

ALL ARROWS POINT UP

ARBITRARY GRID

LEVELS RELATED TO ORDNANCE SURVEY
BY GPS OBSERVATION

LEGEND:


20.00F FLOOR LEVEL
20.00H WINDOW HEAD LEVEL
20.00S WINDOW SILL LEVEL
20.00C CEILING LEVEL
20.00SC SUSPENDED CEILING LEVEL
20.00B BEAM LEVEL
20.00D DOOR HEAD LEVEL

AB AIRBRICK
B BOLLARD
BH HEIGHT TO BEAM UNDERSIDE
BW BRICK WALL
BT BRITISH TELECOM
CATV CABLE TV
CB CUPBOARD
CPS CONCRETE PAVING SLABS
DK DROP KERB
ER EARTH ROD
FB FLOWER BED
FH FIRE HYDRANT
FW FOUL WATER
G GULLY
GV GAS VALVE
IC INSPECTION CHAMBER
IL INVERT LEVEL
LP LAMP POST
P POST
RE RODDING EYE
RG ROAD GULLY
RS ROAD SIGN
RWP RAIN WATER PIPE
SVP SOIL VENT PIPE
SW SURFACE WATER
TL TRAFFIC LIGHT
TOF TOP OF FENCE LEVEL
TOW TOP OF WALL LEVEL
TP TELEGRAPH POLE
V VENT
VP VENT PIPE
WM WATER METER
WP WASTE PIPE
WSV WATER STOP VALVE

FENCE TYPES
BW Barbed Wire
CB Close Board
CI Corrugated Iron
CL Chain Link
CPL Conc. Panel
CP Chestnut Paving

CW Chicken Wire
IW Interwoven
IR Iron Railing
OB Openboard
PR Post and Rail
PW Post and Wire

REVISIONS		DATE	BY
<div><div>matrix</div><div>SURVEYS</div><div>106 Sutton Court Road, London NW3 3JH T: 020 894 0882 E: enquiries@matrixsurveys.co.uk</div></div>			
PROJECT			
NEW END THEATRE 27 NEW END ROAD LONDON NW3 1JD			
TITLE			
FIRST FLOOR			
AS EXISTING			
SCALE	1/50@A1	DATE	AUG 2011
DRAWN BY	RF	CHECKED BY	SN
DRAWING No.	02	FILE No.	11/1604

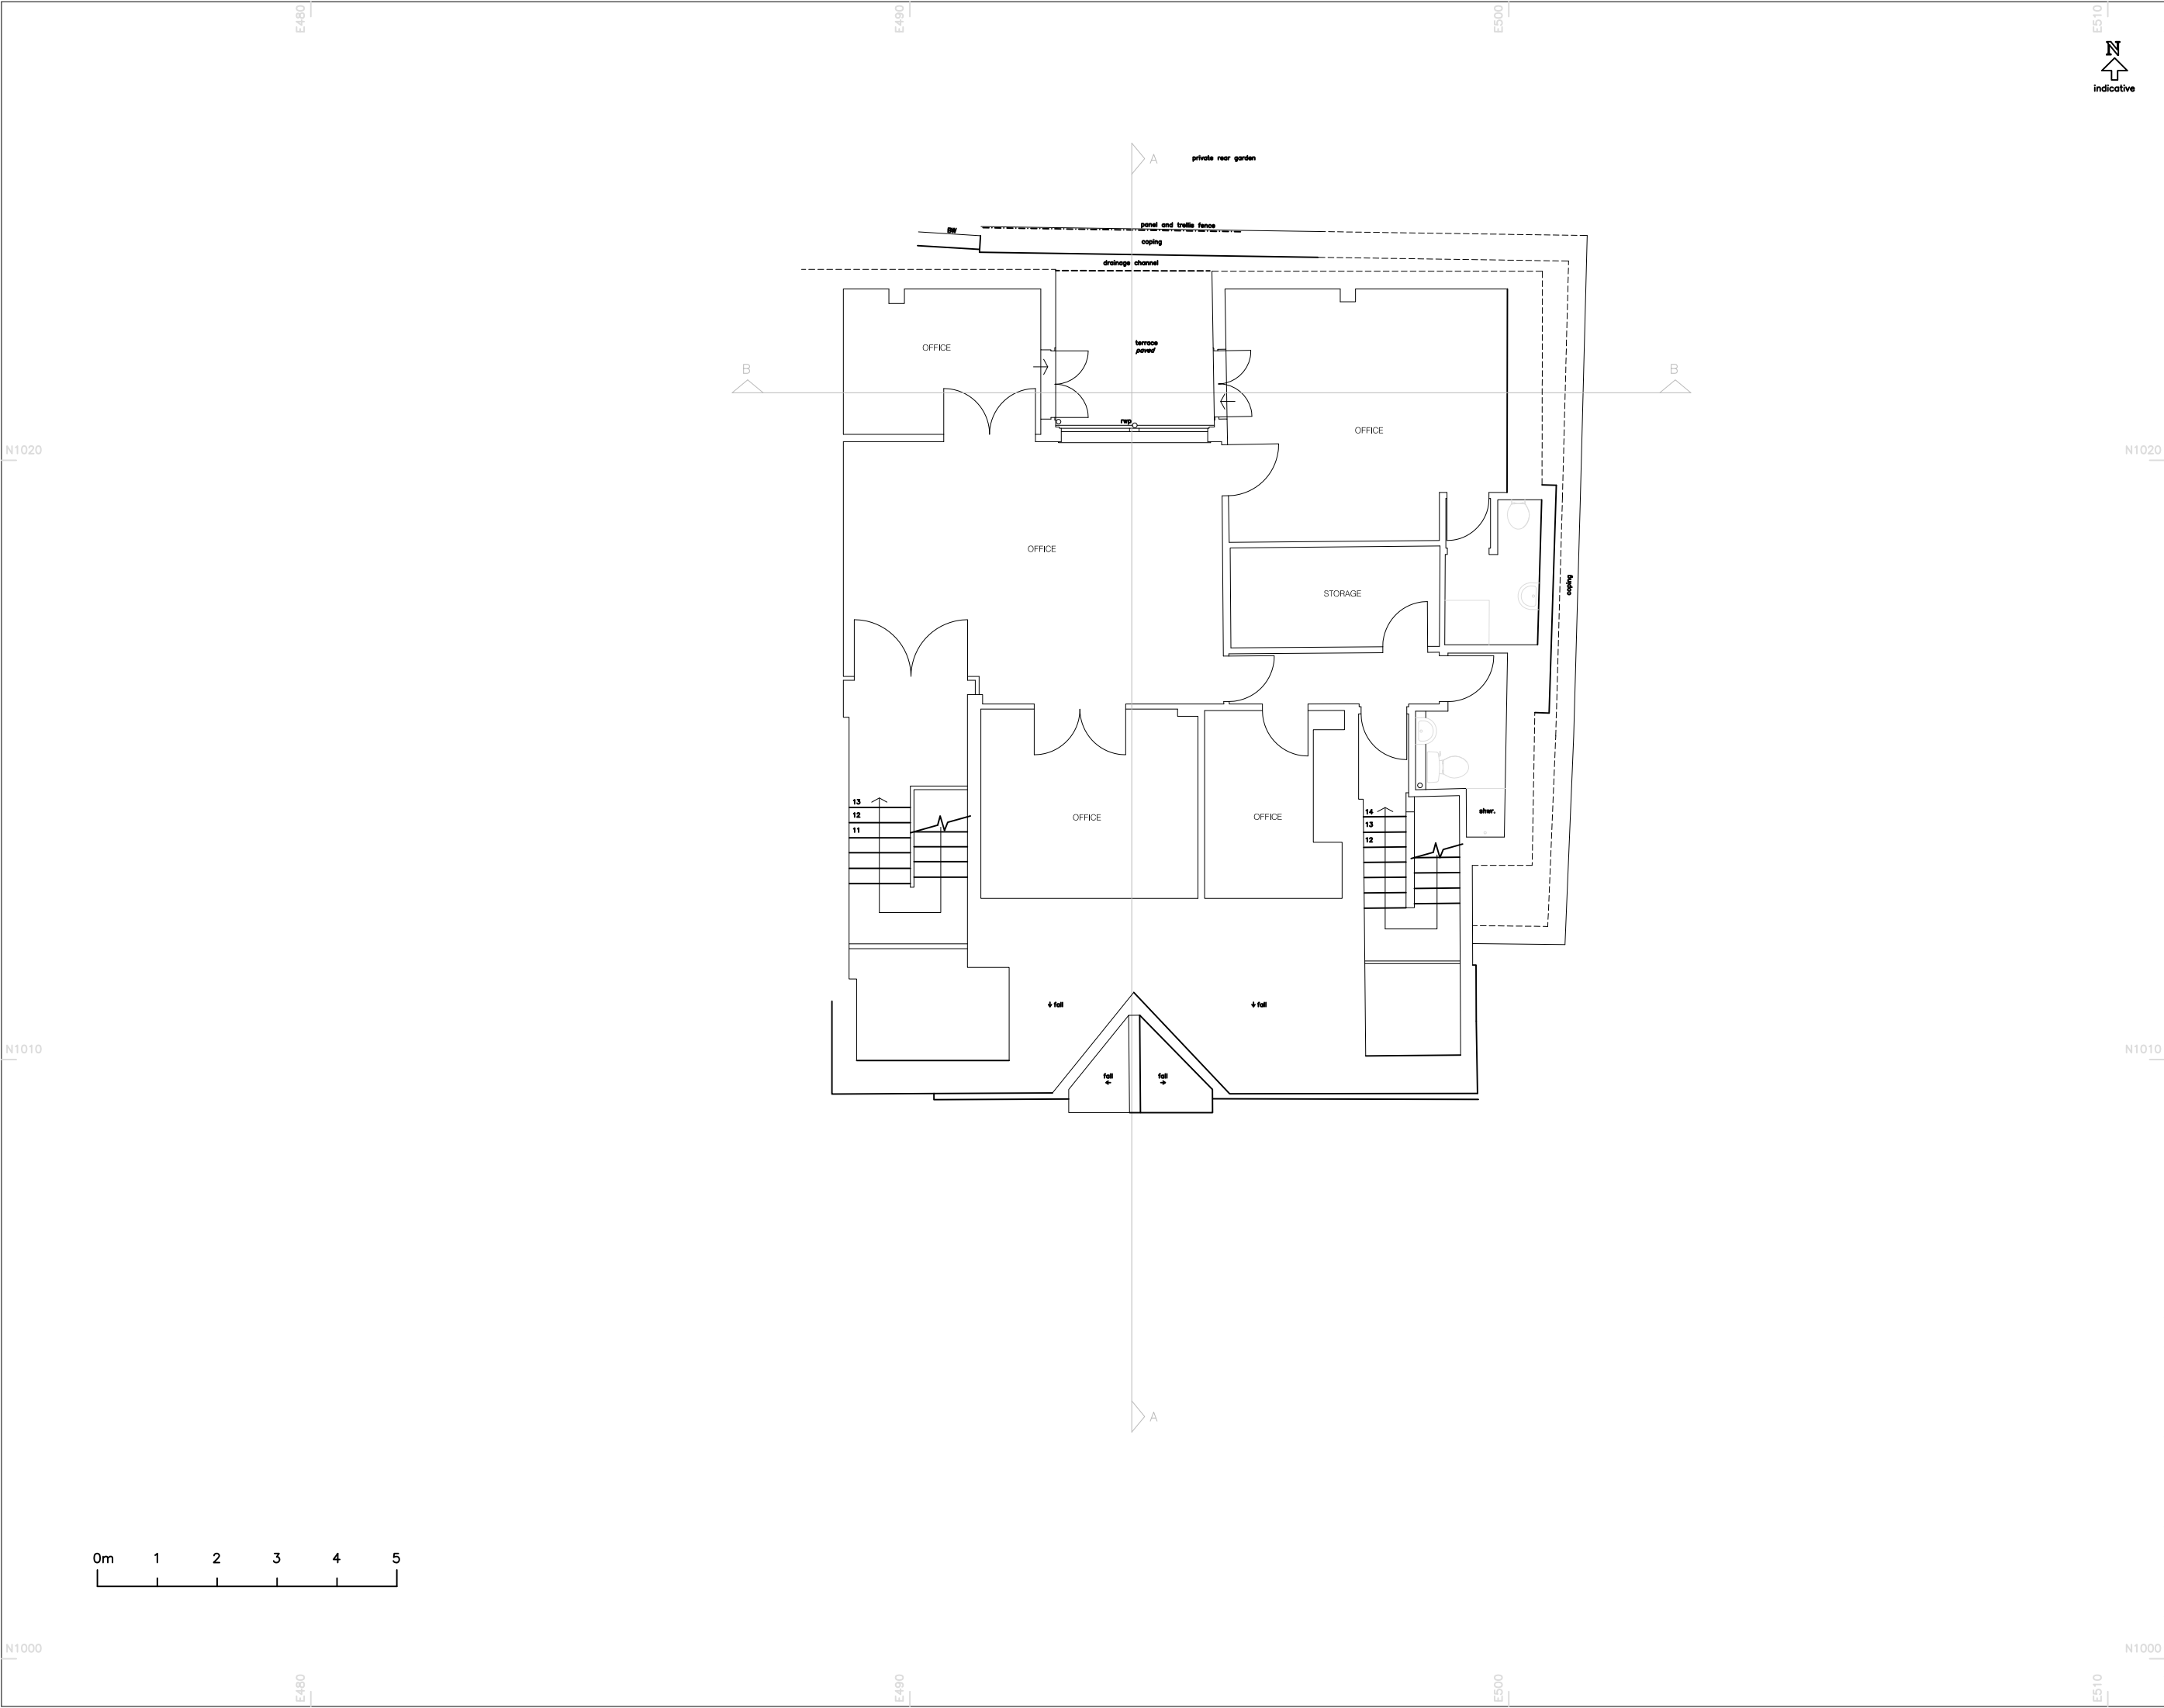

DO NOT SCALE FROM DRAWING
ALL DIMENSIONS TO BE CHECKED ON SITE

NOTES:

ALL MEASUREMENTS TAKEN TO EXISTING
SURFACE FINISHES UNLESS STATED OTHERWISE

ALL LEVELS IN METRES

ALL ARROWS POINT UP

ARBITRARY GRID

LEVELS RELATED TO ORDNANCE SURVEY
BY GPS OBSERVATION

LEGEND:

20.00F FLOOR LEVEL
20.00H WINDOW HEAD LEVEL
20.00S WINDOW SILL LEVEL
20.00C CEILING LEVEL
20.00SC SUSPENDED CEILING LEVEL
20.00B BEAM LEVEL
20.00D DOOR HEAD LEVEL

AB AIRBRICK
B BOLLARD
BH HEIGHT TO BEAM UNDERSIDE
BW BRICK WALL
BT BRITISH TELECOM
CATV CABLE TV
CB CUPBOARD
CPS CONCRETE PAVING SLABS
DK DROP KERB
ER EARTH ROD
FB FLOWER BED
FH FIRE HYDRANT
FW FOUL WATER
G GULLY
GV GAS VALVE
IC INSPECTION CHAMBER
IL INVERT LEVEL
LP LAMP POST
P POST
RE RODDING EYE
RG ROAD GULLY
RS ROAD SIGN
RWP RAIN WATER PIPE
SVP SOIL VENT PIPE
SW SURFACE WATER
TL TRAFFIC LIGHT
TOF TOP OF FENCE LEVEL
TOW TOP OF WALL LEVEL
TP TELEGRAPH POLE
V VENT
VP VENT PIPE
WM WATER METER
WP WASTE PIPE
WSV WATER STOP VALVE

FENCE TYPES
BW Barbed Wire
CB Close Board
CI Corrugated Iron
CL Chain Link
CPL Conc. Panel
CP Chestnut Paving

CW Chicken Wire
IW Interwoven
IR Iron Railing
OB Openboard
PR Post and Rail
PW Post and Wire

REVISIONS

DATE

BY

matrix
SURVEYS

106 Sutton Court Road, London NW3 3JH
T: 020 894 0882 E: enquiries@matrixsurveys.co.uk

PROJECT

NEW END THEATRE
27 NEW END ROAD
LONDON NW3 1JD

TITLE

SECOND FLOOR

AS EXISTING

SCALE

1/50@A1

DATE

AUG 2011

DRAWN BY

RF

CHECKED BY

SN

DRAWING No.

03

FILE No.

11/1604



FRONT ELEVATION

DATUM 110.00m



DO NOT SCALE FROM DRAWING
ALL DIMENSIONS TO BE CHECKED ON SITE


- NOTES:
- ALL MEASUREMENTS TAKEN TO EXISTING
SURFACE FINISHES UNLESS STATED OTHERWISE
- ALL LEVELS IN METRES
- ALL ARROWS POINT UP
- ARBITRARY GRID
- LEVELS RELATED TO ORDNANCE SURVEY
BY GPS OBSERVATION

- LEGEND:
- | | |
|---------|-------------------------|
| 20.00F | FLOOR LEVEL |
| 20.00H | WINDOW HEAD LEVEL |
| 20.00S | WINDOW SILL LEVEL |
| 20.00C | CEILING LEVEL |
| 20.00SC | SUSPENDED CEILING LEVEL |
| 20.00B | BEAM LEVEL |
| 20.00D | DOOR HEAD LEVEL |

- | | |
|------|--------------------------|
| AB | AIRBRICK |
| B | BOLLARD |
| BH | HEIGHT TO BEAM UNDERSIDE |
| BW | BRICK WALL |
| BT | BRITISH TELECOM |
| CATV | CABLE TV |
| CB | CUPBOARD |
| CPS | CONCRETE PAVING SLABS |
| DK | DROP KERB |
| ER | EARTH ROD |
| FB | FLOWER BED |
| FH | FIRE HYDRANT |
| FW | FOUL WATER |
| G | GULLY |
| GV | GAS VALVE |
| IC | INSPECTION CHAMBER |
| IL | INVERT LEVEL |
| LP | LAMP POST |
| P | POST |
| RE | RODDING EYE |
| RG | ROAD GULLY |
| RS | ROAD SIGN |
| RWP | RAIN WATER PIPE |
| SVP | SOIL VENT PIPE |
| SW | SURFACE WATER |
| TL | TRAFFIC LIGHT |
| TDF | TOP OF FENCE LEVEL |
| TOW | TOP OF WALL LEVEL |
| TP | TELEGRAPH POLE |
| V | VENT |
| VP | VENT PIPE |
| WM | WATER METER |
| WP | WASTE PIPE |
| WSV | WATER STOP VALVE |

- FENCE TYPES
- | | | | |
|-----|-----------------|----|---------------|
| BW | Barbed Wire | CW | Chicken Wire |
| CB | Close Board | IW | Interwoven |
| CI | Corrugated Iron | IR | Iron Railing |
| CL | Chain Link | OB | Openboard |
| CPL | Conc. Panel | PR | Post and Rail |
| CP | Chestnut Paling | PW | Post and Wire |

REVISIONS		DATE	BY
<div><div>matrix</div><div>SURVEYS</div><div>106 Sutton Court Road, London NW3 3JH T: 020 894 0882 E: sales@matrixsurveys.co.uk</div></div>			
PROJECT			
NEW END THEATRE 27 NEW END ROAD LONDON NW3 1JD			
TITLE			
FRONT ELEVATION			
AS EXISTING			
SCALE	1/50@A1	DATE	AUG 2011
DRAWN BY	RF	CHECKED BY	SN
DRAWING No.	04	FILE No.	11/1604

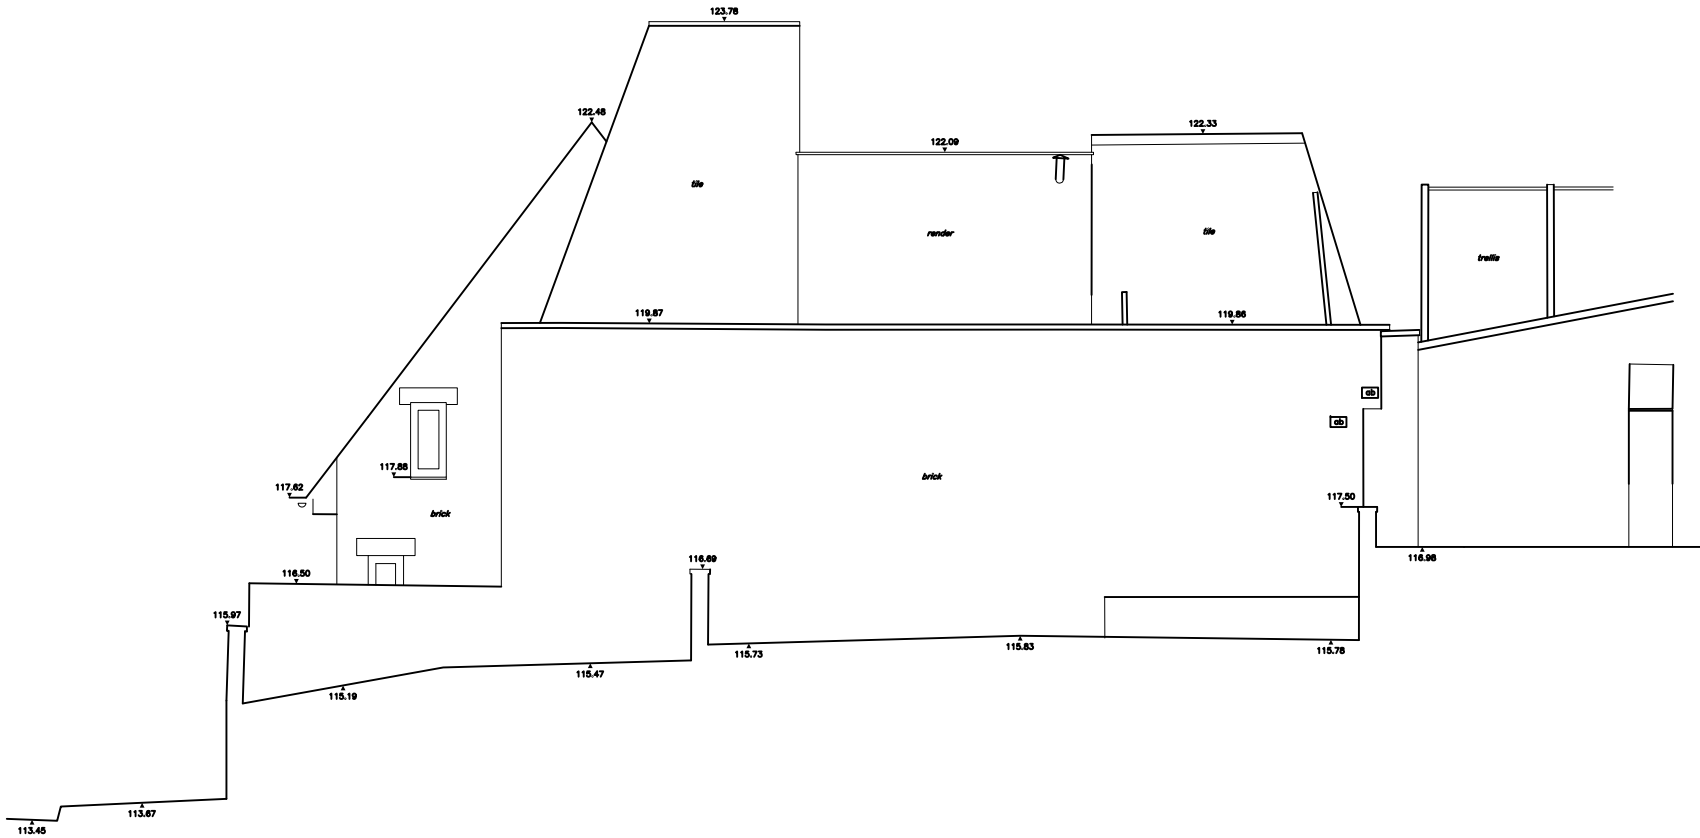

SIDE ELEVATION

DATUM 110.00m



DO NOT SCALE FROM DRAWING
ALL DIMENSIONS TO BE CHECKED ON SITE

NOTES:

ALL MEASUREMENTS TAKEN TO EXISTING
SURFACE FINISHES UNLESS STATED OTHERWISE

ALL LEVELS IN METRES

ALL ARROWS POINT UP

ARBITRARY GRID

LEVELS RELATED TO ORDNANCE SURVEY
BY GPS OBSERVATION

LEGEND:

20.00F FLOOR LEVEL
20.00H WINDOW HEAD LEVEL
20.00S WINDOW SILL LEVEL
20.00C CEILING LEVEL
20.00SC SUSPENDED CEILING LEVEL
20.00B BEAM LEVEL
20.00D DOOR HEAD LEVEL

AB AIRBRICK
B BOLLARD
BH HEIGHT TO BEAM UNDERSIDE
BW BRICK WALL
BT BRITISH TELECOM
CATV CABLE TV
CB CURBOARD
CPS CONCRETE PAVING SLABS
DK DROP KERB
ER EARTH ROD
FB FLOWER BED
FH FIRE HYDRANT
FW FOUL WATER
G GULLY
GV GAS VALVE
IC INSPECTION CHAMBER
IL INVERT LEVEL
LP LAMP POST
P POST
RE RODDING EYE
RG ROAD GULLY
RS ROAD SIGN
RWP RAIN WATER PIPE
SVP SOIL VENT PIPE
SW SURFACE WATER
TL TRAFFIC LIGHT
TOF TOP OF FENCE LEVEL
TOW TOP OF WALL LEVEL
TP TELEGRAPH POLE
V VENT
VP VENT PIPE
WM WATER METER
WP WASTE PIPE
WSV WATER STOP VALVE

FENCE TYPES
BW Barbed Wire
CB Close Board
CI Corrugated Iron
CL Chain Link
CPL Conc. Panel
CP Chestnut Paving
CW Chicken Wire
IW Interwoven
IR Iron Railing
OB Openboard
PR Post and Rail
PW Post and Wire

REVISIONS	DATE	BY
-----------	------	----



PROJECT


NEW END THEATRE
27 NEW END ROAD
LONDON NW3 1JD

TITLE

SIDE ELEVATION

AS EXISTING

SCALE	1/50@A1	DATE	AUG 2011
DRAWN BY	RF	CHECKED BY	SN
DRAWING No.	05	FILE No.	11/1604

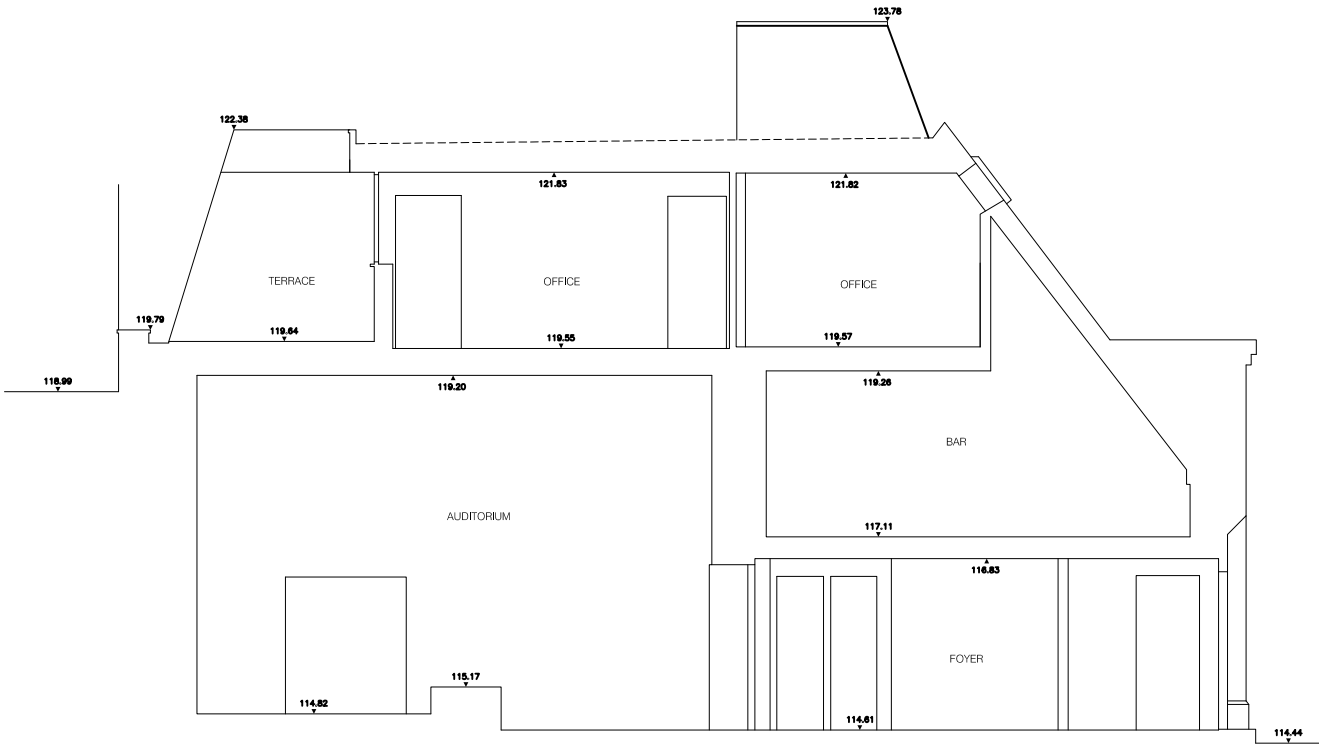

SECTION A

DATUM 110.00m



DO NOT SCALE FROM DRAWING
ALL DIMENSIONS TO BE CHECKED ON SITE

NOTES:

ALL MEASUREMENTS TAKEN TO EXISTING
SURFACE FINISHES UNLESS STATED OTHERWISE

ALL LEVELS IN METRES

ALL ARROWS POINT UP

ARBITRARY GRID


LEVELS RELATED TO ORDNANCE SURVEY
BY GPS OBSERVATION

LEGEND:

20.00F	FLOOR LEVEL
20.00H	WINDOW HEAD LEVEL
20.00S	WINDOW SILL LEVEL
20.00C	CEILING LEVEL
20.00SC	SUSPENDED CEILING LEVEL
20.00B	BEAM LEVEL
20.00D	DOOR HEAD LEVEL
AB	AIRBRICK
B	BOLLARD
BH	HEIGHT TO BEAM UNDERSIDE
BW	BRICK WALL
BT	BRITISH TELECOM
CATV	CABLE TV
CB	CUPBOARD
CPS	CONCRETE PAVING SLABS
DK	DROP KERB
ER	EARTH ROD
FB	FLOWER BED
FH	FIRE HYDRANT
FW	FOUL WATER
G	GULLY
GV	GAS VALVE
IC	INSPECTION CHAMBER
IL	INVERT LEVEL
LP	LAMP POST
P	POST
RE	RODDING EYE
RG	ROAD GULLY
RS	ROAD SIGN
RWP	RAIN WATER PIPE
SVP	SOIL VENT PIPE
SW	SURFACE WATER
TL	TRAFFIC LIGHT
TOF	TOP OF FENCE LEVEL
TOW	TOP OF WALL LEVEL
TP	TELEGRAPH POLE
V	VENT
VP	VENT PIPE
WM	WATER METER
WP	WASTE PIPE
WSV	WATER STOP VALVE

FENCE TYPES			
BW	Barbed Wire	CW	Chicken Wire
CB	Close Board	IW	Interwoven
CI	Corrugated Iron	IR	Iron Railing
CL	Chain Link	OB	Openboard
CPL	Conc Panel	PR	Post and Rail
CP	Chestnut Paling	PW	Post and Wire

REVISIONS		DATE	BY
<div><div>matrix</div><div>SURVEYS</div><div>106 Sutton Court Road, London NW3 3JH T: 020 894 0882 E: enquiries@matrixsurveys.co.uk</div></div>			
PROJECT			
NEW END THEATRE 27 NEW END ROAD LONDON NW3 1JD			
TITLE			
SECTION A			
AS EXISTING			
SCALE	1/50@A1	DATE	AUG 2011
DRAWN BY	RF	CHECKED BY	SN
DRAWING No.	06	FILE No.	11/1604

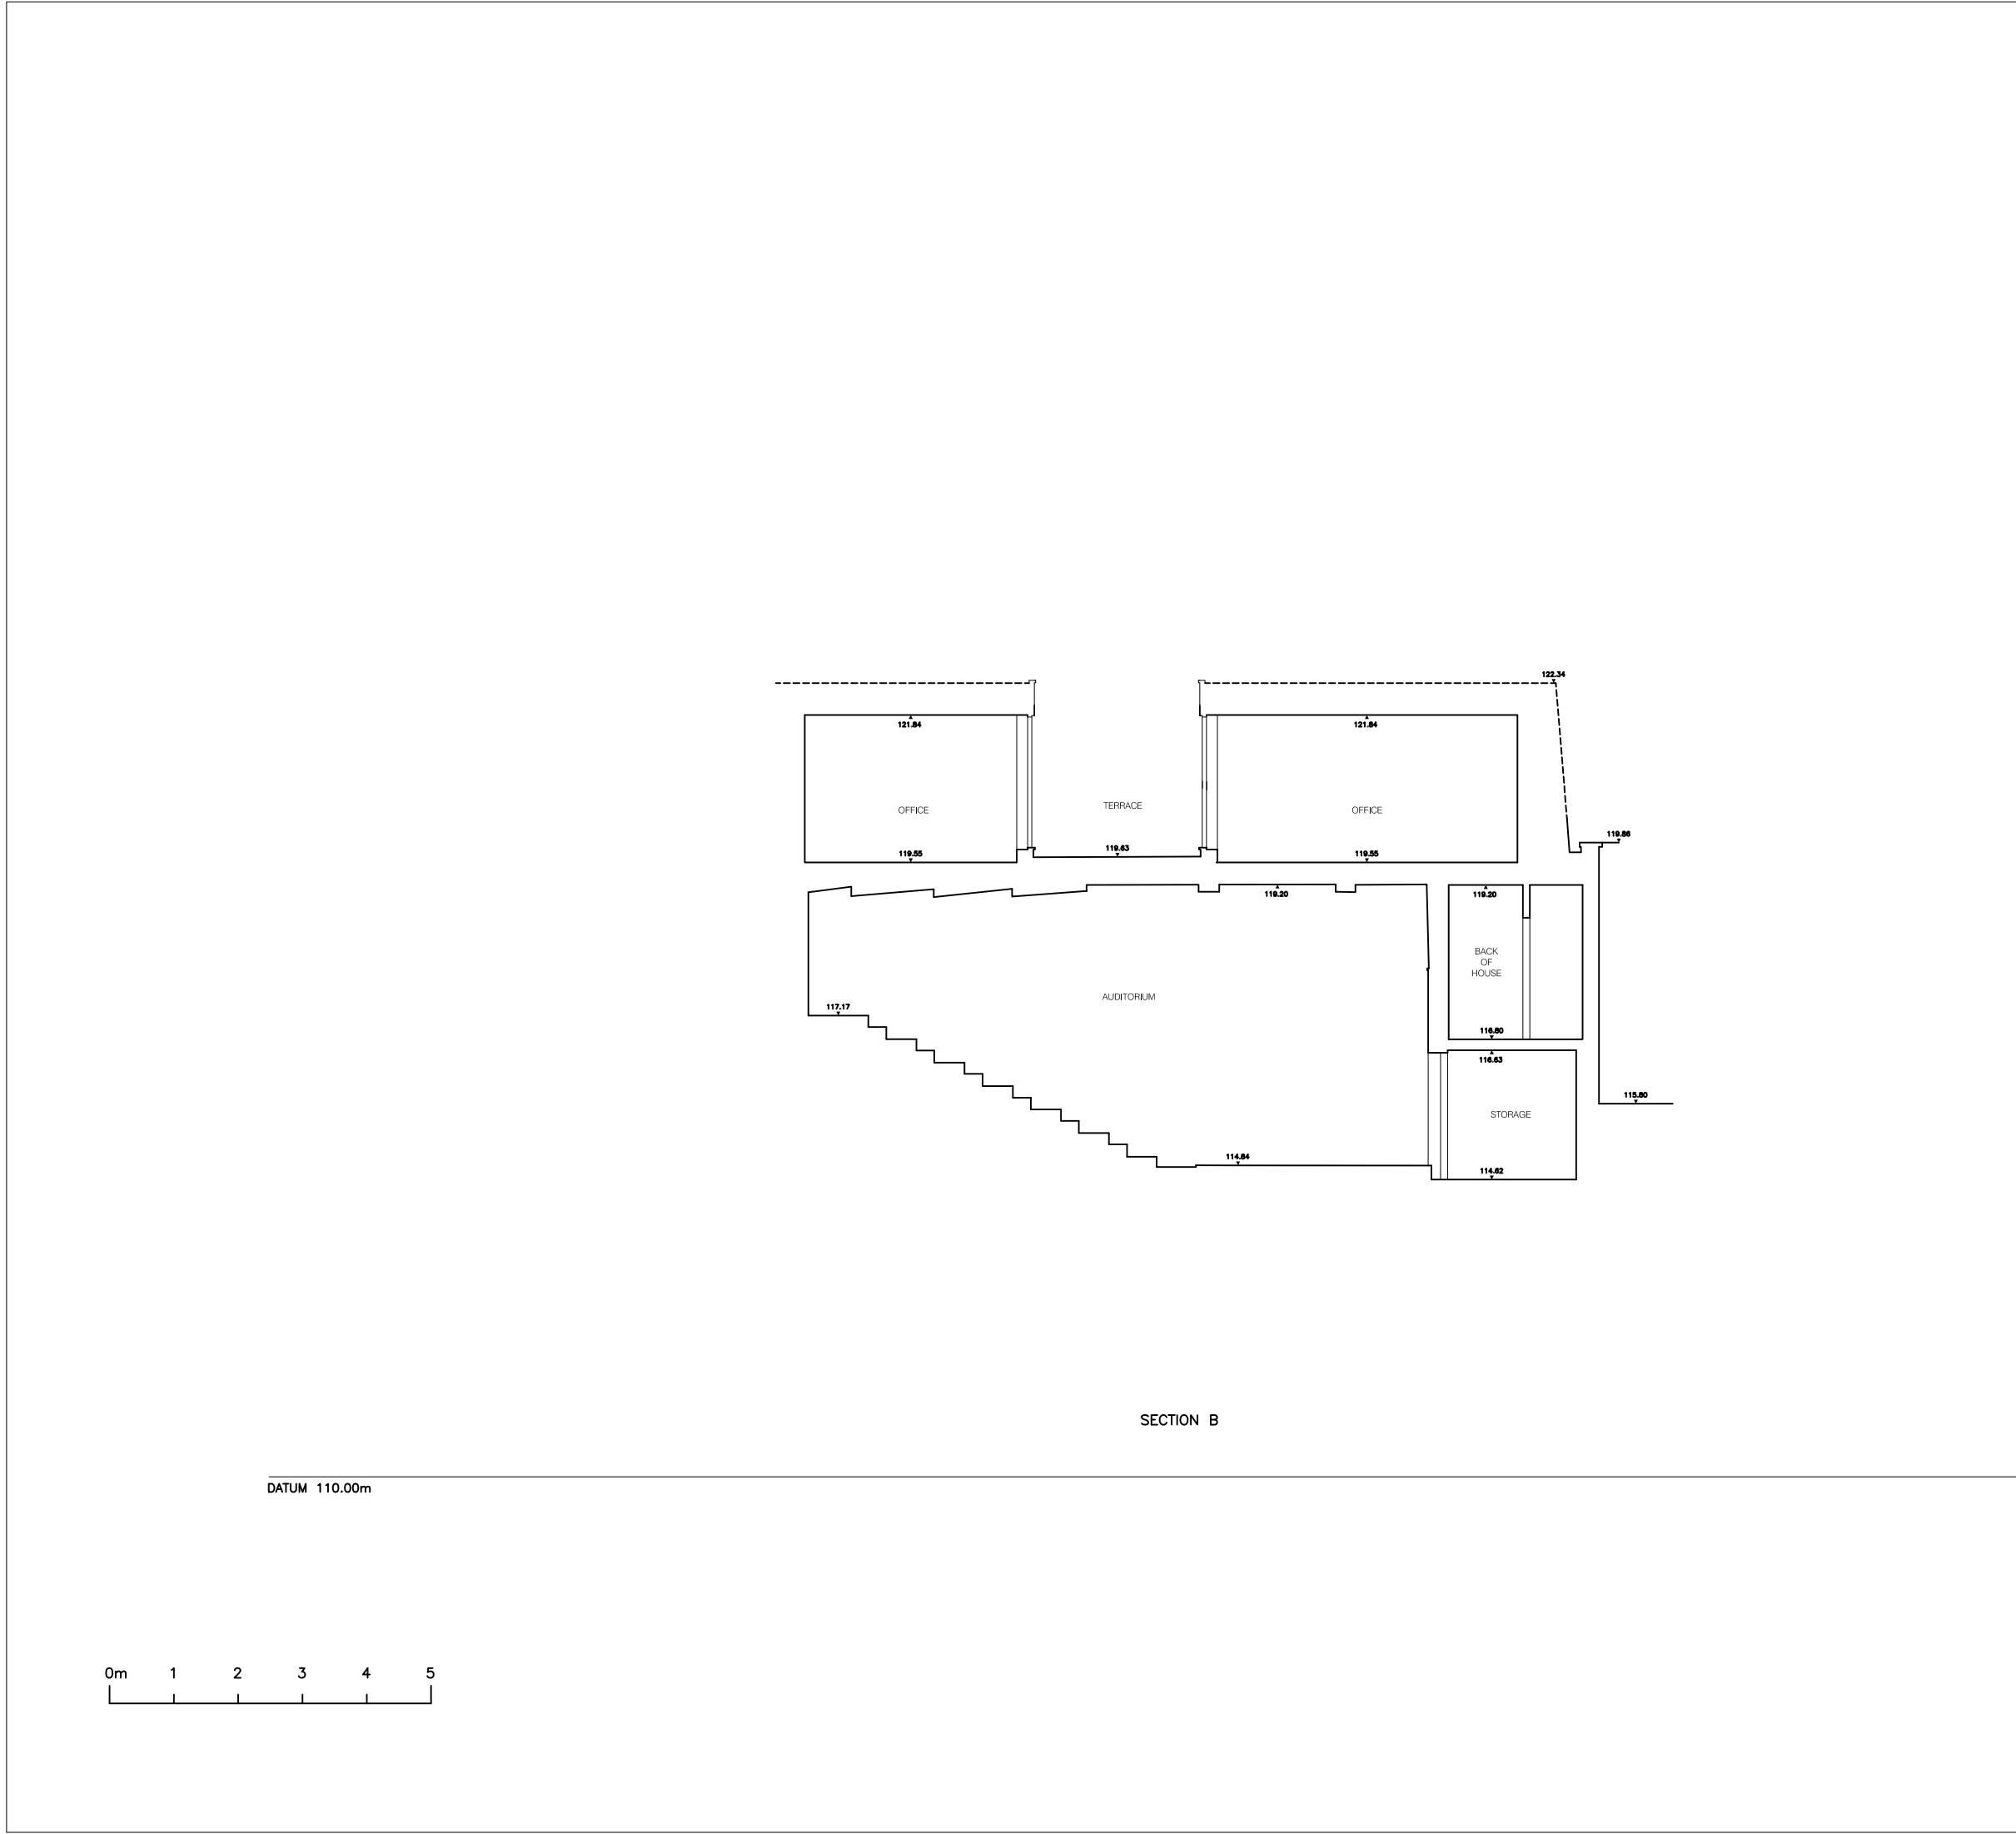

DO NOT SCALE FROM DRAWING
ALL DIMENSIONS TO BE CHECKED ON SITE

NOTES:

ALL MEASUREMENTS TAKEN TO EXISTING
SURFACE FINISHES UNLESS STATED OTHERWISE

ALL LEVELS IN METRES

ALL ARROWS POINT UP

ARBITRARY GRID

LEVELS RELATED TO ORDNANCE SURVEY
BY GPS OBSERVATION

LEGEND:

20.00F FLOOR LEVEL
20.00H WINDOW HEAD LEVEL
20.00S WINDOW SILL LEVEL
20.00C CEILING LEVEL
20.00SC SUSPENDED CEILING LEVEL
20.00B BEAM LEVEL
20.00D DOOR HEAD LEVEL

AB AIRBRICK
B BOLLARD
BH HEIGHT TO BEAM UNDERSIDE
BW BRICK WALL
BT BRITISH TELECOM
CATV CABLE TV
CB CUPBOARD
CPS CONCRETE PAVING SLABS
DK DROP KERB
ER EARTH ROD
FB FLOWER BED
FH FIRE HYDRANT
FW FOUL WATER
G GULLY
GV GAS VALVE
IC INSPECTION CHAMBER
IL INVERT LEVEL
LP LAMP POST
P POST
RE RODDING EYE
RG ROAD GULLY
RS ROAD SIGN
RWP RAIN WATER PIPE
SVP SOIL VENT PIPE
SW SURFACE WATER
TL TRAFFIC LIGHT
TOF TOP OF FENCE LEVEL
TOW TOP OF WALL LEVEL
TP TELEGRAPH POLE
V VENT
VP VENT PIPE
WM WATER METER
WP WASTE PIPE
WSV WATER STOP VALVE

FENCE TYPES
BW Barbed Wire
CB Close Board
CI Corrugated Iron
CL Chain Link
CPL Conc Panel
CP Chestnut Paling

CW Chicken Wire
IW Interwoven
IR Iron Railing
OB Openboard
PR Post and Rail
PW Post and Wire

REVISIONS	DATE	BY
<div><div><div>matrix</div><div>SURVEYS</div><div>106 Sutton Court Road, London NW3 3JH T: 020 894 0882 E: enquiries@matrixsurveys.co.uk</div></div></div>		
PROJECT		
NEW END THEATRE 27 NEW END ROAD LONDON NW3 1JD		
TITLE		
SECTION B		
AS EXISTING		
SCALE	1/50@A1	DATE AUG 2011
DRAWN BY	RF	CHECKED BY SN
DRAWING No.	07	FILE No. 11/1604