




01 TYPOGRAPHIC SETOUT : FOOTBRIDGE COMMS POST WAYFINDING SIGNAGE BOX : PLATFORM 0/1 - SCALE 1:10

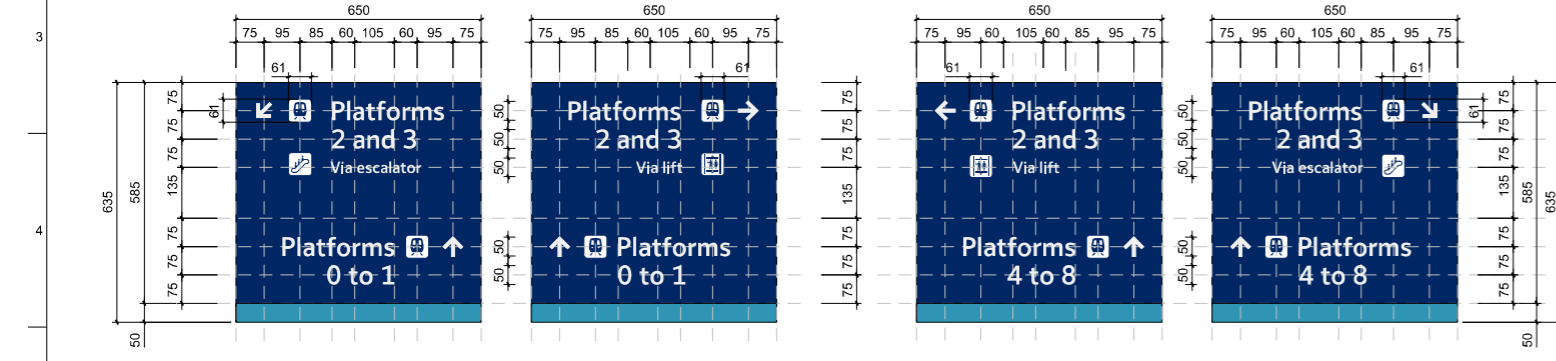


02 TYPOGRAPHIC SETOUT : FOOTBRIDGE COMMS POST WAYFINDING SIGNAGE BOX : PLATFORM 2/3 - SCALE 1:10

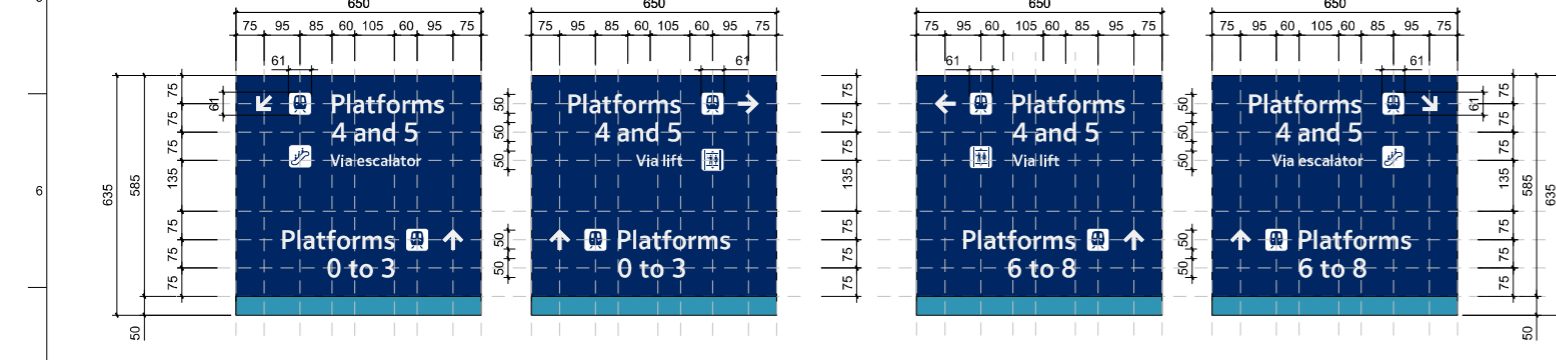


03 TYPOGRAPHIC SETOUT : FOOTBRIDGE COMMS POST WAYFINDING SIGNAGE BOX : PLATFORM 4/5 - SCALE 1:10

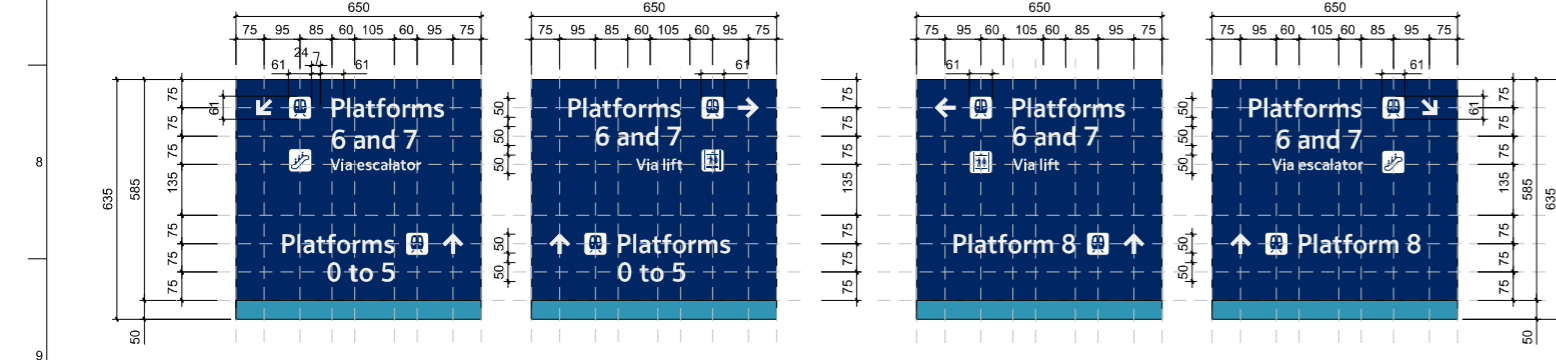


04 TYPOGRAPHIC SETOUT : FOOTBRIDGE COMMS POST WAYFINDING SIGNAGE BOX : PLATFORM 6/7 - SCALE 1:10

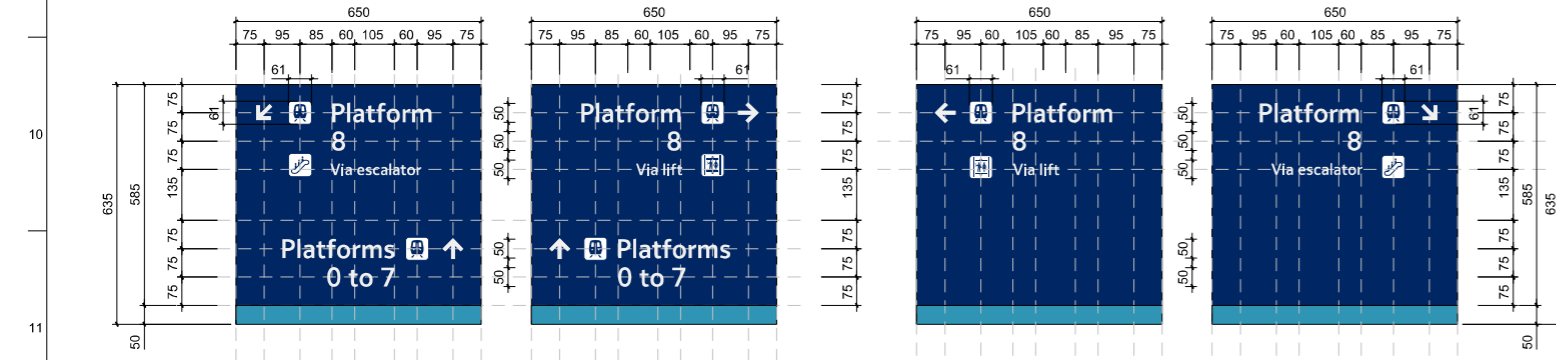


05 TYPOGRAPHIC SETOUT : FOOTBRIDGE COMMS POST WAYFINDING SIGNAGE BOX : PLATFORM 8 - SCALE 1:10

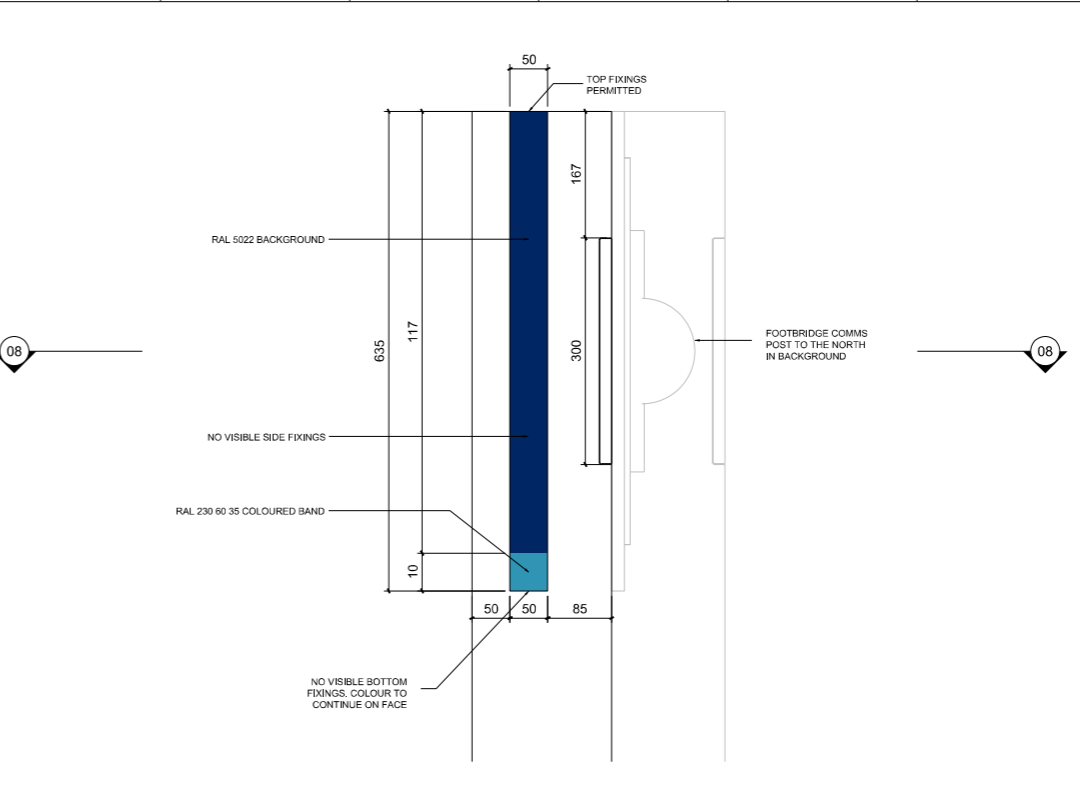

06 DETAILED SECTION THRU WAYFINDING BOX - SCALE 1:5

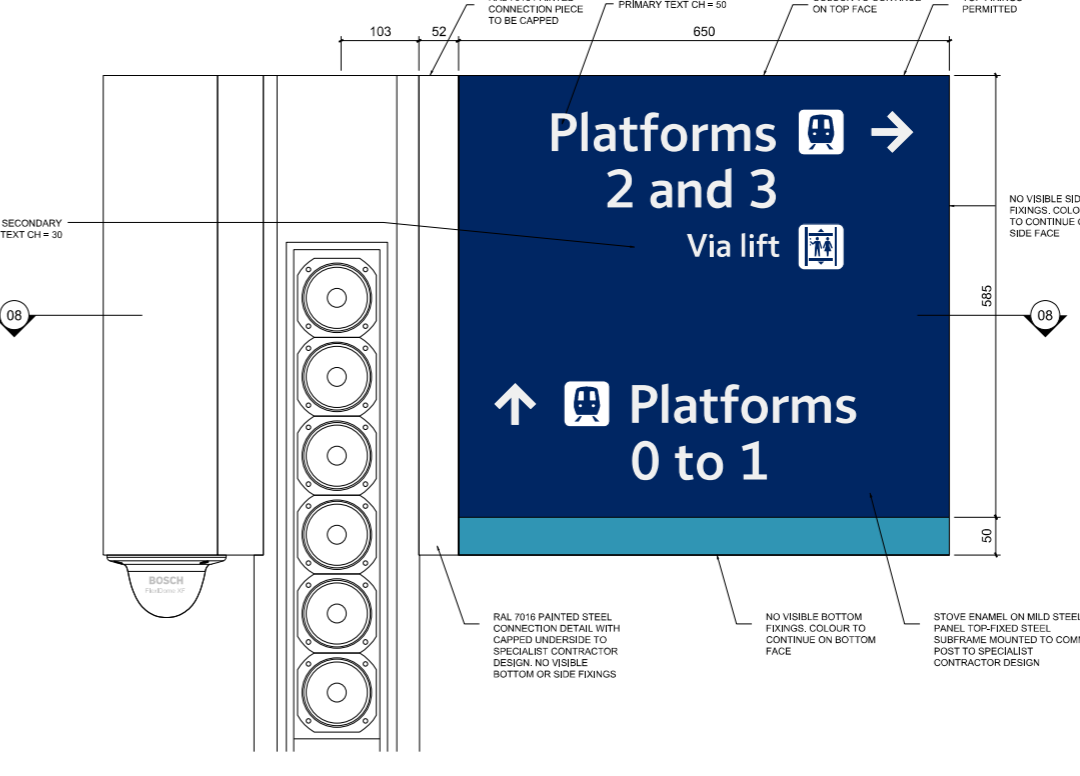


07 TYPICAL FRONT ELEVATION - SCALE 1:5

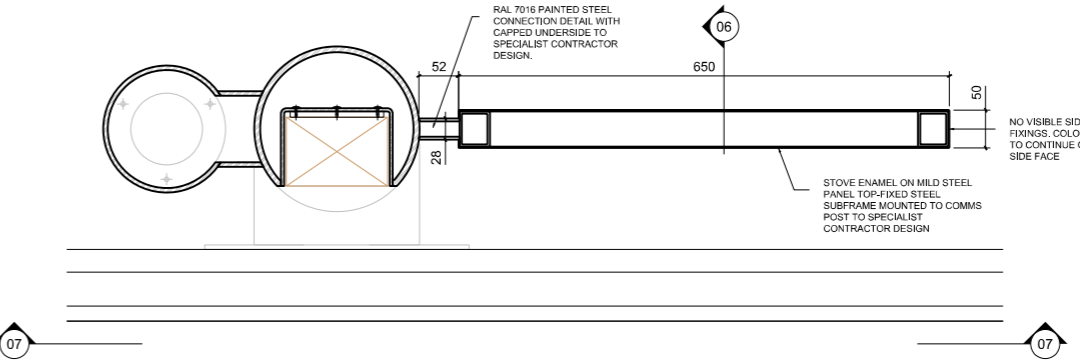

08 DETAILED PLAN - SCALE 1:5

DO NOT SCALE FROM THIS DRAWING

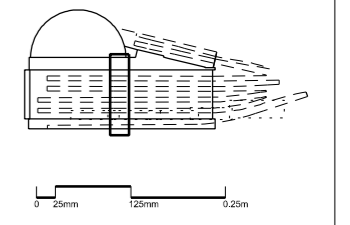

- Notes.
1. Drawings to be read in conjunction with structural, mechanical and electrical information.
  2. Drawings to be read in conjunction with architectural specification.
  3. All dimensions to be site surveyed and agreed with contractor prior to fabrication.
  4. Signage panel typographic set as per 'Design Guidelines & Specification Managed Station Wayfinding' dated 02.03.2011 prescribed by ERI-114
  5. Signage box detailing by specialist contractor
  6. CCTV and COMMS assets as per FOURWAYS design.

02	08-09-11	OR	JA	SG
01	12-08-11	OR	JA	SG
00	14-01-11	OR	AB	SS
Issue	Date	By	Chkd	Appd



VINCI CONSTRUCTION UK LIMITED  
 Cubitt House  
 1 Battle Bridge Road  
 London  
 NIC 4AH

Author  
**JOHN MCASLAN + PARTNERS**  
 7-9 William Road  
 London NW1 3ER  
 T +44 (0)20 7313 8200  
 F +44 (0)20 7313 6001  
 www.mcaslan.co.uk

Consultant  
**CORUS**  
 Railway Infrastructure Services  
 PO Box 298  
 York  
 YO1 6YH  
 T: 01904 454600  
 F: 01904 454601

Job Title  
**Kings Cross Package 3  
 Platform Footbridge/Signage**

Drawing Title  
**Typographic Setout & Typical Details  
 Footbridge Comms Post-Mounted  
 Wayfinding Signage Box  
 M-05.01-05**

Scale at A1  
**1:10 & 1:5**

CCMS No  
 ...

Drawing Status  
**APPROVED FOR CONSTRUCTION**

VCAK Job No	Drawing No	Rev.
VA 001	ENG-DWG-VCAK-KX3-CAD-3603	02