


Ground Floor Plan

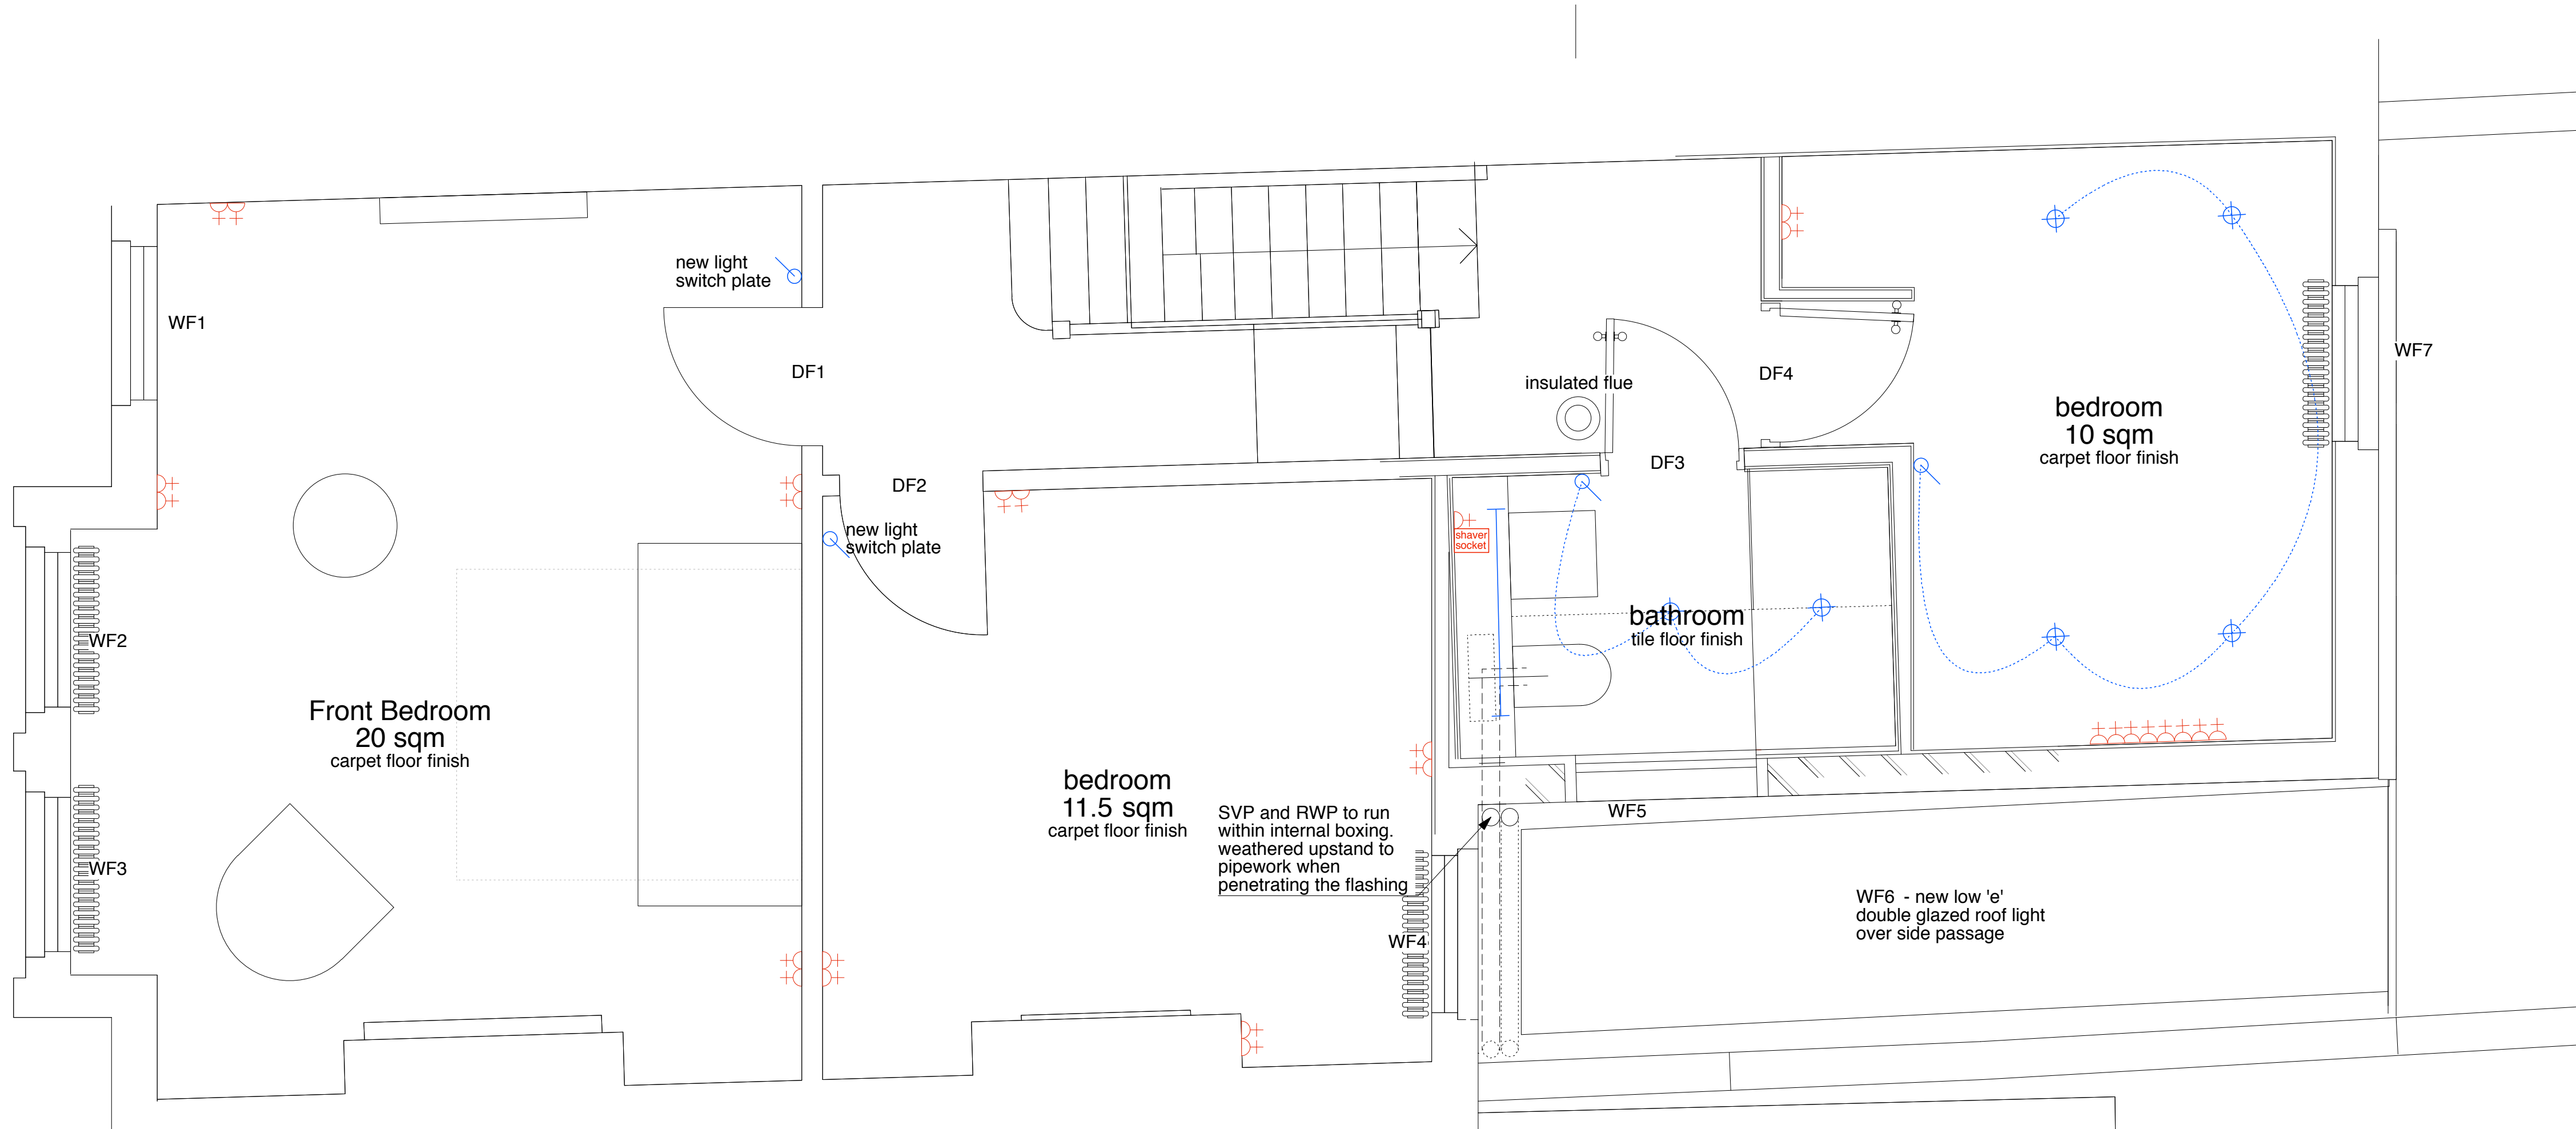

First Floor Plan

Notes

Do not scale

All dimensions to be checked on site and verified with the architect prior to construction.

Any discrepancies or uncertainties regarding this drawing to be discussed with the architect prior to construction

Refer to general requirements schedule

Copyright © Theis and Khan Architects Ltd. All rights reserved

Key to Services Symbols

Sockets	Thermostat
5 Amp socket	Door Contact
Switched spur	Security Alarm key pad
Non switched spur	Fire Alarm Panel
Switched spur (remote switch)	BT Point
Single 13 amp socket	Heating Manifold
Double 13 amp socket	Electrical distribution board
Audio entry Internal Unit	
Audio entry External Unit	
CAT 5 point	

THEIS + KHAN

22 Bateman's Row
London EC2A 3HH
t: 020 7729 9329
f: 020 7729 9341
mail@theisandkhan.com
www.theisandkhan.com

Status: **PLANNING**

Revision	Date	Comments
A	12.07.10	Electrical requirements added to first floor.

Job: 37 Lisburne Road London NW3

Title: Proposed Ground and First Floor Plans

Scale: 1:25@A1 Date: MAY 10 Job no: 1045 Drawing no: 100 Revision: **A**