


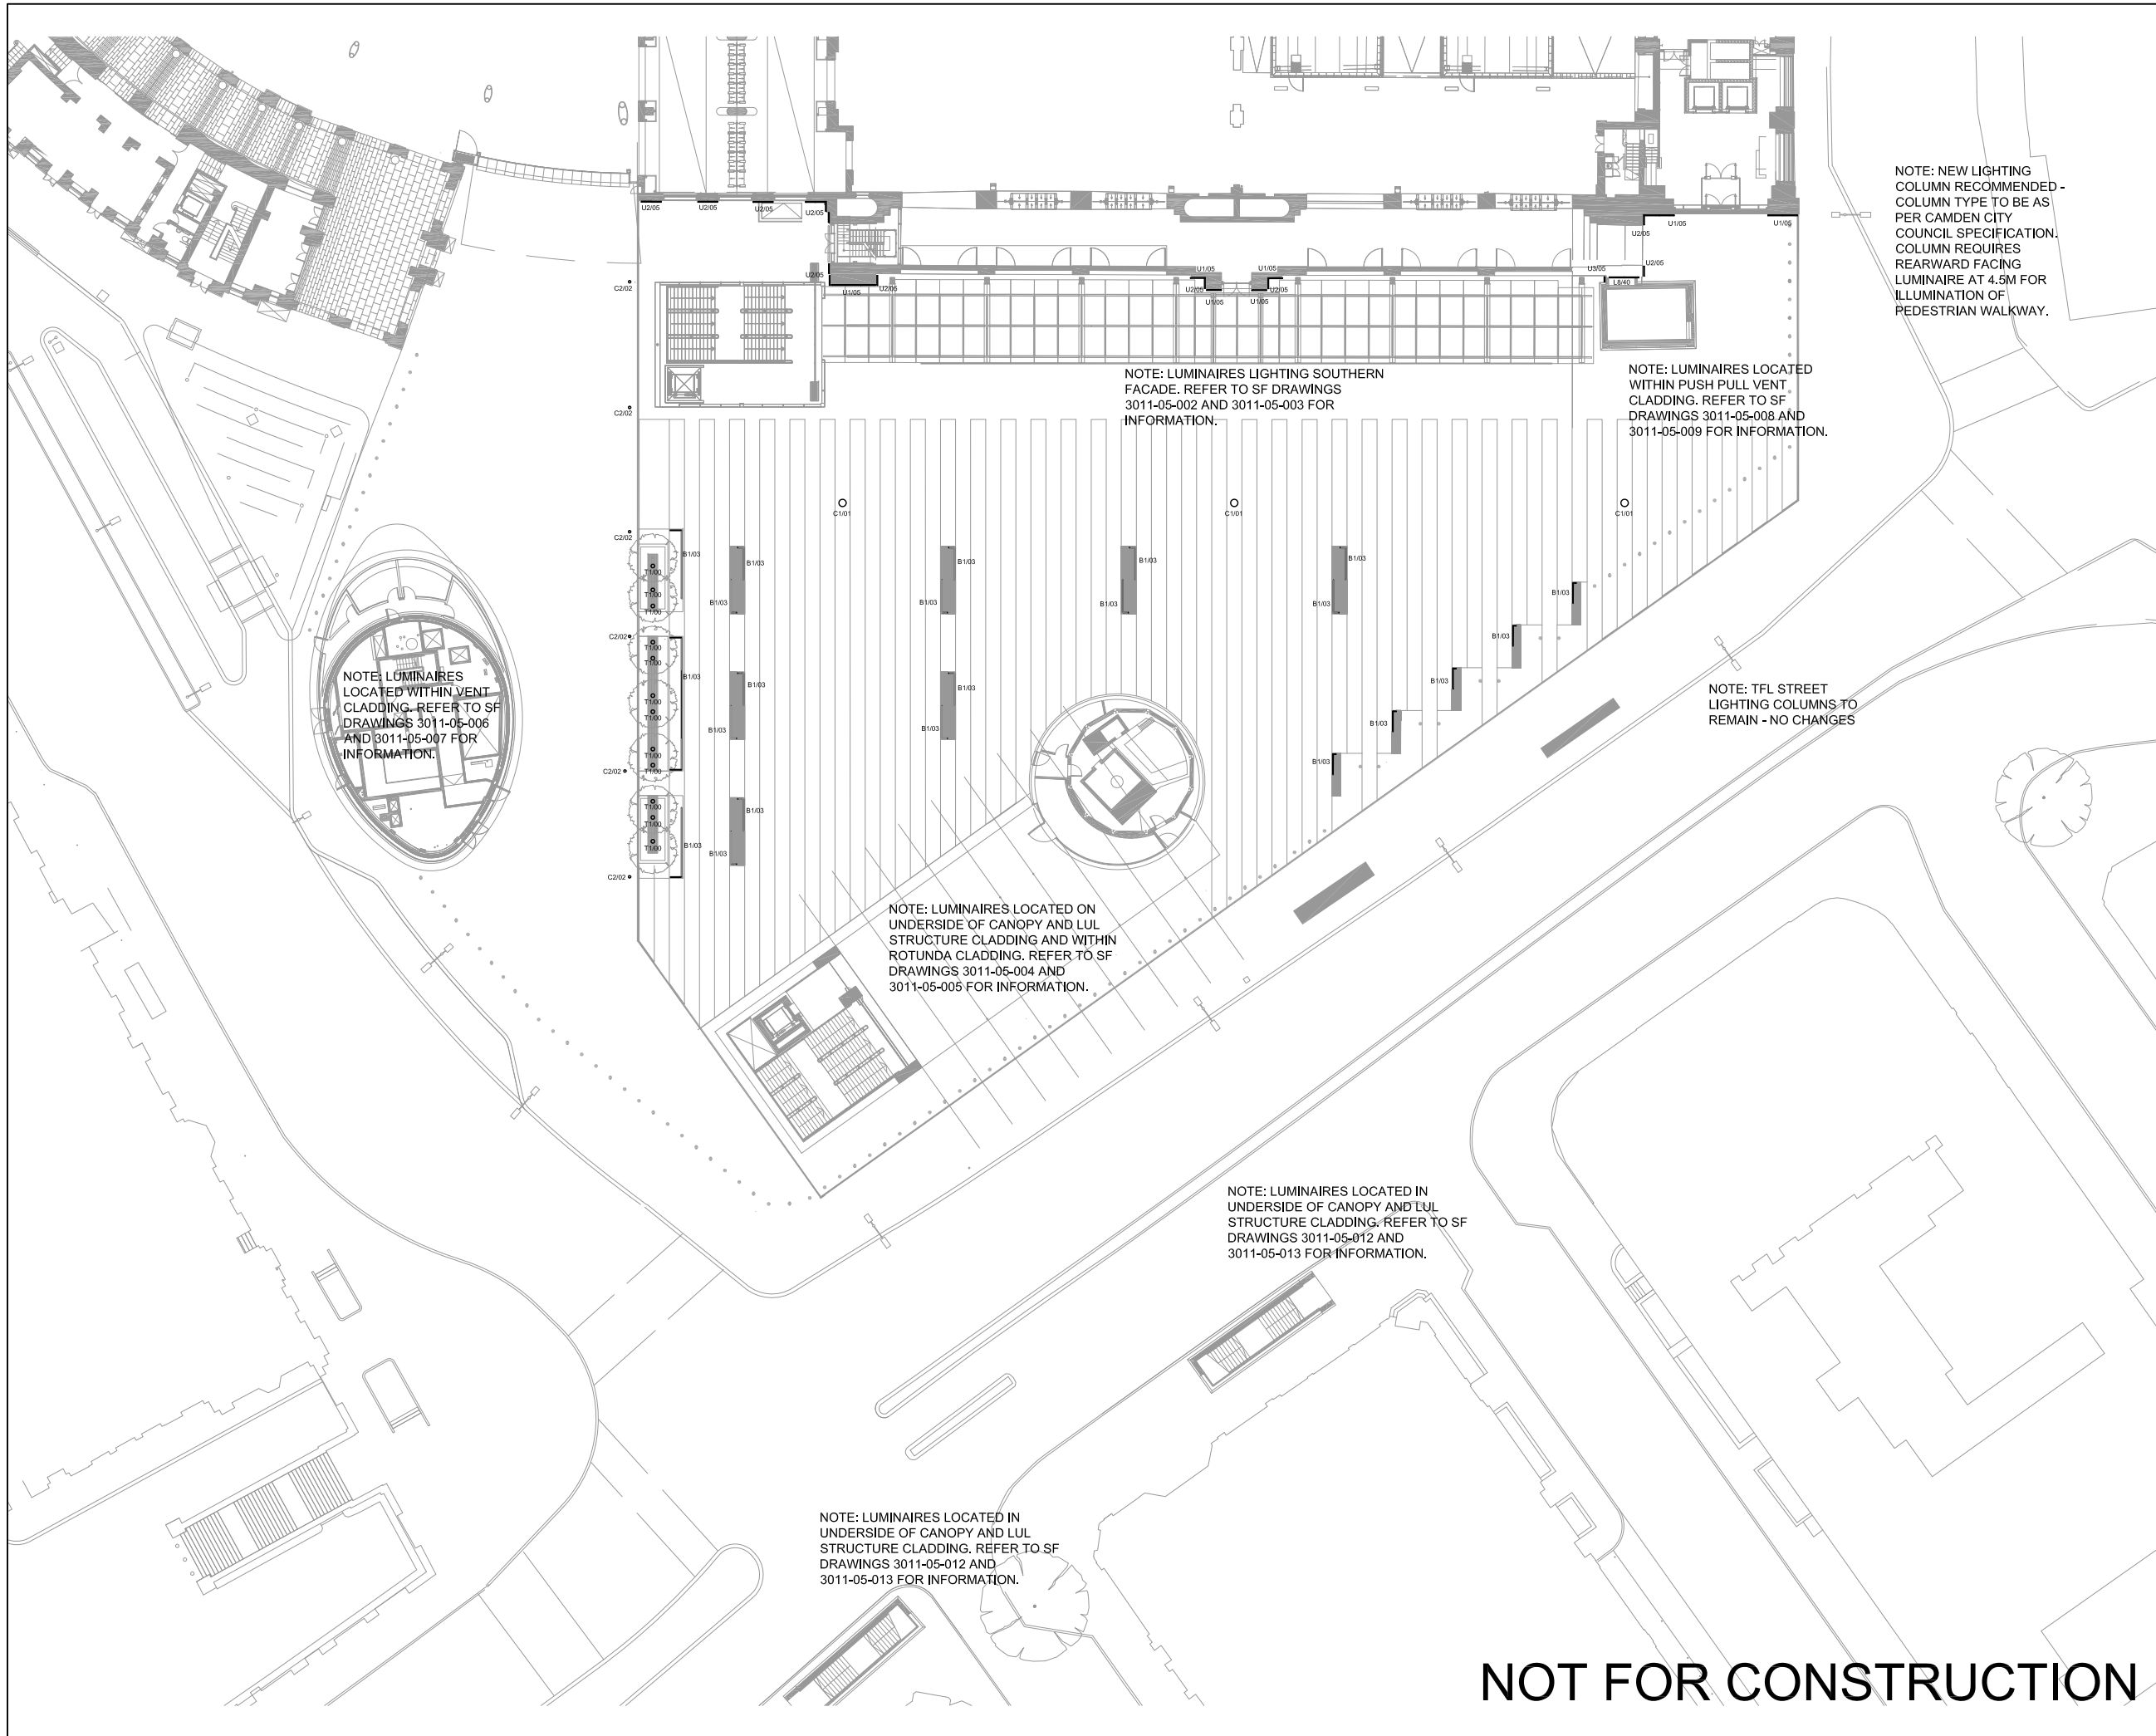

NOTE: NEW LIGHTING COLUMN RECOMMENDED - COLUMN TYPE TO BE AS PER CAMDEN CITY COUNCIL SPECIFICATION. COLUMN REQUIRES REARWARD FACING LUMINAIRE AT 4.5M FOR ILLUMINATION OF PEDESTRIAN WALKWAY.

NOTE: LUMINAIRES LIGHTING SOUTHERN FACADE. REFER TO SF DRAWINGS 3011-05-002 AND 3011-05-003 FOR INFORMATION.

NOTE: LUMINAIRES LOCATED WITHIN PUSH PULL VENT CLADDING. REFER TO SF DRAWINGS 3011-05-008 AND 3011-05-009 FOR INFORMATION.

NOTE: LUMINAIRES LOCATED WITHIN VENT CLADDING. REFER TO SF DRAWINGS 3011-05-006 AND 3011-05-007 FOR INFORMATION.

NOTE: LUMINAIRES LOCATED ON UNDERSIDE OF CANOPY AND LUL STRUCTURE CLADDING AND WITHIN ROTUNDA CLADDING. REFER TO SF DRAWINGS 3011-05-004 AND 3011-05-005 FOR INFORMATION.

NOTE: LUMINAIRES LOCATED IN UNDERSIDE OF CANOPY AND LUL STRUCTURE CLADDING. REFER TO SF DRAWINGS 3011-05-012 AND 3011-05-013 FOR INFORMATION.

NOTE: LUMINAIRES LOCATED IN UNDERSIDE OF CANOPY AND LUL STRUCTURE CLADDING. REFER TO SF DRAWINGS 3011-05-012 AND 3011-05-013 FOR INFORMATION.

NOTE: TFL STREET LIGHTING COLUMNS TO REMAIN - NO CHANGES

- LUMINAIRE KEY
- B1 - IP65 25W P/M LINEAR LED LUMINAIRE, TO BE INTEGRATED INTO BENCH.
 - C1 - 18M HIGH FEATURE LIGHTING COLUMN WITH MULTIPLE HEAD LED PROJECTORS. ESTIMATED WATTAGE PER 1.2KW
 - C2 - 6M HIGH LED LIGHTING COLUMNS WITH MULTIPLE HEAD LED PROJECTORS. ESTIMATED WATTAGE 300W.
 - D1 - IP65 10W SURFACE MOUNTED LED PROJECTOR.
 - D2 - IP65 22W RECESSED LED DOWNLIGHT.
 - D3 - IP65 30W LED DOWNLIGHT
 - L1 - IP54 50W LINEAR LED LUMINAIRE.
 - L2 - IP65 40W LINEAR LED LUMINAIRE.
 - L3 - IP54 15W P/M LINEAR LED LUMINAIRE.
 - L4 - IP65 36W P/M LINEAR LED LUMINAIRE.
 - L5 - IP65 25W P/M LINEAR LED MODULES COMPLETE WITH WIDE BEAM DISTRIBUTION.
 - L6 - IP65 30W P/M LINEAR LED LUMINAIRE.
 - L7 - IP65 40W SURFACE MOUNTED LINEAR LED LUMINAIRE.
 - L8 - IP65 36W SURFACE MOUNTED LINEAR LED LUMINAIRE.
 - L8A - IP65 12W SURFACE MOUNTED LINEAR LED LUMINAIRE.
 - L10 - IP65 70W LINEAR LED LUMINAIRE.
 - L11 - IP65 36W LINEAR LED LUMINAIRE.
 - P2 - IP65 30W LED PROJECTORS.
 - T1 - IP65 30W IN-GROUND LED UPLIGHTER.
 - U1 - IP68 36W IN - GROUND, LINEAR, ADJUSTABLE LED UPLIGHTER.
 - U2 - IP68 24W IN - GROUND, LINEAR, ADJUSTABLE LED UPLIGHTER.
 - U3 - IP68 12W IN - GROUND, LINEAR, ADJUSTABLE LED UPLIGHTER.

01 29-07-11 BH CS CS

Issue Date By Chkd Appd

Client:
Cubitt House
1 Battle Bridge Road
London N1C 4AH
Phone +44 (0)20 7147 6011
Email: KingsCrossRedevelopment@networkrail.co.uk



Stanton Williams
36 Graham Street
London N1 8GJ
Phone +44 (0)20 7880 6400
Email: 420@stantonwilliams.com
www.stantonwilliams.com

STANTON
WILLIAMS

studio **FRACTAL**
Suite 113, The Beehive, City Place,
Gatwick, East Sussex, RH6 0PA,
Tel: 01293 804792, Email: info@studiofractal.co.uk

Job Title
**King's Cross Station
Redevelopment Programme
Package 7**

Drawing Title
Kings Cross Square
GA Lighting Plan

Scale at A1
1: 50
Document Reference No
ENG-DWG-SWA-SSQ-SFR-3011-05-001
Drawing Status
GRIPStage4

SF Job No Drawing No
3011 05-001

Rev.
01

NOT FOR CONSTRUCTION