



COURTYARD AND ROOF
AREA OF WORKS

N.T.S.

- NOTES:
1. THIS DRAWING IS THE PROPERTY OF HITEK CONSULTANTS LIMITED AND IS PROTECTED UNDER THE COPYRIGHTS DESIGNS AND PATENTS ACT 1988. ALL RIGHTS RESERVED. THIS DRAWING IS ISSUED ON CONDITION THAT IT IS NOT COPIED, REPRINTED OR REPRODUCED, WHOLLY OR IN PART, WITHOUT THE CONSENT OF HITEK CONSULTANTS LIMITED.
 2. DO NOT SCALE FROM THIS DRAWING. ALL DIMENSIONS AND SETTING OUT TO BE TAKEN FROM ARCHITECTURAL DRAWINGS.
 3. THIS DRAWING SHALL BE READ IN CONJUNCTION WITH THE ARCHITECTS, STRUCTURAL ENGINEERS AND ALL OTHER SERVICES DRAWINGS AND SPECIFICATIONS.

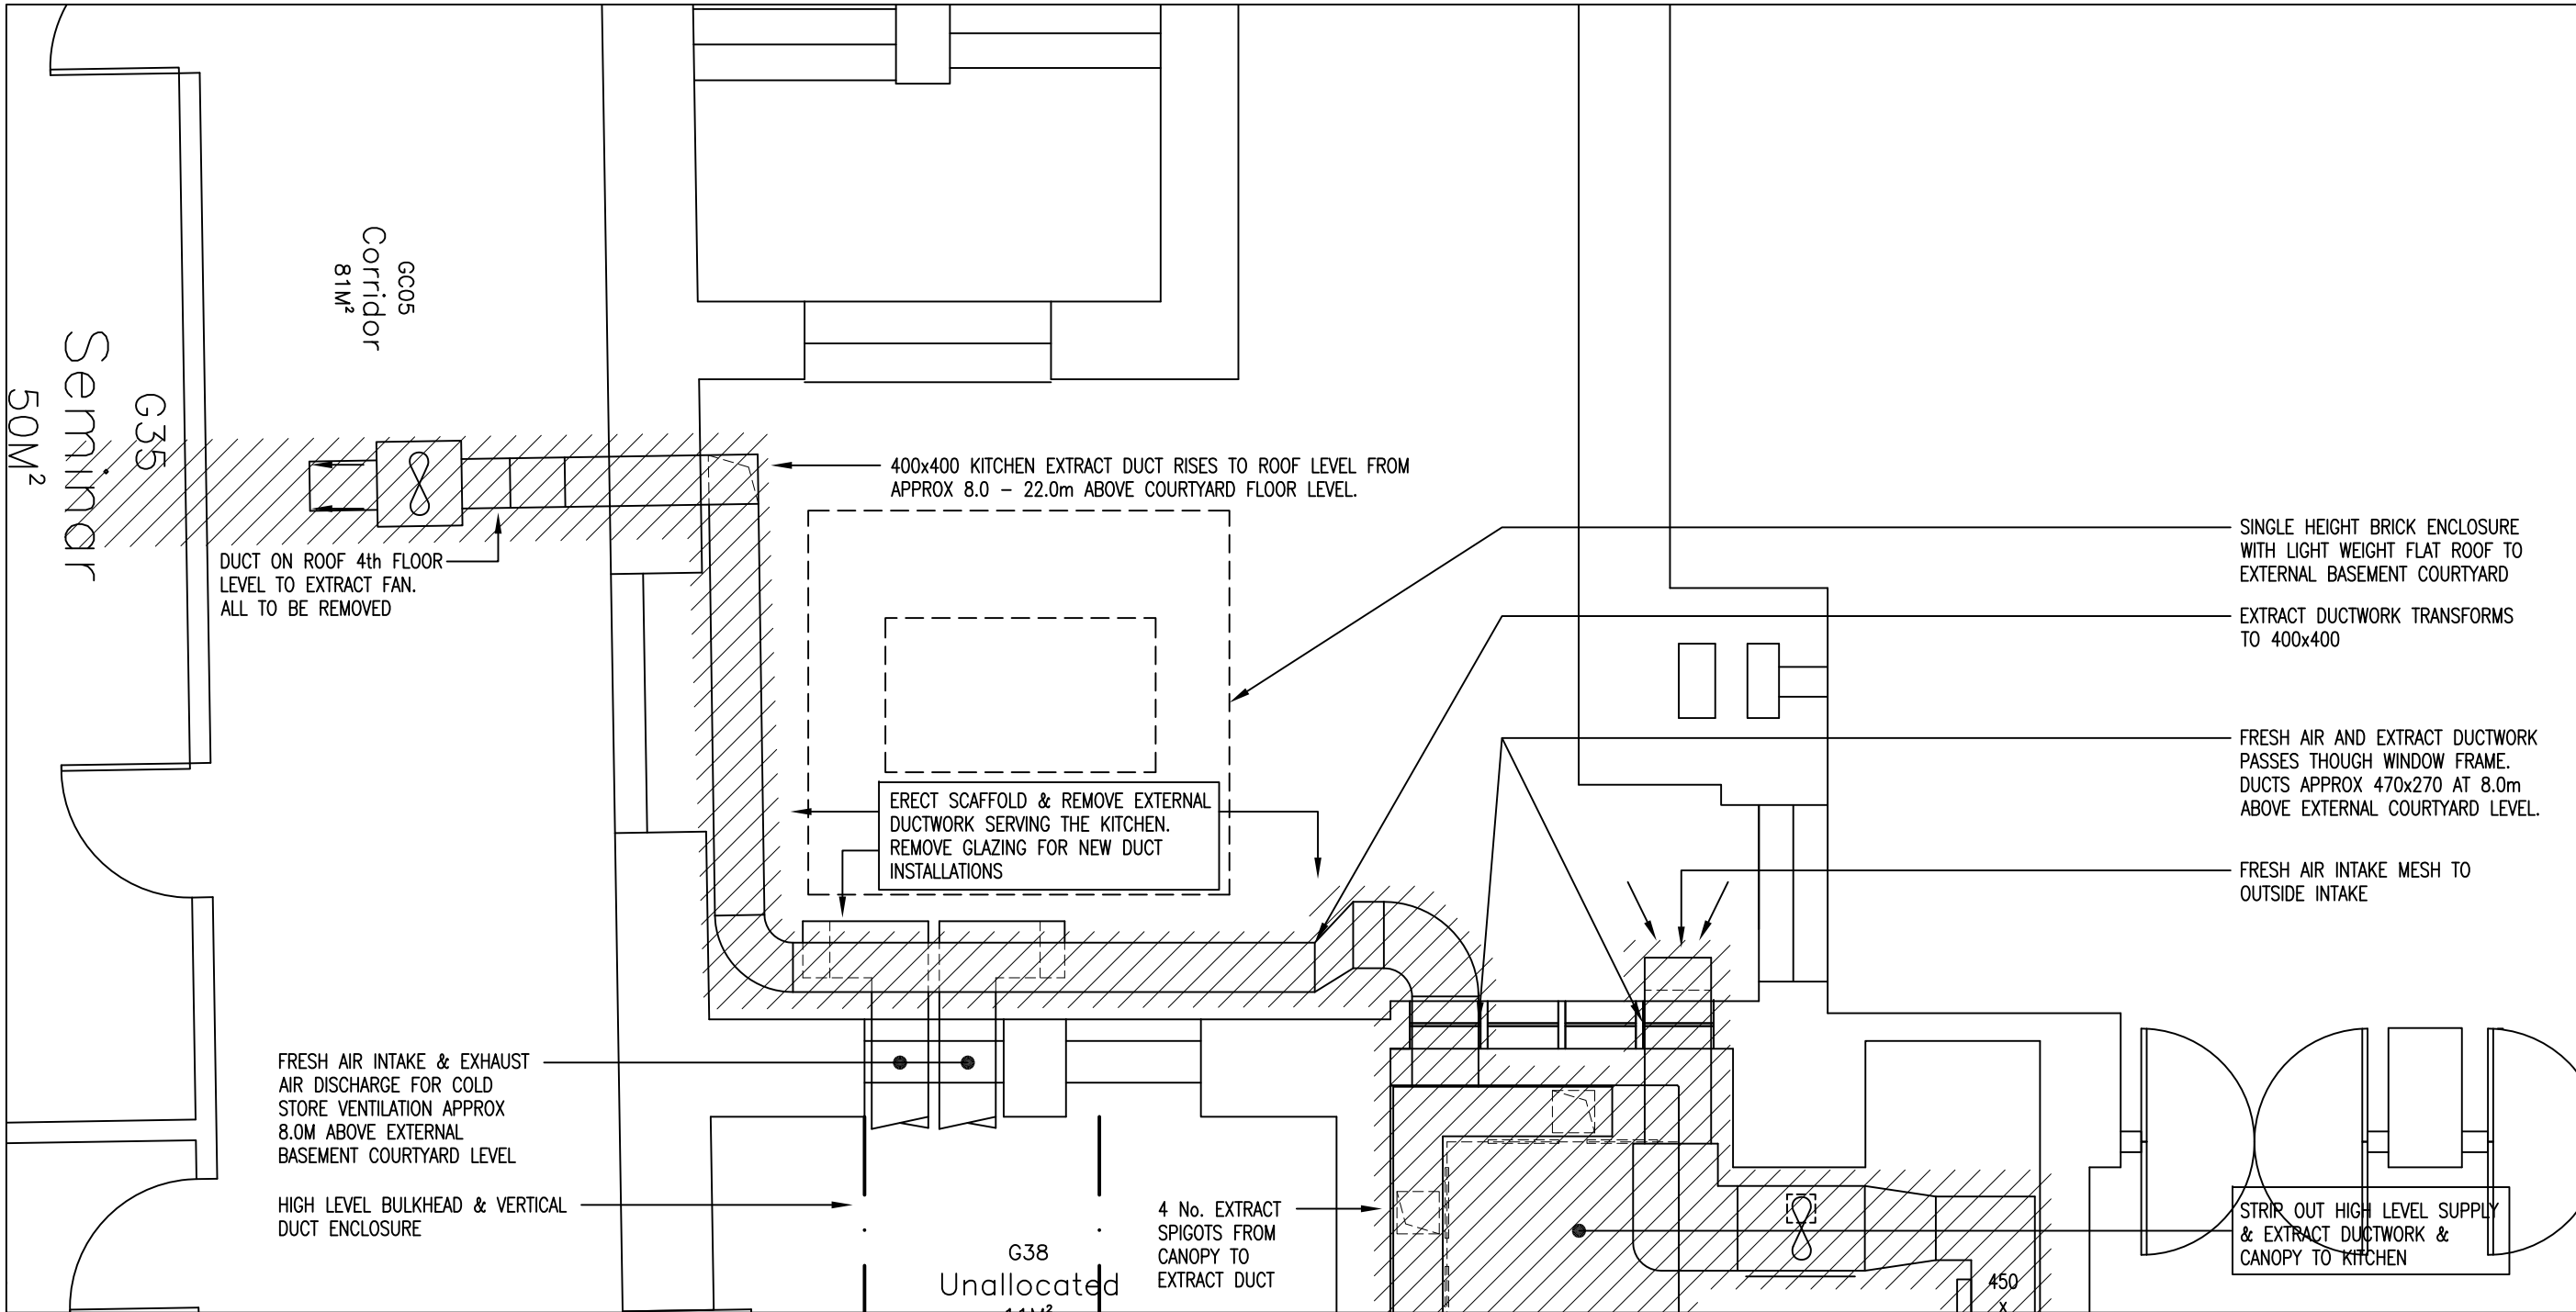

EXISTING ROOF AND COURTYARD PLAN LAYOUT

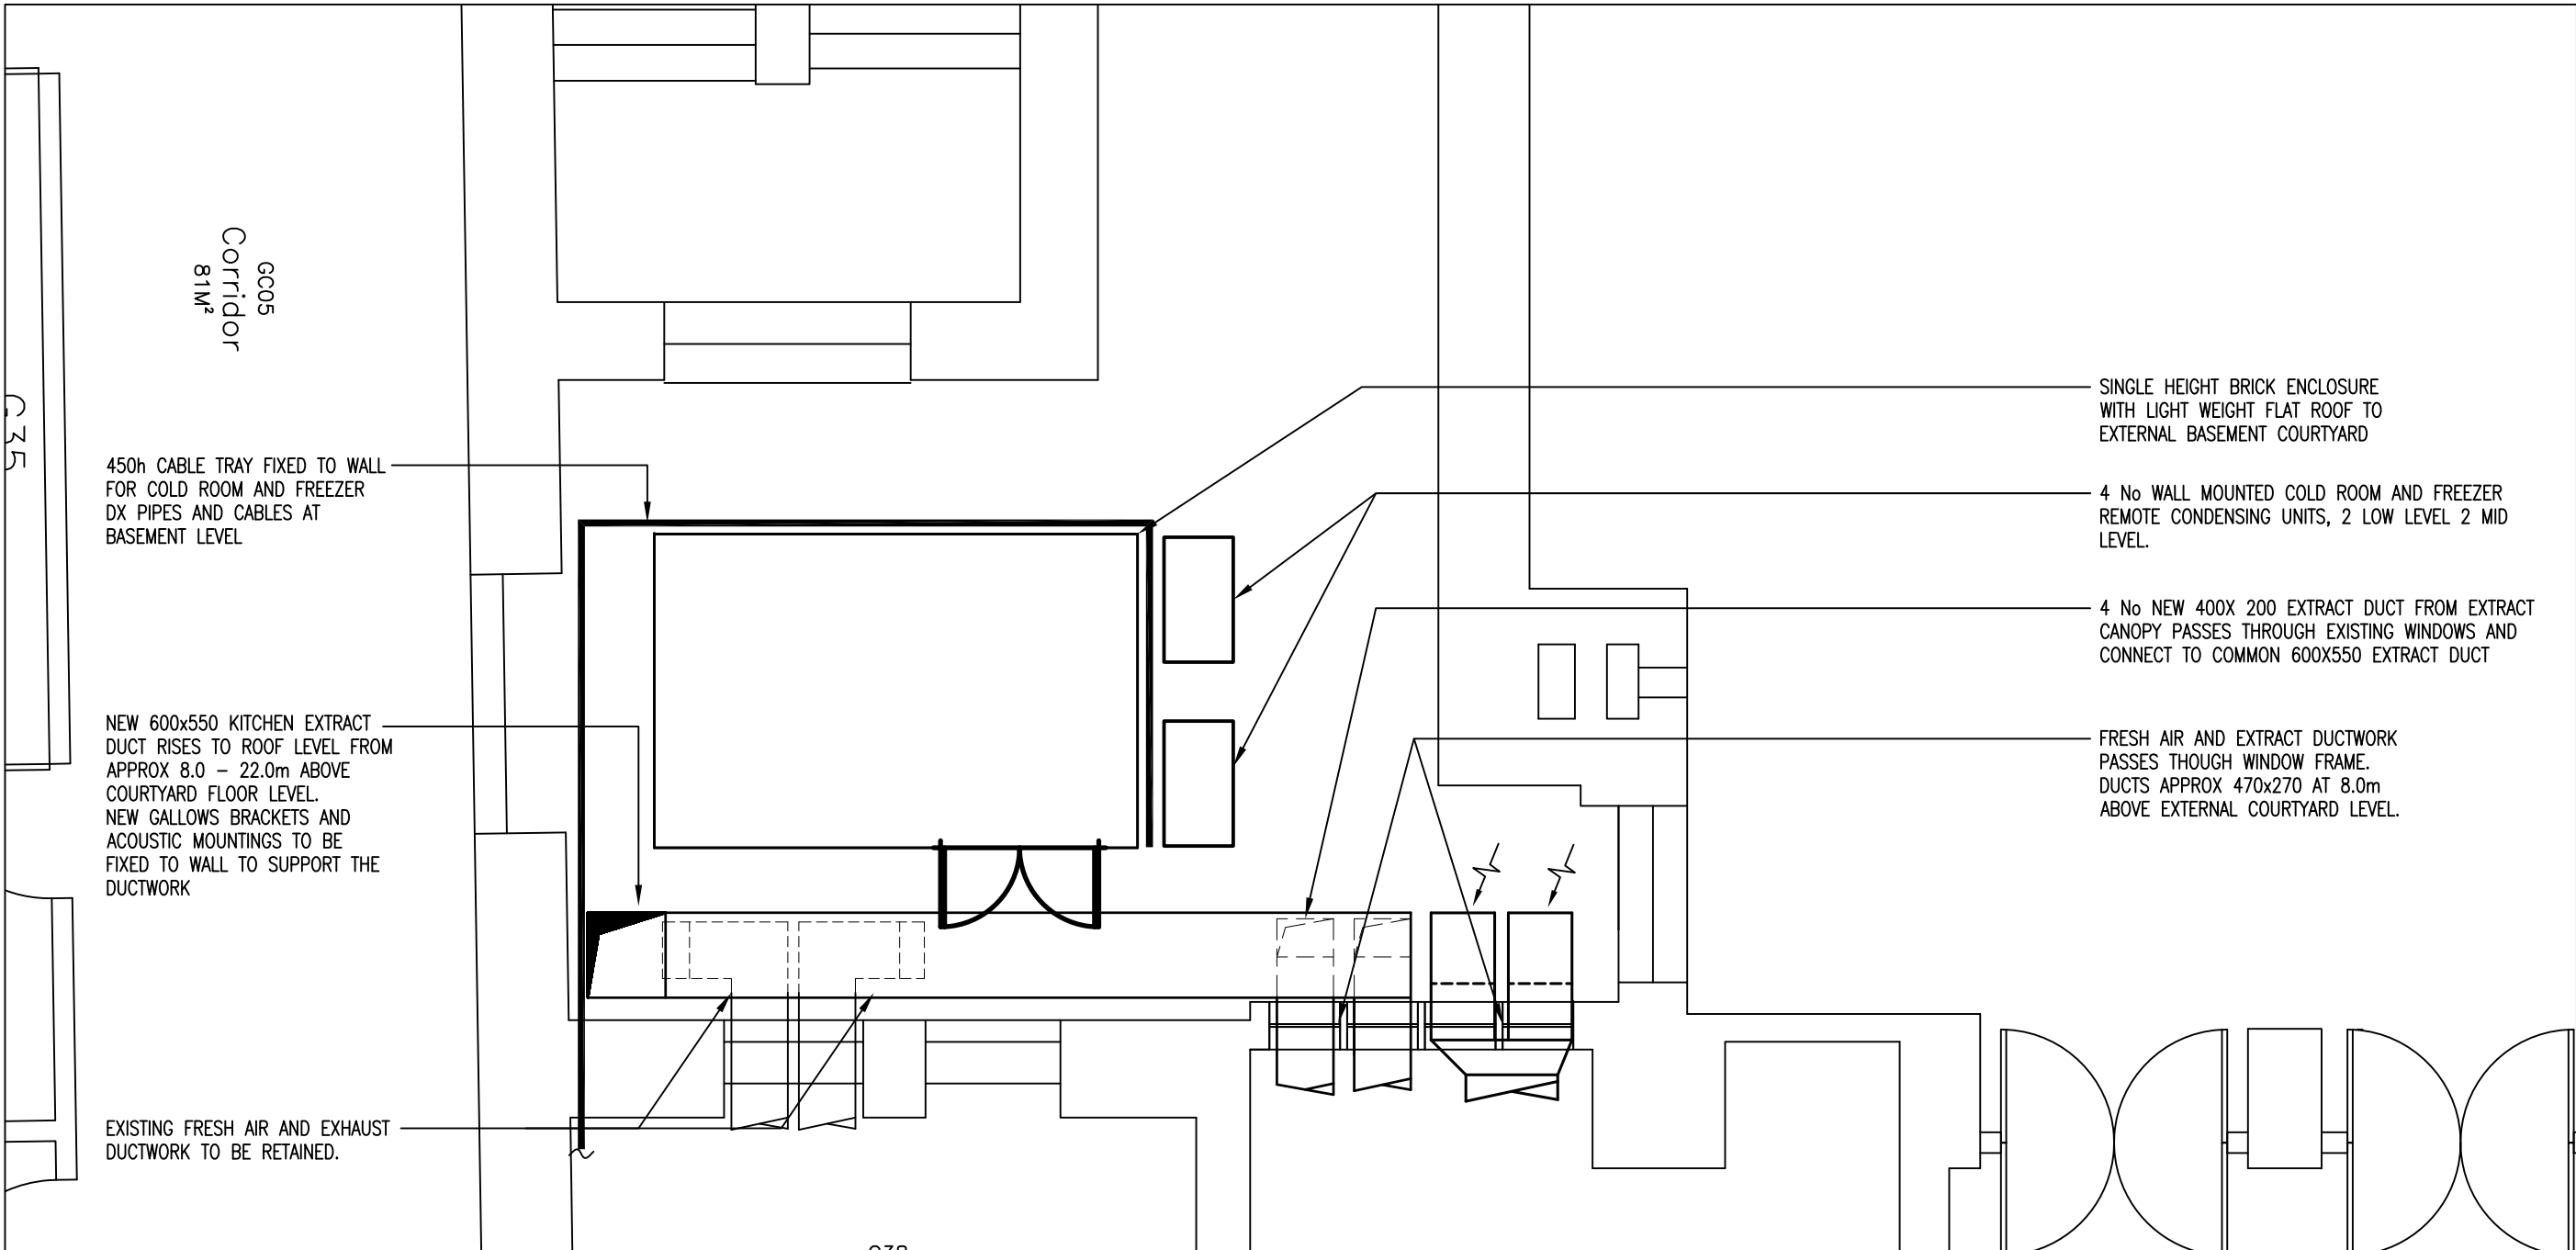

PROPOSED COURTYARD PLAN LAYOUT

Rev	Date	Details	By	Chd
<div>Hitek Consultants Ltd Chartered Building Services Consulting Engineers Barn A, The Stables Parsonage Farm Hollow Hill Lane Iver, Bucks SL0 0JW</div> <div>T 01753 650 310 T 0844 880 5701 F 0844 880 5702 E info@hitekconsultants.co.uk cad@hitekconsultants.co.uk www.hitekconsultants.co.uk</div>				
Project SENATE HOUSE MACMILLAN HALL CATERING ENABLING WORKS				
Client UNIVERSITY of LONDON				
Architect NIGEL BURGESS ASSOCIATES				
Title EXISTING ROOF AND EXISTING & PROPOSED EXTERNAL COURTYARD DUCTWORK PLAN LAYOUT				
Scale 1:50 @ A1		Drawing no. 5150/P/M01		
Date SEPT 2011		Revision		
Designed FMc	Cad ref 5150PM01			
Drawn CAM	Checked DTS			
COPYRIGHT NOTICE THIS DRAWING REMAINS THE PROPERTY OF HITEK CONSULTANTS LIMITED. COPIES OF THIS DRAWING OR PARTS THEREOF ARE PROHIBITED WITHOUT EXPRESS PERMISSION.				