


All Souls Church

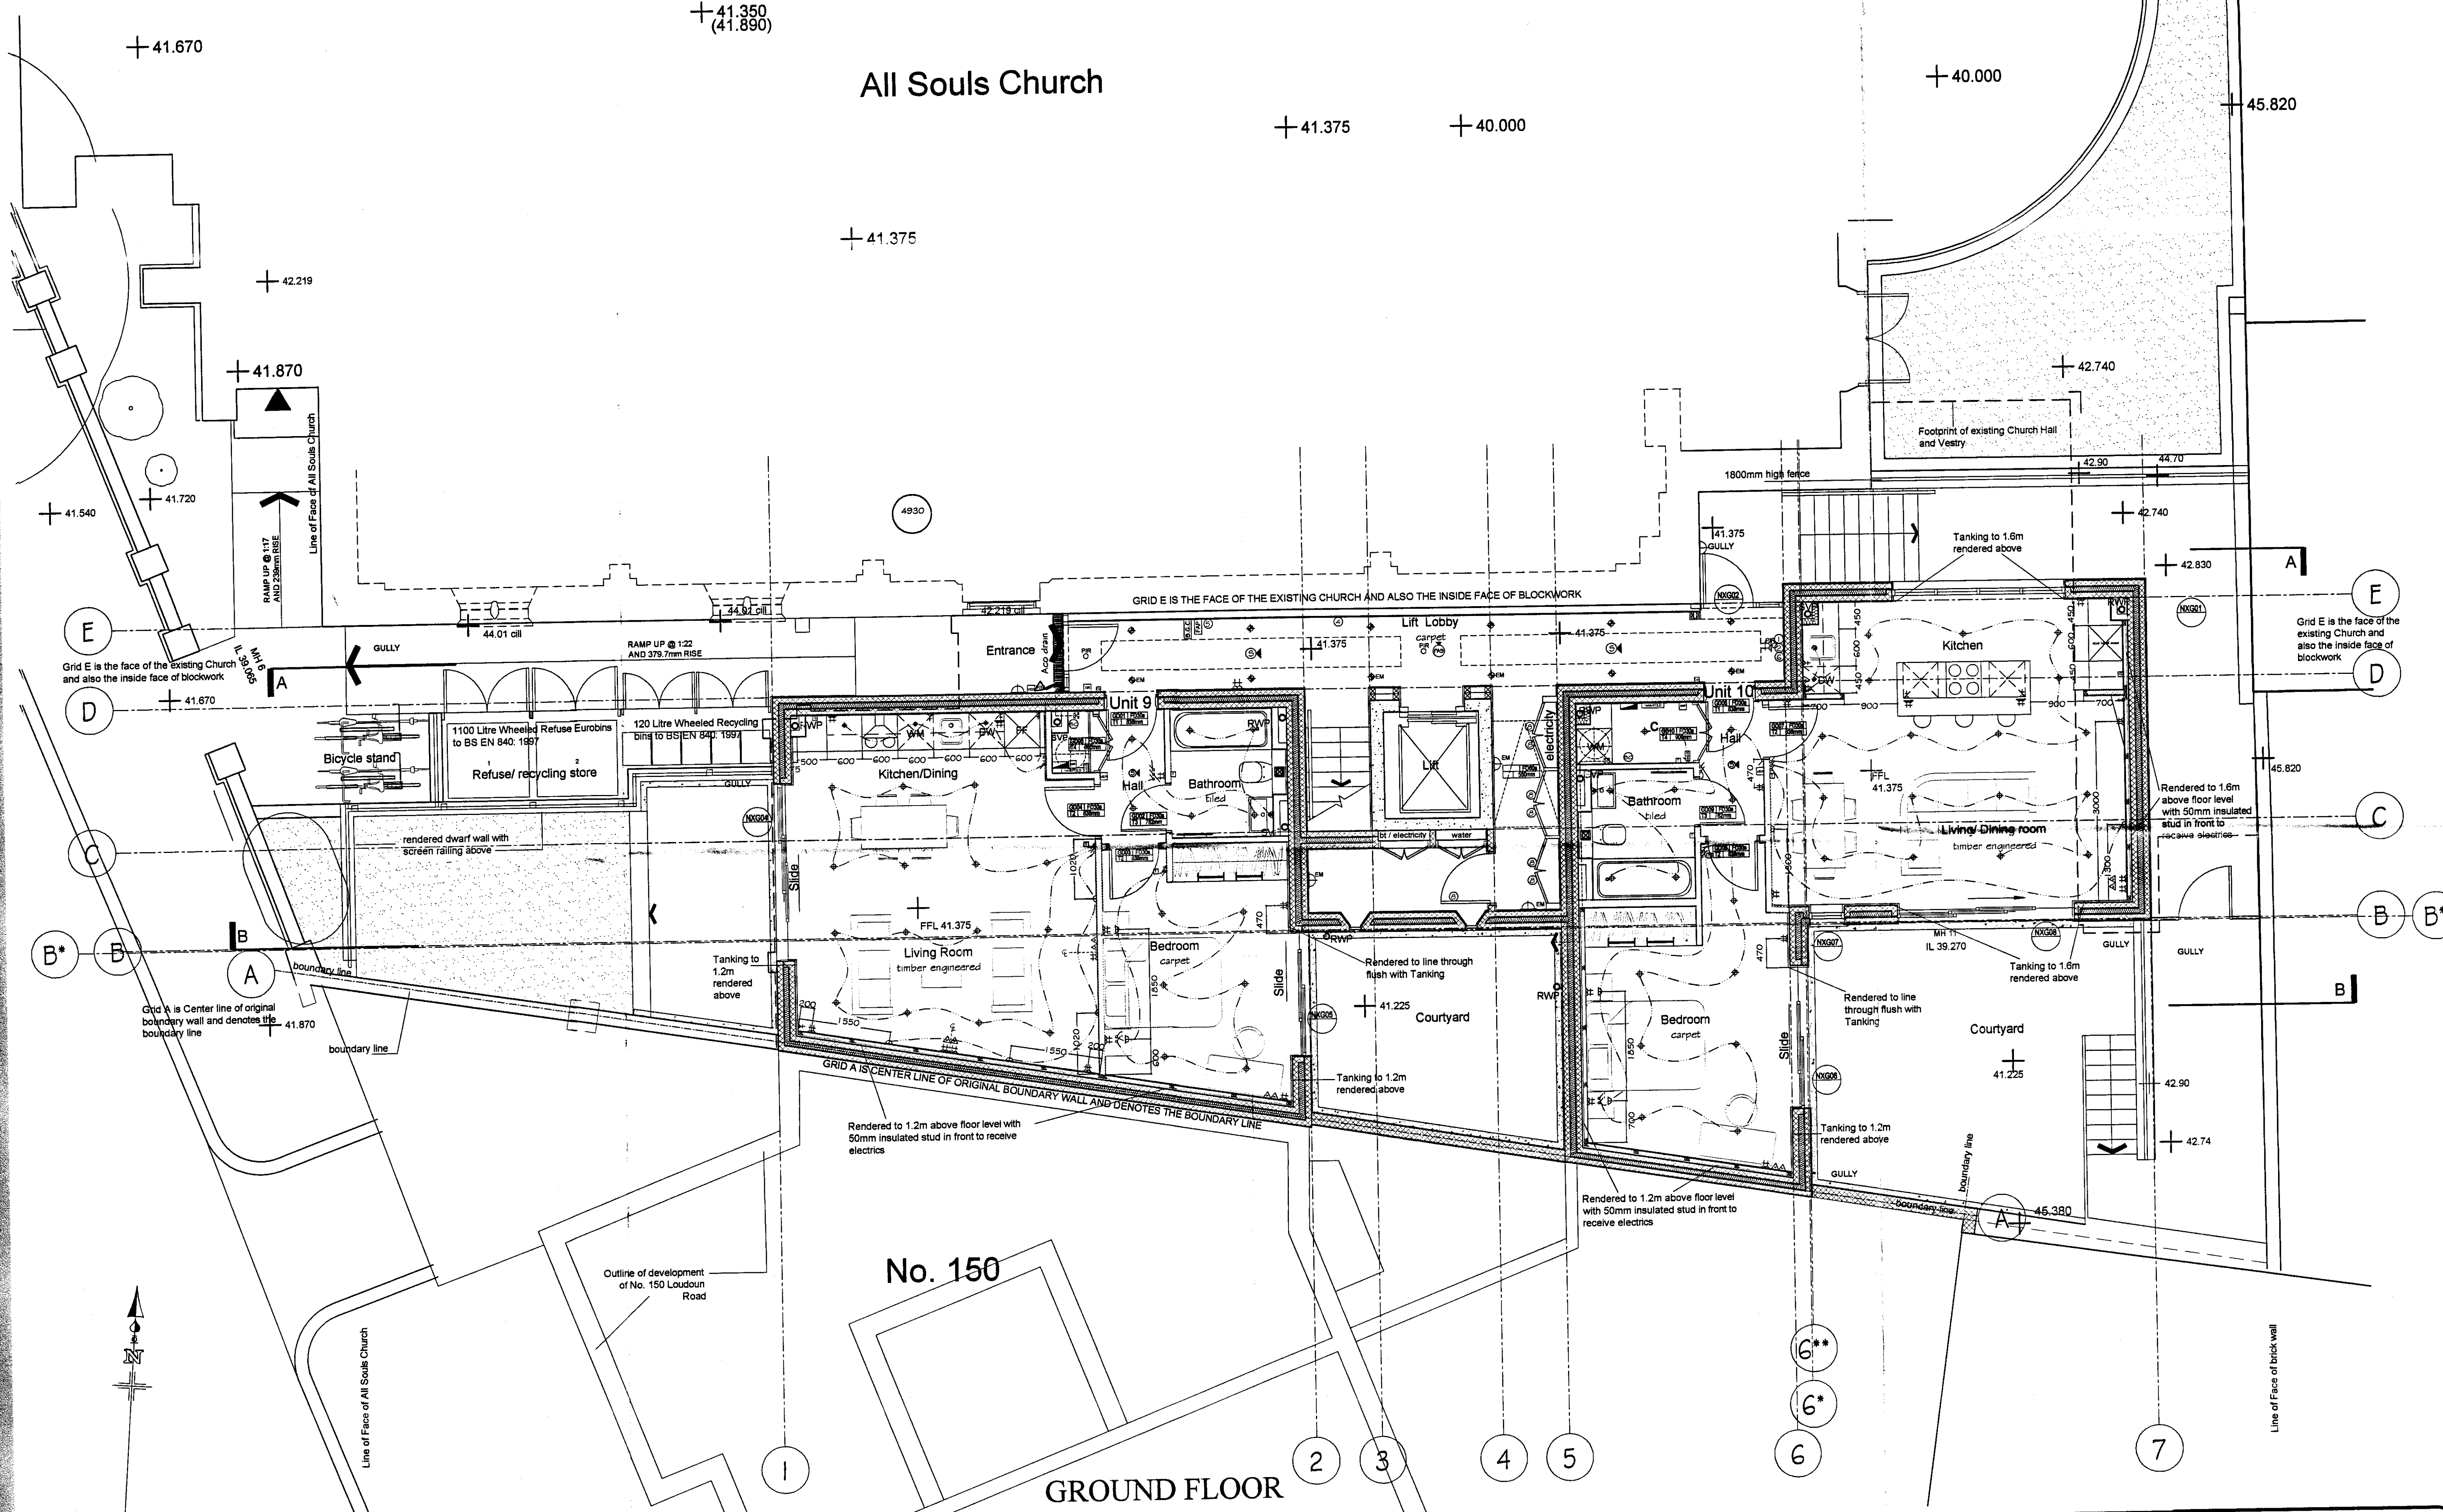

GROUND FLOOR

Notes No scaled dimensions to be taken from this drawing. All dimensions to be site checked.

- | | | | |
|--|--|---|---|
| <ul style="list-style-type: none"> ⊙ Downlighter ⊕ Wall mounted directional movement sensor ⊕ Ceiling mounted 360° movement sensor ⊕ Smoke detector & sounder ⊕ Emergency exit light ⊕ Fire alarm pull ⊕ Fire alarm sounder ⊕ Fire alarm control panel ⊕ Fire alarm reset ⊕ Fire alarm control panel ⊕ Fire alarm control panel ⊕ Fire alarm control panel | <ul style="list-style-type: none"> ⊕ Emergency downlighter ⊕ Light Switch ⊕ Break Glass Contact ⊕ Operative vens control panel ⊕ Video Dry Phone ⊕ Fire alarm pull ⊕ Fire alarm sounder ⊕ Fire alarm control panel ⊕ Fire alarm control panel ⊕ Fire alarm control panel ⊕ Fire alarm control panel ⊕ Fire alarm control panel | <ul style="list-style-type: none"> ⊕ Boland with emergency light ⊕ Pendant Light ⊕ Downlighter with emergency ⊕ High level double sockets ⊕ Low level double sockets ⊕ Low level triple sockets ⊕ Shaver socket ⊕ Isolator Switch ⊕ Surface mounted light ⊕ Fiberoptic light ⊕ Radiator ⊕ Thermostat ⊕ Radiator junction box ⊕ Radiator ⊕ Radiator | <ul style="list-style-type: none"> ⊕ 3 core water fire adaptation ⊕ 3 fire water fire adaptation ⊕ Fire exit left directional sign 'Block Sign' ref 11100910 ⊕ Fire exit right directional sign 'Block Sign' ref 11100910 ⊕ Fire exit left directional sign 'Block Sign' ref 11100910 ⊕ Fire exit right directional sign 'Block Sign' ref 11100910 ⊕ Fire door escape route directional sign 'Block Sign' ref 11100910 ⊕ Fire door escape route directional sign 'Block Sign' ref 11100910 ⊕ Fire door escape route directional sign 'Block Sign' ref 11100910 ⊕ Fire door escape route directional sign 'Block Sign' ref 11100910 ⊕ Fire door escape route directional sign 'Block Sign' ref 11100910 |
|--|--|---|---|

Rev	Date	Revision	Initials	Rev	Date	Revision	Initials

<p>project ALL SOULS CHURCH Loudoun Road London NW8</p> <p>client</p>	<p>drawing AS BUILT GROUND FLOOR PLAN</p> <p>date 10/09</p> <p>scale 1:50</p> <p>drawn LS</p> <p>checked JE</p> <p>job no 6761</p> <p>drawing no 231</p> <p>rev</p>	<p>METROPOLITAN DEVELOPMENT CONSULTANCY</p> <p>66 Bickenhall Mansions, Bickenhall Street, London, W1U 6EX Telephone: 020 7486 6675 Fax: 020 7486 7206 Email: surveyors@mdlondon.com</p>
---	---	---