

PAINT SCHEDULE:

NOTES:

- 1 GENERAL CONTRACTOR TO PERMIT, SUPPLY AND INSTALL SIGNAGE. SIGNAGE CONTRACTOR TO VERIFY SIGNAGE COMPLIANCE WITH LOCAL CODES AND OBTAIN PERMIT AND LANDLORD APPROVAL.
- 3 GENERAL CONTRACTOR SHALL COORDINATE WITH ELECTRICAL CONTRACTOR TO FURNISH AND INSTALL ELECTRICAL CIRCUIT INCLUDING ALL CONDUIT, WIRE, CONNECTIONS, AND BREAKER AT PANELBOARD NECESSARY TO SERVE SIGNAGE.
- 4 SIGNAGE CONTRACTOR TO SUPPLY SHOP DRAWINGS TO STARBUCKS CONSTRUCTION MANAGER AND TO THE GENERAL CONTRACTOR AS NEEDED. NOTIFY STARBUCKS CONSTRUCTION MANAGER IMMEDIATELY IF SHOP DRAWINGS OR INSTALLATION IS IN DISCREPANCY WITH STARBUCKS ARCHITECTURAL DRAWINGS.
- 5 GENERAL CONTRACTOR TO COORDINATE AND SCHEDULE SIGNAGE INSTALLATION WITH THE SIGNAGE CONTRACTOR. STARBUCKS CONSTRUCTION MANAGER TO PROVIDE GENERAL CONTRACTOR WITH SIGNAGE CONTRACTOR CONTACT INFORMATION.
- 6 GENERAL CONTRACTOR TO PROVIDE FIRE TREATED WOOD STUD BLOCKING, OR EQUIVALENT TO SUPPORT SIGNAGE.

SIGNAGE SCHEDULE

SIGNAGE SCHEDULE:

ITEM #	QTY	DESCRIPTION
--------	-----	-------------

ADDITIONAL ITEMS		



STARBUCKS
COFFEE COMPANY
2401 UTAH AVENUE SOUTH
SEATTLE, WASHINGTON 98134
(206) 318-1575

THESE PLANS AND SPECIFICATIONS, AS WELL AS STARBUCKS' NAME AND LOGO, TRADEMARKS AND DESIGNS ARE THE EXCLUSIVE PROPERTY OF STARBUCKS CORPORATION. ANY REPRODUCTION, MODIFICATION, DISCLOSURE AND/OR USE OF THESE MATERIALS (OR ANY PORTION OF THEM) WITHOUT STARBUCKS' PRIOR WRITTEN CONSENT IS STRICTLY PROHIBITED.

THIS DRAWING HAS BEEN REVIEWED, AND WHERE REQUIRED, UPDATED, BY EVOLVE (DESIGN) LIMITED, TO COMPLY WITH THE CURRENT COM REGULATIONS (CONSTRUCTION DESIGN & MANAGEMENT) 13. EVOLVE (DESIGN) LIMITED ARE EMPLOYED BY STARBUCKS COFFEE COMPANY UK AS COMPETENT "DESIGNERS" AS REQUIRED IN THE ABOVE MENTIONED REGULATIONS.

THIS DRAWING HAS ALSO BEEN REVIEWED, AND WHERE REQUIRED, UPDATED, TO COMPLY WITH BUILDING REGULATIONS PART A TO PART P.

EVOLVE (DESIGN) LIMITED, SUITE No.6, No.1 WEST STREET, BANWELL, NORTH SOMERSET, UK, BS22 6DA
T. 0044(0)1934 822764 F. 0044(0)1934 822764

REGISTERED IN ENGLAND NO.04164628
REGISTERED OFFICE: CHARTERHOUSE, 3 BEACONSFIELD ROAD, WESTON 3 MARK, N. BRISTOL, BS22 1YE

REV DATE PD DESCRIPTION

PROJECT: NEAL STREET
42 NEAL STREET
LONDON WC2H 9PS
COUNTRY: ENGLAND


STORE #: 14941
PROJECT #: 52597-001
CONCEPT: PALETTE:
ISSUE DATE: 06/10/10
DM: ARTISAN
PD: HM
CHECKED: EVOLVE
TB

SHEET TITLE
STOREFRONT
ELEVATIONS &
SIGNAGE


SCALE: 1:50 @ A1

SHEET NUMBER
A2.0


CONCEPTUAL DESIGN DRAWINGS ONLY – NOT INTENDED FOR CONSTRUCTION

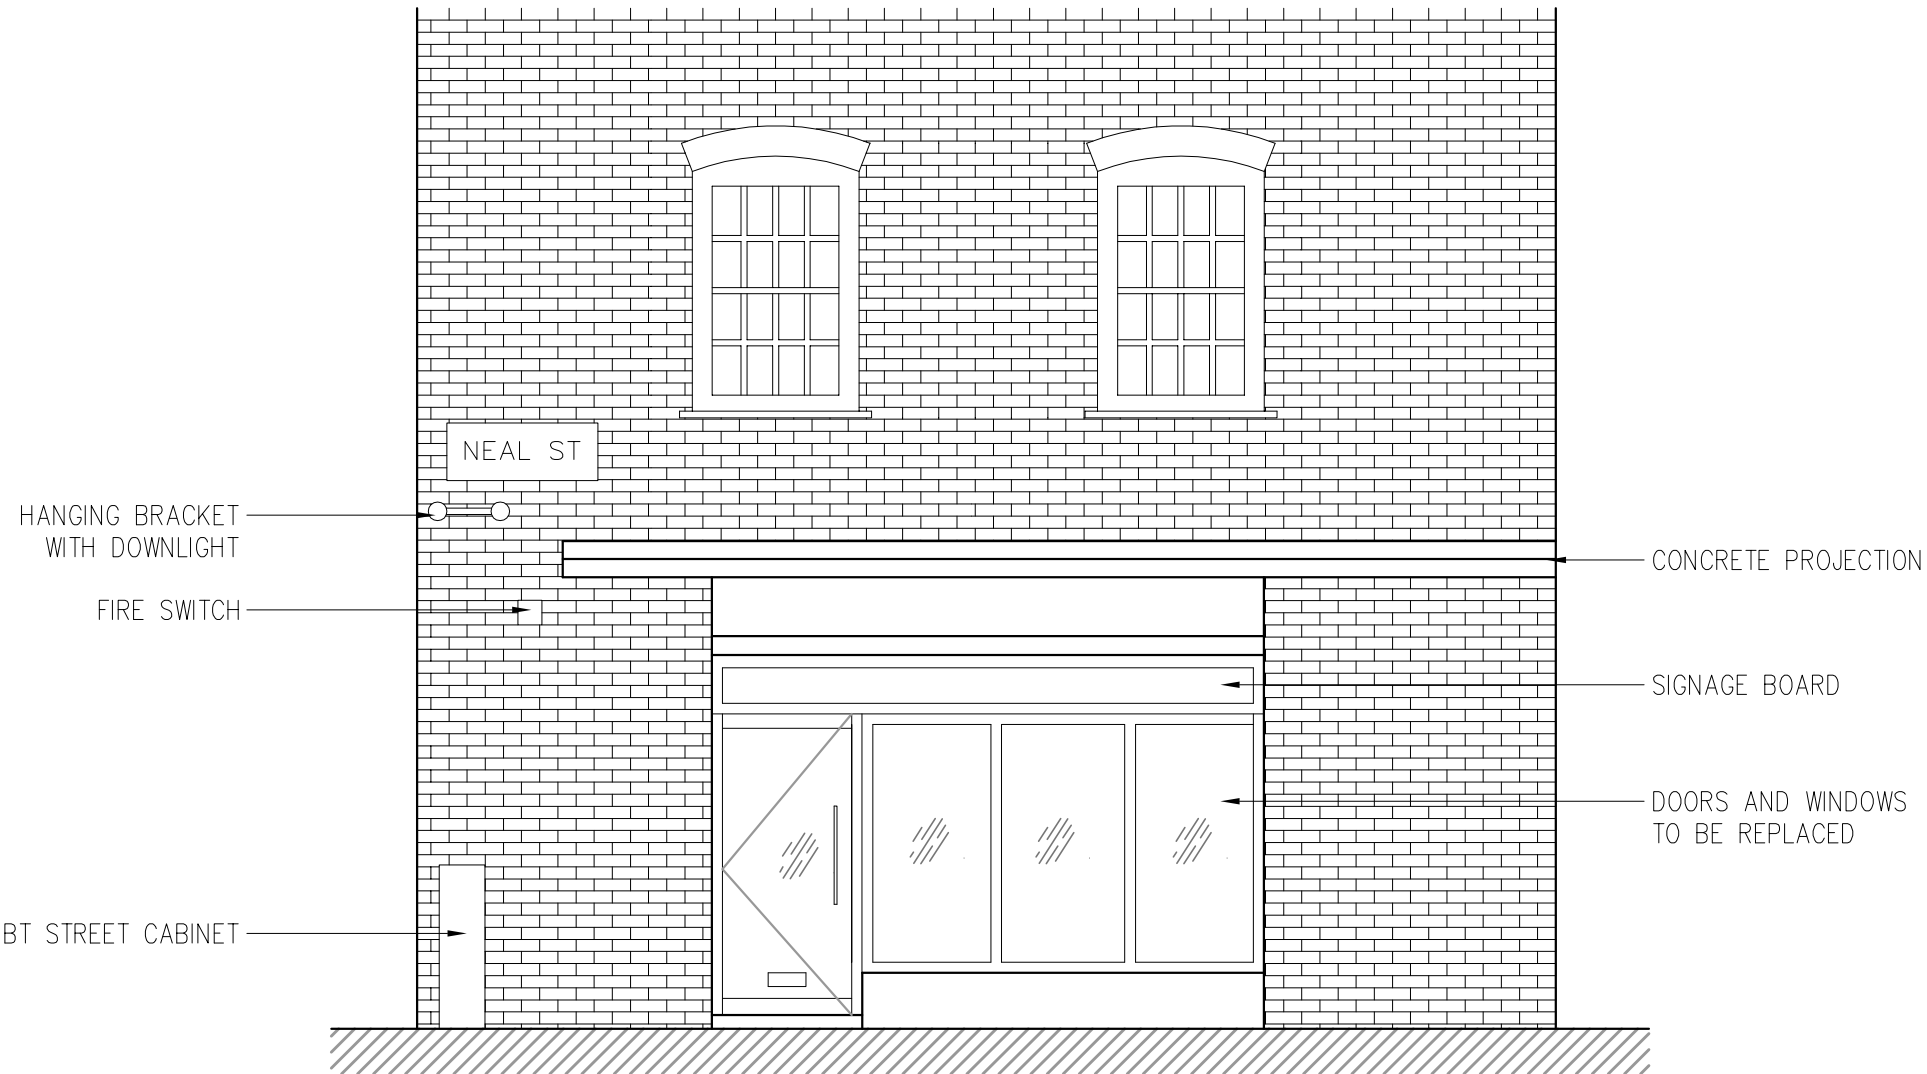


1 EXISTING FRONT ELEVATION

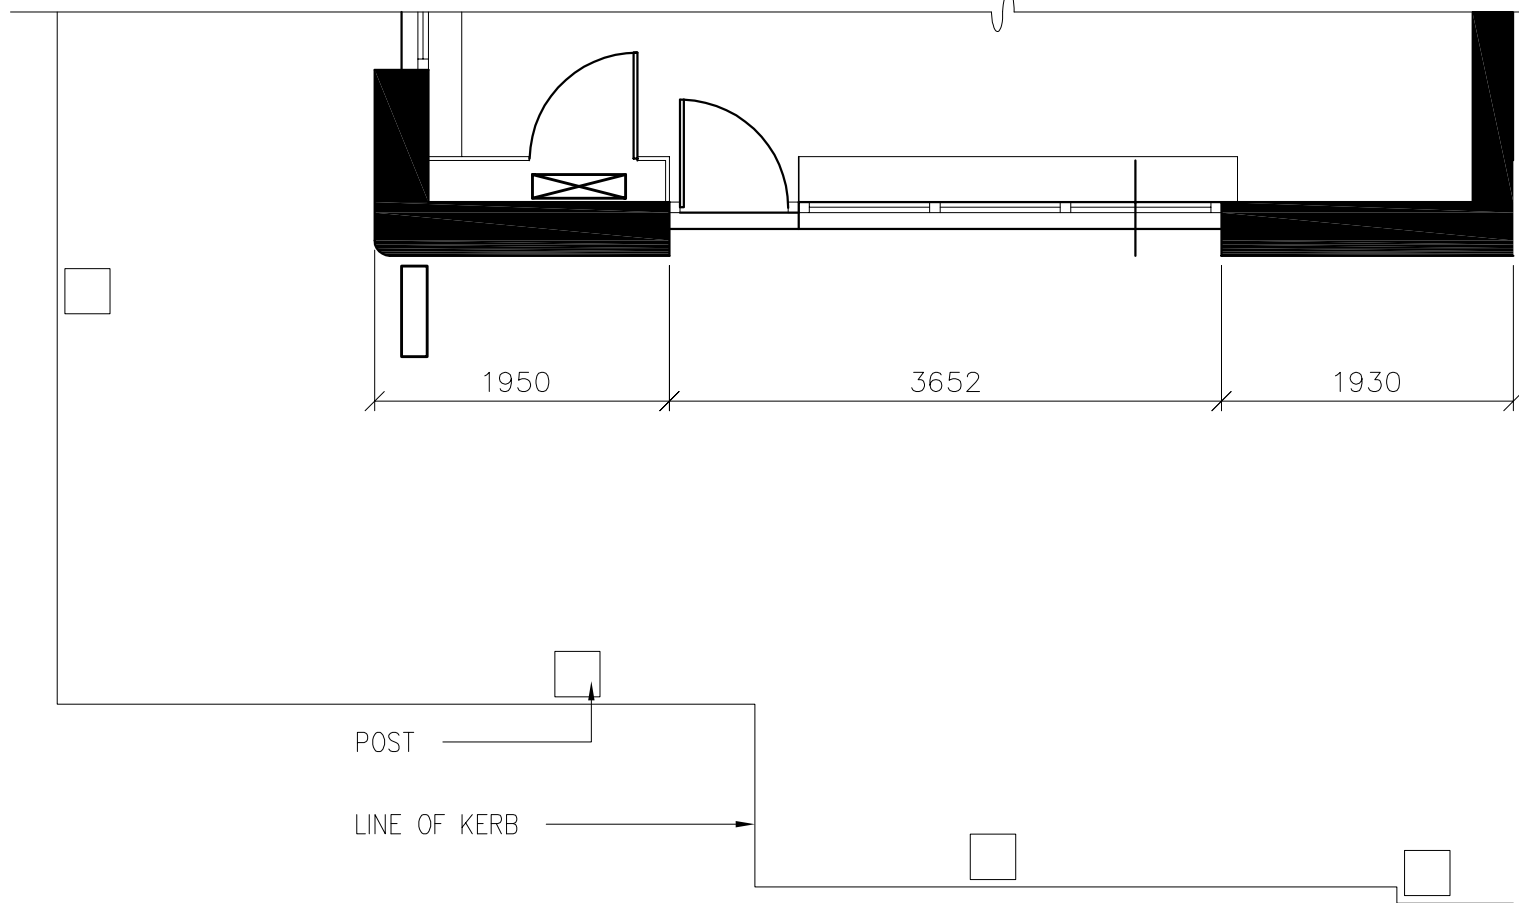


EXISTING PARTIAL PLAN VIEW

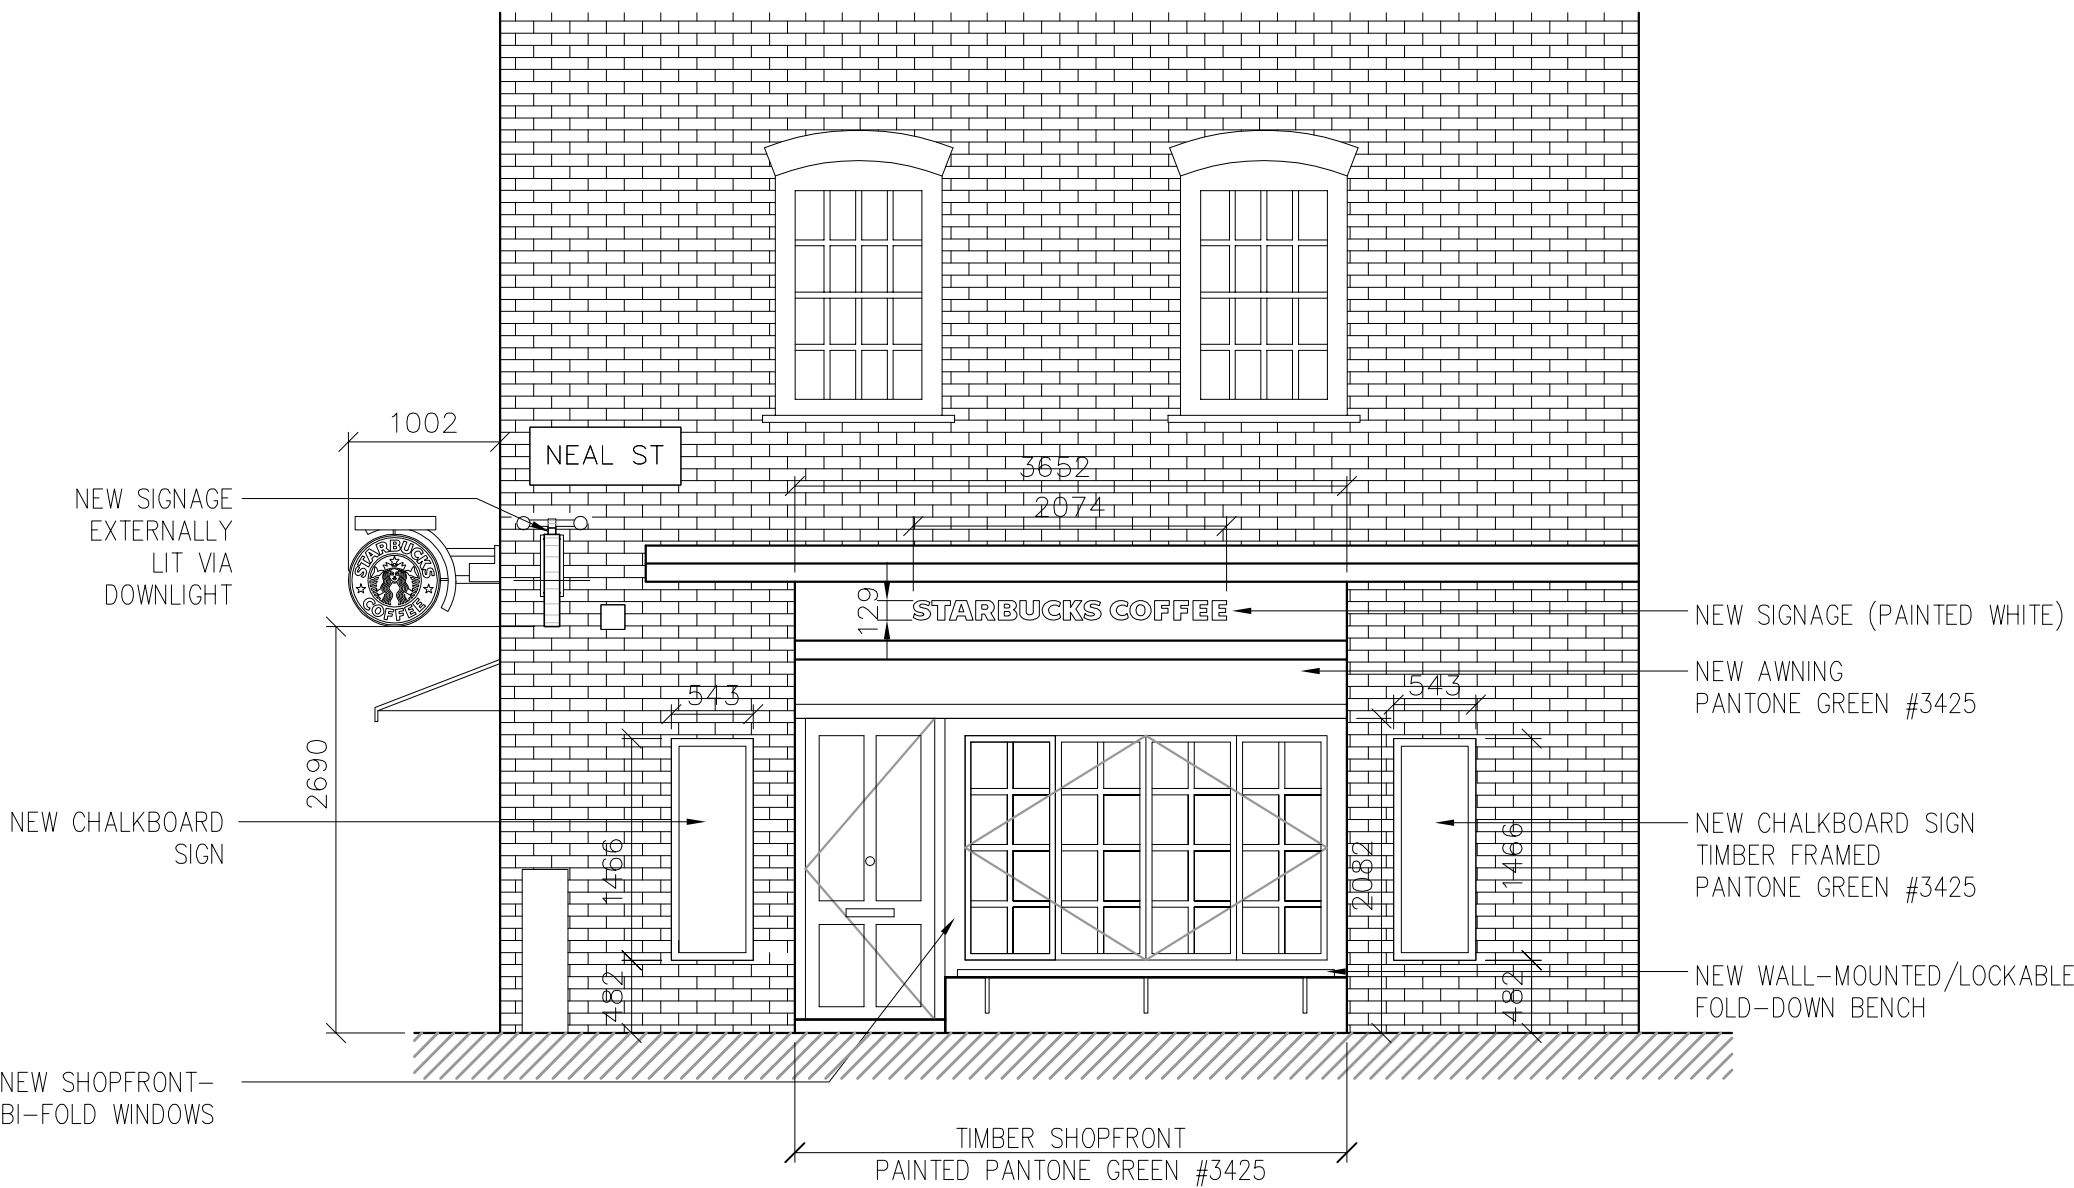


2 PROPOSED FRONT ELEVATION

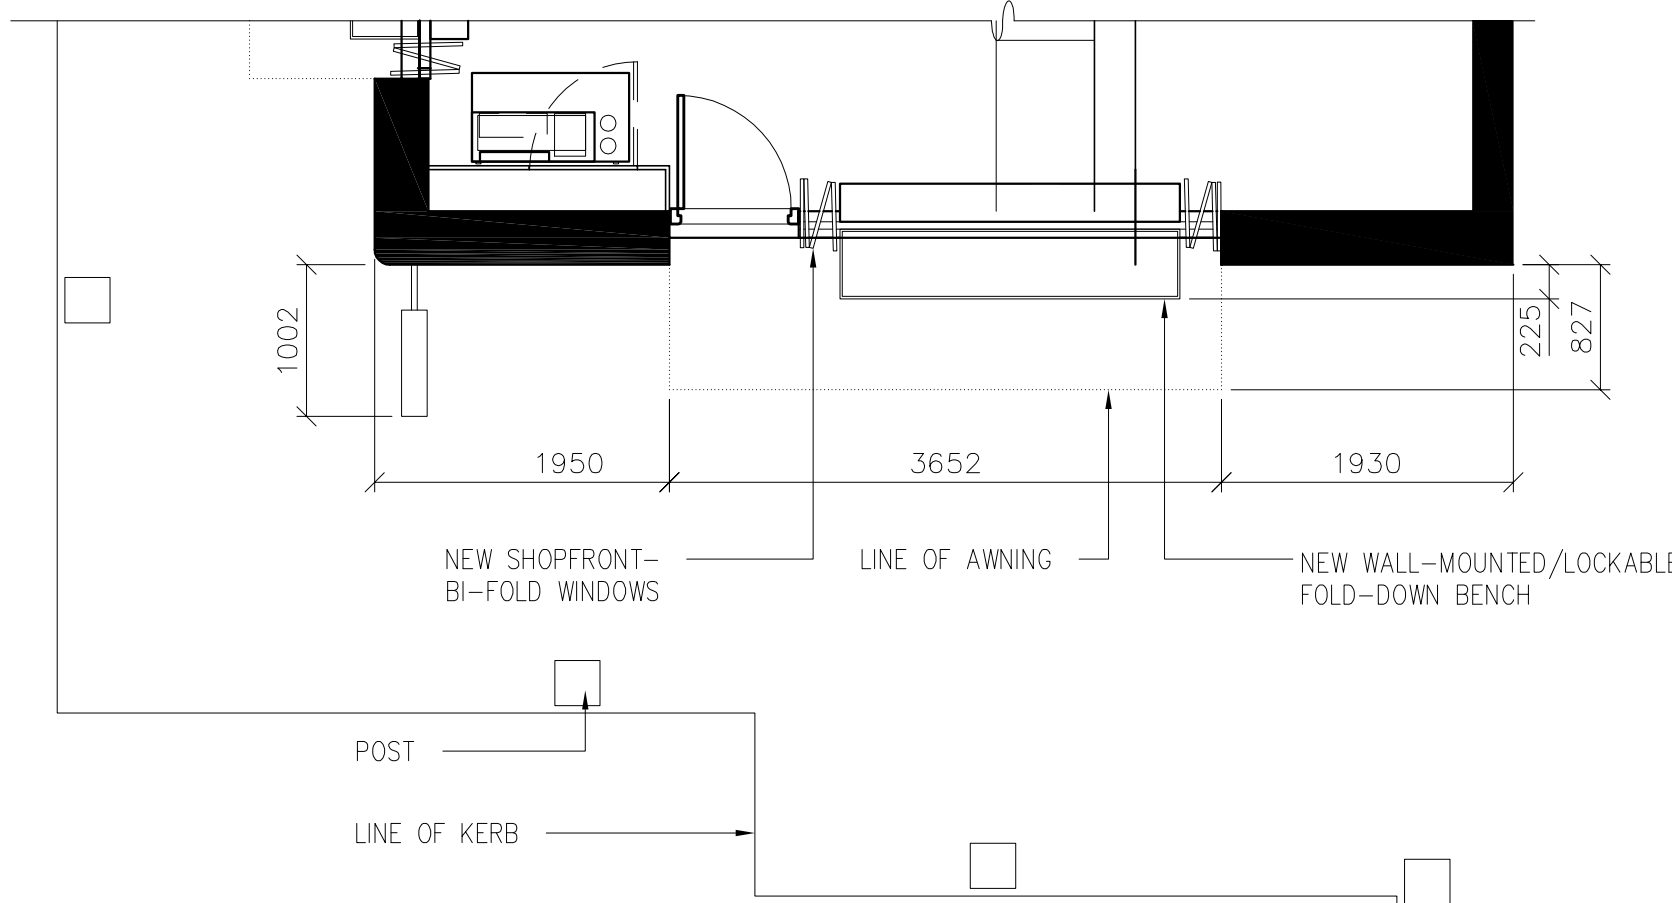

PROPOSED PARTIAL PLAN VIEW

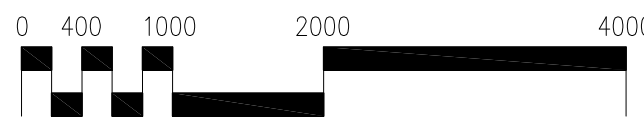

KEY PLAN NTS

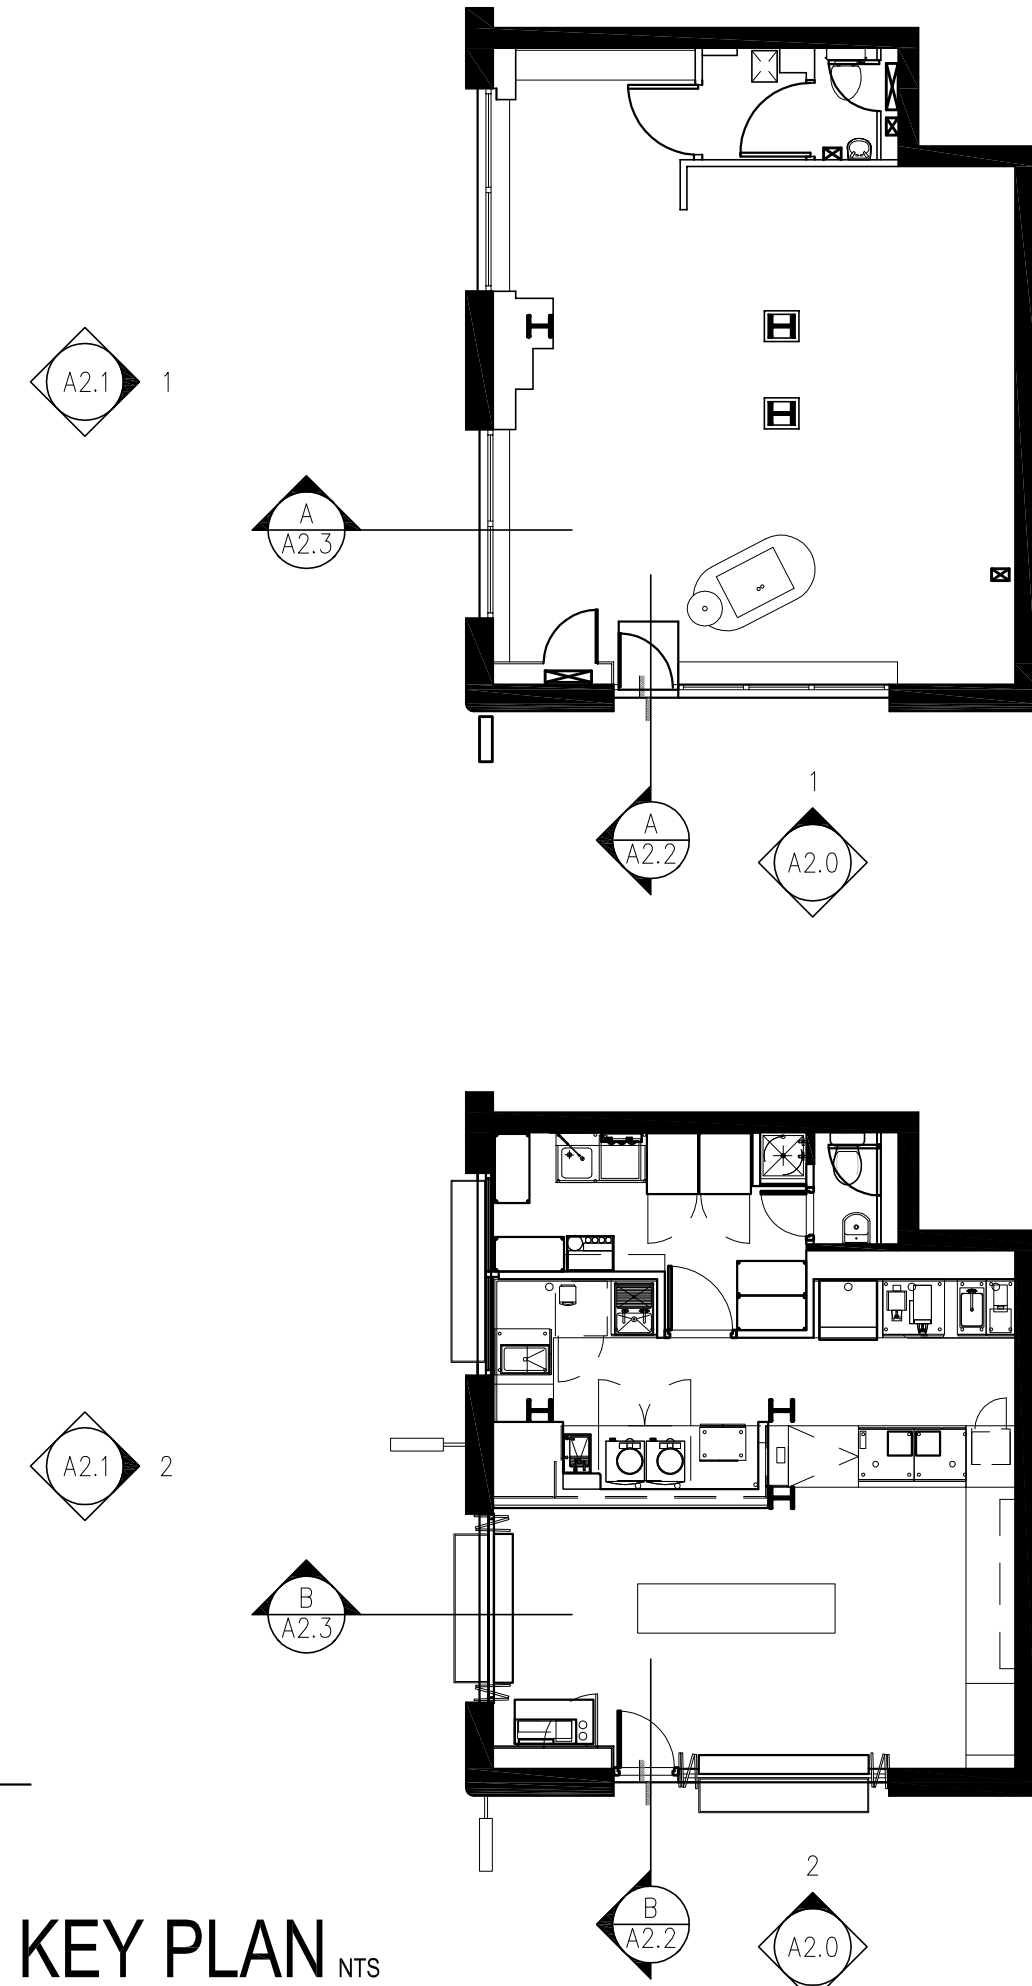

PAINT SCHEDULE:

NOTES:

- 1 GENERAL CONTRACTOR TO PERMIT, SUPPLY AND INSTALL SIGNAGE. SIGNAGE CONTRACTOR TO VERIFY SIGNAGE COMPLIANCE WITH LOCAL CODES AND OBTAIN PERMIT AND LANDLORD APPROVAL.
- 3 GENERAL CONTRACTOR SHALL COORDINATE WITH ELECTRICAL CONTRACTOR TO FURNISH AND INSTALL ELECTRICAL CIRCUIT INCLUDING ALL CONDUIT, WIRE, CONNECTIONS, AND BREAKER AT PANELBOARD NECESSARY TO SERVE SIGNAGE
- 4 SIGNAGE CONTRACTOR TO SUPPLY SHOP DRAWINGS TO STARBUCKS CONSTRUCTION MANAGER AND THE GENERAL CONTRACTOR AS NEEDED. NOTIFY STARBUCKS CONSTRUCTION MANAGER IMMEDIATELY IF SHOP DRAWINGS OR INSTALLATION IS IN DISCREPANCY WITH STARBUCKS ARCHITECTURAL DRAWINGS.
- 5 GENERAL CONTRACTOR TO COORDINATE AND SCHEDULE SIGNAGE INSTALLATION WITH THE SIGNAGE CONTRACTOR. STARBUCKS CONSTRUCTION MANAGER TO PROVIDE GENERAL CONTRACTOR WITH SIGNAGE CONTRACTOR CONTACT INFORMATION.
- 6 GENERAL CONTRACTOR TO PROVIDE FIRE TREATED WOOD STUD BLOCKING, OR EQUIVALENT TO SUPPORT SIGNAGE.



**STARBUCKS
COFFEE COMPANY**
2401 UTAH AVENUE SOUTH
SEATTLE, WASHINGTON 98134
(206) 318-1575

THESE PLANS AND SPECIFICATIONS, AS WELL AS STARBUCKS' NAME AND LOGO, TRADEMARKS AND DESIGNS ARE THE EXCLUSIVE PROPERTY OF STARBUCKS CORPORATION. ANY REPRODUCTION, MODIFICATION, DISCLOSURE AND/OR USE OF THESE MATERIALS (OR ANY PORTION OF THEM) WITHOUT STARBUCKS' PRIOR WRITTEN CONSENT IS STRICTLY PROHIBITED.

S DRAWING HAS BEEN REVIEWED, AND WHERE REQUIRED, BY EVOLVE (DESIGN) LIMITED, TO COMPLY WITH THE CURRENT CDM REGULATIONS (CONSTRUCTION DESIGN MANAGEMENT) 13. EVOLVE (DESIGN) LIMITED ARE EMPLOYED BY STARBUCKS COFFEE COMPANY UK AS COMPETENT 'DESIGNERS' AS REQUIRED IN THE ABOVE MENTIONED REGULATIONS.

S DRAWING HAS ALSO BEEN REVIEWED, AND WHERE
REQUIRED, UPDATED, TO COMPLY WITH BUILDING
REGULATIONS PART A TO PART P

OLVE (DESIGN) LIMITED, SUITE No.6, No.1 WEST STREET,
NEWELL, NORTH SOMERSET, UK. BS29 6DA
0044(0)1934 822764 F. 0044(0)1934 822764

REGISTERED IN ENGLAND NO.04164628
REGISTERED OFFICE: CHARTERHOUSE, 3 BEAONSFIELD
ROAD, WESTON S MARE, Nr.BRISTOL BS23 1YE

REV	DATE	PD	DESCRIPTION
-----	------	----	-------------

SIGNAGE SCHEDULE


SIGNAGE SCHEDULE

ITEM#	QTY	DESCRIPTION
-------	-----	-------------

ADDITIONAL ITEMS

[illegible]


1 EXISTING SIDE ELEVATION

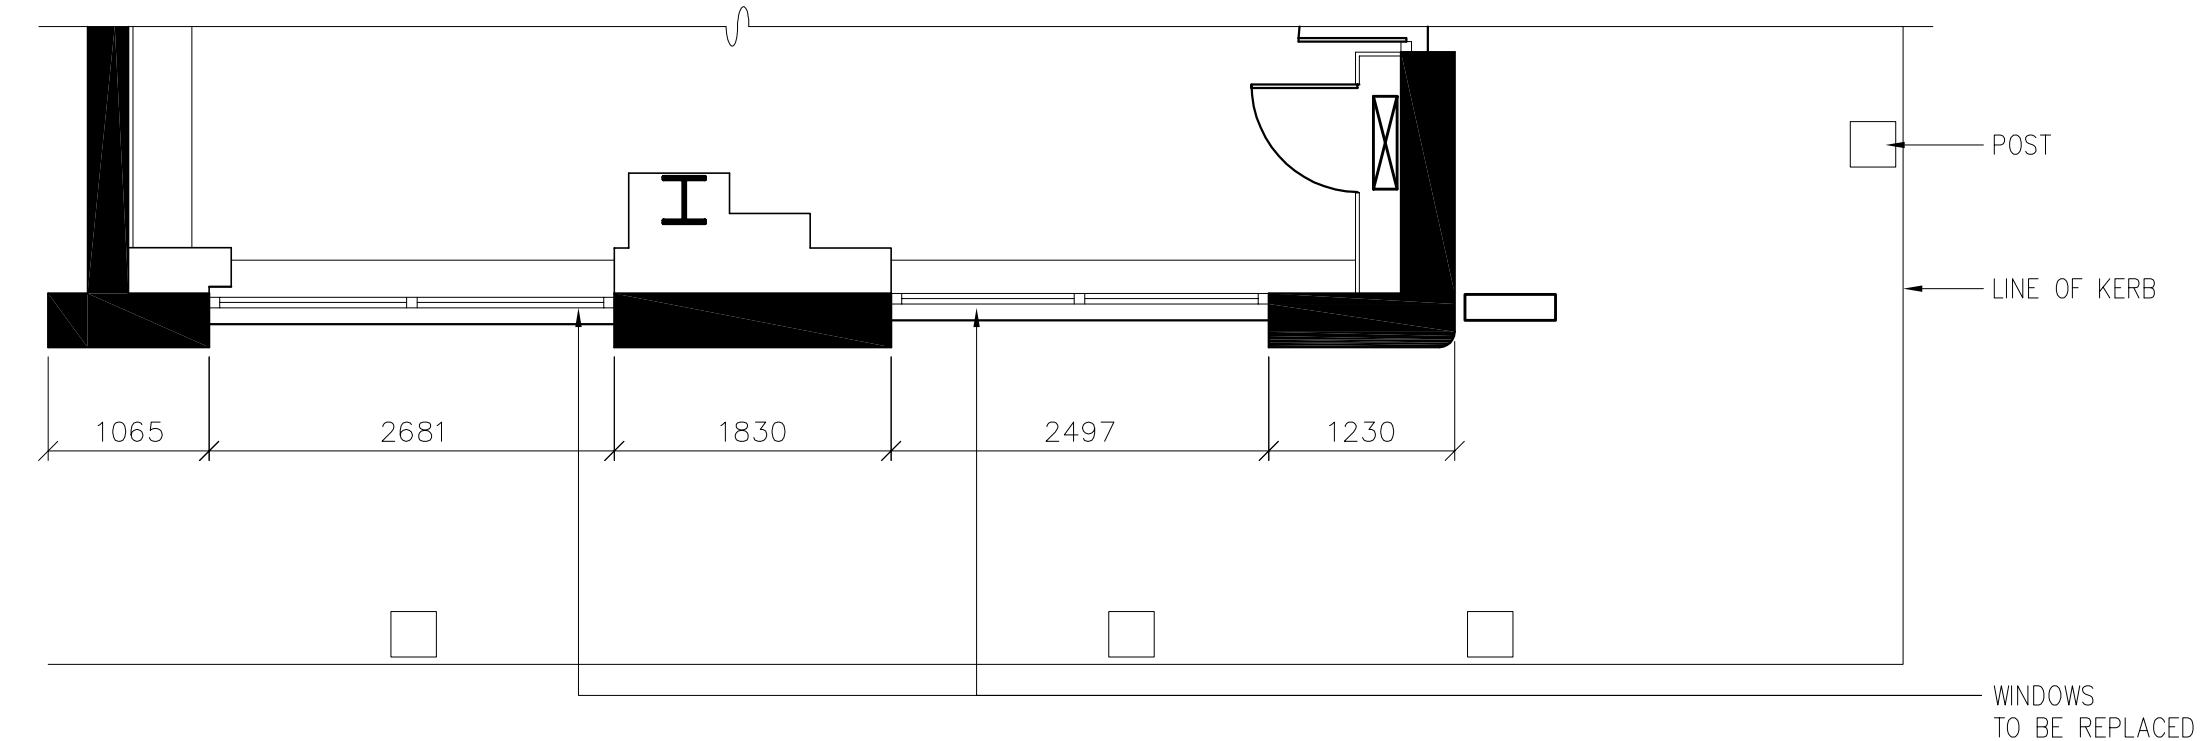


EXISTING PARTIAL PLAN VIEW



2 PROPOSED SIDE ELEVATION

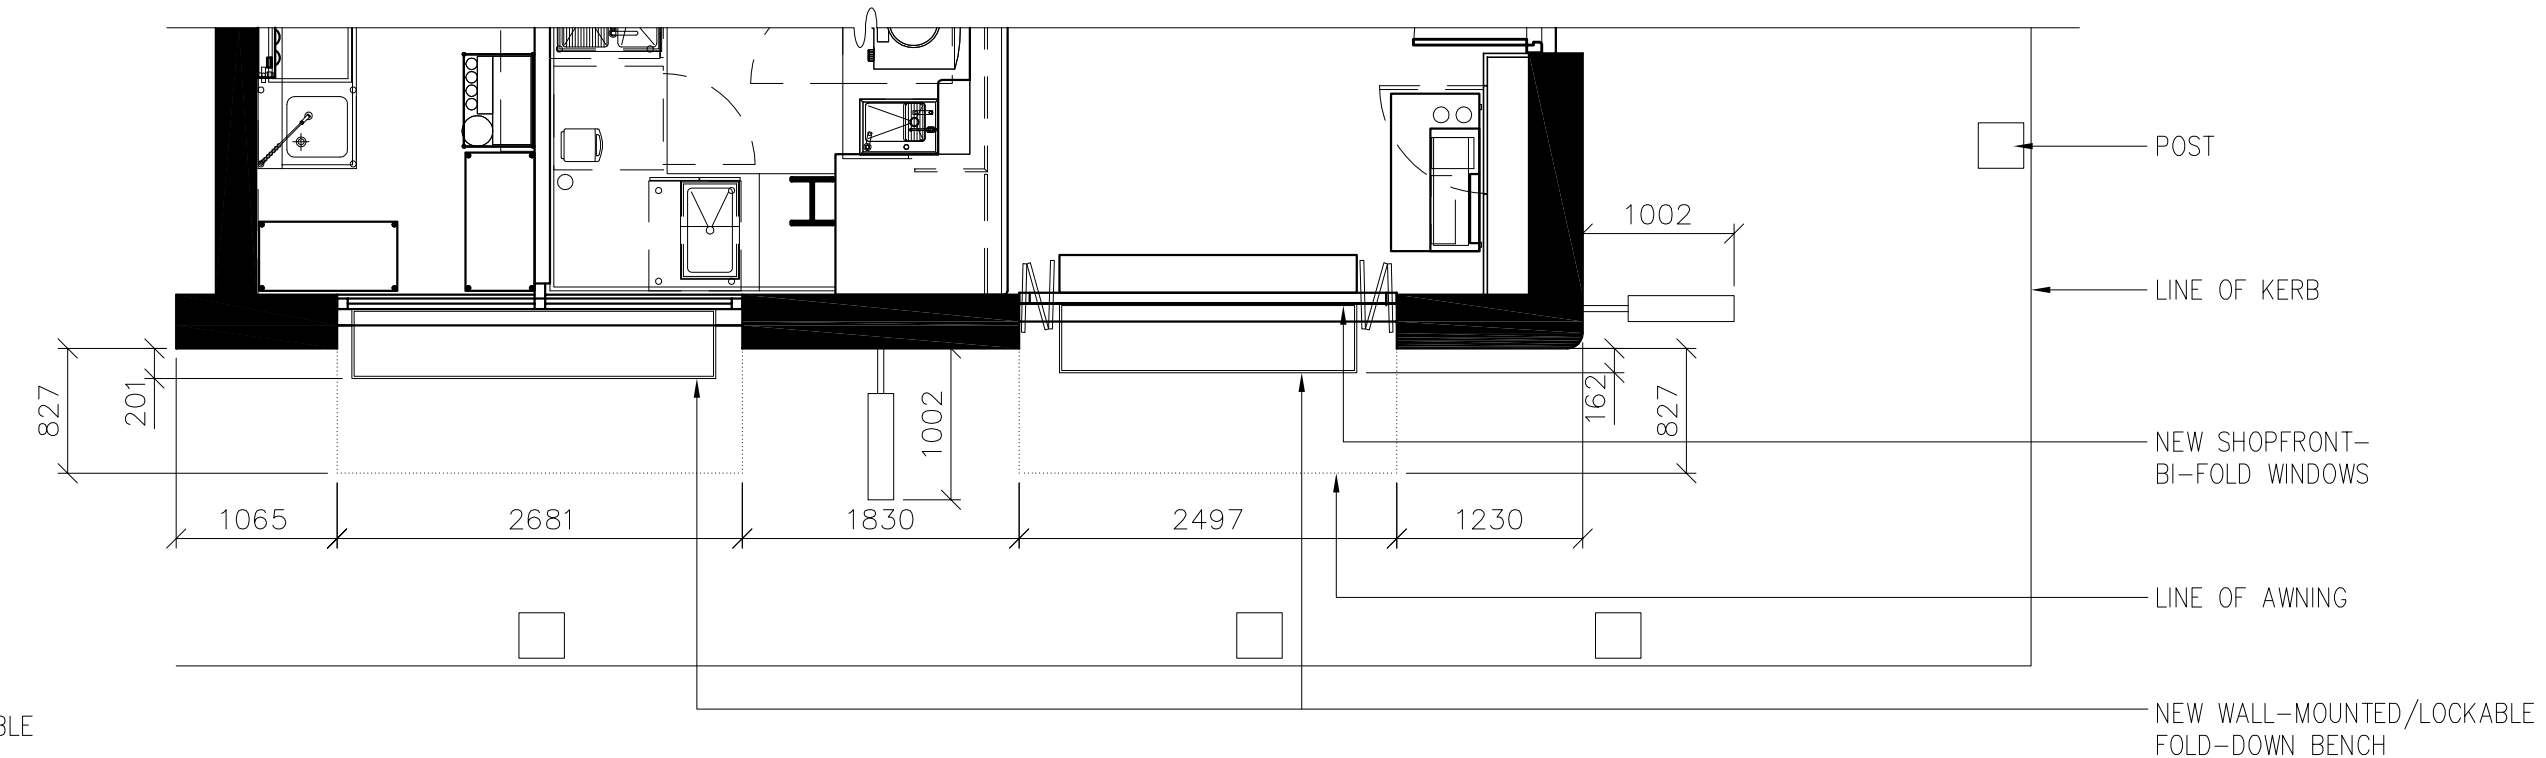

PROPOSED PARTIAL PLAN VIEW

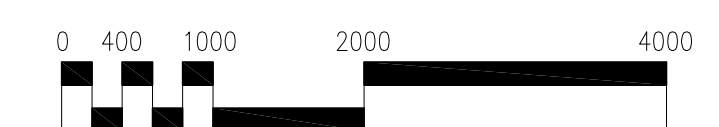

CONCEPTUAL DESIGN DRAWINGS ONLY - NOT INTENDED FOR CONSTRUCTION

PROJECT: **NEAL STREET**
42 NEAL STREET
LONDON WC2H 9PS
COUNTRY: **ENGLAND**


STORE #: 14941
PROJECT #: 52597-001
CONCEPT:
PALETTE: ARTISAN
ISSUE DATE: 06/10/10
DM: HM
PD: EVOLVE
CHECKED: TB

SHEET TITLE


**STOREFRONT
ELEVATIONS &
SIGNAGE**

SCALE: 1:50 @ A1

SHEET NUMBER **A2.1**

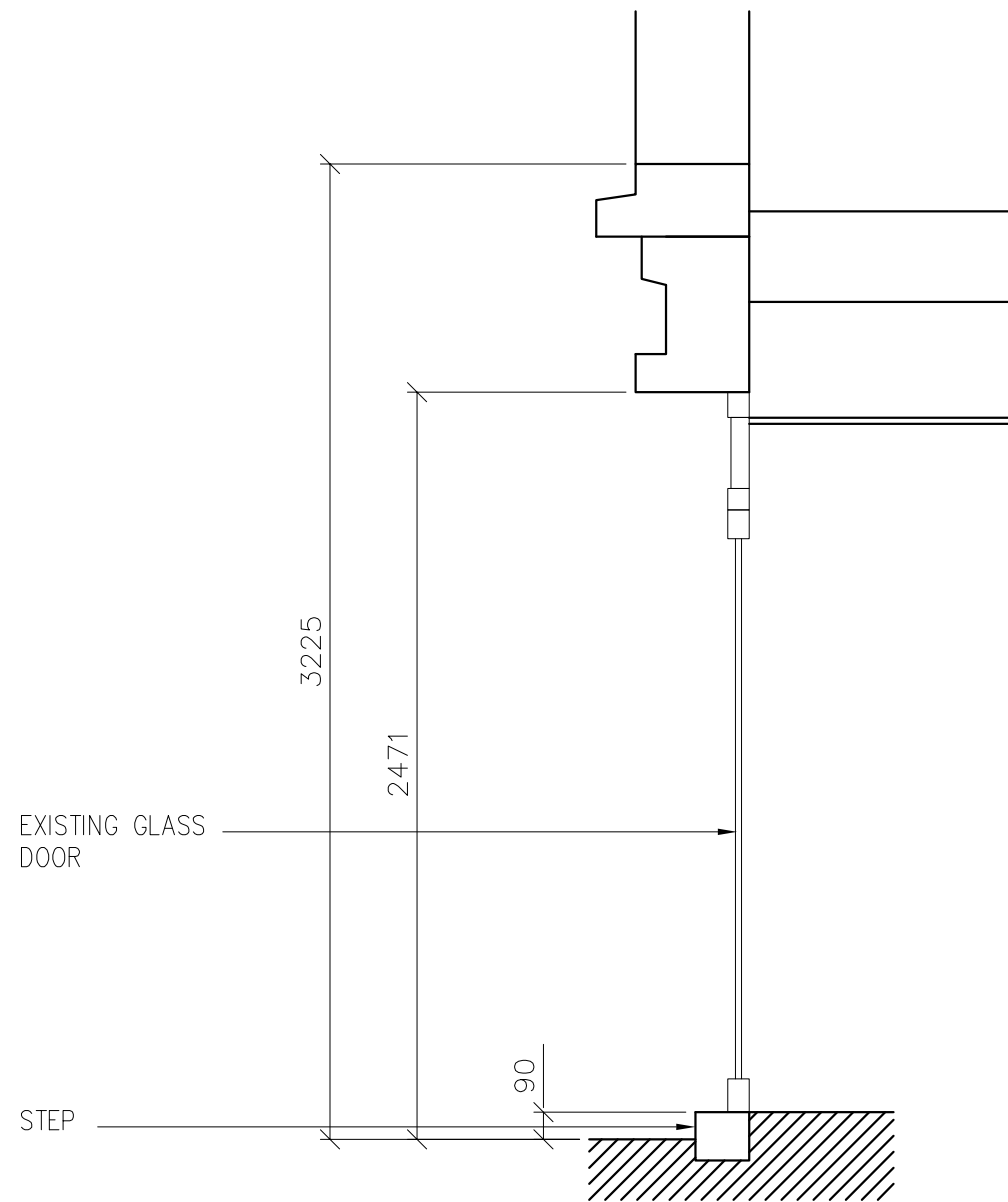

A EXISTING SHOPFRONT SECTION

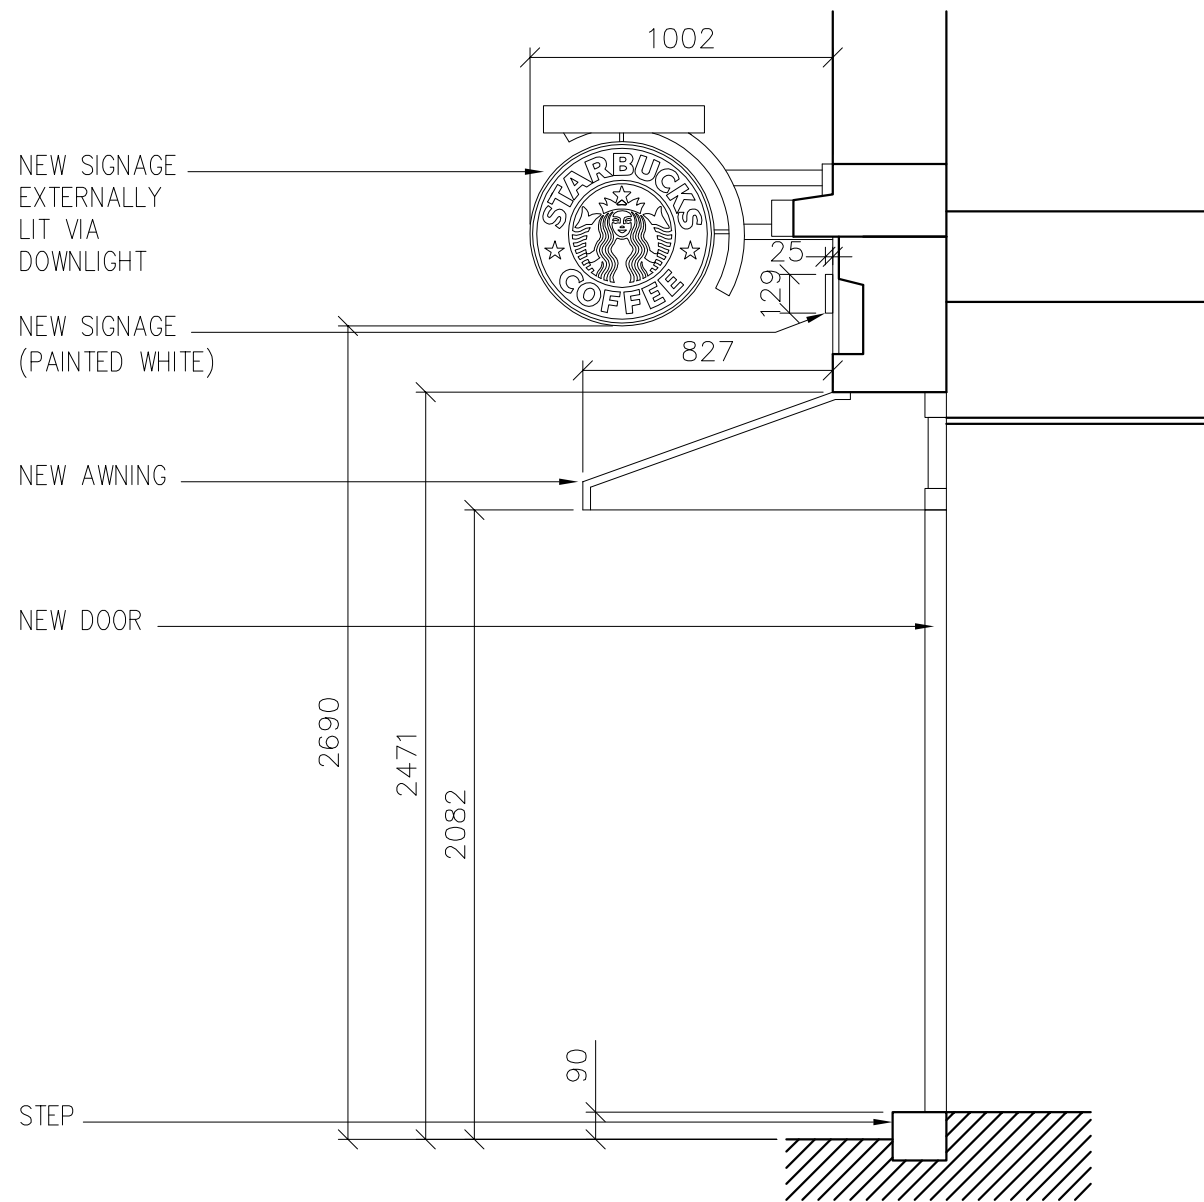

B PROPOSED SHOPFRONT SECTION



STARBUCKS
COFFEE COMPANY (UK)
BUILDING 4 CHISWICK PARK
566 CHISWICK HIGH ROAD
LONDON W4 5YE

THESE PLANS AND SPECIFICATIONS, AS WELL AS STARBUCKS' NAME AND LOGO, TRADEMARKS AND DESIGNS ARE THE EXCLUSIVE PROPERTY OF STARBUCKS CORPORATION. ANY REPRODUCTION, MODIFICATION, DISCLOSURE AND/OR USE OF THESE MATERIALS (OR ANY PORTION OF THEM) WITHOUT STARBUCKS' PRIOR WRITTEN CONSENT IS STRICTLY PROHIBITED.

THIS DRAWING HAS BEEN REVIEWED, AND WHERE REQUIRED, UPDATED, BY EVOLVE (DESIGN) LIMITED, TO COMPLY WITH THE CURRENT COM REGULATIONS (CONSTRUCTION DESIGN & MANAGEMENT) 13. EVOLVE (DESIGN) LIMITED ARE EMPLOYED BY STARBUCKS COFFEE COMPANY UK AS COMPETENT 'DESIGNERS' AS REQUIRED IN THE ABOVE MENTIONED REGULATIONS.

THIS DRAWING HAS ALSO BEEN REVIEWED, AND WHERE REQUIRED, UPDATED, TO COMPLY WITH BUILDING REGULATIONS PART A TO PART P

EVOLVE (DESIGN) LIMITED, SUITE No.6, No.1 WEST STREET, BANWELL, NORTH SOMERSET, UK, BS29 6DA
T: 0044(0)1934 822764 F: 0044(0)1934 822764

REGISTERED IN ENGLAND NO.04164628
REGISTERED OFFICE: CHARTERHOUSE, 3 BEACONSFIELD ROAD, WESTON S MARE, IV BRISTOL, BS23 1YE

REV DATE PD DESCRIPTION

STARBUCKS COFFEE
PROJECT: 42 NEAL STREET
LONDON WC2H 9PS
COUNTRY: ENGLAND


STORE #: 14941
PROJECT #: 52597-001
CONCEPT:
PALETTE: ARTISAN
ISSUE DATE: 08/10/10
DM: HM
PD: EVOLVE
CHECKED: TB

SHEET TITLE
STOREFRONT
SECTIONS


SCALE: 1:25 @ A2

SHEET NUMBER
A2.2

CONCEPTUAL DESIGN DRAWINGS ONLY – NOT INTENDED FOR CONSTRUCTION

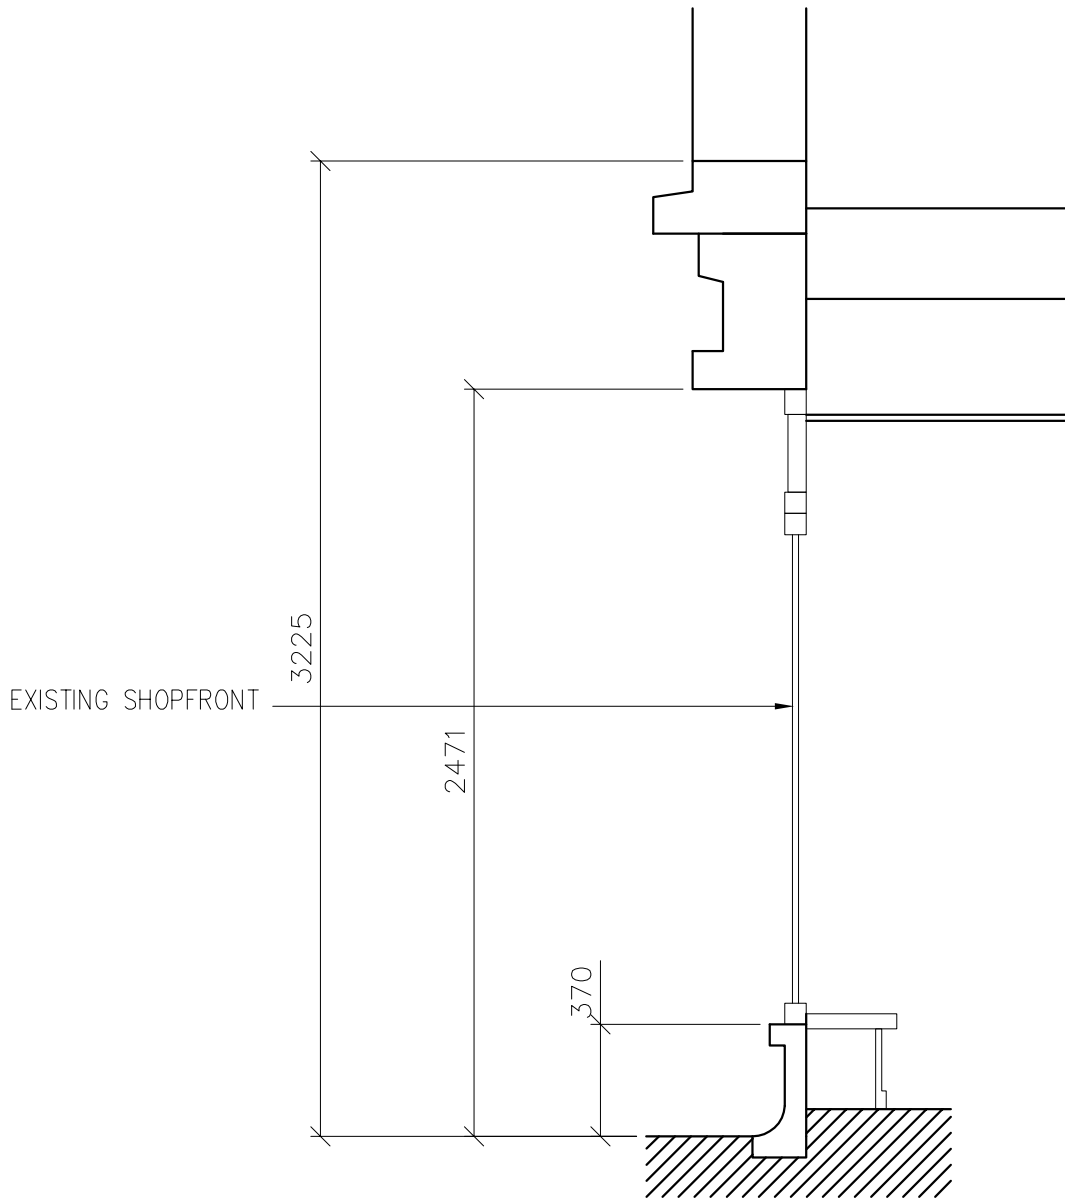

A EXISTING SHOPFRONT SECTION

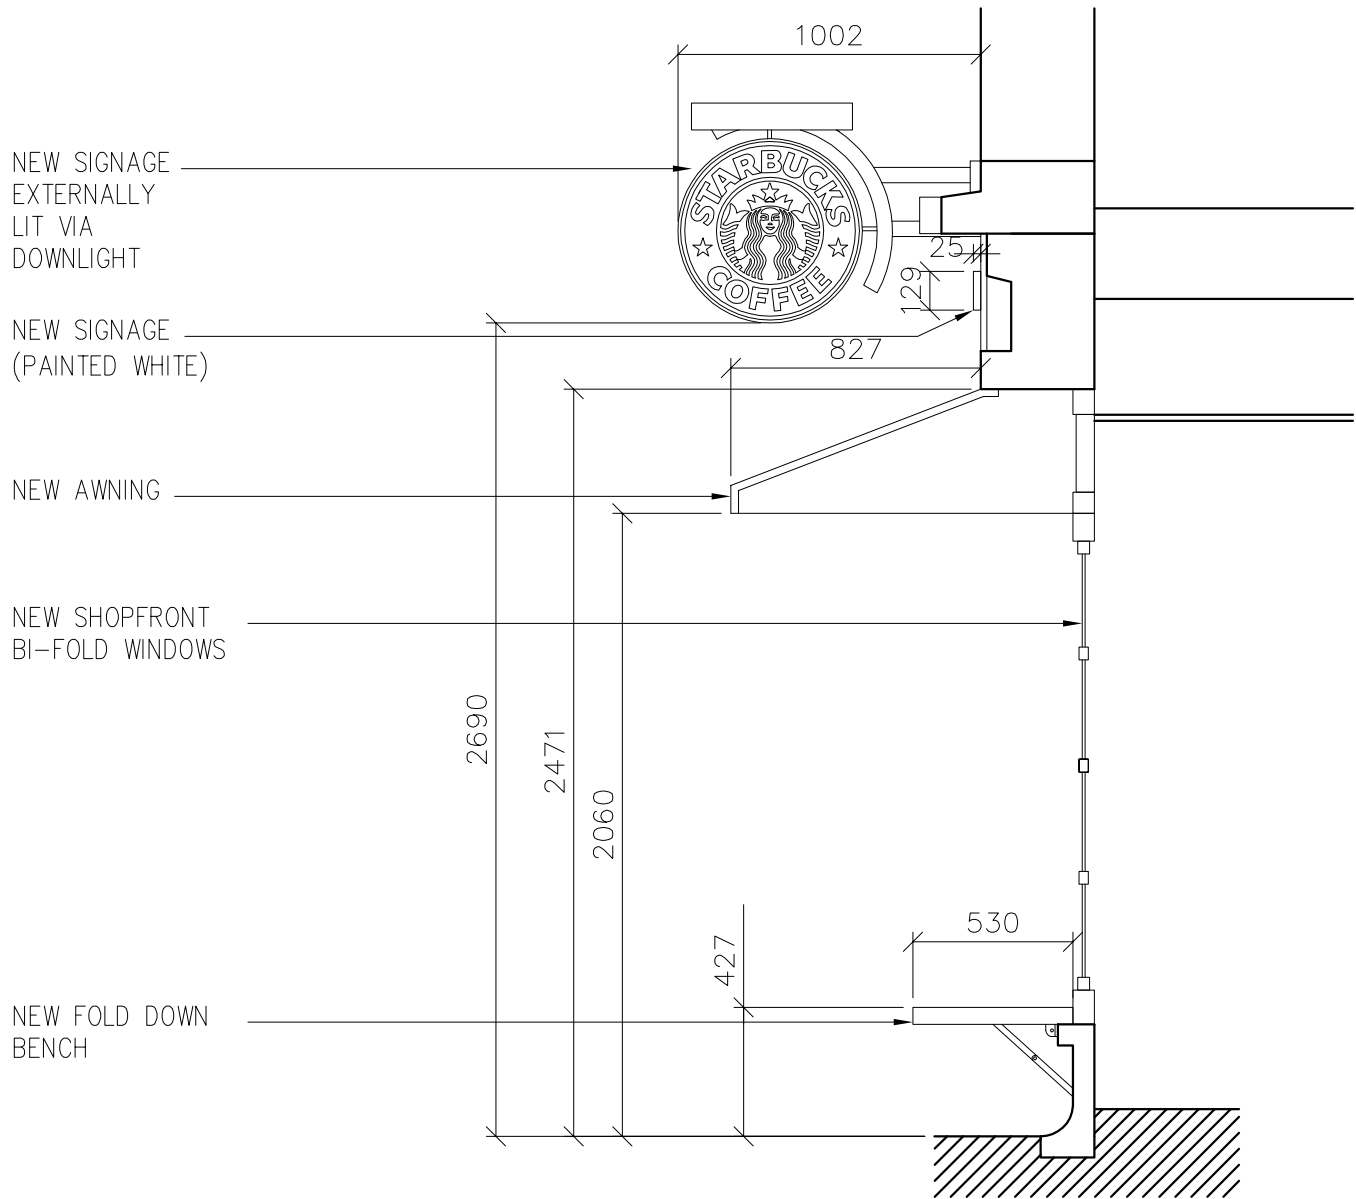

B PROPOSED SHOPFRONT SECTION



STARBUCKS
COFFEE COMPANY (UK)
BUILDING 4 CHISWICK PARK
566 CHISWICK HIGH ROAD
LONDON W4 5YE

THESE PLANS AND SPECIFICATIONS, AS WELL AS STARBUCKS' NAME AND LOGO, TRADEMARKS AND DESIGNS ARE THE EXCLUSIVE PROPERTY OF STARBUCKS CORPORATION. ANY REPRODUCTION, MODIFICATION, DISCLOSURE AND/OR USE OF THESE MATERIALS (OR ANY PORTION OF THEM) WITHOUT STARBUCKS' PRIOR WRITTEN CONSENT IS STRICTLY PROHIBITED.

THIS DRAWING HAS BEEN REVIEWED, AND WHERE REQUIRED, UPDATED, BY EVOLVE (DESIGN) LIMITED, TO COMPLY WITH THE CURRENT COM REGULATIONS (CONSTRUCTION DESIGN & MANAGEMENT) 13. EVOLVE (DESIGN) LIMITED ARE EMPLOYED BY STARBUCKS COFFEE COMPANY UK AS COMPETENT 'DESIGNERS' AS REQUIRED IN THE ABOVE MENTIONED REGULATIONS.

THIS DRAWING HAS ALSO BEEN REVIEWED, AND WHERE REQUIRED, UPDATED, TO COMPLY WITH BUILDING REGULATIONS PART A TO PART P

EVOLVE (DESIGN) LIMITED, SUITE No.6, No.1 WEST STREET, BANWELL, NORTH SOMERSET, UK. BS29 6DA
T: 0044(0)1934 822764 F: 0044(0)1934 822764

REGISTERED IN ENGLAND NO.04164628
REGISTERED OFFICE: CHARTERHOUSE, 3 BEACONSFIELD ROAD, WESTON S MARE, WYBRISTOL, BS23 1YE

REV	DATE	PD	DESCRIPTION

STARBUCKS COFFEE

PROJECT: **42 NEAL STREET**
LONDON WC2H 9PS

COUNTRY: **ENGLAND**


STORE #: 14941
PROJECT #: 52597-001

CONCEPT: ARTISAN
ISSUE DATE: 08/10/10
DM: HM
PD: EVOLVE
CHECKED: TB


SHEET TITLE
STOREFRONT SECTIONS

SCALE: 1:25 @ A2

SHEET NUMBER
A2.3

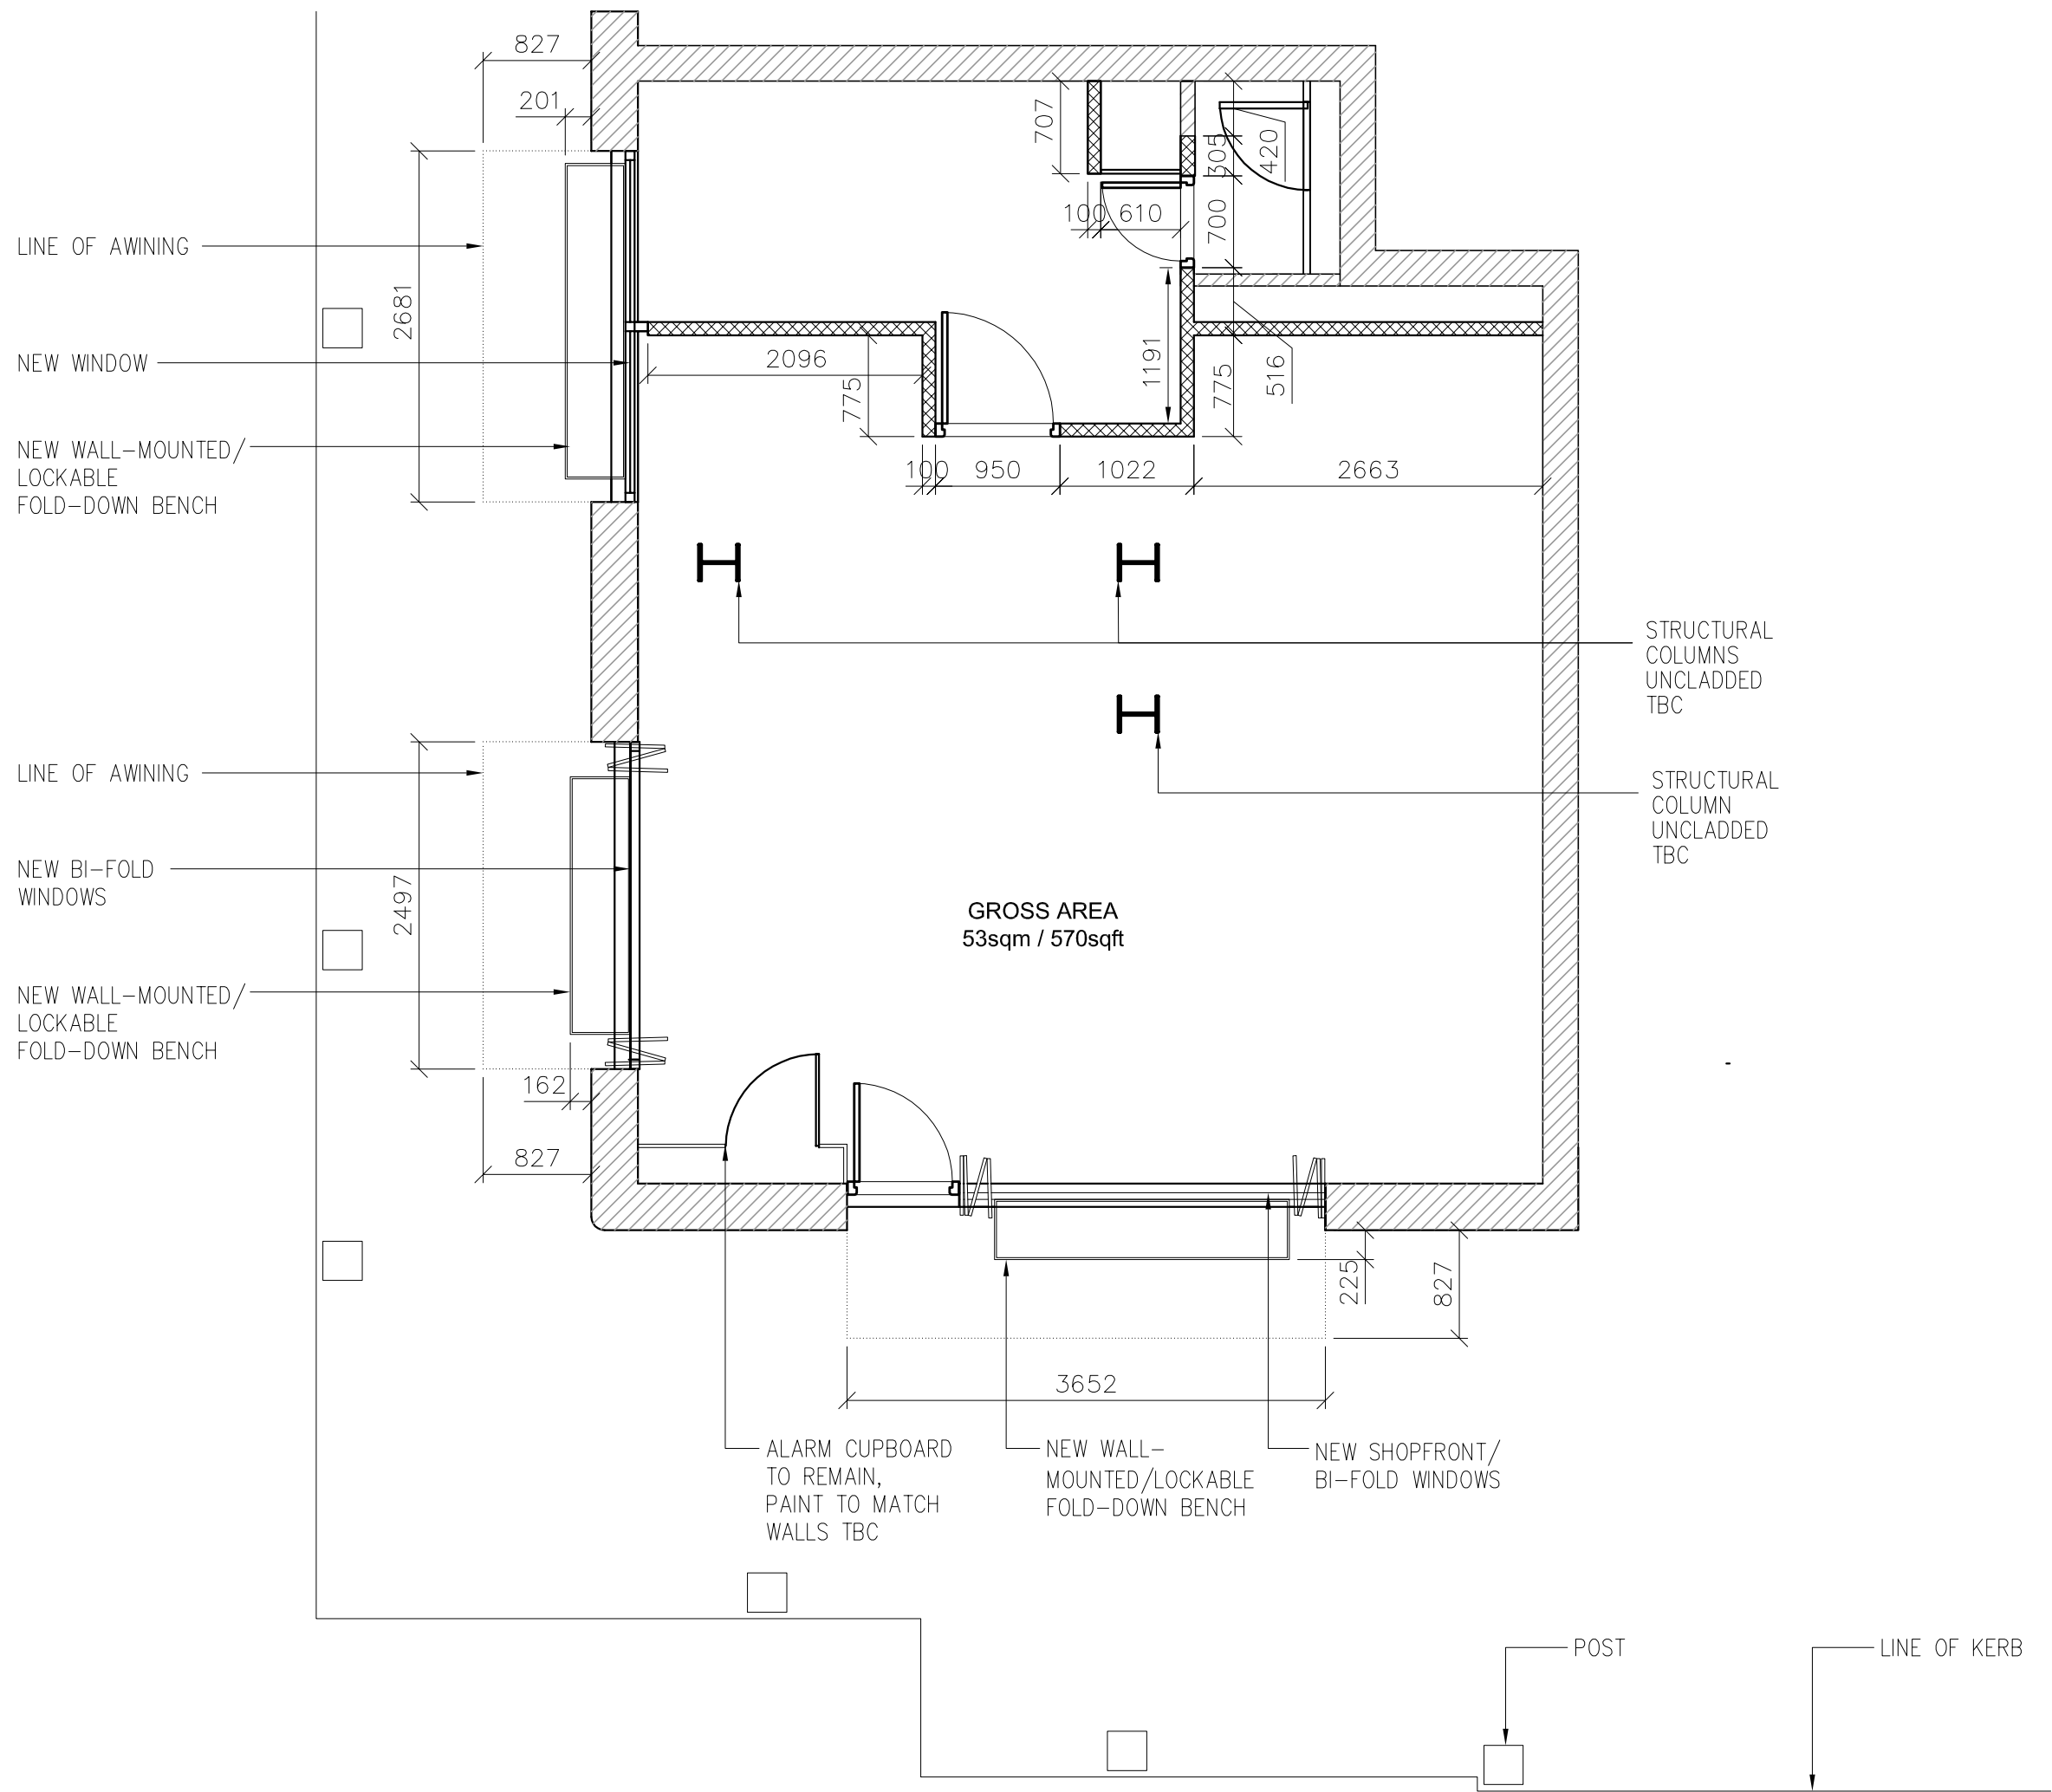

PROPOSED FLOOR PLAN

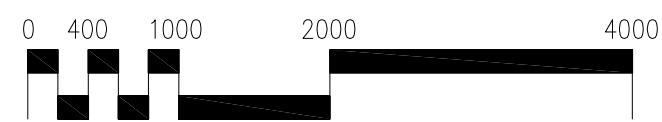

WALL LEGEND:

- EXISTING WALL
- NEW FULL HEIGHT STUD PARTITION WALL

NOTES:

- GENERAL CONTRACTOR TO VERIFY ALL DIMENSIONS AND NOTIFY STARBUCKS CONSTRUCTION MANAGER OF ANY DISCREPANCIES PRIOR TO CONSTRUCTION. ALL DIMENSIONS TO BE TAKEN FROM DESIGNATED DATUM POINT.
- IF EXISTING EXTERIOR ENTRANCE THRESHOLD EXCEEDS REQUIRED MAXIMUM HEIGHT, REMOVE AND REPLACE WITH ACCESSIBLE THRESHOLD. RAISED THRESHOLDS AND FLOOR LEVEL CHANGES AT ACCESSIBLE DOORWAYS TO BE BEVELED WITH A SLOPE NO GREATER THAN 1:12.
- GENERAL CONTRACTOR TO PROVIDE FIRE TREATED WOOD STUD BLOCKING, OR EQUIVALENT TO SUPPORT SIGNAGE.
- ALL DOORS TO PROVIDE 900mm MIN CLEAR OPENING WHEN OPENED TO 90 DEGREE POSITION UNLESS OTHERWISE NOTED.
-
- LANDLORD TO PROVIDE DOOR HARDWARE PER STARBUCKS' SPECIFICATIONS.
- VERIFY ALL EXISTING DOORS, HARDWARE AND FRAMES MEET STARBUCKS AND/OR CODE REQUIREMENTS.
- SEE REFLECTED CEILING PLAN AND SECTIONS AND DETAILS FOR OVERHEAD SOFFIT AND BULKHEAD WALL FRAMING.
- PLUMBING AND ELECTRICAL STUB-UPS. REFER TO PLUMBING PLAN & SCHEDULES AND ELECTRICAL PLAN & SCHEDULES FOR NOTES AND LOCATIONS.
- DESIGNATED ENTRY / EXIT FOR COVERAGE BY CCTV ALL DOORS TO BE USED FOR ENTRY & EXIT ARE TO BE CLEARLY DEFINED ON THE DRAWINGS
- ALL WALL FINISHES TO ACHIEVE CLASS 'O' SPREAD OF FLAME TO SATISFY BUILDING CONTROL & BAA REQUIREMENTS

CONCEPTUAL DESIGN DRAWINGS ONLY – NOT INTENDED FOR CONSTRUCTION



STARBUCKS
COFFEE COMPANY (UK)
BUILDING 4 CHISWICK PARK
566 CHISWICK HIGH ROAD
LONDON W4 5YE

THESE PLANS AND SPECIFICATIONS, AS WELL AS STARBUCKS' NAME AND LOGO, TRADEMARKS AND DESIGNS ARE THE EXCLUSIVE PROPERTY OF STARBUCKS CORPORATION. ANY REPRODUCTION, MODIFICATION, DISCLOSURE AND/OR USE OF THESE MATERIALS (OR ANY PORTION OF THEM) WITHOUT STARBUCKS' PRIOR WRITTEN CONSENT IS STRICTLY PROHIBITED.

THIS DRAWING HAS BEEN REVIEWED, AND WHERE REQUIRED, UPDATED, BY EVOLVE (DESIGN) LIMITED, TO COMPLY WITH THE CURRENT CDM REGULATIONS (CONSTRUCTION DESIGN & MANAGEMENT) 13. EVOLVE (DESIGN) LIMITED ARE EMPLOYED BY STARBUCKS COFFEE COMPANY UK AS COMPETENT 'DESIGNERS' AS REQUIRED IN THE ABOVE MENTIONED REGULATIONS.

THIS DRAWING HAS ALSO BEEN REVIEWED, AND WHERE REQUIRED, UPDATED, TO COMPLY WITH BUILDING REGULATIONS PART A TO PART P

EVOLVE (DESIGN) LIMITED, SUITE No.6, No.1 WEST STREET, BAYWELL, NORTH SOMERSET, UK, BS29 6DA
T: 0244001834 822764 F: 0244001834 822764

REGISTERED IN ENGLAND NO.04164628
REGISTERED OFFICE: CHARTERHOUSE, 3 BEACONSFIELD ROAD, WESTON S MARE, NR BRISTOL, BS23 1YE


REV DATE PD DESCRIPTION

STARBUCKS COFFEE
PROJECT: 42 NEAL STREET
LONDON WC2H 9PS
COUNTRY: ENGLAND


STORE #: 14941
PROJECT #: 52597-001
CONCEPT:
PALETTE: ARTISAN
ISSUE DATE: 08/10/10
DM: HM
PD: EVOLVE
CHECKED: TB

SHEET TITLE
PROPOSED
FLOOR
PLAN
SCALE: 1:50 @ A2

SHEET NUMBER
A3.1

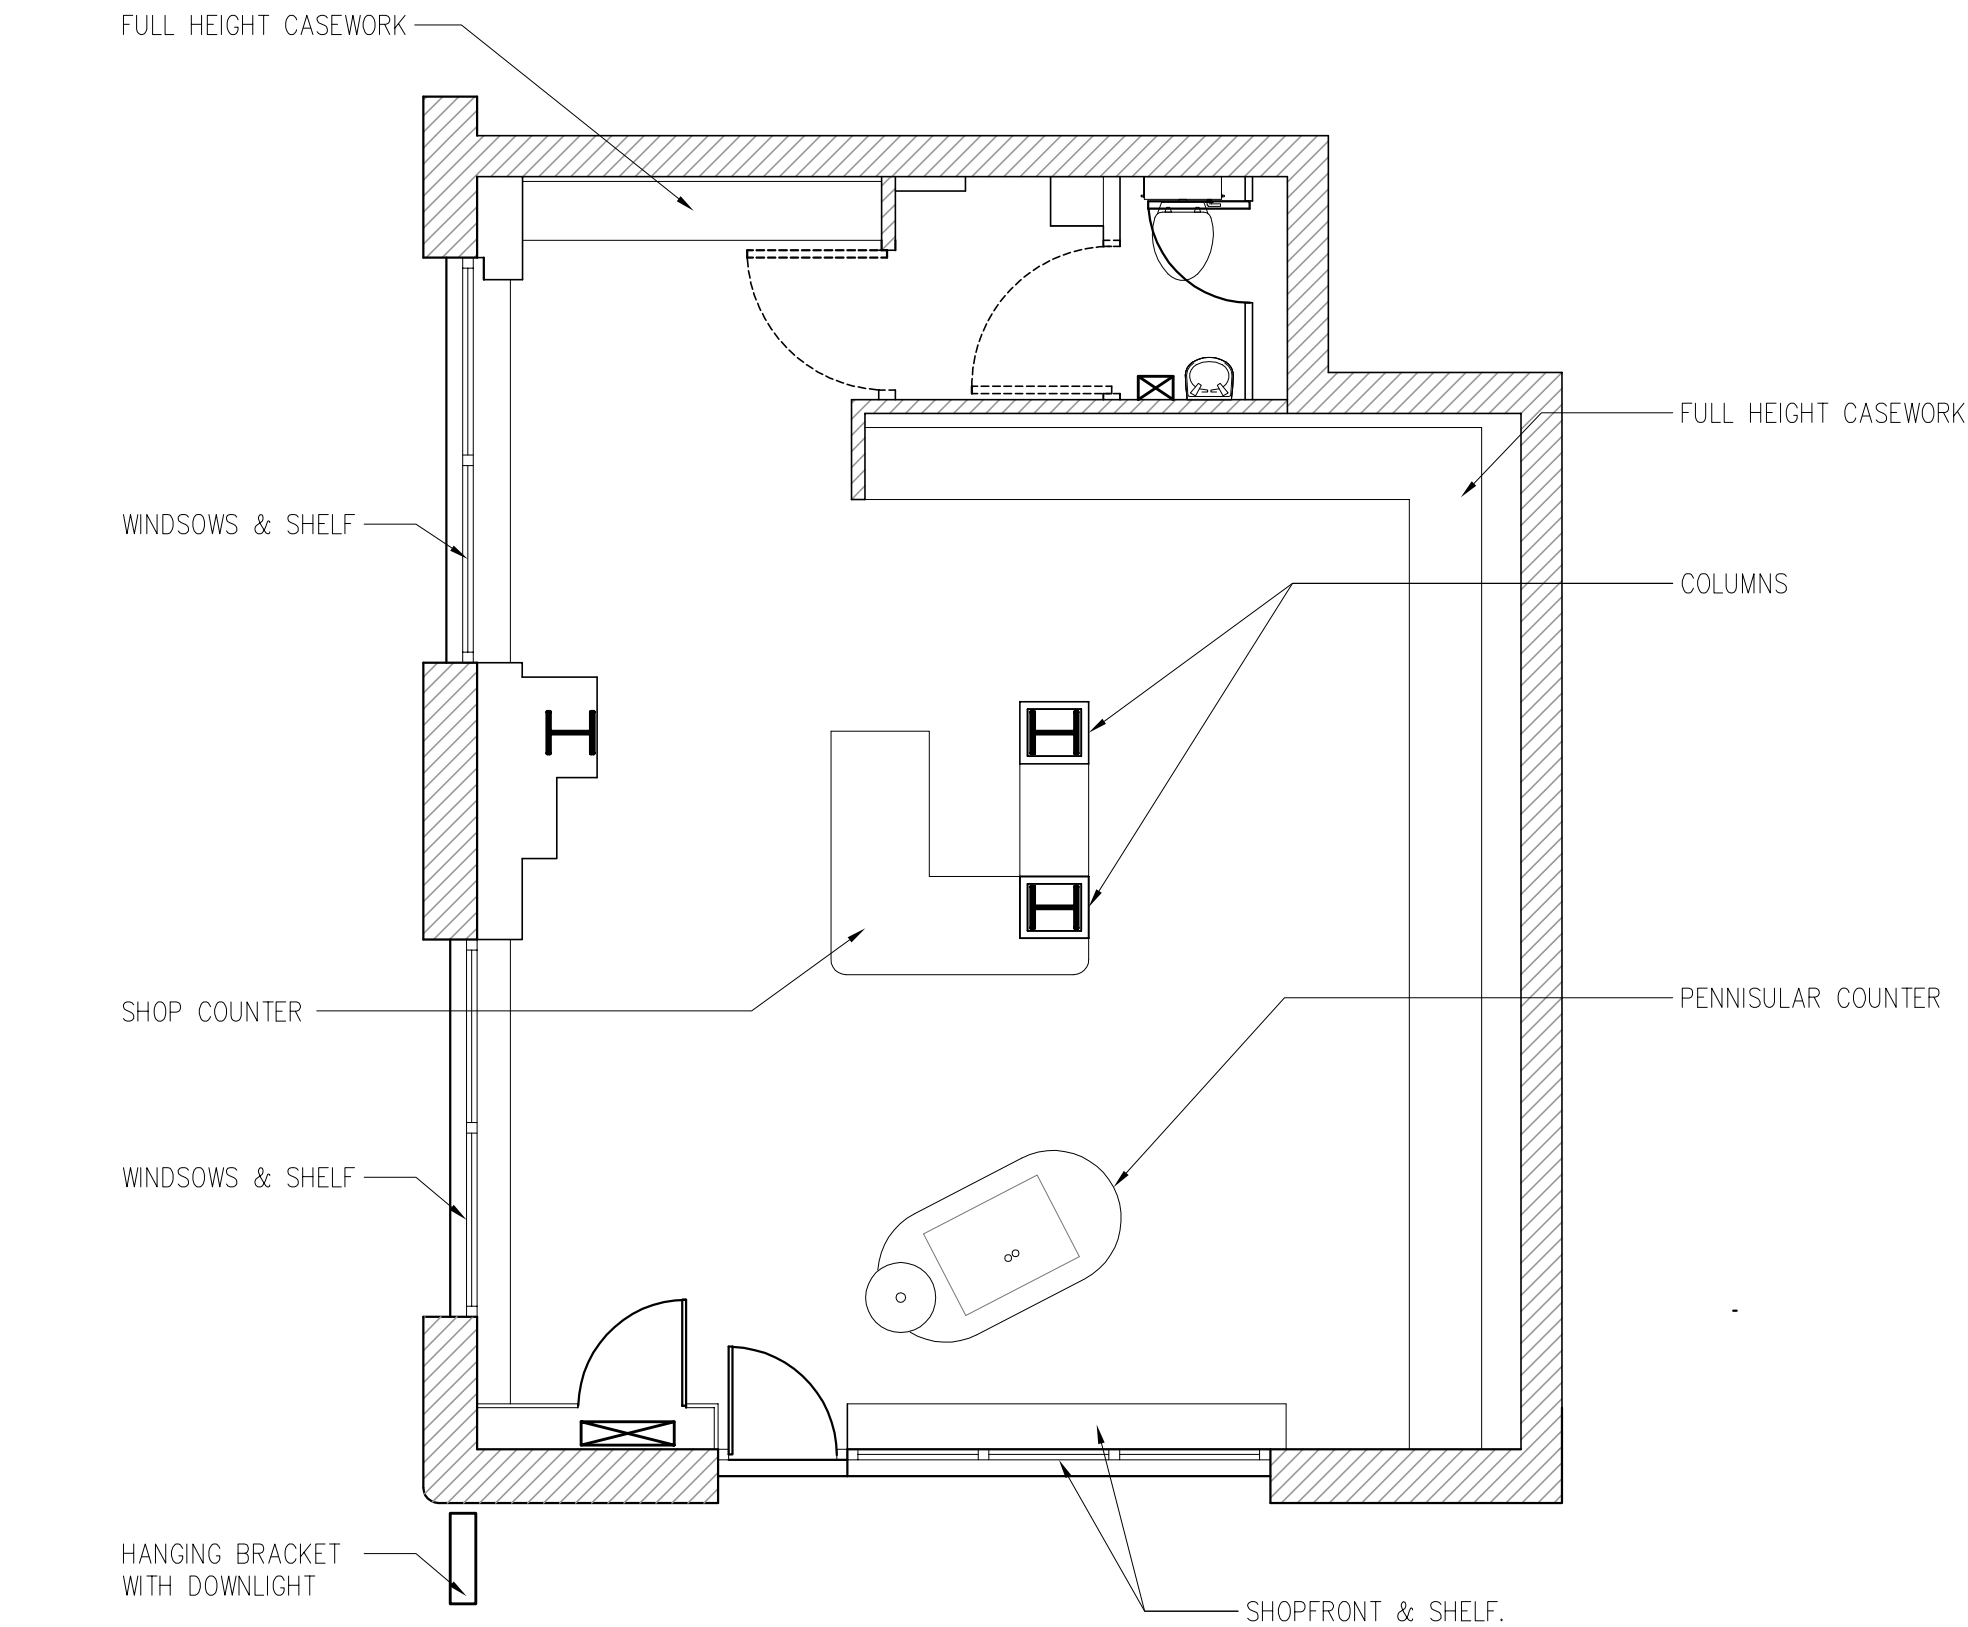

EXISTING FLOOR PLAN

 

STARBUCKS
COFFEE COMPANY (UK)
BUILDING 4 CHISWICK PARK
566 CHISWICK HIGH ROAD
LONDON W4 5YE

THESE PLANS AND SPECIFICATIONS, AS WELL AS STARBUCKS' NAME AND LOGO, TRADEMARKS AND DESIGNS ARE THE EXCLUSIVE PROPERTY OF STARBUCKS CORPORATION. ANY REPRODUCTION, MODIFICATION, DISCLOSURE AND/OR USE OF THESE MATERIALS (OR ANY PORTION OF THEM) WITHOUT STARBUCKS' PRIOR WRITTEN CONSENT IS STRICTLY PROHIBITED.

THIS DRAWING HAS BEEN REVIEWED, AND WHERE REQUIRED, UPDATED, BY EVOLVE (DESIGN) LIMITED, TO COMPLY WITH THE CURRENT CDM REGULATIONS (CONSTRUCTION DESIGN & MANAGEMENT) 13. EVOLVE (DESIGN) LIMITED ARE EMPLOYED BY STARBUCKS COFFEE COMPANY UK AS COMPETENT 'DESIGNERS' AS REQUIRED IN THE ABOVE MENTIONED REGULATIONS.

THIS DRAWING HAS ALSO BEEN REVIEWED, AND WHERE REQUIRED, UPDATED, TO COMPLY WITH BUILDING REGULATIONS PART A TO PART P

EVOLVE (DESIGN) LIMITED, SUITE No.6, No.1 WEST STREET, BAYWELL, NORTH SOMERSET, UK, BS29 6DA
T: 0344(0)1834 822764 F: 0344(0)1834 822764

REGISTERED IN ENGLAND NO.04164628
REGISTERED OFFICE: CHARTERHOUSE, 3 BEACONSFIELD ROAD, WESTON S MARE, W. BRISTOL, BS23 1YE

REV DATE	PD DESCRIPTION
----------	----------------

STARBUCKS COFFEE
PROJECT: 42 NEAL STREET
LONDON WC2H 9PS
COUNTRY: ENGLAND

STORE #: 14941
PROJECT #: 52597-001
CONCEPT: ARTISAN
ISSUE DATE: 08/10/10
DM: HM
PD: EVOLVE
CHECKED: TB

SHEET TITLE
EXISTING
FLOOR
PLAN
SCALE: 1:50 @ A2

SHEET NUMBER
G1.0