




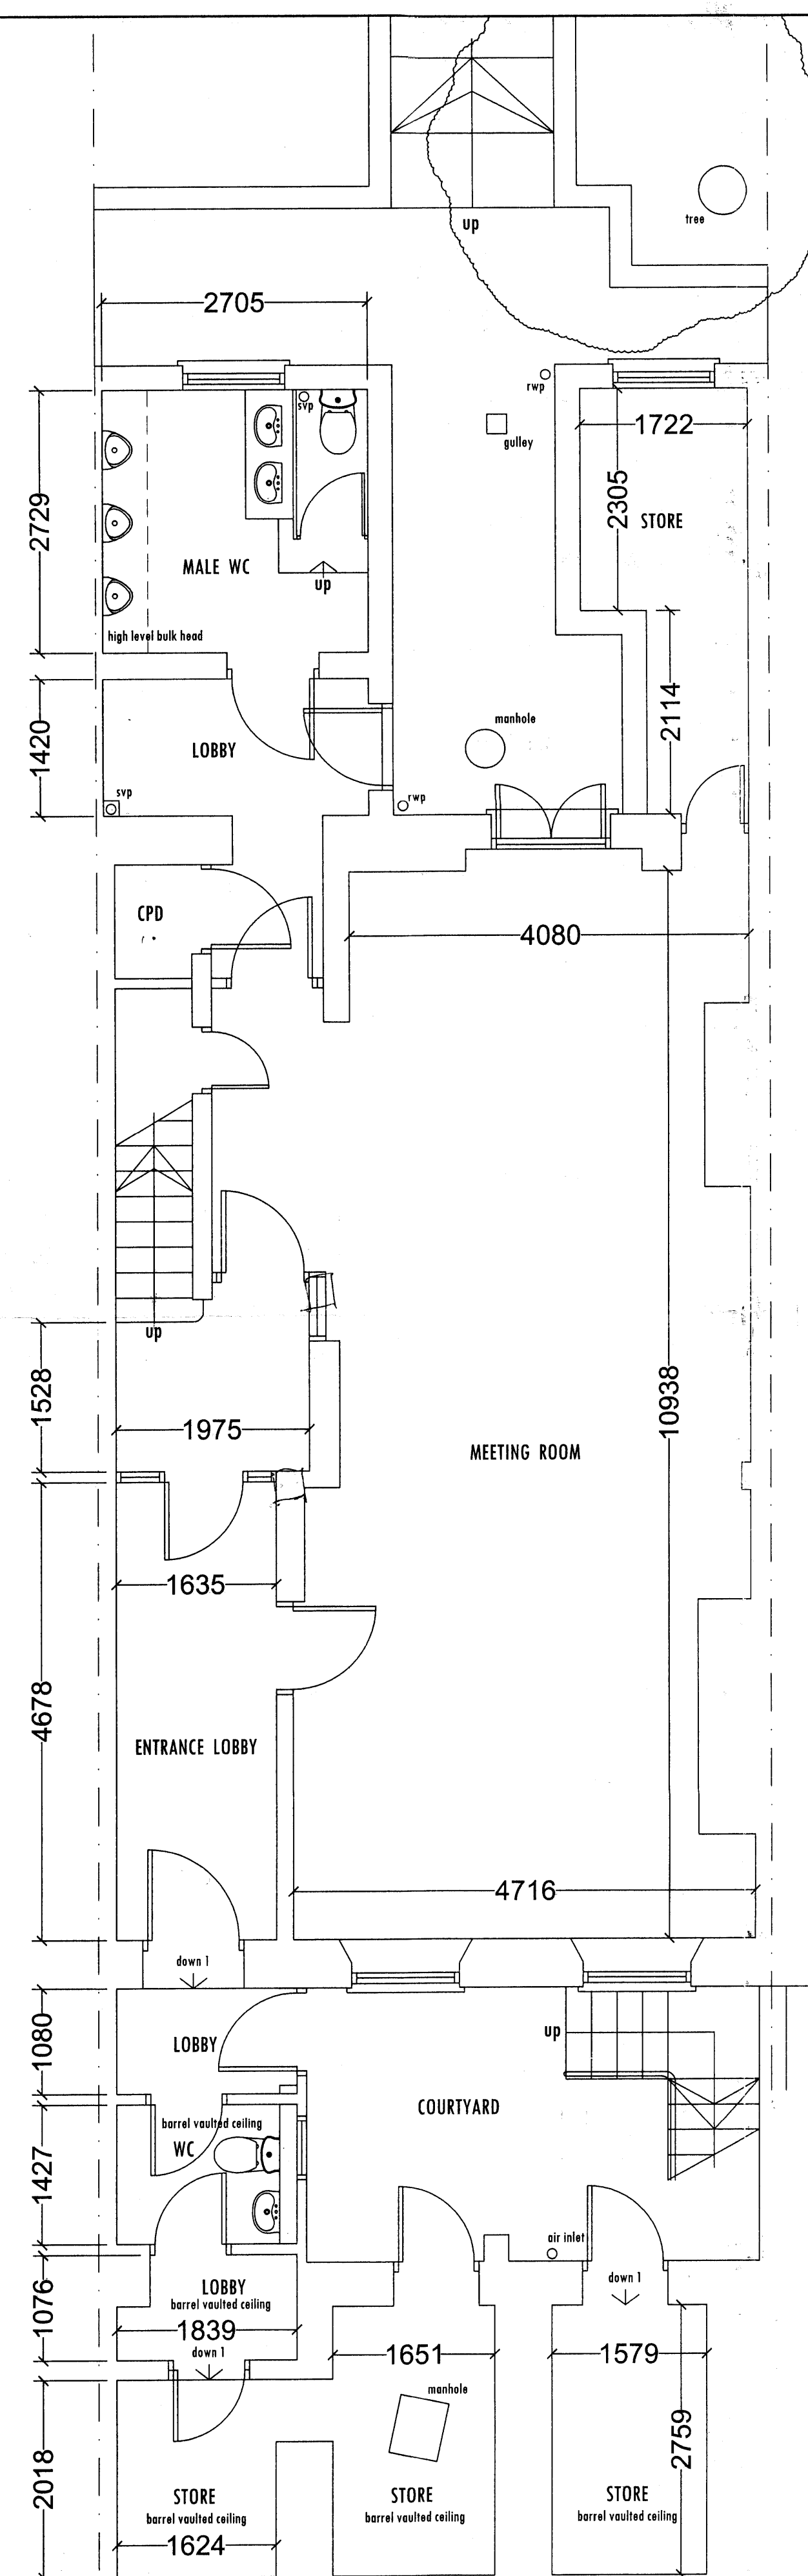

**BASEMENT FLOOR PLAN (GIA = 115.38 m2)
AS EXISTING**

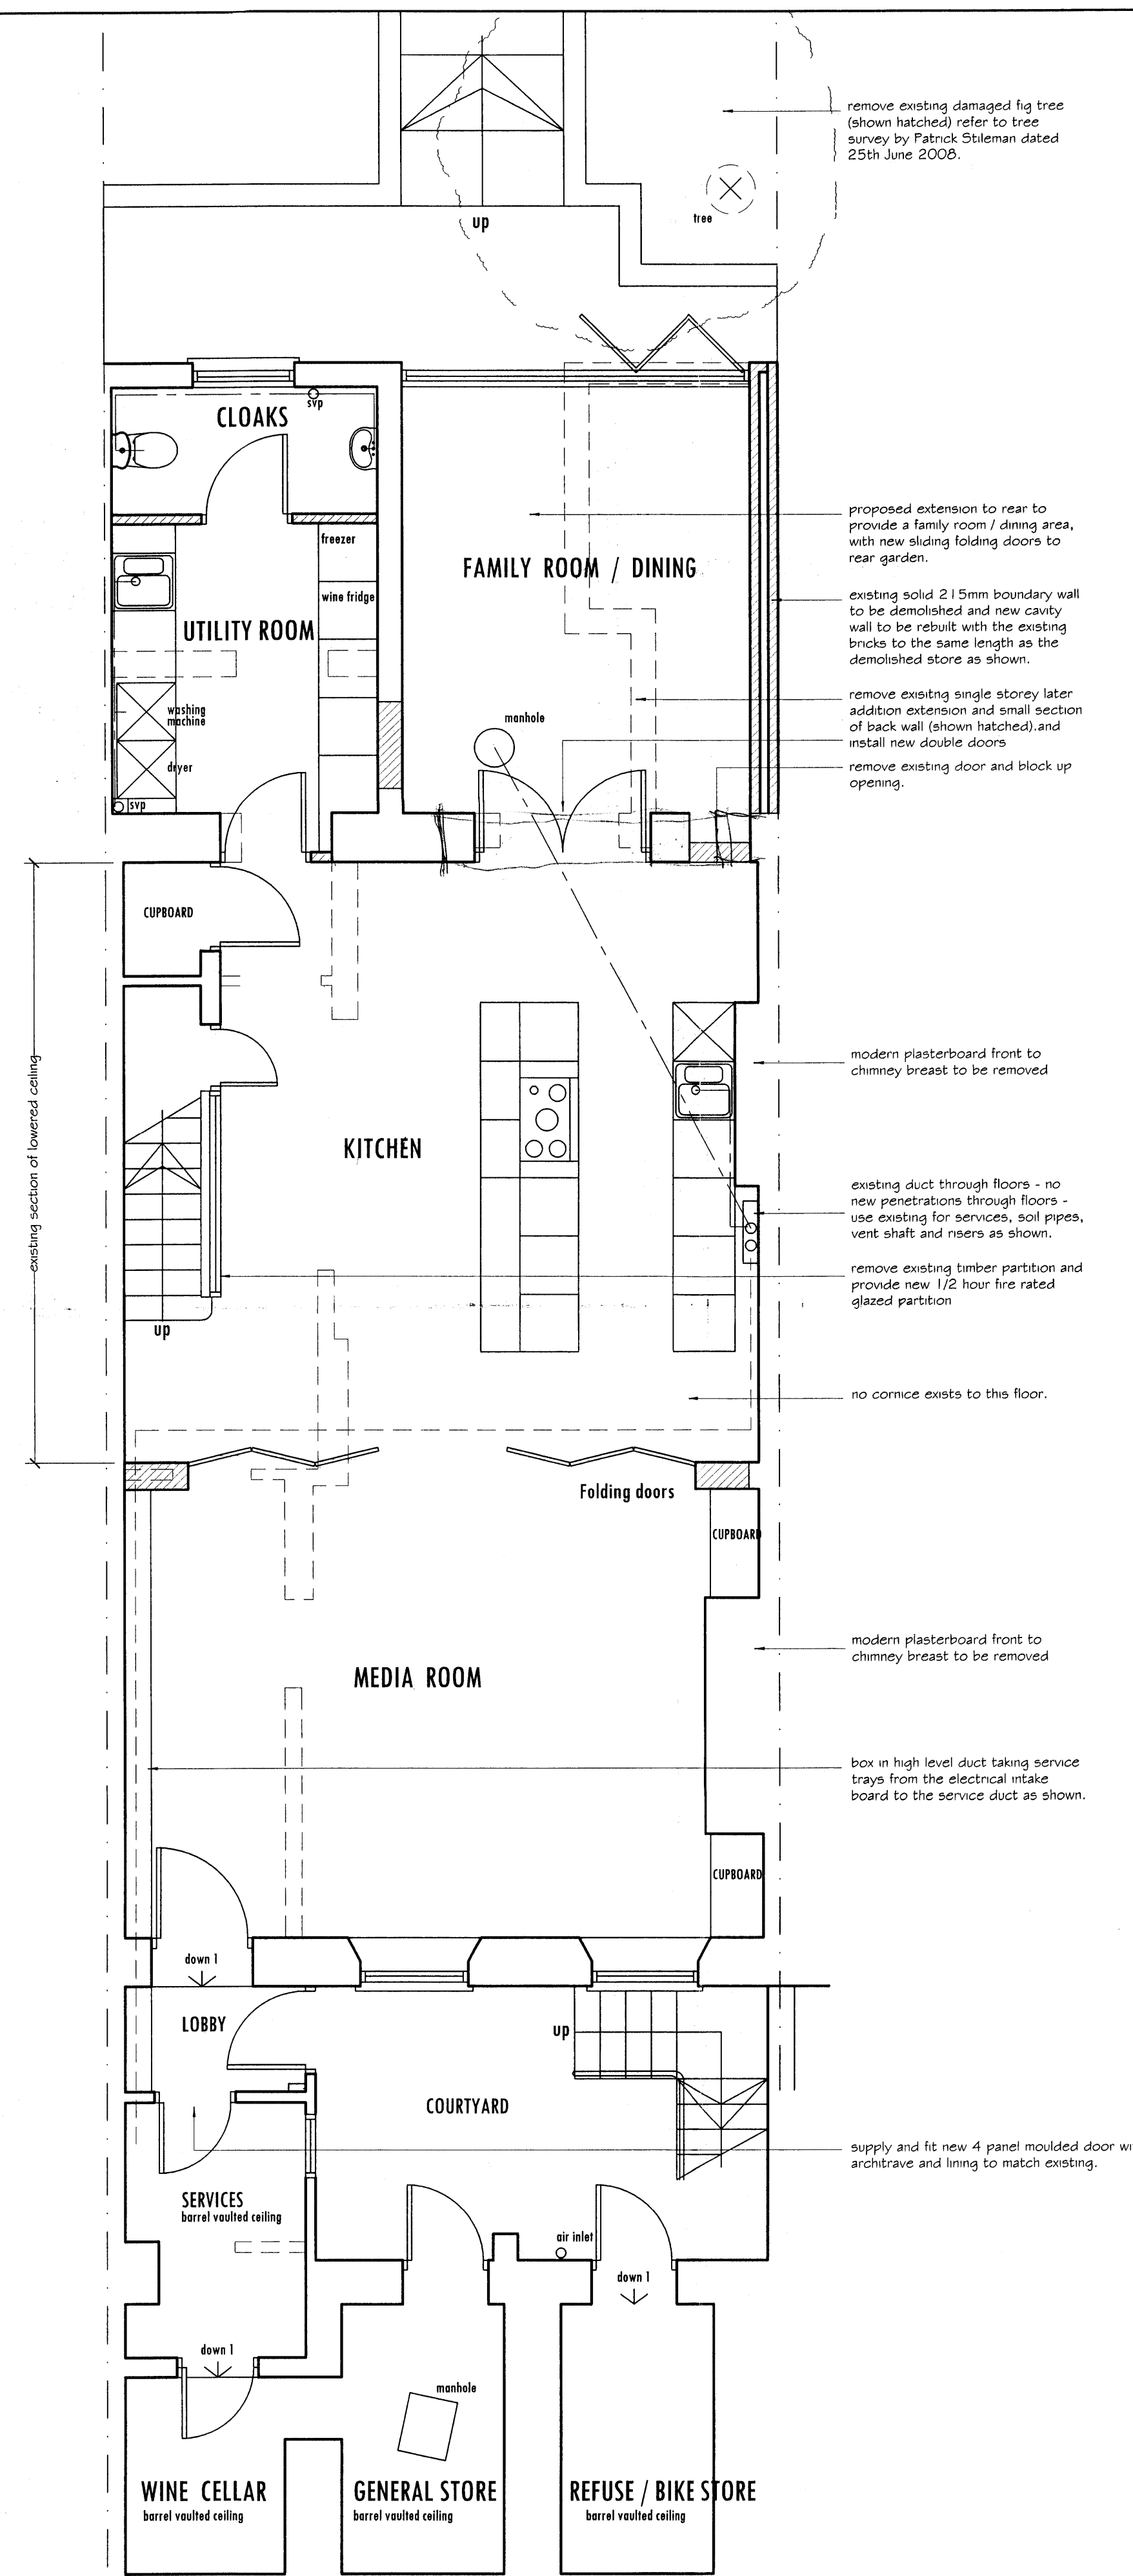

**BASEMENT FLOOR PLAN
AS PROPOSED**

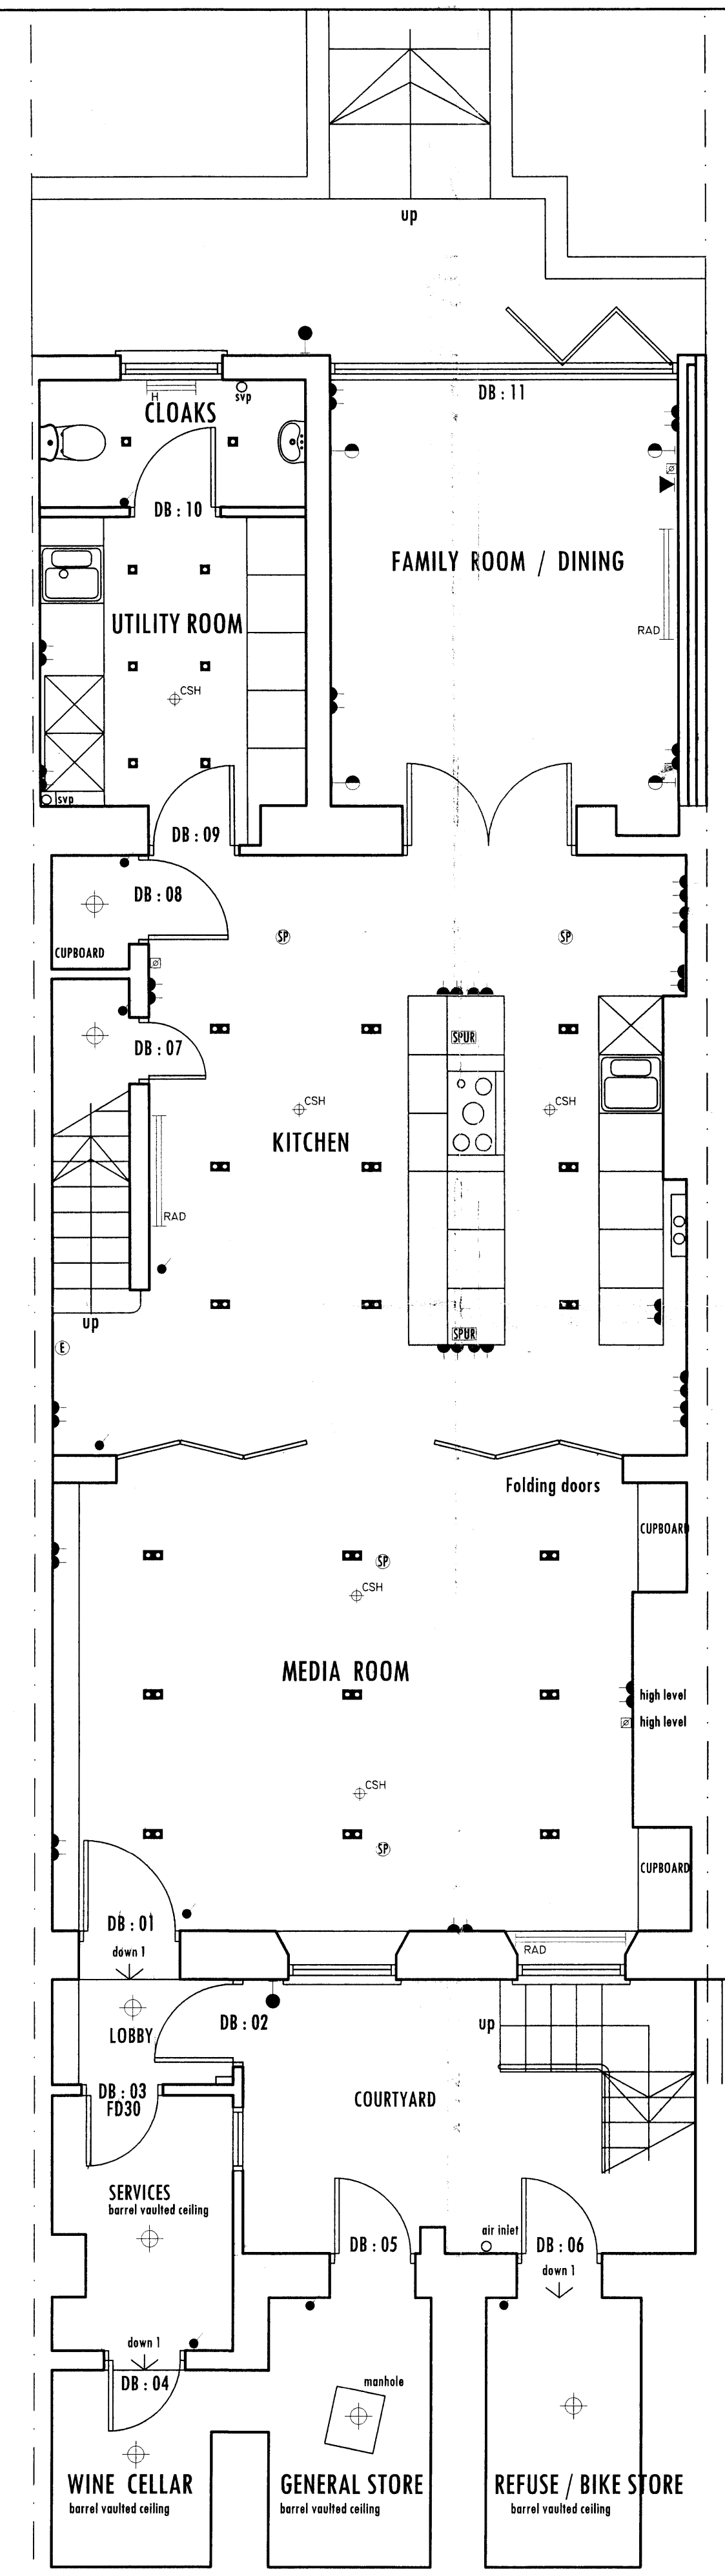

**BASEMENT FLOOR PLAN
ELECTRICAL LAYOUT**

NOTES :
Do not scale from this drawing.
Use figured dimensions only.
Figured dimensions are in millimetres.

All specified products and materials are to be fitted and installed in accordance with the manufacturers specifications and instructions.

All building works are to be carried out in strict accordance with the current Building Regulations and Codes of Practice.

LEGEND

- SD SMOKE DETECTORS
- SPUR FUSED SPUR OUTLET (LOW LEVEL)
- WALL LIGHT FITTING
- EXTERNAL WALL LANTERN
- LOW LEVEL WALL LIGHT FITTING
- PENDANT LIGHT FITTING
- SWITCHED DOUBLE SOCKET
- SWITCHED SINGLE SOCKET
- RADIATOR
- LV DOWN LIGHT - DOUBLE FITTING
- LV DOWN LIGHT - SINGLE FITTING
- PULL CORD
- ONE WAY SWITCH
- TWO WAY SWITCH
- DIMMER SWITCH
- HEATED TOWEL RAIL
- TV JACK
- TELEPHONE JACK
- CEILING SPRINKLER HEAD
- WARDROBE LIGHTS
- ELECTRO SHAVE POINT
- LV UNDER CUPD. LIGHTING
- 5 AMP LIGHTING (DIMMABLE)
- SENSOR TO WINDOW
- H/LEVEL MOVEMENT SENSOR
- ENTRY PHONE
- SPEAKER

DOOR SCHEDULE

- DB : 01 FLUSH FRAME LESS DOOR
- DB : 02 EXISTING EXTERNAL DOOR
- DB : 03 4 PANELLED DOOR
- DB : 04 FLUSH FRAME LESS DOOR
- DB : 05 EXISTING EXTERNAL DOOR
- DB : 06 EXISTING EXTERNAL DOOR
- DB : 07 SECRET DOOR
- DB : 08 SECRET DOOR
- DB : 09 FLUSH FRAME LESS DOOR
- DB : 10 FLUSH FRAME LESS DOOR
- DB : 11 GLAZED FOLDING DOORS

CHALLINOR HALL ASSOCIATES

Architectural Design Consultants

The Mews studio

102a Longstone Road

Eastbourne BN21 3SJ Tel 01323 411933

Client

WIGMORE INVESTMENTS Ltd

Project Title

CHANGE OF USE FROM OFFICES TO
SINGLE PRIVATE DWELLING

6 ENDSLEIGH STREET
LONDON WC1H 0DZ

Drawing Title

BASEMENT FLOOR PLANS
(existing, proposed & electrical layout)

As approved

Scale
1 : 50 (A1)

Copyright 2006

Date
OCTOBER 2008

Drawn By
LW

Revisions

B OCT 08 client amendments added
C OCT 08 FURTHER CLIENT AMENDMENTS
d APR 09 PLANNERS AMENDMENTS