




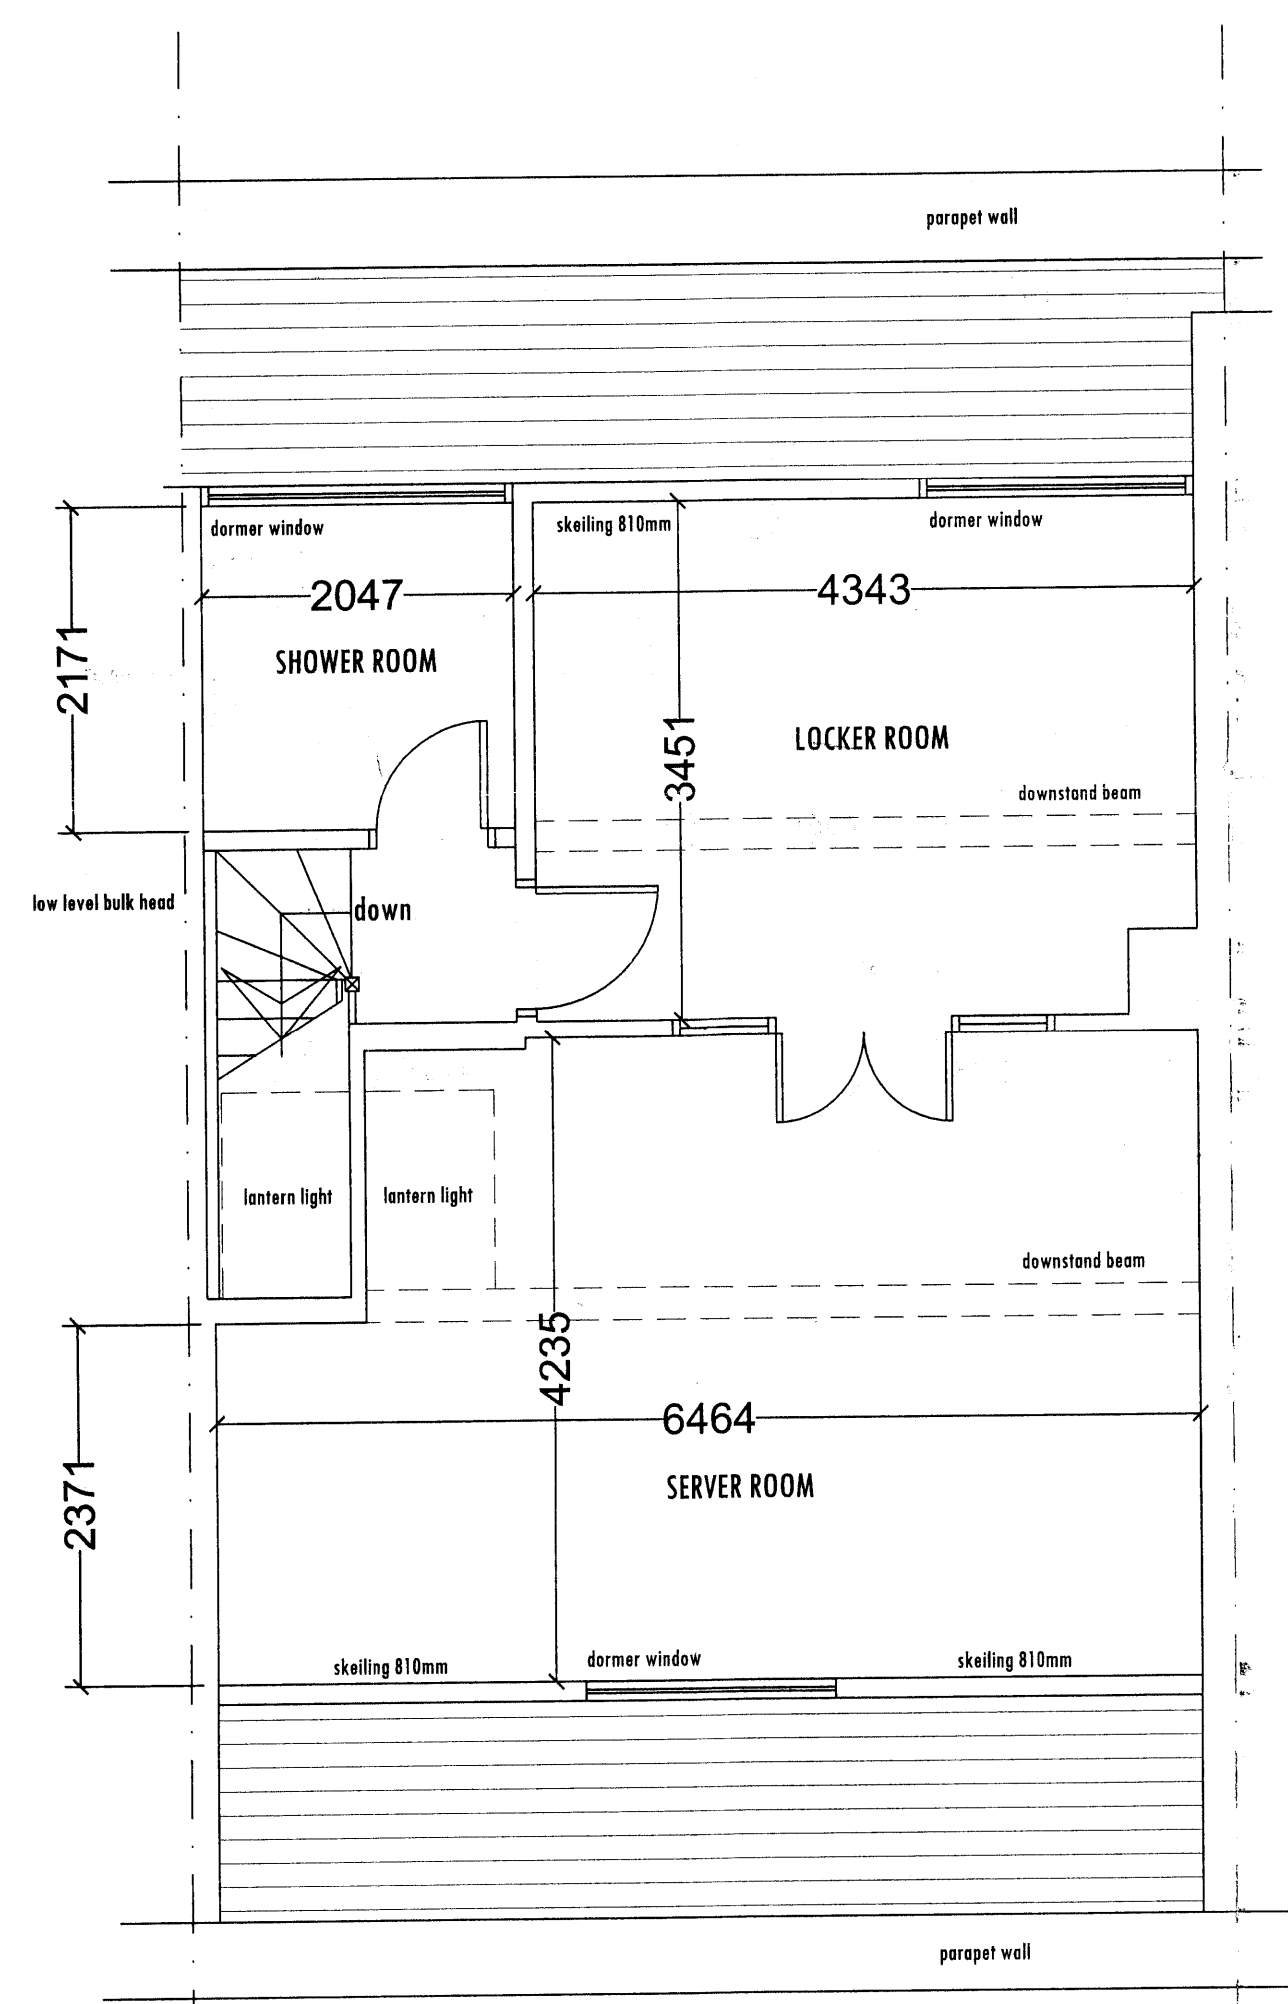

FOURTH FLOOR PLAN (GIA 50.60 m2)
AS EXISTING

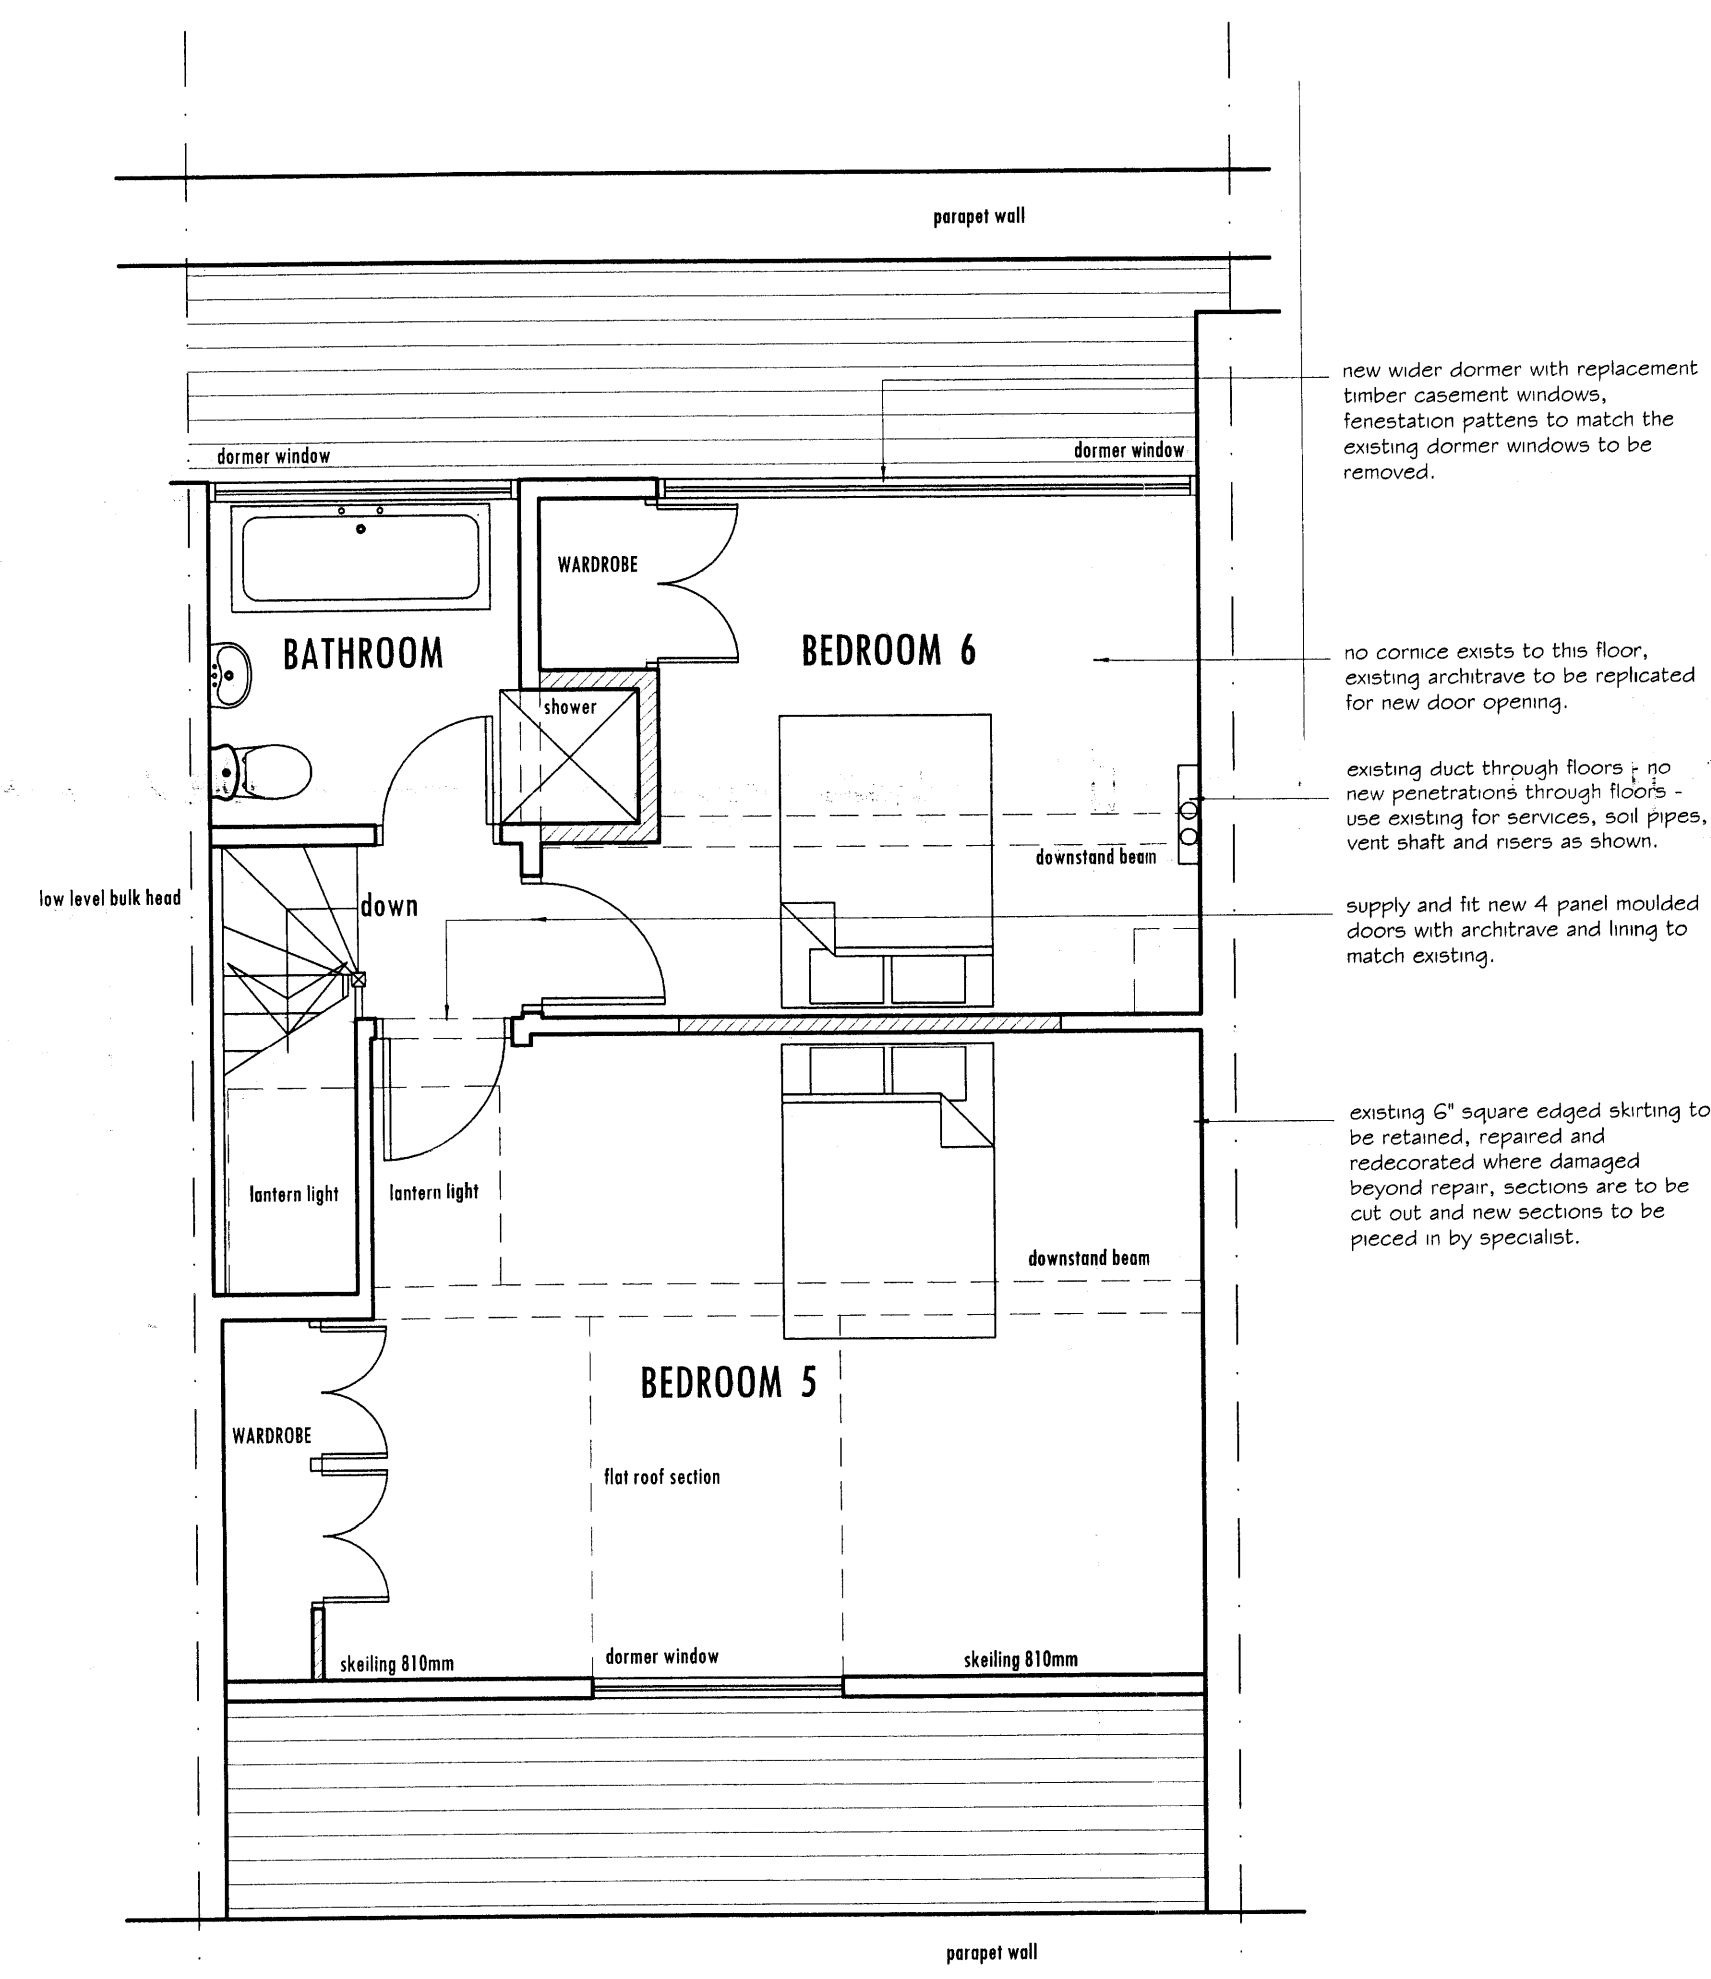

FOURTH FLOOR PLAN
AS PROPOSED

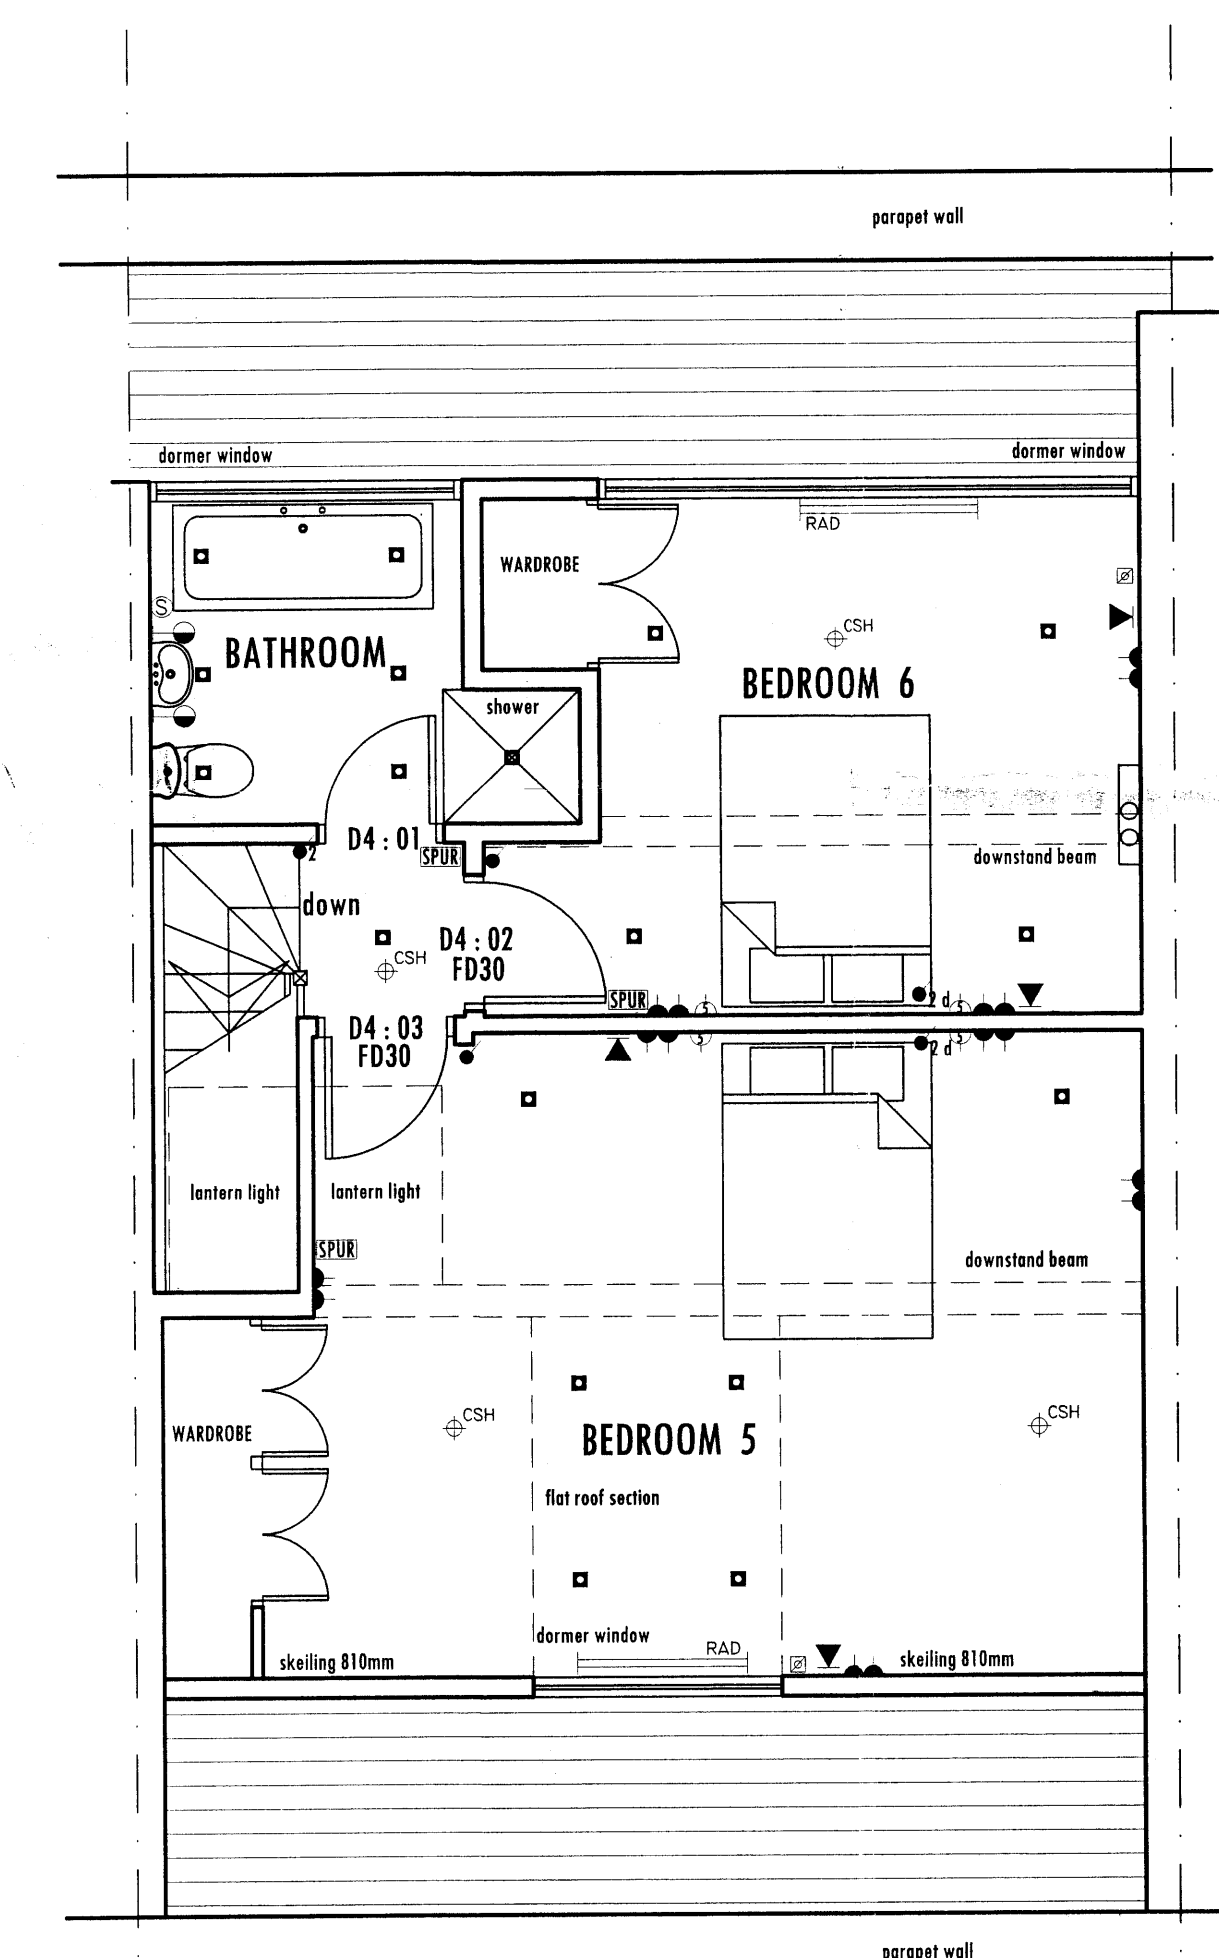

FOURTH FLOOR PLAN - ELECTRICAL LAYOUT

DOOR SCHEDULE

D4 : 01 4 PANELLED DOOR (SINGLE FACED)
D4 : 02 4 PANELLED DOOR (SINGLE FACED)
D4 : 03 4 PANELLED DOOR (SINGLE FACED)

(GIA = 50.60 m2)

NOTES :
Do not scale from this drawing.
Use figured dimensions only.
Figured dimensions are in millimetres.

All specified products and materials are to be fitted and installed in accordance with the manufacturers specifications and instructions.

All building works are to be carried out in strict accordance with the current Building Regulations and Codes of Practice.

LEGEND

	SMOKE DETECTORS
	FUSED SPUR OUTLET (LOW LEVEL)
	WALL LIGHT FITTING
	EXTERNAL WALL LANTERN
	LOW LEVEL WALL LIGHT FITTING
	PENDANT LIGHT FITTING
	SWITCHED DOUBLE SOCKET
	SWITCHED SINGLE SOCKET
	RADIATOR
	L.V DOWN LIGHT - DOUBLE FITTING
	L.V DOWN LIGHT - SINGLE FITTING
	PULL CORD
	ONE WAY SWITCH
	TWO WAY SWITCH
	DIMMER SWITCH
	HEATED TOWEL RAIL
	TV JACK
	TELEPHONE JACK
	CEILING SPRINKLER HEAD
	WARDROBE LIGHTS
	ELECTRO SHAVE POINT
	L.V UNDER CUPD. LIGHTING
	SENSOR TO WINDOW
	H/LEVEL MOVEMENT SENSOR
	ENTRY PHONE
	SPEAKER

CHALLINOR HALL ASSOCIATES

Architectural Design Consultants
The Mews studio
102a Longstone Road
Eastbourne BN21 3SJ Tel 01323 411933

Client
WIGMORE INVESTMENTS Ltd

Project Title
CHANGE OF USE FROM OFFICES TO
SINGLE PRIVATE DWELLING
6 ENDSLEIGH STREET
LONDON WC1H 0DZ

Drawing Title
FOURTH FLOOR PLANS
(existing, proposed & electrical layout)
'as approved'

Scale
1 : 50 (A1)

Date
OCTOBER 2008

Drawn By
LW

Revisions	
A JUNE 08	electrical layout plan amended and notes amended on the proposed plan
B OCT 2008	FURTHER CLIENT AMENDMENTS