



THIRD FLOOR PLAN (GIA = 70.90 m2)
AS EXISTING

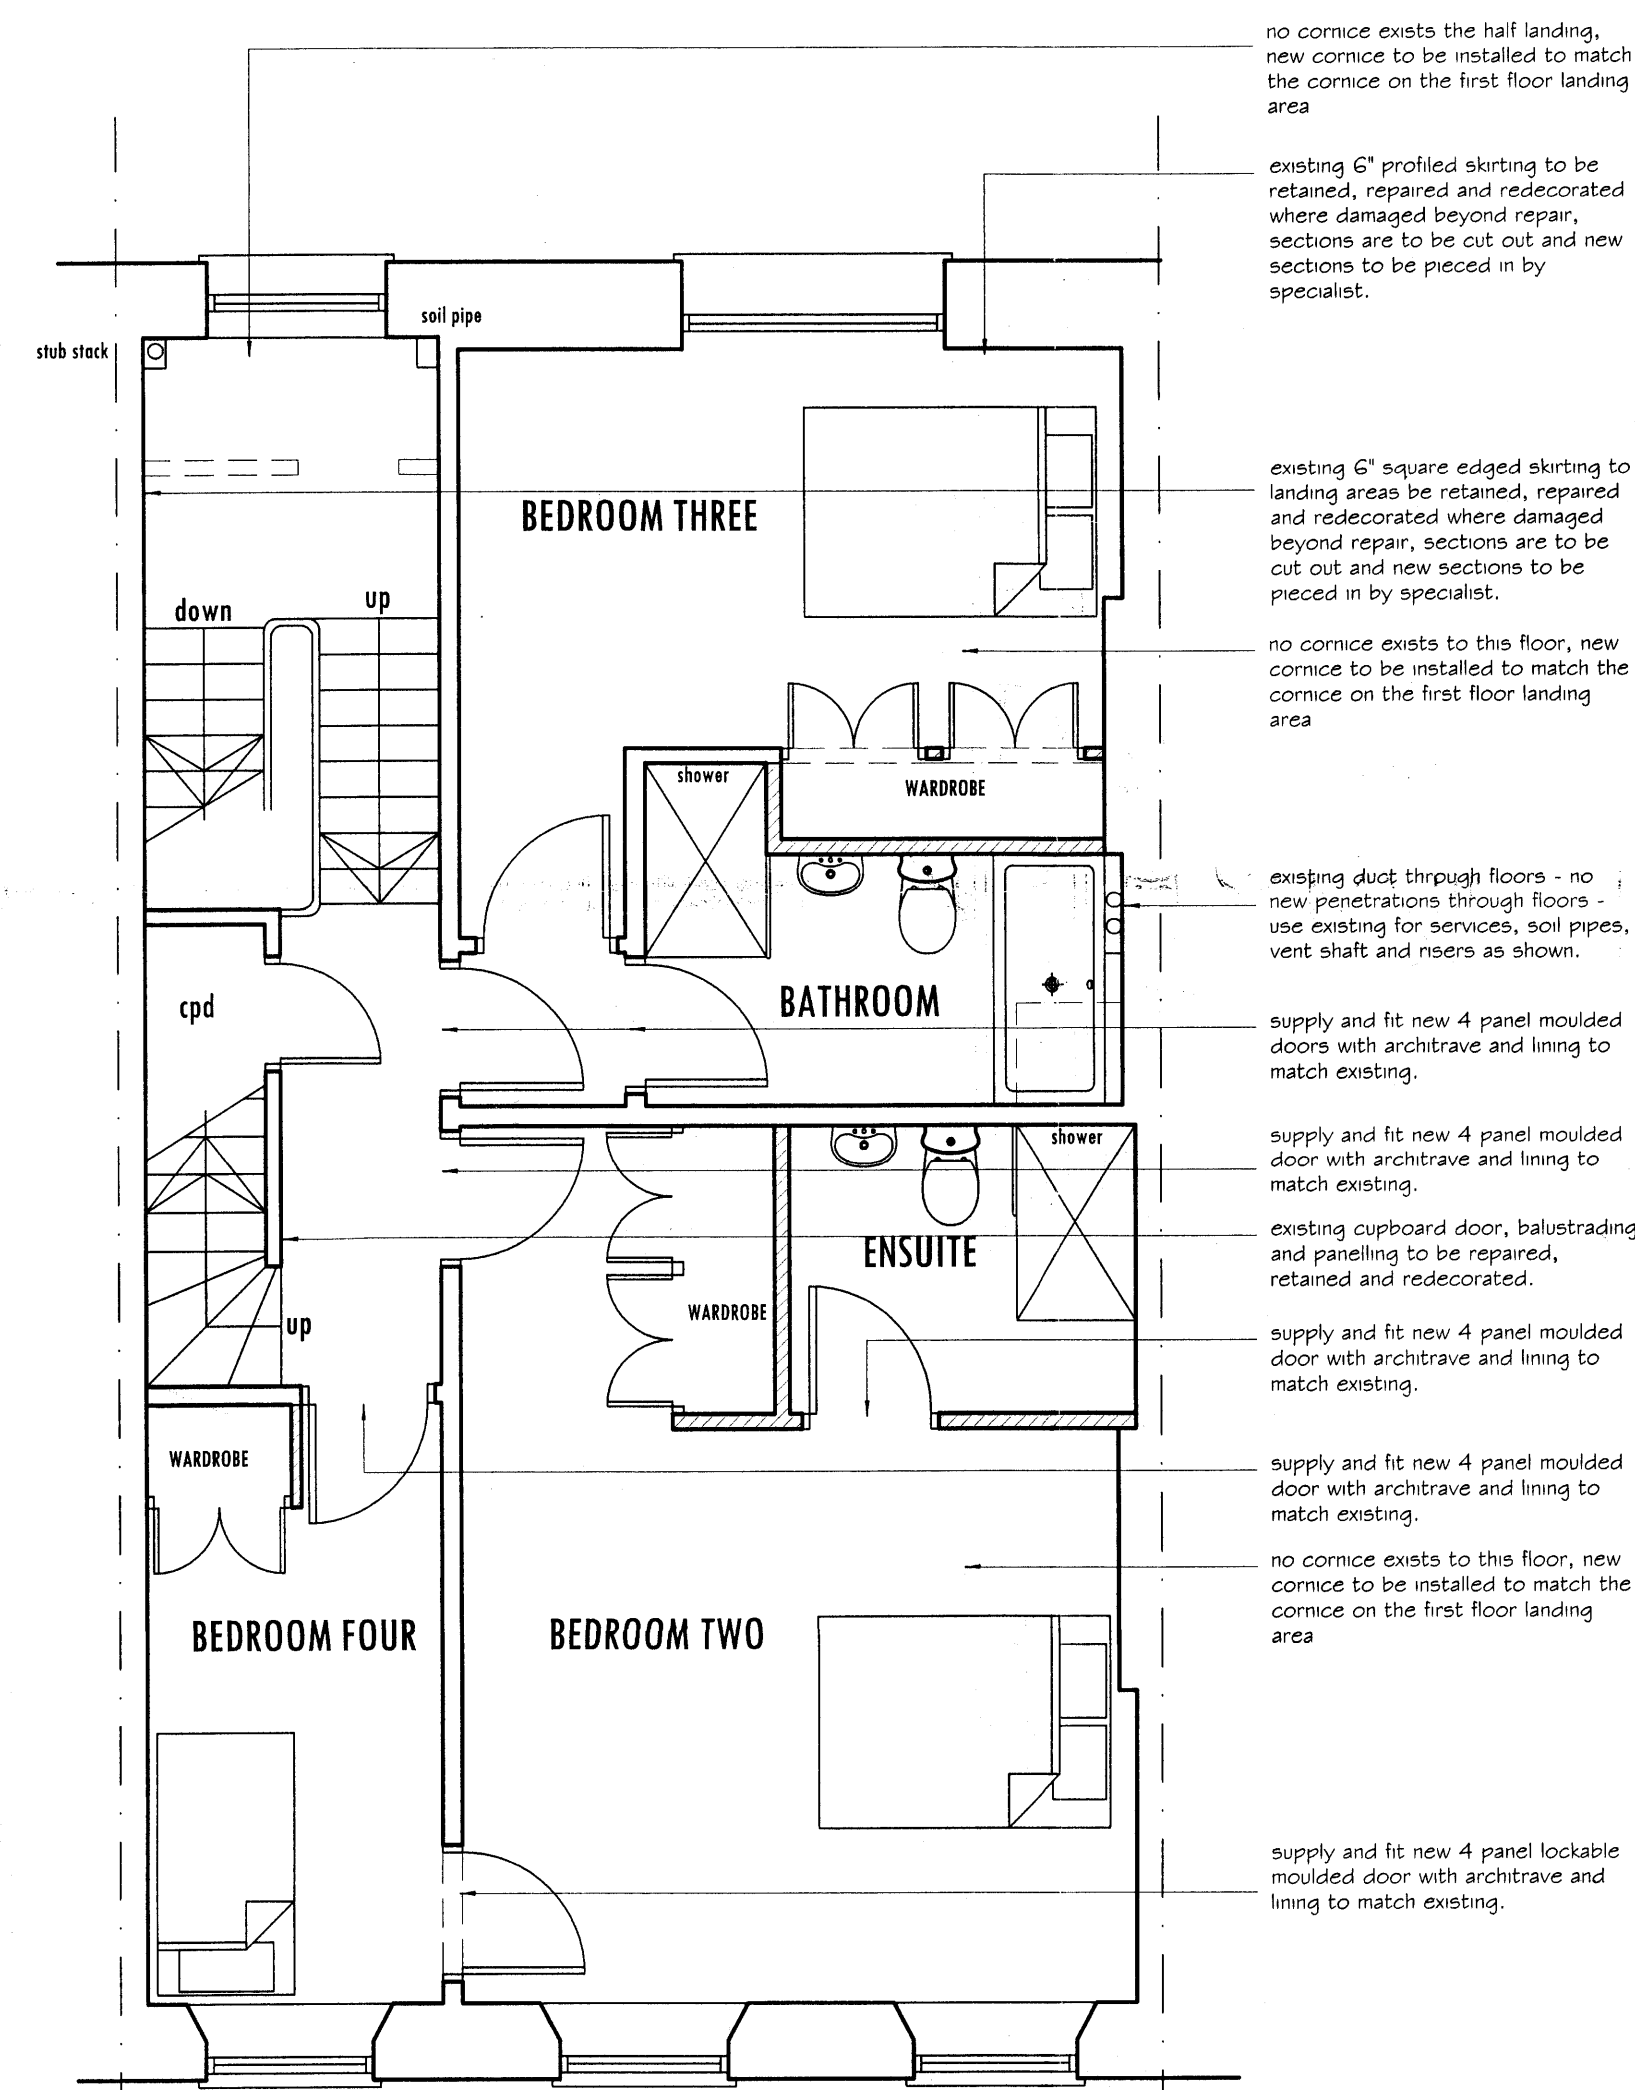

THIRD FLOOR PLAN
AS PROPOSED

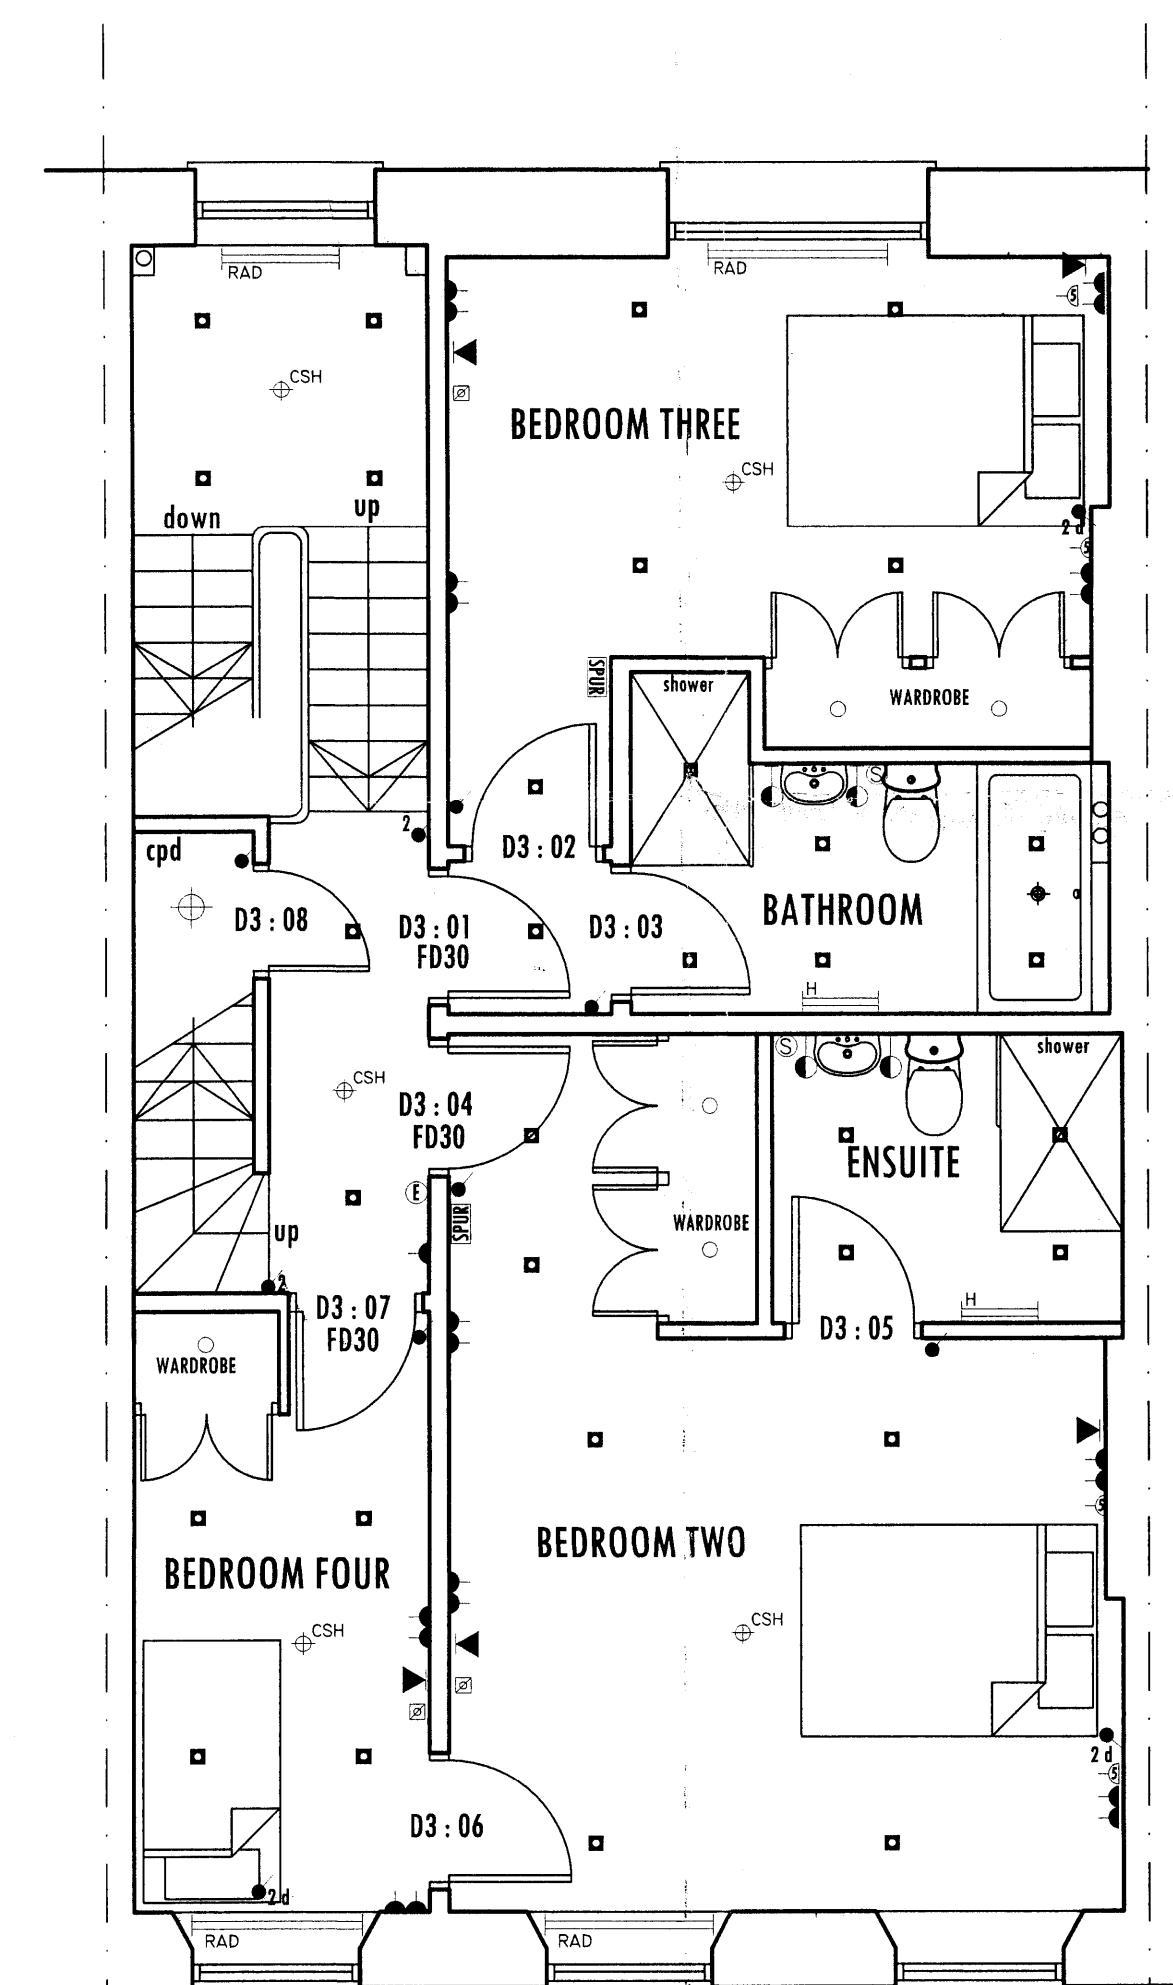

THIRD FLOOR PLAN - ELECTRICAL LAYOUT

DOOR SCHEDULE

D3 : 01	4 PANELLED DOOR
D3 : 02	4 PANELLED DOOR AS EXISTING
D3 : 03	4 PANELLED DOOR
D3 : 04	4 PANELLED DOOR
D3 : 05	SECRET DOOR
D3 : 06	SECRET DOOR
D3 : 07	4 PANELLED DOOR
D3 : 08	4 PANELLED DOOR AS EXISTING

(GIA = 70.90 m2)

NOTES :
Do not scale from this drawing.
Use figured dimensions only.
Figured dimensions are in millimetres.

All specified products and materials are to be fitted and installed in accordance with the manufacturers specifications and instructions.

All building works are to be carried out in strict accordance with the current Building Regulations and Codes of Practice.

LEGEND

SD	SMOKE DETECTORS
SPUR	FUSED SPUR OUTLET (LOW LEVEL)
WALL LIGHT FITTING	WALL LIGHT FITTING
EXTERNAL WALL LANTERN	EXTERNAL WALL LANTERN
LOW LEVEL WALL LIGHT FITTING	LOW LEVEL WALL LIGHT FITTING
PENDANT LIGHT FITTING	PENDANT LIGHT FITTING
SWITCHED DOUBLE SOCKET	SWITCHED DOUBLE SOCKET
SWITCHED SINGLE SOCKET	SWITCHED SINGLE SOCKET
RAD	RADIATOR
L.V DOWN LIGHT - DOUBLE FITTING	L.V DOWN LIGHT - DOUBLE FITTING
L.V DOWN LIGHT - SINGLE FITTING	L.V DOWN LIGHT - SINGLE FITTING
PULL CORD	PULL CORD
ONE WAY SWITCH	ONE WAY SWITCH
TWO WAY SWITCH	TWO WAY SWITCH
DIMMER SWITCH	DIMMER SWITCH
HEATED TOWEL RAIL	HEATED TOWEL RAIL
TV JACK	TV JACK
TELEPHONE JACK	TELEPHONE JACK
CEILING SPRINKLER HEAD	CEILING SPRINKLER HEAD
WARDROBE LIGHTS	WARDROBE LIGHTS
ELECTRO SHAVE POINT	ELECTRO SHAVE POINT
L.V UNDER CUPD. LIGHTING	L.V UNDER CUPD. LIGHTING
5 AMP LIGHTING (DIMMABLE)	5 AMP LIGHTING (DIMMABLE)
SENSOR TO WINDOW	SENSOR TO WINDOW
H/LEVEL MOVEMENT SENSOR	H/LEVEL MOVEMENT SENSOR
ENTRY PHONE	ENTRY PHONE
SPEAKER	SPEAKER

CHALLINOR HALL ASSOCIATES

Architectural Design Consultants
The Mews studio
102a Longstone Road
Eastbourne BN21 3SJ Tel/ 01323 411933

Client
WIGMORE INVESTMENTS Ltd

Project Title
CHANGE OF USE FROM OFFICES TO
SINGLE PRIVATE DWELLING
6 ENDSLEIGH STREET
LONDON WC1H 0DZ

Drawing Title
THIRD FLOOR PLANS
(existing, proposed & electrical layout)

Scale
1 : 50 (A1)

Date
OCTOBER 2008

Drawn By
LW

Revisions	
A JUNE 08	electrical layout plan amended and notes amended on the proposed plan
B OCT 08	clients amendments added
C OCT 08	FURTHER CLIENT AMENDMENTS