
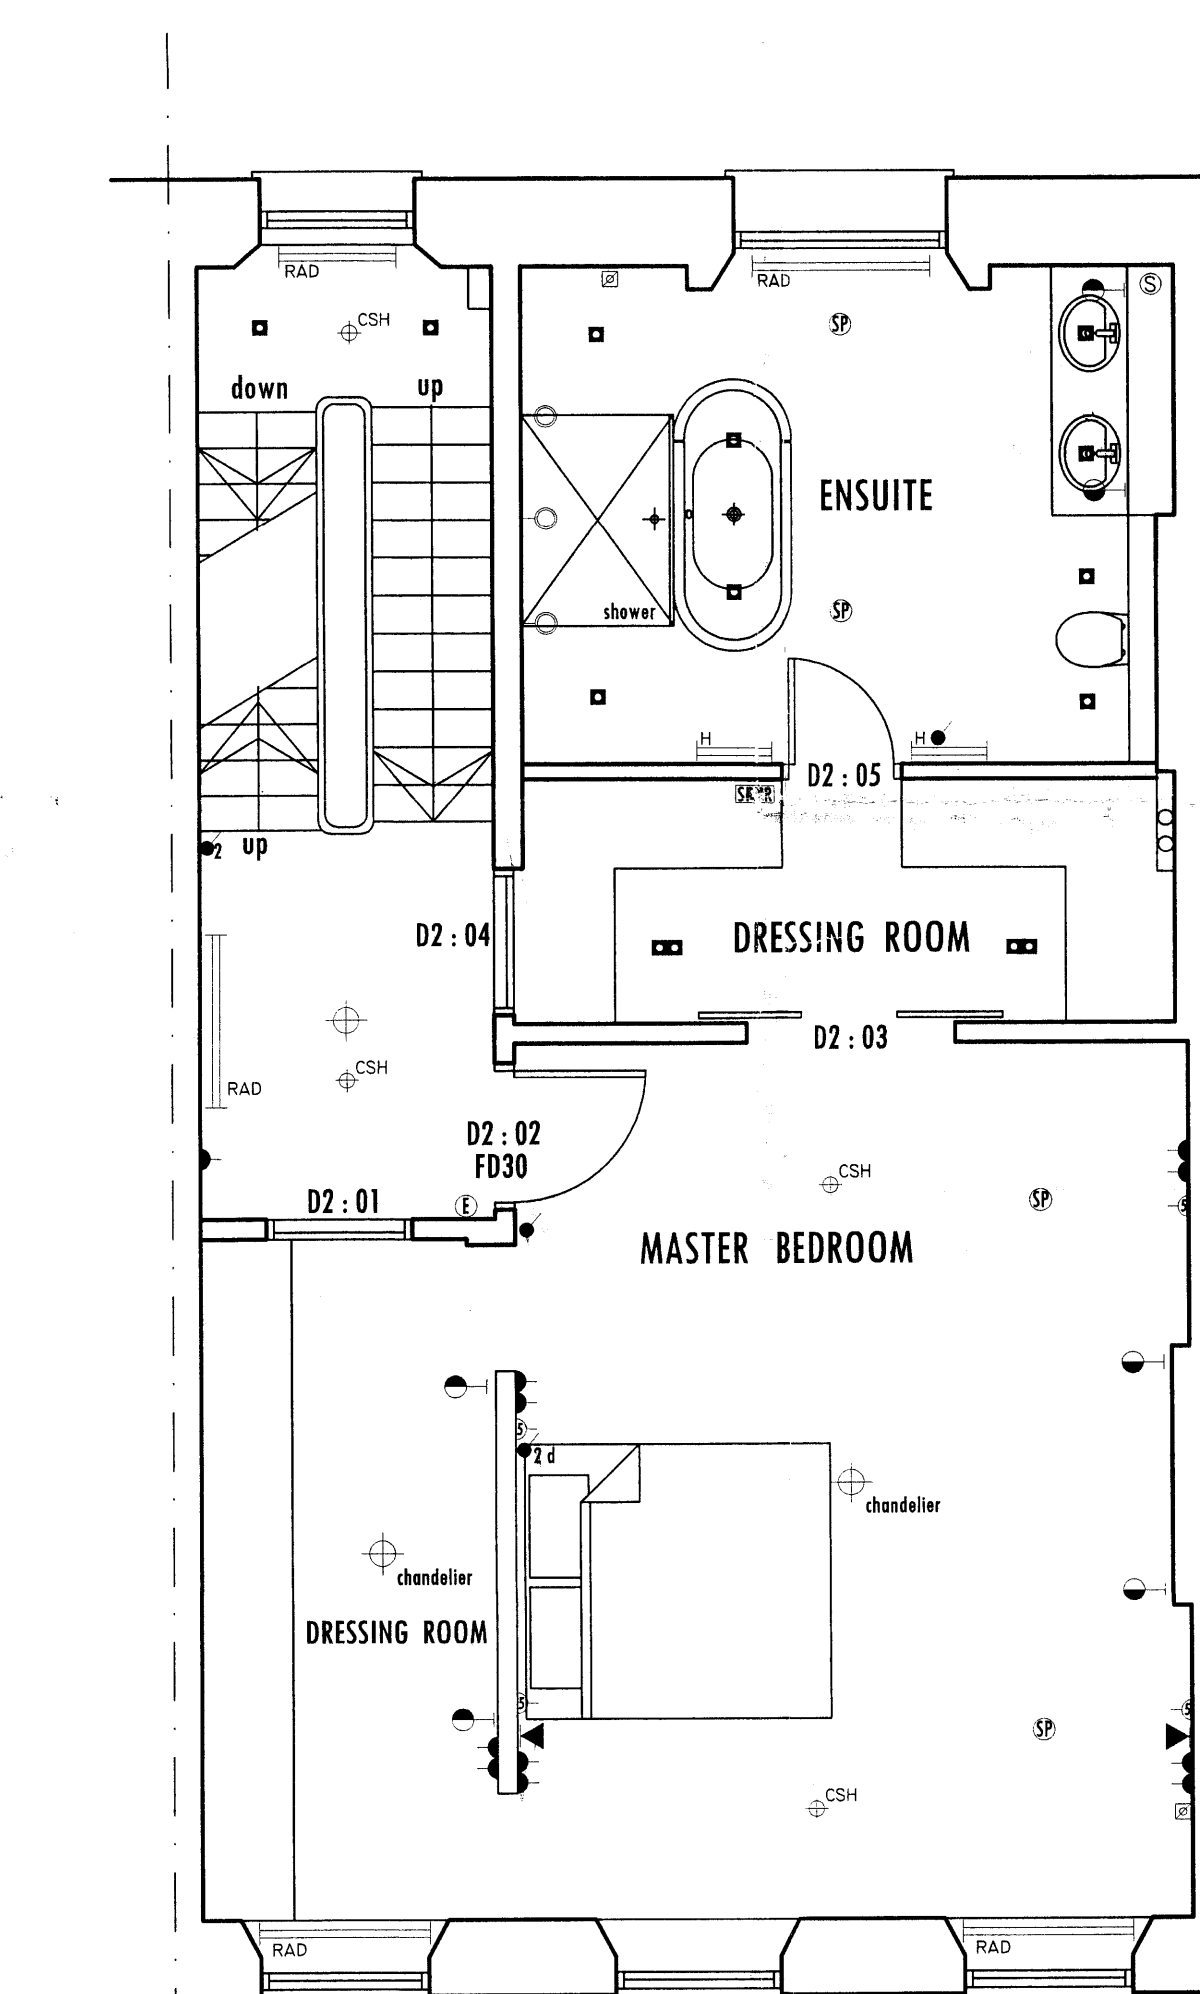
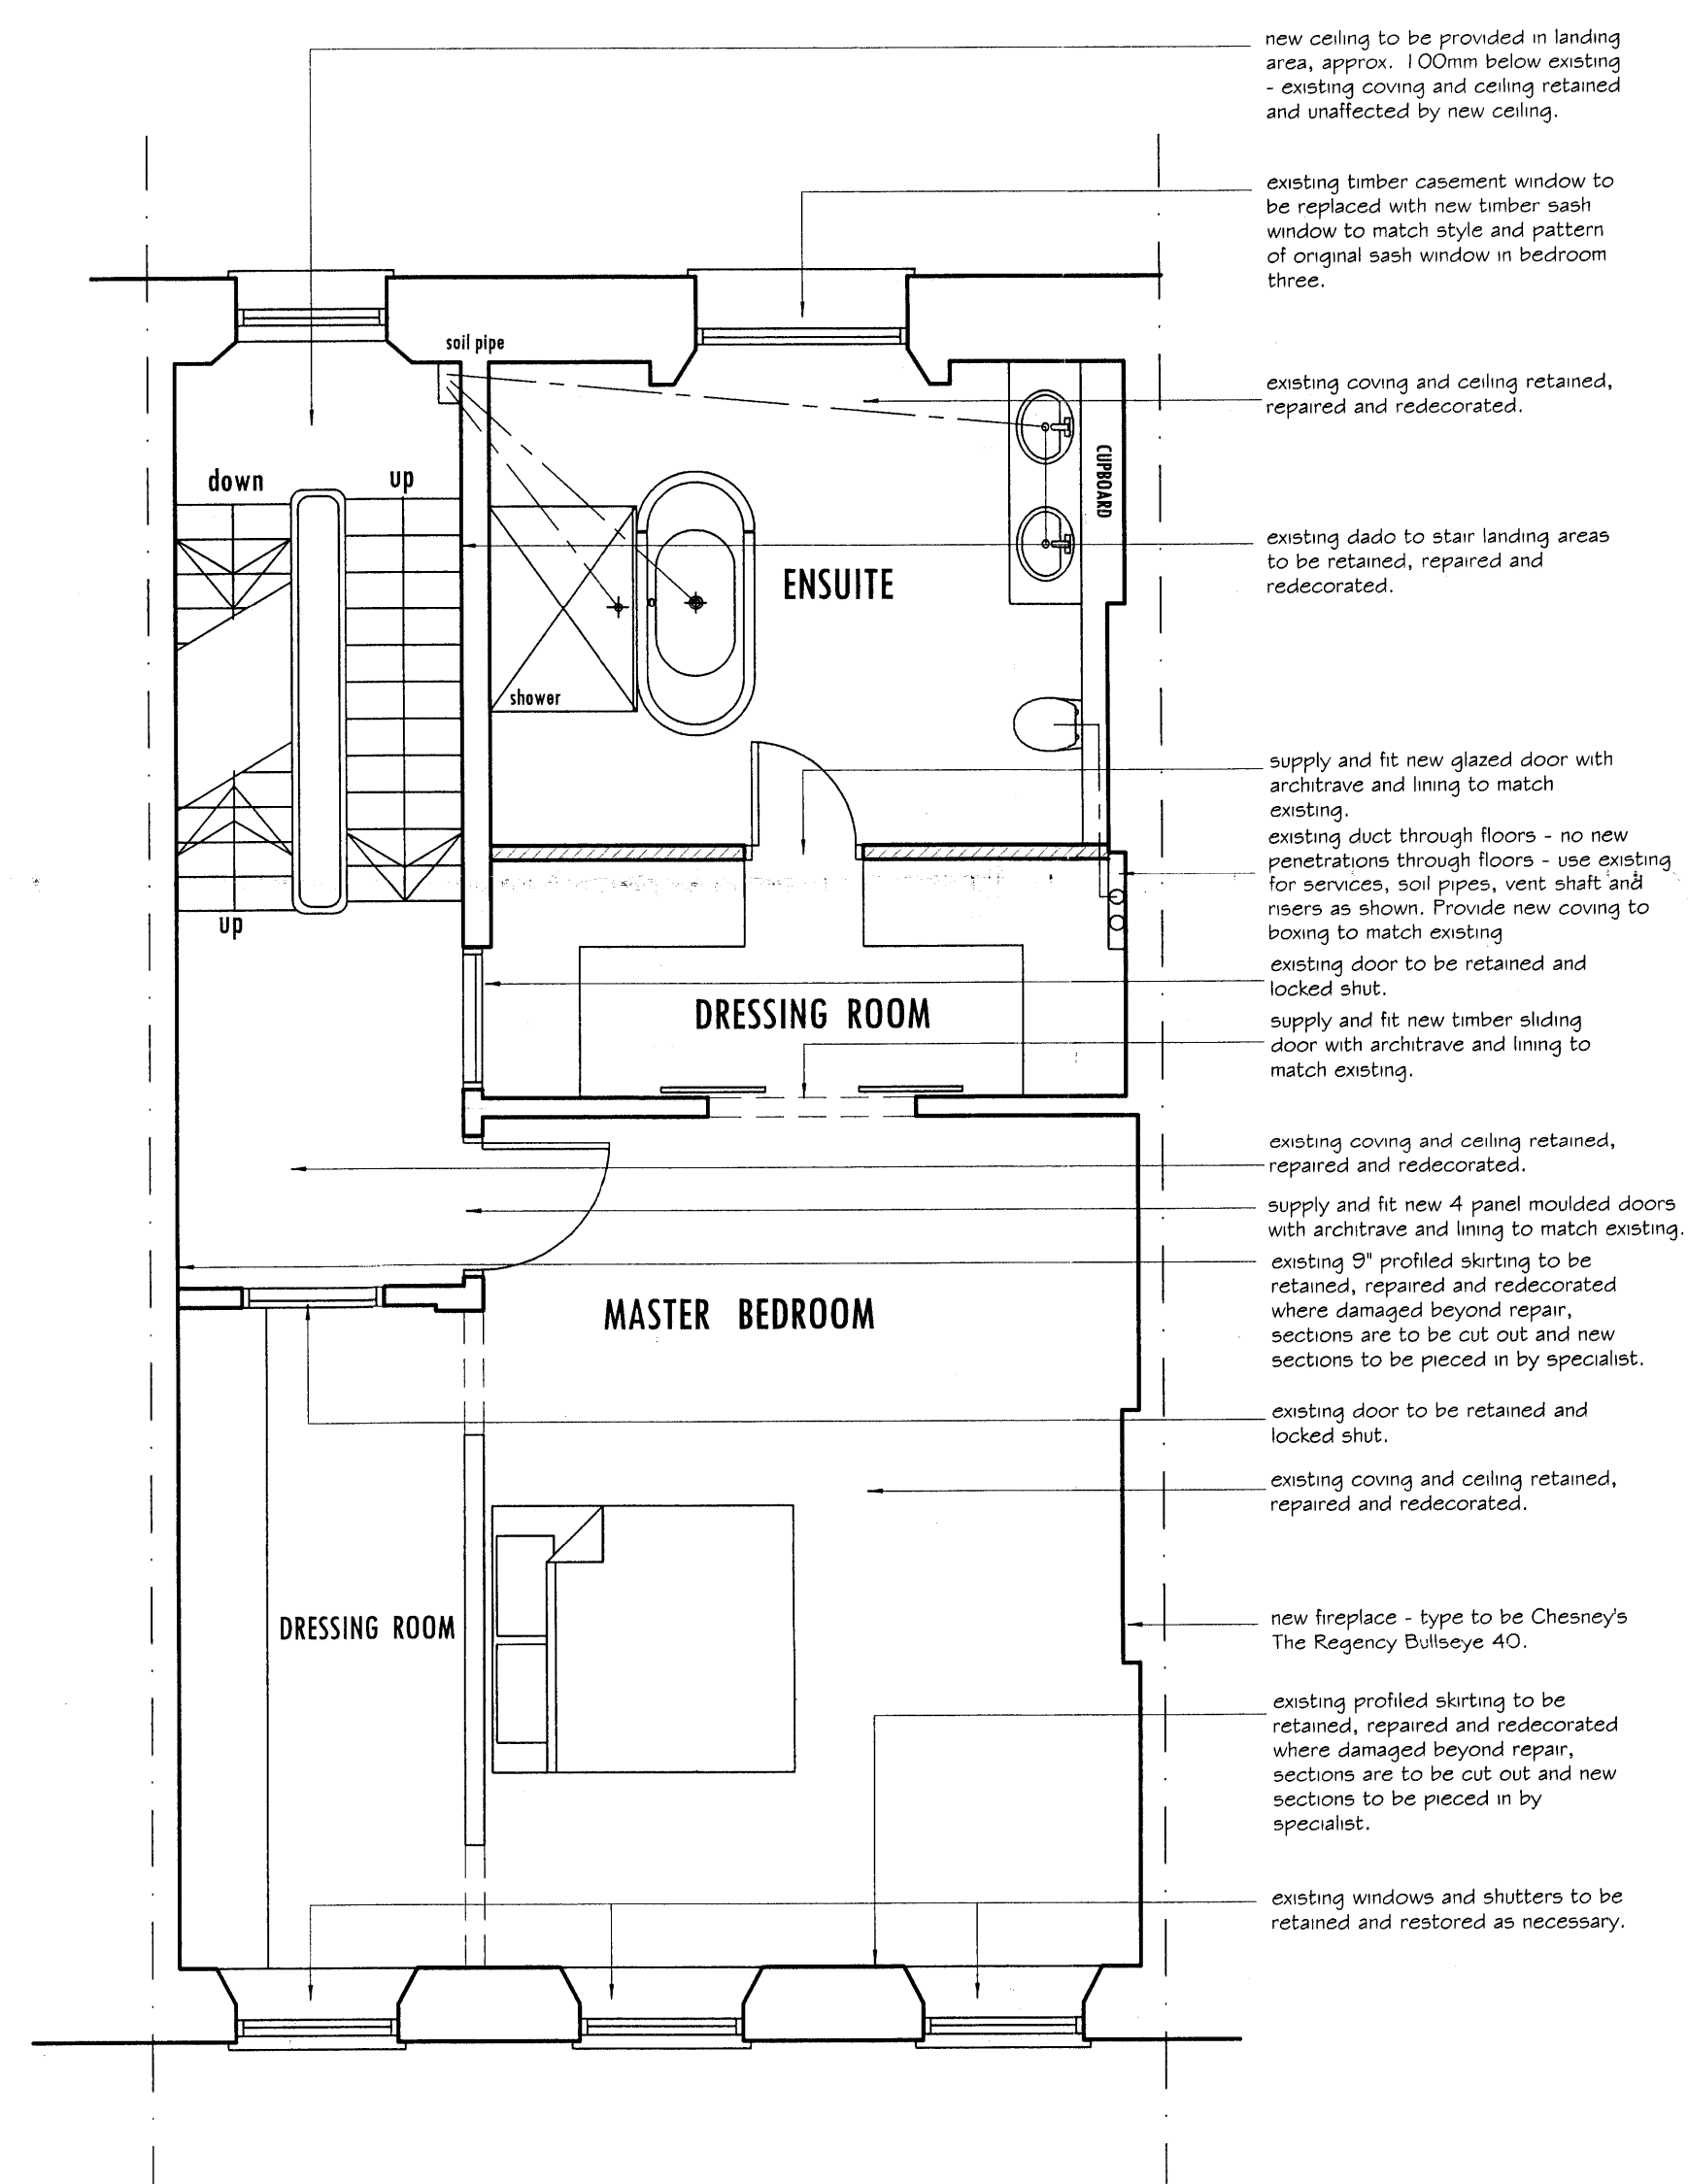


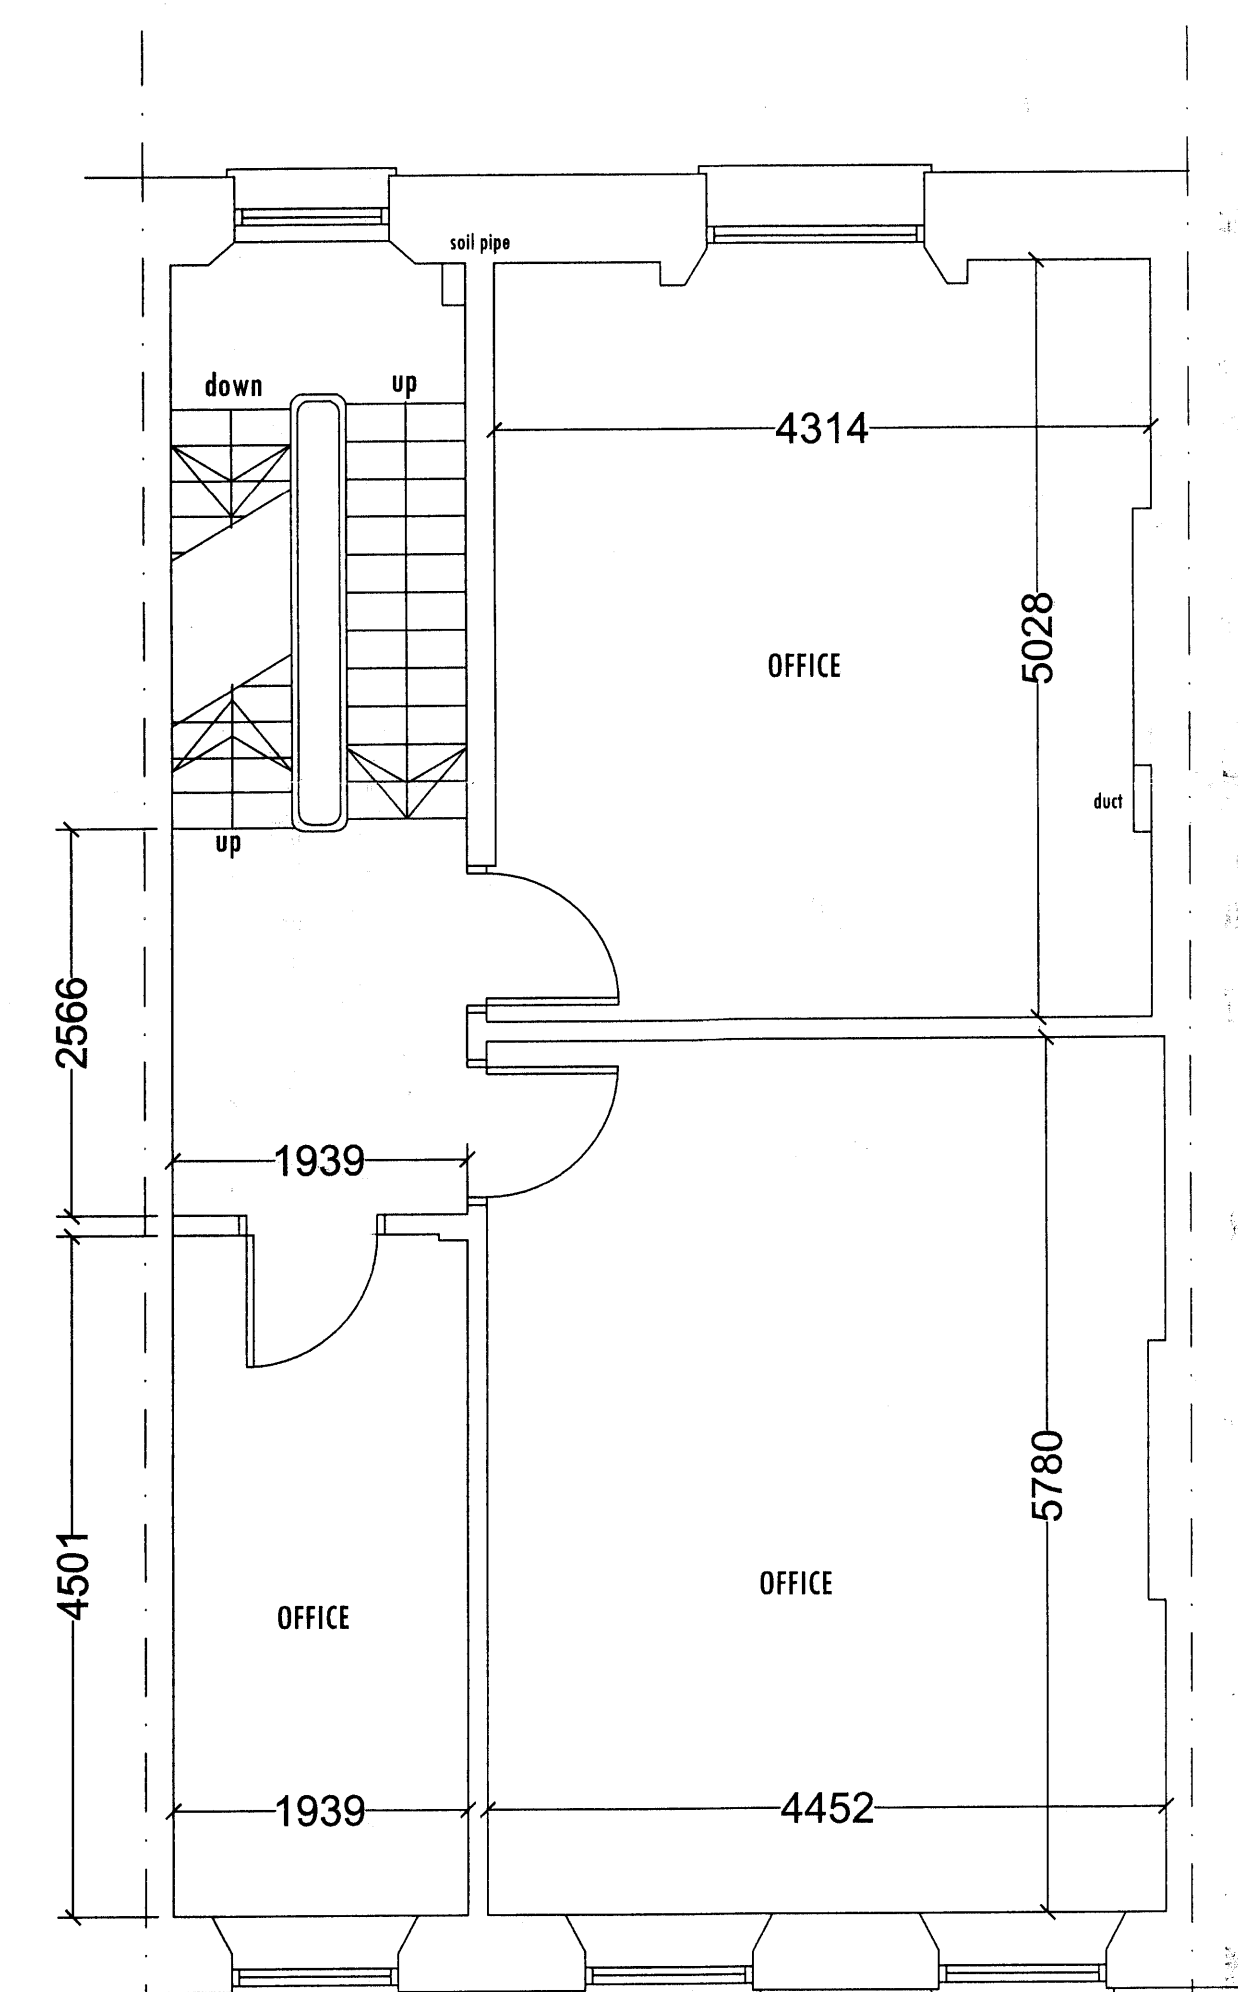

DOOR SCHEDULE

D2 : 01	4 PANELLED DOOR AS EXISTING LOCKED SHUT
D2 : 02	4 PANELLED DOOR
D2 : 03	SLIDING DOUBLE DOORS
D2 : 04	4 PANELLED DOOR AS EXISTING LOCKED SHUT
D2 : 05	GLAZED DOOR

(GIA = 70.90 m2)

NOTES :
Do not scale from this drawing.
Use figured dimensions only.
Figured dimensions are in millimetres.

All specified products and materials are to be fitted and installed in accordance with the manufacturers specifications and instructions.

All building works are to be carried out in strict accordance with the current Building Regulations and Codes of Practice.

LEGEND

	SMOKE DETECTORS
	FUSED SPUR OUTLET (LOW LEVEL)
	WALL LIGHT FITTING
	EXTERNAL WALL LANTERN
	LOW LEVEL WALL LIGHT FITTING
	PENDANT LIGHT FITTING
	SWITCHED DOUBLE SOCKET
	SWITCHED SINGLE SOCKET
	RADIATOR
	L.V DOWN LIGHT - DOUBLE FITTING
	L.V DOWN LIGHT - SINGLE FITTING
	PULL CORD
	ONE WAY SWITCH
	TWO WAY SWITCH
	DIMMER SWITCH
	HEATED TOWEL RAIL
	TV JACK
	TELEPHONE JACK
	CEILING SPRINKLER HEAD
	WARDROBE LIGHTS
	ELECTRO SHAVE POINT
	L.V UNDER CUPD. LIGHTING
	5 AMP LIGHTING (DIMMABLE)
	SENSOR TO WINDOW
	H/LEVEL MOVEMENT SENSOR
	ENTRY PHONE
	SPEAKER

CHALLINOR HALL ASSOCIATES

Architectural Design Consultants

The Mews studio

102a Longstone Road

Eastbourne BN21 3SJ Tel 01323 411933

Client

WIGMORE INVESTMENTS Ltd

Project Title

CHANGE OF USE FROM OFFICES TO
SINGLE PRIVATE DWELLING

6 ENDSLEIGH STREET
LONDON WC1H 0DZ

Drawing Title

SECOND FLOOR PLANS
(existing, proposed & electrical layout)

Scale
1 : 50 (A1)

Copyright 2006

Date
OCTOBER 2008

Drawn By
LW

Revisions		
A	JUNE 08	electrical layout plan amended and
B	OCT 08	clients amendments added
C	OCT 08	FURTHER CLIENT AMENDMENTS
d	april 09	PLANNERS AMENDMENTS