



SECOND FLOOR PLAN (GIA = 70.90 m2)
AS EXISTING

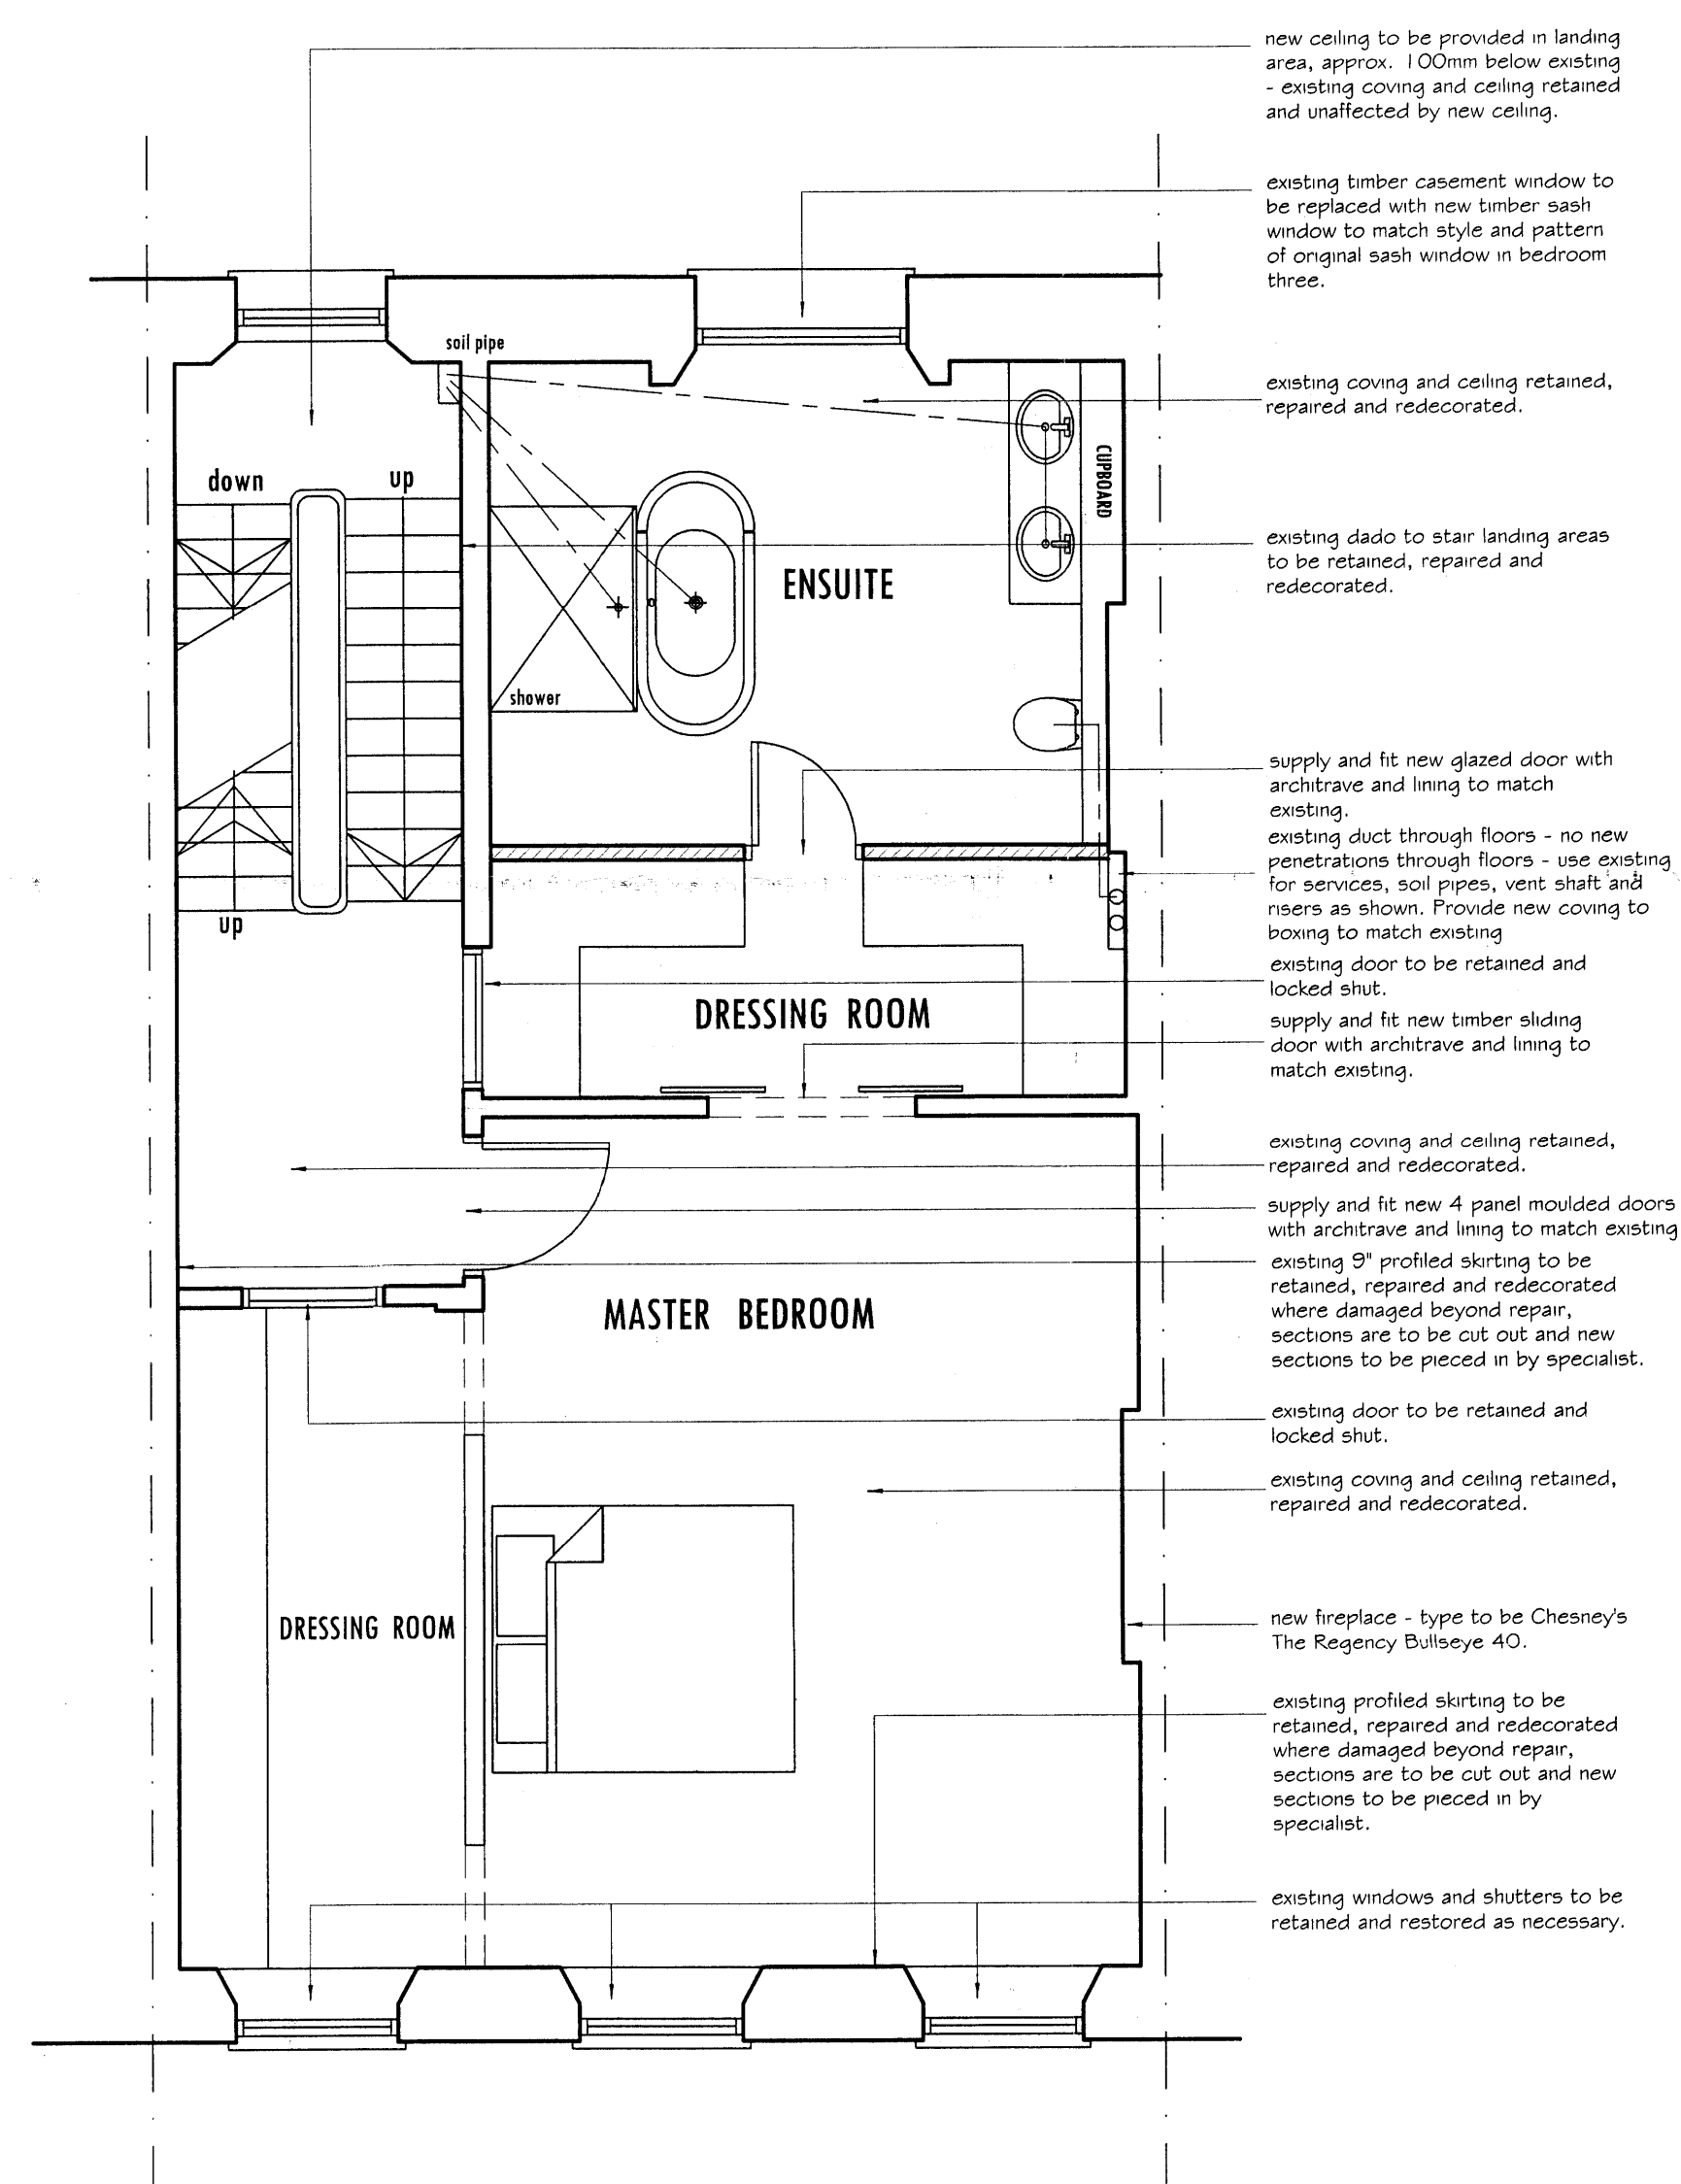

SECOND FLOOR PLAN
AS PROPOSED

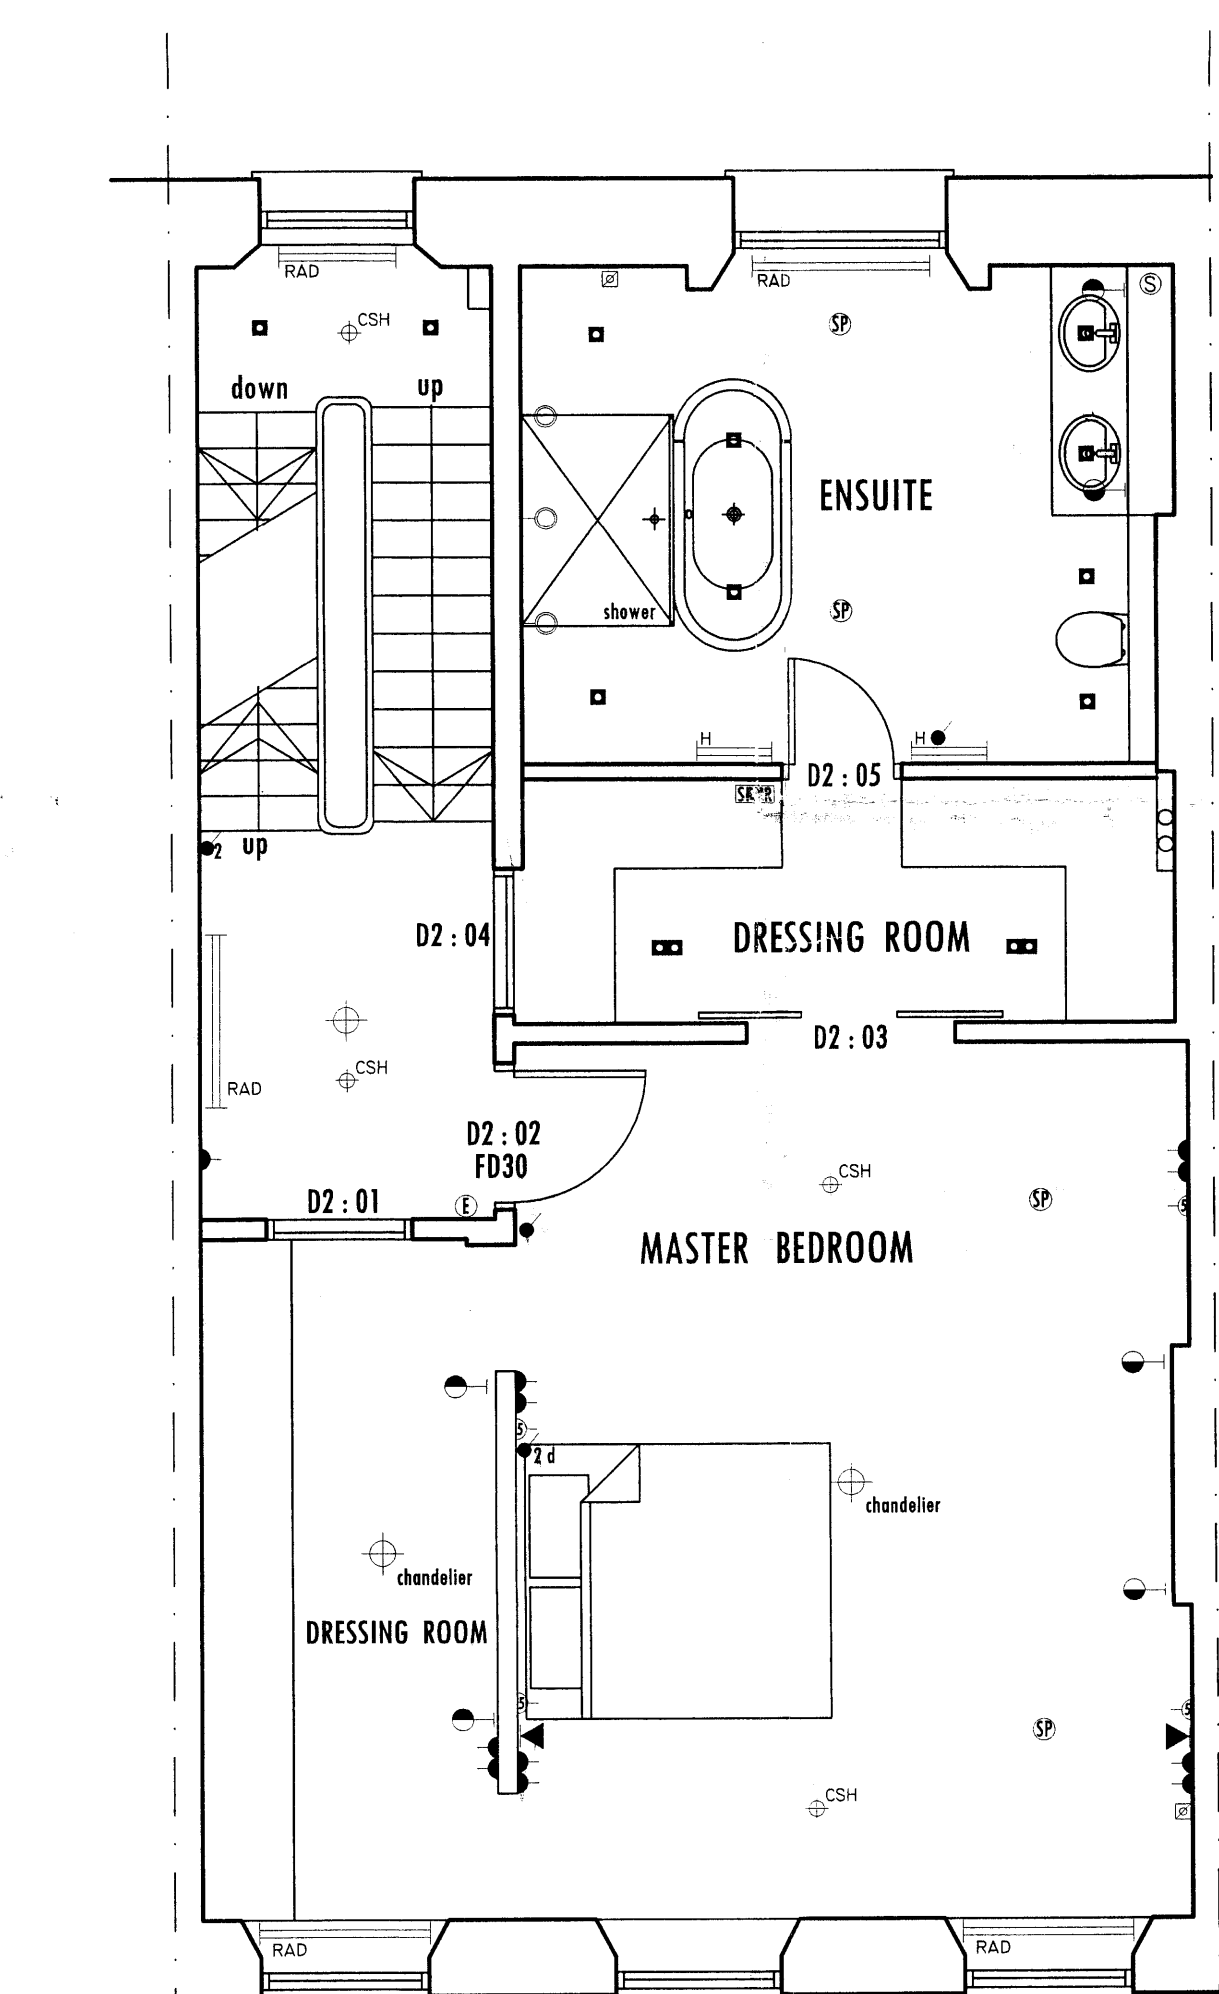

SECOND FLOOR PLAN - ELECTRICAL LAYOUT

DOOR SCHEDULE	
D2 : 01	4 PANELLED DOOR AS EXISTING LOCKED SHUT
D2 : 02	4 PANELLED DOOR
D2 : 03	SLIDING DOUBLE DOORS
D2 : 04	4 PANELLED DOOR AS EXISTING LOCKED SHUT
D2 : 05	GLAZED DOOR

(GIA = 70.90 m2)

NOTES :
Do not scale from this drawing.
Use figured dimensions only.
Figured dimensions are in millimetres.

All specified products and materials are to be fitted and installed in accordance with the manufacturers specifications and instructions.

All building works are to be carried out in strict accordance with the current Building Regulations and Codes of Practice.

LEGEND

SD	SMOKE DETECTORS
SPUR	FUSED SPUR OUTLET (LOW LEVEL)
WALL LIGHT FITTING	
EXTERNAL WALL LANTERN	
LOW LEVEL WALL LIGHT FITTING	
PENDANT LIGHT FITTING	
SWITCHED DOUBLE SOCKET	
SWITCHED SINGLE SOCKET	
RAD	RADIATOR
L.V DOWN LIGHT - DOUBLE FITTING	
L.V DOWN LIGHT - SINGLE FITTING	
PULL CORD	
ONE WAY SWITCH	
TWO WAY SWITCH	
DIMMER SWITCH	
HEATED TOWEL RAIL	
TV JACK	
TELEPHONE JACK	
CEILING SPRINKLER HEAD	
WARDROBE LIGHTS	
ELECTRO SHAVE POINT	
L.V UNDER CUPD. LIGHTING	
5 AMP LIGHTING (DIMMABLE)	
SENSOR TO WINDOW	
H/LEVEL MOVEMENT SENSOR	
ENTRY PHONE	
SPEAKER	

CHALLINOR HALL ASSOCIATES

Architectural Design Consultants
The Mews studio
102a Longstone Road
Eastbourne BN21 3SJ Tel 01323 411933

Client
WIGMORE INVESTMENTS Ltd

Project Title
CHANGE OF USE FROM OFFICES TO
SINGLE PRIVATE DWELLING
6 ENDSLEIGH STREET
LONDON WC1H 0DZ

Drawing Title
SECOND FLOOR PLANS
(existing, proposed & electrical layout)
As approved

Scale
1 : 50 (A1)

Date
OCTOBER 2008

Revisions	
A	JUNE 08 electrical layout plan amended and
B	OCT 08 clients amendments added
C	OCT 08 FURTHER CLIENT AMENDMENTS
d	april 09 PLANNERS AMENDMENTS