



FIRST FLOOR PLAN (GIA = 70.90 m2)
AS EXISTING

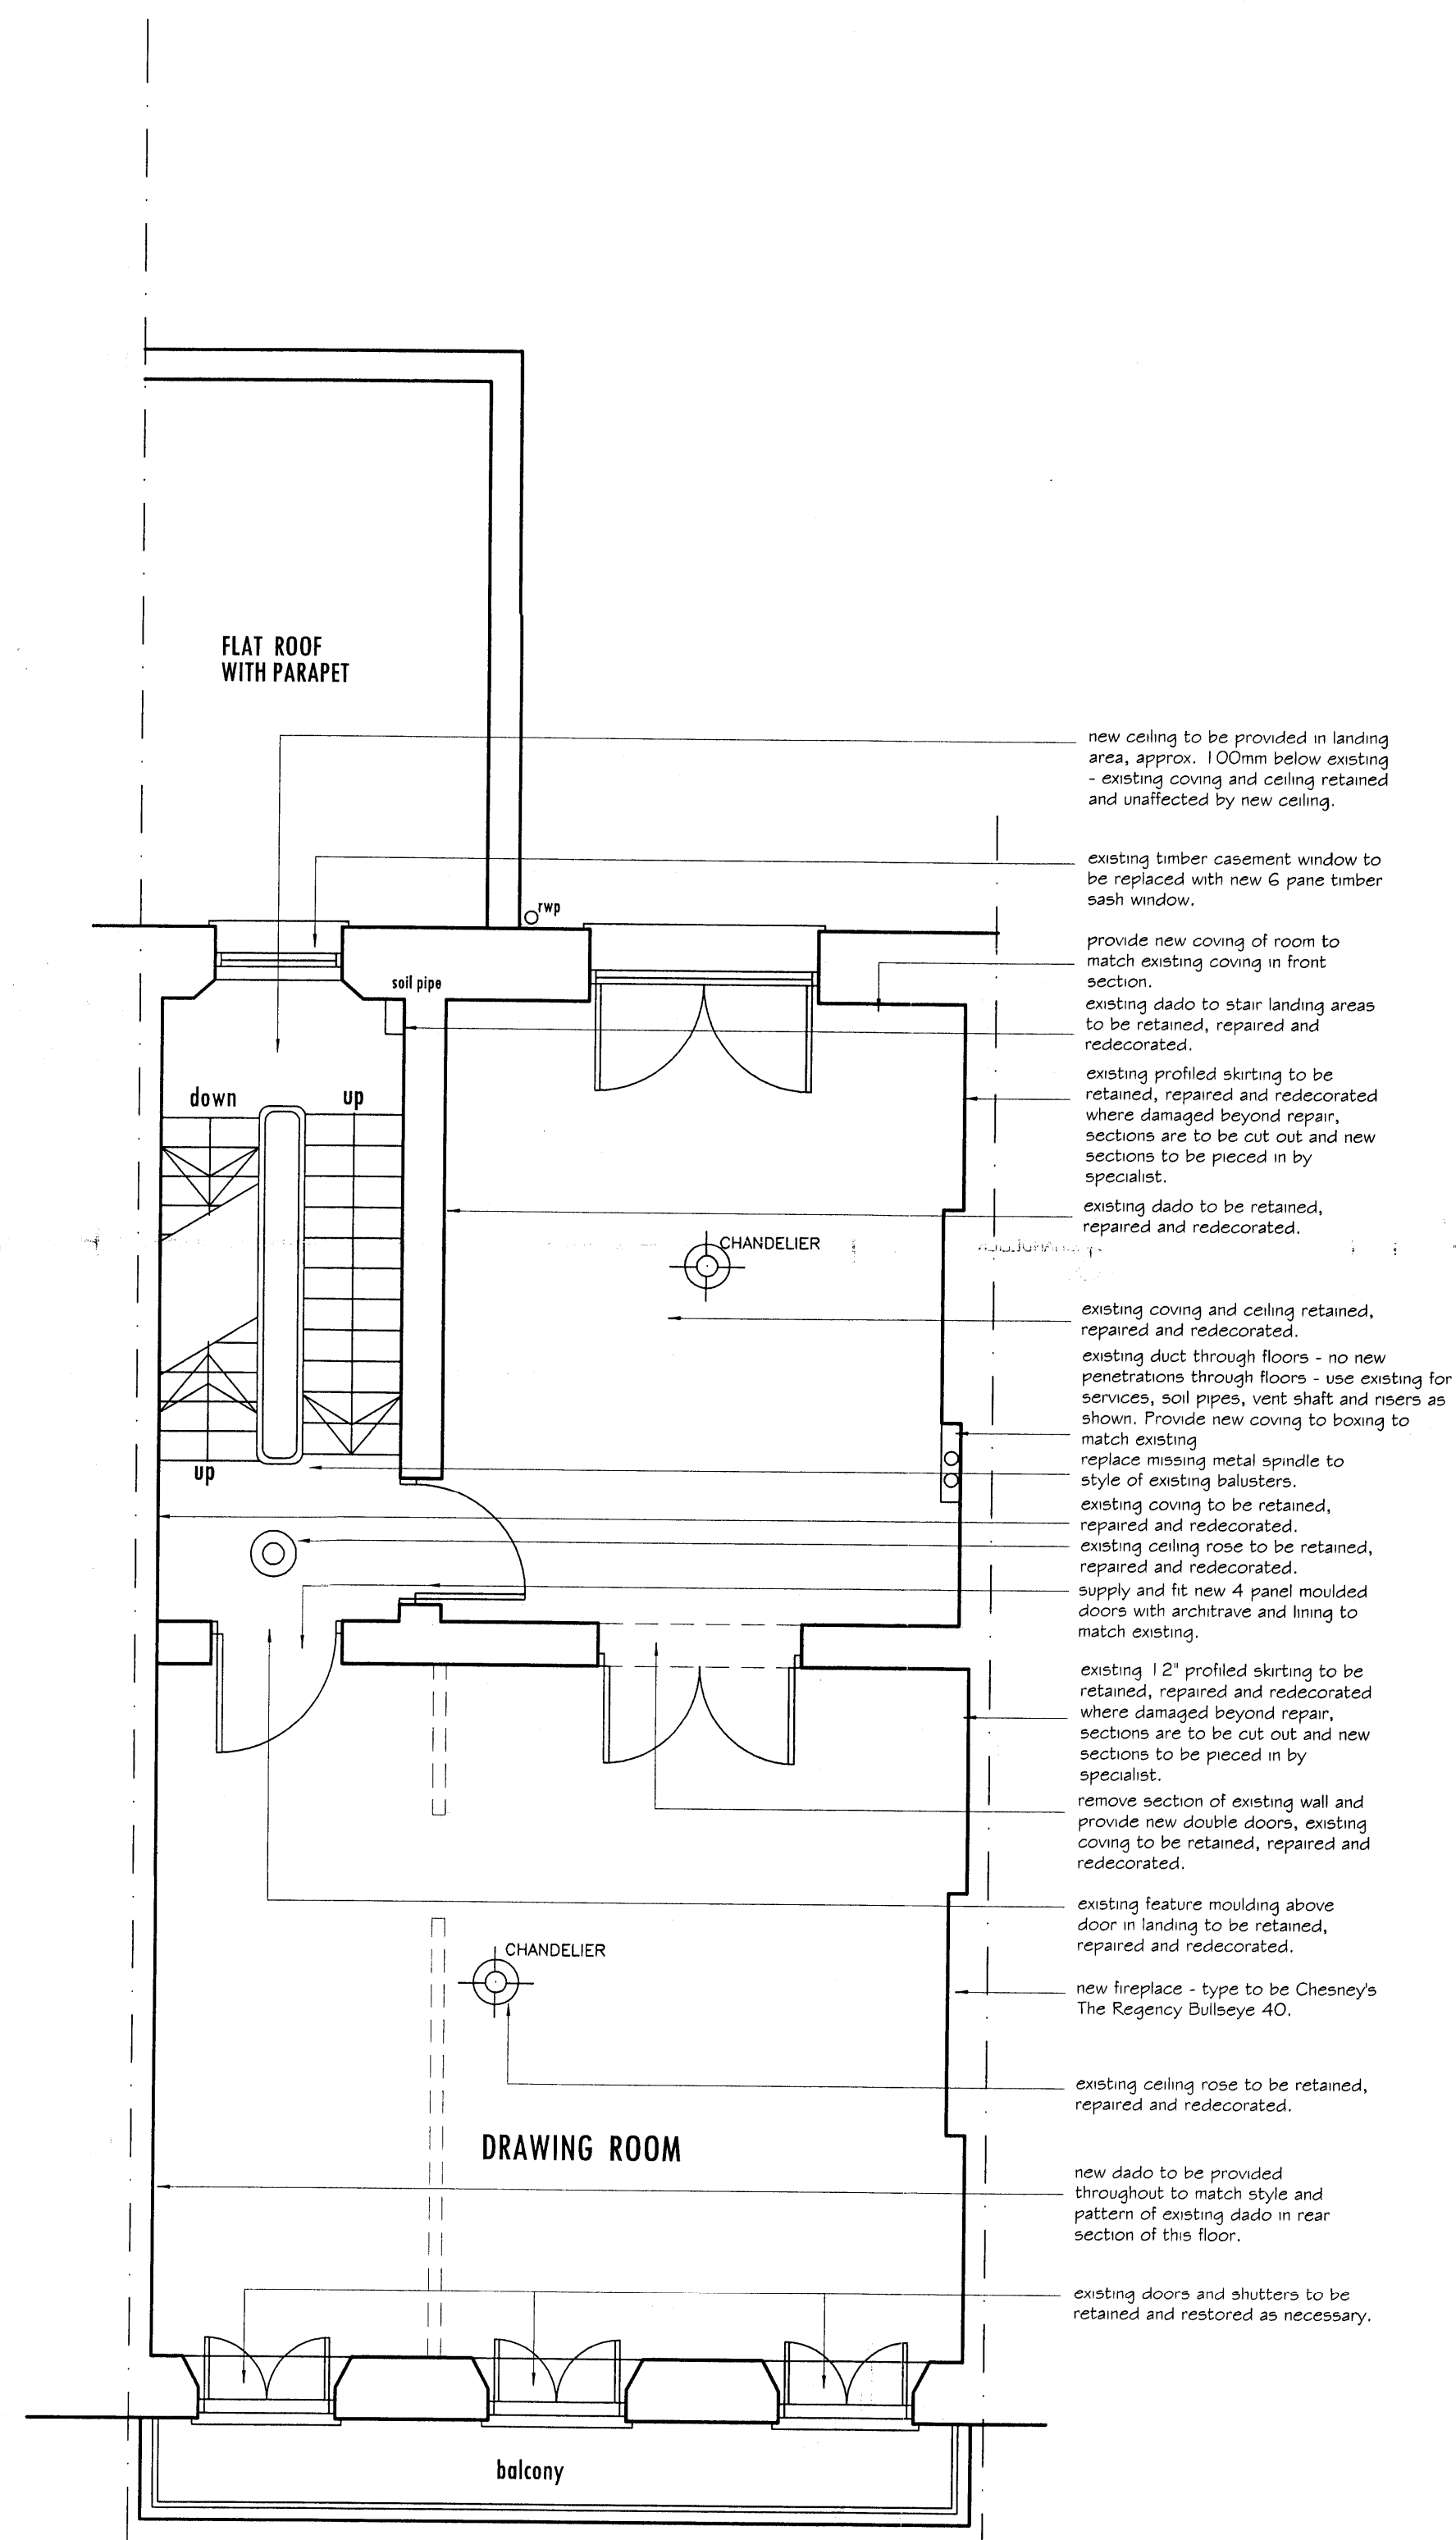

FIRST FLOOR PLAN
AS PROPOSED

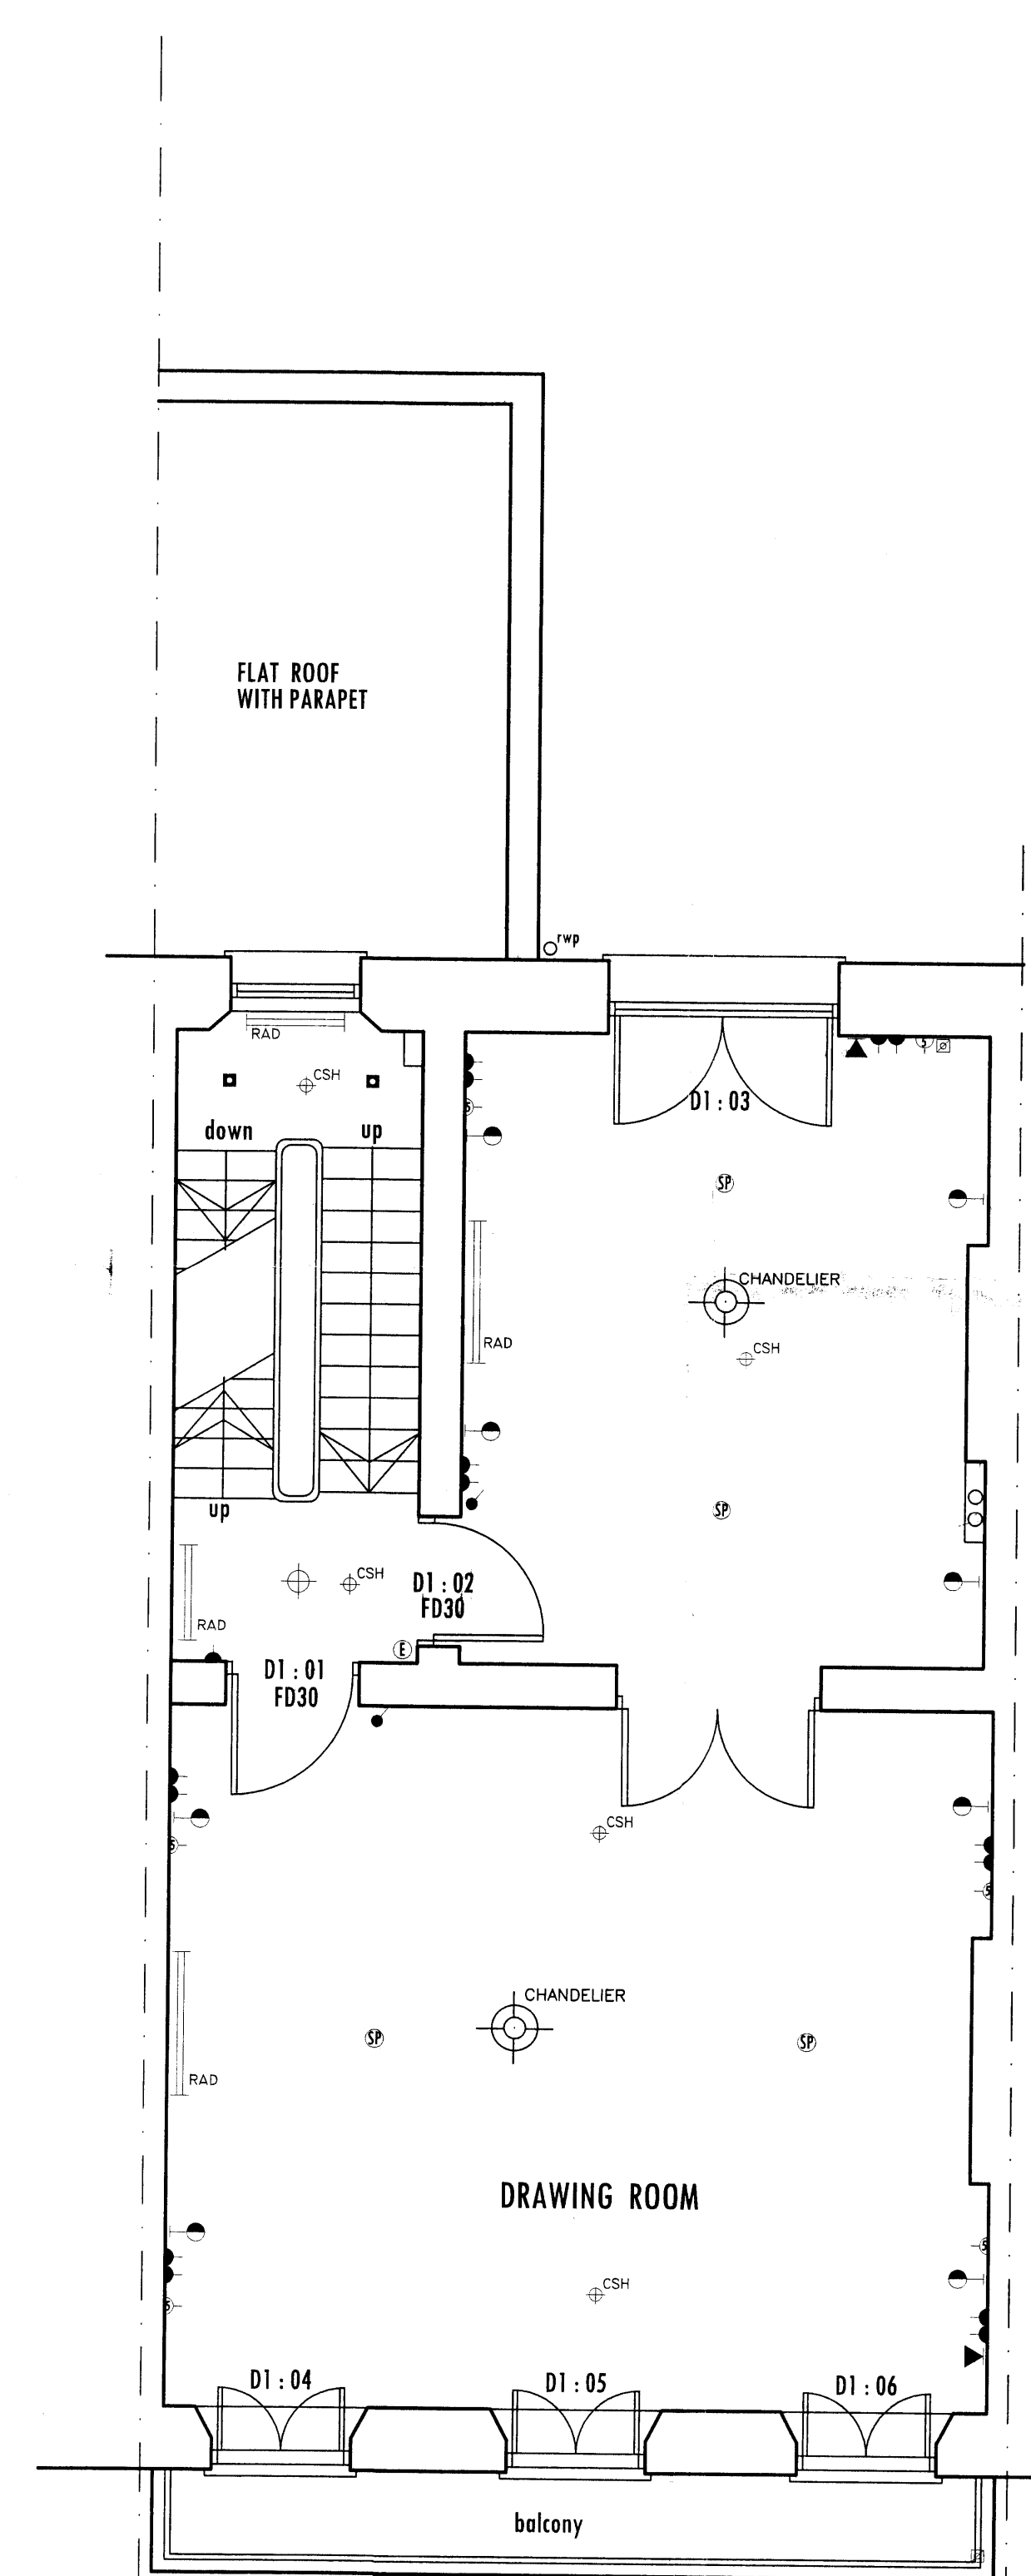

FIRST FLOOR PLAN - ELECTRICAL LAYOUT

DOOR SCHEDULE	
D1 : 01	4 PANELLED DOOR
D1 : 02	4 PANELLED DOOR
D1 : 03	EXISTING GLAZED DOORS
D1 : 04	EXISTING GLAZED DOORS
D1 : 05	EXISTING GLAZED DOORS
D1 : 06	EXISTING GLAZED DOORS

(GIA = 70.90 m2)

NOTES :
Do not scale from this drawing.
Use figured dimensions only.
Figured dimensions are in millimetres.

All specified products and materials are to be fitted and installed in accordance with the manufacturers specifications and instructions.

All building works are to be carried out in strict accordance with the current Building Regulations and Codes of Practice.

LEGEND

SD	SMOKE DETECTORS
SPUR	FUSED SPUR OUTLET (LOW LEVEL)
WALL LIGHT FITTING	WALL LIGHT FITTING
EXTERNAL WALL LANTERN	EXTERNAL WALL LANTERN
LOW LEVEL WALL LIGHT FITTING	LOW LEVEL WALL LIGHT FITTING
PENDANT LIGHT FITTING	PENDANT LIGHT FITTING
SWITCHED DOUBLE SOCKET	SWITCHED DOUBLE SOCKET
SWITCHED SINGLE SOCKET	SWITCHED SINGLE SOCKET
RAD	RADIATOR
LV DOWN LIGHT - DOUBLE FITTING	LV DOWN LIGHT - DOUBLE FITTING
LV DOWN LIGHT - SINGLE FITTING	LV DOWN LIGHT - SINGLE FITTING
PULL CORD	PULL CORD
ONE WAY SWITCH	ONE WAY SWITCH
TWO WAY SWITCH	TWO WAY SWITCH
DIMMER SWITCH	DIMMER SWITCH
HEATED TOWEL RAIL	HEATED TOWEL RAIL
TV JACK	TV JACK
TELEPHONE JACK	TELEPHONE JACK
CEILING SPRINKLER HEAD	CEILING SPRINKLER HEAD
WARDROBE LIGHTS	WARDROBE LIGHTS
ELECTRO SHAVE POINT	ELECTRO SHAVE POINT
LV UNDER CUPD. LIGHTING	LV UNDER CUPD. LIGHTING
5 AMP LIGHTING (DIMMMABLE)	5 AMP LIGHTING (DIMMMABLE)
SENSOR TO WINDOW	SENSOR TO WINDOW
HI LEVEL MOVEMENT SENSOR	HI LEVEL MOVEMENT SENSOR
ENTRY PHONE	ENTRY PHONE
SPEAKER	SPEAKER

CHALLINOR HALL ASSOCIATES

Architectural Design Consultants

The Mews studio

102a Longstone Road

Eastbourne BN21 3SJ Tel 01323 411933

Client

WIGMORE INVESTMENTS Ltd

Project Title

CHANGE OF USE FROM OFFICES TO
SINGLE PRIVATE DWELLING

6 ENDSLEIGH STREET
LONDON WC1H 0DZ

Drawing Title

FIRST FLOOR PLANS
(existing, proposed & electrical layout)

As approved

Scale
1 : 50 (A1)

Copyright 2008

Date
OCTOBER 2008

Drawn By
LW

Revisions

A	JUNE 08	electrical layout plan amended
B	OCT 08	clients amendments added
C	OCT 08	FURTHER CLIENT AMENDMENTS
d	APR 09	PLANNERS AMENDMENTS