



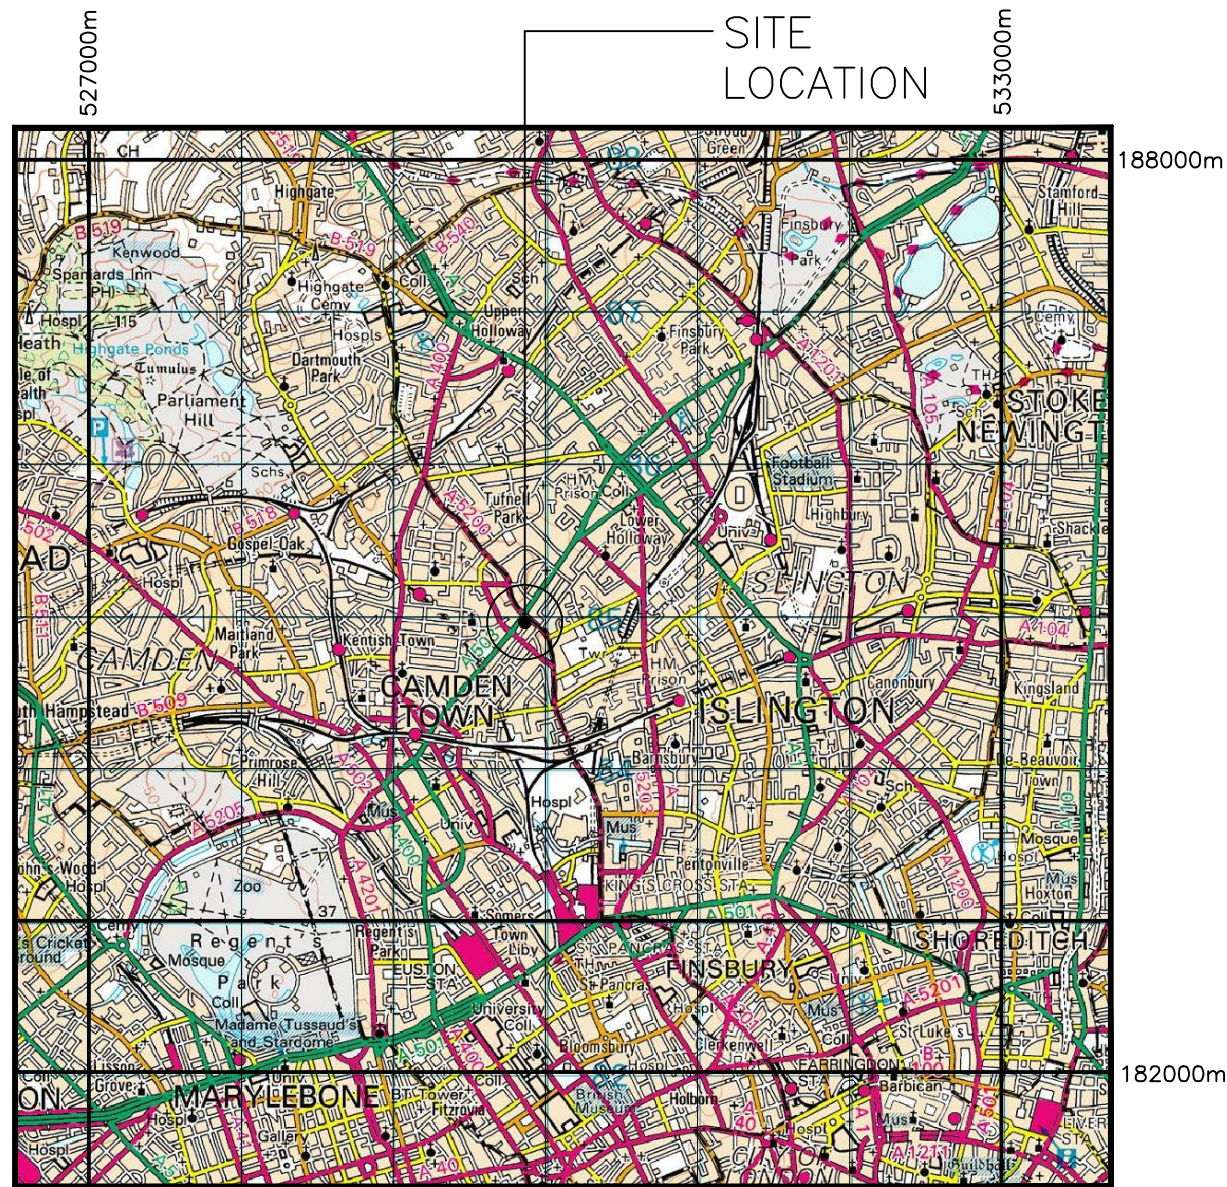

SITE GRID REFERENCE 529923E 184852N
SCALE 1:50000

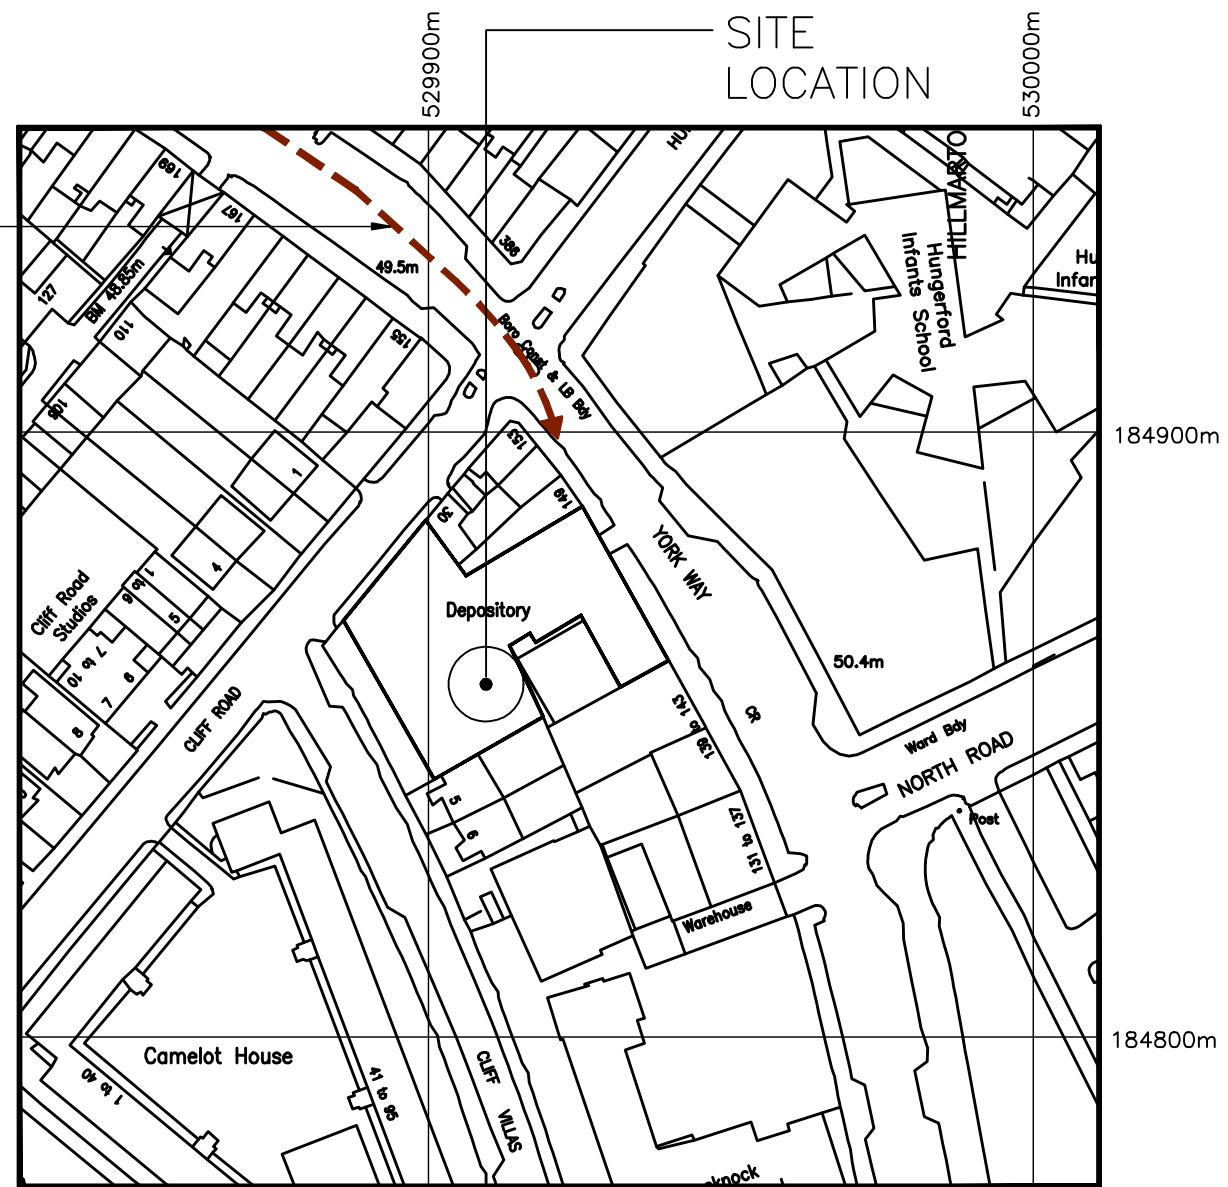

SITE GRID REFERENCE 529923E 184852N
SCALE 1:1250




SITE PHOTOGRAPH

NOTES:

1. FROM END OF M1 HEAD SOUTHEAST TOWARD NORTH CIRCULAR ROAD (A406). TAKE A SLIGHT RIGHT AT FALLODEN WAY/A1 UNTIL JUNCTION ROAD. TURN LEFT AT BRECKNOCK ROAD/A5200 WHICH BECOMES YORK WAY
2. SURROUNDING AREA IS COMMERCIAL.
3. DISTANCE TO PUBLIC HIGHWAY APPROX. 5m

REPRODUCED FROM ORDNANCE SURVEY WITH THE PERMISSION OF THE CONTROLLER OF HER MAJESTY'S STATIONERY OFFICE.
© CROWN COPYRIGHT. LICENCE NO. AL100034583

REV.	DATE	REMARKS	BY	CHK.

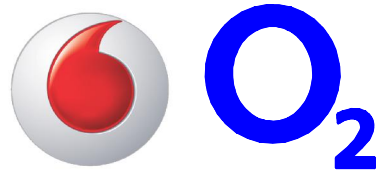

CORNERSTONE PROJECT



Tyco Electronics
Tyco Electronics UK Infrastructure Ltd.
Harlot House
Harlot Road
Chersey, Surrey
KT16 8DT
Telephone 01832 575 900 Fax 01832 575 901

CELL NAME	OPTION	DRAWN	CHECKED	APPROVED	DATE	SCALE
ABC SELF STORAGE	A	SPD	NDS	SY	22.05.10	AS SHOWN
SITE ADDRESS		CORNERSTONE ID	HOST ID	SHARER ID		
145-147 YORK WAY LONDON N7 9LG		CS - 14698	02 - 009091	VF - 80451		
DRAWING TITLE		CONSULTANT REF No.		PURPOSE OF ISSUE	DRAWING No.	REVISION
SITE LOCATION MAPS		1330/044		PLANNING	100	-



OPCS POLE MOUNTED ANTENNAS

'3' POLE MOUNTED ANTENNAS

OPCS POLE MOUNTED ANTENNAS

ORANGE EQUIPMENT CABINETS ON STEEL SUPPORT FRAME

OPCS CABLE TRAY

OPCS POLE MOUNTED ANTENNAS

'3' EQUIPMENT CABINETS ON STEEL SUPPORT FRAME

O₂ (UK) 2No. 900 ANTENNAS MOUNTED ON SUPPORT FIXED TO TRIPOD.

O₂ (UK) CABLE TRAY
PROPOSED VODAFONE RRU'S TO BE MOUNTED ON HANDRAIL

PROPOSED REMOVAL OF 2No O₂ (UK) 2100 ANTENNAS AND REPLACE WITH 2No O₂ (UK)/VODAFONE 2100/2100 ANTENNAS MOUNTED ON STAND-OFF BRACKETS, FIXED TO TRIPOD.

PROPOSED 100 WIDE CABLE TRAY TO ACCOMMODATE VODAFONE POWER AND FIBRE CABLES

O₂ (UK) EQUIPMENT CABIN MOUNTED ON STEEL SUPPORT FRAME.

PROPOSED LOCATION OF VODAFONE EQUIPMENT WITHIN O₂ (UK) CABIN.

STEP-OVER

'3' POLE MOUNTED ANTENNAS

LIFT MOTOR ROOM

MAIN ROOF LEVEL +20.0m

'3' CABLE TRAY

'3' POLE MOUNTED ANTENNAS


OPCS POLE MOUNTED ANTENNAS

ELEVATION 'A'

ROOF LAYOUT PLAN

SCALE 1:200

- NOTES:**
1. ALL DIMENSIONS ARE IN MILLIMETRES UNLESS OTHERWISE SPECIFIED
 2. ASSUME ALL SITE DETAILS ARE EXISTING UNLESS OTHERWISE NOTED.
 3. THE DRAWINGS COMPLY WITH O₂ (UK) & VODAFONE STANDARD ICNIRP GUIDELINES.

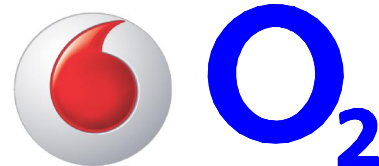

CORNERSTONE PROJECT



Tyco Electronics UK Infrastructure Ltd.
Harlot House
Harlot Road
Chermsley, Surrey
KT16 8DT

Telephone 01832 575 900 Fax 01832 575 901

CELL NAME
ABC SELF STORAGE

OPTION
A

DRAWN SPD	CHECKED NDS	APPROVED SY	DATE 22.05.10	SCALE AS SHOWN
--------------	----------------	----------------	------------------	-------------------

SITE ADDRESS
145-147 YORK WAY
LONDON
N7 9LG


CORNERSTONE ID CS - 14698	HOST ID O2 - 009091	SHARER ID VF - 80451
------------------------------	------------------------	-------------------------

CONSULTANT REF No.
1330/044

DRAWING TITLE
SITE PLAN

PURPOSE OF ISSUE PLANNING	DRAWING No. 200	REVISION A
------------------------------	--------------------	---------------


REV.	DATE	REMARKS	BY	CHK.
A	09.07.10	ANTENNA NOTES AMENDED	GW	NDS

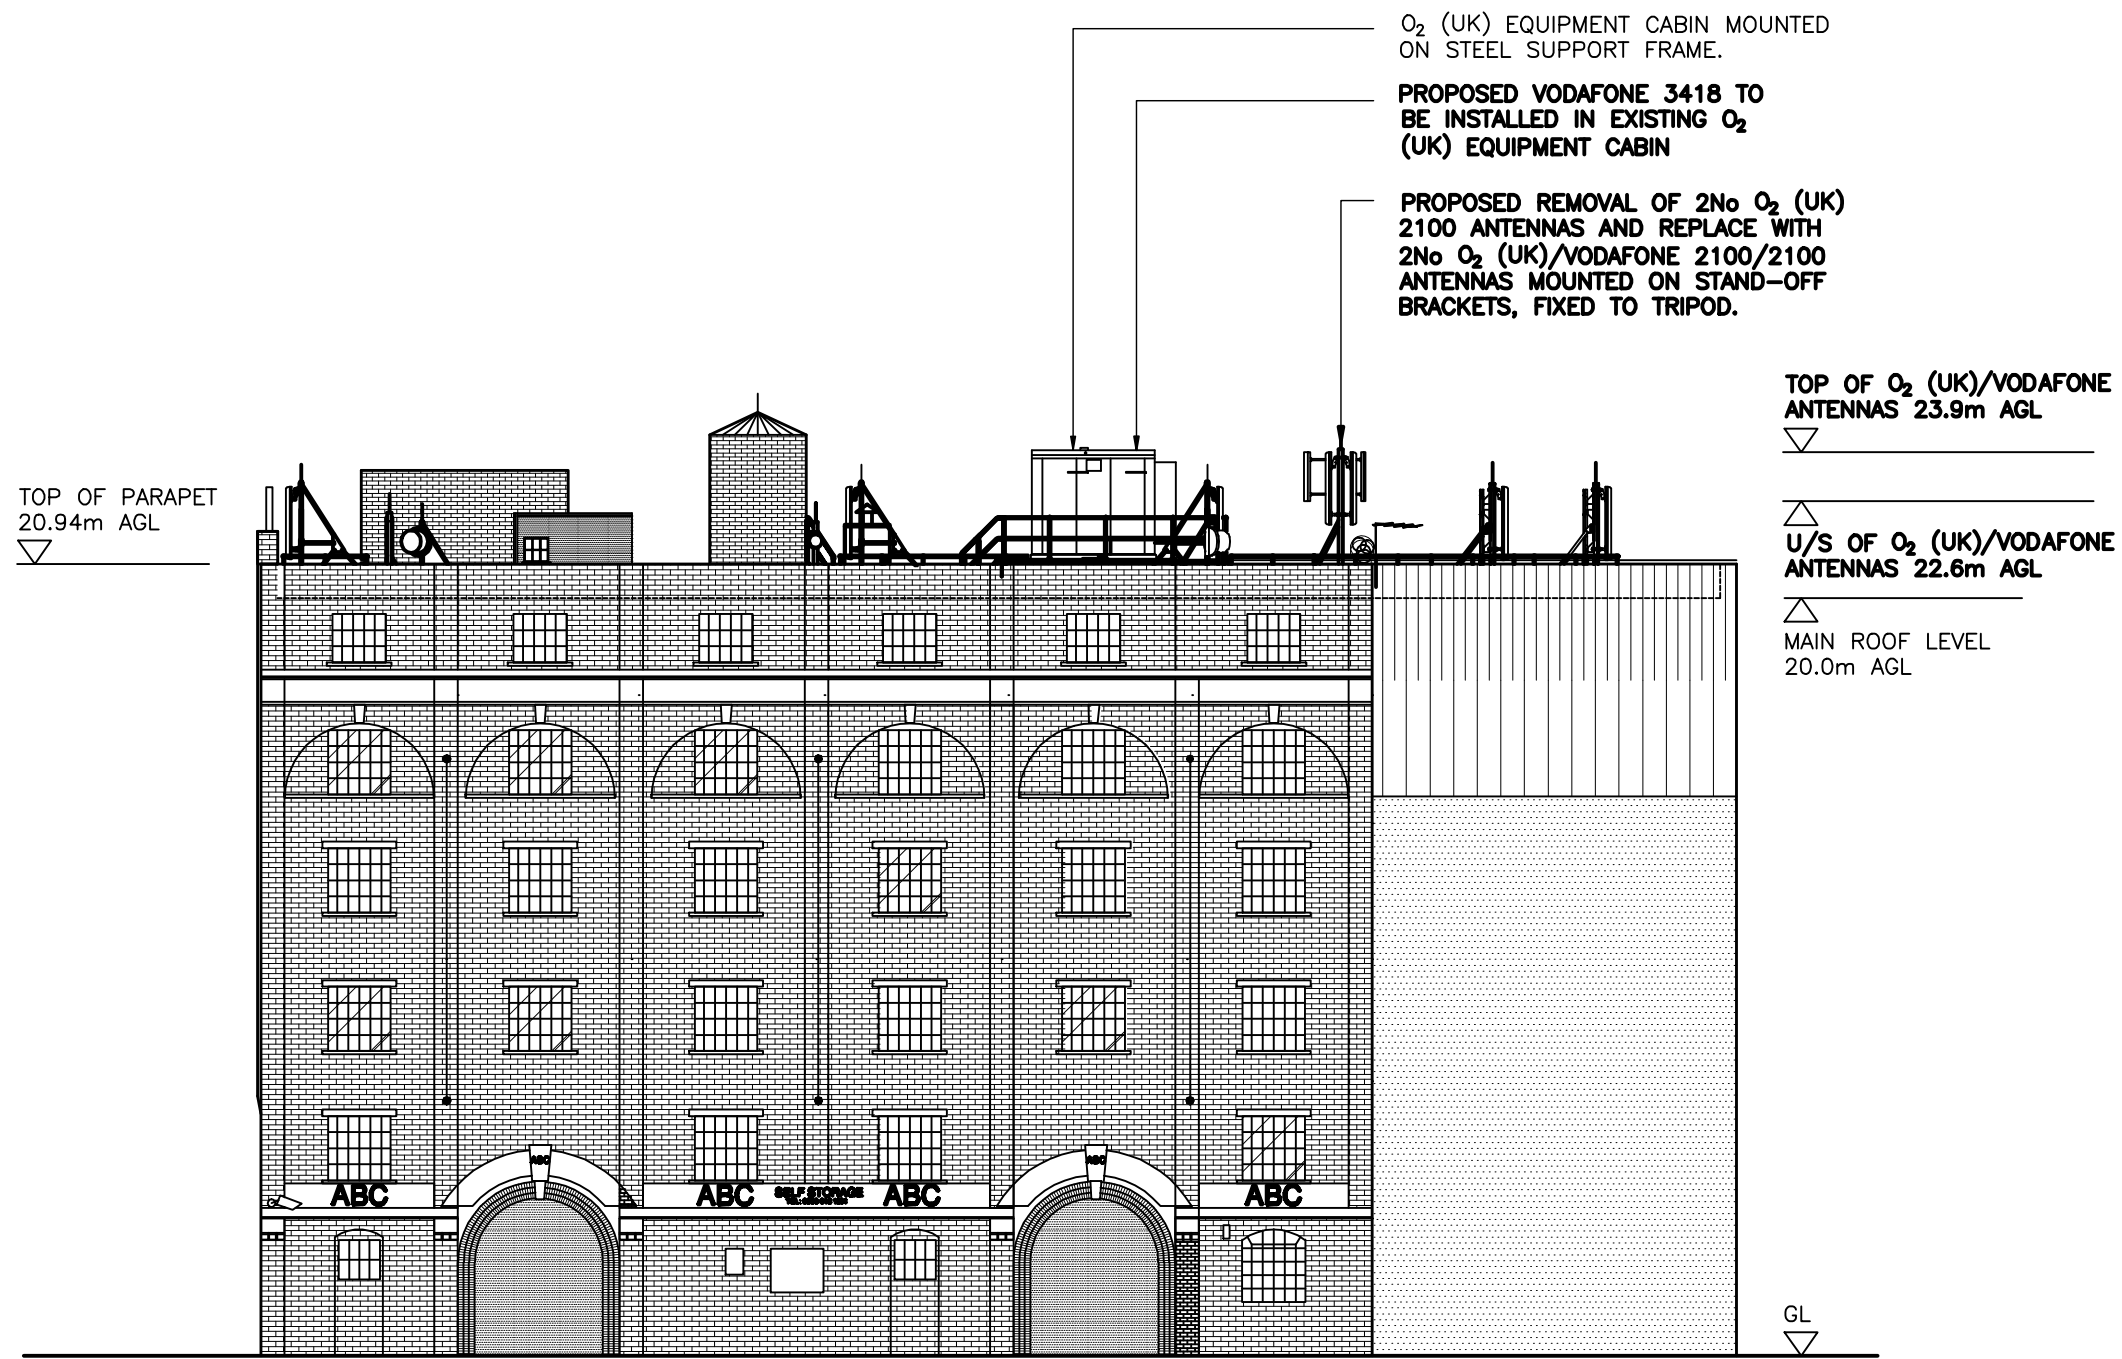

ELEVATION 'A'
SCALE 1:200

- NOTES:
1. ALL DIMENSIONS ARE IN MILLIMETRES UNLESS OTHERWISE SPECIFIED
 2. ASSUME ALL SITE DETAILS ARE EXISTING UNLESS OTHERWISE NOTED.
 3. THE DRAWINGS COMPLY WITH O₂ (UK) & VODAFONE STANDARD ICNIRP GUIDELINES.

REV.	DATE	REMARKS	BY	CHK.
A	09.07.10	ANTENNAS AMENDED	GW	NDS

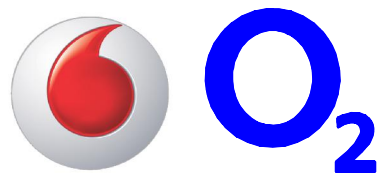


CORNERSTONE PROJECT



Tyco Electronics UK Infrastructure Ltd.
Harlot House
Harlot Road
Chermsley, Surrey
KT16 8DT


Telephone 01832 575 900 Fax 01832 575 901

CELL NAME	OPTION	DRAWN	CHECKED	APPROVED	DATE	SCALE
ABC SELF STORAGE	A	SPD	NDS	SY	22.05.10	AS SHOWN
SITE ADDRESS 145-147 YORK WAY LONDON N7 9LG	CORNERSTONE ID CS - 14698		HOST ID 02 - 009091		SHARER ID VF - 80451	
	CONSULTANT REF No. 1330/044					
	DRAWING TITLE PROPOSED ELEVATION		PURPOSE OF ISSUE PLANNING	DRAWING No. 300		REVISION A

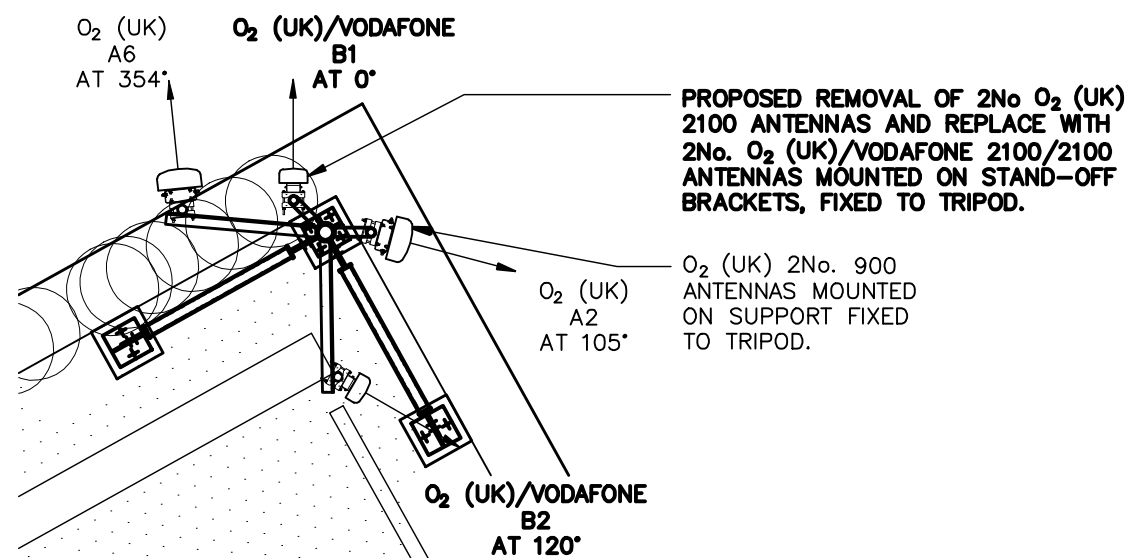

PROPOSED ANTENNA PLAN (CELLS 1 & 3)

SCALE 1:50

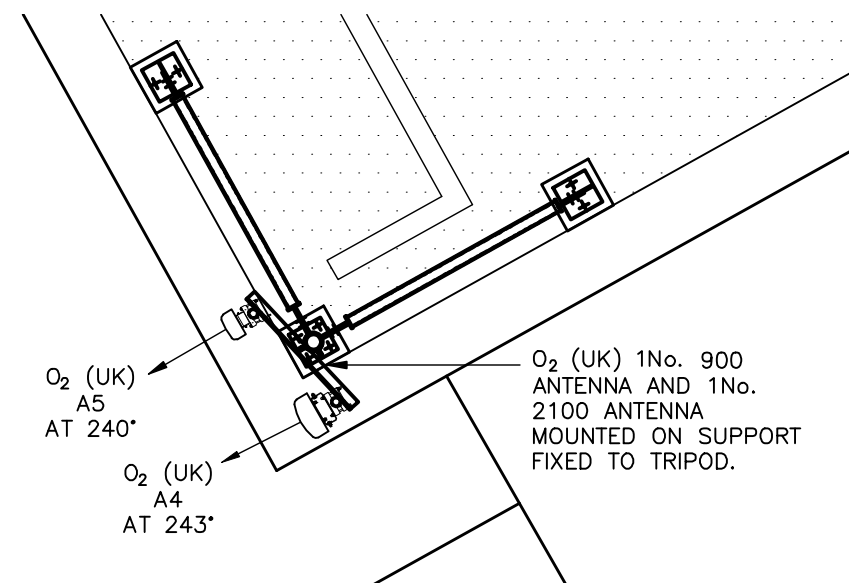

PROPOSED ANTENNA PLAN (CELL 2)

SCALE 1:50




PROPOSED TRANSIT GLAND TO BE INSTALLED TO ACCOMMODATE VODAFONE DC AND FIBRE CABLES

PROPOSED VODAFONE RBS 3418 MODULES TO BE HOUSED WITHIN NEW ELTEK

PROPOSED REMOVAL OF O2 (UK) PSSS600 ETLEK SSU INDOOR

CABLE TRANSIT GLAND (0 SPARE WAYS)

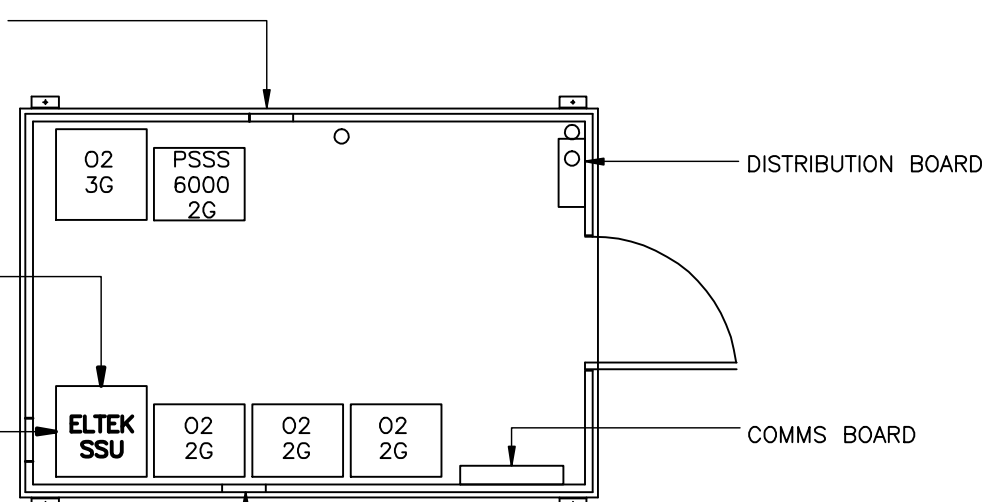


INTERNAL CABIN PLAN

SCALE 1:5100

- NOTES:
1. ALL DIMENSIONS ARE IN MILLIMETRES UNLESS OTHERWISE SPECIFIED
 2. ASSUME ALL SITE DETAILS ARE EXISTING UNLESS OTHERWISE NOTED.
 3. THE DRAWINGS COMPLY WITH O2 (UK) & VODAFONE STANDARD ICNIRP GUIDELINES.

REV.	DATE	REMARKS	BY	CHK.
A	09.07.10	ANTENNAS AMENDED	GW	AK

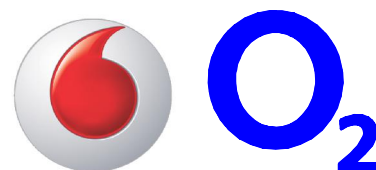

CORNERSTONE PROJECT



CELL NAME ABC SELF STORAGE	OPTION A	DRAWN SPD	CHECKED NDS	APPROVED SY	DATE 22.05.10	SCALE AS SHOWN
SITE ADDRESS 145-147 YORK WAY LONDON N7 9LG		CORNERSTONE ID CS - 14698		HOST ID 02 - 009091		SHARER ID VF - 80451
		CONSULTANT REF No. 1330/044				
		DRAWING TITLE ANTENNA/EQUIPMENT LAYOUT		PURPOSE OF ISSUE PLANNING		DRAWING No. 400
				REVISION A		