
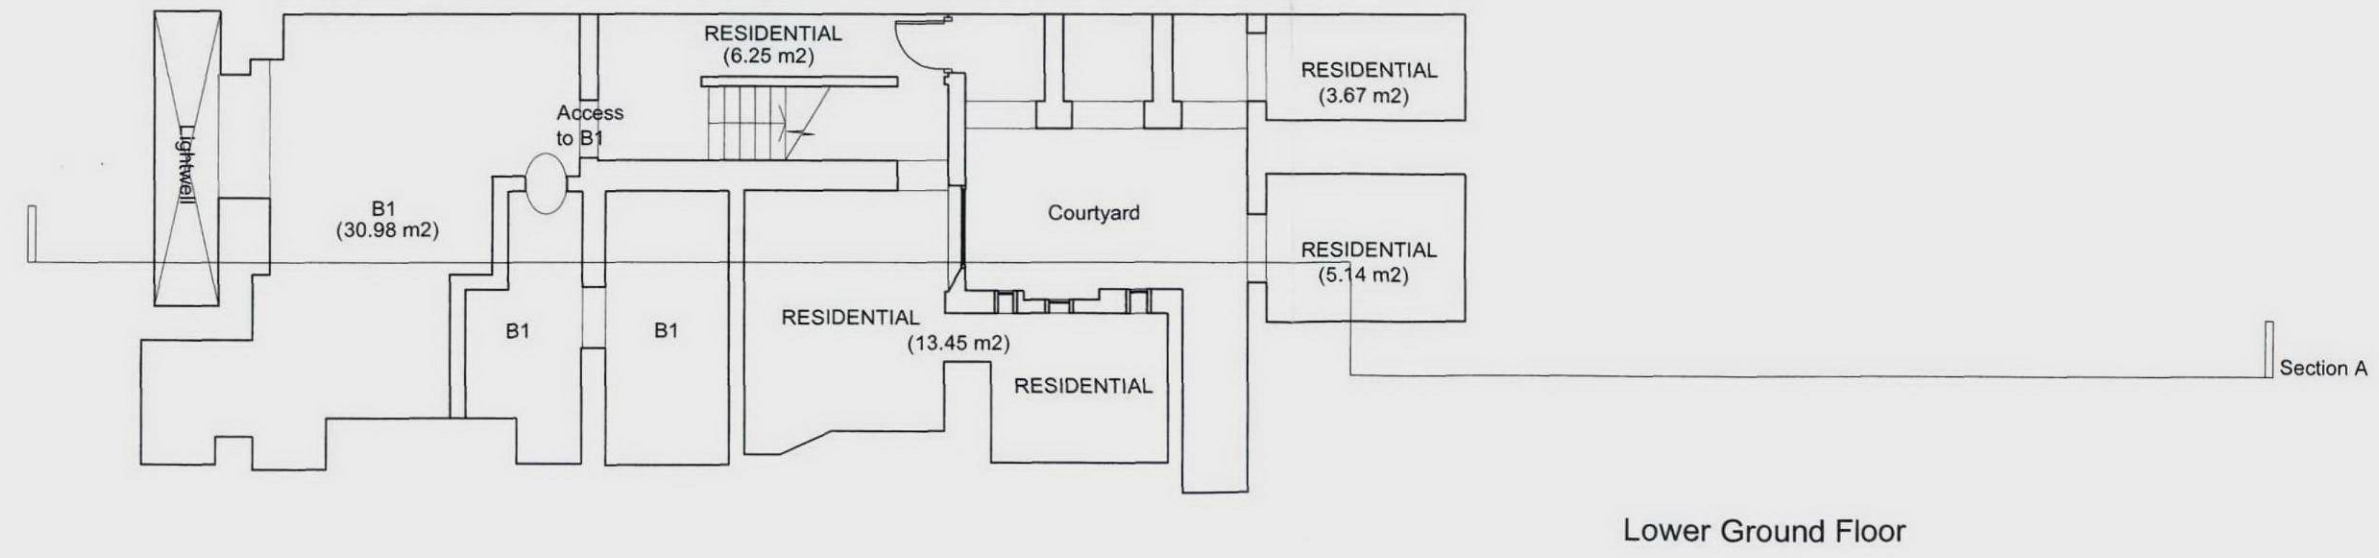
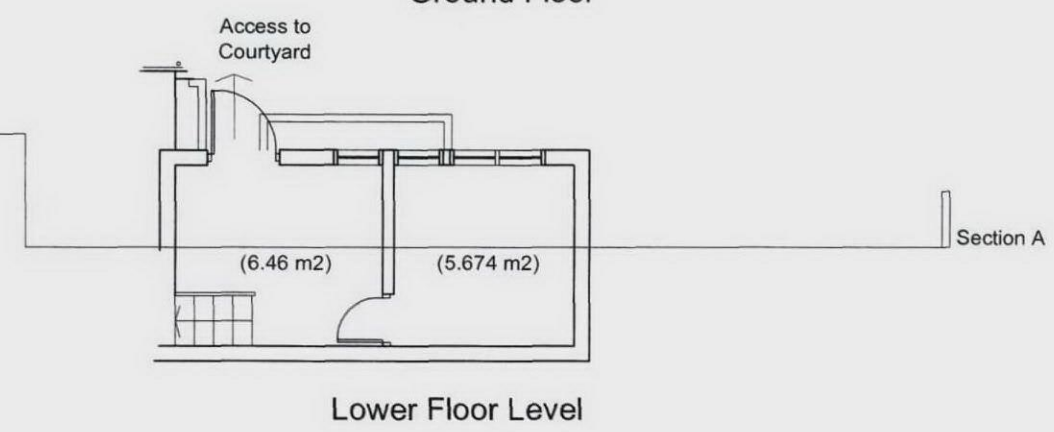


B. EXISTING PLANS

Camden ref:
2009/4688/P
prior planning

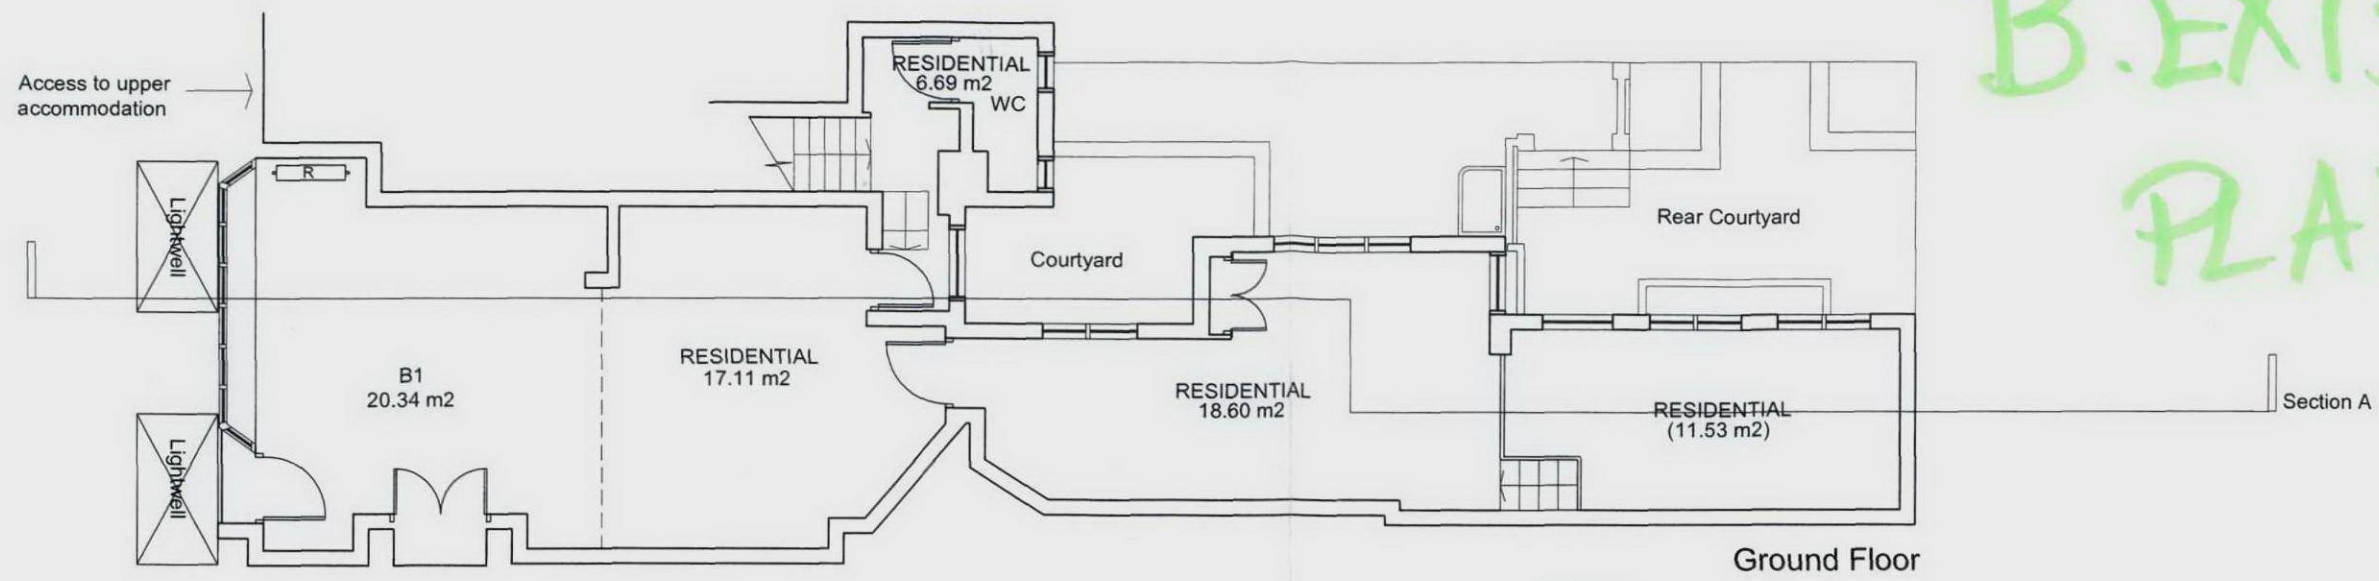

- notes:
1. Steelwork setting out to Structural Engineers Details.
 2. All dimensions to be checked on site.
 3. All dimensions are to masonry unless otherwise stated. (NB: Not plaster finishes).
 4. All information is to be checked and verified by the contractors and subcontractors for accuracy and fit.
 5. Discrepancies or omissions to be brought to the attention of Douglas and King prior to construction.
 6. Do not scale from this drawing.
 7. Refer to detailed design drawings for electrical layout.

Douglas & King Back Building 150 Curtain Road London EC2A 3AR t + 44 (020) 7613 1395 f + 44 (020) 7613 1389 info@douglasandking.com www.douglasandking.com	revision A	date 24.10.05	notes Hatching Removed.	project 36-38 Lambs Conduit Street	drawing title Proposed: Plans	scale 1:100 @ A3	date Feb 2004	survey
				client Danny Pope			drawing no LSC ga 001 A	