



Cast iron central core

Hollow core to accomodate 18 mm diameter electric supply for light fitting (tbc)

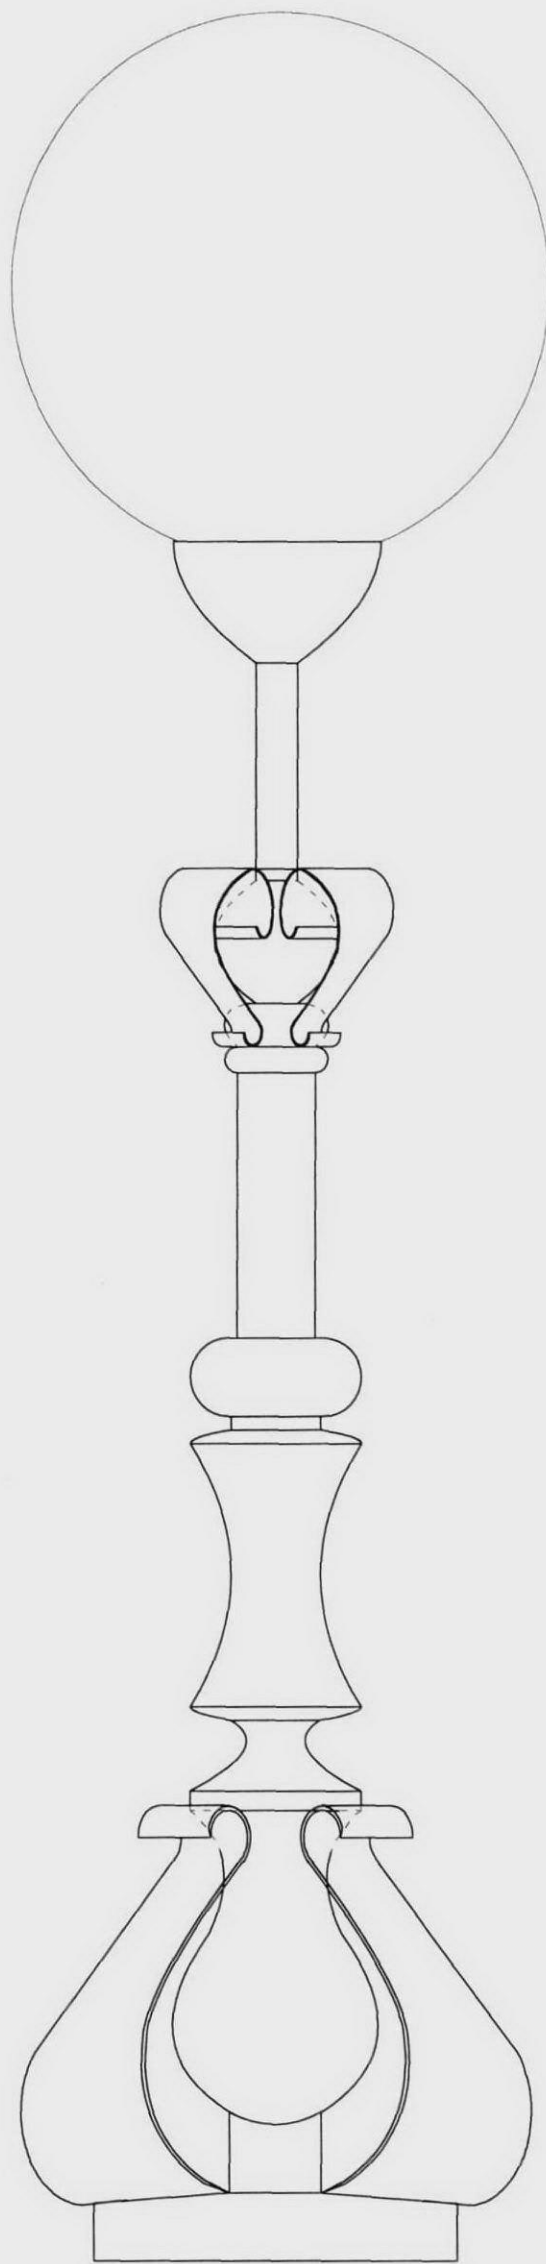

Front elevation with wrought iron decorations shown

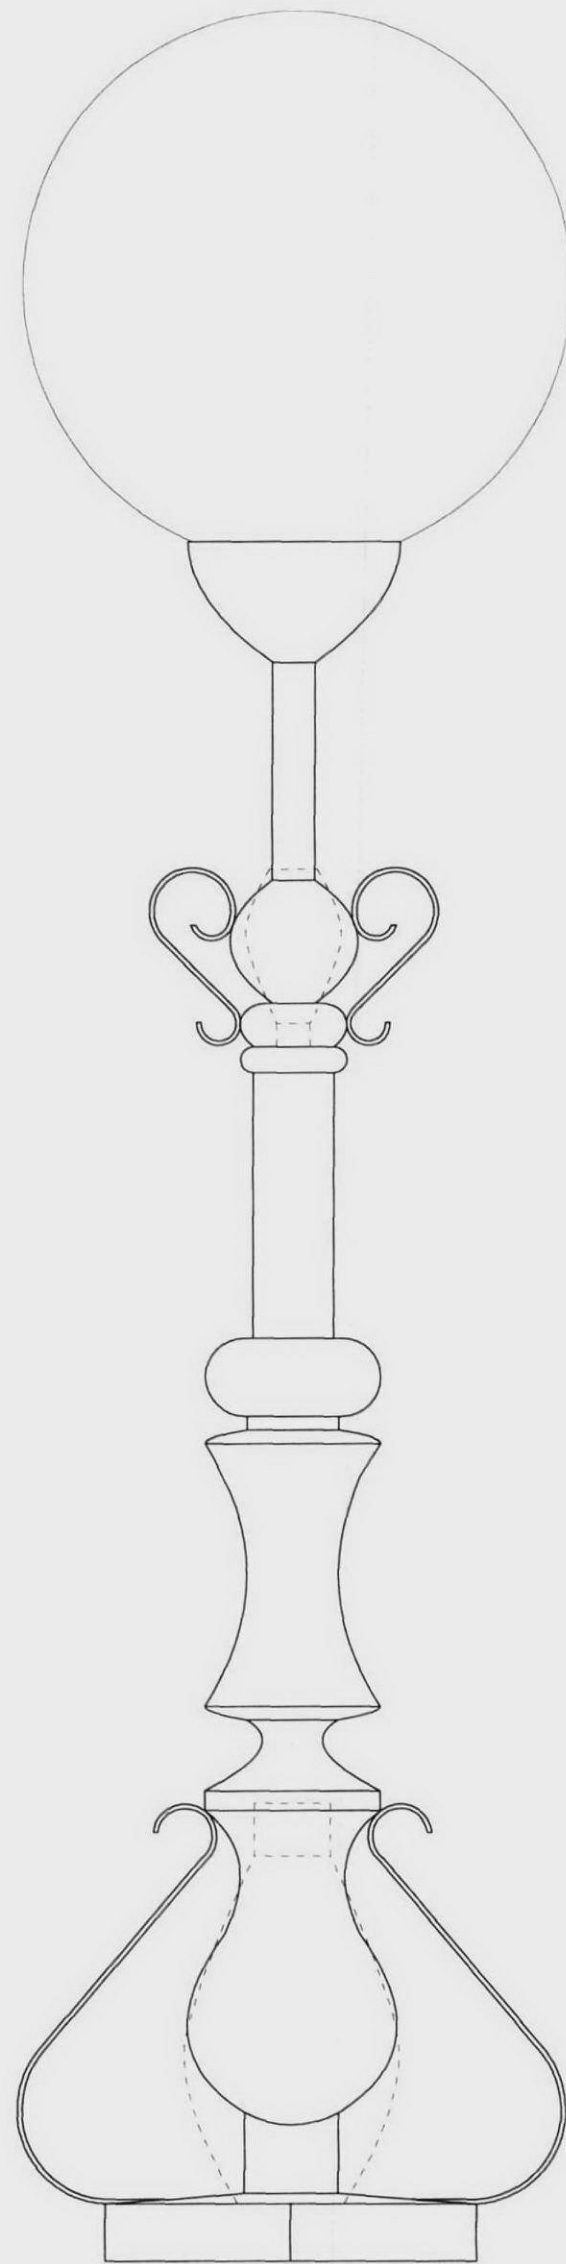

Section

LONDON BOROUGH OF CAMDEN
HIGHGATE BRANCH LIBRARY

Dannatt, Johnson Architects

52c Borough High Street, London, SE1 1XN
Telephone (020) 7357 7100 Fax (020) 7357 7200

DETAIL LAMP-HOLDERS
STATUS: PLANNING - LBC

Drawing Number
462-BD-03

Revision

-

Drawn

CF

Checked

Scale

1: 5
@ A3

Date

MAY 10