
 


 









 

 
 
 
 





MEANS OF ESCAPE AND EQUIPMENT:		FIRE FIGHTING EQUIPMENT:		OTHER CODES:	
	Fire Alarm Call Point		Fire Exit Sign with Emergency Light (suspended)		Areas Restricted in use (ie. store/maintenance)
	Control Panel Sounders		Fire Exit Sign (with direction)		Area not covered by this certificate
	Redundant Control Panel Sounders	SCA	Self closing door with auto release	POC	Pressurisation Override Control
	Control Panel Illuminated Signals	PB	Door with panic bolt	PR	Area covered by pressurisation system
	Control Panel sounders and Illuminated Signals	SF	Door with simple fastening	MSE	Area covered by Mechanical Smoke Extraction
	Break Glass for Key	TP	Fire alarm telephone point	NSE	Area covered by Natural Smoke Extraction
	Emergency Door Release	VP	Vision panel to door		Fire Alarm Panel
	Area Covered by Emergency Escape Lighting	S	Smoke seals		Kitchen - Hot Range Fire Suppression Button.
	Area Covered by Auto Heat Detectors	BF	Break fastening (ie. break glass bolt)		Kitchen - Emergency Shut Off Button.
	Area Covered by Auto Smoke Detectors	SL	Security lock		
	Fire Door Keep Shut	FFF	Door free from fastenings		
	Fire Door Keep Locked	FR30SC	Fire Door - 30 mins - Self Closing		
	Gangway Keep Clear				
	Fire Escape Keep Clear				
	Fire Exit Sign				



GROUND FLOOR PLAN

MOUNTBATTEN HOTEL
20 MONMOUTH STREET, LONDON WC2H 9HD
PROPOSED INTERNAL ALTERATIONS

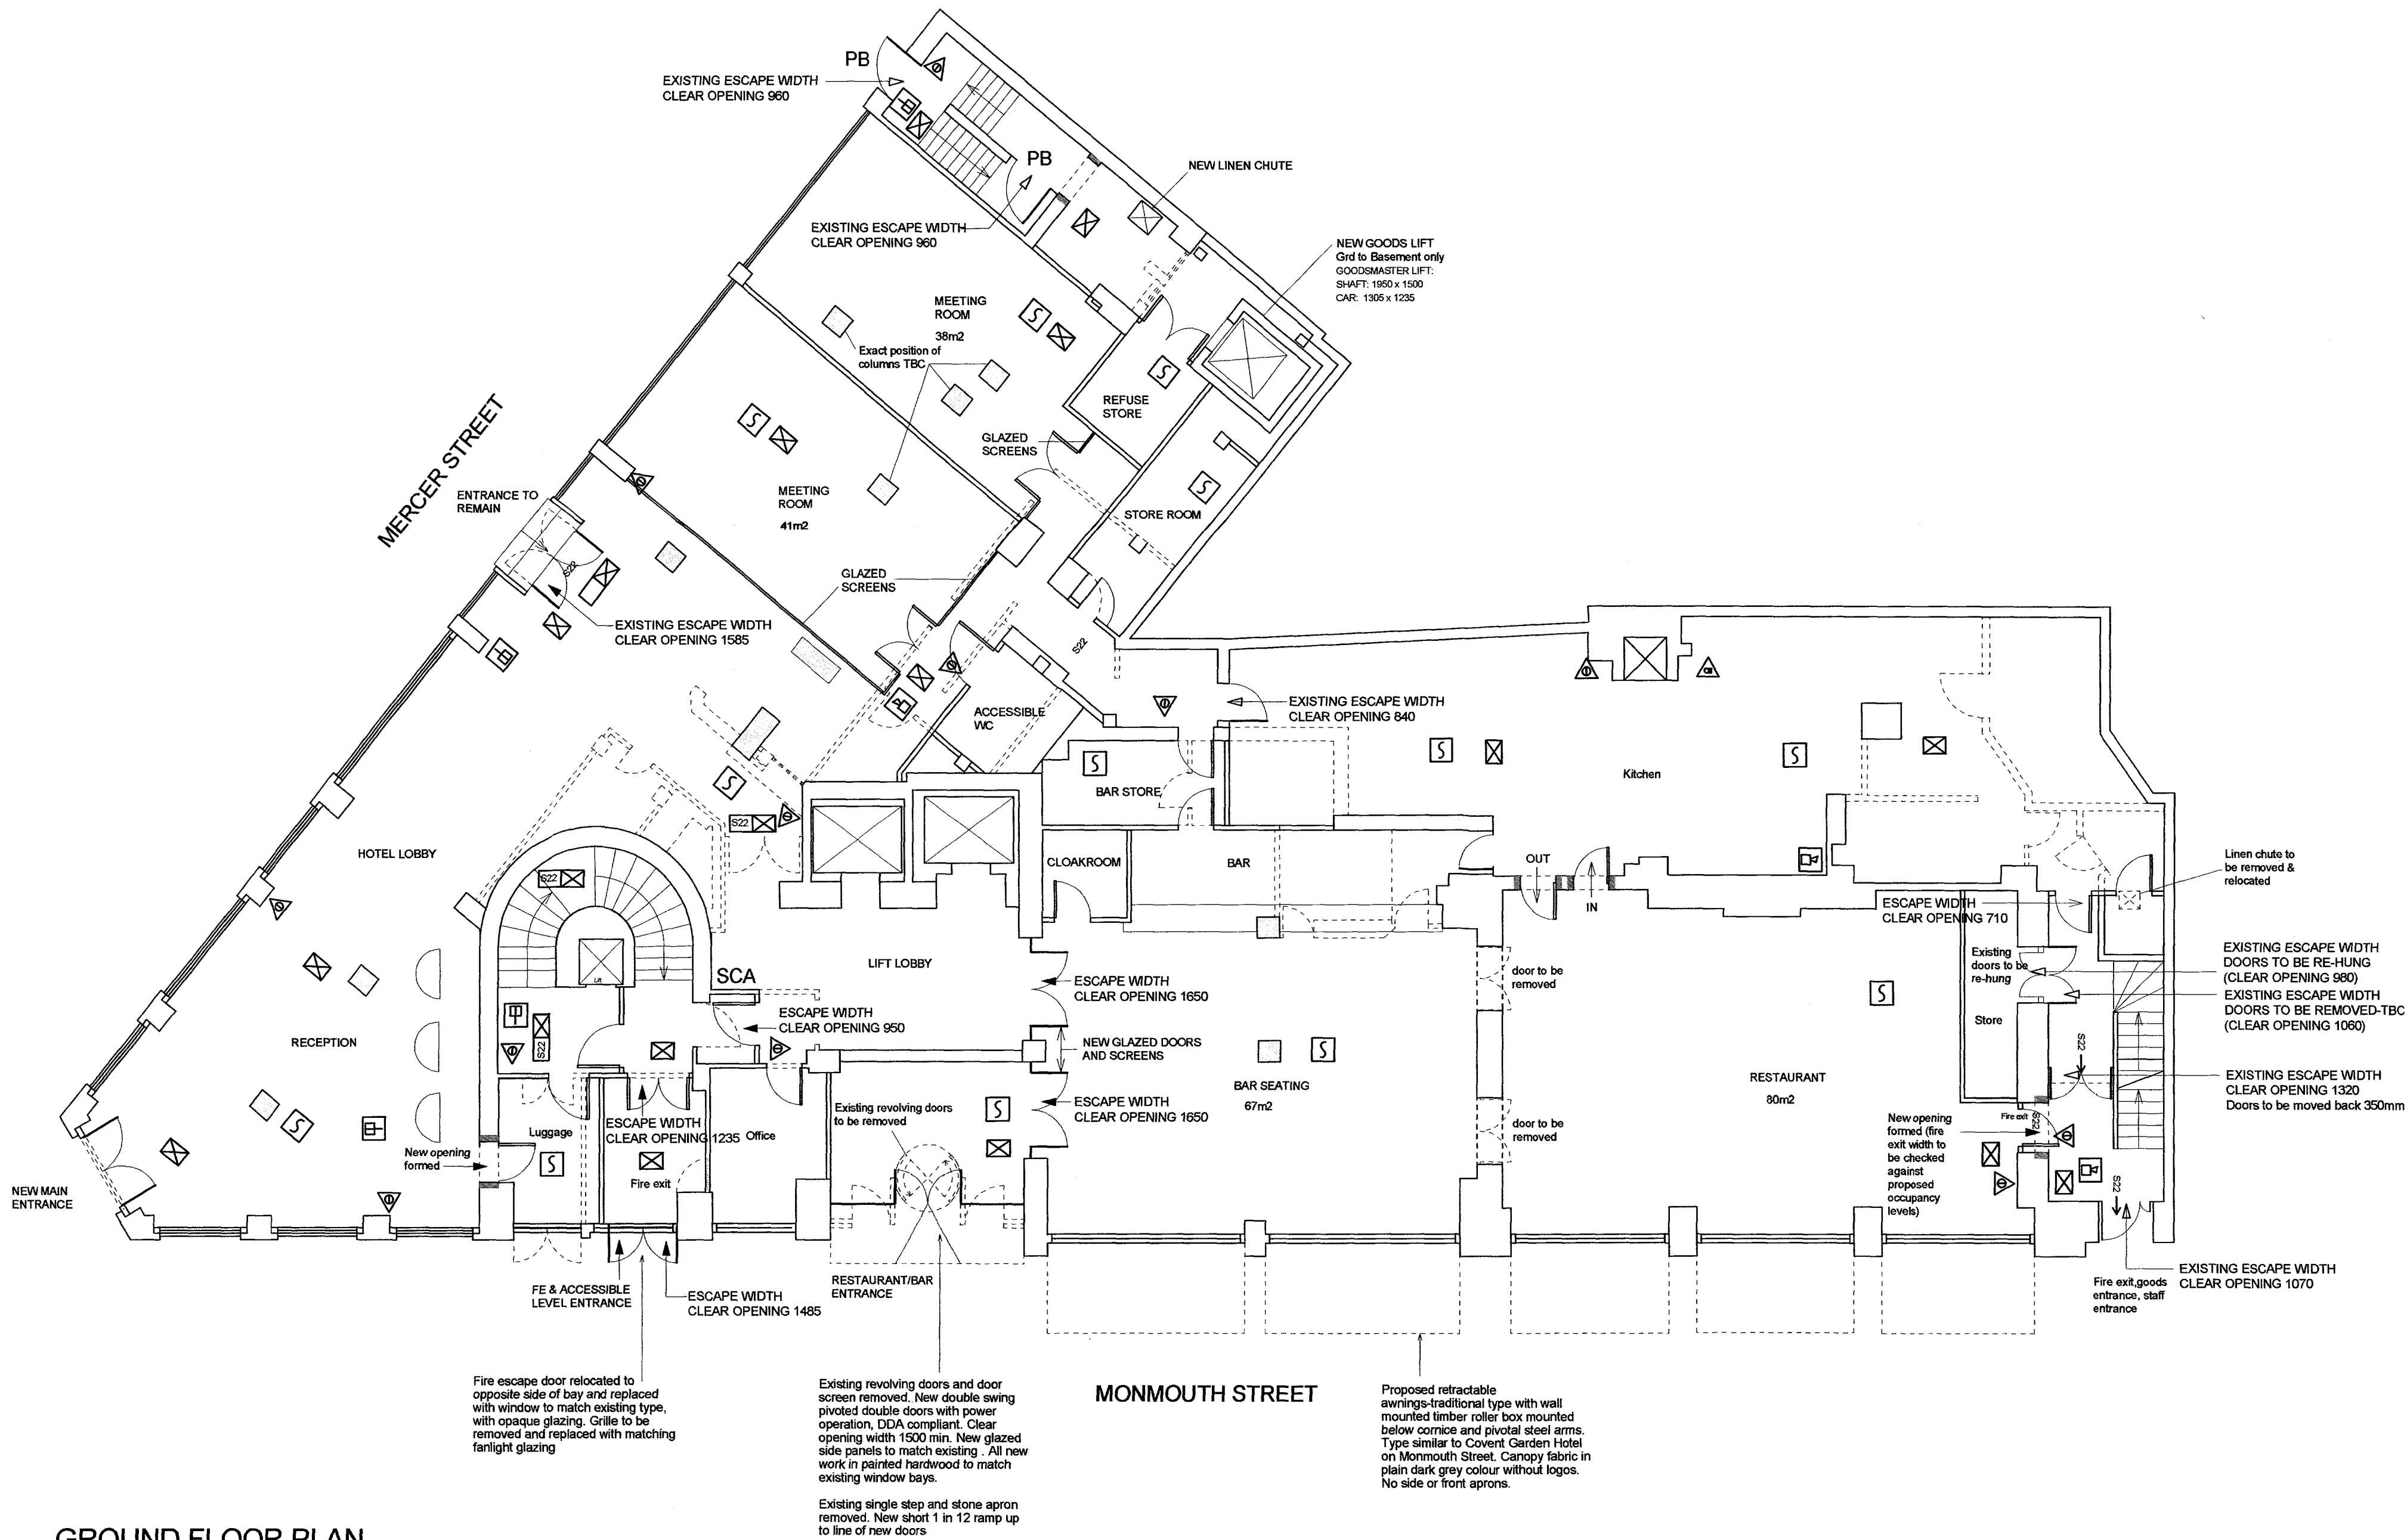PROPOSED GROUND FLOOR PLAN

REVISIONS

--	--	--	--

SCALE	DATE	DRAWN	CHECKED
1/100	05/2010	KB	

CODE	NUMBER
J695	PL 03