


North Point

The copyright of this drawing is vested in Price-Arthur Consultancy or the employer. Drawings must not be copied or reproduced without written consent. This drawing is to be used for this project only and should not be used for any other purpose. Do Not Scale

Notes

1.

EXISTING EXTRACT FANS TO BE REMOVED AND WINDOWS REFURBISHED/REPAIRED

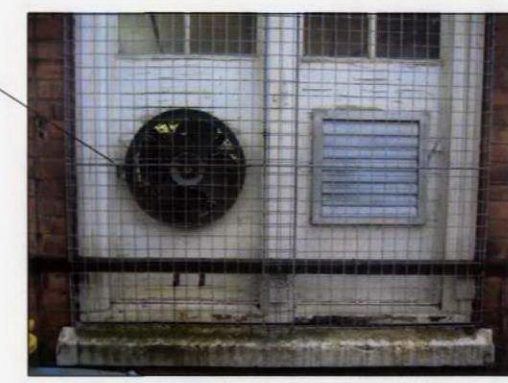

Hatched area to be bricked up to allow new canopy to be installed


SIDE ELEVATION OF KITCHEN

NOTE:

- 1 EXISTING BUILDING FABRIC UNCHANGED - BLACK LINES
- 2 NEW VENTILATION PLANT - RED LINES


RECEIVED
22 JUN 2010

FRONT ELEVATION OF KITCHEN

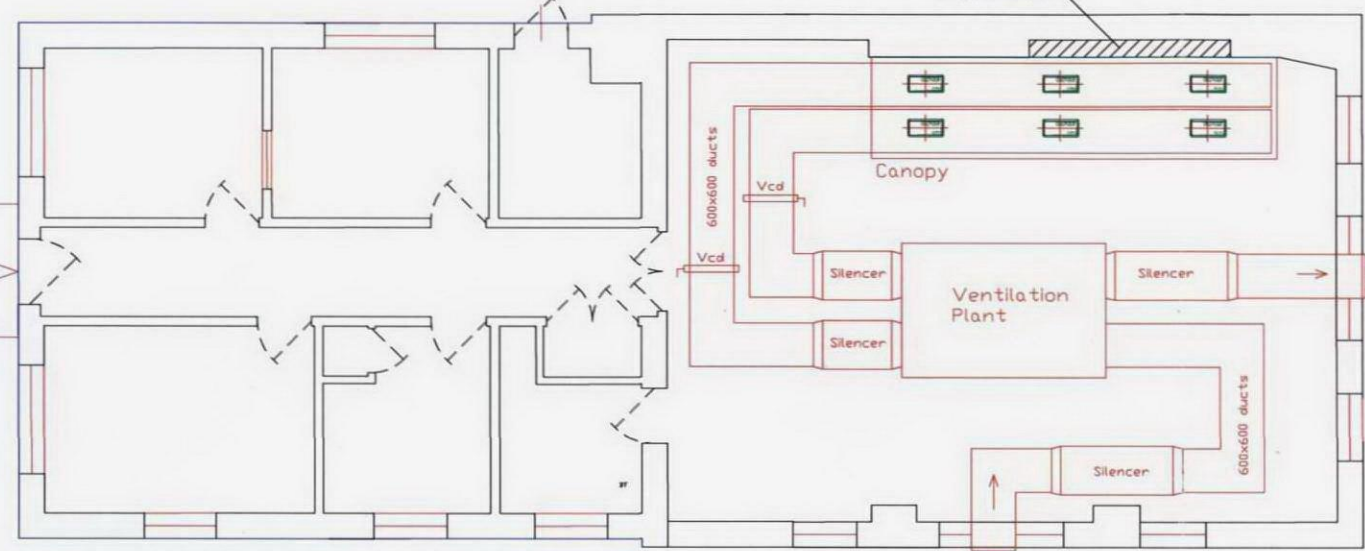


Section thru' window (1:25) showing louvre detail.

Louvre to be fixed to window frame mullions using approved method

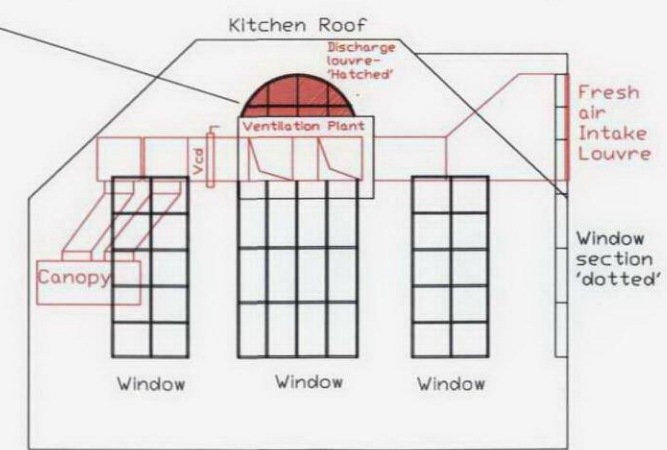

SIDE ELEVATION OF KITCHEN

FRONT ELEVATION OF KITCHEN

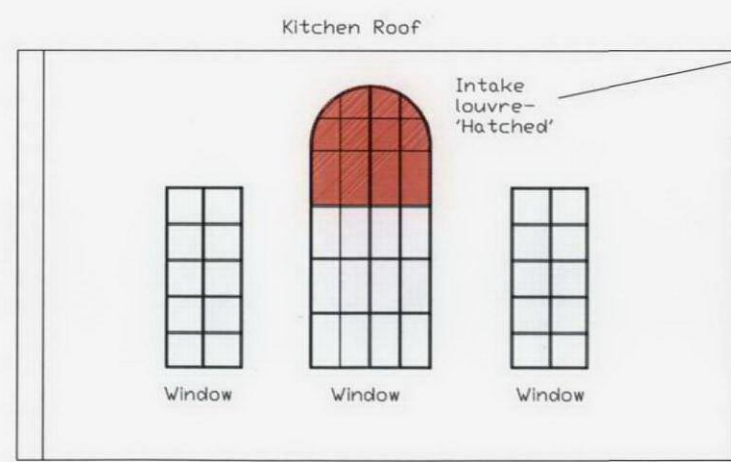

PLANNING



Price - Arthur Consultancy
Building Services Consulting Engineers & project Managers
Finch Lodge
The Folly
Buntingford
Herts
SG9 9EB
Tel: 01763 272448
Fax: 01763 274528

CLIENT
London Borough of Camden

PROJECT
Beckford Primary School
New Kitchen Ventilation System
and Associated Works

DESCRIPTION
VENTILATION SYSTEM LAYOUT

Drawn: pla	Checked:	
Scale: 1:50 @A1	Date: 22 June '10	Rev:
Drawing No: P4422/beck/m/01/P		