


EXISTING HAND
RAIL


NEW COMMS ROOM
CONDENSER.

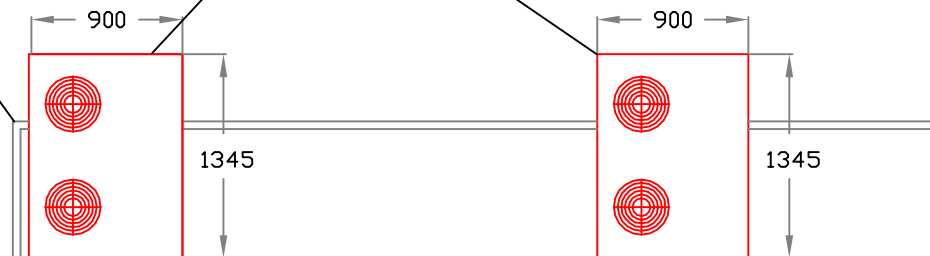

ELEVATION A
SCALE 1:50 @ A3


NEW VRV
CONDENSER

EXISTING HAND
RAIL

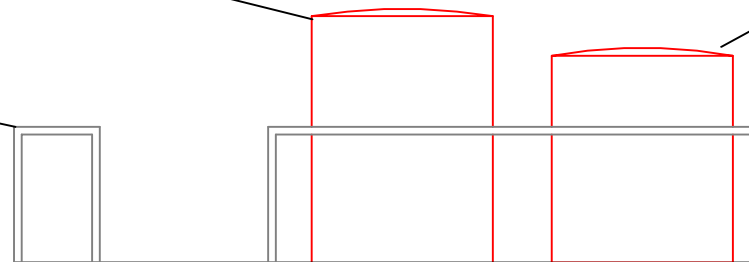


ELEVATION B
SCALE 1:50 @ A3

EXISTING
CONDENSER

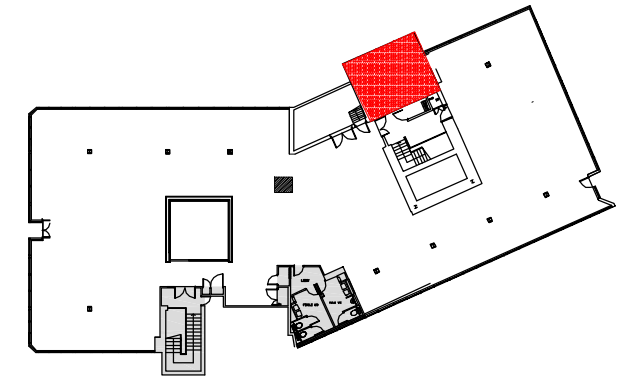

LOCATION PLAN
NOT TO SCALE

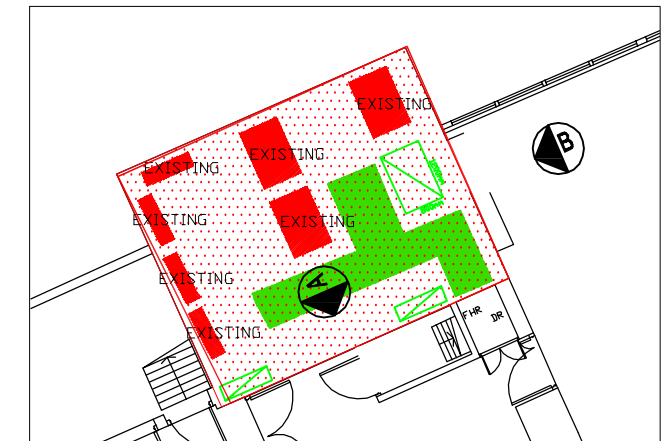

PROPOSED ROOF PLAN
NOT TO SCALE

65 KINGSWAY
LONDON WC2B 6TD

NAME: CONDENSER ELEVATIONS
SCALE: 1:50
PAPER SIZE: A3

DATE: 04.03.10
DRAWN: MCL

THE **INTERIORS** GROUP